
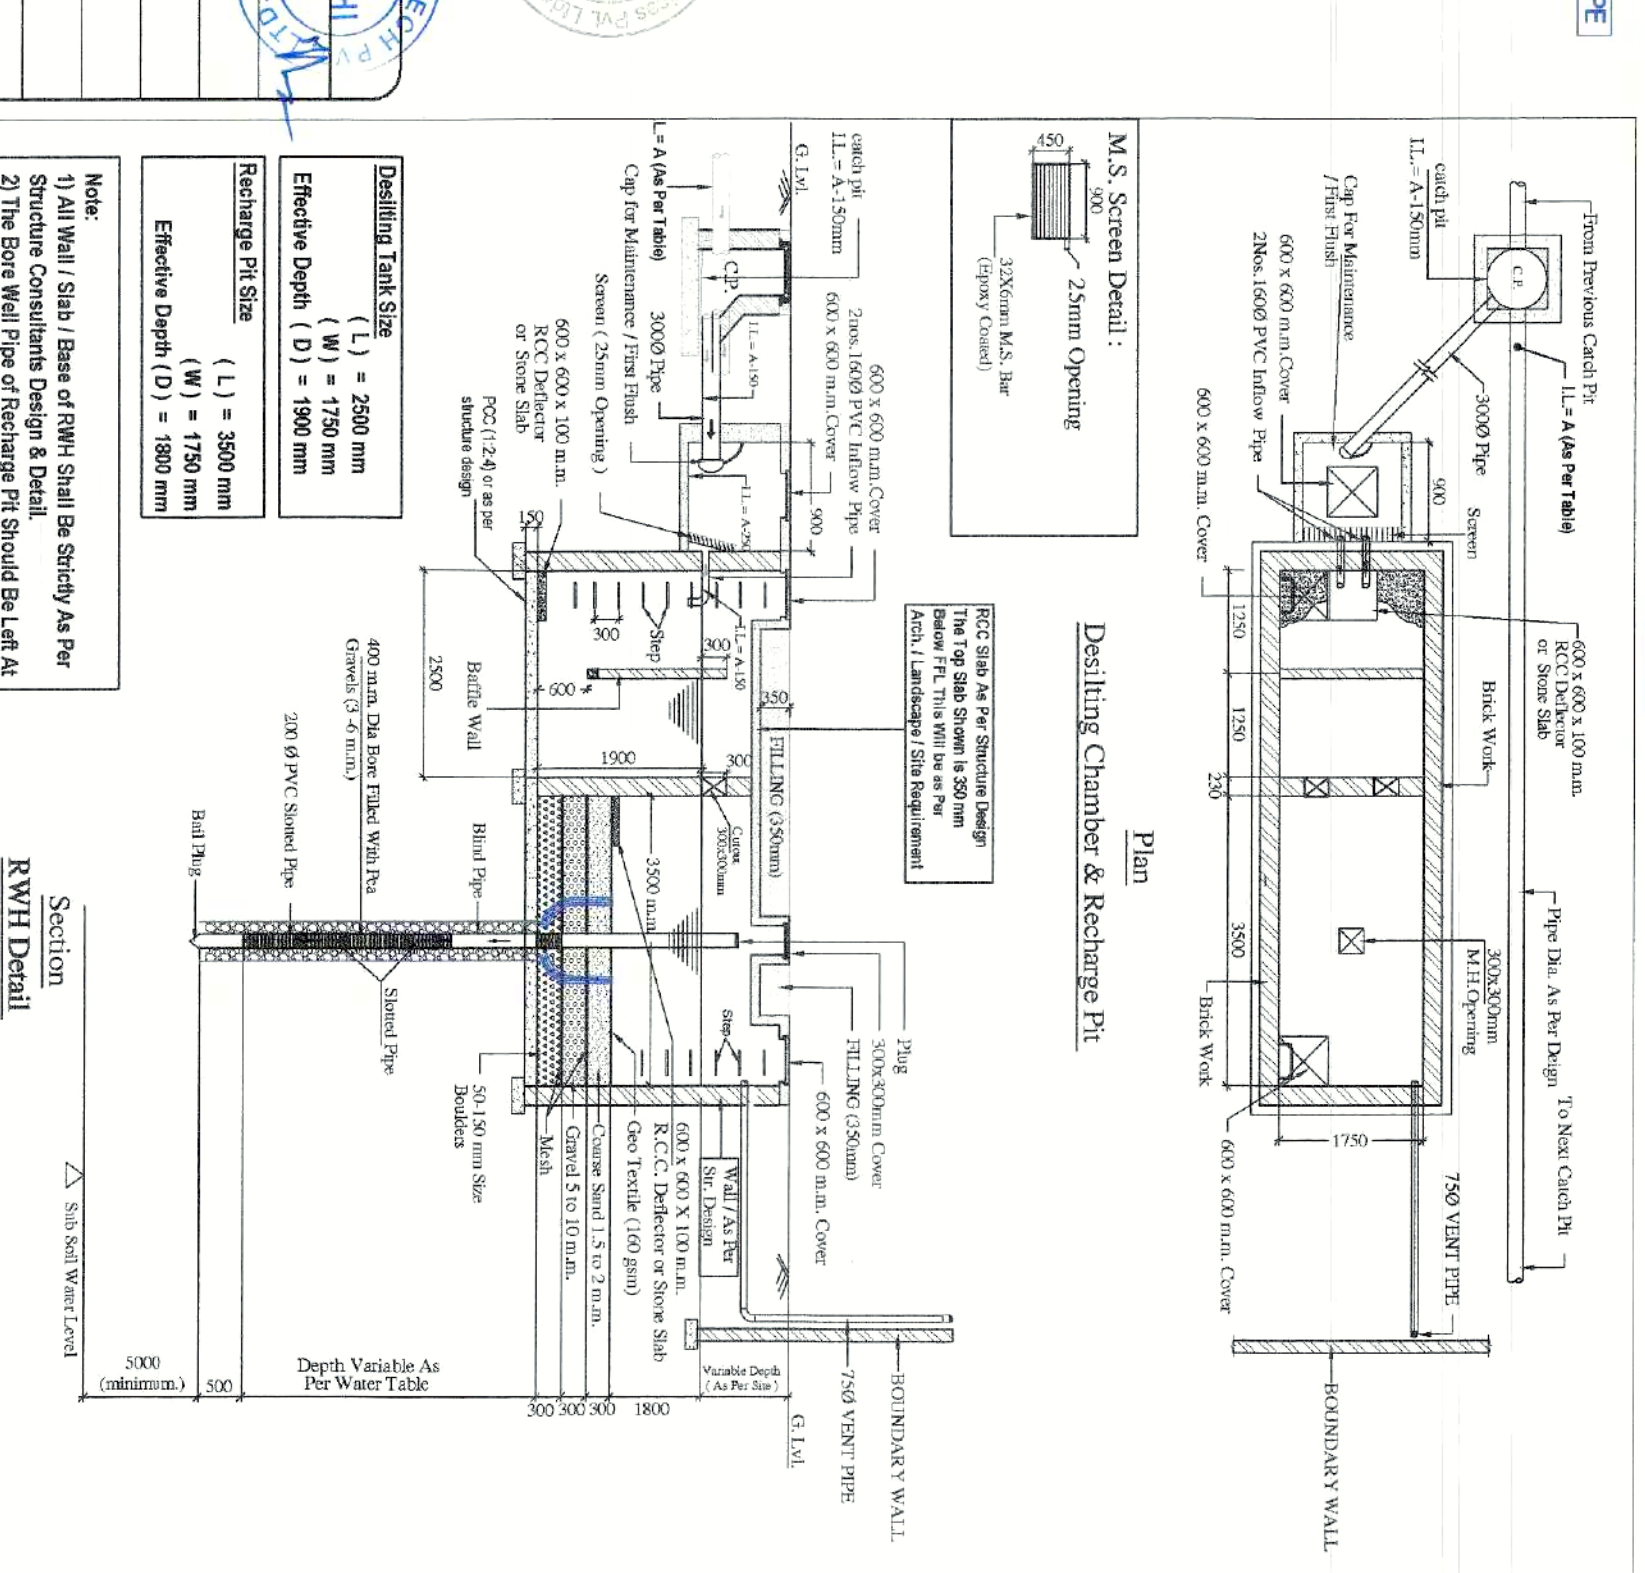
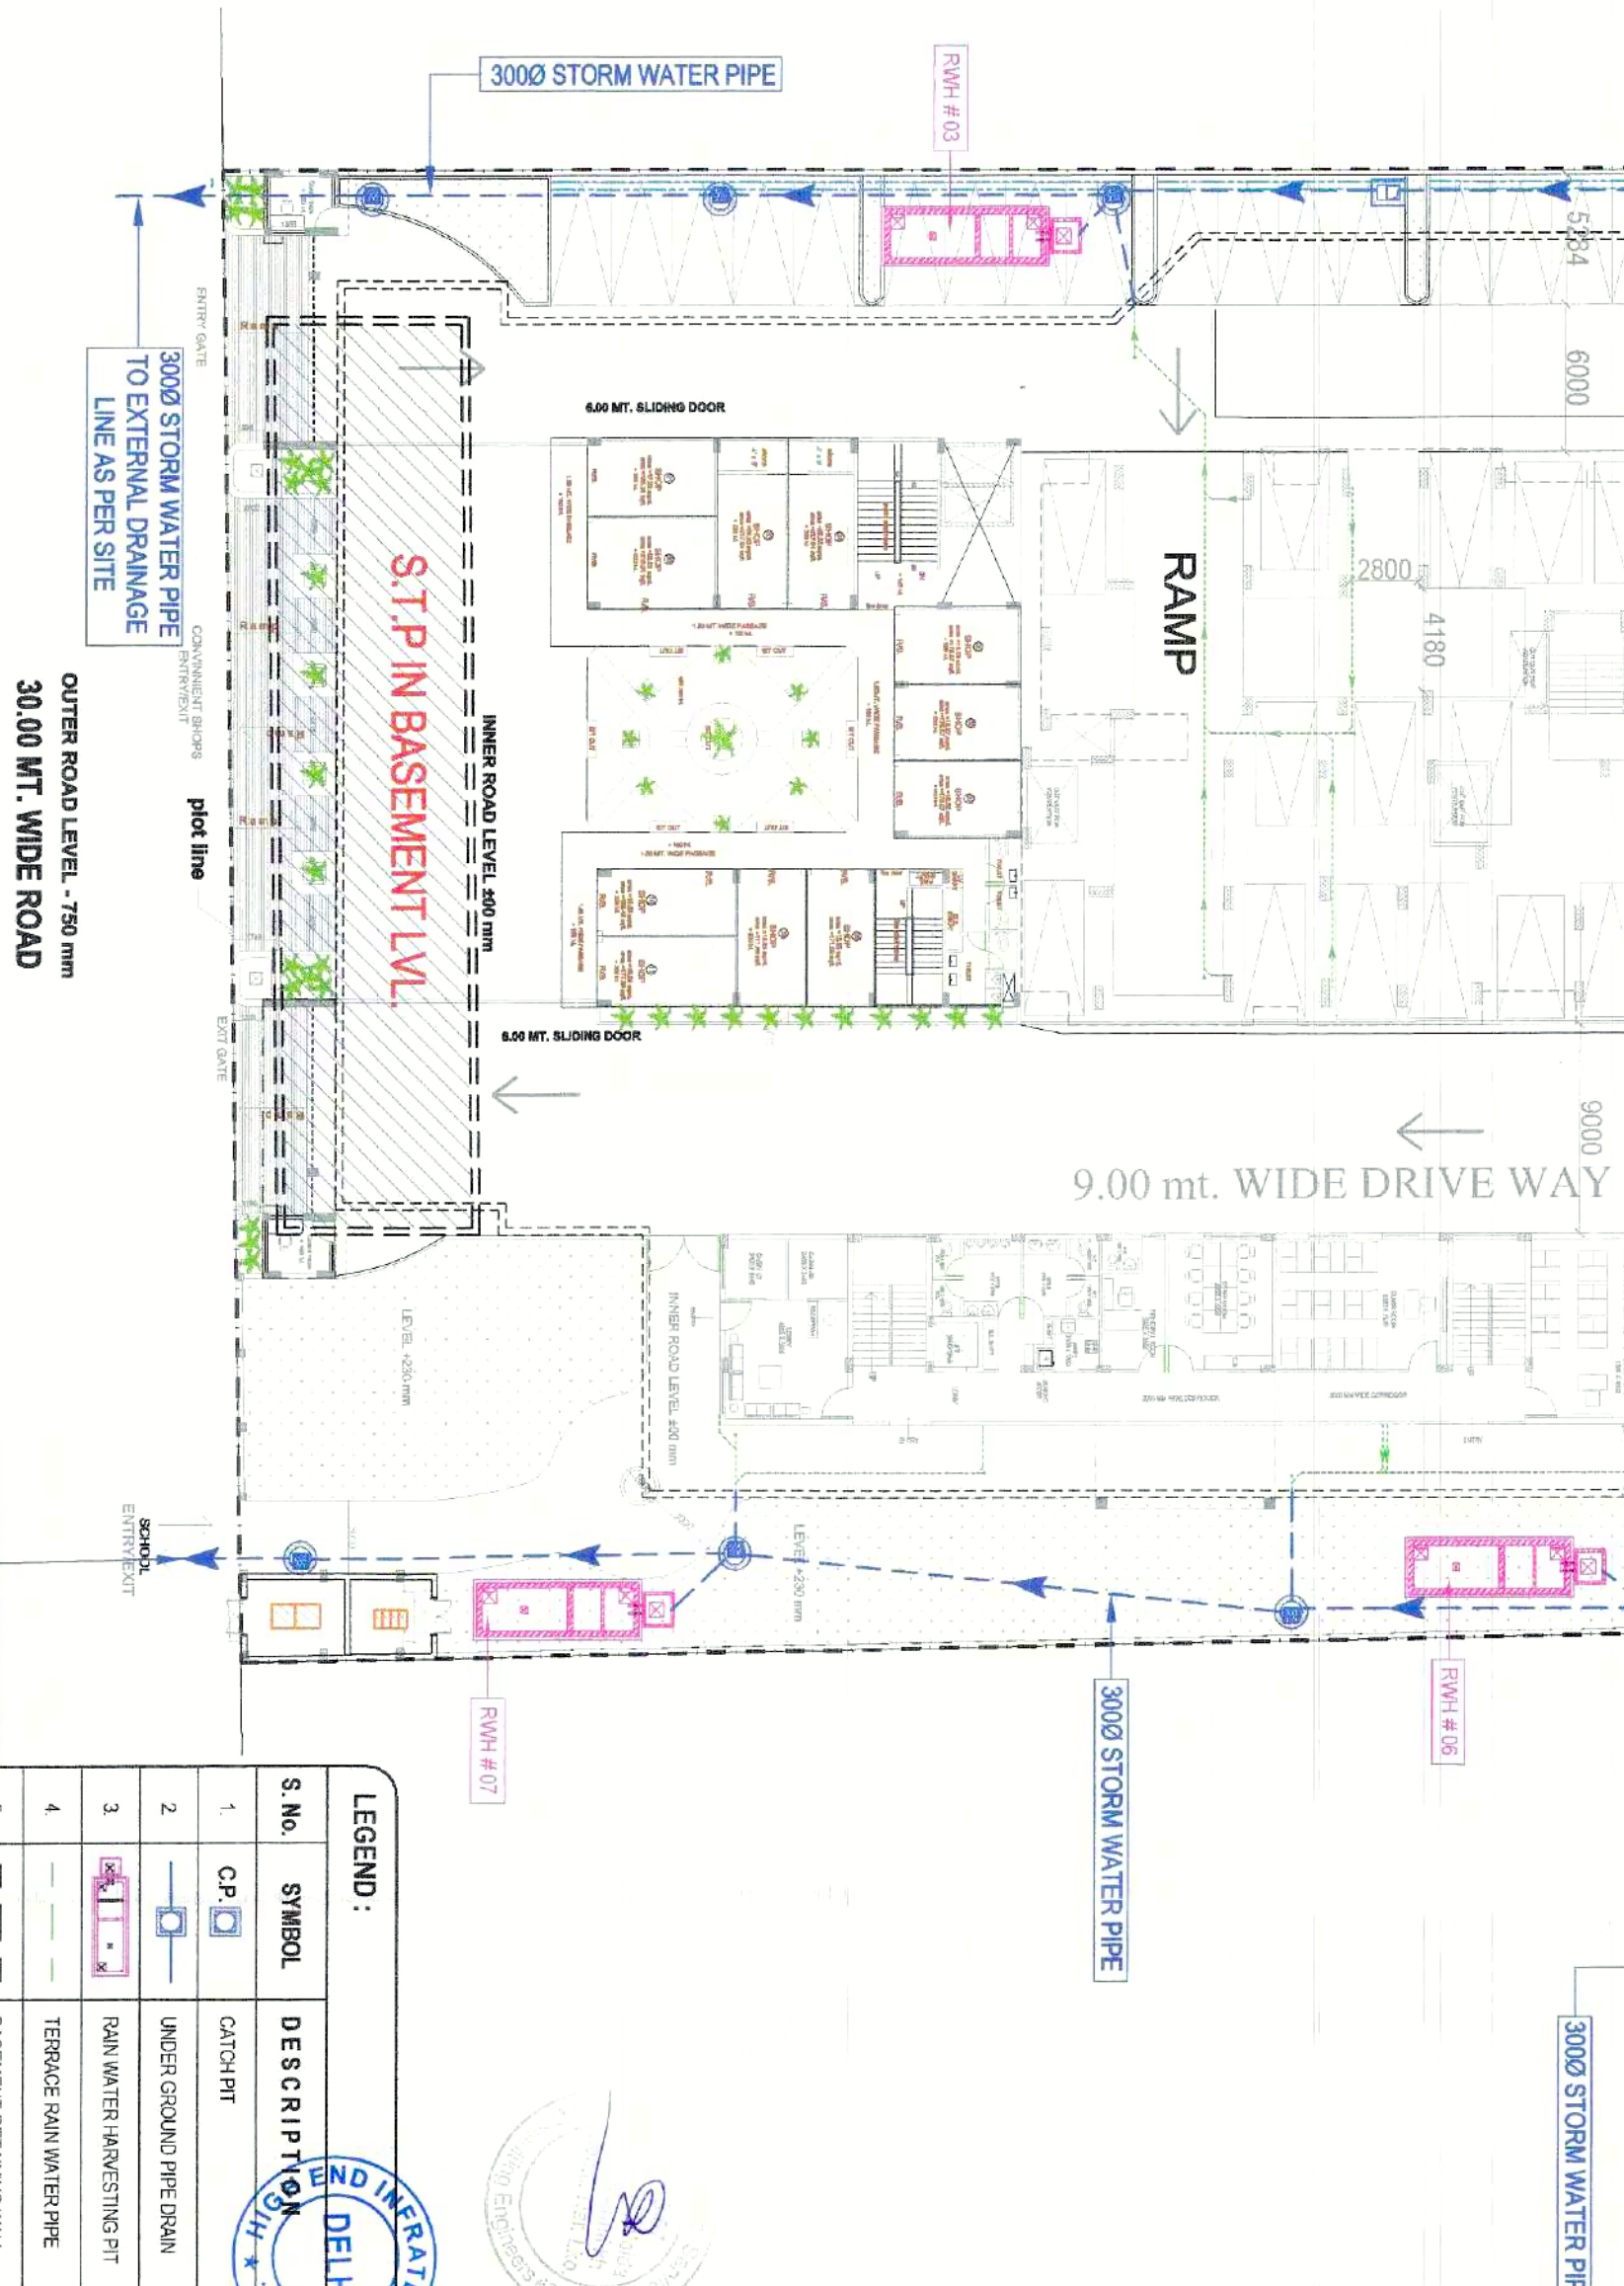


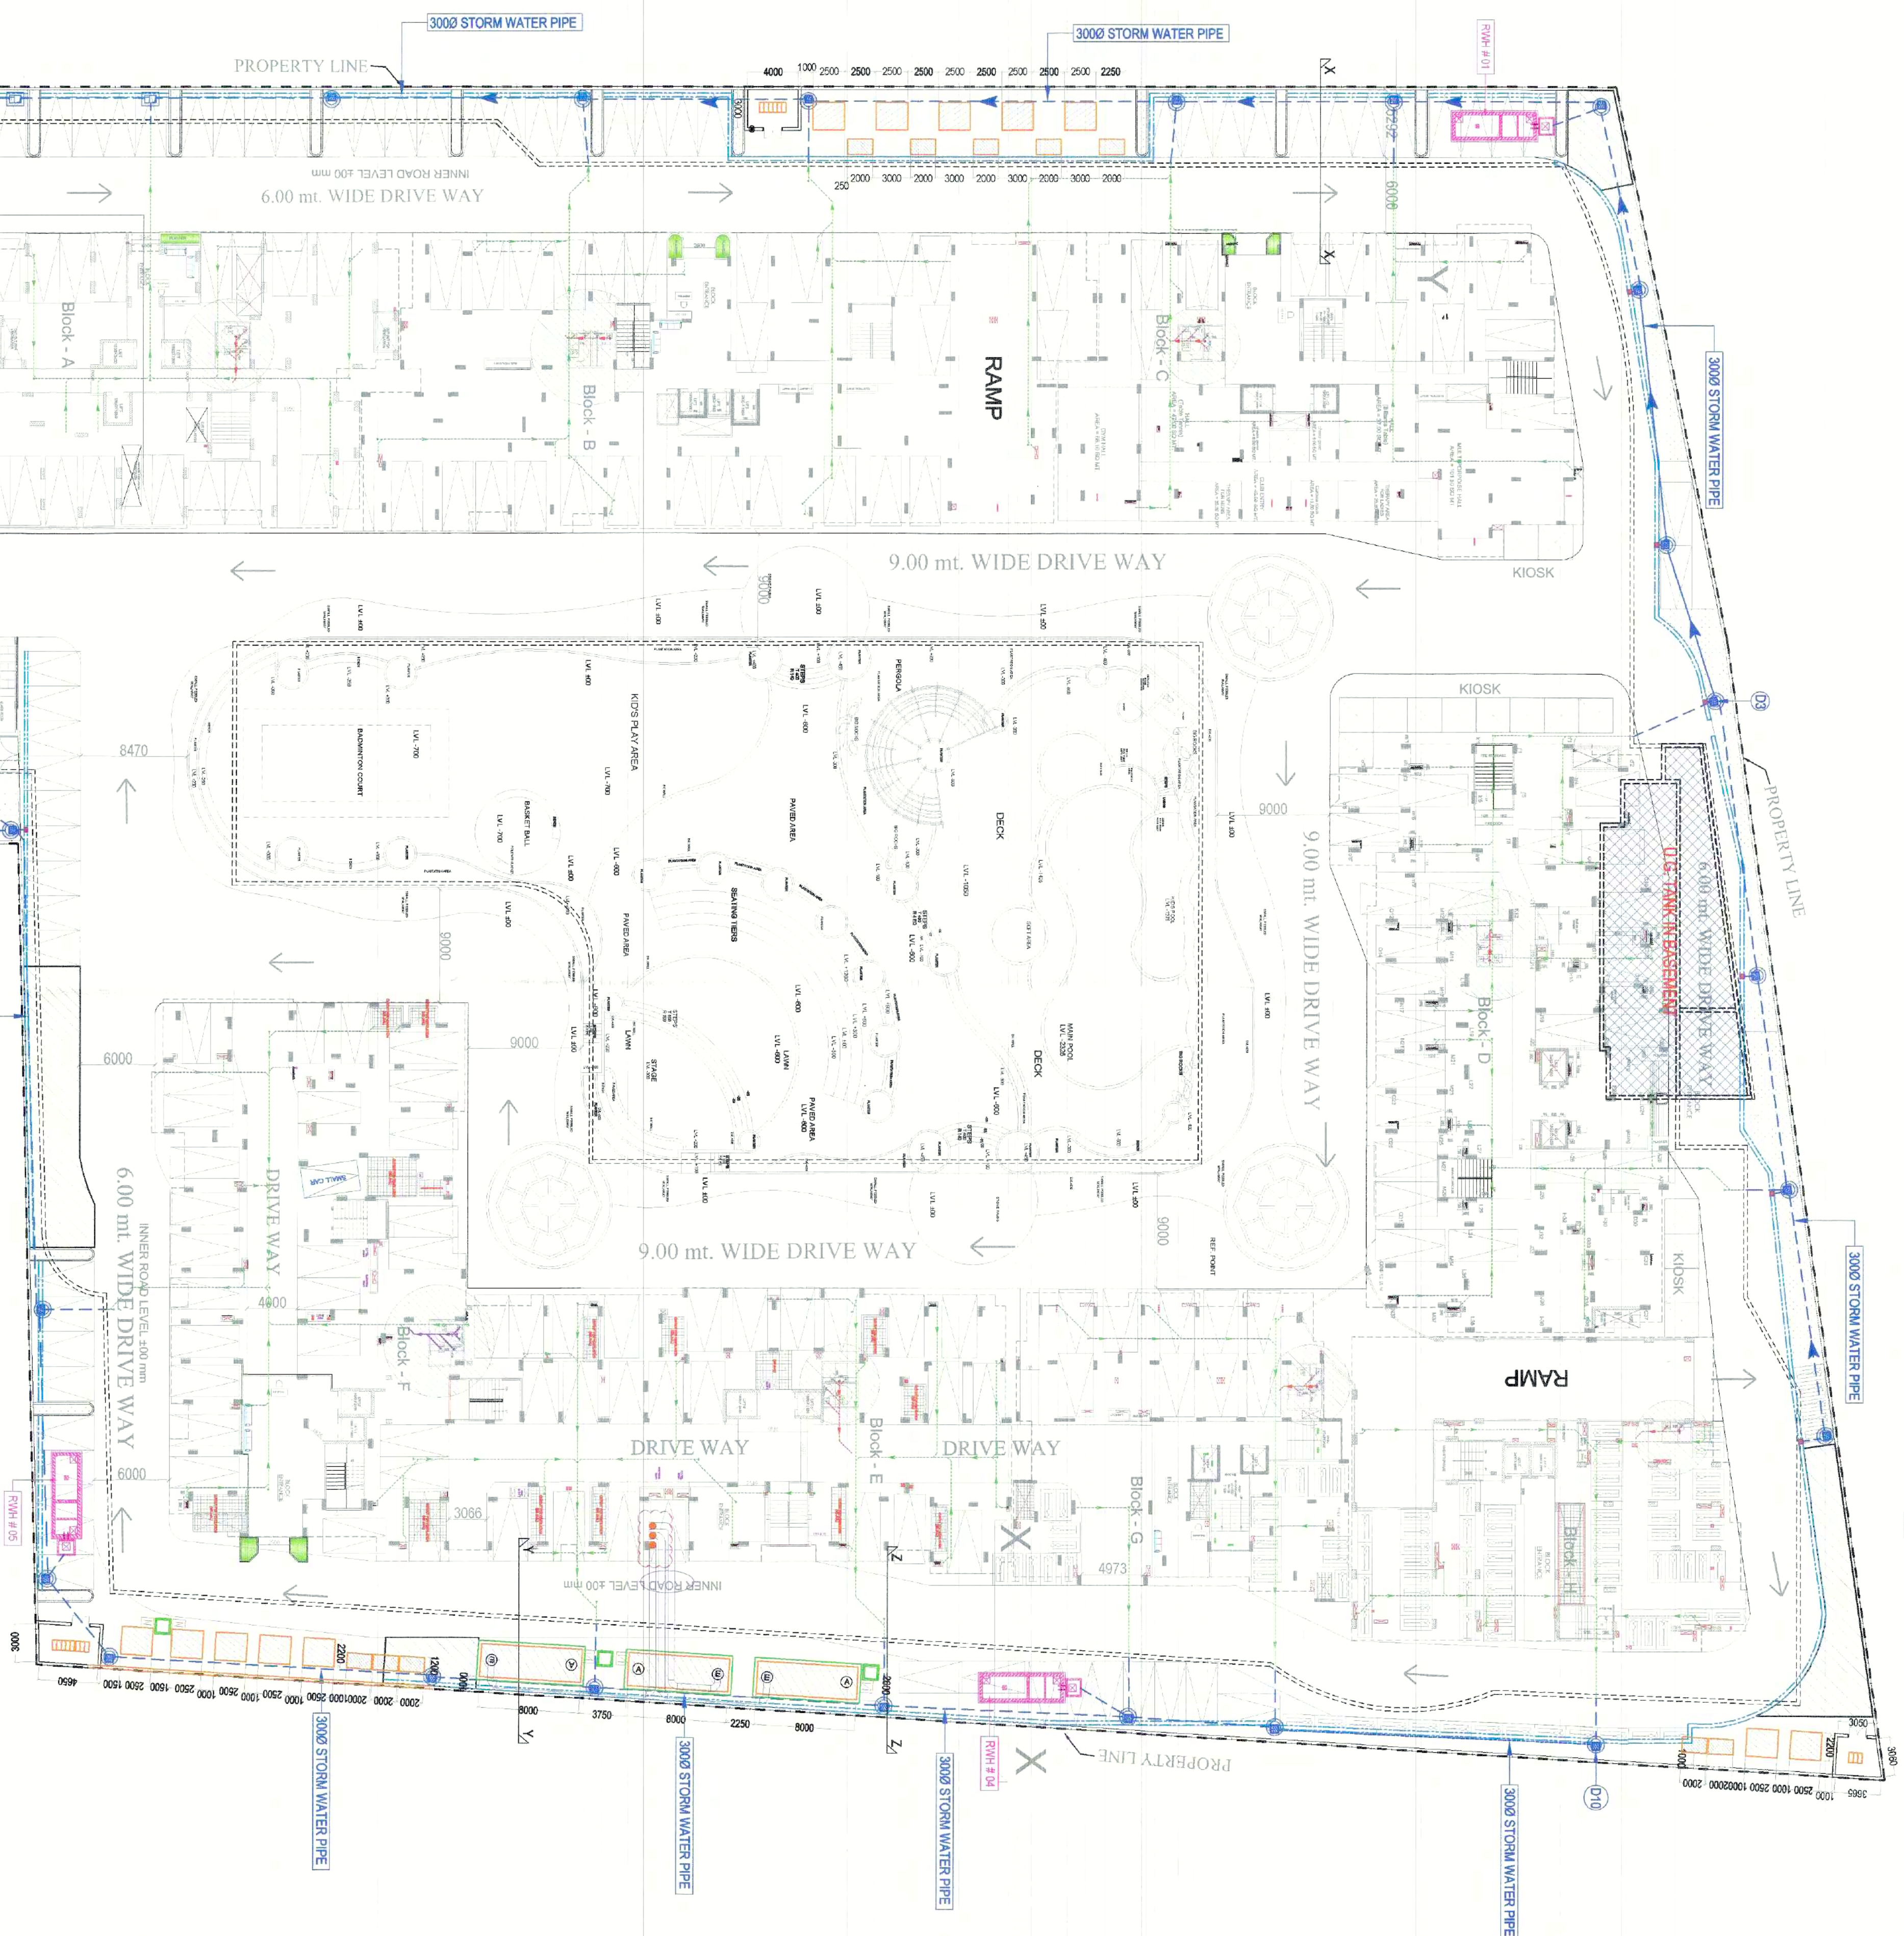

LEGEND:

S. No.	SYMBOL	DESCRIPTION
1	CP	CATCH PIT
2	—	UNDER GROUND PIPE DRAIN
3	—	RAIN WATER WASTING PIT
4	—	TERMINAL RAIN WATER PIPE
5	—	BASEMENT RECHARGE WALL
6	—	SEALER RAIN

Project

PROPOSED GROUP HOUSING (WINDSOR PARADISE - II) AT KH. NO. -1006 to 1008 AT VILLAGE NOORNAAGAR GHANABAD (U.P.)

Title

SITE PLAN

drawing released for

☐ APPROVAL
☐ ADVANCE COPY
☐ SUBMISSION
☐ CONSTRUCTION

dra. no.

CS/SP/PL-42

scale

(A1) 1:300

date

23.08.2019

drawn by

S.Shandani

designed by

Shahid Shahr

checked by

Anand Havelia

architects

ANU AGRAWAL ARCHITECTS P. LTD.
architects, engineers, landscape & interior designers
OFF: A-304, KANUNPUR, CHANDIGARH (INDIA) (NEAR MALL)
MOB. : 9915199511, 9915199512
email: anu.agrawal@anuarthitects.com

services consultant

cespi
Consummate Engineering Services (P) Ltd.
Head Office: B-67, Sector-67, Mohali-150001
Toll Office: 3-1006, Badli, Phase-1, Gurgaon, Haryana
e-mail : info@cespi.in, website : www.cespi.in