



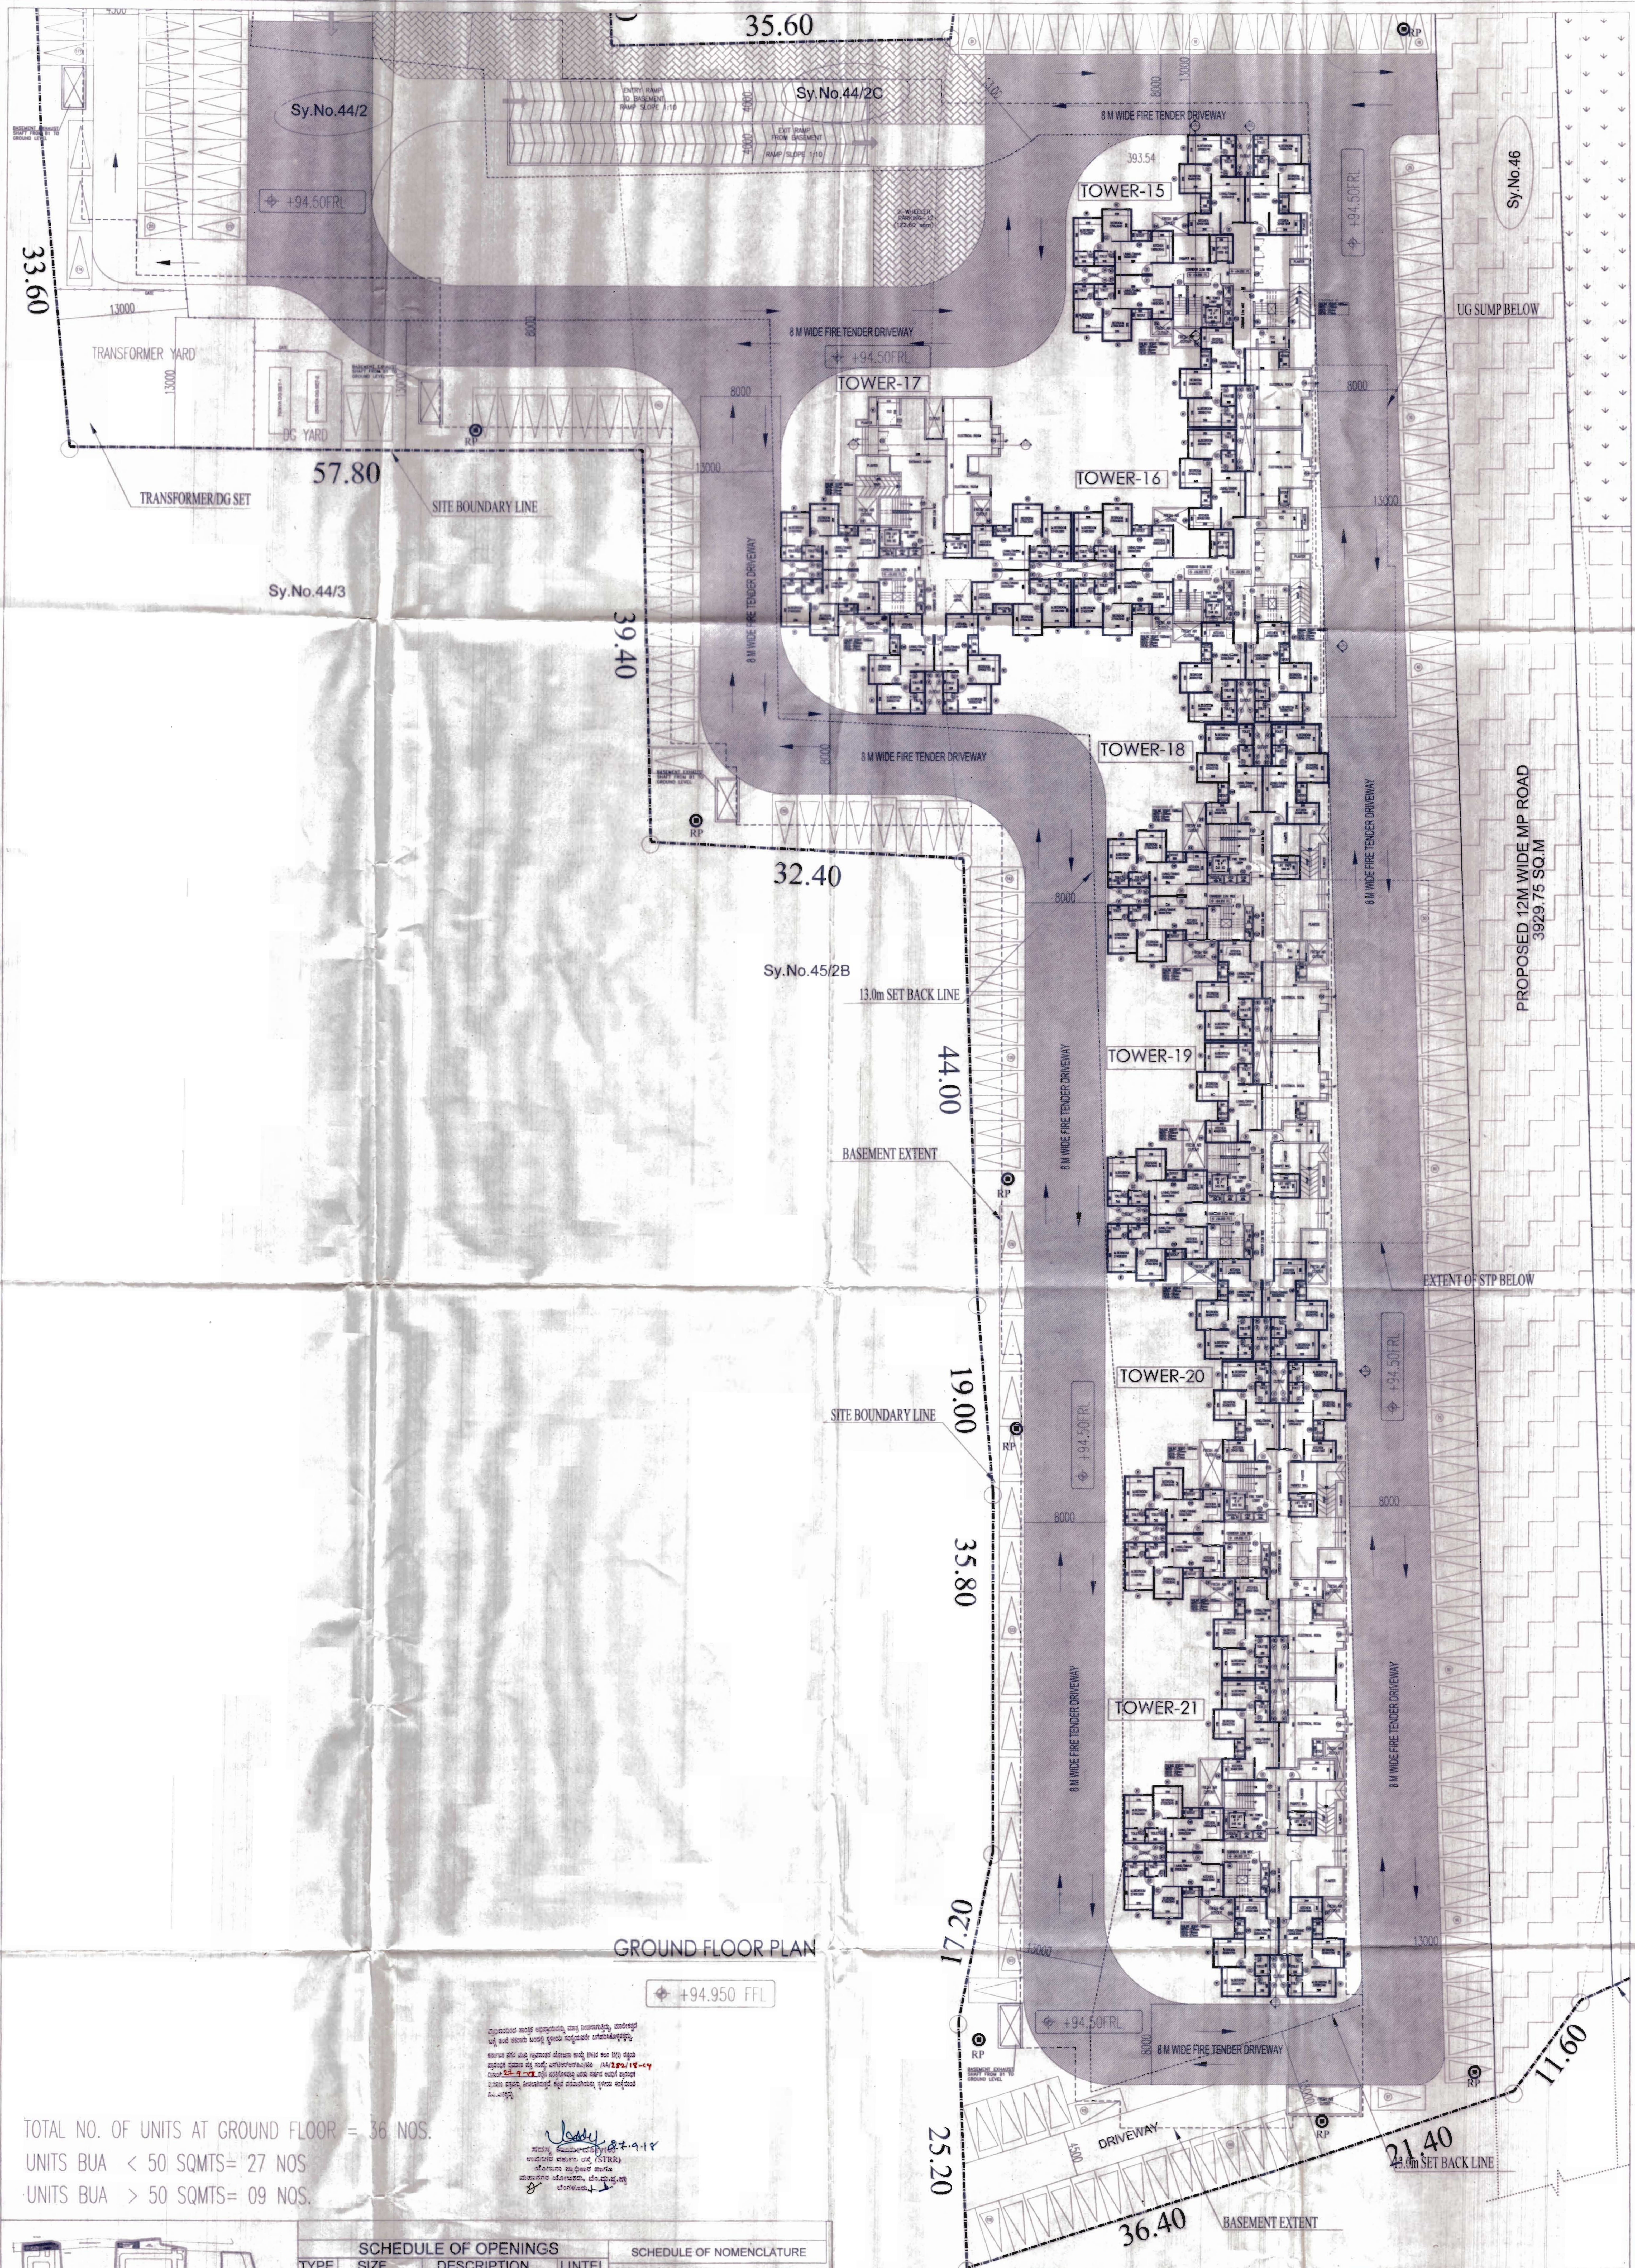


TOTAL NO. OF UNITS AT GROUND FLOOR = 36 NOS.
UNITS BUA < 50 SQMTS= 27 NOS
UNITS BUA > 50 SQMTS= 09 NOS.

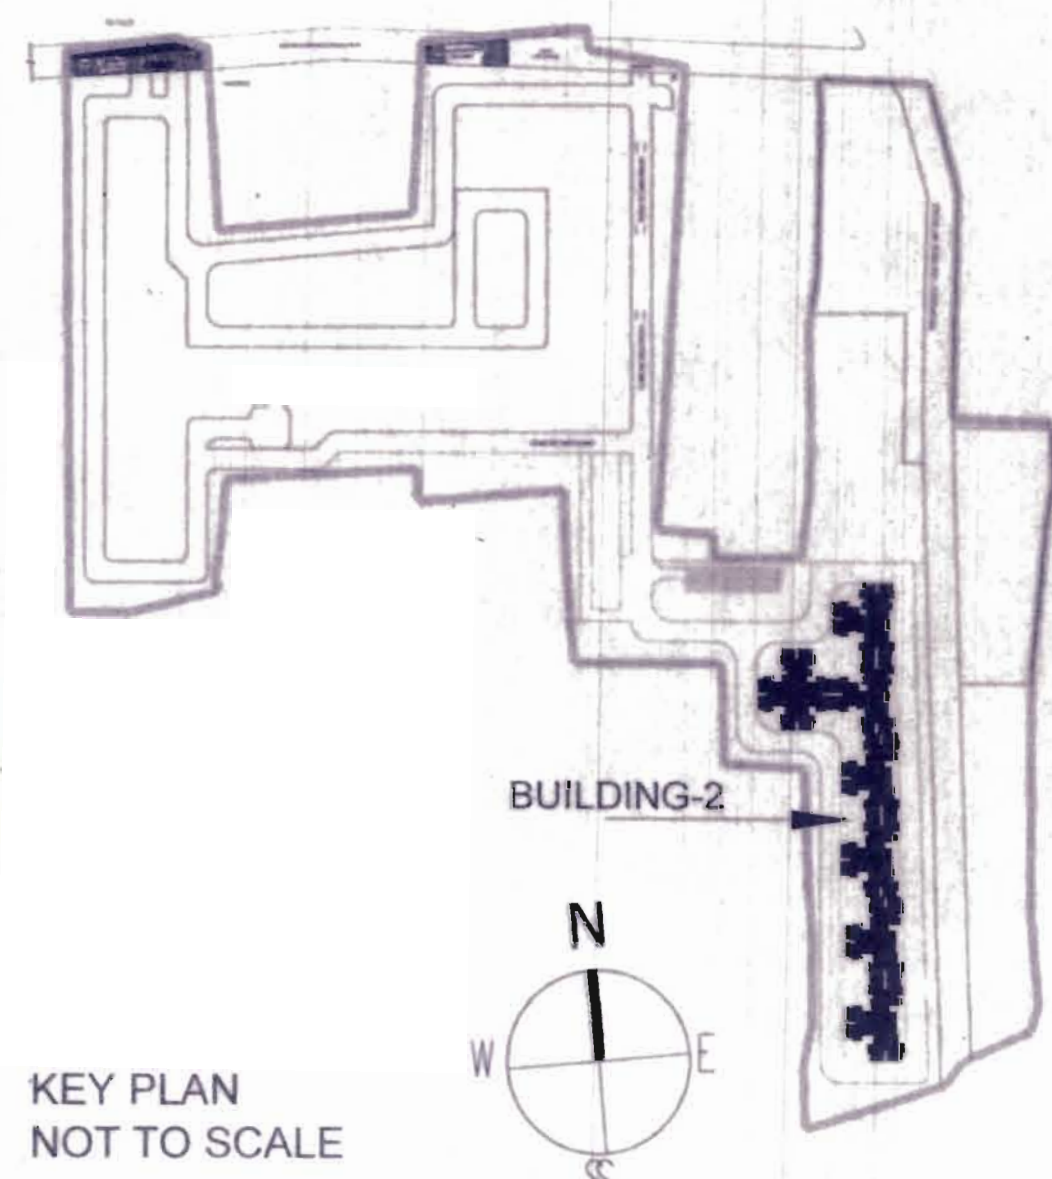

SCHEDULE OF OPENINGS				SCHEDULE OF NOMENCLATURE	
TYPE	SIZE	DESCRIPTION	LINTEL	NAME	DESCRIPTION
DOORS					
FD1	1100 x 2100	FIRE RATED DOOR	2100	PHE	PUBLIC HEALTH ENGINEERING
FD2	900 x 1500	FIRE RATED DOOR	2100	COM	COMMUNICATION
FD3	700 x 1500	FIRE RATED DOOR	2100	ELE	ELECTRICAL
FD4	1500 x 2100	FIRE RATED DOOR	2100	FHR	FIRE HOSE REEL
FD5	2000 x 2100	FIRE RATED DOOR	2100	BAL	BALCONY
FD6	900 x 2100	FIRE RATED DOOR	2100	FCC	FIRE COMMAND CENTRE
DW1	1550 x 2100	AL GLAZED SLIDING DOOR	2100		
D1	1050 x 2100	FLUSH DOOR	2100		
D2	900 x 2100	FLUSH DOOR	2100		
D3	700 x 2100	FLUSH DOOR	2100		
D4	1500 x 2100	FLUSH DOOR	2100		
WINDOWS					
W1	1800x1200	AL GLAZED SLIDING WINDOW	2100		
W2	1500x1200	AL GLAZED SLIDING WINDOW	2100		
W3	740x1200	AL GLAZED WINDOW	2100		
W4	1200x1200	AL GLAZED SLIDING WINDOW	2100		
W5	950x1200	AL GLAZED WINDOW	2100		
KW	800x1200	AL GLAZED WINDOW	2100		
VENTILATORS					
V1	600 X 900	AL GLAZED VENTILATOR	2100		
				NOTE: ALL DIMENSIONS ARE IN MILLIMETERS	
				ORIENTATION :	SHEET NO : 04

OWNER'S SIGNATURE :	PROJECT NAME :
K.L SANTOSH (PARTNER) ICONICA PROJECTS	PROPOSED RESIDENTIAL APARTMENT BUILDING (BUILDING No. 2 (TOWER- 15 To 21) IN APPROVED RESIDENTIAL GROUP HOUSING DEVELOPMENT PLAN VIDE No STRRPA/TP/D/P/05/2016-17, Dtd 08-08-2017 AT KHATA No 1124 (150230010700323186) Sy Nos. 5/1,5/2,7/2,10/2,44/2,44/5,45/2C,46 & 47 OF MANCHANAHALLI VILLAGE, ATTIBELE HOBLI, ANEKAL TALUK, BANGALORE URBAN DISTRICT
ARCHITECT'S SIGNATURE :	PROJECT CONSULTANTS :
MANIRAJ D (B.C.C/B.L-3/B-A-2862/2017-18)	Gardencity Realty Pvt Ltd. ARCHITECTURE DIVISION 5AC-510, HRBR LAYOUT 2nd Block, Kalyan Nagar, Outer Ring Road, Bengaluru-560043, Tel: +91 80 46664555
SANCTION DRAWING	
SUBJECT OF DRAWING :	
SHEET No.4/10 BUILDING-2 GROUND FLOOR PLAN	
SCALE : 1:200	DATE : 23.07.2018
DRAWN : S.P	CHECKED : ASHOK
DRAWING NO : A-BLDG-2-103	

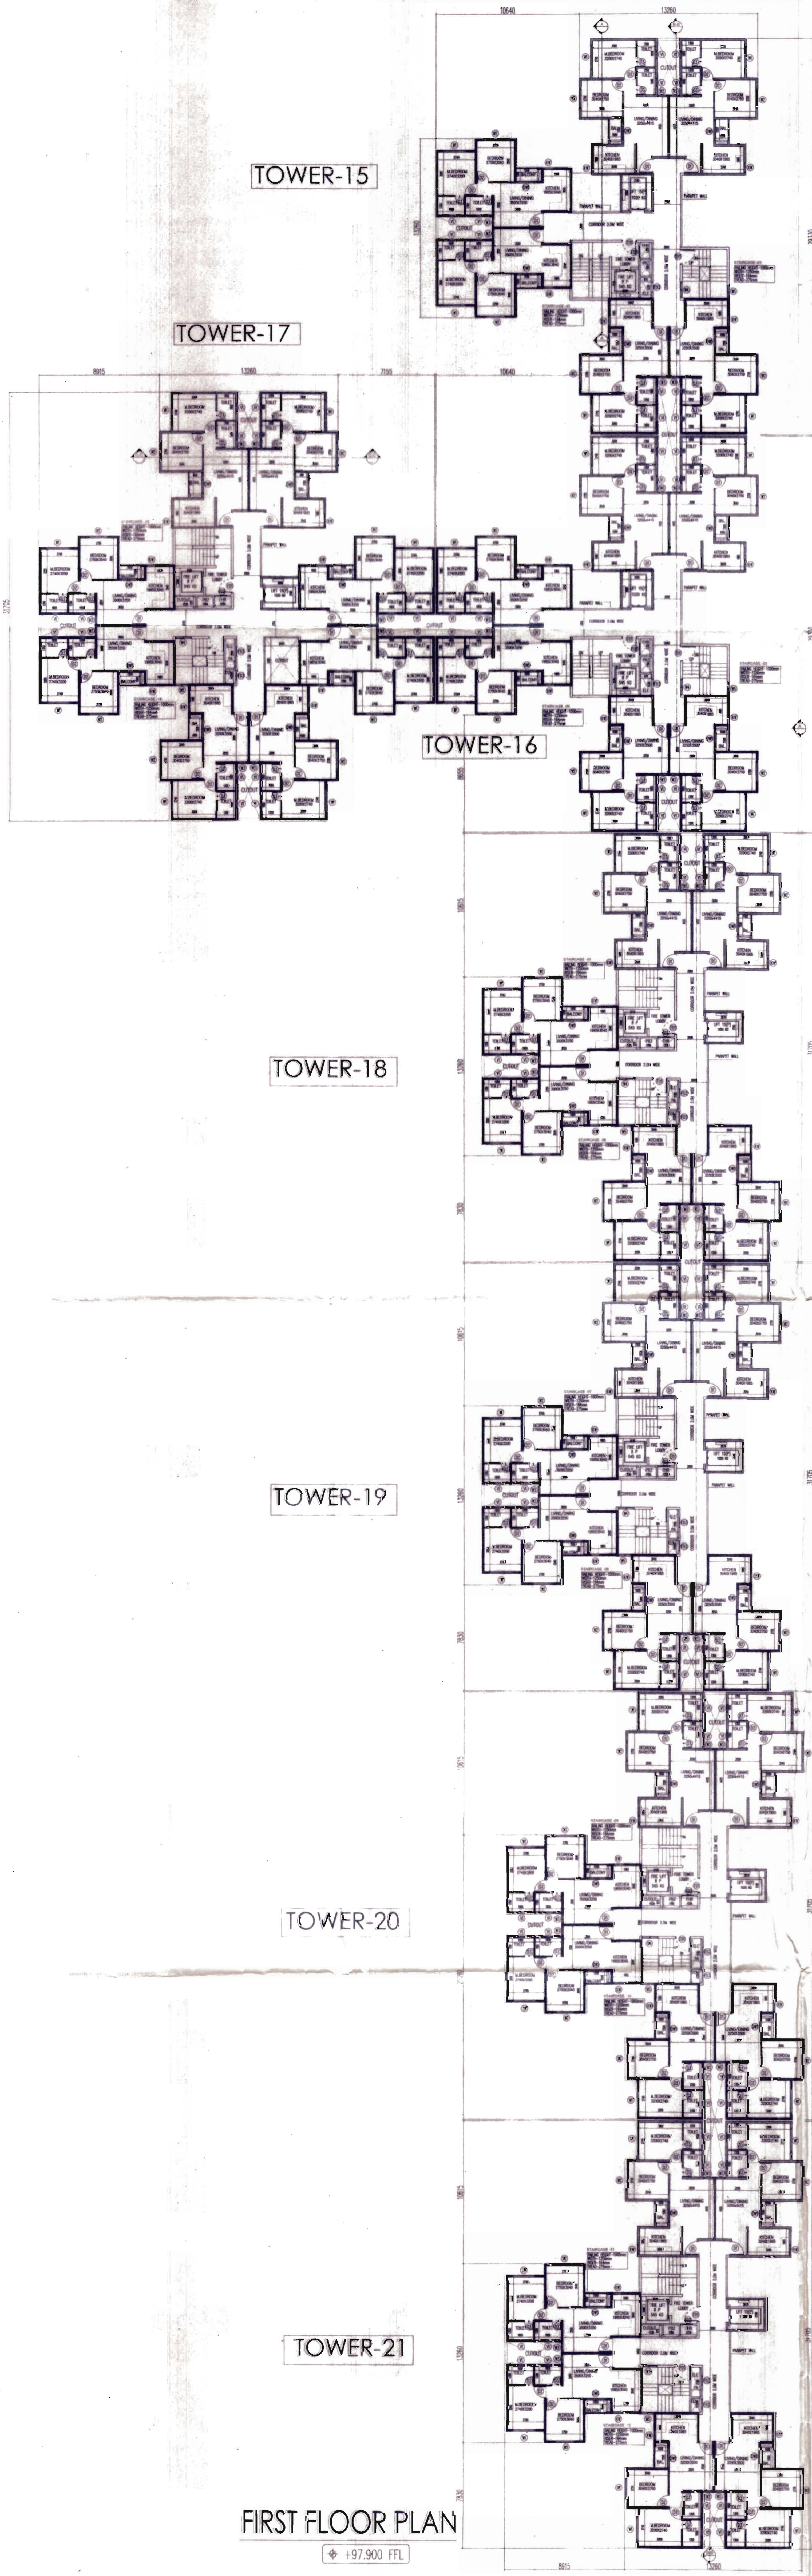

TOWER-15

TOWER-17

TOWER-16

TOWER-18


TOWER-19

TOWER-20

TOWER-21

FIRST FLOOR PLAN

+97.900 FFL

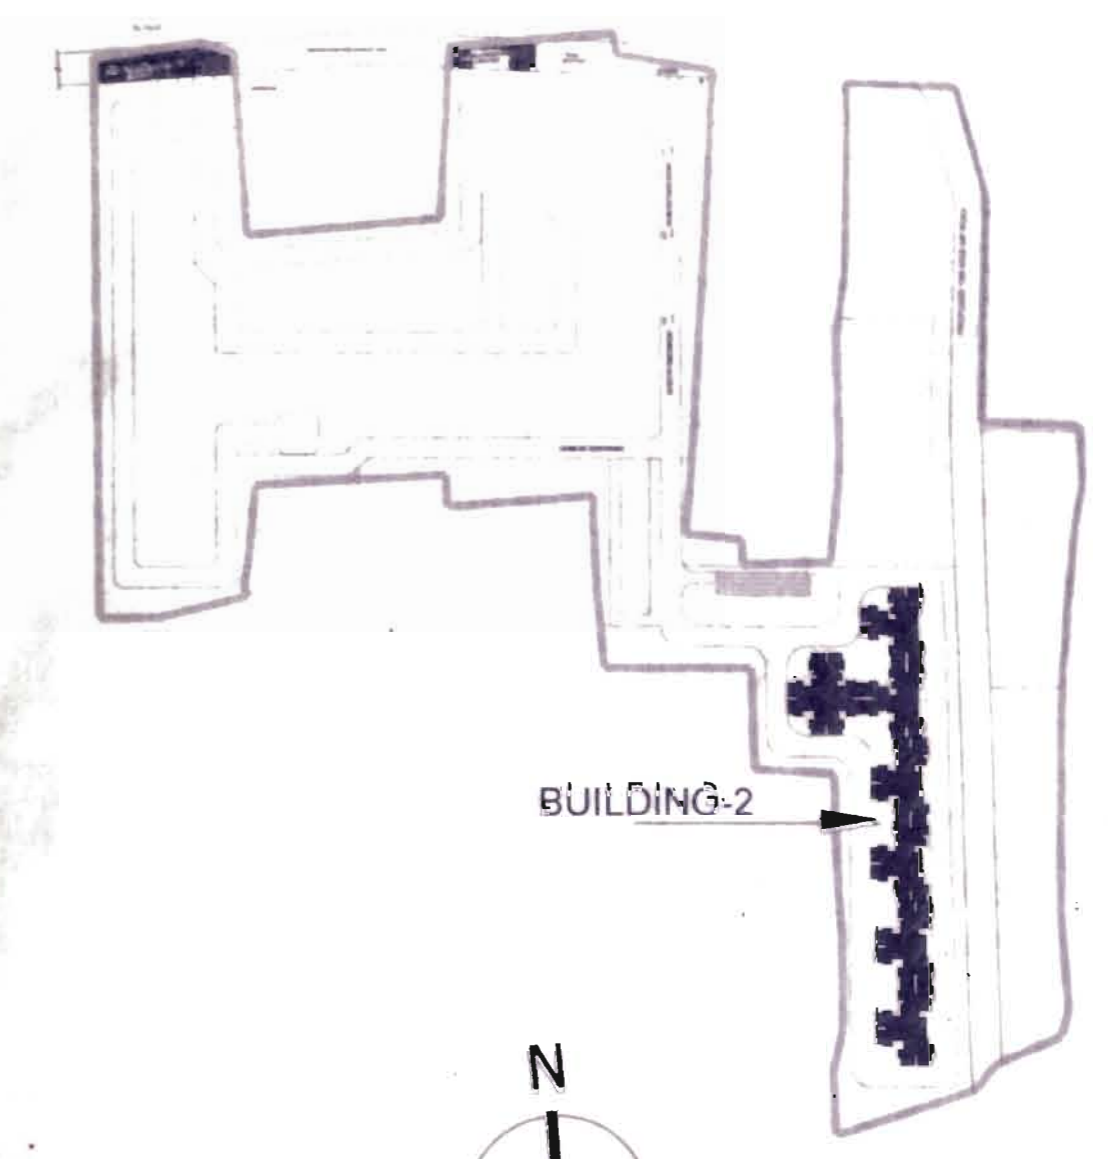

KEY PLAN
NOT TO SCALE

SCHEDULE OF OPENINGS			
TYPE	SIZE	DESCRIPTION	LINTEL
DOORS			
FD1	1100 x 2100	FIRE RATED DOOR	2100
FD2	900 x 1500	FIRE RATED DOOR	2100
FD3	700 x 1500	FIRE RATED DOOR	2100
FD4	1500 x 2100	FIRE RATED DOOR	2100
FD5	2000 x 2100	FIRE RATED DOOR	2100
FD6	900 x 2100	FIRE RATED DOOR	2100
DW1	1550 x 2100	AL. GLAZED SLIDING DOOR	2100
D1	1050 x 2100	FLUSH DOOR	2100
D2	900 x 2100	FLUSH DOOR	2100
D3	700 x 2100	FLUSH DOOR	2100
D4	1500 x 2100	FLUSH DOOR	2100
WINDOWS			
W1	1800x1200	AL. GLAZED SLIDING WINDOW	2100
W2	1500x1200	AL. GLAZED SLIDING WINDOW	2100
W3	740x1200	AL. GLAZED WINDOW	2100
W4	1200x1200	AL. GLAZED SLIDING WINDOW	2100
W5	950x1200	AL. GLAZED WINDOW	2100
W6	800x1200	AL. GLAZED WINDOW	2100
VENTILATORS			
V1	600 X 900	AL. GLAZED VENTILATOR	2100

SCHEDULE OF NOMENCLATURE	
NAME	DESCRIPTION
PHE	PUBLIC HEALTH ENGINEERING
COM	COMMUNICATION
ELE	ELECTRICAL
FHR	FIRE HOSE REEL
BAL	BALCONY
FCC	FIRE COMMAND CENTRE

NOTE:
ALL DIMENSIONS ARE IN MILLIMETERS

ORIENTATION :	SHEET NO :
	05

OWNER'S SIGNATURE :

K.L.SANTOSH
(PARTNER)
ICONICA PROJECTS

ARCHITECT'S SIGNATURE :

MANIRAJ D
BCC/IL-3.6/A-2862/2017-18

PROJECT NAME :
PROPOSED RESIDENTIAL APARTMENT BUILDING
(BUILDING No. 2 (TOWER- 15 TO 21))
IN APPROVED RESIDENTIAL GROUP HOUSING
DEVELOPMENT PLAN
VIDE No.STRRA/TP/DP/05/2016-17, Dtd.03-09-2017
AT KHATA No.1124/150200101700320198
Sy.No. 5/1,5/2,7/2,10/2,44/2,44/5,45/2C,46 & 47
OF MANCHANA HALLI VILLAGE, ATTIBBLE HOBLI,
ANEKAL TALUK, BANGALORE URBAN DISTRICT

PROJECT CONSULTANTS :
Gardencity Realty Pvt Ltd.
ARCHITECTURE DIVISION
SAC-510, HRBR LAYOUT 2nd Block,
Kalyan Nagar, Outer Ring Road,
Bangalore-560043, Tel: +91 80 46664555



SUBJECT OF DRAWING :
SANCTION DRAWING

SHEET No.5/10
BUILDING-2
FIRST FLOOR PLAN

SCALE : 1:150
DATE : 13.07.2018
DRAWN : S.P.
CHECKED : HOK
DRAWING NO : A R 15-2-104

ಇದರಲ್ಲಿ ಎಲ್ಲಾ ಅಳತೆಗಳು ಮಿಮಿಟರಲ್ಲಿ ಇವೆ.
ಇದರಲ್ಲಿ ಎಲ್ಲಾ ಅಳತೆಗಳು ಮಿಮಿಟರಲ್ಲಿ ಇವೆ.
ಇದರಲ್ಲಿ ಎಲ್ಲಾ ಅಳತೆಗಳು ಮಿಮಿಟರಲ್ಲಿ ಇವೆ.
ಇದರಲ್ಲಿ ಎಲ್ಲಾ ಅಳತೆಗಳು ಮಿಮಿಟರಲ್ಲಿ ಇವೆ.
ಇದರಲ್ಲಿ ಎಲ್ಲಾ ಅಳತೆಗಳು ಮಿಮಿಟರಲ್ಲಿ ಇವೆ.


TOTAL NO. OF UNITS AT FIRST FLOOR = 44 NOS.
UNITS BUA < 50 SQMTS= 30 NOS
UNITS BUA > 50 SQMTS= 14 NOS.

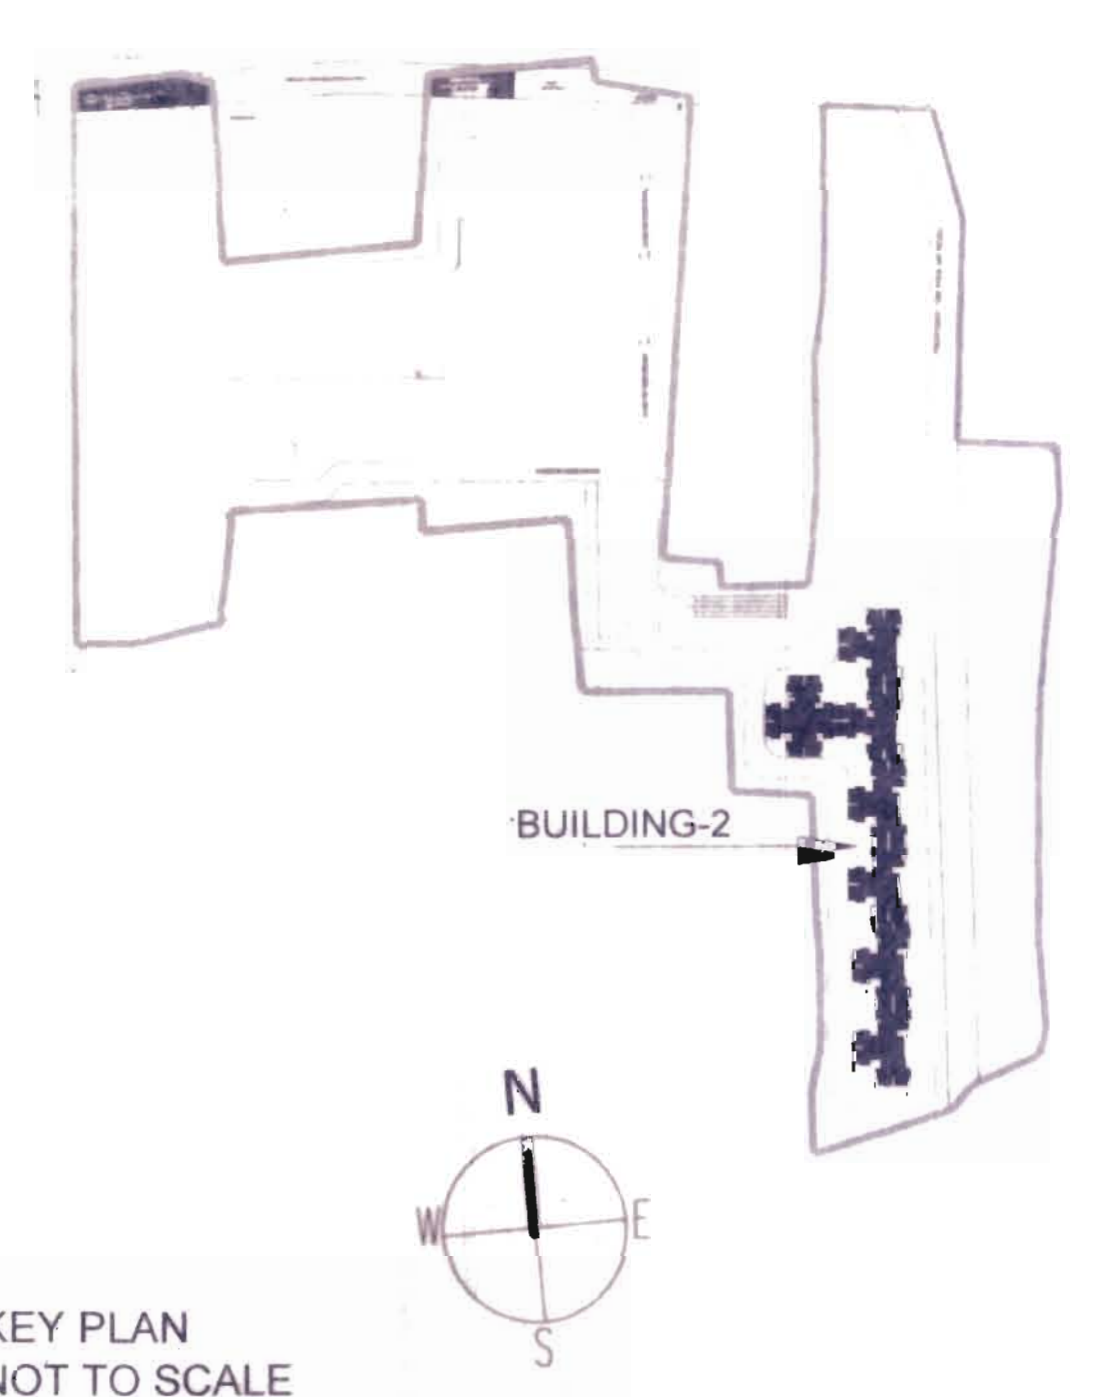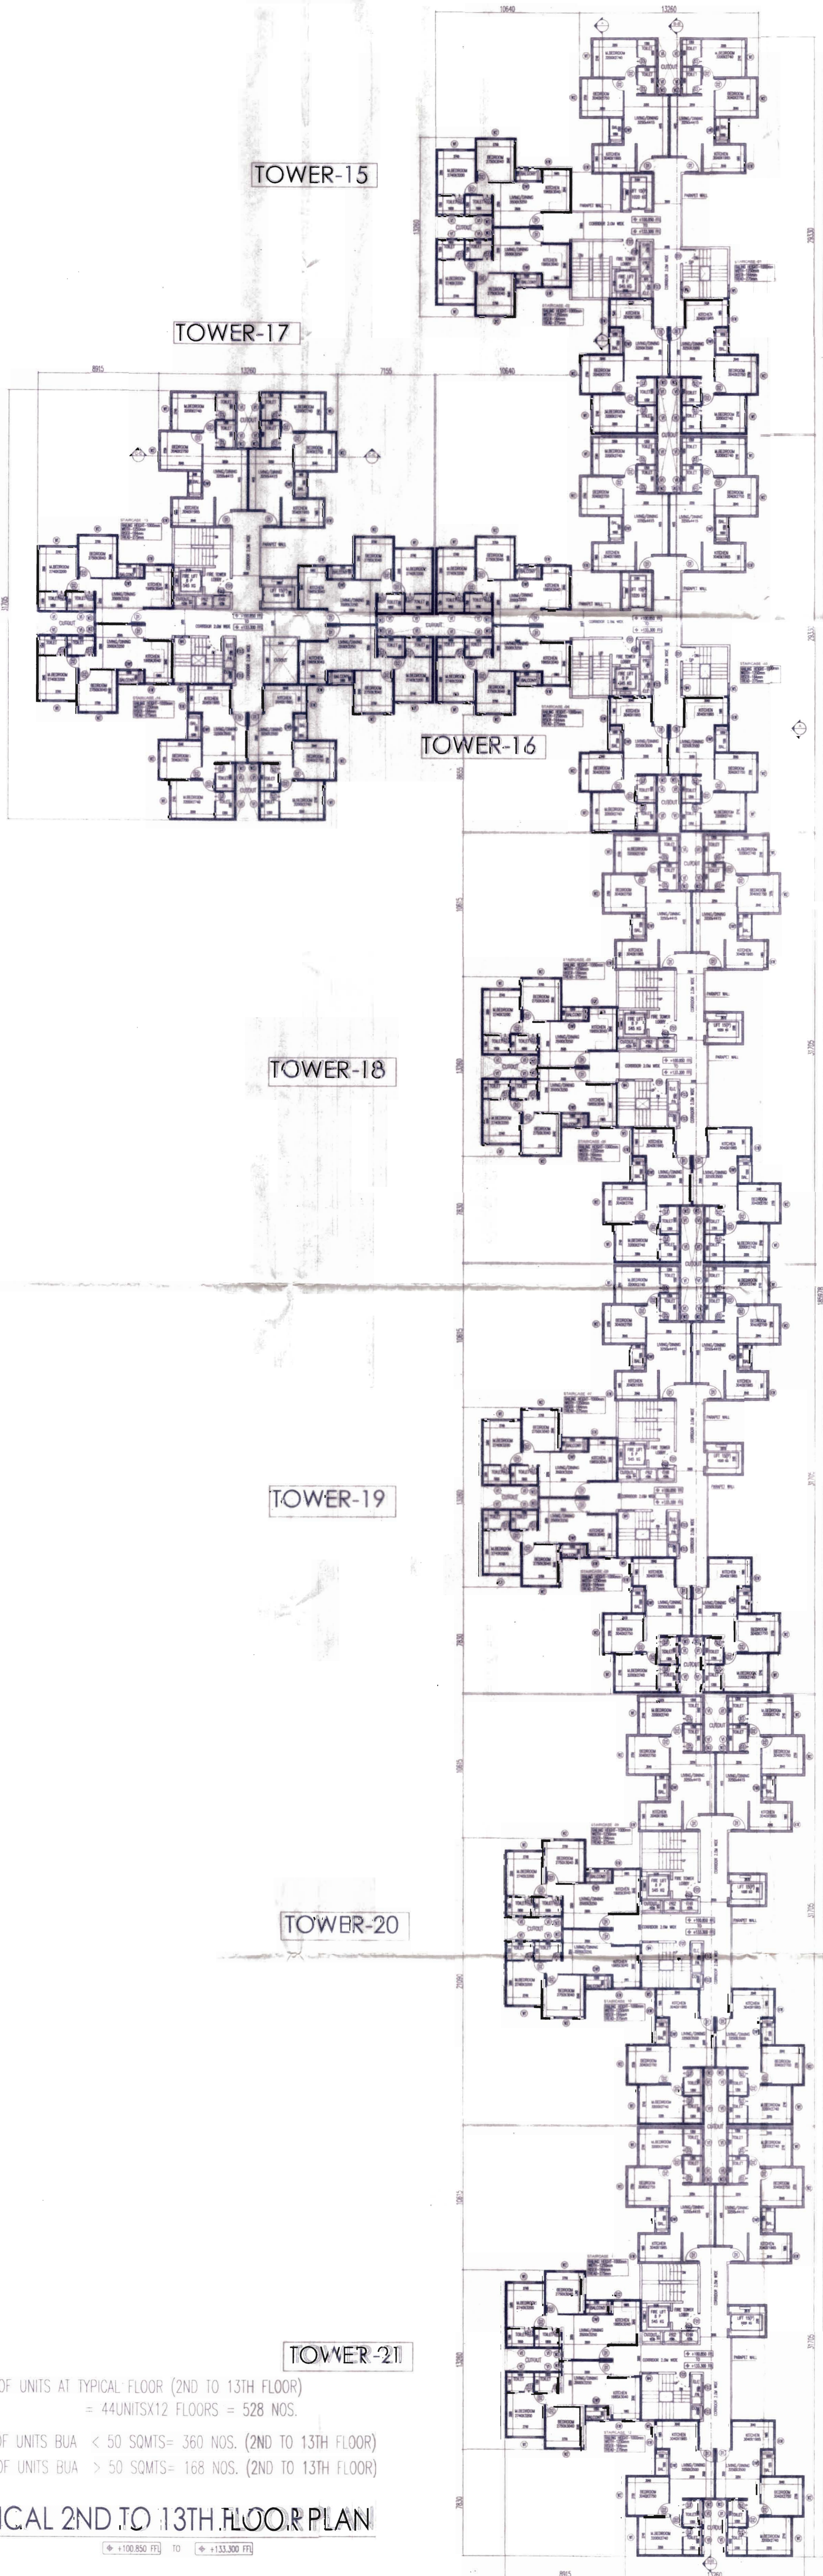

SCHEDULE OF OPENINGS			
TYPE	SIZE	DESCRIPTION	LINTEL
DOORS			
FD1	1100 x 2100	FIRE RATED DOOR	2100
FD2	900 x 1500	FIRE RATED DOOR	2100
FD3	700 x 1500	FIRE RATED DOOR	2100
FD4	1500 x 2100	FIRE RATED DOOR	2100
FD5	2000 x 2100	FIRE RATED DOOR	2100
FD6	900 x 2100	FIRE RATED DOOR	2100
DW1	1550 x 2100	AL GLAZED SLIDING DOOR	2100
D1	1050 x 2100	FLUSH DOOR	2100
D2	900 x 2100	FLUSH DOOR	2100
D3	700 x 2100	FLUSH DOOR	2100
D4	1500 x 2100	FLUSH DOOR	2100
WINDOWS			
W1	1800x1200	AL GLAZED SLIDING WINDOW	2100
W2	1500x1200	AL GLAZED SLIDING WINDOW	2100
W3	740x1200	AL GLAZED WINDOW	2100
W4	1200x1200	AL GLAZED SLIDING WINDOW	2100
W5	950x1200	AL GLAZED WINDOW	2100
W6	800x1200	AL GLAZED WINDOW	2100
VENTILATORS			
V1	600 X 900	AL GLAZED VENTILATOR	2100

SCHEDULE OF NOMENCLATURE	
NAME	DESCRIPTION
PHE	PUBLIC HEALTH ENGINEERING
COM	COMMUNICATION
ELE	ELECTRICAL
FHR	FIRE HOSE REEL
BAL	BALCONY
FCC	FIRE COMMAND CENTRE

NOTE:
ALL DIMENSIONS ARE IN MILLIMETERS

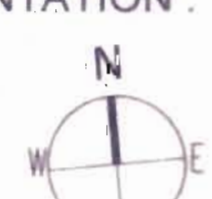ORIENTATION : 

SHEET NO : 06

OWNER'S SIGNATURE : 

K.L. SANTOSH
(PARTNER)
ICONICA PROJECTS

ARCHITECT'S SIGNATURE : 

MANIRAJ D
BCC/BL-3/6/A-2862/2017-18

PROJECT NAME :
PROPOSED RESIDENTIAL APARTMENT BUILDING
[BUILDING No. 2 (TOWER- 15 TO 21)]
IN APPROVED RESIDENTIAL GROUP HOUSING
DEVELOPMENT PLAN
VIDE No STRRPA/TP/DP/05/2016-17, Dtd:08-09-2017
AT KHATA No.1124(150200101700320198)
Sy.Nos. 5/1,5/2,7/2,10/2,44/2,44/5,45/2C,46 & 47
OF MANCHANAHALI VILLAGE, ATTIBELE HOBLI,
ANEKAL TALUK, BANGALORE URBAN DISTRICT

PROJECT CONSULTANTS :
Gardencity Realty Pvt Ltd.
ARCHITECTURE DIVISION
5AC-510, HRBR LAYOUT 2nd Block,
Kalyan Nagar, Outer Ring Road,
Bengaluru-560043, Tel: +91 80 46664555



SUBJECT OF DRAWING :
SANCTION DRAWING

SHEET No.6/10
BUILDING-2
TYPICAL FLOOR PLAN-2ND FLOOR TO 13TH FLOOR

SCALE : 1:150
DATE : 23.07.2018
DRAWN : S.P.
CHECKED : ASHOK
DRAWING NO : A-BLDG-2-105

TOTAL NO. OF UNITS AT TYPICAL FLOOR (2ND TO 13TH FLOOR)
= 44UNITSX12 FLOORS = 528 NOS.

TOTAL NO. OF UNITS BUA < 50 SQMTS= 360 NOS. (2ND TO 13TH FLOOR)

TOTAL NO. OF UNITS BUA > 50 SQMTS= 168 NOS. (2ND TO 13TH FLOOR)

TYPICAL 2ND TO 13TH FLOOR PLAN

◆ +100.850 FT) TO ◆ +133.300 FT)

TOTAL NO. OF UNITS AT 14TH FLOOR = 26 NOS.
UNITS BUA < 50 SQMTS= 18 NOS
UNITS BUA > 50 SQMTS= 08 NOS.

14TH FLOOR PLAN

◆ +136.250 (M)

TOWER-15

TOWER-17



TOWER-16

TOWER-18

TOWER-19

TOWER-20

TOWER-21

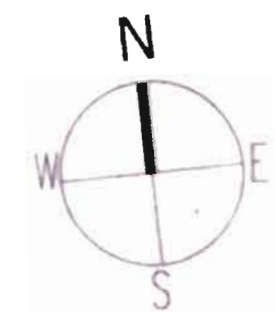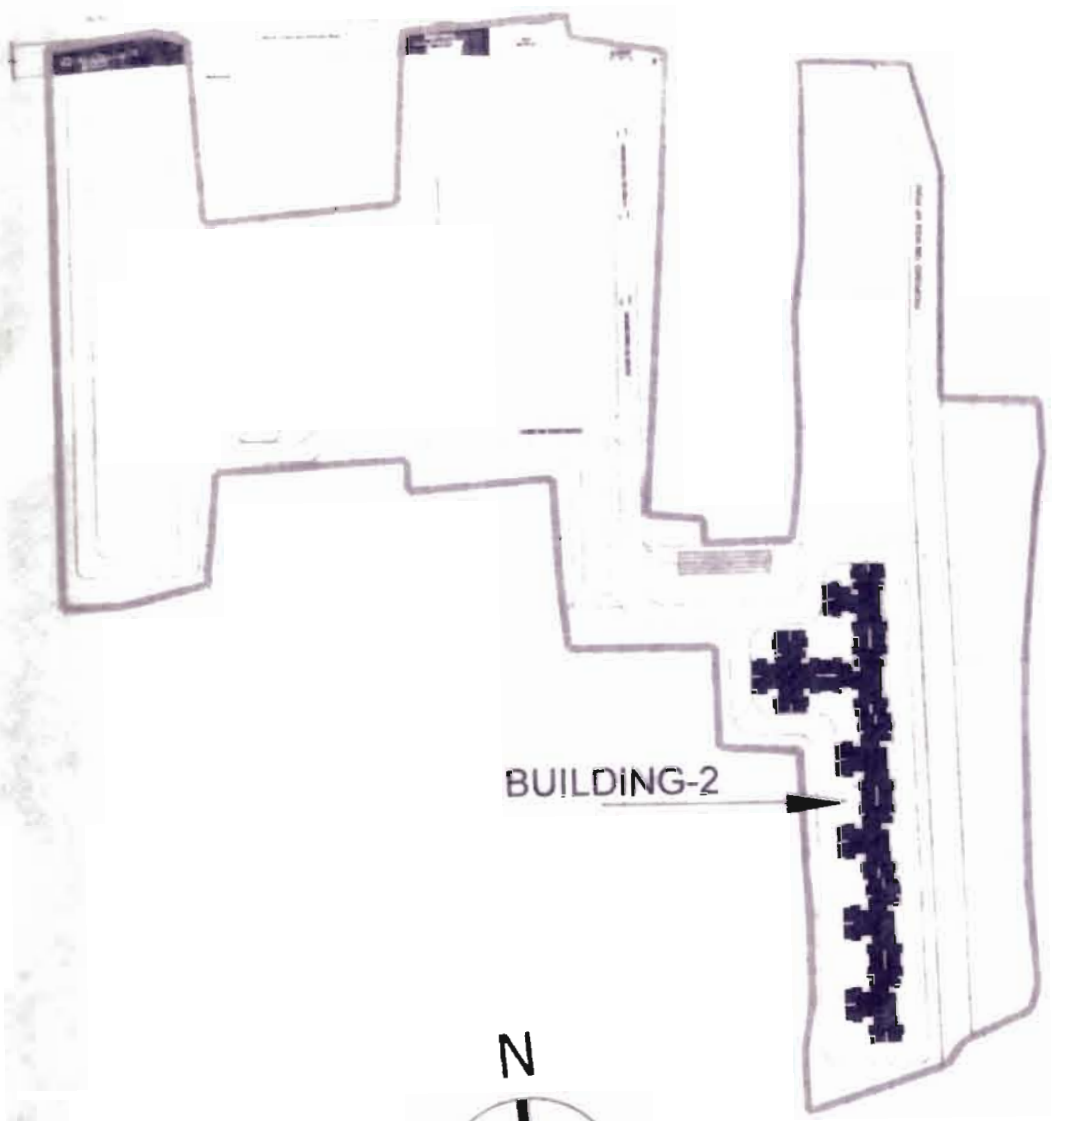

KEY PLAN
NOT TO SCALE

SCHEDULE OF OPENINGS

TYPE	SIZE	DESCRIPTION	LINTEL
DOORS			
FD1	1100 x 2100	FIRE RATED DOOR	2100
FD2	900 x 1500	FIRE RATED DOOR	2100
FD3	700 x 1500	FIRE RATED DOOR	2100
FD4	1500 x 2100	FIRE RATED DOOR	2100
FD5	2000 x 2100	FIRE RATED DOOR	2100
FD6	900 x 2100	FIRE RATED DOOR	2100
DW1	1550 x 2100	AL. GLAZED SLIDING DOOR	2100
D1	1050 x 2100	FLUSH DOOR	2100
D2	900 x 2100	FLUSH DOOR	2100
D3	700 x 2100	FLUSH DOOR	2100
D4	1500 x 2100	FLUSH DOOR	2100
WINDOWS			
W1	1800x1200	AL. GLAZED SLIDING WINDOW	2100
W2	1500x1200	AL. GLAZED SLIDING WINDOW	2100
W3	740x1200	AL. GLAZED WINDOW	2100
W4	1200x1200	AL. GLAZED SLIDING WINDOW	2100
W5	950x1200	AL. GLAZED WINDOW	2100
KW	800x1200	AL. GLAZED WINDOW	2100
VENTILATORS			
V1	600 x 900	AL. GLAZED VENTILATOR	2100


SCHEDULE OF NOMENCLATURE

NAME	DESCRIPTION
PHE	PUBLIC HEALTH ENGINEERING
COM	COMMUNICATION
ELE	ELECTRICAL
FHR	FIRE HOSE REEL
BAL	BALCONY
FCC	FIRE COMMAND CENTRE

NOTE :

ALL DIMENSIONS ARE IN MILLIMETERS

ORIENTATION :

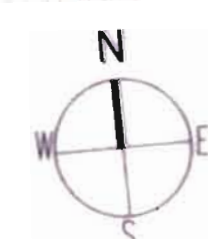

SHEET NO :

07

OWNER'S SIGNATURE :

K.L.SANTOSH
(PARTNER)
ICONICA PROJECTS

ARCHITECT'S SIGNATURE :

MANIRAJ.D
BCC/BL-3 B/A-2862/2017-18

PROJECT NAME :

PROPOSED RESIDENTIAL APARTMENT BUILDING
(BUILDING No. 2 (TOWER- 15 To 21)
IN APPROVED RESIDENTIAL GROUP HOUSING
DEVELOPMENT PLAN
VIDE No.STRRPA/TP/DP/05/2016-17, Dtd:08-09-2017
AT KHATA No.1124(150200101700320198)
Sy.Nos. 5/1.5/2.7/2.10/2.44/2.44/5.45/2C.46 & 47
OF MANCHANAHALLI VILLAGE, ATTIBELE HOBLI,
ANEKAL TALUK, BANGALORE URBAN DISTRICT

PROJECT CONSULTANTS

**Gardencity
Realty Pvt Ltd.**

ARCHITECTURE DIVISION
54C-510, HRBR LAYOUT 2nd Block,
Kalyan Nagar, Outer Ring Road,
Bangalore-560043, Tel: +91 80 46664555




SUBJECT OF DRAWING :
SANCTION DRAWING


SHEET No.7/11
BUILDING-2
14TH FLOOR PLAN

SCALE : 1:150 DATE : 20/07/2018
DRAWN : S.P. CHECKED : ASHOK

DRAWING NO : 4 B.DC 2-106

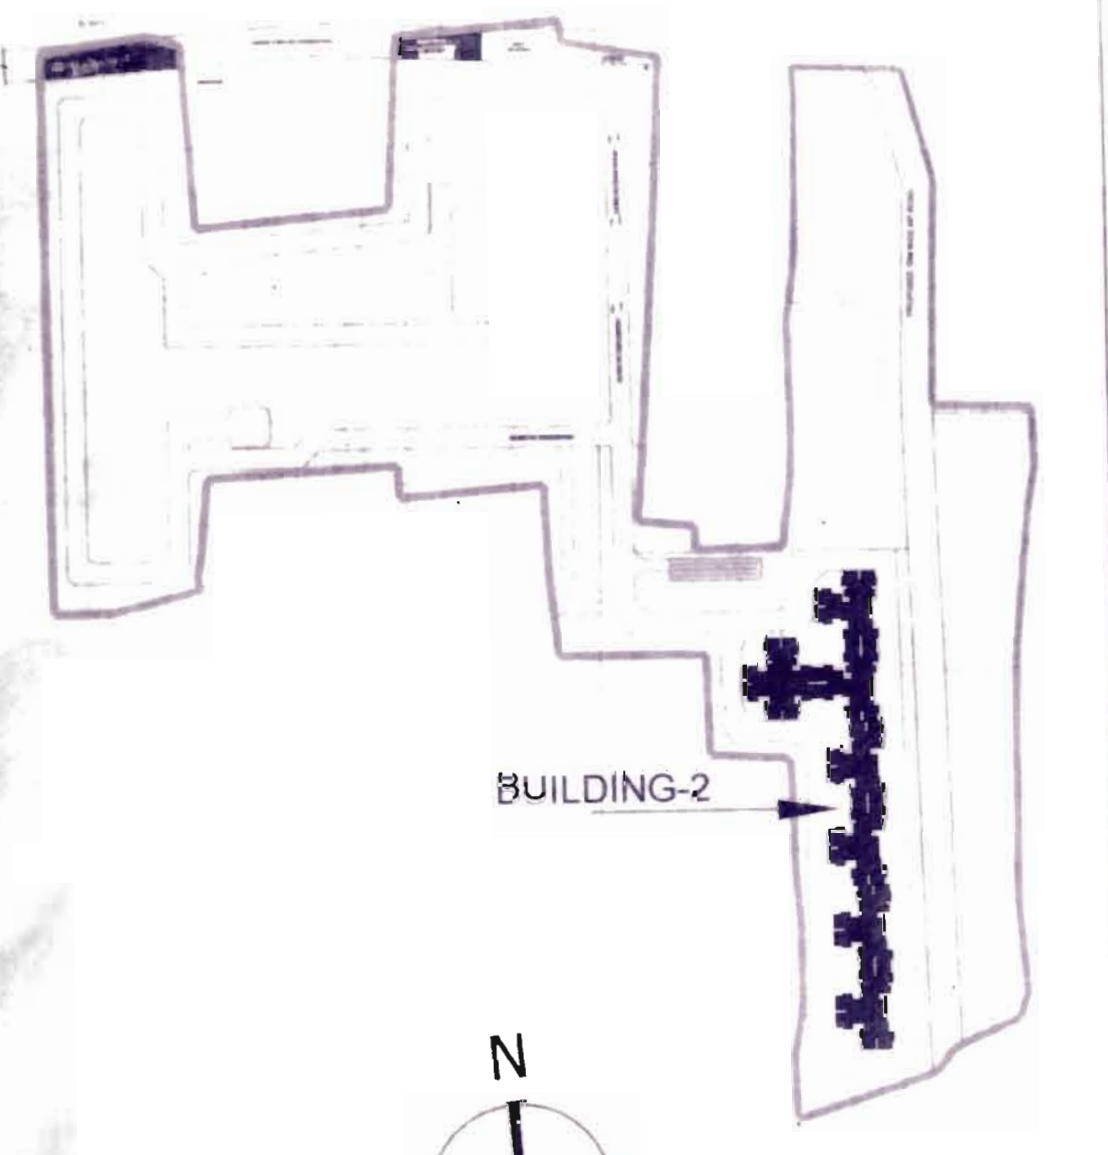

KEY PLAN
NOT TO SCALE

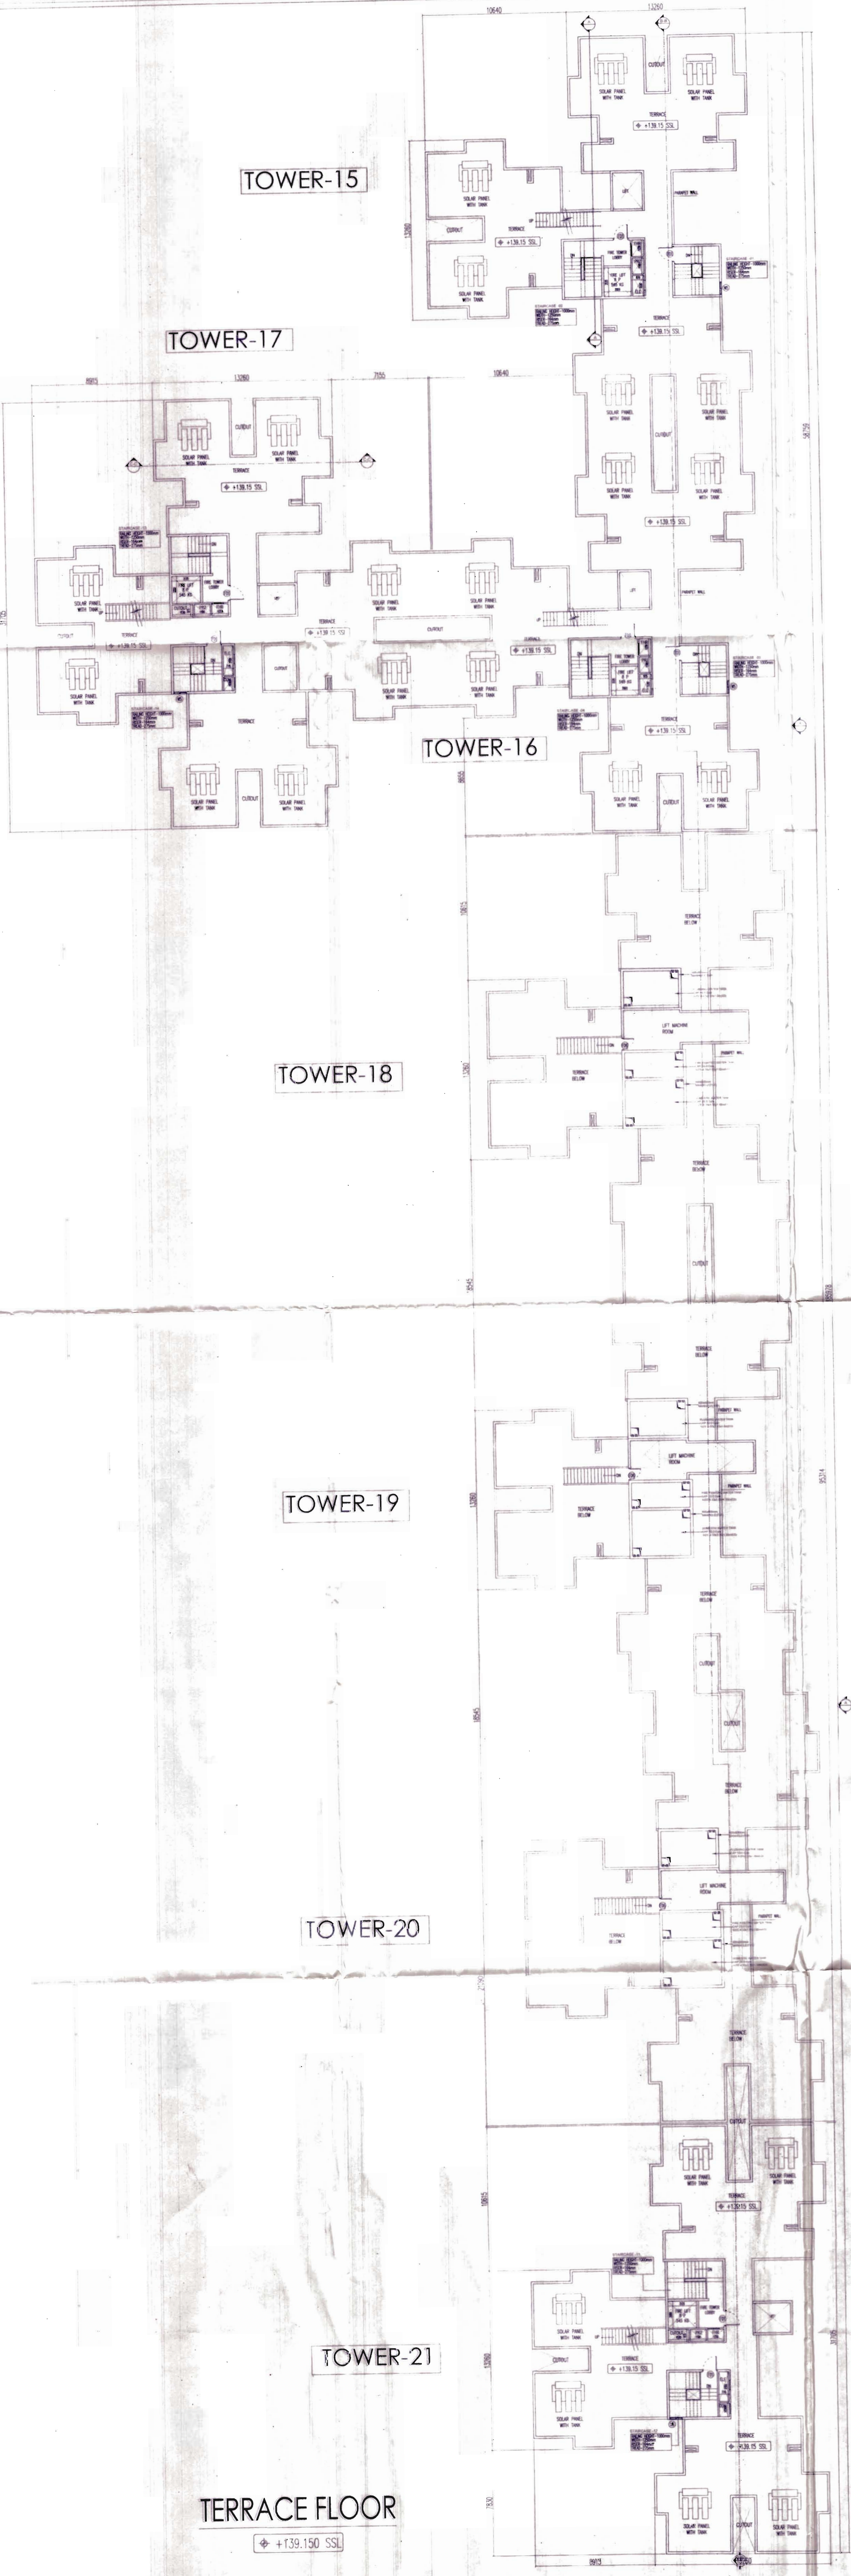

SCHEDULE OF OPENINGS			
TYPE	SIZE	DESCRIPTION	LINTEL
DOORS			
FD1	1100 x 2100	FIRE RATED DOOR	2100
FD2	900 x 1500	FIRE RATED DOOR	2100
FD3	700 x 1500	FIRE RATED DOOR	2100
FD4	1500 x 2100	FIRE RATED DOOR	2100
FD5	2000 x 2100	FIRE RATED DOOR	2100
FD6	900 x 2100	FIRE RATED DOOR	2100
DW1	1550 x 2100	AL. GLAZED SLIDING DOOR	2100
D7	1050 x 2100	FLUSH DOOR	2100
D2	900 x 2100	FLUSH DOOR	2100
D3	700 x 2100	FLUSH DOOR	2100
D4	1500 x 2100	FLUSH DOOR	2100
WINDOWS			
W1	1800x1200	AL. GLAZED SLIDING WINDOW	2100
W2	1500x1200	AL. GLAZED SLIDING WINDOW	2100
W3	740x1200	AL. GLAZED WINDOW	2100
W4	1200x1200	AL. GLAZED SLIDING WINDOW	2100
W5	950x1200	AL. GLAZED WINDOW	2100
KW	800x1200	AL. GLAZED WINDOW	2100
VENTILATORS			
V1	600 x 900	AL. GLAZED VENTILATOR	2100

SCHEDULE OF NOMENCLATURE	
NAME	DESCRIPTION
PHE	PUBLIC HEALTH ENGINEERING
COM	COMMUNICATION
ELE	ELECTRICAL
FHR	FIRE HOSE REEL
BAL	BALCONY
FCC	FIRE COMMAND CENTRE

NOTE:
ALL DIMENSIONS ARE IN MILLIMETERS

ORIENTATION :	SHEET NO :
	08

OWNER'S SIGNATURE :

K.L.SANTOSH
(PARTNER)
ICONICA PROJECTS

ARCHITECT'S SIGNATURE

MAHARAJD
BCC/BL-3.6/A-2862/2017-18

PROJECT NAME :
PROPOSED RESIDENTIAL APARTMENT BUILDING
(BUILDING No. 2 (TOWER- 15 To 21)
IN APPROVED RESIDENTIAL GROUP HOUSING
DEVELOPMENT PLAN
VIDE No.STR/PA/TP/DP/05/2016-17, Dtd:08-09-2017
AT KHATA No.1124(150200101700320198)
Sy.Nos. 5/1,5/2,7/2,10/2,44/2,44/5,45/2,C,46 & 47
OF MANCHANAHALLI VILLAGE, ATTIBELE HOBLI,
ANEKAL TALUK, BANGALORE URBAN DISTRICT


PROJECT CONSULTANTS :
Gardencity Realty Pvt Ltd.
ARCHITECTURE DIVISION
SAC-510, HRBR LAYOUT 2nd Block,
Kalyan Nagar, Outer Ring Road,
Bengaluru-560043, Tel: +91 80 46664555

SUBJECT OF DRAWING :
SANCTION DRAWING


SHEET No.8/10
BUILDING-2
TERRACE PLAN

SCALE : 1:150
DATE : 23.07.2018
DRAWN : SP
CHECKED : A.P.

DRAWING NO : A BLDG-2-107

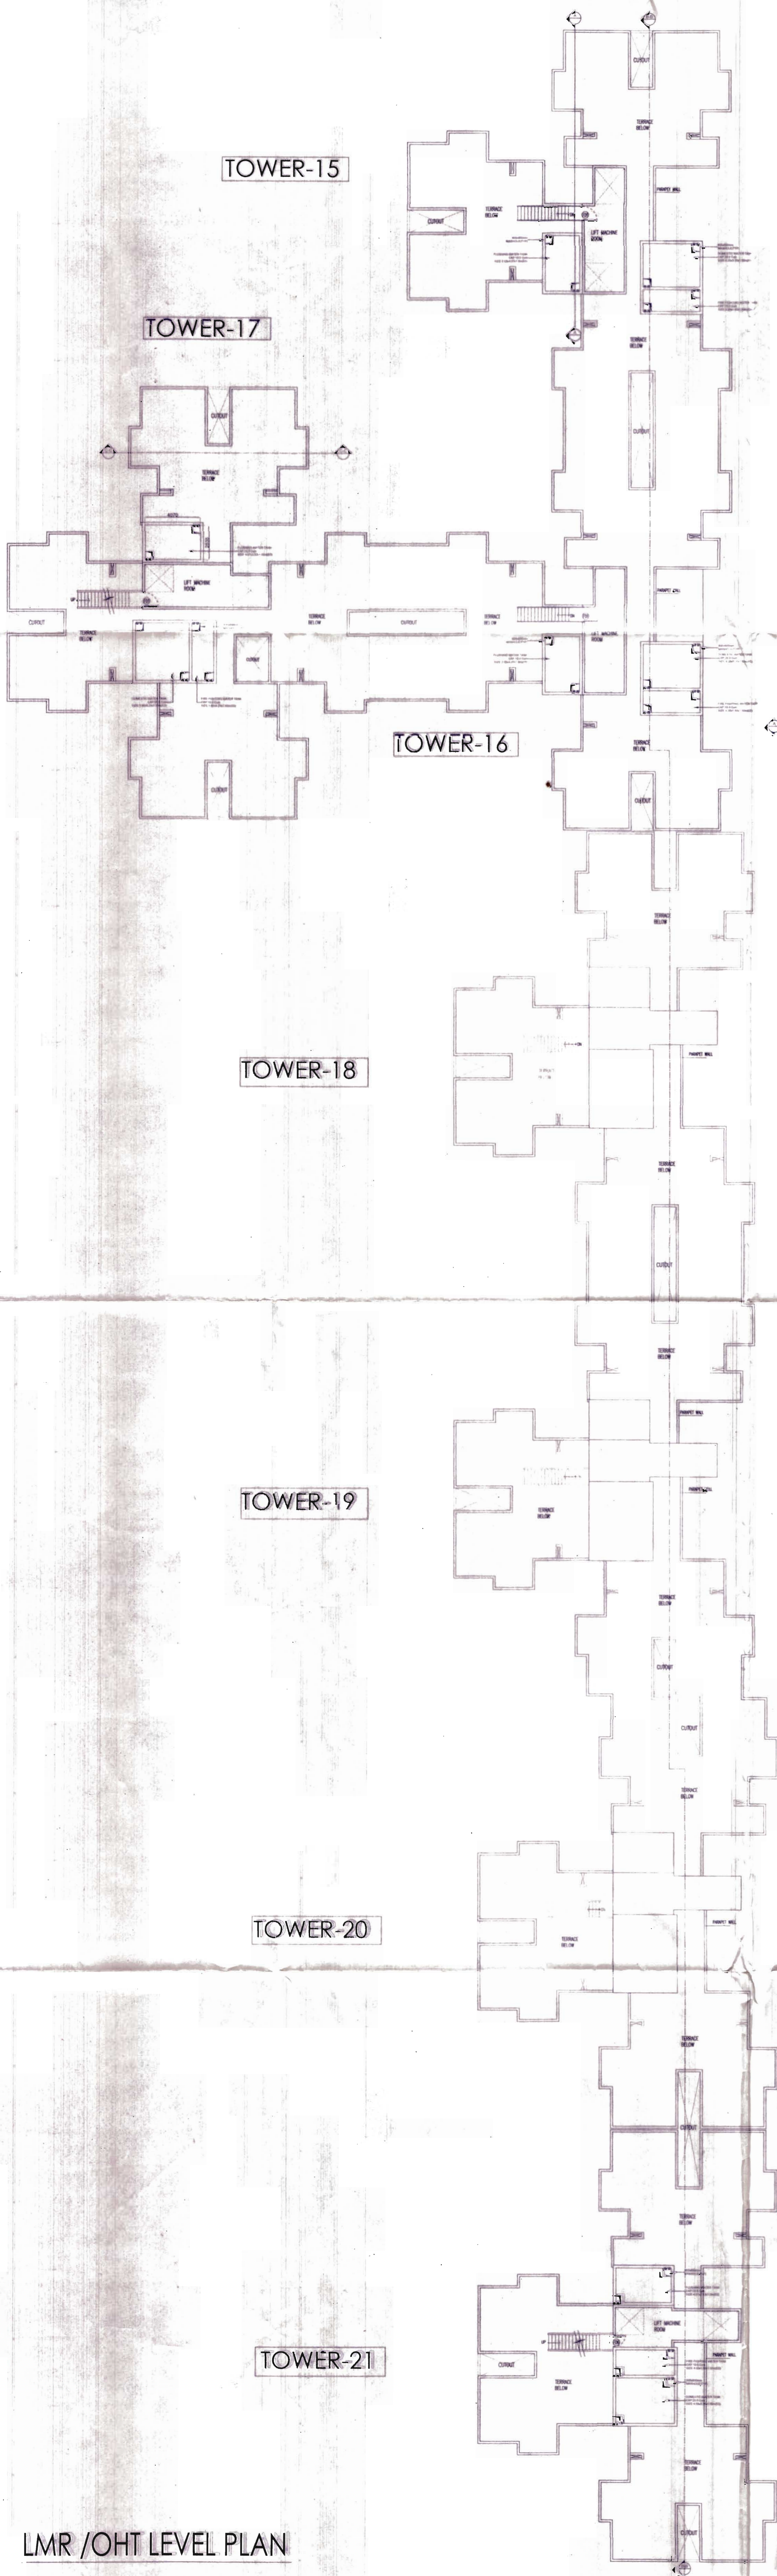

LMR /OHT LEVEL PLAN

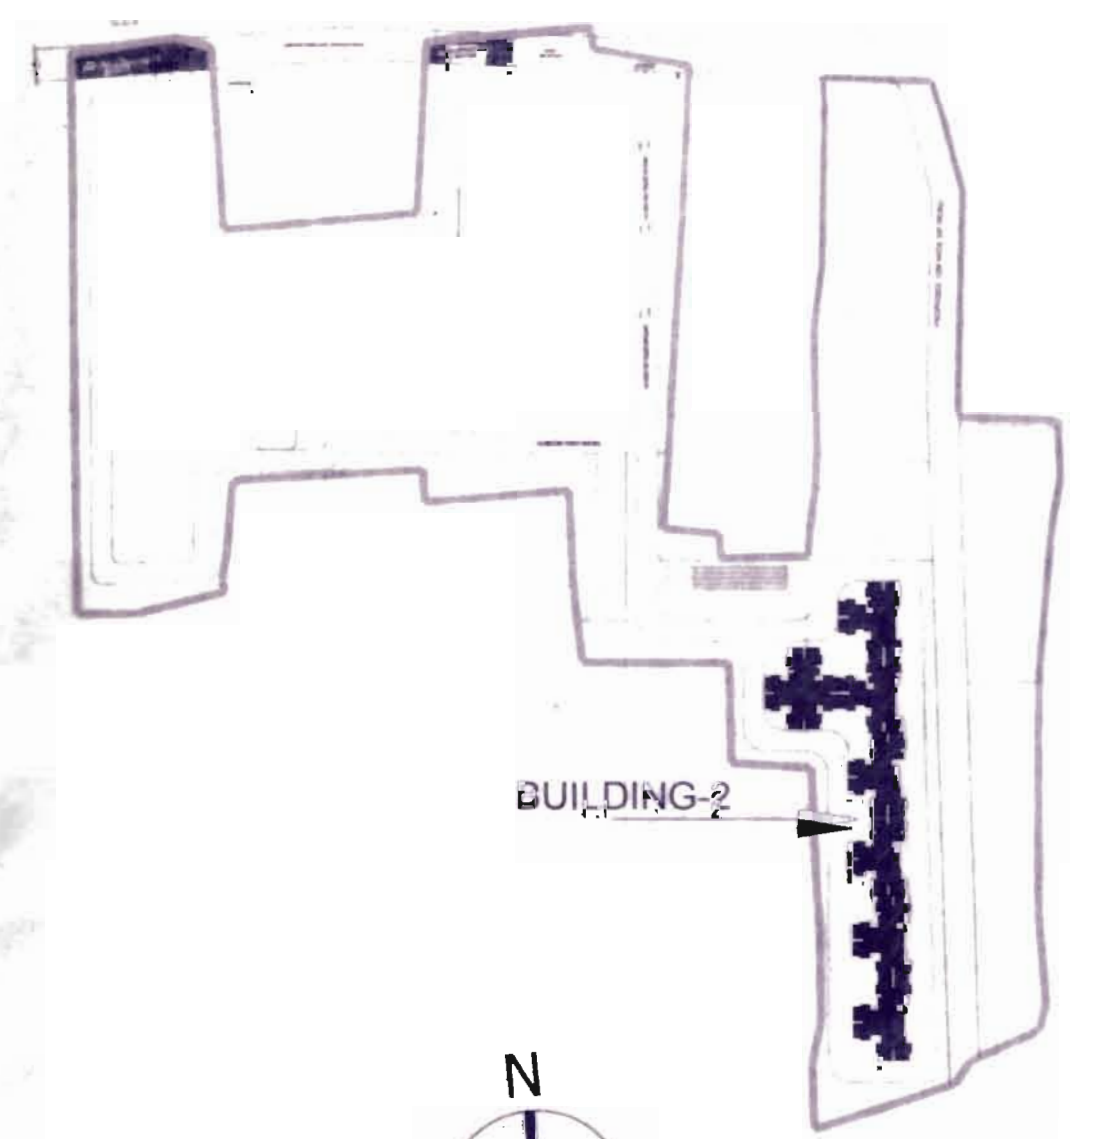


KEY PLAN
NOT TO SCALE

SCHEDULE OF OPENINGS			
TYPE	SIZE	DESCRIPTION	LINTEL
DOORS			
FD1	1100 x 2100	FIRE RATED DOOR	2100
FD2	900 x 1500	FIRE RATED DOOR	2100
FD3	700 x 1500	FIRE RATED DOOR	2100
FD4	1500 x 2100	FIRE RATED DOOR	2100
FD5	2000 x 2100	FIRE RATED DOOR	2100
FD6	900 x 2100	FIRE RATED DOOR	2100
DW1	1550 x 2100	AL GLAZED SLIDING DOOR	2100
D1	1050 x 2100	FLUSH DOOR	2100
D2	900 x 2100	FLUSH DOOR	2100
D3	700 x 2100	FLUSH DOOR	2100
D4	1500 x 2100	FLUSH DOOR	2100
WINDOWS			
W1	1800x1200	AL GLAZED SLIDING WINDOW	2100
W2	1500x1200	AL GLAZED SLIDING WINDOW	2100
W3	740x1200	AL GLAZED WINDOW	2100
W4	1200x1200	AL GLAZED SLIDING WINDOW	2100
W5	950x1200	AL GLAZED WINDOW	2100
KW	800x1200	AL GLAZED WINDOW	2100
VENTILATORS			
V1	600 X 900	AL GLAZED VENTILATOR	2100

SCHEDULE OF NOMENCLATURE	
NAME	DESCRIPTION
PHE	PUBLIC HEALTH ENGINEERING
COM	COMMUNICATION
ELE	ELECTRICAL
FHR	FIRE HOSE REEL
BAL	BALCONY
FCC	FIRE COMMAND CENTRE

NOTE:
ALL DIMENSIONS ARE IN MILLIMETERS

ORIENTATION:

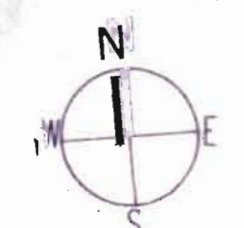

SHEET NO.:

09

OWNER'S SIGNATURE:

[Signature]

RIL SANTOSH
(PARTNER)
BANGALORE

ARCHITECT'S SIGNATURE:

[Signature]

MANIPAL
BCC/BL-4/34-286/2017-18

PROJECT NAME:
PROPOSED RESIDENTIAL APARTMENT BUILDING
(BUILDING NO. 2 (TOWER- 15 TO 21))
IN APPROVED RESIDENTIAL GROUP HOUSING
DEVELOPMENT PLAN
VIDE No.STRP/AT/DP/05/2016-17, Dt:08-09-2017
AT KHATA No.1124(150200101700320198)
Sy Nos. 5/1,5/2,7 2,10/2,44/2,44/2,45-2C-46 & 47
OF MANCHANAHALI VILLAGE, ATTIBELE HOBLI,
ANEKAL TALUK, BANGALORE URBAN DISTRICT

PROJECT CONSULTANTS:

Gardencity Realty Pvt Ltd

ARCHITECTURE DIVISION
SAC-510, HRBR LAYOUT 2nd Block,
Kalyan Nagar, Outer Ring Road,
Bangalore-560043, Tel: +91 80 46664555



SUBJECT OF DRAWING:
SANCTION DRAWING

SHEET No.9/10
BUILDING-2
LMR LEVEL PLAN

SCALE : 1:150
DATE : 23.07.2018
DRAWN : S.P
CHECKED : ASHOK

DRAWING NO : A-BLDG-2-108