
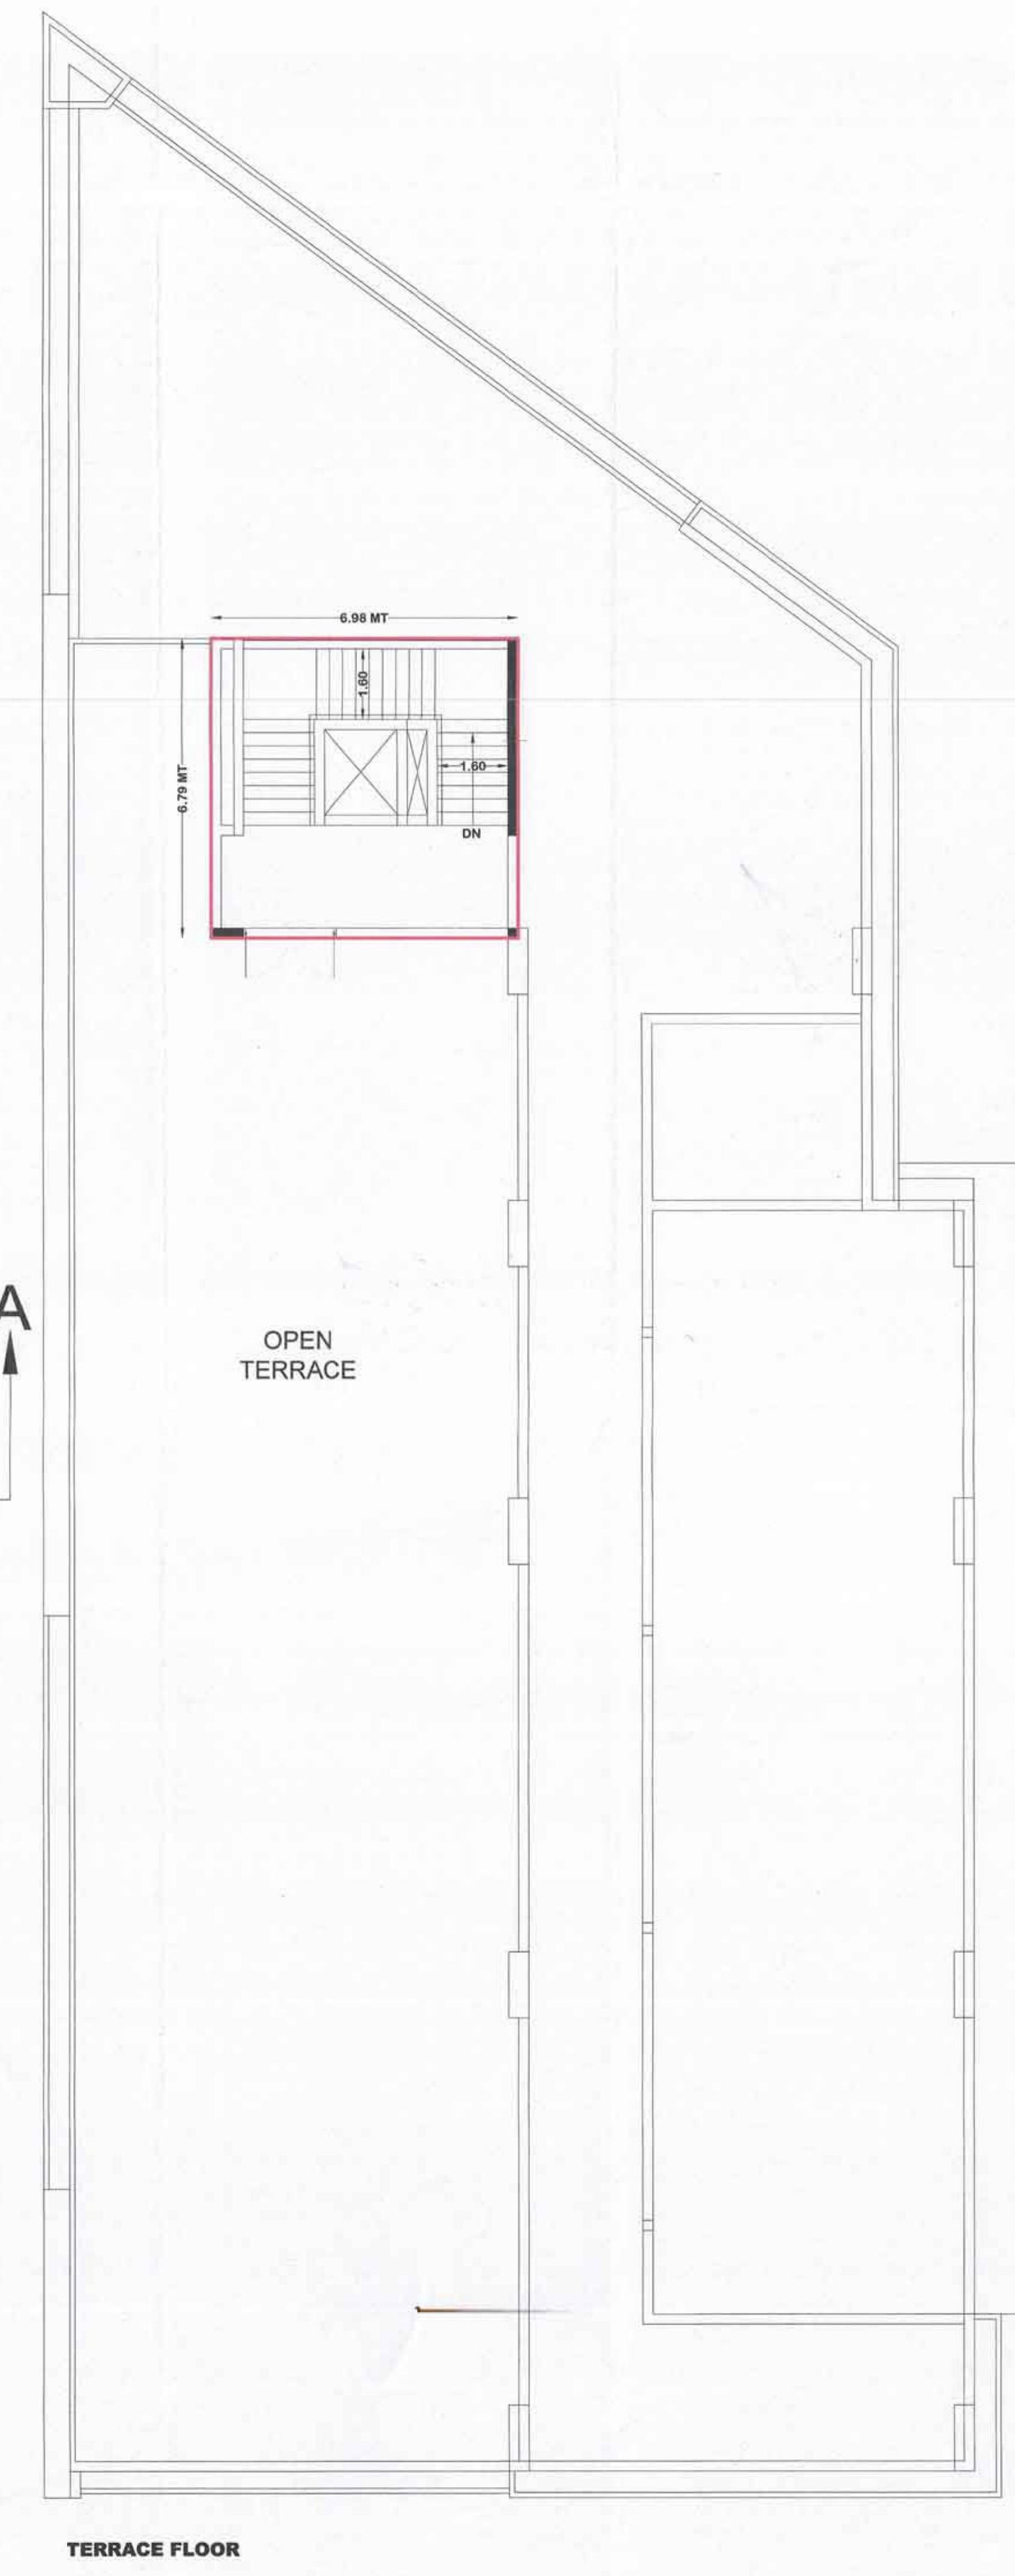
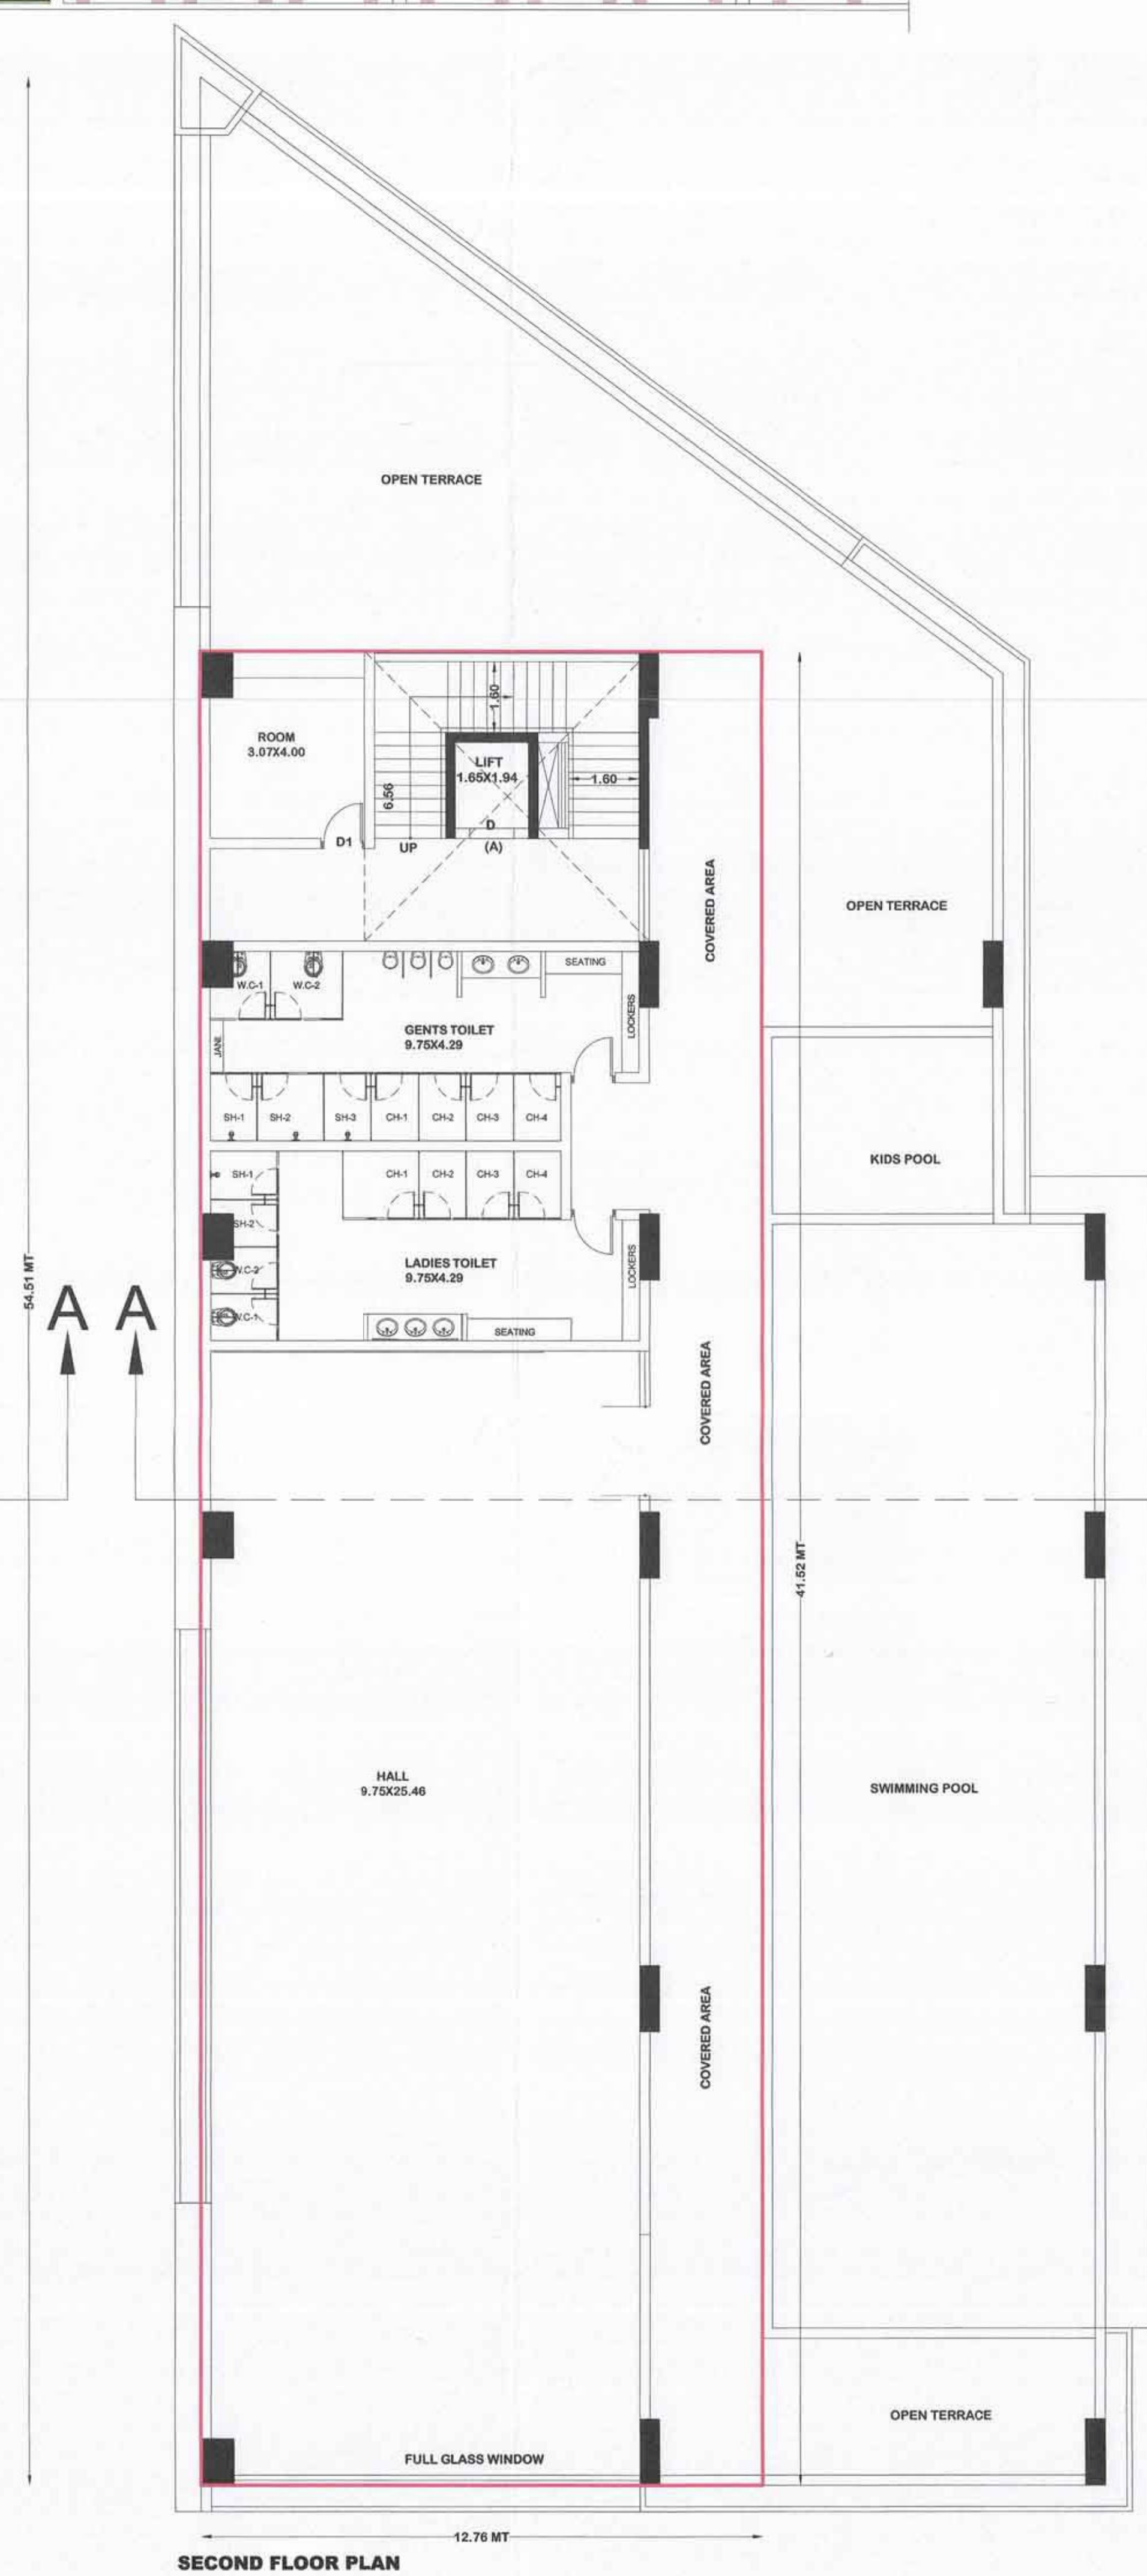
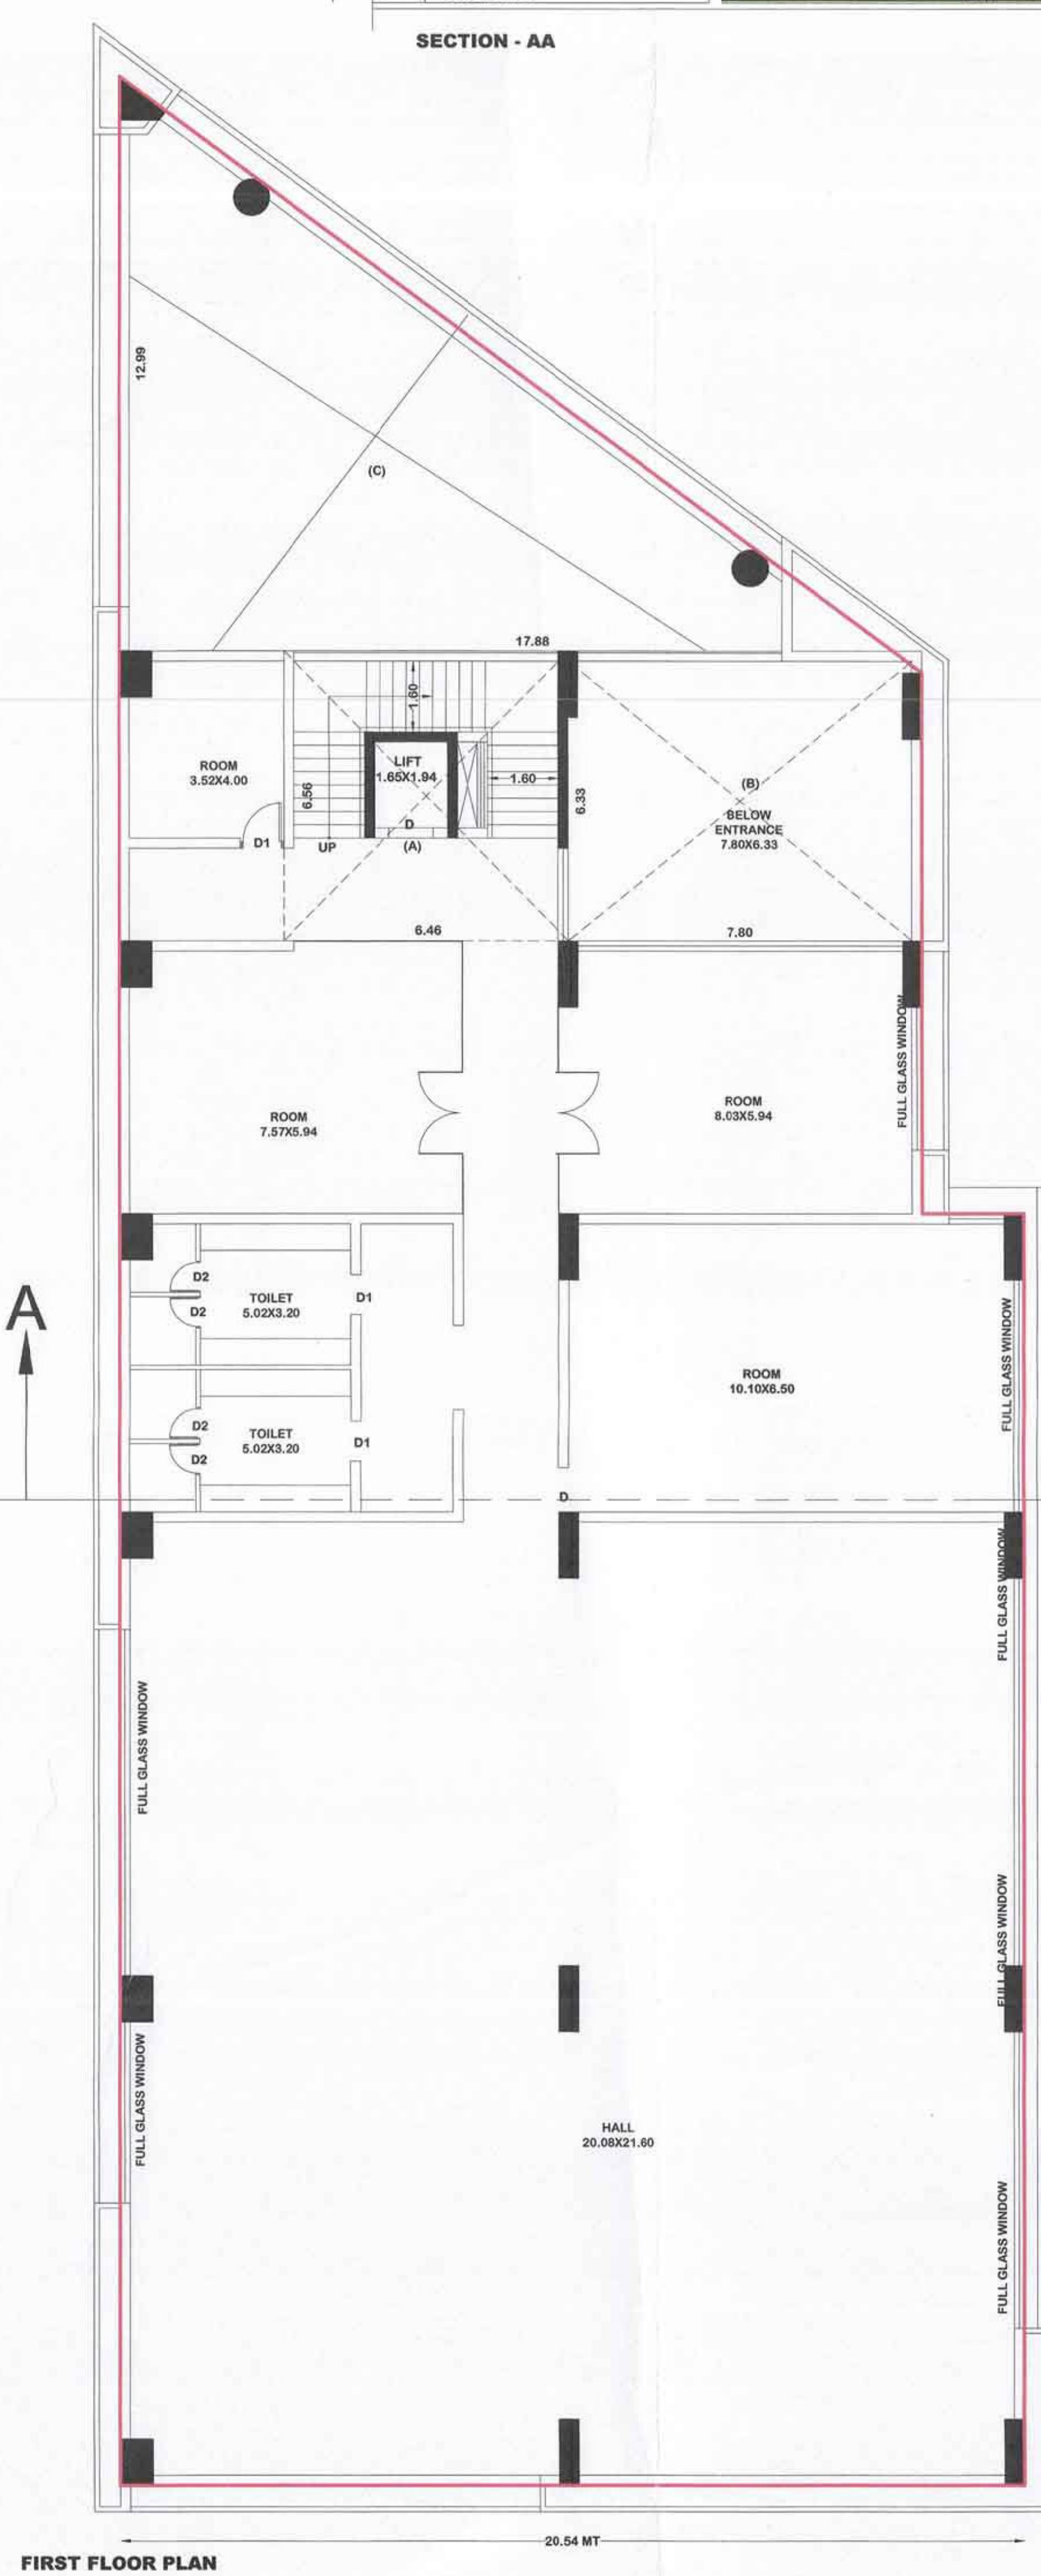
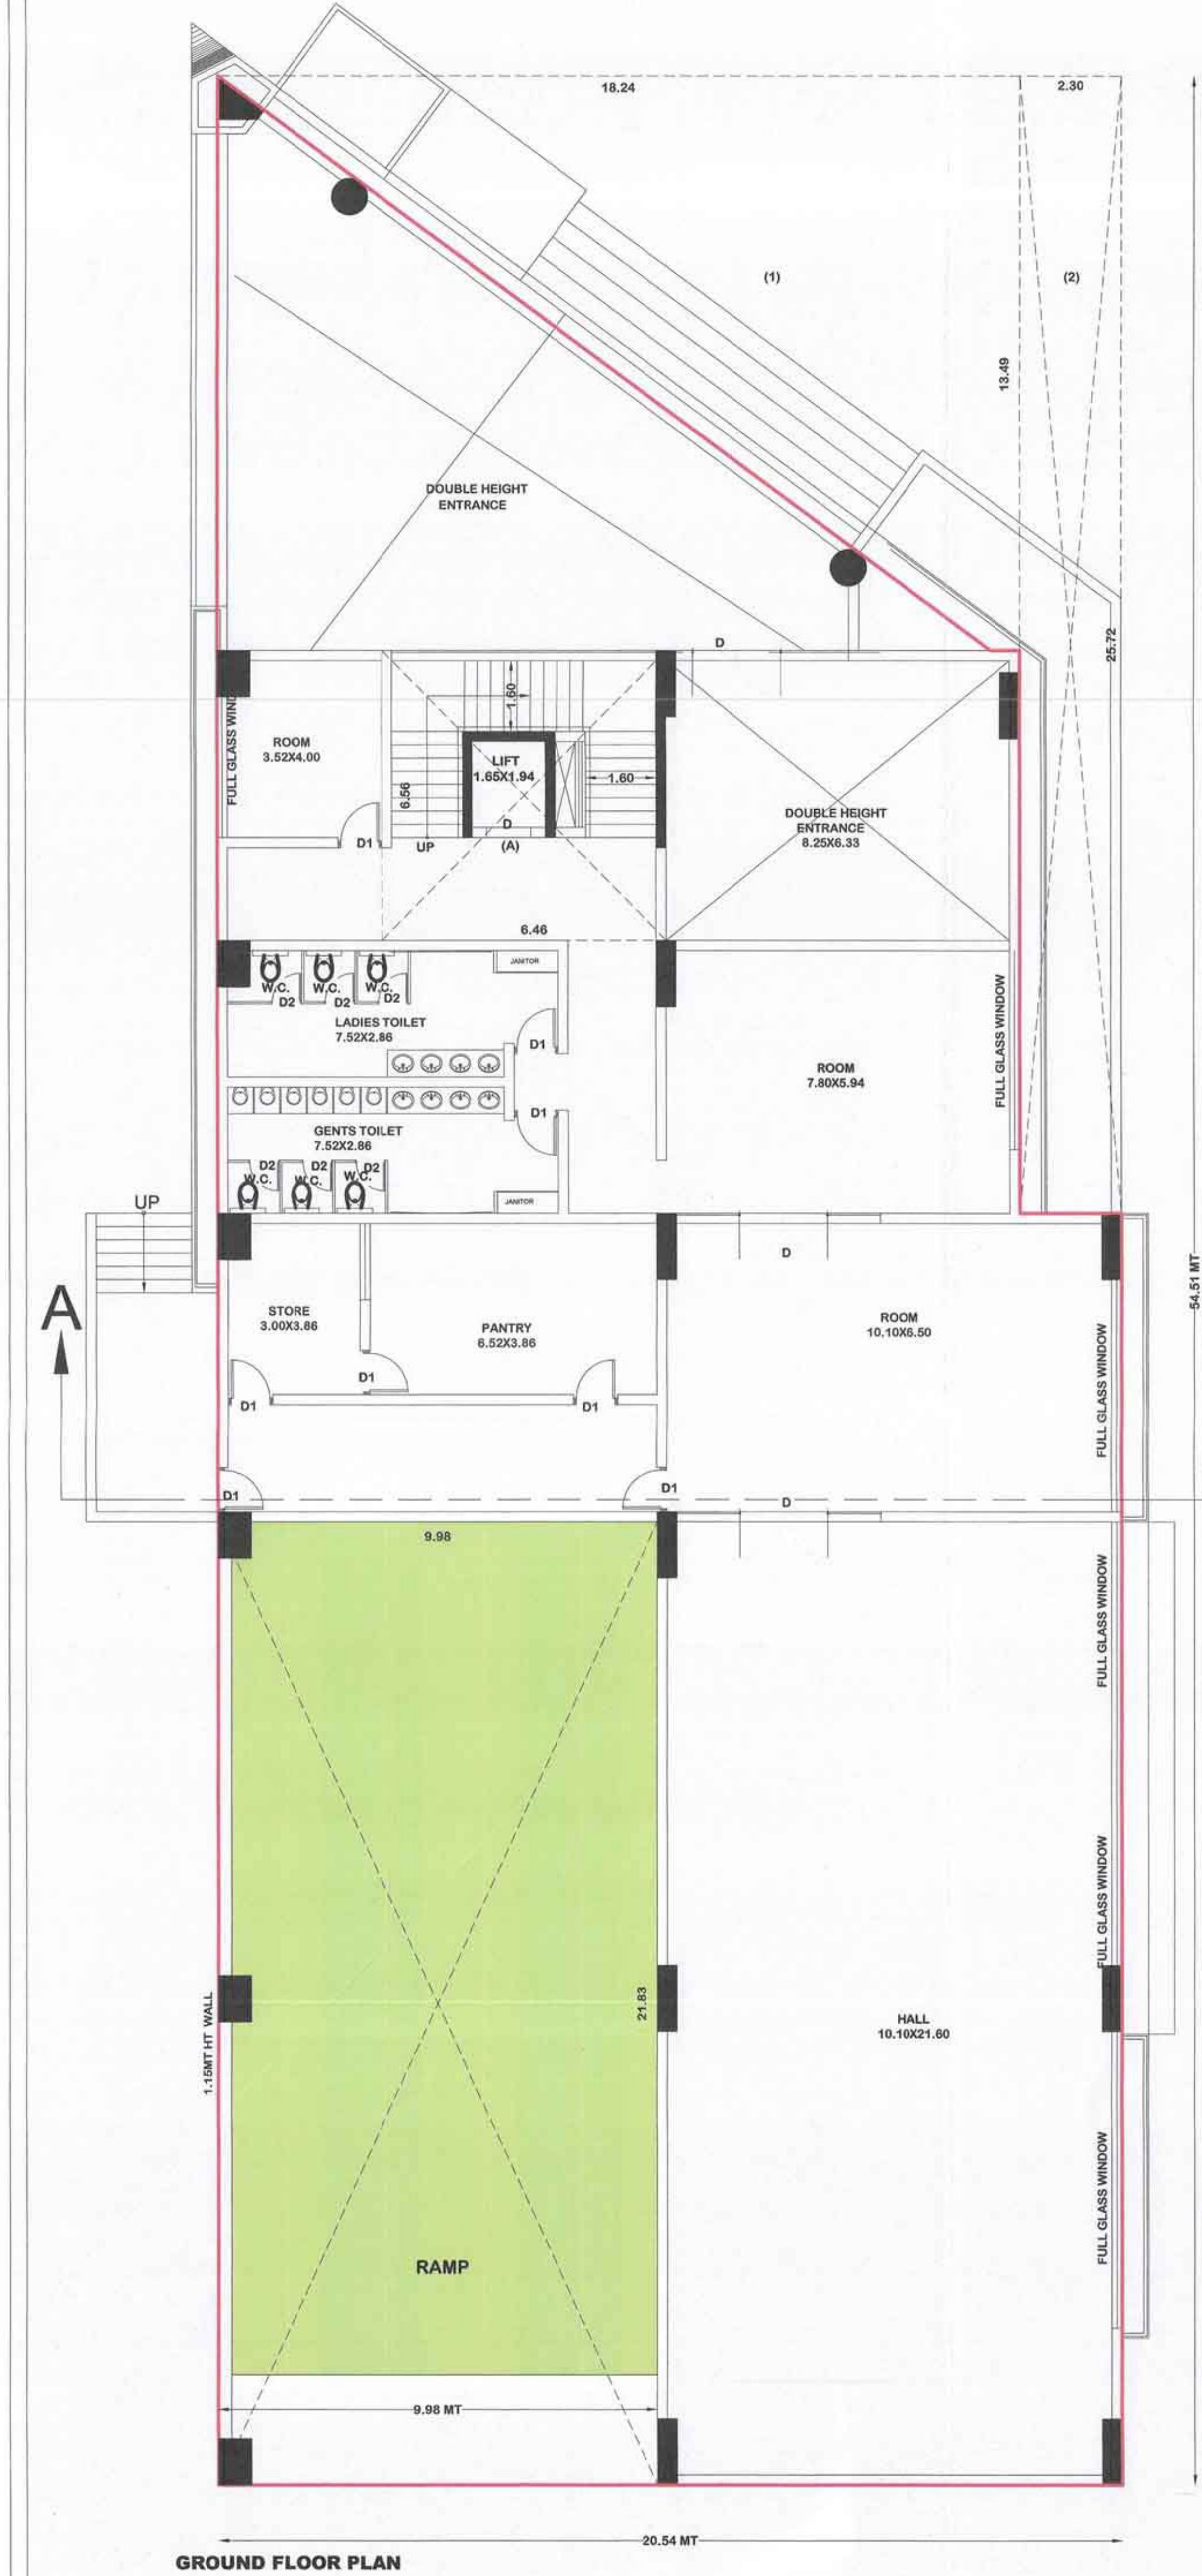


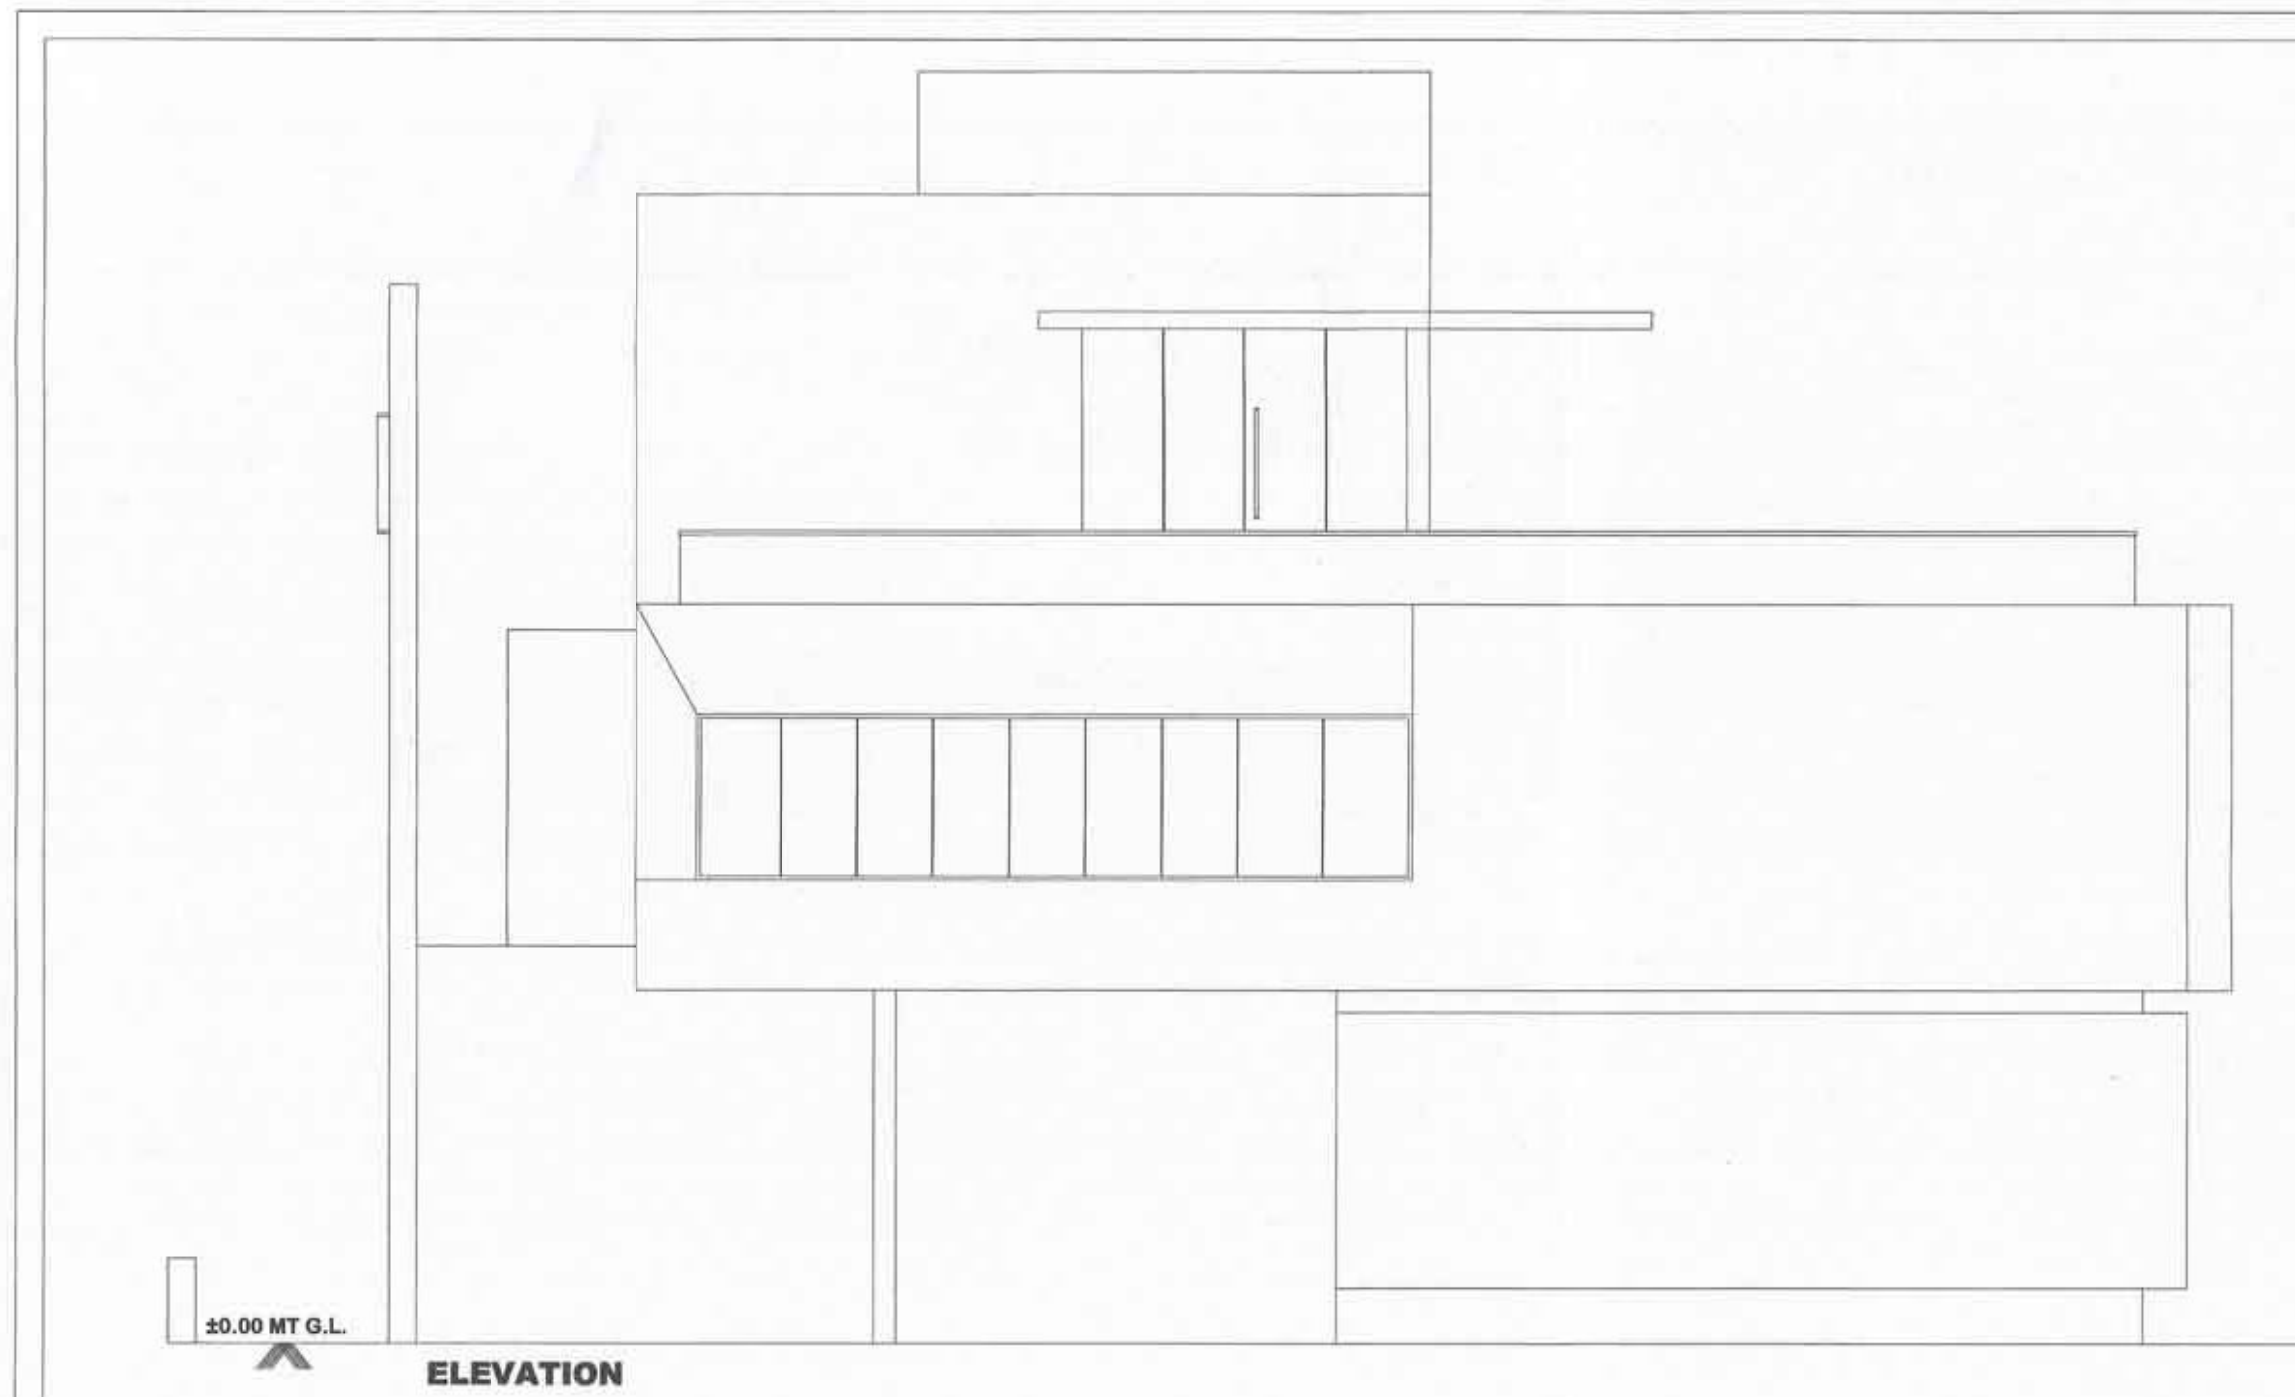

અધિકારી પાસેથી મળેલા માપ અને માપદંડો પર આધારિત છે. જો માપદંડોમાં ફેરફાર આવે તો આ દસ્તાવેજ અમારું જવાબદારી હેઠળ રહેશે.

Owner is fully responsible for open marginal Space and road line Portion.

માનક સરકાર :
આ દસ્તાવેજ માત્ર માપદંડો અને માપદંડોના હેતુ માટે છે. જો માપદંડોમાં ફેરફાર આવે તો આ દસ્તાવેજ અમારું જવાબદારી હેઠળ રહેશે.

SHEET NO. 17

LAYOUT PLAN SHOWING PROP "COMPACT HOUSING" RESIDENTIAL BUILDING IN SHANTIGRAM TOWNSHIP ON BLOCK NO.318,327,328,340/1, AT VILLAGE RHODIYAR, TAL.: DASKROD, DIST.: AHMEDABAD. (A PART OF SHANTIGRAM TOWNSHIP SITUATED AT VILLAGE : RHODIYAR, KHORLA, DANTALI & JASPUR)

SCALE: 1:00 CM = 1.00 MT (CLUB HOUSE)

USE: RESI.

AREA TABLE

FLOOR	USE	UNIT	FL. AREA	F.S.I AREA	B.U.P AREA
GR.FL.	CLUB HOUSE	01	580.00	687.03	937.45
1st FL.	---	---	610.00	726.72	937.45
2nd FL.	---	---	390.00	487.42	529.80
TERRA.	---	---	0.00	0.00	47.39
TOTAL	---	01	1580.00	1901.17	2452.09

SCHEDULE OF OPENING

DOOR	WINDOW	VENTILATION
D1 = 1.80 X 2.10	W = 0.90 X 1.20	V = 0.80 X 0.80
D2 = 1.00 X 2.10	W1 = 0.75 X 1.20	
D3 = 0.75 X 1.10		

PROF. WORK

PROF. WORK

GROUND FLOOR CALC.

20.54 X 54.51

Less

1. 18.24 X 13.49/2

2. 2.30 X 25.72

TOTAL LESS WRK

PROF. GROUND & 1st FLOOR B.U.P AREA =

1119.64 - 182.19 =

937.45 SQ. MTR.

F.S.I. AREA CALC.

GROUND FLOOR

B.U.P AREA ON GROUND FLOOR

Less

A. 6.46 X 6.56

B. 8.25 X 1.83

TOTAL LESS WRK

PROF. GR. FLOOR FSI AREA =

937.45 - 509.45 =

428.00 SQ. MTR.

F.S.I. AREA CALC.

1ST FLOOR

B.U.P AREA ON 1ST FLOOR

Less

A. 6.46 X 6.56

B. 8.25 X 1.83

TOTAL LESS WRK

PROF. 1ST FLOOR FSI AREA =

937.45 - 510.71 =

426.74 SQ. MTR.

B.U.P AREA CALC.

2ND FLOOR

PROF. 2ND FLOOR B.U.P AREA =

529.80 SQ. MTR.

F.S.I. AREA CALC.

2ND FLOOR

B.U.P AREA ON 1ST FLOOR

Less

A. 6.46 X 6.56

TOTAL LESS WRK

PROF. 1ST FLOOR FSI AREA =

529.80 - 42.38 =

487.42 SQ. MTR.

B.U.P AREA CALC.

STAIR CABIN.

PROF. STAIR CABIN B.U.P AREA =

47.39 SQ. MTR.

ADANI TOWNSHIP & REAL ESTATE CO. PVT. LTD.

Ranjana Wazir, Atreco House

CBD, Shantigram, SG Highway

Ahmedabad-382421

AUDA Reg No. AUDA/DEV/854

DEVELOPER

ADANI TOWNSHIP & REAL ESTATE CO. PVT. LTD.

Ranjana Wazir, Atreco House

CBD, Shantigram, SG Highway

Ahmedabad-382421

AUDA Reg No. AUDA/DEV/854

ENGINEER

DHIRU G. SOMPUJA

80/25, Jambhwal Heights,

Opp. A. C. Banglow, East Road,

Howrah, Ahmedabad

AUDA/REG-100343 DT: 7/4/2018

SHANTIGRAM ESTATE MANAGEMENT PVT. LTD.

AUDA LIC NO. CDW-1/681

Atreco House, CBD - Shantigram,

SG Highway, Ahmedabad-382421

OWNERS

શ્રી રમેશ અંબારવાળી અને શ્રી રમેશ અંબારવાળી

અને તેમના પત્નીશ્રી રમેશ અંબારવાળી

અને તેમના પત્નીશ્રી રમેશ અંબારવાળી

અને તેમના પત્નીશ્રી રમેશ અંબારવાળી

APPROVED

As amended by Red (Colour) Subject

to the condition as mentioned in this

office Letter PRM No. 227/11/2020

Dated: 11/12/2020

Note Approved by Chairman

11/12/2020

Senior Town Planner

Ahmedabad Urban Development Authority

Ahmedabad.

(1) HYDRANT SYSTEM
CATCH PIPES LOCATED NEAR THE HOSE REEL HOSE OR HYDRANT OUTLET AT EACH FLOOR FOR THE MAIN FIRE PUMP AT UNDERGROUND WATER TANK WITH A CAPACITY TO DISCHARGE 100 LITERS PER MINUTE AT 7 BAR PRESSURE AS MEASURED AT THE TERRACE LEVEL SHOULD BE INSTALLED.
THE HOSE FOR THE BUILDING EXCEEDING 18 METERS HEIGHT SHOULD NOT BE OF LESS THAN 100 MM INTERNAL DIAMETER. THE HOSE SHOULD BE CONNECTED TO THE BOTTOM OF THE TERRACE TANK WITH A STOP VALVE AND A NRV TO ACT AS A DOWN-COMER.
ONE REEL IS REQUIRED FOR EVERY 1000 SQ. MT. FLOOR AREA AND IF THE BUILDING IS DIVIDED INTO TWO OR MORE PARTS THEN EACH PART SHOULD HAVE A SEPARATE REEL WITH ALL THE FITTINGS AT EACH FLOOR LEVEL.
EACH FLOOR SHOULD HAVE ONE HYDRANT OUTLET WITH A GUNG FOR ATTACHING A 100 MM HOSE. 20MM BORE HOSE REEL HOSE WITH 8 MM SHUT-OFF NOZZLE AT EACH FLOOR LEVEL. THE HOSE SHOULD BE KEPT IN SUCH A MANNER TO REACH THE FARTHEST CORNER OF THE FLOOR. HOSEBOX WITH 100MM BORE 30MM HOSE AND 12.5 M. REEL NOZZLE ALTERNATE FLOORS. THE HOSE-REEL HOSE SHOULD BE COUPLED TO THE REEL.
FIRE SERVICE INLET SHOULD BE INSTALLED AT A POINT NEAR THE ENTRY TO THE PREMISES WHERE A FIRE ENGINE COULD EASILY REACH. A PERMANENT HYDRANT POINT COMPRISING OF 63 MM DIA SIZE 2 NOS OF HYDRANT VALVE SHOULD BE INSTALLED AT THE TERRACE LEVEL. THE OVERHEAD TANK REFILLING BYPASS CONNECTION SHOULD BE DONE AT THE TERRACE LEVEL.
THE OVERHEAD TANK SHALL BE OF A CAPACITY OF NOT LESS THAN 20,000 LITERS. THE UNDERGROUND TANK SHALL BE OF NOT LESS THAN 100,000 LITERS.
(2) FIRE LIFT
THE FIRE LIFT AND ALL LIFTS SHOULD HAVE A PROVISION TO STOP TO AUTOMATICALLY IN CASE OF ELECTRICAL FAILURE. EACH BUILDING SHOULD HAVE AT LEAST ONE LIFT AS A FIRE LIFT AND IF THE BUILDING IS DIVIDED INTO TWO OR MORE PARTS THEN EACH PART SHOULD HAVE A FIRE LIFT. LIFT WELL SHOULD HAVE BLOWERS TO PRESSURIZE THE LIFT WELL SO CONNECTED THAT IT WILL AUTOMATICALLY OPERATE WHEN ALARM CALL POINT IS OPERATED, SO THAT IT PREVENTS THE LIFT WELL GETTING SMOKE LOGGED.
(3) FIRE ALARMS
FIRE ALARM CALL POINT TO BE INSTALLED AT EACH FLOOR WITH SOUNDERS CAPABLE OF BEING HEARD ALL THROUGHOUT THE BUILDING.
(4) EXTINGUISHERS
ONE CARBON DIOXIDE (CO2) TYPE EXTINGUISHER OF 4.5 KG. WITH ISI MARK AND ONE EXTINGUISHER OF 1 KG. DRY CHEMICAL POWDER (DCP) TYPE EXTINGUISHER WITH ISI MARK TO BE INSTALLED ON EACH FLOOR IN CASE OF COMMERCIAL BUILDING. ONE CARBON DIOXIDE (CO2) TYPE EXTINGUISHER OF 4.5 KG. WITH ISI MARK OR TWO CARBON DIOXIDE (CO2) TYPE EXTINGUISHER OF 2 KG. CAPACITY ON EACH FLOOR AND 1 KG. DRY CHEMICAL POWDER (DCP) WITH ISI MARK TYPE EXTINGUISHER ON ALTERNATE FLOOR IN CASE OF RESIDENTIAL BUILDING. IF THE BUILDING IS DIVIDED INTO TWO OR MORE PARTS THEN EACH PART SHOULD HAVE THESE EXTINGUISHERS INSTALLED.
(5) STAIRCASES
THE STAIRCASES ARE TO BE OPEN FROM AT LEAST ONE OR TWO SIDES BUT IF THE STAIRCASE IS IN THE CORNER OF THE BUILDING IT HAS TO BE OPEN FROM TWO SIDES. THE STAIRCASES SHOULD BE LOCATED IN THE STAIRCASE OR CLOSE TO THE STAIRCASE. THE STAIRCASES SHOULD BE LOCATED IN THE STAIRCASE OR CLOSE TO THE STAIRCASE. THE STAIRCASES SHOULD BE LOCATED IN THE STAIRCASE OR CLOSE TO THE STAIRCASE.
(6) BASEMENT
THE BASEMENT OF 200 SQ. METERS OR MORE SHOULD BE PROTECTED WITH AUTOMATIC SPRINKLER SYSTEM WITH AT LEAST ONE SPRINKLER HEAD FOR EACH CAR PARKING SPACE.
ADDITIONALLY BE PROTECTED BY A HYDRANT OUTLET AND 20 MM BORE HOSE-REEL HOSES WITH 8MM BORE NOZZLES AT EACH BASEMENT LEVEL.
A LIGHTNING ARRESTER SHOULD ALSO BE INSTALLED AND BE PROPERLY EARTHED TO PREVENT DAMAGE TO THE BUILDING WHEN THE LIGHTNING STRIKES.
(7) BUILDING FALLS IN A CORNERED AREA OR IF IT HAS AN ENCLOSED STAIRCASE (STAIRS) NOT WELL LIT UP ON THE INSIDE, THEN ADEQUATE PHOTO LUMINESCENT (P.L.) OR LUMINOUS SIGNS SHOULD BE DISPLAYED AT EACH FLOOR LANDING, STAIRCASE, DEAD END AND ALONG ALL EXIT ROUTES LEADING TO THE GROUND LEVEL. THE SIGNS SHOULD INDICATE FIRE FIGHTING, FIRE SAFETY, FIRST AID AND OTHER SAFETY EQUIPMENT PRESENT ON THE RESPECTIVE FLOOR (LANDING / STAIRCASE / DEAD END) AND ALONG ALL EXIT ROUTES LEADING TO THE GROUND LEVEL.
(8) ELECTRICAL POWER SUPPLY TO THE ENTIRE FIRE SAFETY SYSTEM
ELECTRICITY SUPPLY TO THE FIRE PUMP, FIRE ALARM SYSTEM, STAIRCASE PRESSURIZATION SYSTEM AND FIRE LIFT SHOULD BE MADE AVAILABLE FROM THE MAIN ELECTRICAL SUPPLY (I.E. FROM ELECTRICAL POWER SUPPLY OF THE COMPANY). THIS IS TO ENSURE AVAILABILITY OF POWER SUPPLY TO THE FIRE PROTECTION & SAFETY SYSTEM EVEN AFTER THE MAIN ELECTRICAL SUPPLY TO THE BUILDING IS SWITCHED OFF AT THE TIME OF FIRE.
(9) INSPECTION OF A LOW RISE BUILDING BY THE FIRE SERVICES AUTHORITY, IF THE FIRE OFFICER CONCERNED FINDS THE NEED FOR ADDITIONAL FIRE PROTECTION (PROTECTION VENTILATION SYSTEM REQUIRED OR EQUIPMENT I.E. PASSIVE SYSTEM SPRINKLER (DROPSHOWER) ETC.) AS PER THE LOAD / FIRE RISK / RISK DETERMINING POTENTIAL OCCUPANCY / CORNER AREA, THESE ADDITIONAL MEASURES / EQUIPMENT HAVE TO BE IMPLEMENTED / INSTALLED.

(11) LENGED
1. FIRE HYDRANT SYSTEM PIPE MAIN
2. SINGLE HEADED HYDRANT VALVE
3. BLUE VALVE
4. TOWAY SIAMES CONNECTION
5. RISE OR DROP
6. NON RETURN VALVE
7. REDUCER
8. FIRE HOSE BOX
9. HOSE REEL HOSE
10. HYDRANT VALVE
11. FIRE ALARM CALL POINT
12. FIRE ALARM SOUNDER
13. FIRE ALARM BELL
14. FIRE ALARM BELL
15. FIRE ALARM BELL
991. FIRE ALARM BELL