
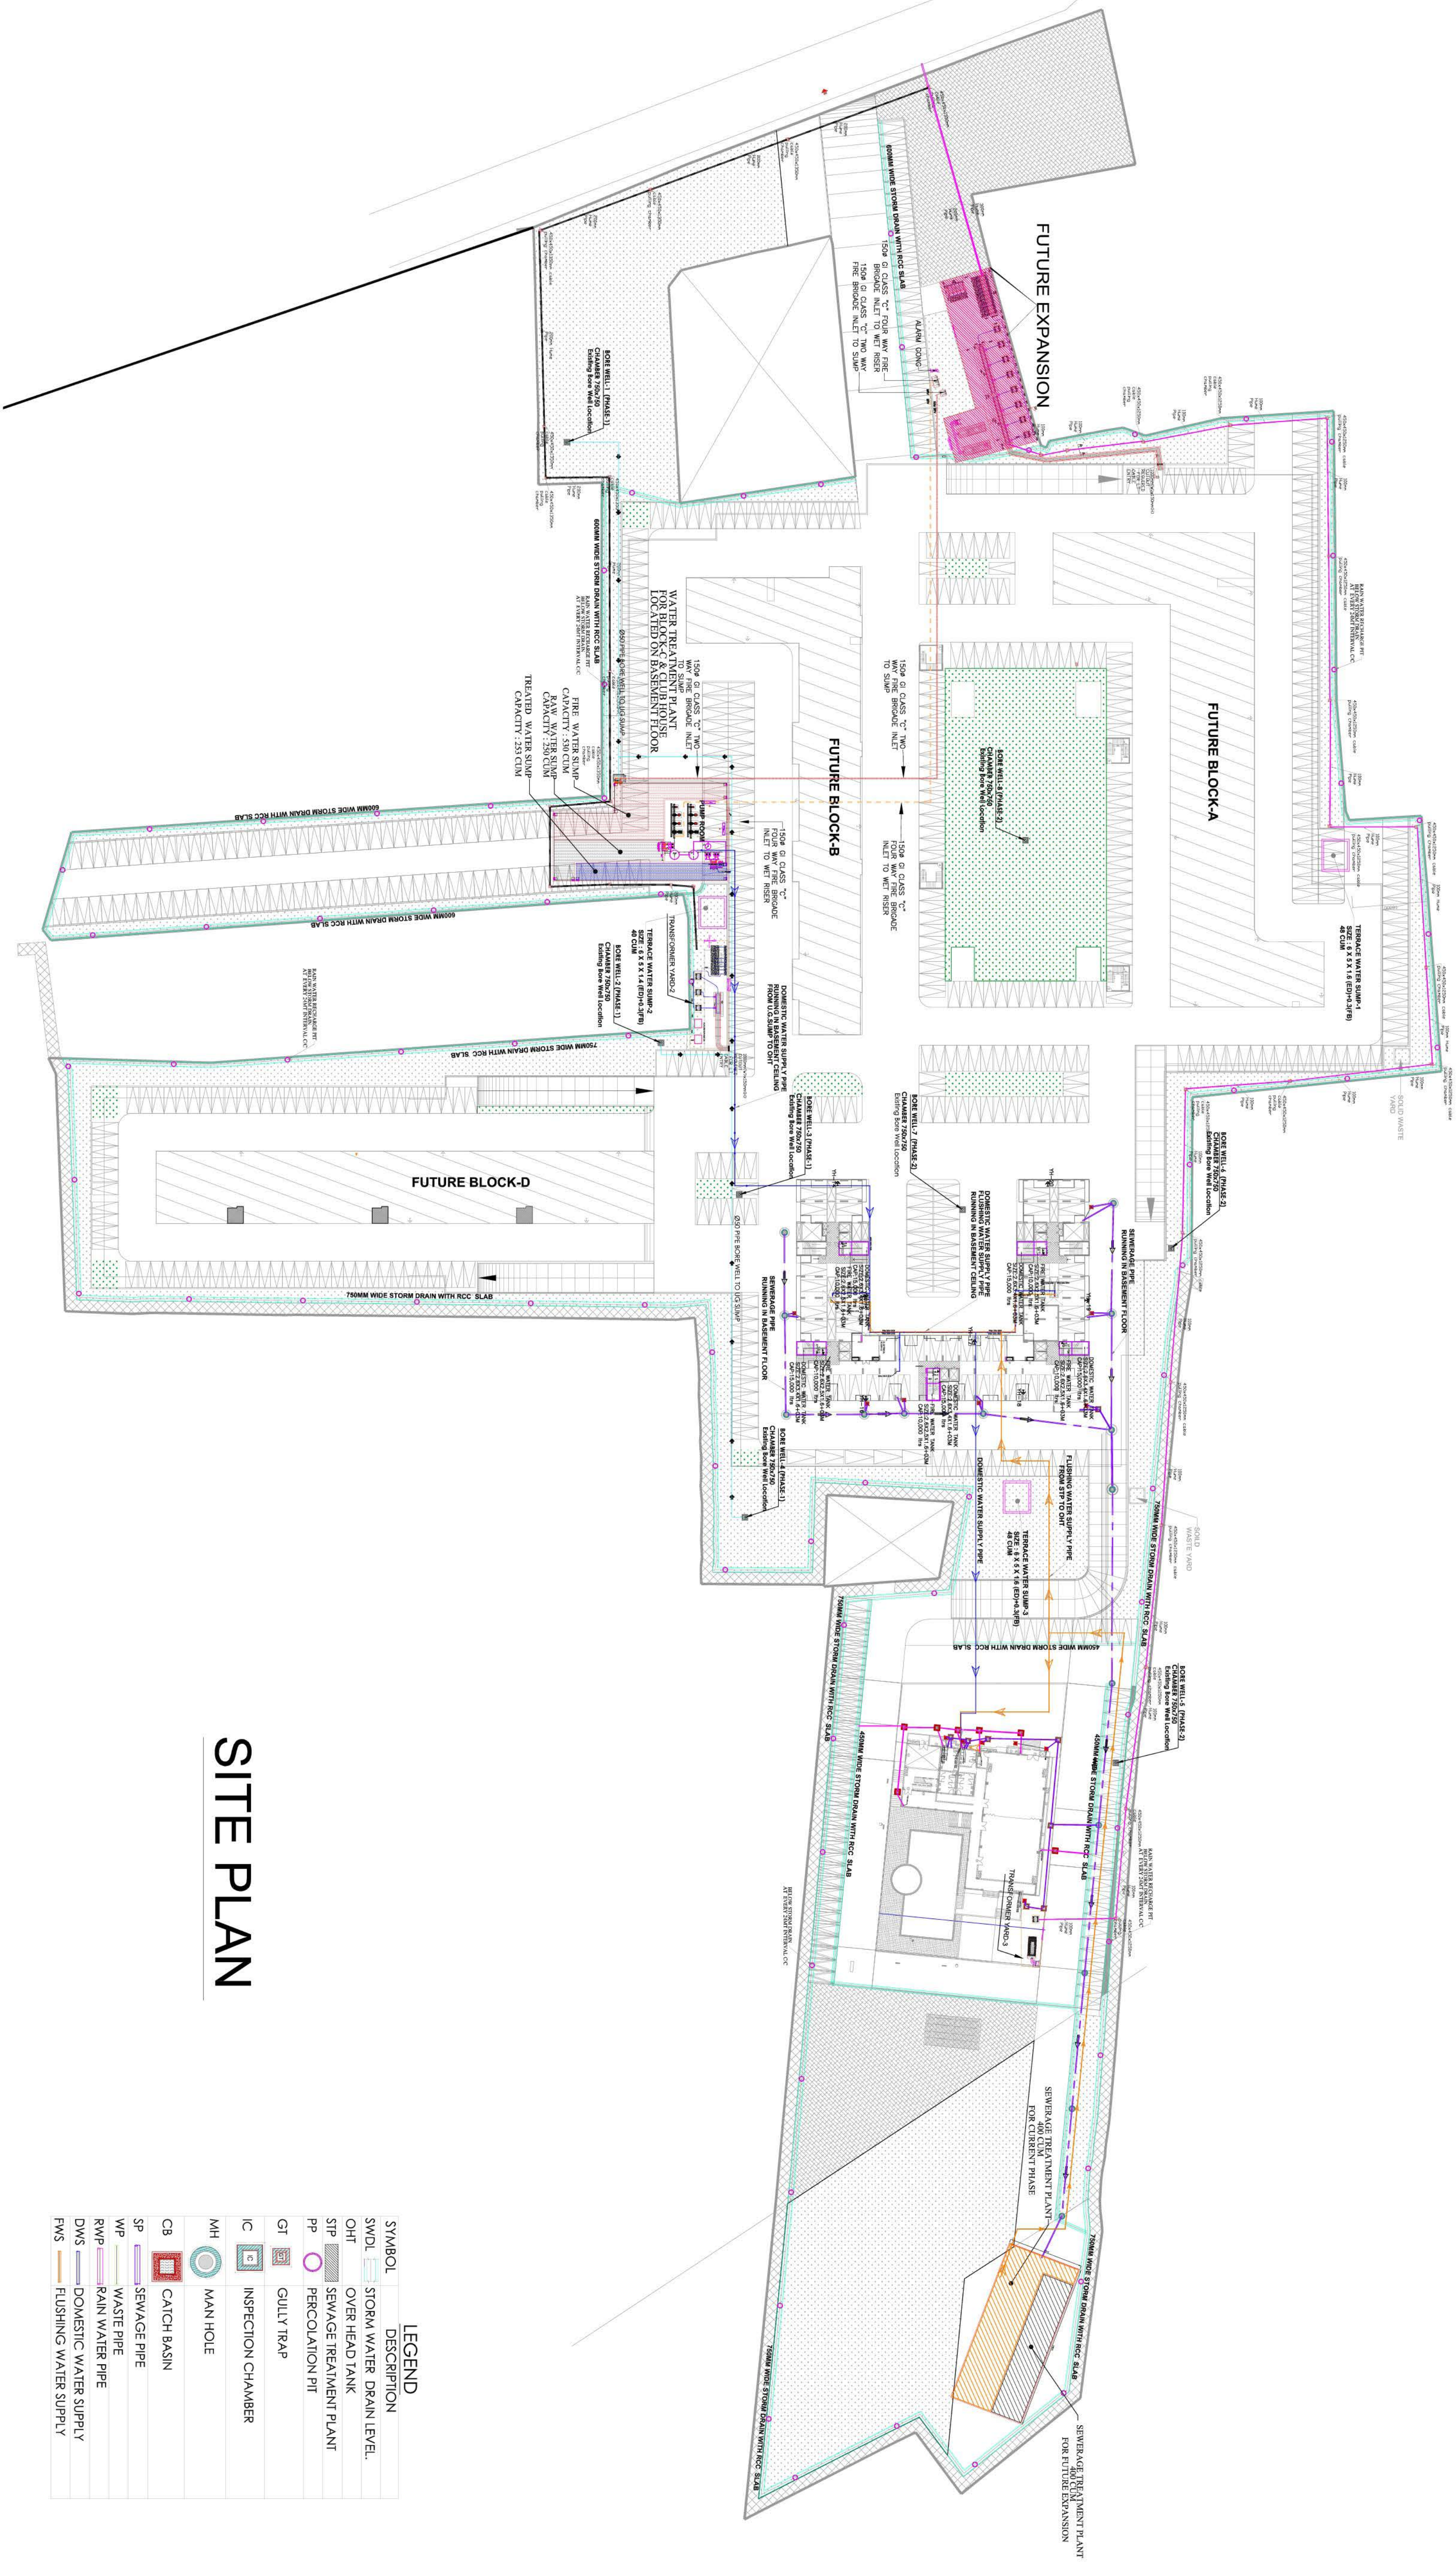


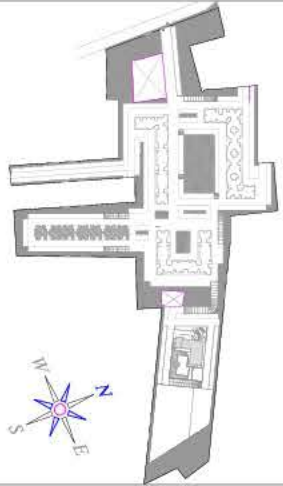

SITE PLAN

SYMBOL	DESCRIPTION
SWDL	STORM WATER DRAIN LEVEL.
OHT	OVER HEAD TANK
STP	SEWAGE TREATMENT PLANT
PP	PERCOLATION PIT
GT	GULLY TRAP
IC	INSPECTION CHAMBER
MH	MAN HOLE
CB	CATCH BASIN
SP	SEWAGE PIPE
WP	WASTE PIPE
RWP	RAIN WATER PIPE
DWS	DOMESTIC WATER SUPPLY
FWS	FLUSHING WATER SUPPLY

PROJECT SPECIFIC NOTES		GENERAL NOTES	
PROJECT NAME: KENGERI-2		PROJECT LOCATION: KENGERI-2	
PROJECT NUMBER: 1347/2017		PROJECT DATE: 13/07/2017	
DRAWING STATUS: 13/07/2017		DRAWING SCALE: A1	
DRAWING TITLE: SITE PLAN		DRAWING NO: 1347/2017	
CHECKED BY: SHALESH KUMAR		DESIGNED BY: SHALESH KUMAR	
DRAWING NO: 1347/2017		REVISION: R0	
PROJECT NAME: KENGERI-2		PROJECT LOCATION: KENGERI-2	
PROJECT NUMBER: 1347/2017		PROJECT DATE: 13/07/2017	
DRAWING STATUS: 13/07/2017		DRAWING SCALE: A1	
DRAWING TITLE: SITE PLAN		DRAWING NO: 1347/2017	
CHECKED BY: SHALESH KUMAR		DESIGNED BY: SHALESH KUMAR	
DRAWING NO: 1347/2017		REVISION: R0	
PROJECT NAME: KENGERI-2		PROJECT LOCATION: KENGERI-2	
PROJECT NUMBER: 1347/2017		PROJECT DATE: 13/07/2017	
DRAWING STATUS: 13/07/2017		DRAWING SCALE: A1	
DRAWING TITLE: SITE PLAN		DRAWING NO: 1347/2017	
CHECKED BY: SHALESH KUMAR		DESIGNED BY: SHALESH KUMAR	
DRAWING NO: 1347/2017		REVISION: R0	