


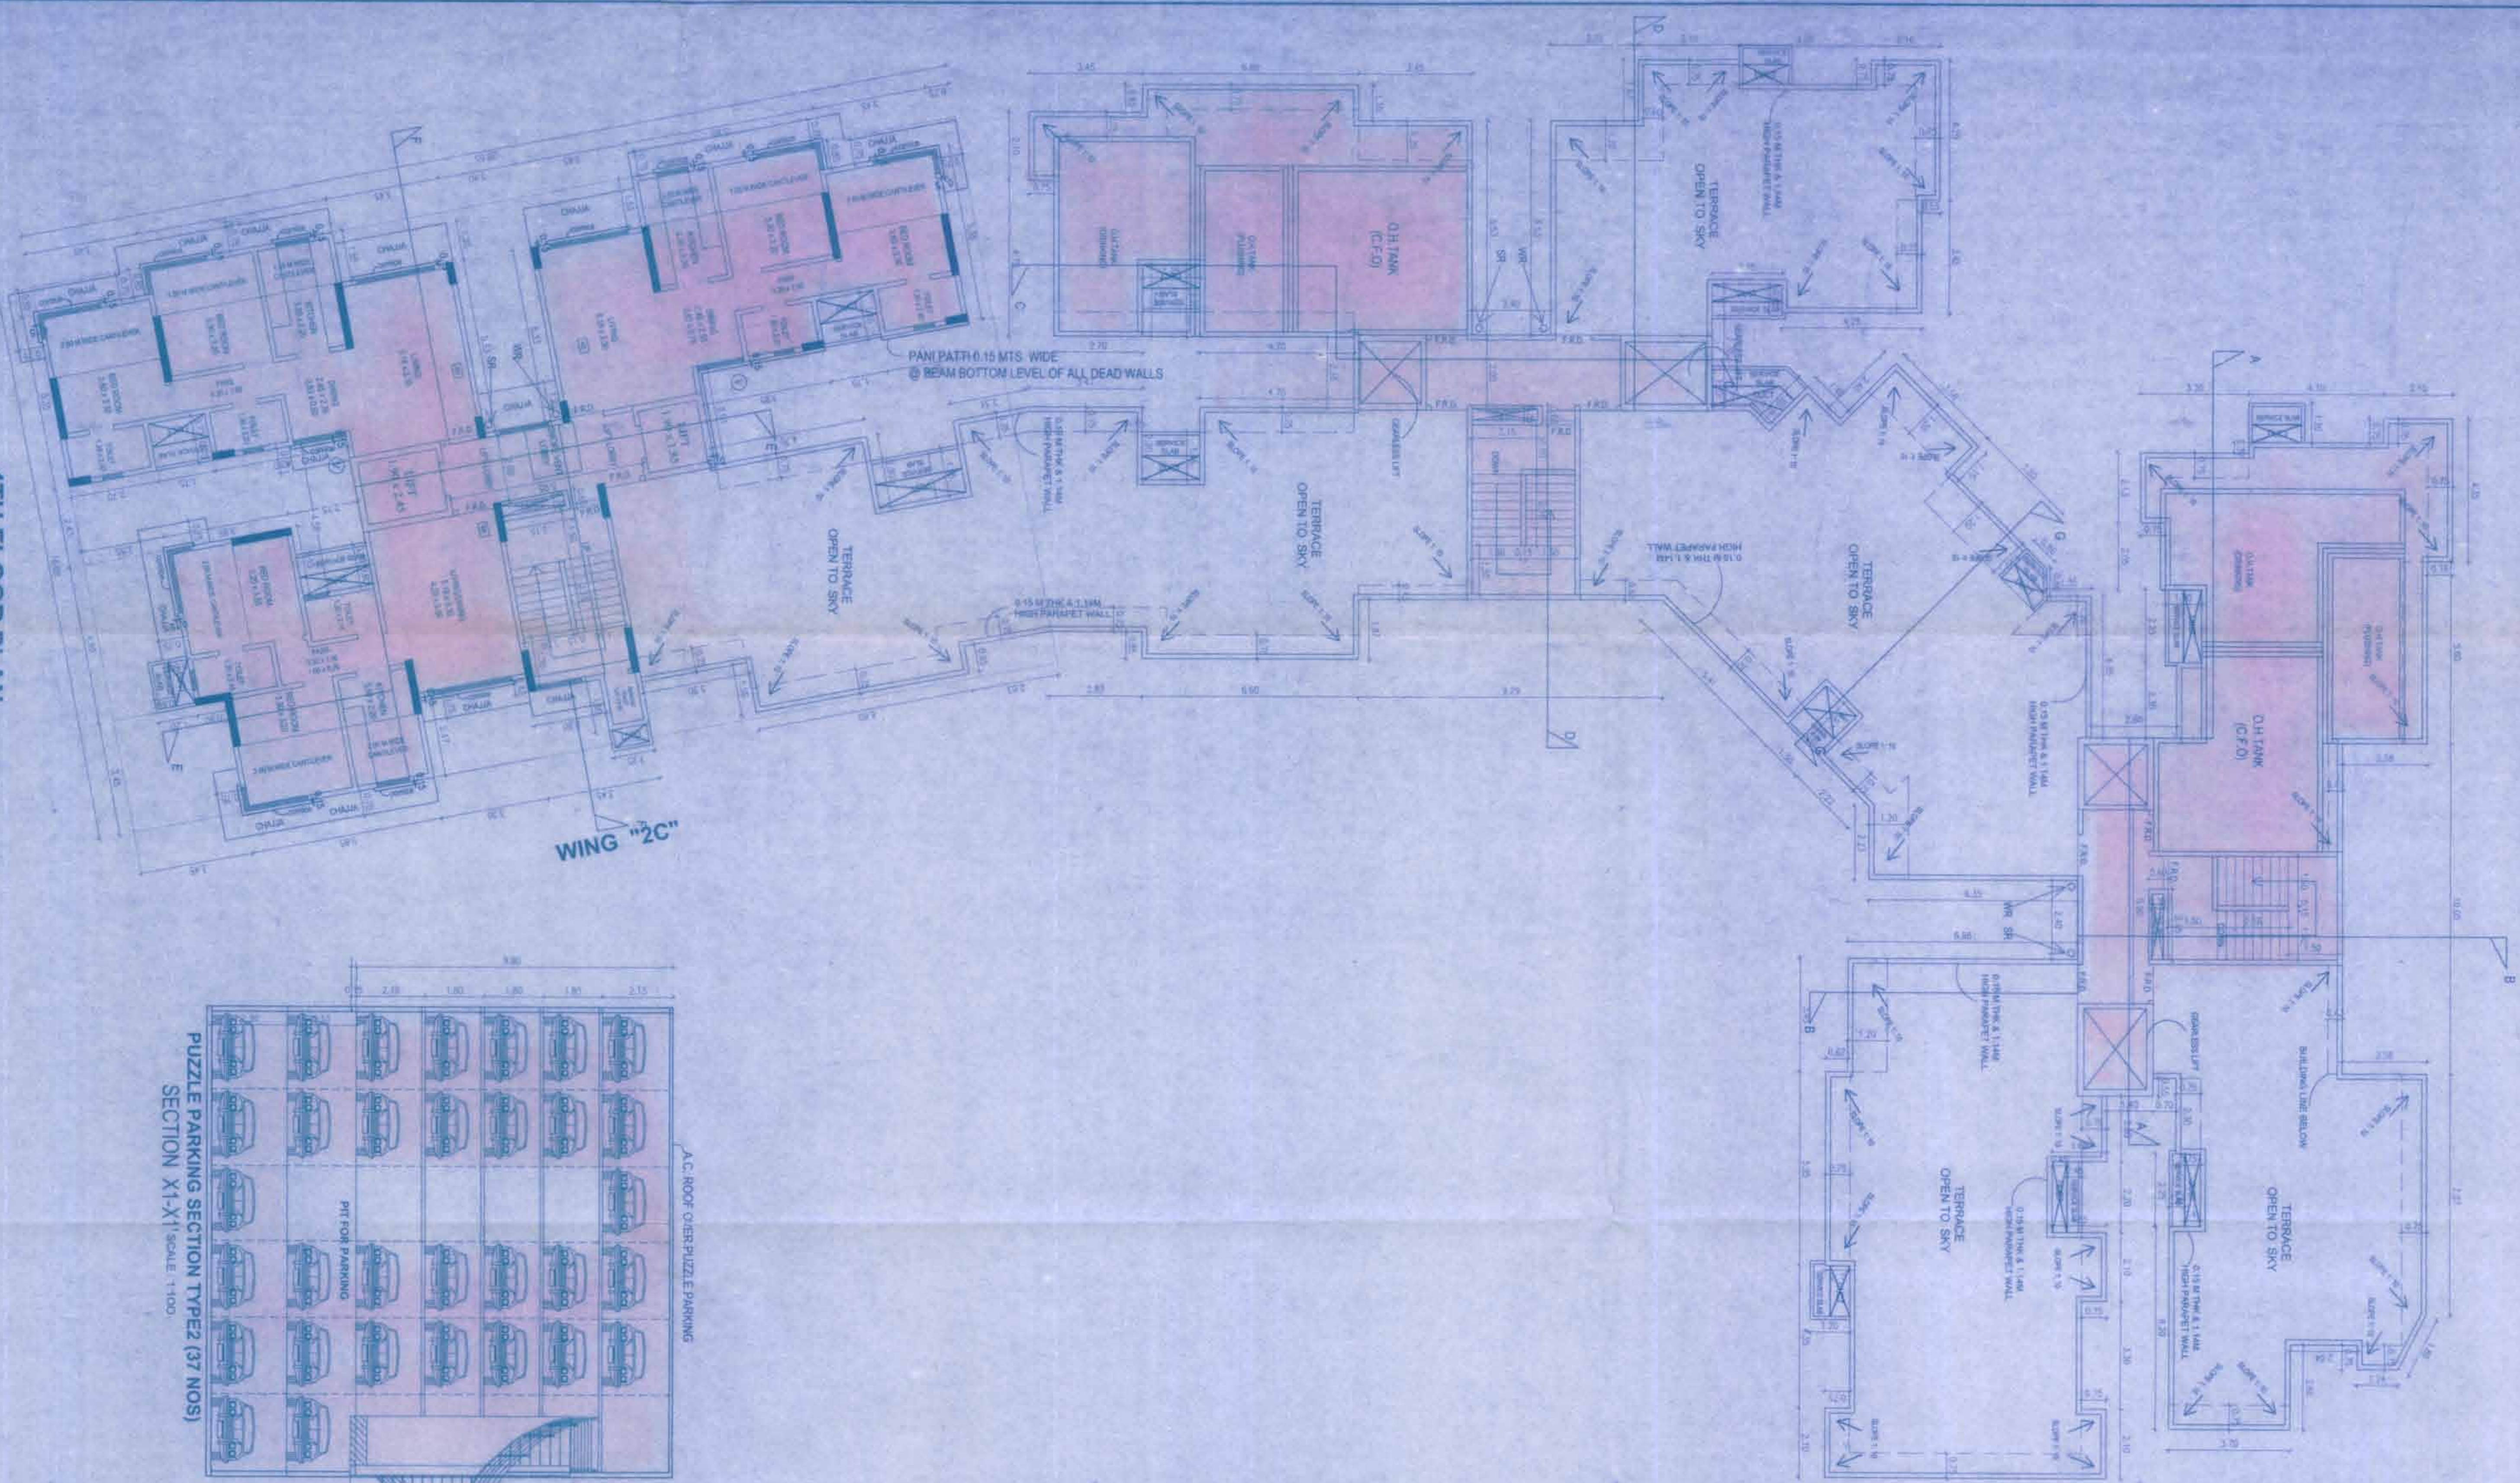

4TH FLOOR PLAN SCALE: 1:100

TERRACE FLOOR PLAN
SCALE: 1:100

[illegible]


Ms. D. R. VADYA & Co.
ARCHITECTS & INTERIORS PLANNERS
B-1, CHANDRA SEKHARAPURAM, CHANDRASEKHAR
ROAD, PUNE - 411 004
Contact: 020-2611 4001

मुद्रांकित महानगरपालिका
"रेड" विभाग / पूर्व
दिनांक 13 MAY 2016
वार्डकाय अभियंता इनामरी
उपनाय (पञ्चम उपायारी)