
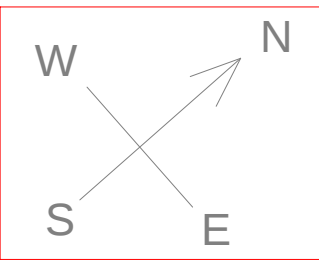


PHASE 1

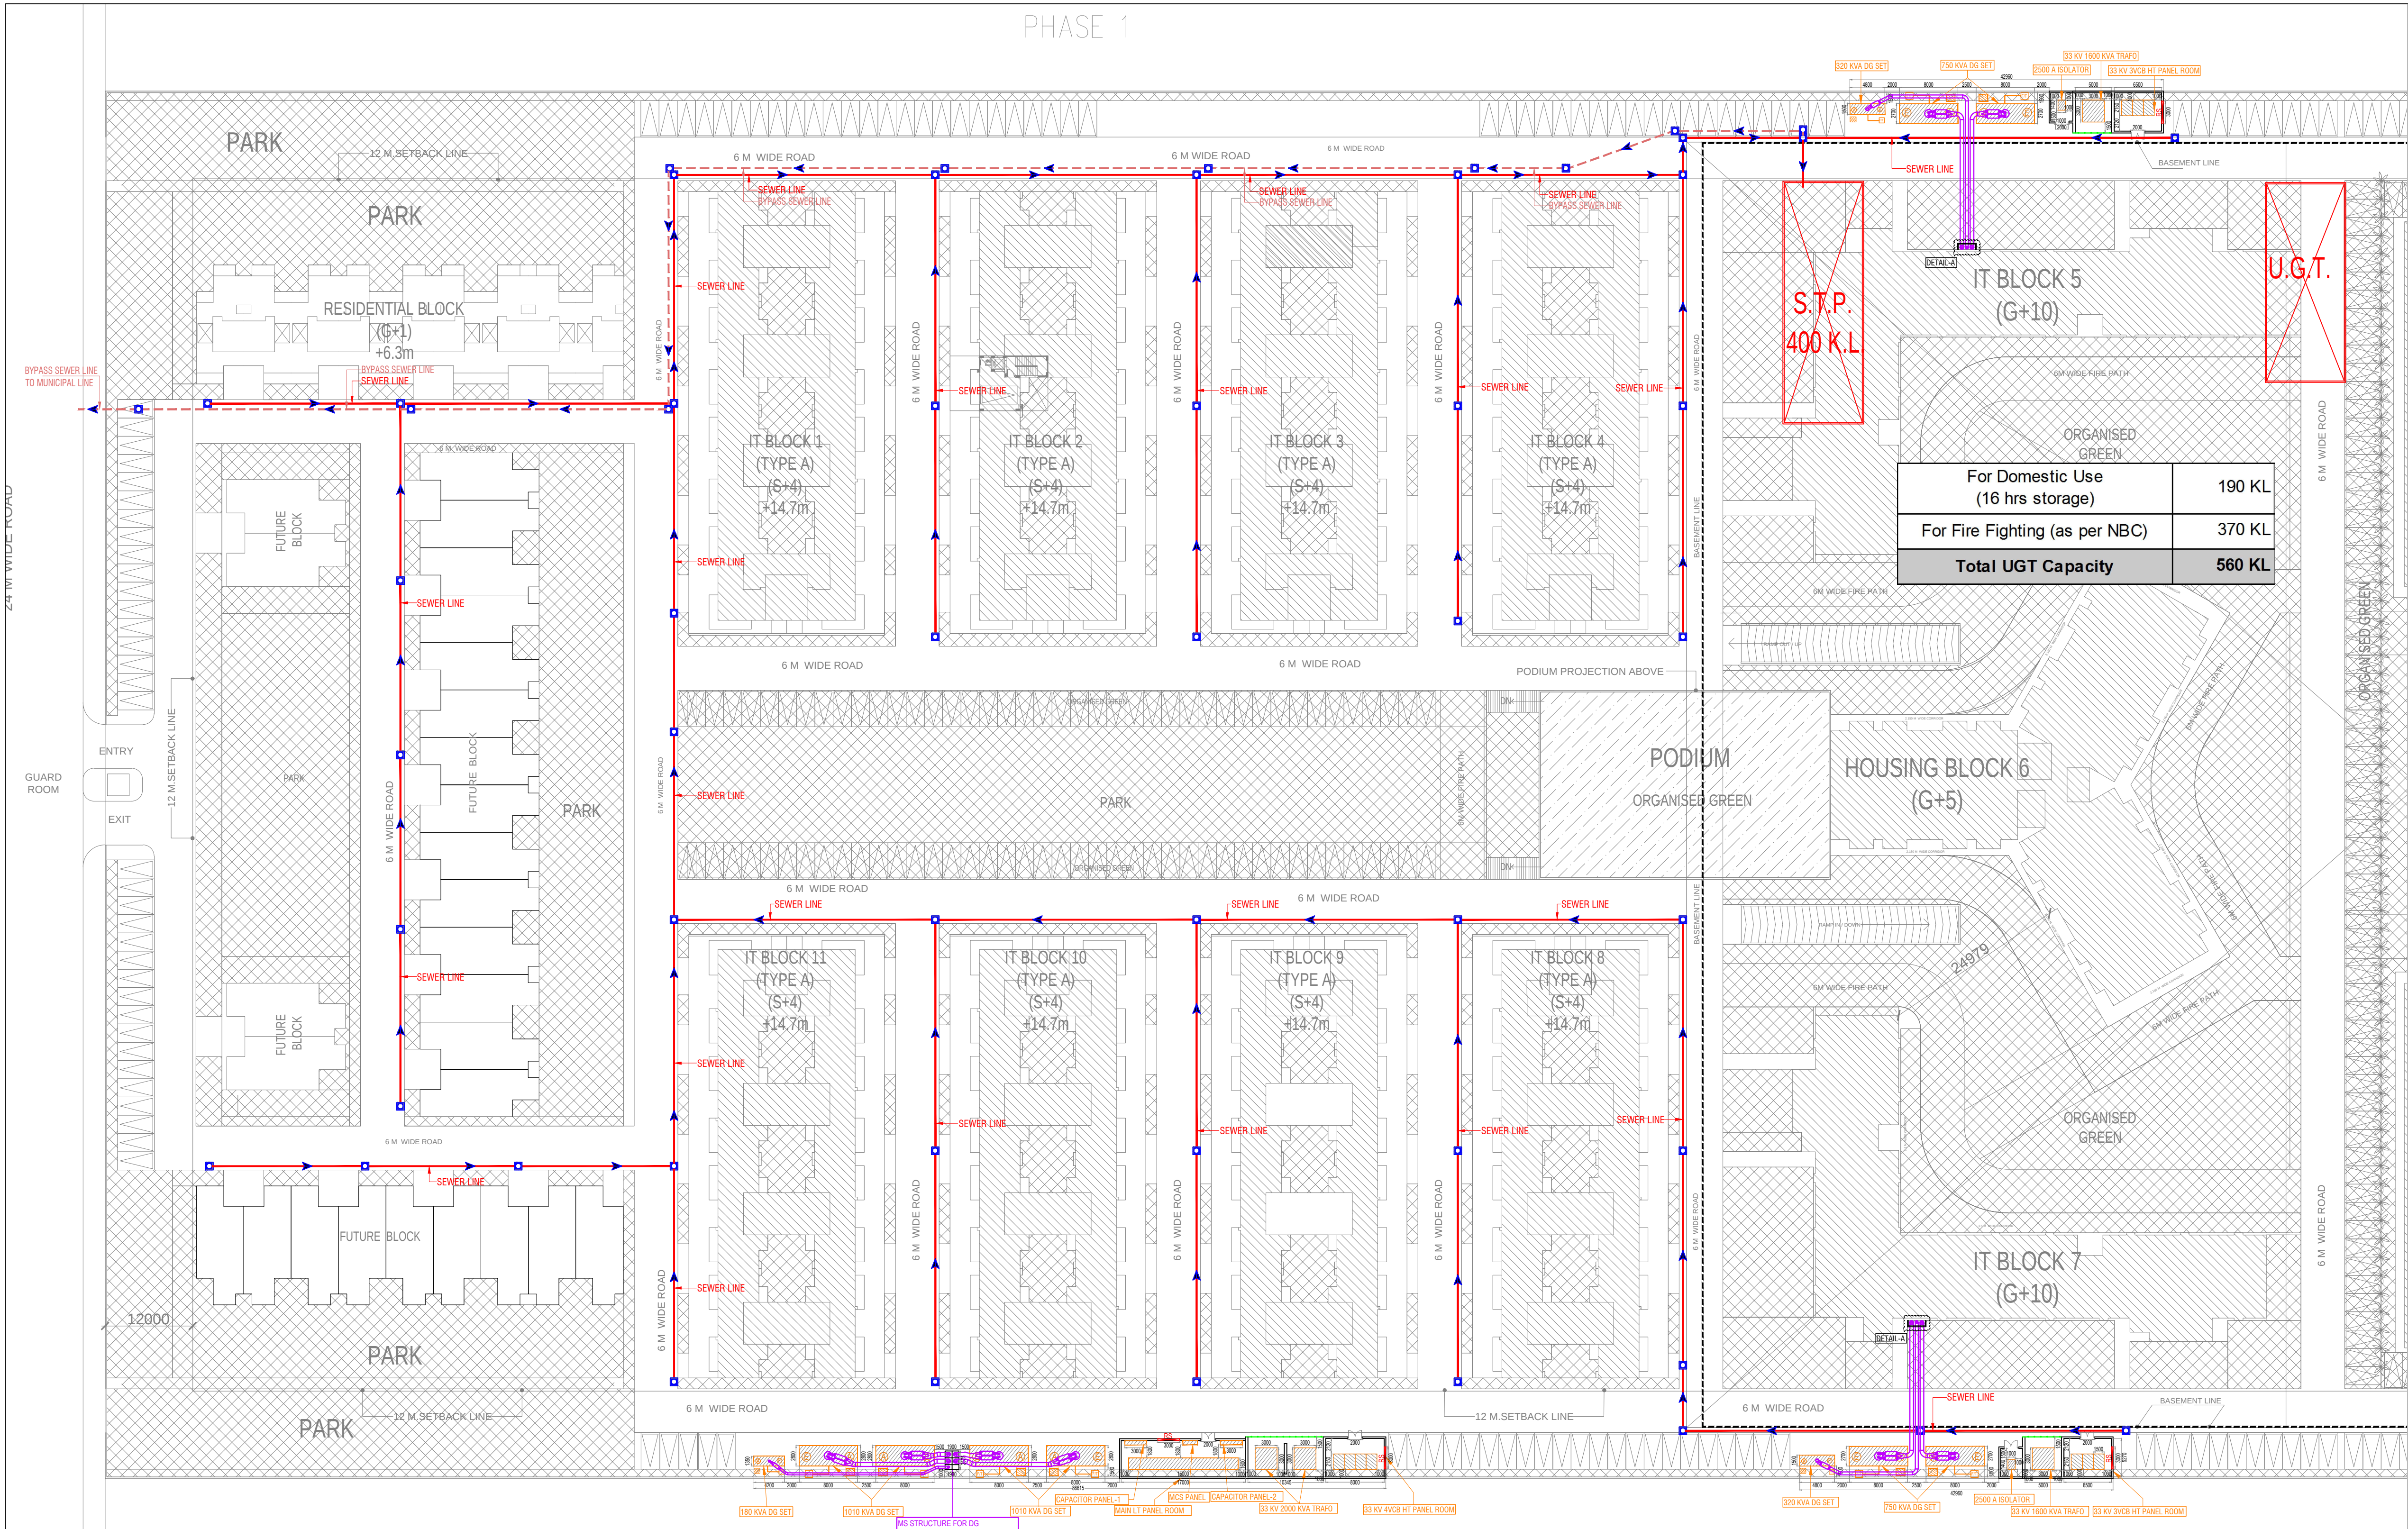

LEGEND :		
S. No.	SYMBOL	DESCRIPTION
1.	M.H.	MANHOLE
2.		SEWER LINE
3.		BYPASS SEWER LINE
4.		BASEMENT LINE

Rev. no.	Date	Revision
..	..	..
Project PROPOSED I.T. PARK AT PLOT NO-06,K.P.-5,GREATER NOIDA WEST, GAUTAM BUDH NAGAR,UP		
Owner ELEGANT IT SOLUTIONS PVT LTD ..		
Title SITE PLAN		
Subtitle EXTERNAL SEWERAGE SYSTEM		
Drawing released for ☐ APPROVAL ☒ SUBMISSION ☐ ADVANCE COPY ☐ CONSTRUCTION		
Drg. no. I.T. PARK / EX / S-01	Drawn by Kulwant	
Scale 1:500 @ A1	Designed by R.K.	
Date May 2017	Checked by Anand Havelia	
Architects YUVAN 195,Ram Vihar, Delhi-92 ..		
Services Consultant Consummate Engineering Services (P) Ltd. Noida Office : B - 67, Sector - 67, Noida - 201 301 Tel : (0120)6943500 (23 Lines) Lko. Office : R 006, Rohtas Plumeria, Gomti Nagar, Lucknow e mail : mail@cespl.in, website : www.cespl.in		