


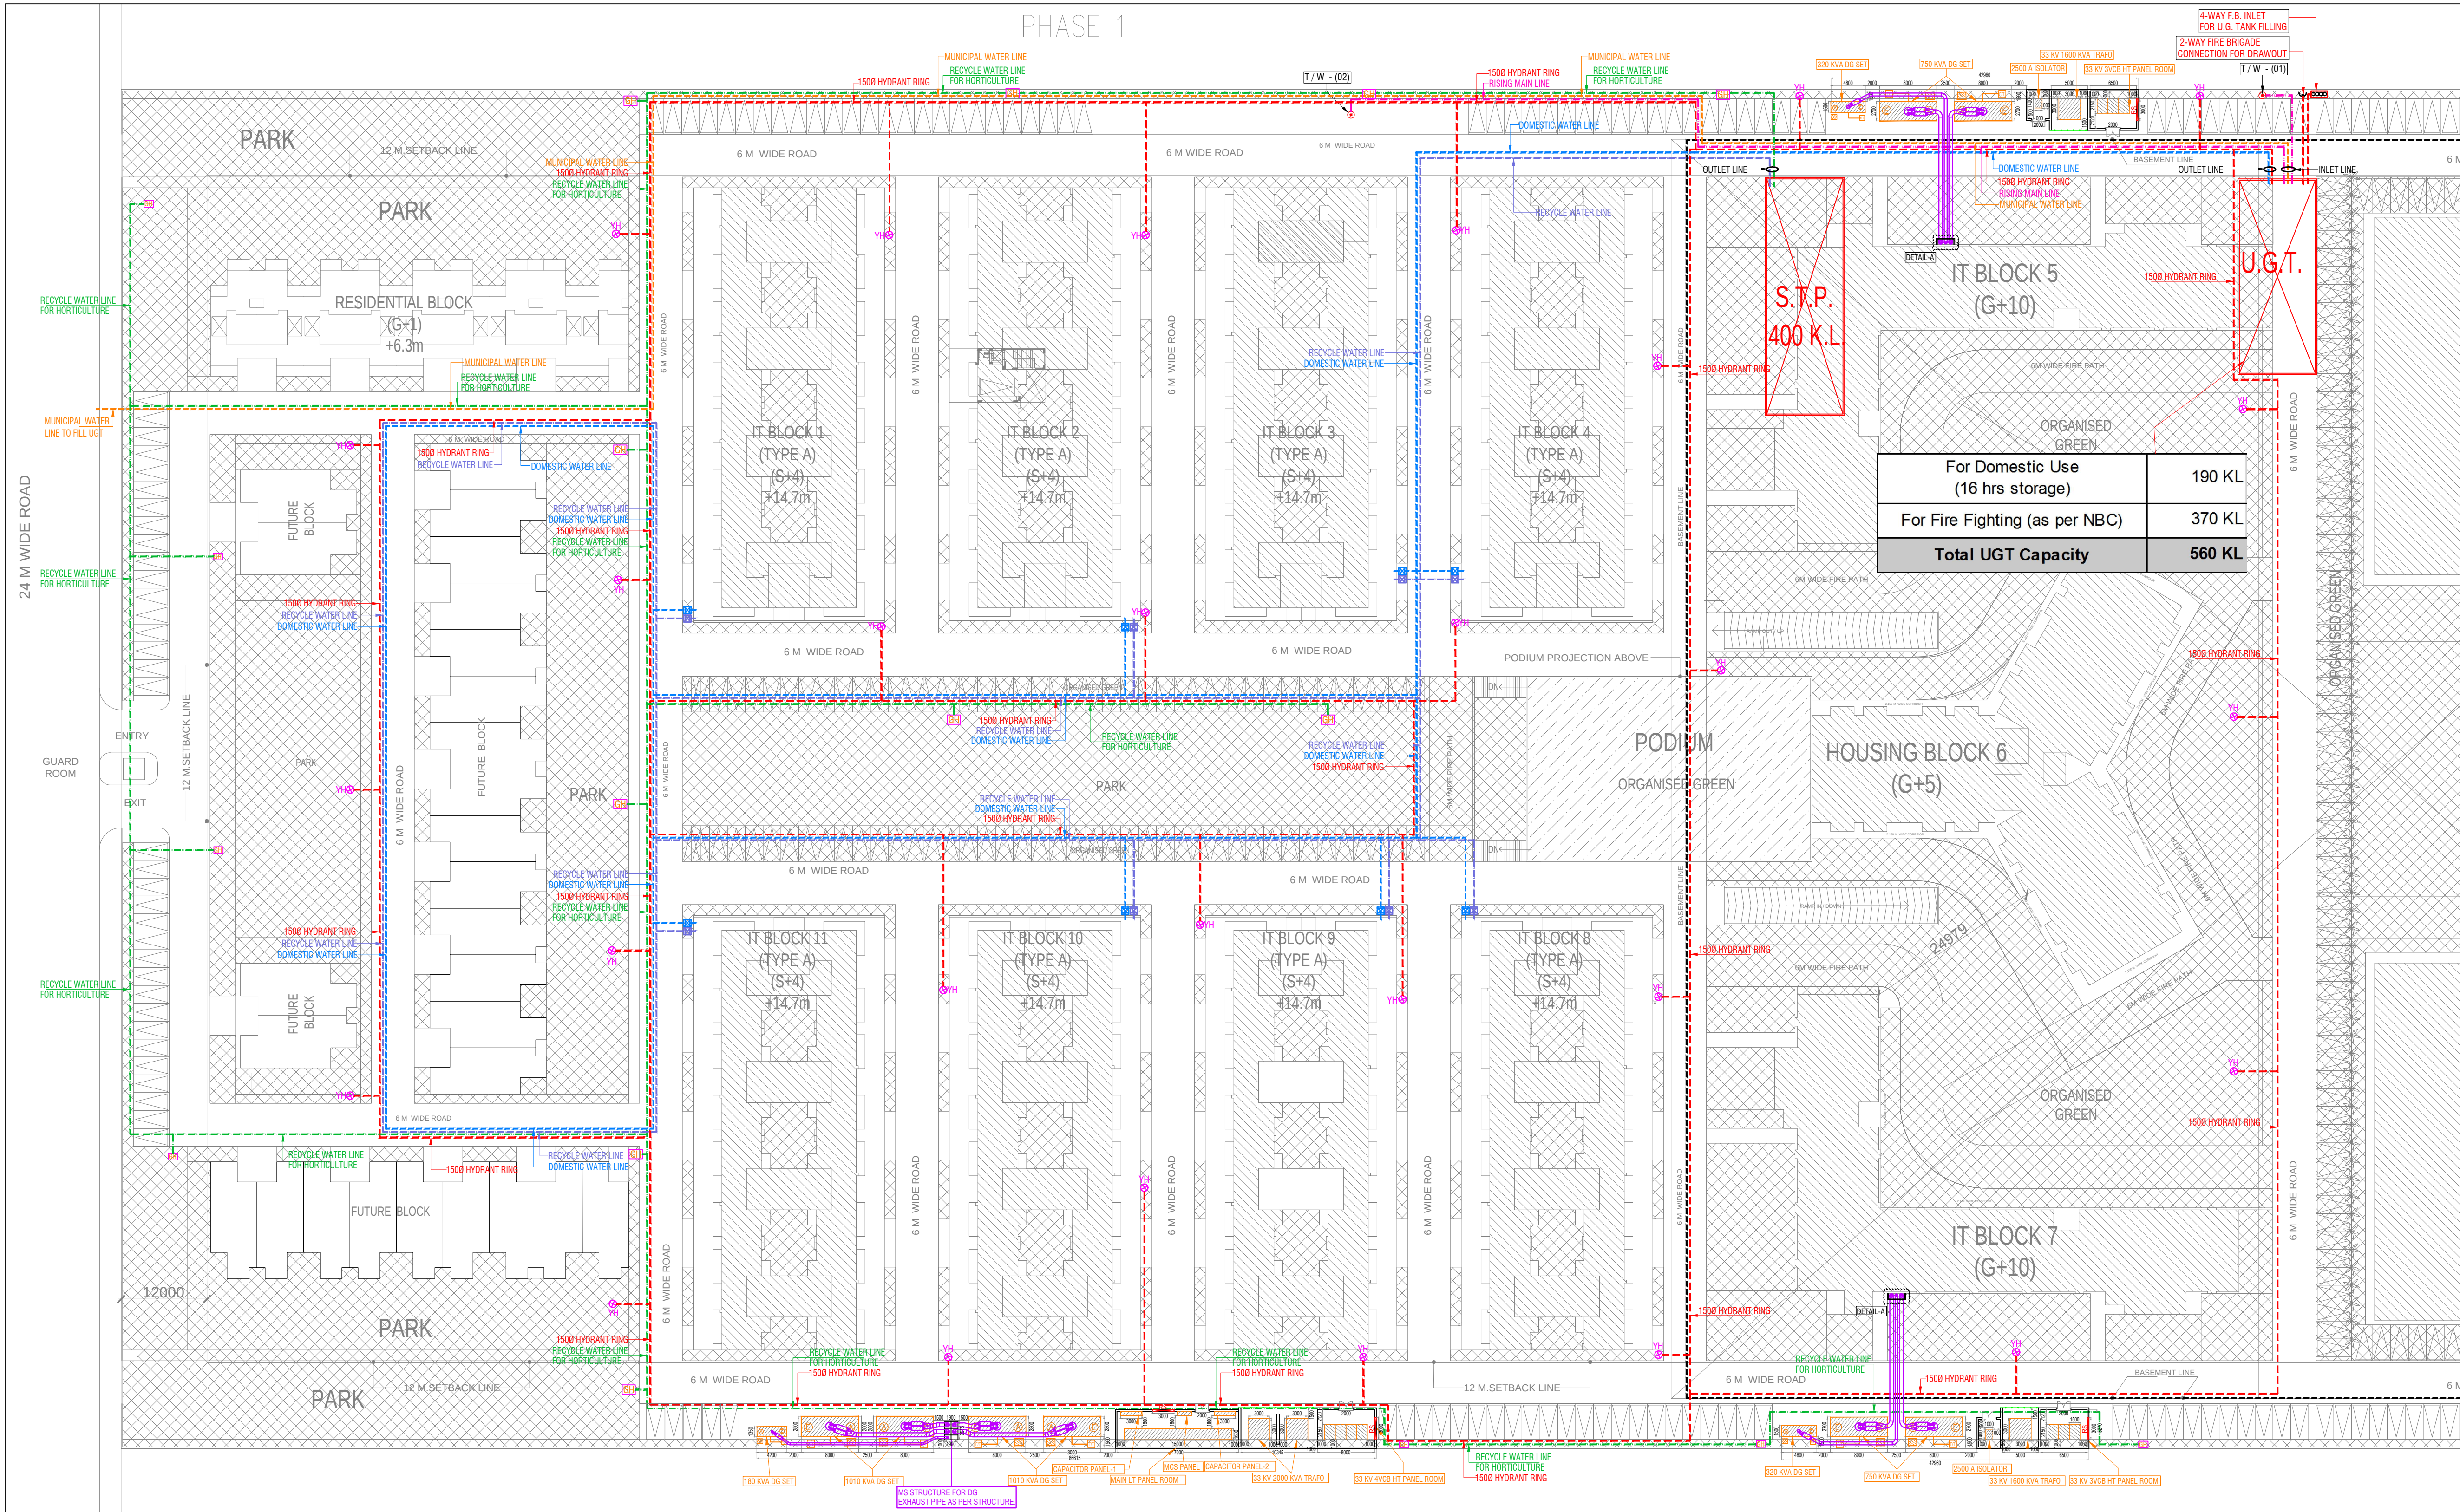

LEGEND :		
S. No.	SYMBOL	DESCRIPTION
1.		DOMESTIC WATER SUPPLY PIPE LINE
2.		RECYCLE WATER SUPPLY PIPE LINE
3.		RECYCLED WATER SUPPLY PIPE LINE (FOR HORTICULTURE)
4.		RIISING MAIN WATER PIPE LINE
5.		MUNICIPAL WATER SUPPLY PIPE LINE
6.		ISOLATING VALVE
7.		PROPOSED TUBE WELL
8.		BASEMENT LINE
9.		GARDEN HYDRANT

LEGEND : FIRE SYSTEM		
S. No.	SYMBOL	DESCRIPTION
1.		FIRE LINE
2.		YARD HYDRANT 63 M.M. DIA. SINGLE HEADED HYDRANT VALVE WITH 2 NOS. 15 M. LONG. 63 M.M. DIA. FIRE HOSE PIPE & 1 NO. BRANCH PIPE WITH NOZZLE
3.		FIRE BRIGADE CONNECTION
4.		BUTTERFLY VALVE
5.		NONRETURN VALVE (CHECK VALVE)
6.		ISOLATING VALVE WITH MASONARY CHAMBER

For Domestic Use (16 hrs storage)	190 KL
For Fire Fighting (as per NBC)	370 KL
Total UGT Capacity	560 KL

Rev. no.	Date	Revision
..	..	..

Project
PROPOSED I.T. PARK AT PLOT
NO-06,K.P.-5,GREATER NOIDA WEST, GAUTAM
BUDH NAGAR,UP

Owner
ELEGENT IT SOLUTIONS PVT LTD
..

Title
SITE PLAN

Subtitle
EXTERNAL WATER SUPPLY SYSTEM

Drawing released for
☐ APPROVAL ☒ SUBMISSION
☐ ADVANCE COPY ☐ CONSTRUCTION

Drg. no. I.T. PARK / EX / S-03 Drawn by Kulwant

Scale 1:500 @ A1 Designed by R.K.

Date May 2017 Checked by Anand Havelia

Architects
YUVAN
195,Ram Vihar, Delhi-92
..

Services Consultant
Consummate Engineering Services (P) Ltd.
Noida Office : B - 67, Sector - 67, Noida - 201 301
Tel : (0120)6943500 (23 Lines)
Lko. Office : R 006, Rohitas Plumeria, Gomti Nagar, Lucknow
e mail : mail@cespl.in, website : www.cespl.in