


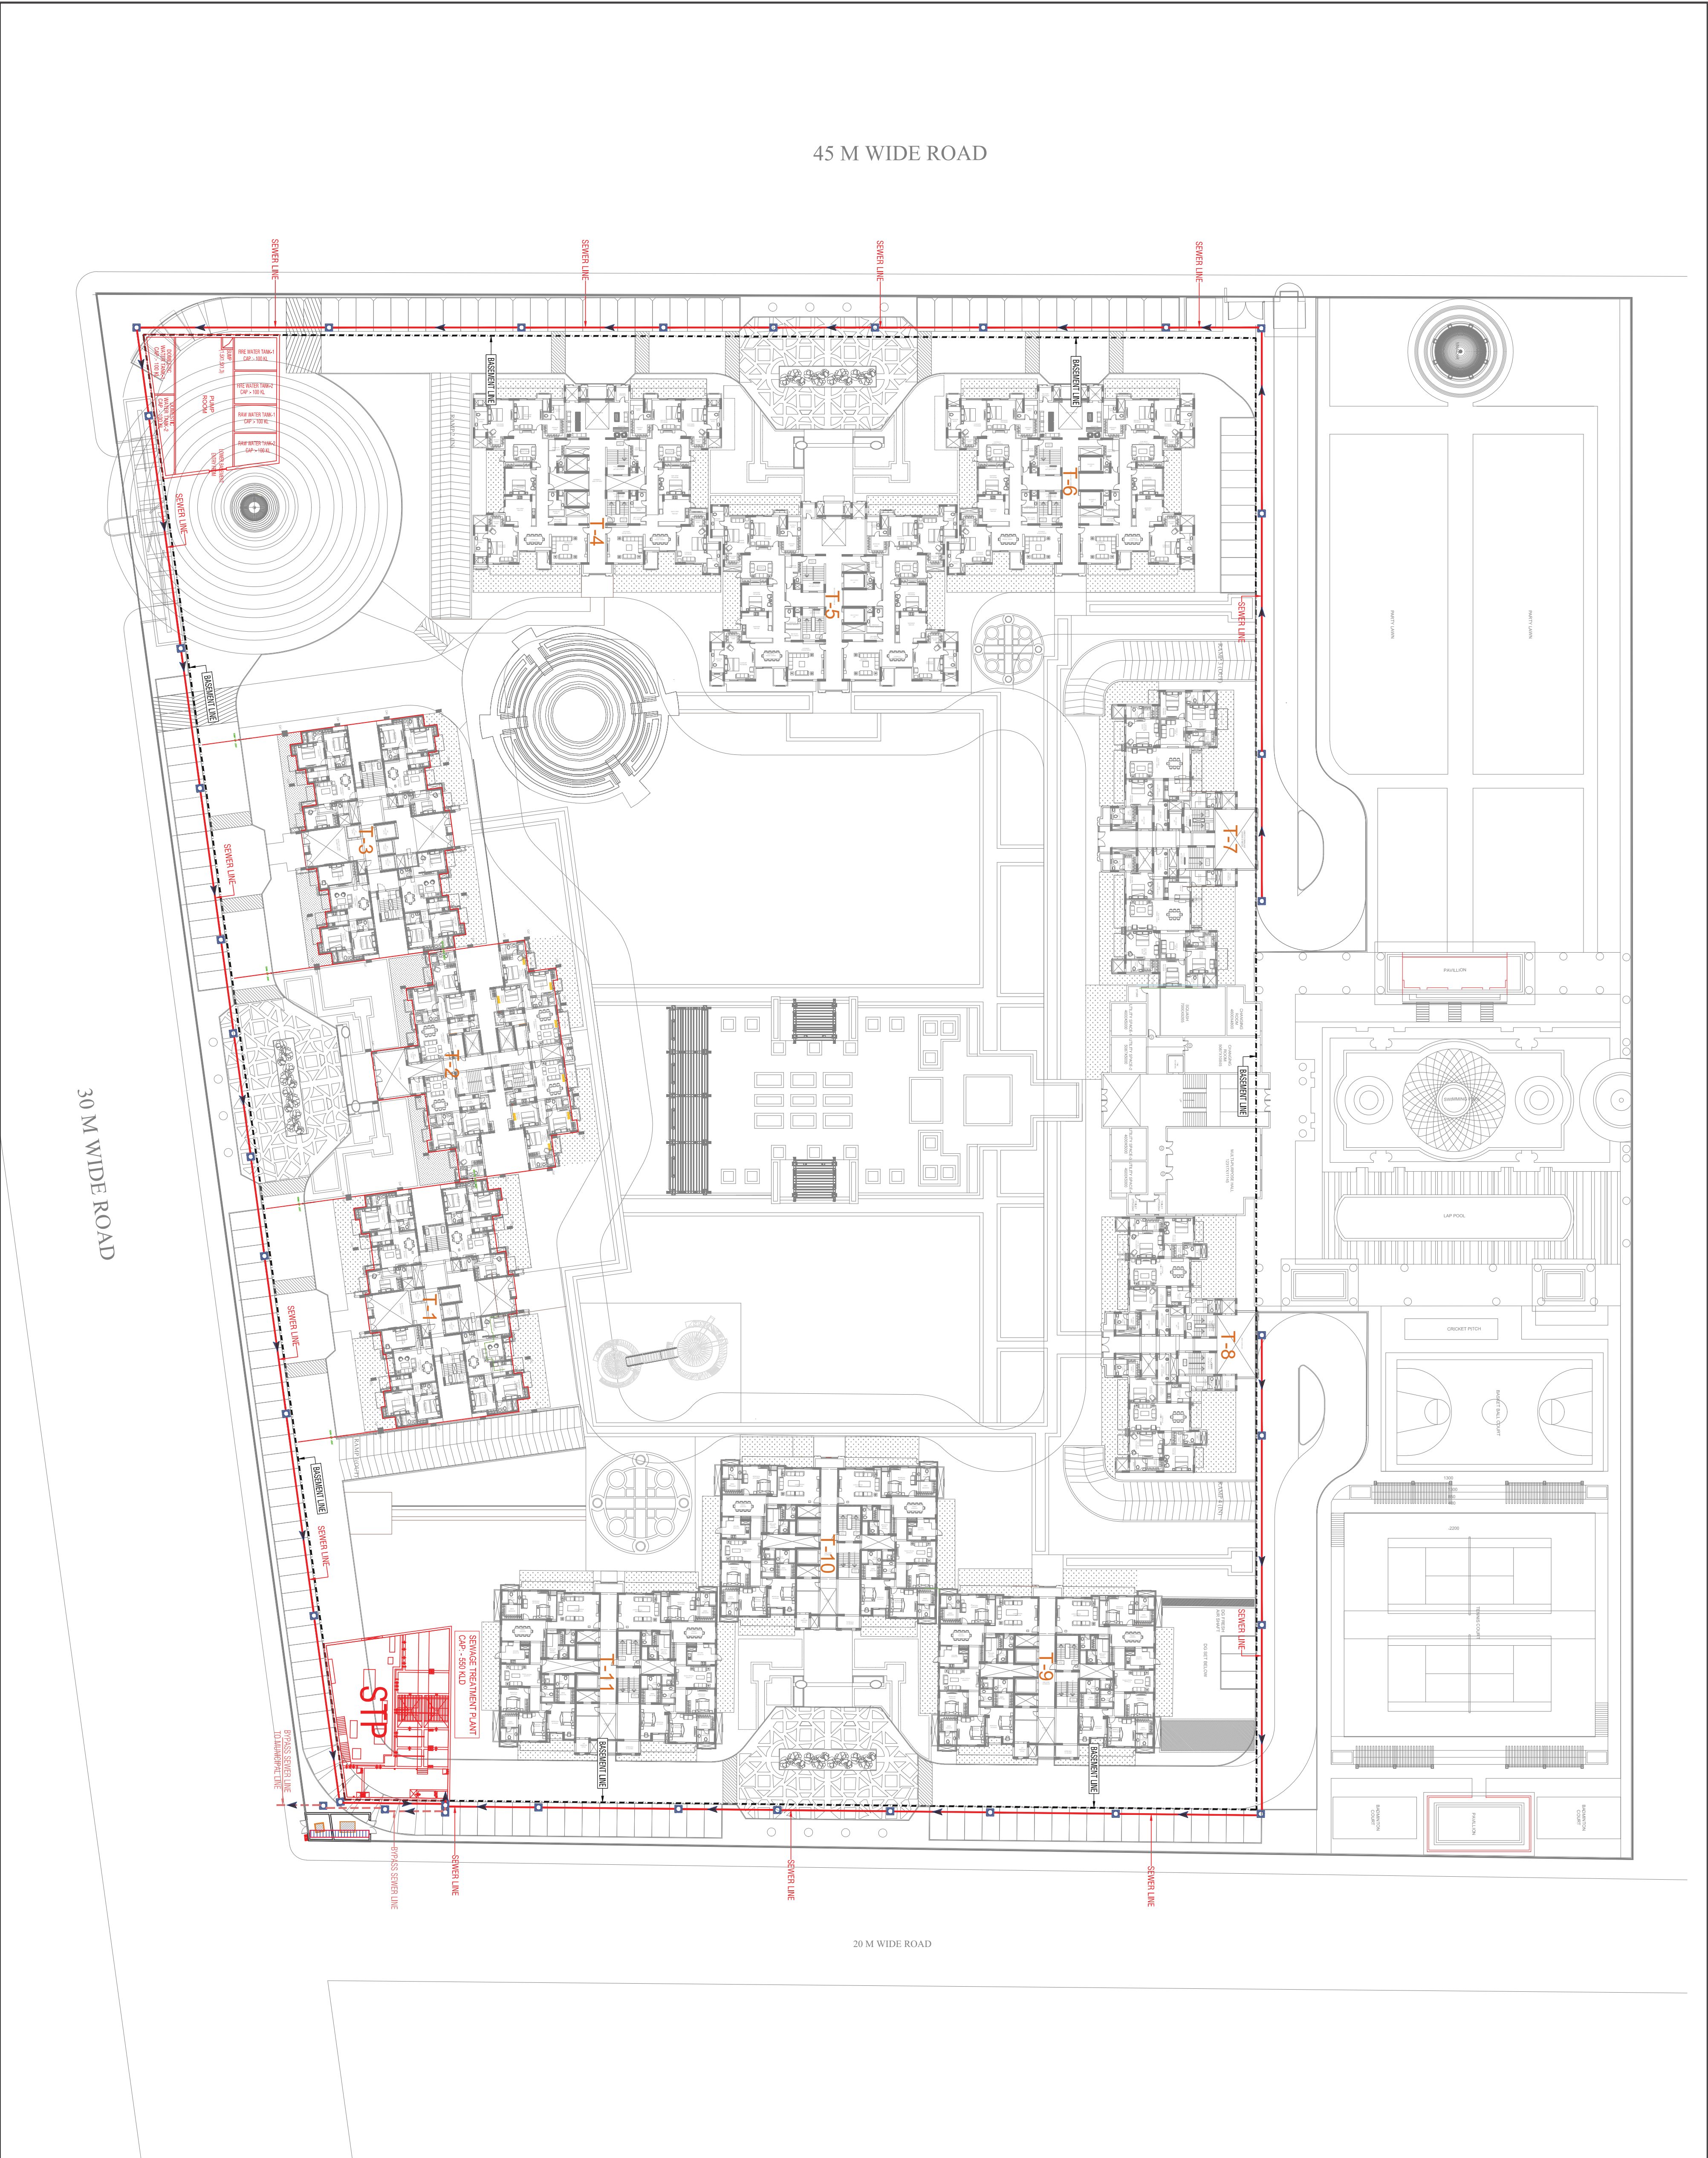

LEGEND :	
S. No.	SYMBOL. DESCRIPTION
1.	M.H. MANHOLE
2.	SEWER LINE
3.	BYPASS MANHOLE
4.	BYPASS SEWER LINE
5.	BASINENT LINE

Rev. no.	Date	Revision

Project
ACE PARKWAY
SECTOR 150, NOIDA

Title
SITE PLAN

Subtitle
EXTERNAL SEWERAGE SYSTEM

Drawing released for

☐ APPROVAL

☐ ADVANCE COPY

SUBMISSION

CONSTRUCTION

Drg. no.

ACE PARKWAY/ EX/ S-01

Scale

1:450

Date

JULY 2016

Drawn by

KULWANT

Designed by

R.K.

Checked by

Arvind Hephila

Architects

Raj Kumar

Services Consultant

Consunmate Engineering Services (P) Ltd.