



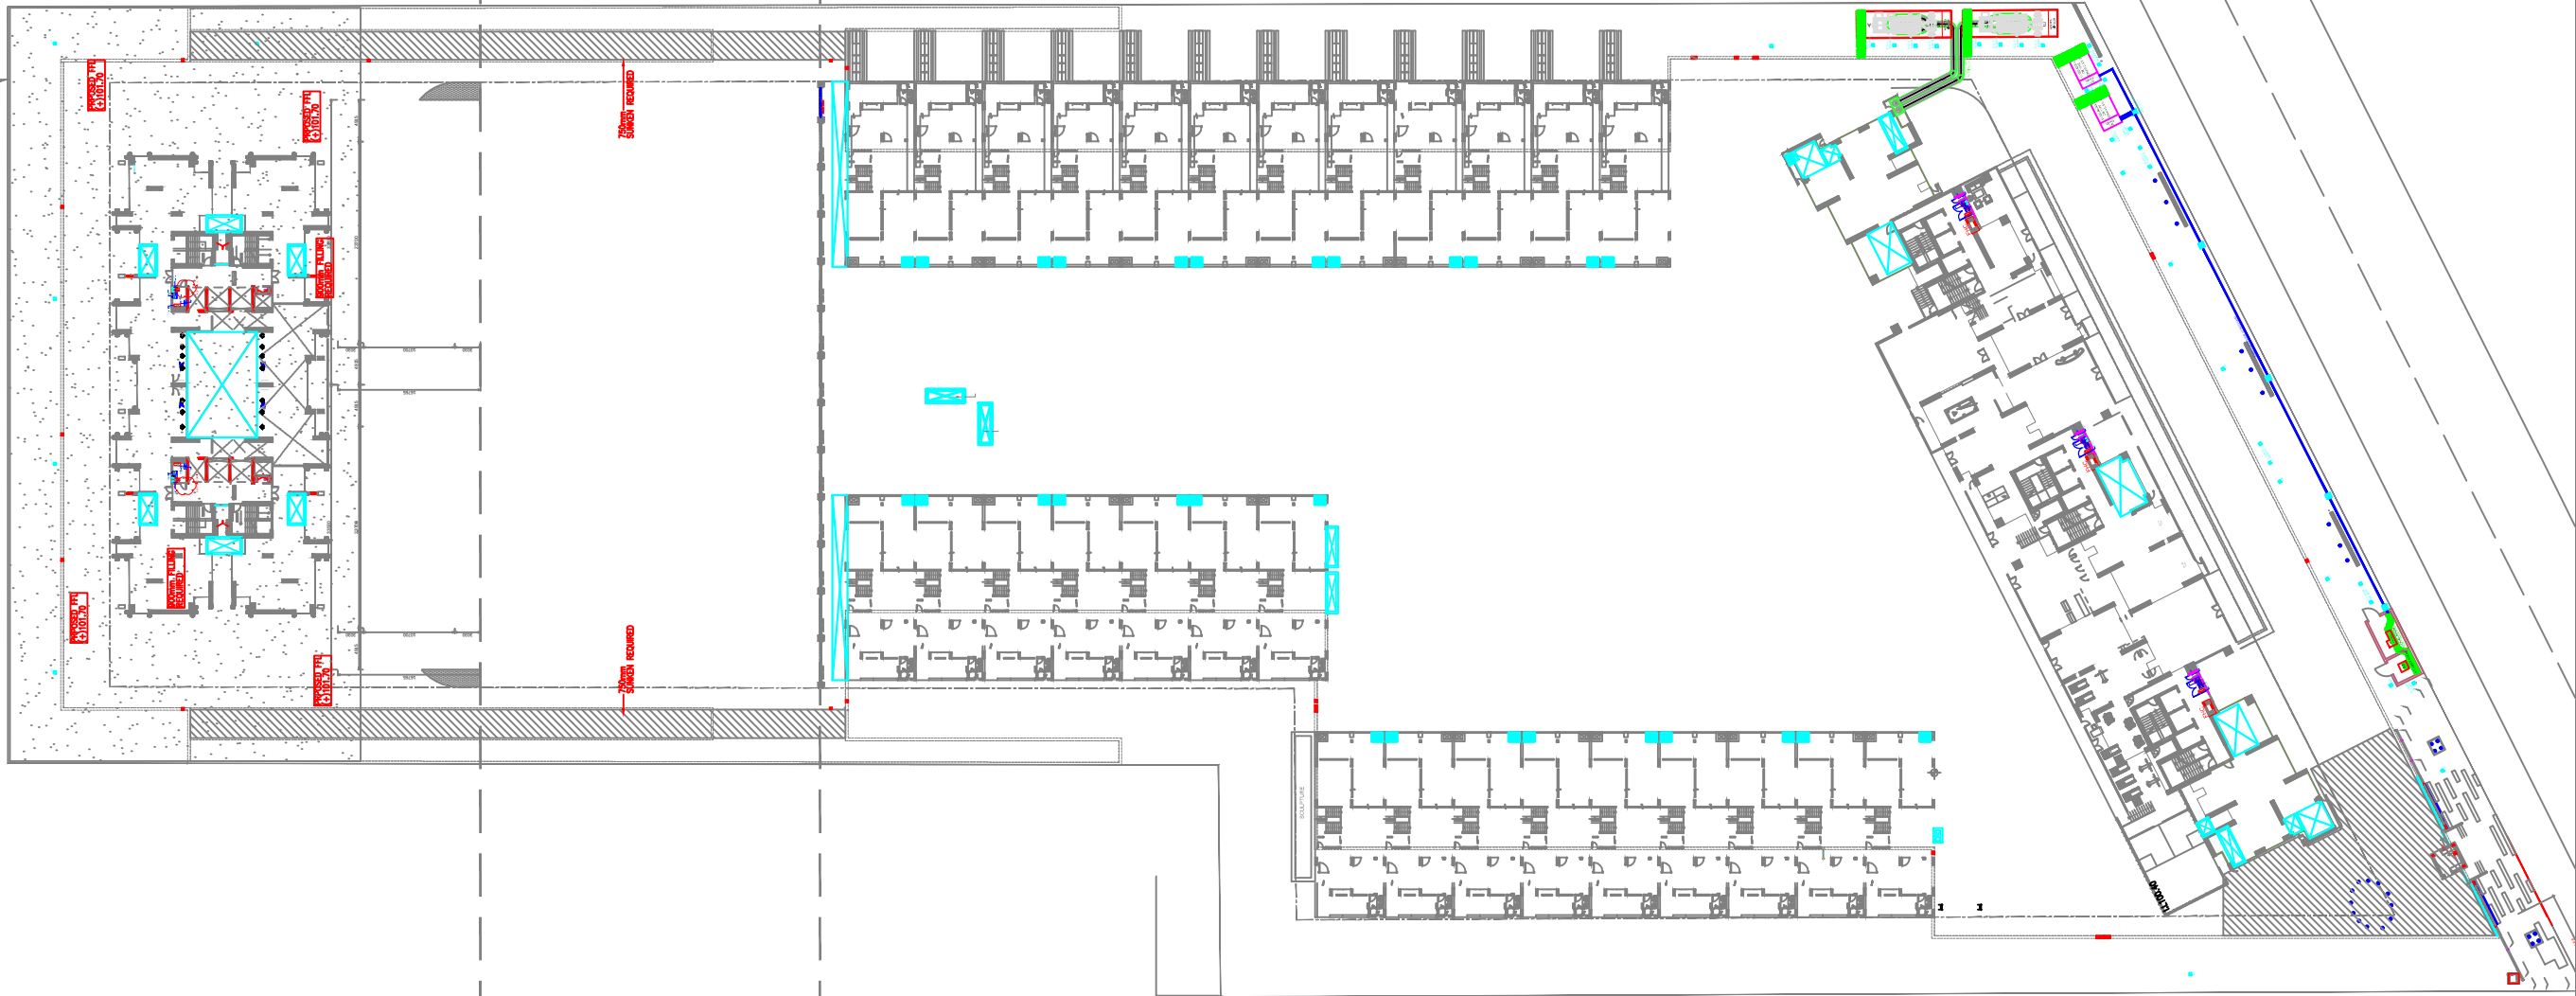

NOTE	
MANHOLE SIZE	MANHOLE DEPTH
900x800mm	750-900mm
1200 MM DIA	900-2300mm
1500 MM DIA	2310-9000mm

LEGEND :-	
SYMBOL	DESCRIPTION
	STORM LINE
	900ø/1200ø SEWER MANHOLE
	STORM MANHOLE 900x800mm
	CATCH BASIN 500x450mm

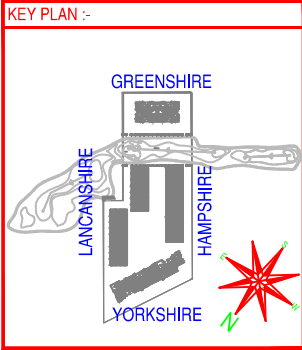

CLIENT NAME :-	
M / SLOGIX HEIGHTS PVT.LTD	
PROJECT :-	
MAHAGUN MEADOWS	
SECTOR-150,NOIDA	
PROJECT TITLE :-	

R3	20.06.16	REVISED RAIN WATER HARVESTING PIT SIZE
R2	20.05.16	REVISED STORM WATER PIPE DIA
R1	11.04.16	AS PER MARK

No.	Date	Description
Revisions		
STRUCTURAL CONSULTANT		
MAHIMTURA CONSULTANTS PVT.LTD		
MEP SERVICES CONSULTANT		
SNC SERVICES		
SNC SERVICES CONSULTANT		
LANDSCAPE CONSULTANT		
S.BOSE		

Building Services (MEP) Consultants
SNC
MEP Consulting Engineers
Sunil Nayyar Consultants Pvt. Ltd.
Head Office : 206- 206A & 305A-305B, 2nd & 3rd Floor,
Time Centre, DLF Golf Course Road,
Sector-54, Gurgaon-122002, Haryana (India)
Tele : + 91-124-4803800 (30 Lines)
Fax : + 91-124-4803817
E-mail : sncgurgaon@snc.co.in
URL : www.snc.co.in
■ Delhi ■ Gurgaon

STATUS:	G.F.C
---------	-------

TITLE:	ELECTRICAL LAYOUT MAHAGUN MEADOWS
--------	--------------------------------------

Project	MAHAGUN MEADOWS	DRG. NO. MMDW/PL/02b
Scale	1:400@A1	
Date	26.05.2016	
DRN. BY	BCJ	
CHKD. BY	AN	

Architect
Hafeez
Contractor
29 Bank Street, Bombay 23, Tel: +91 22 22681920
Fax: +91 22 22684737
www.architecthafeezcontractor.com
email: hafeez@hconcontractor.com