
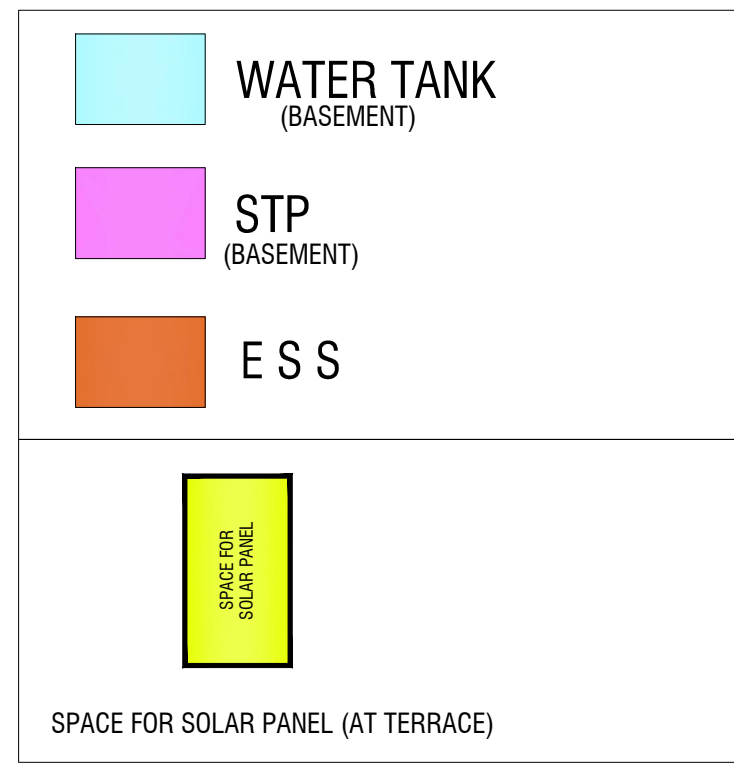
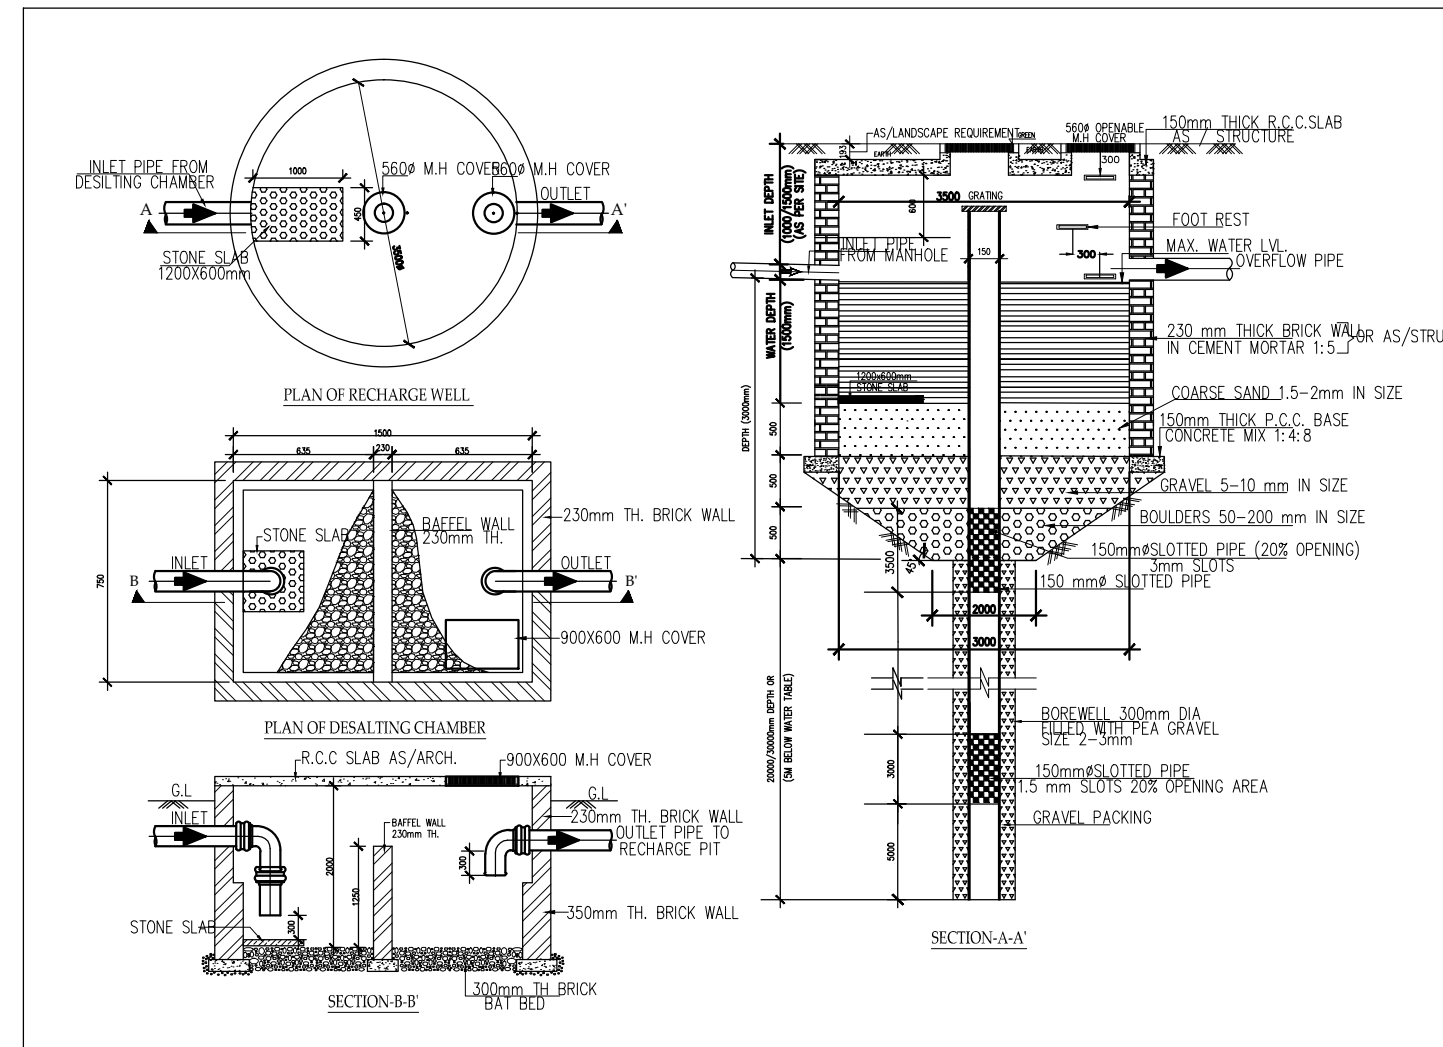


45.0M. WIDE ROAD
MASTER PLAN PROPOSED ROAD

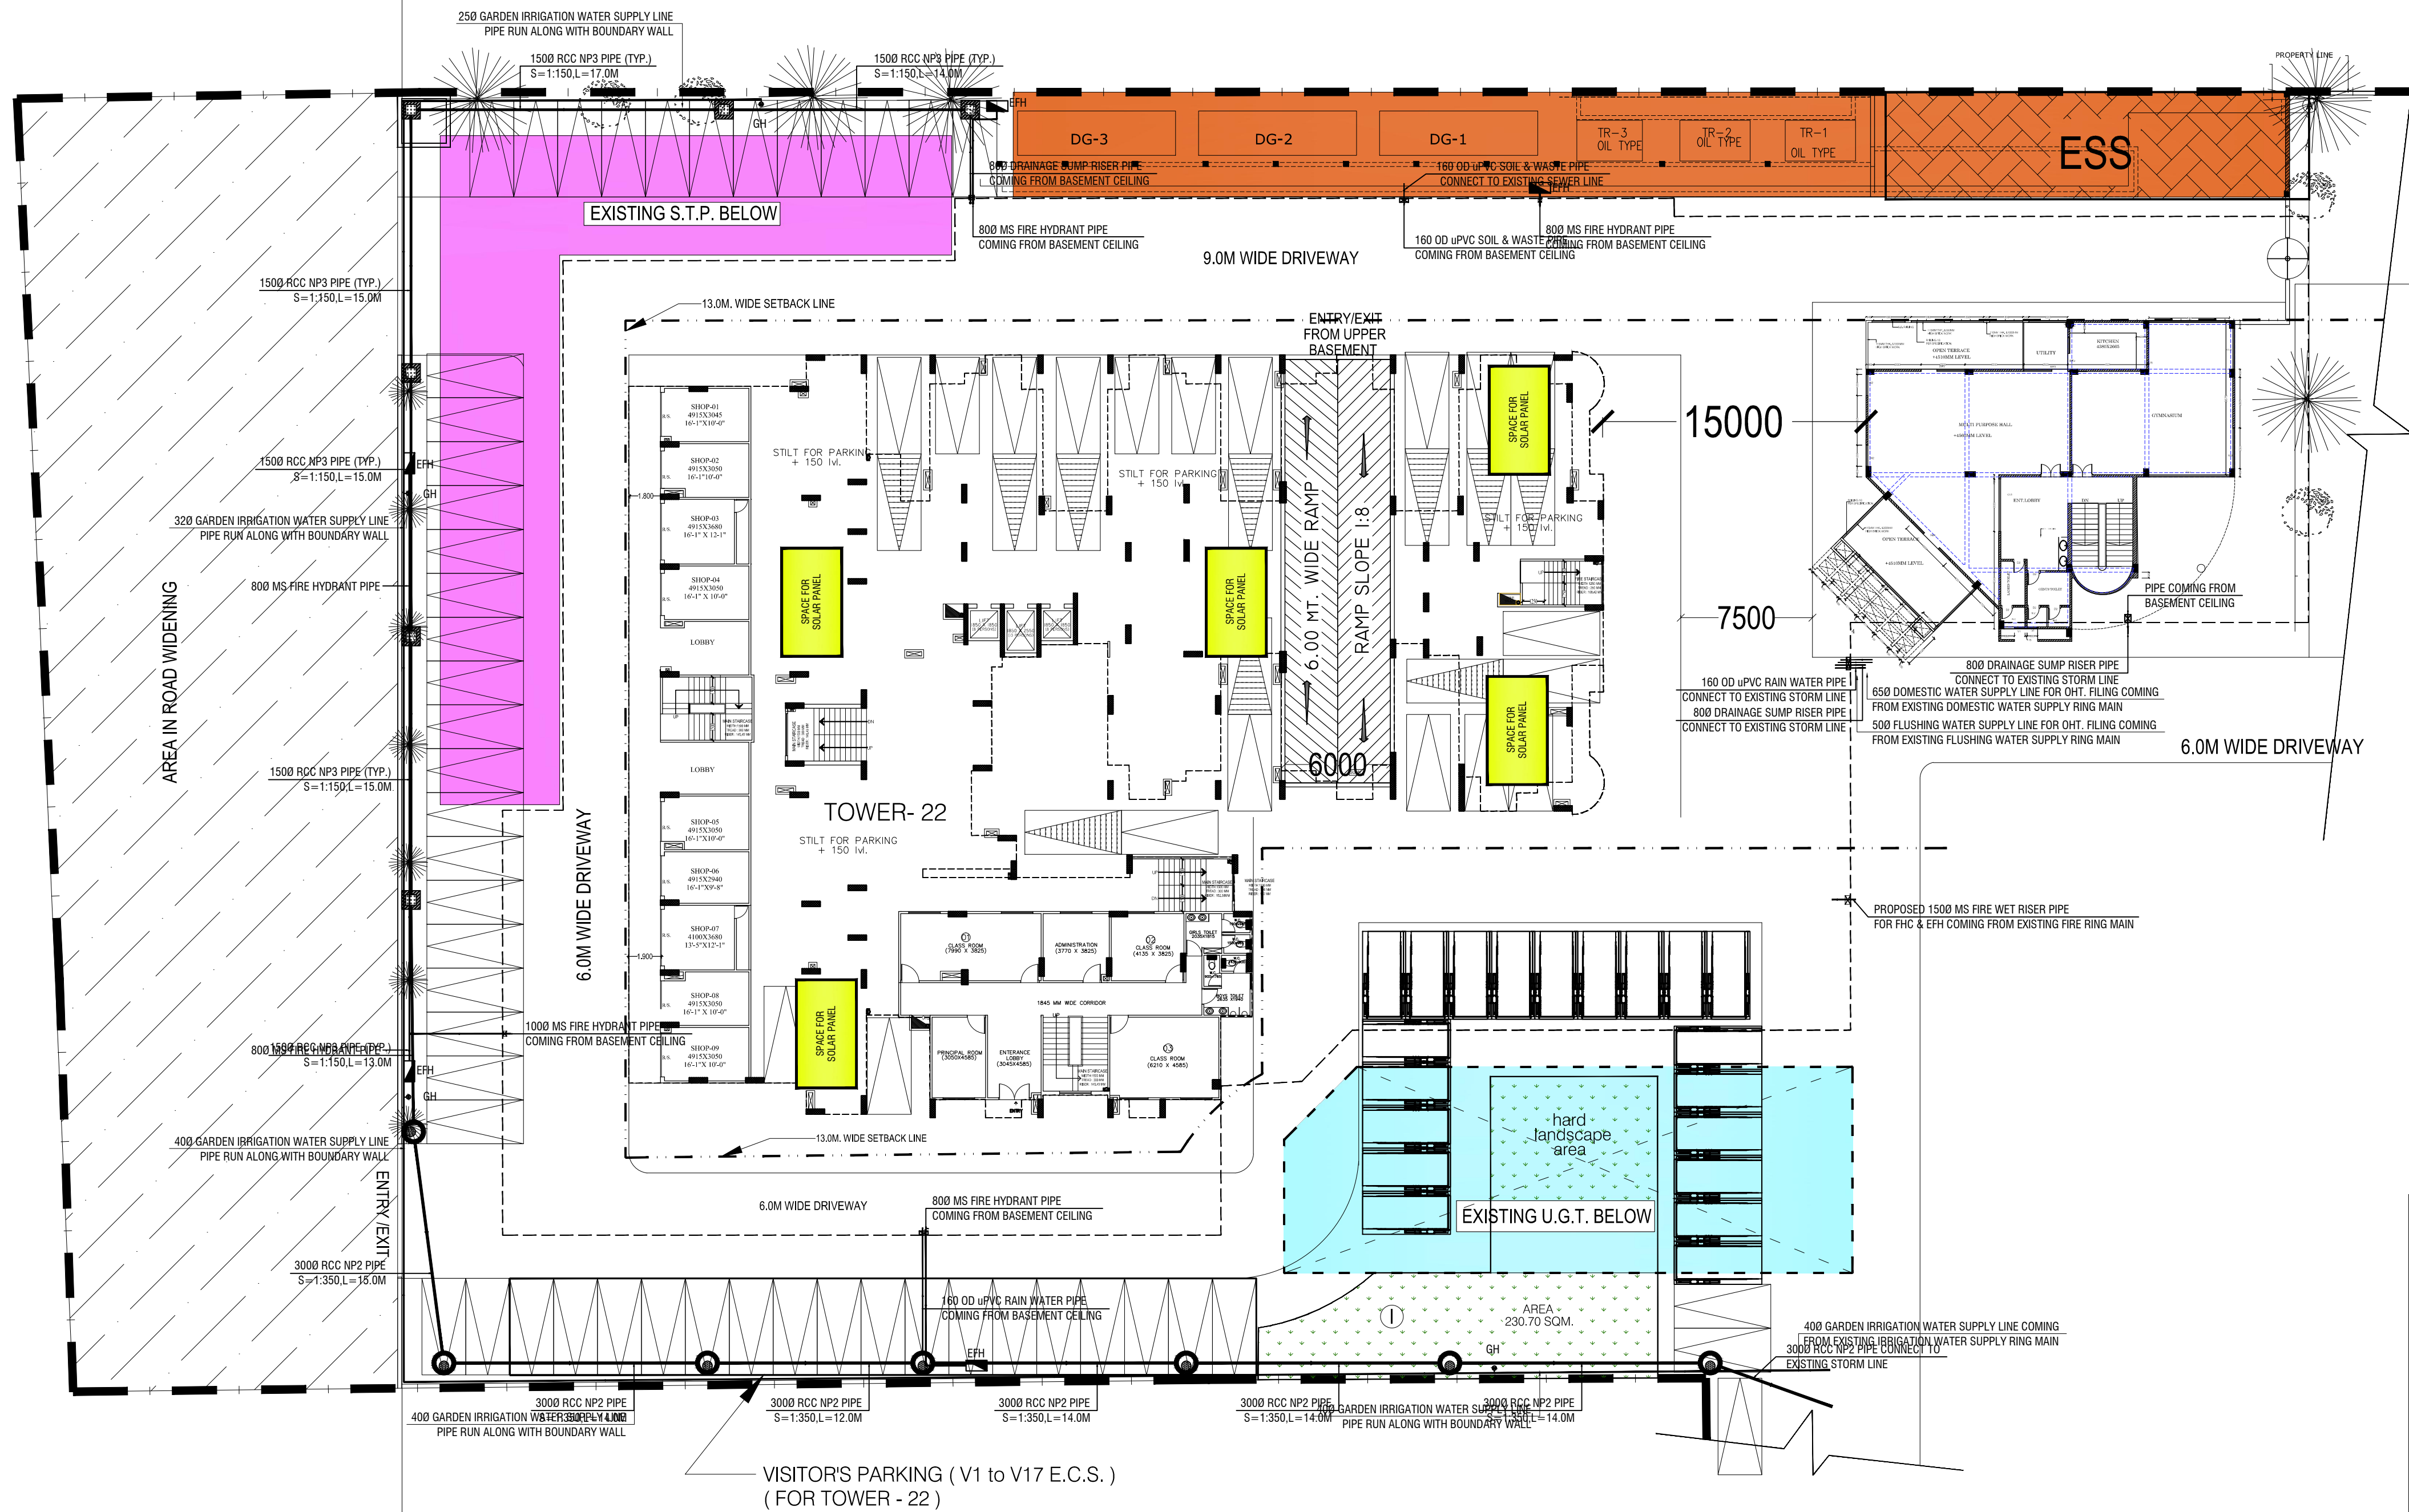

PLUMBING LEGEND:-	
	EXTERNAL STORM WATER LINE
	IRRIGATION WATER SUPPLY LINE
	EXTERNAL FIRE HYDRANT LINE
	STORM WATER MANHOLE WITH 5600 PERFORATED MANHOLE COVER.
(I)	910 DIA MANHOLE UPTO 1.67 M DEPTH
(II)	1220 DIA MANHOLE UPTO 2.29 M DEPTH
(III)	1520 DIA MANHOLE ABOVE 2.29 M DEPTH
	CATCH BASIN (600 x 600) MM
	EXTERNAL FIRE HYDRANT
	GARDEN HYDRANT
G.L.	GROUND LEVEL
I.L.	INVERT LEVEL
C.L.	CONNECTION LEVEL
D.C.	DESILTING CHAMBER (1000 x 2000 MM DIA)
COP	CLEAN OUT PLUG
	VALVE WITH CHAMBER

PROJECT:
DRAWING FOR THE
GROUP HOUSING (GULMOHUR GARDEN) A
KHASRA NO. 1131, 1133, 1139,1143,1144
VILLAGE NOOR NAGAR, PARGANA LONI,
TEHSIL & DIST. GHAZIABAD, U.P.


OWNER:
M/s.S.V.P. BUILDERS INDIA LTD.
M/s.S.V.P. DEVELOPERS
M/s.JPG BUILDERS

DRAWING TITLE :
PLAN OF DEVELOPMENT OF WOR
TOWER - 22

AUTH. SIGN. ARCHITECT'S SIGN.

Design Studio
ANUJ AGARWAL ARCHITECTS
OFFICE:- A-244 KAUSHAMBI GHAZIABAD (U.P.)
Ph-0120 - 4165716 , 4563716 , 6454182
e-mail : arch.anujagarwal@gmail.com

SCALE N.T.S. DATE
DESIGN BY DRG. No. DG-02

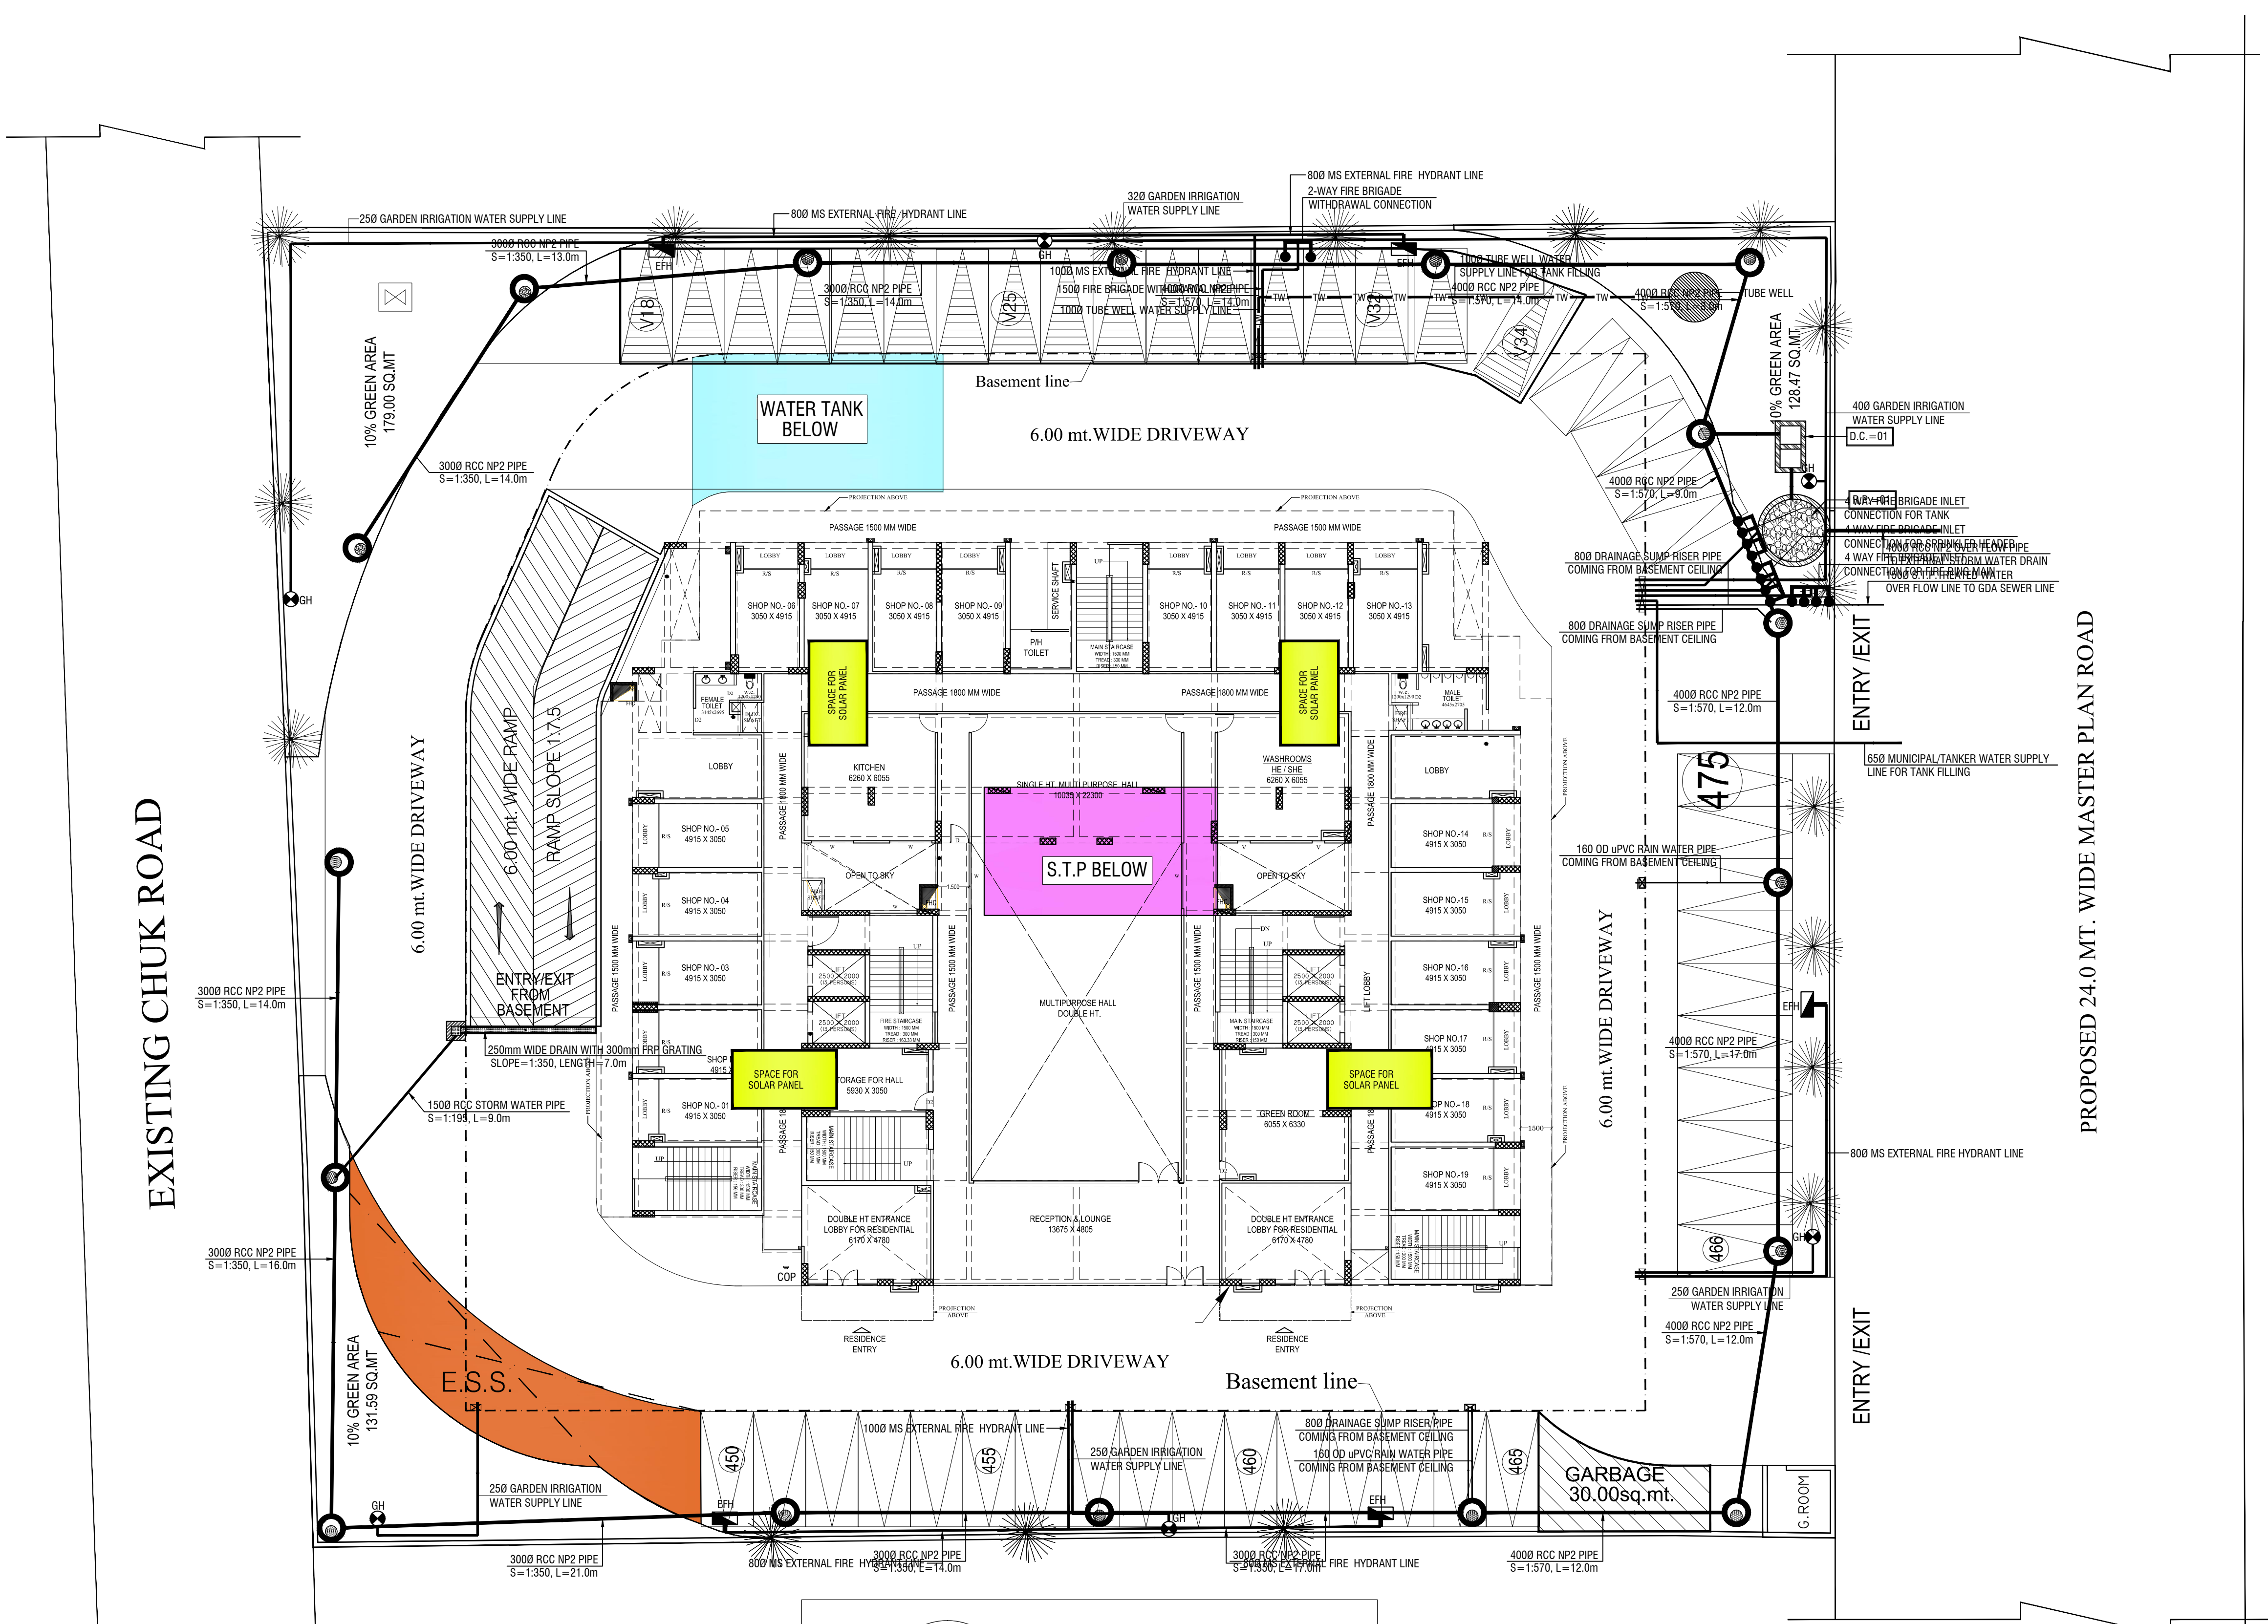


PLUMBING LEGEND:-	
	EXTERNAL STORM WATER LINE
	DOMESTIC WATER SUPPLY FILLING LINE FROM MUNICIPAL / TANKER LINE.
	IRRIGATION WATER SUPPLY LINE
	TUBE WELL WATER SUPPLY LINE
	EXTERNAL FIRE HYDRANT LINE
	STORM WATER MANHOLE WITH 5600 PERFORATED MANHOLE COVER.
(I)	910 DIA MANHOLE UPTO 1.67 M DEPTH
(II)	1220 DIA MANHOLE UPTO 2.29 M DEPTH
(III)	1520 DIA MANHOLE ABOVE 2.29 M DEPTH
	CATCH BASIN (600 x 600) MM
	EXTERNAL FIRE HYDRANT
	GARDEN HYDRANT
G.L.	GROUND LEVEL
I.L.	INVERT LEVEL
C.L. R.P.	CONNECTION LEVEL RECHARGE PIT (3000 MM DIA)
D.C.	DESILTING CHAMBER (1000 x 2000 MM DIA)
COP	CLEAN OUT PLUG
	VALVE WITH CHAMBER

PROJECT:
DRAWING FOR THE
GROUP HOUSING (GULMOHUR GARDEN) AT
KHASRA NO. 1131, 1133, 1139,1143,1144
VILLAGE NOOR NAGAR, PARGANA LONI,
TEHSIL & DIST. GHAZIABAD, U.P.

OWNER:
M/s.S.V.P. BUILDERS INDIA LTD.
M/s.S.V.P. DEVELOPERS
M/s.JPG BUILDERS

DRAWING TITLE :
PLAN OF DEVELOPMENT OF WORK
TOWER - 25

AUTH. SIGN. ARCHITECT'S SIGN.

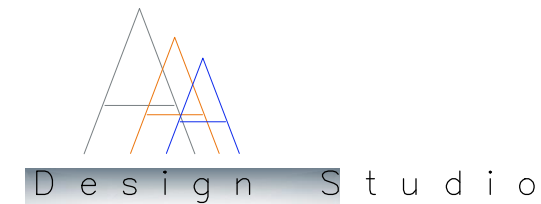

ANUJ AGARWAL ARCHITECTS
OFFICE:- A-244 KAUSHAMBI GHAZIABAD (U.P.)
Ph:-0120 - 4165716 , 4563716 , 6454182
e-mail : arch.anujagarwal@gmail.com

SCALE N.T.S	DEALT BY	DATE
DESIGN BY		DRG. No. DG-02

WATER TANK
(BASEMENT)

STP
(BASEMENT)

ESS

SPACE FOR SOLAR PANEL
(AT TERRACE)

