


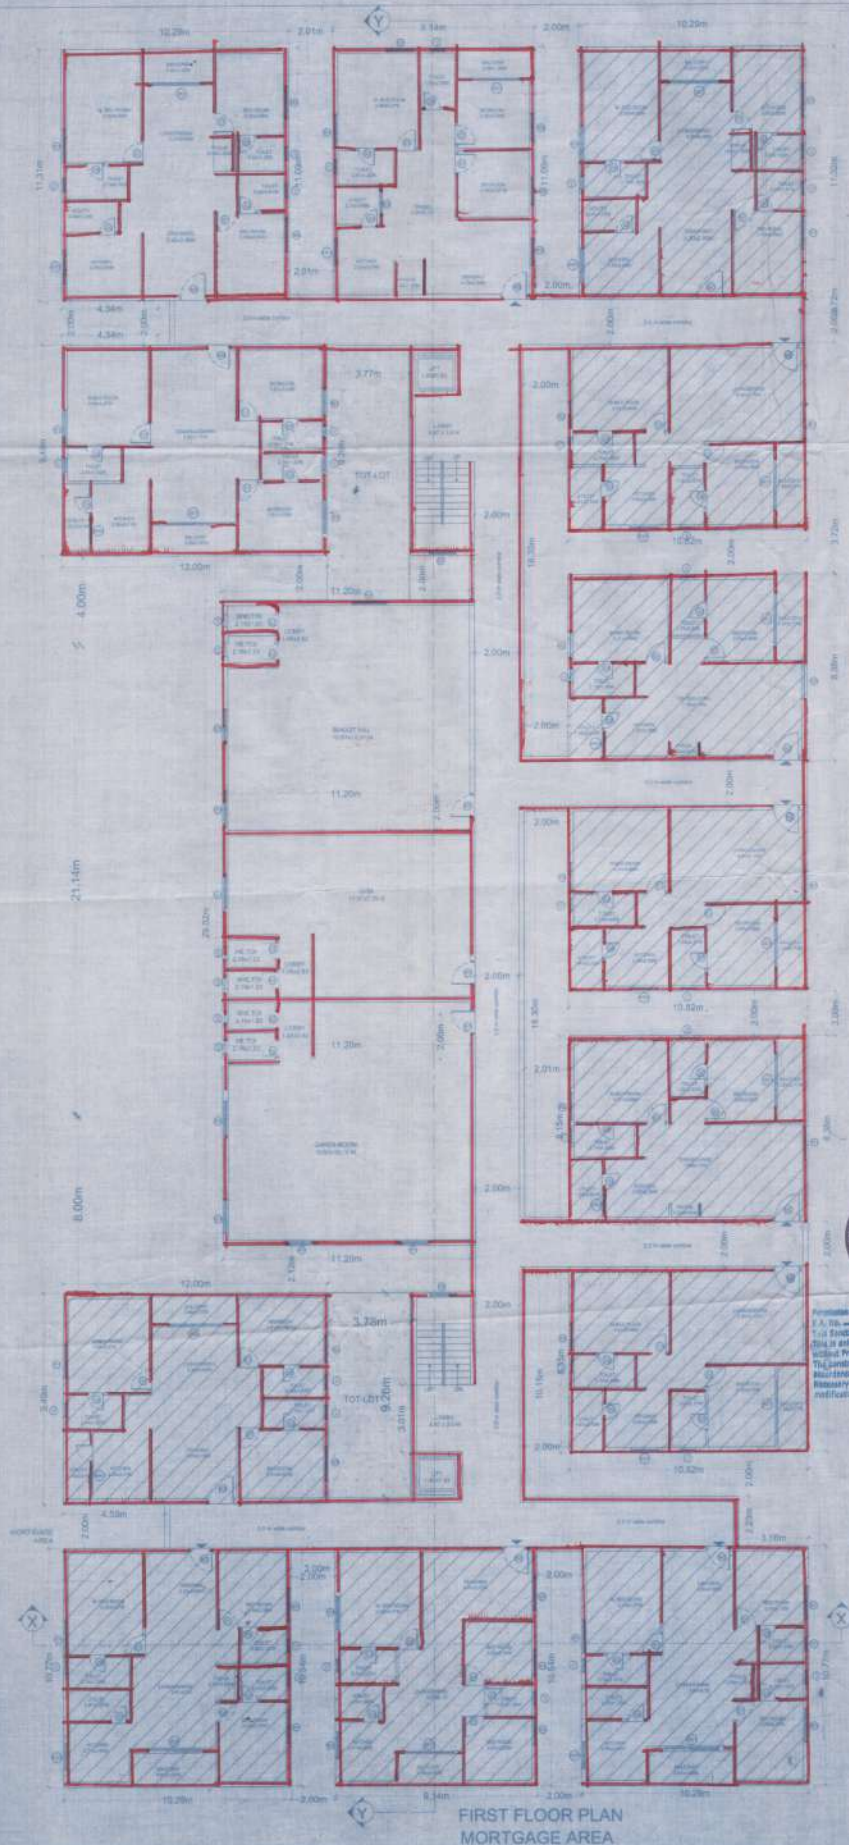

FIRST FLOOR PLAN
MORTGAGE AREA

TITLE

PLAN SHOWING THE PROPOSED RESIDENTIAL BUILDING CONSISTING OF (PARKING STILT + 5 UPPER FLOORS) IN PLOT NO.4 PART, SY No'S - 32.38 & 39, SITUATED AT NAGARAM VILLAGE AND MUNICIPALITY, KEESARA MANDAL, MEDCHAL-MALKAJGIRI DISTRICT, TELANGANA STATE.

BELONGING TO:

LAND OWNER:
BMT - POTLURI LAKSHMI TEJESWINI,
D/o Sd P. SUBRAMANYESWARA RAO.

DEVELOPER:

M/S SRI ACHYUTA RAINBOW INFRA.

REPRESENTED BY:

MANAGING PARTNER:
SRIKANUMURI VENKATA SATHYANARAYANA RAJU,
S/O. LATE VENKATAPATHI RAJU.

REFERENCE:

SCALE: 1:100

PROPOSED:

EXISTING:



SCHEDULE OF OPENINGS

ITEM	DESCRIPTION	REMARKS
MAIN DOOR	MD	1.20 x 2.00 m
DOOR	D1	0.90 x 2.00 m
DOOR	D2	0.90 x 2.00 m
SLIDING DOOR	SD1	2.40 x 2.00 m
WINDOW	W1	1.50 x 1.50 m
WINDOW	W2	1.50 x 1.50 m
WINDOW	W3	0.90 x 1.50 m
WINDOW	W4	1.20 x 1.50 m
WINDOW	W5	1.20 x 1.50 m
WINDOW	W6	0.90 x 1.50 m
VENTILATOR	V	0.90 x 0.90 m

AREA STATEMENT

ITEM	DESCRIPTION	REMARKS
TOTAL LAND AREA	100.00 SQ. MTS	
STILT FLOOR AREA	100.00 SQ. MTS	
STILT FLOOR PARKING AREA	100.00 SQ. MTS	
STILT FLOOR SERVICE AREA	100.00 SQ. MTS	
STILT FLOOR TOTAL AREA	100.00 SQ. MTS	

1. The Applicant/Developer should submit the following documents to the Local Authority for approval of the proposed building plan:
a. A site plan showing the location of the building on the plot.
b. A floor plan showing the layout of the building.
c. A section drawing showing the height of the building.
d. A structural drawing showing the foundation and structural frame.
e. A drainage plan showing the location of the drainage system.
f. A water supply plan showing the location of the water supply system.
g. A fire safety plan showing the location of the fire safety system.
h. A security plan showing the location of the security system.
i. A landscape plan showing the location of the landscape system.
j. A parking plan showing the location of the parking system.

2. The Applicant/Developer should submit the following documents to the Local Authority for approval of the proposed building plan:
a. A site plan showing the location of the building on the plot.
b. A floor plan showing the layout of the building.
c. A section drawing showing the height of the building.
d. A structural drawing showing the foundation and structural frame.
e. A drainage plan showing the location of the drainage system.
f. A water supply plan showing the location of the water supply system.
g. A fire safety plan showing the location of the fire safety system.
h. A security plan showing the location of the security system.
i. A landscape plan showing the location of the landscape system.
j. A parking plan showing the location of the parking system.

3. The Applicant/Developer should submit the following documents to the Local Authority for approval of the proposed building plan:
a. A site plan showing the location of the building on the plot.
b. A floor plan showing the layout of the building.
c. A section drawing showing the height of the building.
d. A structural drawing showing the foundation and structural frame.
e. A drainage plan showing the location of the drainage system.
f. A water supply plan showing the location of the water supply system.
g. A fire safety plan showing the location of the fire safety system.
h. A security plan showing the location of the security system.
i. A landscape plan showing the location of the landscape system.
j. A parking plan showing the location of the parking system.

4. The Applicant/Developer should submit the following documents to the Local Authority for approval of the proposed building plan:
a. A site plan showing the location of the building on the plot.
b. A floor plan showing the layout of the building.
c. A section drawing showing the height of the building.
d. A structural drawing showing the foundation and structural frame.
e. A drainage plan showing the location of the drainage system.
f. A water supply plan showing the location of the water supply system.
g. A fire safety plan showing the location of the fire safety system.
h. A security plan showing the location of the security system.
i. A landscape plan showing the location of the landscape system.
j. A parking plan showing the location of the parking system.

5. The Applicant/Developer should submit the following documents to the Local Authority for approval of the proposed building plan:
a. A site plan showing the location of the building on the plot.
b. A floor plan showing the layout of the building.
c. A section drawing showing the height of the building.
d. A structural drawing showing the foundation and structural frame.
e. A drainage plan showing the location of the drainage system.
f. A water supply plan showing the location of the water supply system.
g. A fire safety plan showing the location of the fire safety system.
h. A security plan showing the location of the security system.
i. A landscape plan showing the location of the landscape system.
j. A parking plan showing the location of the parking system.

6. The Applicant/Developer should submit the following documents to the Local Authority for approval of the proposed building plan:
a. A site plan showing the location of the building on the plot.
b. A floor plan showing the layout of the building.
c. A section drawing showing the height of the building.
d. A structural drawing showing the foundation and structural frame.
e. A drainage plan showing the location of the drainage system.
f. A water supply plan showing the location of the water supply system.
g. A fire safety plan showing the location of the fire safety system.
h. A security plan showing the location of the security system.
i. A landscape plan showing the location of the landscape system.
j. A parking plan showing the location of the parking system.