


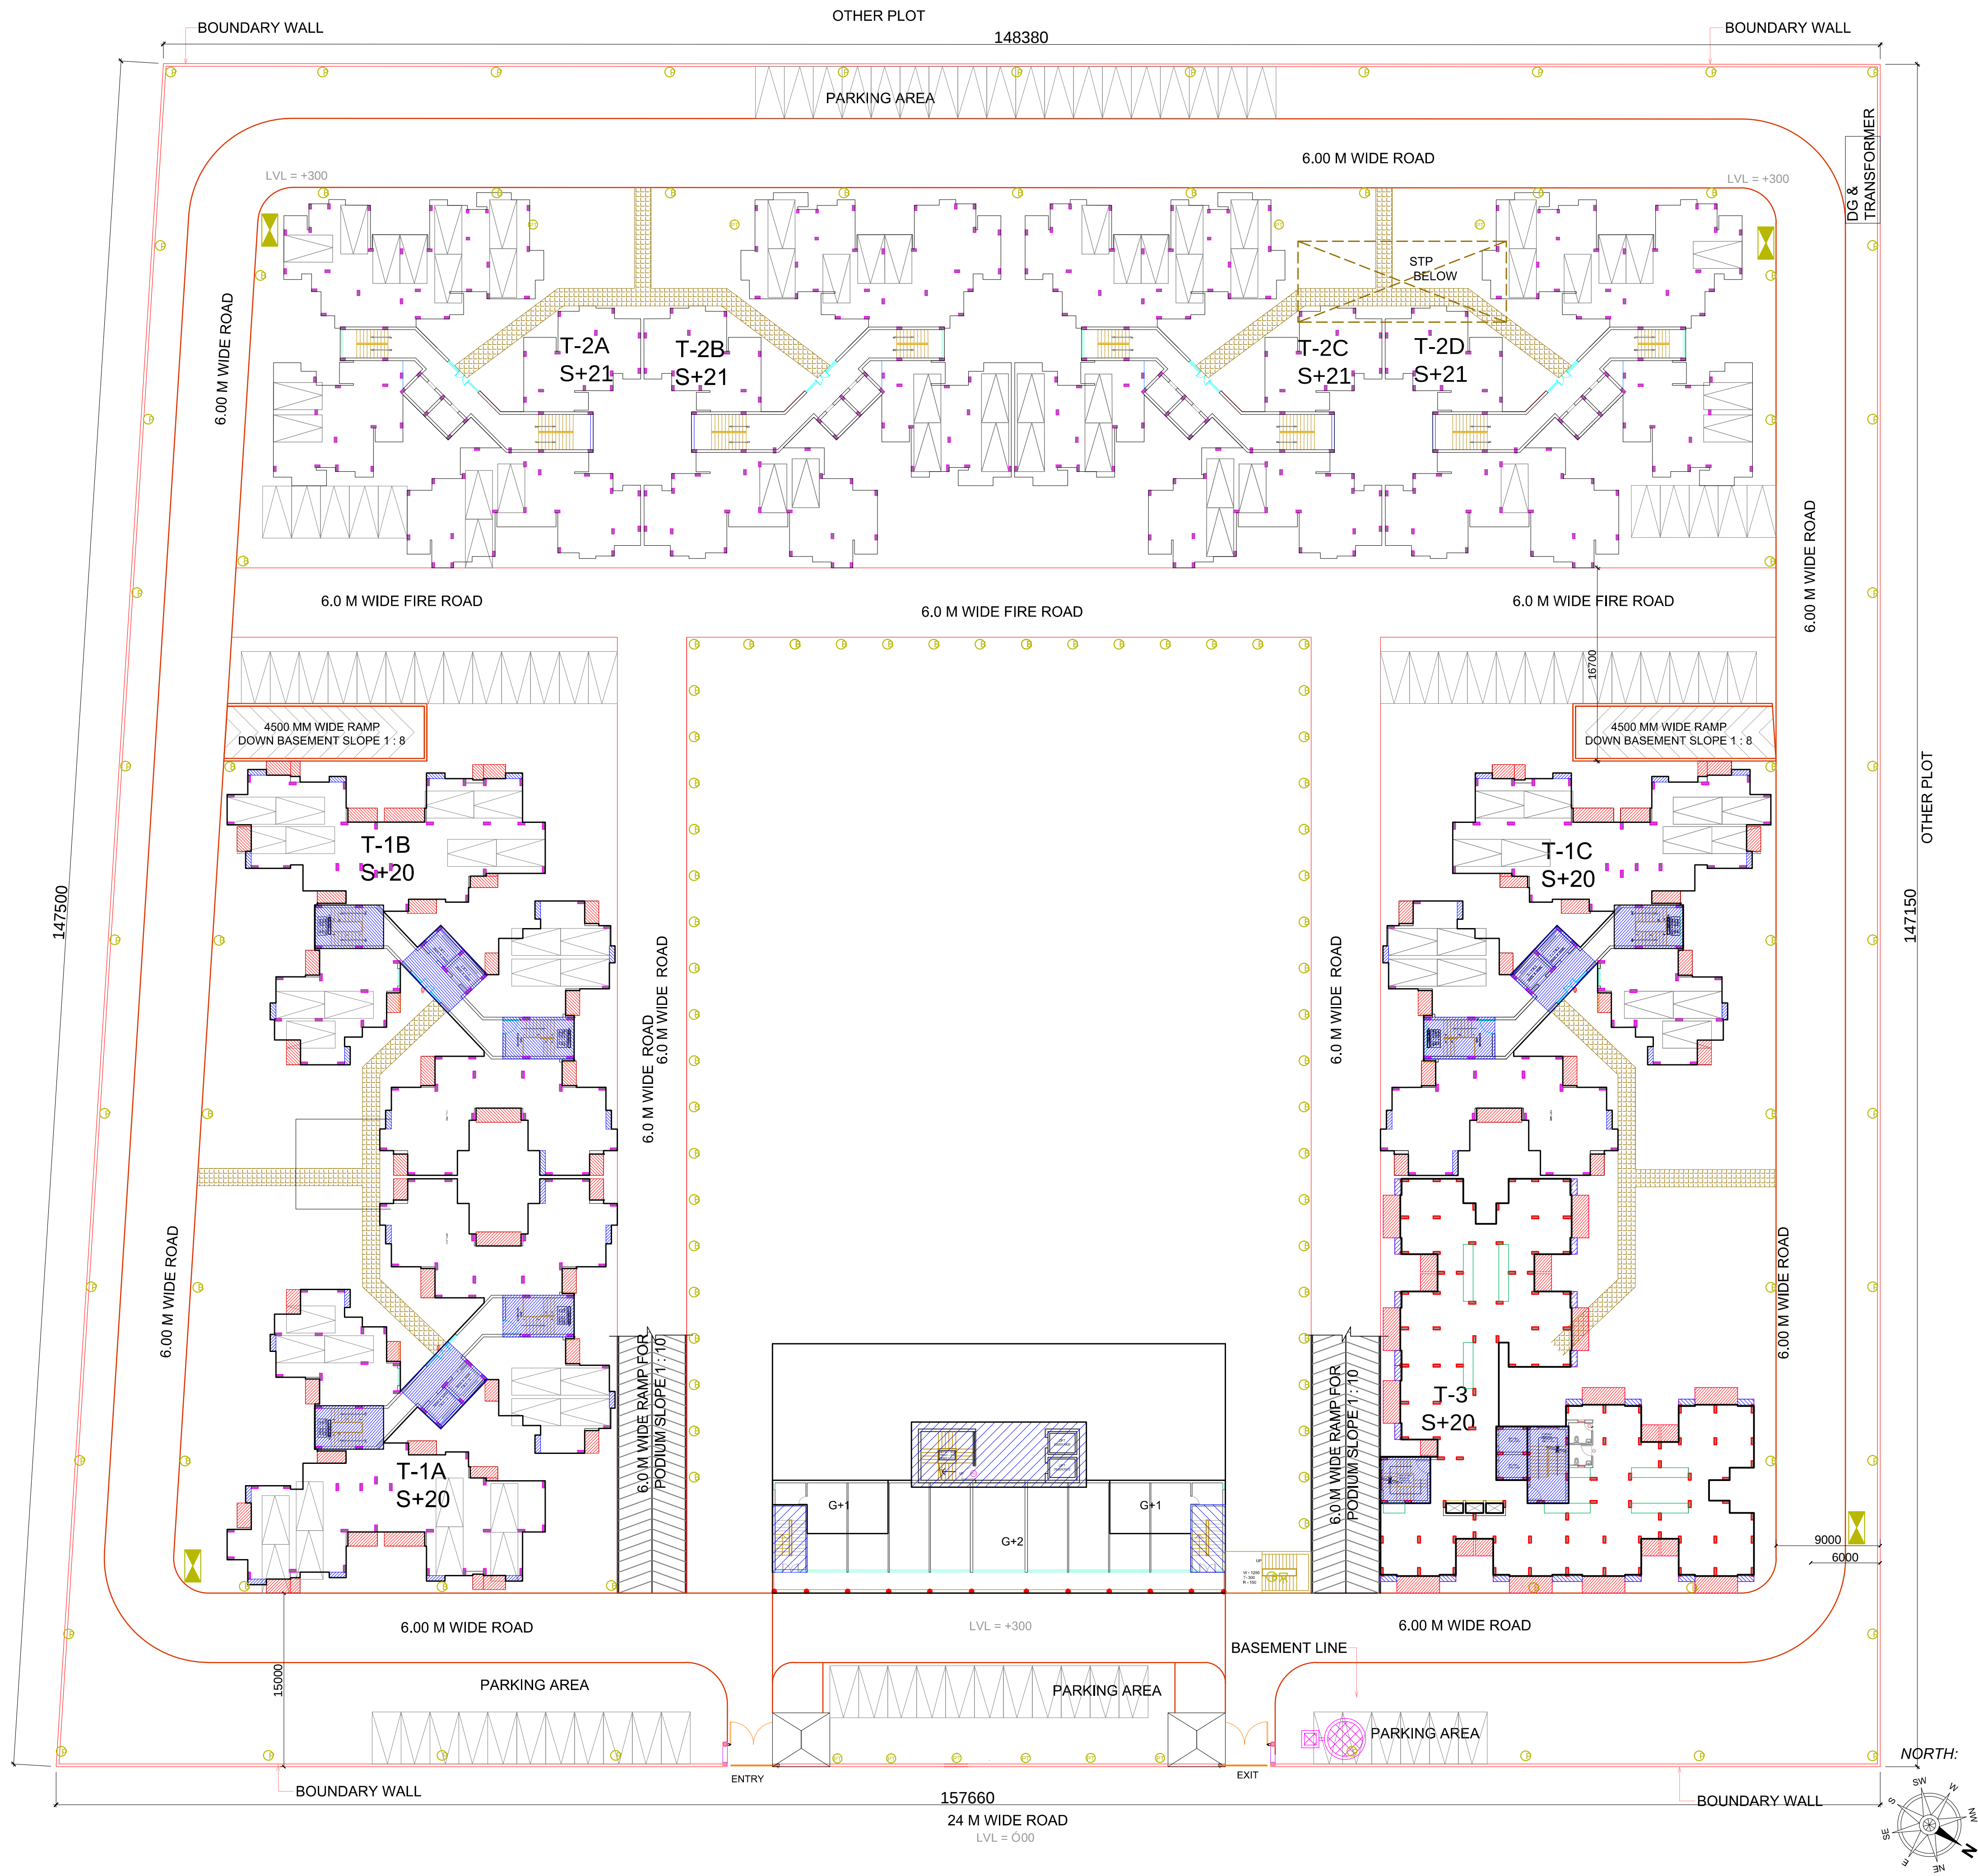

	POLE LIGHT
	BOLLARD LIGHT
	POST TOP LIGHT
	SPIKE LIGHT
	FEEDER PILLAR

PROJECT:
**PROPOSED GROUP HOUSING FOR
M/S ECOGREEN BUILDTECH Pvt. Ltd.
AT PLOT NO. GH-02B, SECTOR - 10,
GREATER NOIDA (U.P.)**

CLIENT:
**M/S ECOGREEN BUILDTECH Pvt. Ltd.
38 , C BLOCK DDA MARKET,
SURAJMAL VIHAR DELHI - 110092**

ARCHITECT:
R T & Associates Pvt. Ltd.
ARCHITECTS, DESIGNERS & PROJECT MANAGEMENT
A-47 & 48, SECTOR - 67
NOIDA - 201301, UTTAR PRADESH
TEL: 0120 - 6495313, 2484020 / 21
FAX: 0120 - 6495313 E-MAIL: rtadesigns@gmail.com

OWNER'S SIGNATURE	ARCHITECT'S SIGNATURE
	RAHUL TYAGI CA / 97 / 22027

REVISION SUBMISSION
DRAWING TITLE:
EXTERNAL ELECTRICAL LAYOUT PLAN

DRAWN ALOK SHARMA	CHKD PARDEEP SHARMA	SHEET SIZE A-1	DWG. NO. A - 00
SCALE 1: 900	DATE 25-07-2014		