


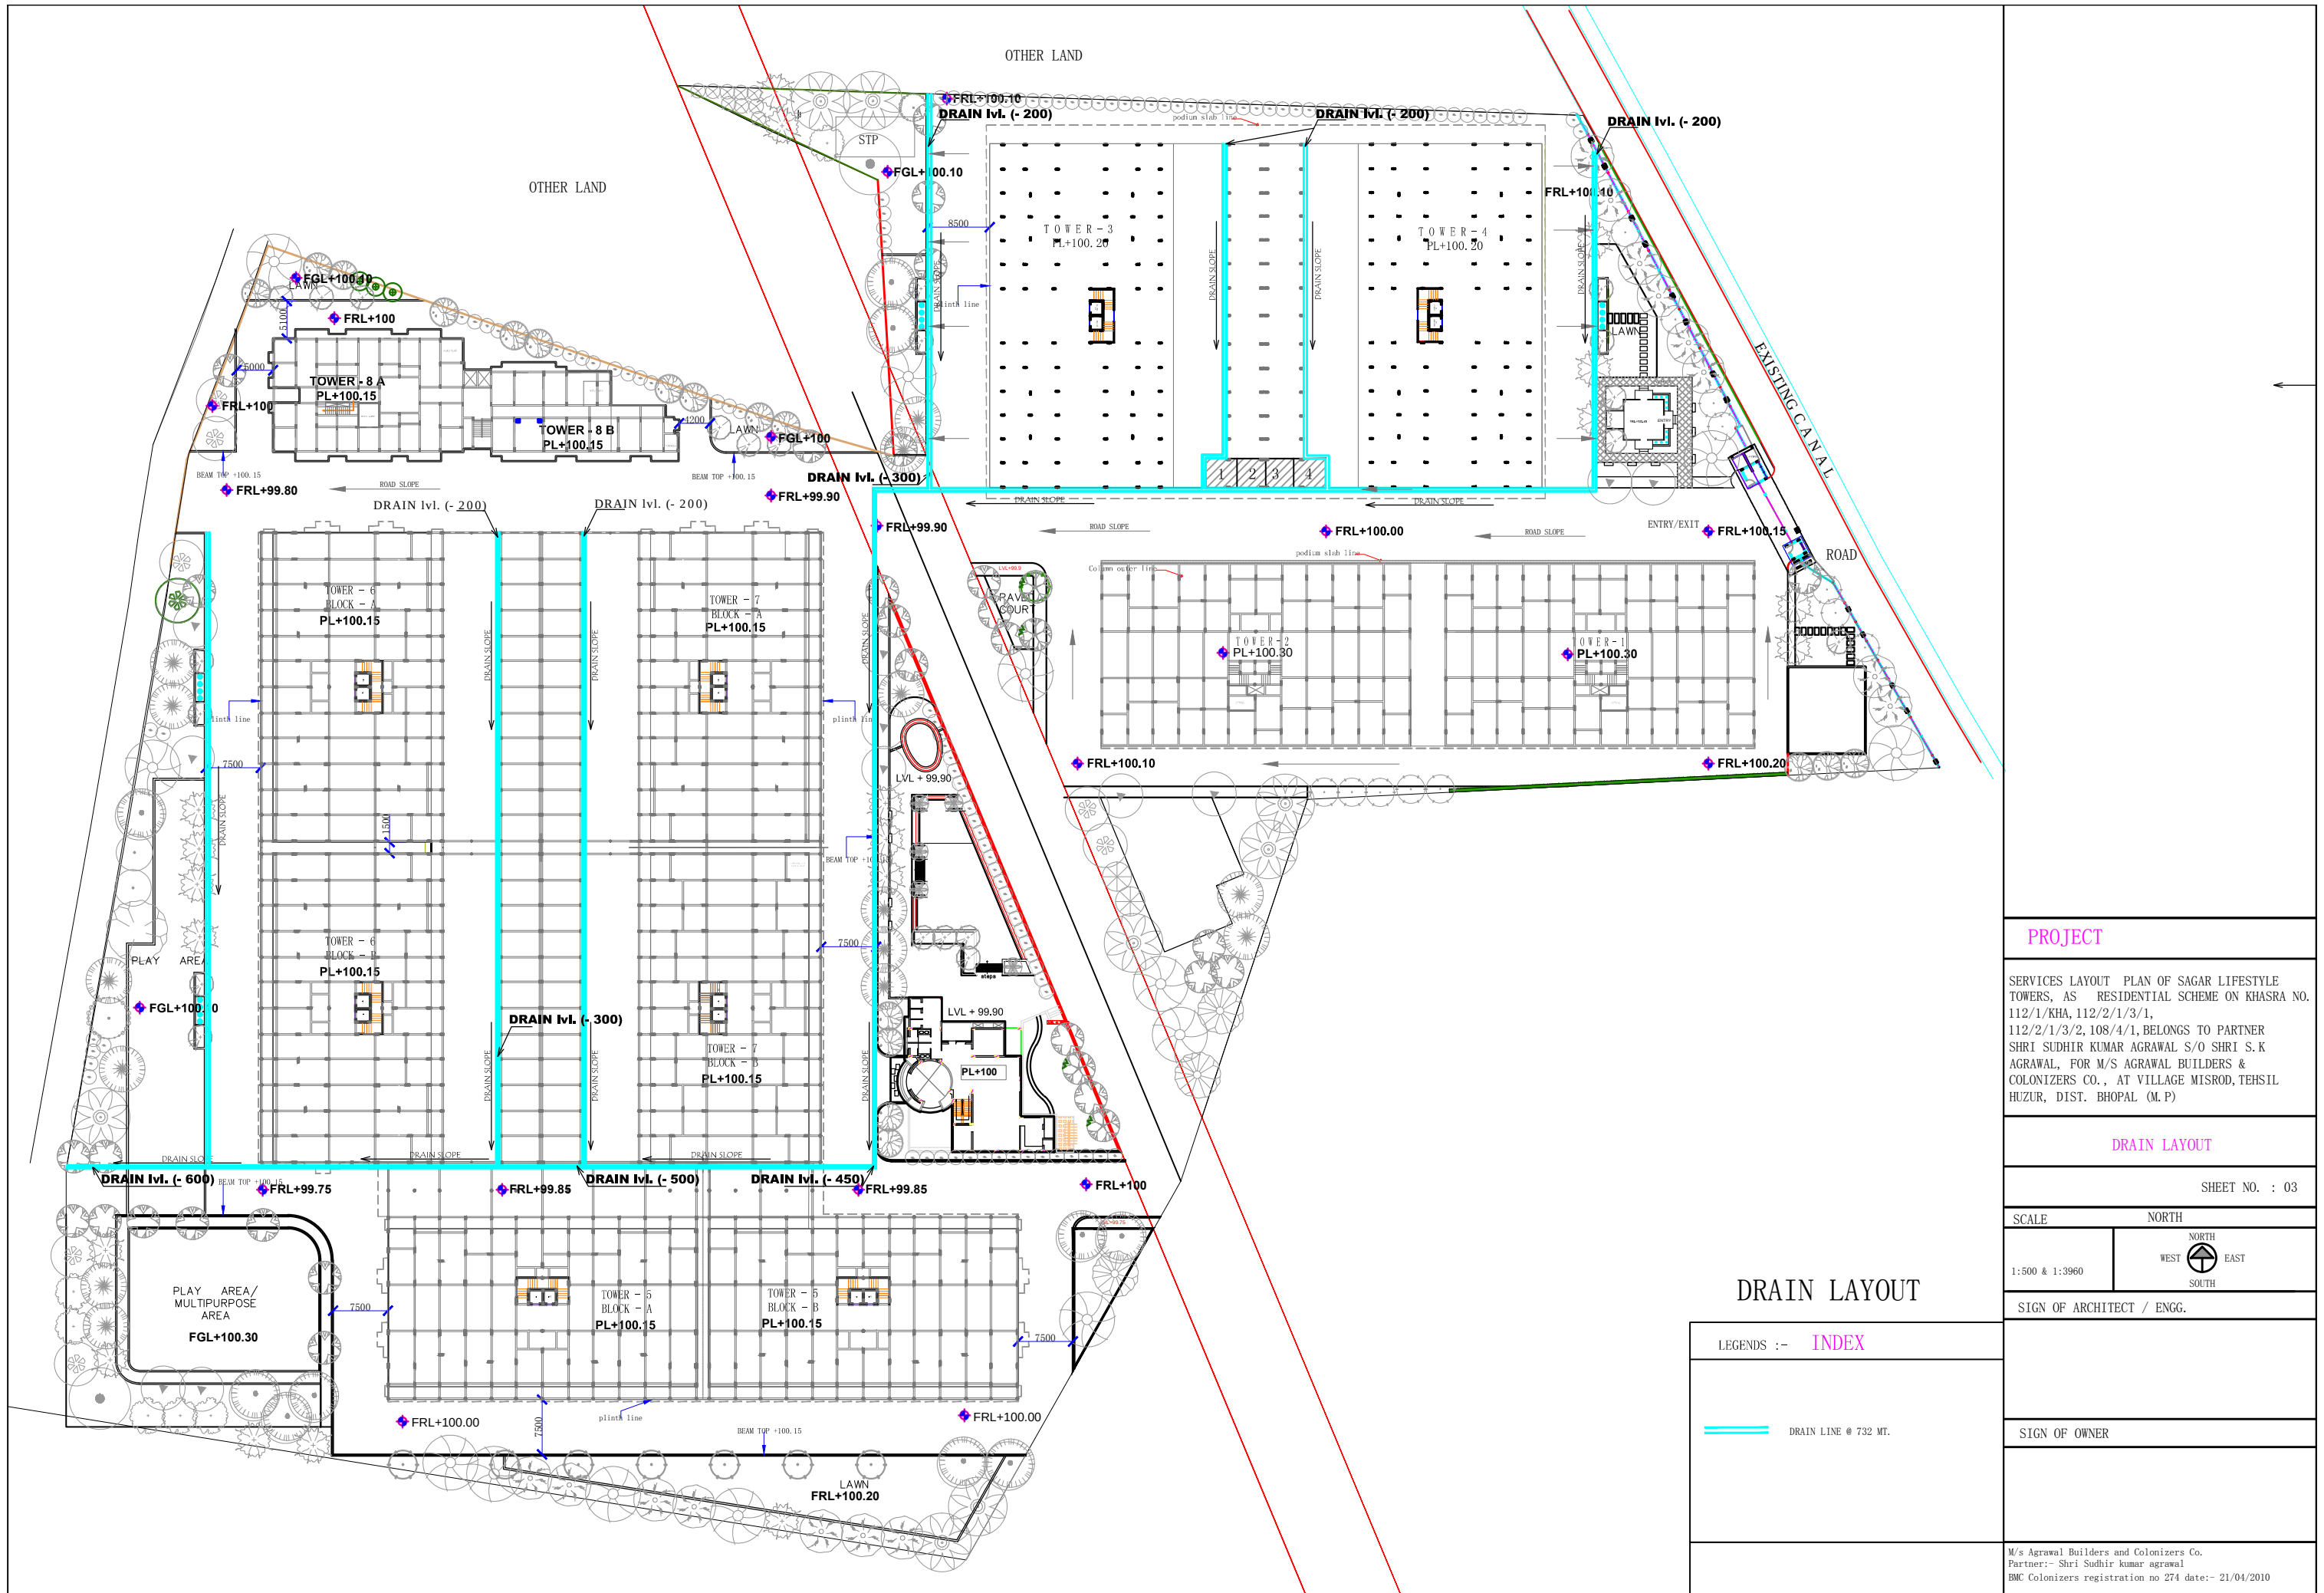

PROJECT

SERVICES LAYOUT PLAN OF SAGAR LIFESTYLE TOWERS, AS RESIDENTIAL SCHEME ON KHASRA NO. 112/1/KHA, 112/2/1/3/1, 112/2/1/3/2, 108/4/1, BELONGS TO PARTNER SHRI SUDHIR KUMAR AGRAWAL S/O SHRI S.K AGRAWAL, FOR M/S AGRAWAL BUILDERS & COLONIZERS CO., AT VILLAGE MISROD, TEHSIL HUZUR, DIST. BHOPAL (M.P)

DRAIN LAYOUT

SHEET NO. : 03

SCALE

NORTH

1:500 & 1:3960

NORTH

WEST

EAST

SOUTH

SIGN OF ARCHITECT / ENGG.

SIGN OF OWNER

DRAIN LAYOUT

LEGENDS :- INDEX

DRAIN LINE @ 732 MT.

M/s Agrawal Builders and Colonizers Co.
Partner:- Shri Sudhir kumar agrawal
BMC Colonizers registration no 274 date:- 21/04/2010



PROJECT

SERVICES LAYOUT PLAN OF SAGAR LIFESTYLE TOWERS, AS RESIDENTIAL SCHEME ON KHASRA NO. 112/1/KHA, 112/2/1/3/1, 112/2/1/3/2, 108/4/1, BELONGS TO PARTNER SHRI SUDHIR KUMAR AGRAWAL S/O SHRI S.K AGRAWAL, FOR M/S AGRAWAL BUILDERS & COLONIZERS CO., AT VILLAGE MISROD, TEHSIL HUZUR, DIST. BHOPAL (M.P)

ELECTRICAL LAYOUT

SHEET NO. : 03

SCALE 1:500 & 1:3960

NORTH

WEST EAST SOUTH

SIGN OF ARCHITECT / ENGG.

SIGN OF OWNER

M/s Agrawal Builders and Colonizers Co.
Partner:- Shri Sudhir kumar agrawal
BMC Colonizers registration no 274 date:- 21/04/2010

ELECTRICAL LAYOUT		QTY
LEGENDS :-	INDEX	
	TRANSFORMER	11
	MAIN TRANSFORMER	1
	POLE	70

