

Form 346
88in replying please quote No.
and date of this letter.**Ex. Engineer Bldg. Proposal (W.S.)
H and K - Wards
Municipal Office, R. K. Patkar Marg.
Bandra (West), Mumbai - 400 050**Intimation of Disapproval under Section 346 of the Mumbai
Municipal Corporation Act, as amended up to date.**1 APR 2016****No. CE/9053/WS/AK****MEMORANDUM**Municipal Office,
Mumbai 20**M/s. Tirupati Gruhpravesh L.L.P. C.A. to D.N.Nagar Tirupati CHS Ltd.**

With reference to your Notice, letter No. 337 dated 06.08.2014 and delivered on 08.08.2014 and the plans, Sections, Specifications and Description and further particulars and details of your redevelopment of existing building No.7 known as D.N. Nagar, Tirupati C.H.S. Ltd. on plot bearing C.T.S. No.195(pt) of village Andheri, D.N. Nagar MHADA Layout, Andheri (W) Mumbai, furnished to me under your letter, dated 06.08.2014 I have to inform you that I cannot approve the building or work proposed to be erected or executed, and I therefore hereby formally intimate to you under Section 346 of the Bombay Municipal Corporation Act as amended upto-date, my disapproval by thereof reasons :-

A. CONDITIONS TO BE COMPLIED WITH BEFORE STARTING THE WORK / BEFORE PLINTH C.C.

- 1) That the commencement certificate under section 44/69 (1)(a) of the M.R.T.P. Act will not be obtained before starting the proposed work.
- 2) That the compound wall is not constructed on all sides of the plot clear of the road widening line with foundation below level of bottom of road side drain without obstructing the flow of rain water from the adjoining holding to prove possession of holding as per D.C. Regulation No.38(27) before starting the work.
- 3) That the low lying plot will not be filled upto a reduced level of atleast 28.04 mtr. T.H.D. or 0.15 mtr. above adjoining road level whichever is higher with murum, earth, boulders etc. and will not be levelled, rolled and consolidated and sloped towards road side, before starting the work.
- 4) That the specifications for layout / D.P. / or access roads / development of setback land will not be obtained from E.E.R.C.(W.S.) before starting the construction work and the access and setback land will not be developed accordingly including providing street lights and S.W.D. from E.E.R.C.(W.S.) / E.E.S.W.D. of W.S. before submitting B.C.C
- 5) That the Structural Engineer will not be appointed. Supervision memo as per appendix XI (regulation 5(3)(ix)) will not be submitted by him.
- 6) That the structural design and calculations for the proposed work and for existing building showing adequacy thereof to take up the additional load will not be submitted before C.C.

- () That proper gutters and down pipes are not intended to be put to prevent water dropping from the leaves of the roof on the public street.
- () That the drainage work generally is not intended to be executed in accordance with the Municipal requirements.

Subject to your so modifying your intention as to obviate the before mentioned objections and meet by requirements, but not otherwise you will be at liberty to proceed with the said building or work at anytime before the 14th day of May 2008, but not so as to contravene any of the provision of the said Act, as amended as aforesaid or any rule, regulations or bye-law made under that Act at the time and force.

Your attention is drawn to the Special Instructions and Note accompanying this Intimation of Disapproval.


 Executive Engineer, Building Proposals.
 Zone K Wards

SPECIAL INSTRUCTIONS.

- (1) THIS INTIMATION GIVES NO RIGHT TO BUILD UPON GROUND WHICH IS NOT YOUR PROPERTY.
- (2) Under Section 68 of the Bombay Municipal Corporation Act, as amended, the Municipal Commissioner for Greater Mumbai has empowered the City Engineer to exercise, perform and discharge the powers, duties and functions conferred and imposed upon and vested in the Commissioner by Section 346 of the said Act.
- (3) Under Bye Law No.8, the Commissioner has fixed the following levels :-
 "Every person who shall erect as new domestic building shall cause the same to be built so that every part of the plinth shall be -
 "(a) Not less than 60 cms. above the centre of the adjoining street at the nearest point at which the drain from such building can be connected with the sewer than existing or thereafter to be laid in such street."
 "(b) Not less than 60 cms. above every portion of the ground within 160 cms. of such building."
 "(c) Not less than 28.04 mtr. above Town Hall Datum."
- (4) Your attention is invited to the provision of Section 152 of the Act whereby the person liable to pay property taxes is required to give notice of erection of a new building or occupation of building which has been vacant, to the Commissioner, within fifteen days of the completion or of the occupation whichever first occurs. Thus, compliance with this provision is punishable under Section 471 of the Act irrespective of the fact that the valuation of the premises will be liable to be revised under Section 167 of the Act, from the earliest possible date in the current year in which the completion on occupation is detected by the Assessor and Collector's department.
- (5) Your attention is further drawn to the provision of Service 353-A about the necessity of submitting occupation certificate with a view to enable the Municipal Commissioner for Greater Mumbai to inspect your premises and to grant a permission before occupation and to levy penalty for non-compliance under Section 471, if necessary.
- (6) Proposed date of commencement of work should be communicated as per requirements of Section 347(1) (aaa) of the Bombay Municipal Corporation Act.
- (7) One more copy of the block plan should be submitted for the Collector, Mumbai Suburban District.
- (8) Necessary permission for non-agricultural use of the land shall be obtained from the Collector, Mumbai Suburban District before the work is started. The non-agricultural assessment shall be paid at the site that may be fixed by the Collector under the Land Revenue Code and Rules thereunder.

Attention is drawn to the notes accompanying this Intimation of Disapproval.

E 1 A. 15 2016

CE/9053/WS/AK

Ex. Engineer Bldg. Proposal (W.S)
H and K - Wards
Municipal Office, R. K. Patkar Marg,
Bandra (West), Mumbai - 400 050

- 7) That the sanitary arrangement shall not be carried out as per Municipal specifications and Drainage layout will not be submitted before C.C.
- 8) That the registered undertaking and additional copy of plan shall not be submitted for agreeing to hand over the setback land free of compensation and that the setback handing over certificate will not be obtained from Asstt. Comm. [K/West] that the ownership of the setback land will not be transferred in the name of M.C.G.M. before demolition of existing building
- 9) That the Registered Agreement with the existing tenant alongwith the list will not be submitted before C.C.
- 10) That the consent letter from the existing tenants for the proposed additions/alterations in their tenement will not be submitted before C.C.
- 11) That the Indemnity Bond indemnifying the Corporation for damages, risks, accidents etc. and to the occupiers and an undertaking regarding no nuisance will not be submitted before C.C.
- 12) That the existing structure proposed to be demolished will not be demolished or necessary Phase Programme with agreement will not be submitted and got approved before C.C.
- 13) That the requirements of N.O.C. of (i) Reliance Energy /Tata Power, [ii] S.G. [iii] P.C.O., [iv] A.A. & C. [K/West], [v] S.P. [vi] S.W.D., [vii] M.T.N.L., [viii] H.E. will not be obtained and the requisitions if any will not be complied with before occupation certificate / B.C.C.
- 14) That the conditions mentioned in the release letter of M.H.A.DA.. under No.CO/MB/ARCH/F-1008/803/2007 dated 08.02.2007 will not be complied with.
- 15) That the qualified/registered site supervisor through architect/structural Engineer will not be appointed before applying for C.C.
- 16) That the true copy of the sanctioned layout/sub-division/amalgamation approved under the terms and conditions thereof will not be submitted before C.C. and compliance thereof will not be done before submission of B.C.C
- 17) That the development charges as per M.R.T.P. (amendment) Act 1992 will not be paid.
- 18) That the registered undertaking in prescribed proforma agreeing to demolish the excess area if constructed beyond permissible FSI shall not be submitted before asking for C.C.
- 19) That the lease deed of area of plot adm. 101.45 sq.mt. shall not be submitted before requesting for C.C.
- 20) That the names of the allottees shall not be mentioned in the plan and the said plan shall not be submitted to MHADA for confirmation.

CE/9053/WS/AK

- 21) That the Indemnity Bond cum registered undertaking from Developer that 18 Nos. of tenants will be re-accommodated now and further remaining will be re-accommodated while further construction with utilization of T.D.R., shall not be submitted.
- 22) The registered undertaking the double slab with water proofing treatment for contravening toilet shall not be submitted.
- 23) That the NOC from Society alongwith certified extract of General Body Resolution for development/additions and alterations will not be submitted before C.C.
- 24) That the requisite premium as intimated will not be paid before applying for C.C.
- 25) That the registered undertaking shall not be submitted for payment of difference in premium paid and calculated as per revised land rates.
- 26) That the C.C. shall not be asked unless payment of advance for providing treatment at construction site to prevent epidemics like Dengue, Malaria, etc. is made to the Insecticide Officer of the concerned Ward Office and provision shall be made as and when required by the Insecticide Officer for inspection of water tanks by providing safe but stable ladder, etc. and requirements as communicated by the Insecticide Office shall not be complied with.
- 27) That the Phase programme will not be got approved before asking for C.C.
- 28) That the Janata Insurance Policy in the name of site or policy to cover the compensation claims arising out of workman's compensation Act 1923 will not be taken out before starting the work and also will not be renewed during the construction work.
- 29) That the N.O.C. from Superintendent of Garden for tree authority shall not be submitted.
- 30) That the soil investigation will not be done and report thereof will not be submitted with structural design.
- 31) That the building will not be designed with the requirements of all relevant IS codes including IS code 1893 for earthquake design while granting occupation certificate from Structural Engineer to that effect will be insisted.
- 32) That no main beam in R.C.C. framed structure shall not be less than 230 mm. wide. The size of the columns shall also not be governed as per the applicable I.S. Codes.
- 33) That all the cantilevers [projections] shall not be designed for five times the load as per I.S. code 1993-2002. This also includes the columns projecting beyond the terrace and carrying the overhead water storage tank, etc.
- 34) That the R.C.C. framed structures, the external walls shall be less than 230 mm, if in brick masonry or 150 mm autoclaved cellular concrete block excluding plaster thickness as circulated under No.CE/5591 of 15.4.1974.
- 35) That the Vermiculture bins for disposal of wet waste as per the design and specification of Organisations/individuals specialized in this field, as per the list furnished by Solid Waste

1 APR 2016

CE/9053/WS/AK

Ex. Engineer Bldg. Proposal (W.S.)
H and S. Ward
Municipal Office, D. N. Palkar Bldg.
Bandra (W.S.), Mumbai - 400 050

Management Department of M.C.G.M. shall not be provided to the satisfaction of Municipal Commissioner.

- 36) That the phasewise programme for removal of the debris shall not be submitted and got approved.
- 37) That the registered undertaking for not misusing the part / pocket terraces / A.H.U.s. and area claimed free of F.S.I. will not be submitted.
- 38) That the registered undertaking for water proofing of terrace and Nahani traps shall not be submitted.
- 39) That the Indemnity Bond for compliance of I.O.D. conditions shall not be submitted.
- 40) That the owner/developer shall not display a board at site before starting the work giving the details such as name and address of the owner/developer, architect and structural engineer, approval no. and date of the layout and building proposal, date of issue of C.C., area of the plot, permissible built up area, built up area approved, number of floors etc.
- 41) That the design for Rain Water Harvesting System from Consultant shall not be submitted.
- 42) That the N.O.C. from E.E. Mech. (E.I.) P&D for the provision of artificial light, ventilation shall not be submitted.
- 43) That the sheet piling along with diaphragm wall shall not be constructed taking all the precautionary measures under the strict supervision of registered Structural Engineer before actual work of basement is taken in hand after issue of C.C.
- 44) That the necessary remarks for training of nalla/construction of SWD will not be obtained from Dy. Ch.Eng. (SWD) City and Central Cell before plinth C.C. and compliance of said remarks will not be insisted before granting full C.C. for the building.
- 45) That "All Dues Clearance Certificate" related to H.E.'s dept. from the concerned A.E.W.W. [K/West Ward] shall not be submitted before applying for C.C.
- 46) That the debris removal deposit of Rs. 45,000/- or Rs. 2/- per sq.mtr. of the built up area, whichever is less will not be paid before further C.C.
- 47) That the 'Debris Management Plan' shall not be got approved from Executive Engineer [Env.] and the conditions therein shall not be complied with.
- 48) That the N.O.C. from Collector - M.S.D. for excavation of land shall not be submitted.
- 49) That remarks / specifications regarding formation level and construction of road from the office of Dy.Chief Engineer [Roads] W.S. shall not be obtained before applying for C.C.
- 50) The work shall not be carried out between sunrise and sunset.
- 51) That RUT for handing over excess parking to the MCGM shall not be submitted.

- 52) That the revised RCC drawings designs & calculation shall not be submitted.
- 53) That the revised byelaw 4(c) shall not be submitted.
- 54) That the NOC from A.A. & C. shall not be submitted.
- 55) That all Dues Clearance Certificate related to H.E.'s Dept. from A.E.W.W. (K/W ward) shall not be submitted.

B. CONDITIONS TO BE COMPLIED BEFORE FURTHER C.C.

- 1) That the notice in the form of appendix XVII of D.C.R. shall not be submitted on completion of plinth.
- 2) That N.O.C. from Civil Aviation department will not be obtained for the proposed height of the building.
- 3) That the amended layout with approval or allowing T.D.R. on the plot under reference shall not be submitted before requesting for C.C. beyond plot potential shall not be submitted.
- 4) That the debris shall not be transported to the respective Municipal dumping site and challan to that effect shall not be submitted to this office for record.
- 5) That the N.O.C. from A.A. & C. [K/West] shall not be submitted.
- 6) That the plinth stability certificate from R.C.C. consultant shall not be submitted.
- 7) That the work-start notice shall not be submitted.
- 8) That the design of the road crust obtained from the Road Consultant of the office of Dy.Chief Engineer [Roads]W.S. to carry out the construction of road upto sub-base level as per the design shall not be complied with before asking for C.C. beyond plinth.
- 9) That C.C. shall not be granted beyond plinth level unless the concerned owner / builder satisfies the competent authority that he has moved the concerned authorities / utilities for providing connection in this regard & advance connection [not commissioned] is taken as per the specifications.
- 10) That the A.M.S.L. of the completed work upto plinth/stilt/podium level as applicable shall not be verified and submitted.

C. GENERAL CONDITIONS TO BE COMPLIED WITH BEFORE O.C. :-

- 1) That the conditions of Govt. order under No. _CO/MB/ARCH/NOC/F-1008/803/2007 dated 08.02.2007 shall not be complied with and that the certificate regarding compliance of conditions mentioned therein will not be submitted before submission of B.C.C.
- 2) That some of drains will not be laid internally with C.I. pipes.

E 1 APR 2016 CE/9053/WS/AK

 
- 3) That the dust bin will not be provided as per C.E.'s circular No. CE/9297/11 dated 26.6.1978.
- 4) That the surface drainage arrangement will not be made in consultation with E.E.(S.W.D.) or as per his remarks and a completion certificate will not be obtained and submitted before applying for occupation certificate/B.C.C.
- 5) That the 10' wide paved pathway upto staircase will not be provided.
- 6) That the surrounding open spaces, parking spaces and terrace will not be kept open and unbuilt upon; and will not be levelled and developed before requesting to grant permission to occupy the bldg. or submitting the B.C.C. whichever is earlier.
- 7) That the name plate/board showing plot no., name of the bldg. etc. shall not be displayed at a prominent place before O.C.C./B.C.C.
- 8) That the carriage entrance will not be provided before starting the work.
- 9) That the parking spaces will not be provided as per D.C.R. No.36.
- 10) That B.C.C. will not be obtained and IOD and debris deposit etc. will not be claimed for refund within a period of six years from the date of occupation.
- 11) That every part of the building constructed and more particularly overhead water tank will not be provided with the proper access for the staff of Insecticide Officer with a provision of temporary but safe and stable ladder.
- 12) That the owner/developer will not hand over the possession to the prospective buyer before obtaining occupation permission.
- 13) That the letter box of appropriate size shall not be provided for all the tenements at the ground floor.
- 14) That the infrastructural works such as construction of hand-holes/manholes, ducts for underground cables, concealed wiring inside the flats/rooms, room/space for telecom installations etc. required for providing telecom services shall not be provided.
- 15) That the regulation No.45 and 46 of D.C. Reg. 1991 shall not be complied with.
- 16) That the provisions of Rain Water Harvesting as per the design prepared by approved consultants in the field shall not be made to the satisfaction of Municipal Commissioner while developing plots having area more than 300 Sq.Mts. as per Govt. notification under Sec.37[2] of M.R.T.P. Act, 1966.
- 17) That the Vermiculture bins for disposal of wet waste as per the design and specification of Organisations/individuals specialized in this field, as per the list furnished by Solid Waste Management Department of M.C.G.M. shall not be provided to the satisfaction of Municipal Commissioner.
- 18) That the Drainage Completion Certificate shall not be submitted.

CE/9053/WS/AK

- 19) That the Lift Inspector's completion certificate shall not be submitted.
- 20) That the structural stability certificate shall not be submitted.
- 21) That the Site Supervisor's completion certificate shall not be submitted.
- 22) That the smoke test certificate shall not be submitted.
- 23) That the water proofing certificate shall not be submitted.
- 24) That the N.O.C. from A.A. & C. [K/West] shall not be submitted.
- 25) That the final NOC from MHADA shall not be submitted.
- 26) That the final NOC from C.F.O. shall not be submitted.
- 27) That the completion certificate for Rain Water Harvesting System from Consultant shall not be submitted.
- 28) That the completion certificate from E.E. Mech. (E.I.) P&D for the provision of artificial light, ventilation and / or A.H.U. shall not be submitted.
- 29) That the construction of road including S.W. Drain and footpath, providing central dividers, lane marking and providing street furniture and obtain completion certificate from E.E. [Roads]W.S. shall not be submitted before applying for occupation.
- 30) That the payment towards the difference in pro-rata cost of C.C. road and asphalt road for road width of 18.30 mtrs. and above shall not be made in the office of Dy. Chief Engineer [Roads] before applying for occupation.
- 31) That the A.M.S.L. of completed work (top of the building) shall not be verified and submitted.

D) CONDITIONS TO BE COMPLIED WITH BEFORE B.C.C. :-

1. That the certificate under Sec.270-A of the B.M.C. Act will not be obtained from H.E.'s department regarding adequacy of water supply.


21/06/2016
Ex. Engr. Bldg. Prop. (W.S.) K Ward
B. M. C. Mahanagar Palika

F 1 APR 2016

CE/9053/WS/AK
NOTES 3

By Engineer B.L. ...
Municipal ...
to ...
are complied with ...


- (1) The work should not be started unless objections from **A1** to **Bandy** are complied with.
- (2) A certified set of latest approved plans shall be displayed on site at the time of commencement the work and during the progress of the construction work.
- (3) Temporary permission on payment of deposit should be obtained any shed to house and store for constructional purposes, Residence of workmen shall not be allowed on site. The temporary structures for storing constructional material shall be demolished before submission of building completion certificate and a certificate signed by Architect submitted along with the building completion certificate.
- (4) Temporary sanitary accommodation on full flushing system with necessary drainage arrangement should be provided on site workers, before starting the work.
- (5) Water connection for constructional purpose will not be given until the hoarding is constructed and application made to the Ward Officer with the required deposit for the construction of carriage entrance, over and road side drain.
- (6) The owners shall intimate the Hydraulic Engineer or his representative in Wards atleast 15 days prior to the date of which the proposed construction work is taken in hand that the water existing in the compound will be utilized for their construction works and they will not use any Municipal Water for construction purposes. Failing this, it will be presume the Municipal tap water has been consumed on the construction works and bills preferred against them accordingly.
- (7) The hoarding or screen wall for supporting the depots of building materials shall be constructed before starting any work even though no materials may be expected to be stabled in front of the property. The scaffoldings, bricks, metal, sand preps debris etc. should not be deposited over footpaths or public street by the owner/architect/their contractors etc. without obtaining prior permission from the Ward Officer of the area.
- (8) The work should not be started unless the manner in obviating all the objection is approved by this department.
- (9) No work should be started unless the structural design is approved.
- (10) The work above plinth should not be started before the same is shown to this office Sub-Engineer concerned and acknowledgement obtained from him regarding correctness of the open spaces and dimensions.
- (11) The application for sewer street connections, if necessary, should be made simultaneously with commencement of the work as the Municipal Corporation will require time to consider alternative site to avoid the excavation of the road an footpath.
- (12) All the terms and conditions of the approved layout / sub-division under No. _____ of _____ should be adhered to and complied with.
- (13) No Building / Drainage Completion Certificate will be accepted non water connection granted (except for the construction purpose) unless road is constructed to the satisfaction of the Municipal Commissioner as per the provision of Section 345 of the Bombay Municipal Corporation Act and as per the terms and conditions for sanction to the layout.
- (14) Recreation ground or amenity open space should be developed before submission of Building Completion Certificate.
- (15) The access road to the full width shall be constructed in water bound macadam before commencing work and should be complete to the satisfaction of Municipal Commissioner including asphaltting lighting and drainage before submission of the Building Completion Certificate.
- (16) Flow of water through adjoining holding or culvert, if any should be maintained unobstructed.
- (17) The surrounding open spaces around the building should be consolidated in Concrete having broken glass pieces at the rate of 125 cubic meters per 10 sq.mts. below payment.
- (18) The compound wall or fencing should be constructed clear of the road widening line with foundation below level of bottom of road side drain without obstructing flow of rain water from adjoining holding before starting the work to prove the owner's holding.
- (19) No work should be started unless the existing structure proposed to be demolished are demolished.

CE/9053/WS/AK

- (20) This intimation of Disapproval is given exclusively for the purpose of enabling you to proceed further with the arrangements of obtaining No Objection Certificate from the Housing Commissioner under Section 13(h)(H) of the Rent Act and in the event of your proceeding with the work either without an intimation, about commencing the work under Section 347(1)(aa) for your starting the work without removing the structures proposed to be removed the act shall be taken as a severe breach of the conditions under which this Intimation of Disapproval is issued and the sanctioned will be revoked and the commencement certificate granted under Section 45 of the Maharashtra Regional and Town Planning Act, 1966 (12 of the Town Planning Act), will be withdrawn.
- (21) If it is proposed to demolish the existing structures by negotiations with the tenants, under the circumstances, the work as per approved plans should not be taken up in hand unless the City Engineer is satisfied with the following.
- (i) Specific plans in respect of evicting or rehousing the existing tenants on hour starting their number and the area in occupation of each.
 - (ii) Specifically signed agreement between you and the existing tenants that they are willing to avail or the Alternative accommodation in the proposed structure at standard rent.
 - (iii) Plans showing the phased programme of construction has to be duly approved by this office before starting the work so as not to contravene at any stage of construction, the Development Control Rules regarding open spaces, light and ventilation of existing structure.
- (22) In case of extension to existing building, blocking of existing windows of rooms deriving light and its from other sides should be done first before starting the work.
- (23) In case of additional floor no work should be start or during monsoon which will same arise water leakage and consequent nuisance to the tenants staying on the floor below.
- (24) The bottom of the over hand storage work above the finished level of the terrace shall not be more than 1 mt.
- (25) The work should not be started above first floor level unless the No Objection Certificate from Civil Aviation Authorities, where necessary is obtained.
- (26) It is to be understood that the foundations must be excavated down to hard soil.
- (27) Positions of the nahanis and other appurtenances in the building should be so arranged as not to necessitate the laying of drains inside the building.
- (28) The water arrangement must be carried out in strict accordance with the Municipal requirements.
- (29) No new well, tank, pound, cistern or fountain shall be dug or constructed without the previous permission in writing of the Municipal Commissioner for Greater Mumbai, as required in Section 381-A of the Municipal Corporation Act.
- (30) All gully traps and open channel drains shall be provided with right fitting mosquito proof covers made of wrought iron plates or hinges. The manholes of all cisterns shall be covered with a properly fitting mosquito proof hinged cast iron cap over in one piece, with locking arrangement provided with a bolt and huge screwed on highly serving the purpose of a lock and the warning pipes of the ribbert pressed with screw or dome shape pieces (like a garden mari rose) with copper pipes with perfections each not exceeding 1.5 mm. in diameter the cistern shall be made easily, safely and permanently accessible by providing a firmly fixed iron ladder, the upper ends of the ladder should be earmarked and extended 40 cms above the top where they are to be fixed an its lower ends in cement concrete block.
- (31) No broken bottles should be fixed over boundary walls. This prohibition refers only to broken bottles to not to the use of plane glass for coping over compound wall.
- (32) (a) Louvers should be provided as required Bye-law No.5(b).
(b) Lintels of Arches should be provided over Door and Window opening.
(c) The drains should be laid as require under section 234-1(a).
(d) The inspection chamber should be plastered inside and outside.
- (33) If the proposed additional is intended to be carried out on old foundations and structures, you will do so at your own risk.

COPY TO—ARCHITECT OWNER


[Signature]
01/04/2016
Executive Engineer, Building Proposal
Zones
K Ward.

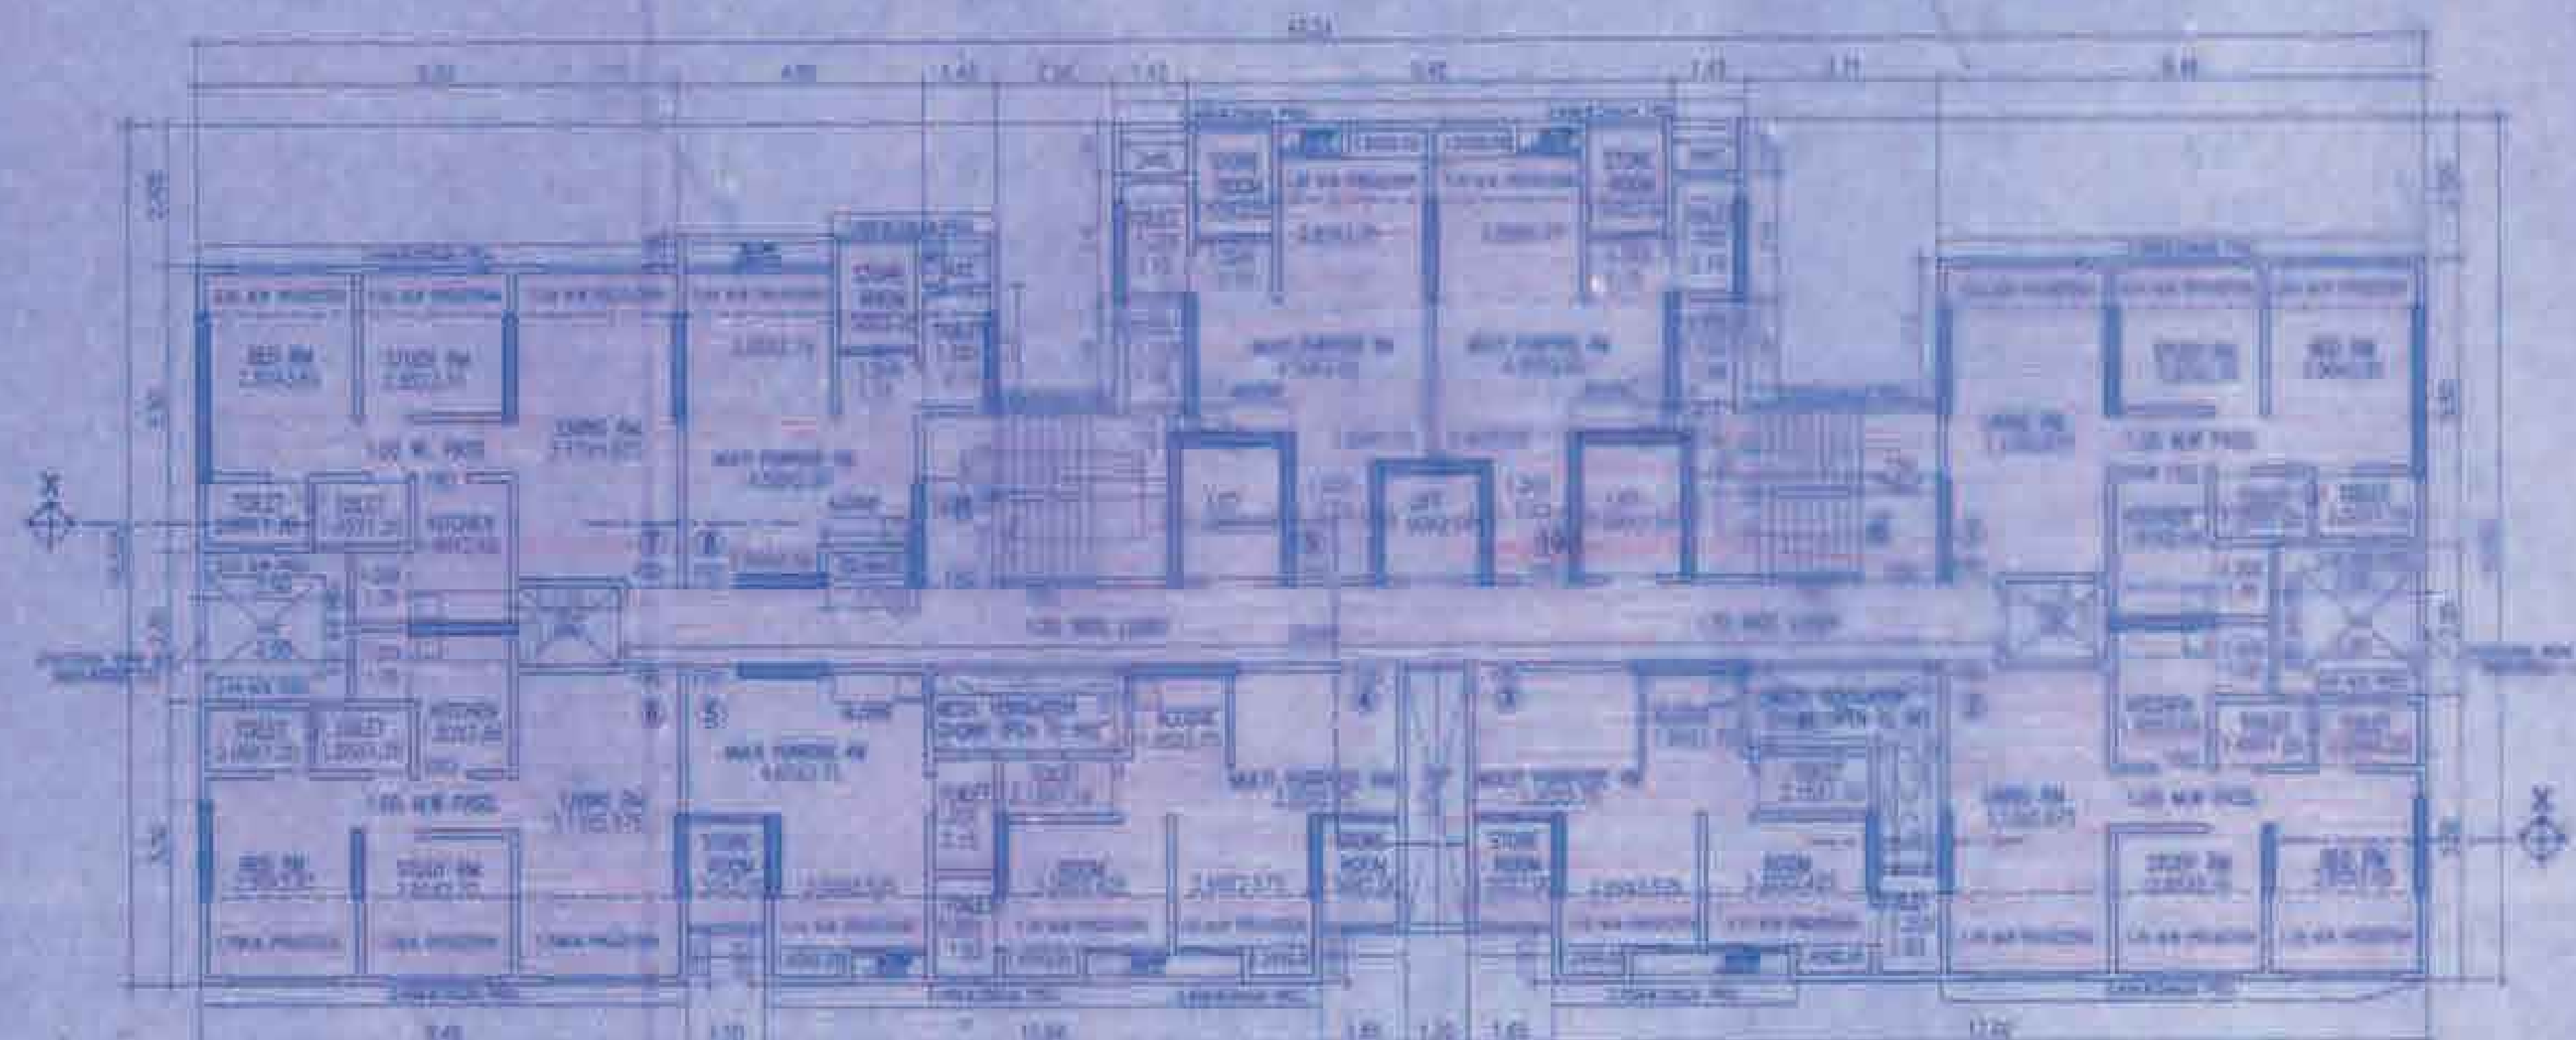

TYPICAL FLOOR PLAN
2ND TO 4TH FLOOR
SCALE 1:100

**FITNESS CENTER
AREA DIA. & CAL.**

PROPOSED BUILT-UP AREA	= 225.75
PROPOSED FILL AT 7' SL	= 165.00
TOTAL COVERED AREA OF PROPOSED BUILT-UP	= 390.75
PROPOSED COVERED AREA	= 37.15
AREA OF FILL AREA	= 165.00
COVERED AREA	= 390.75

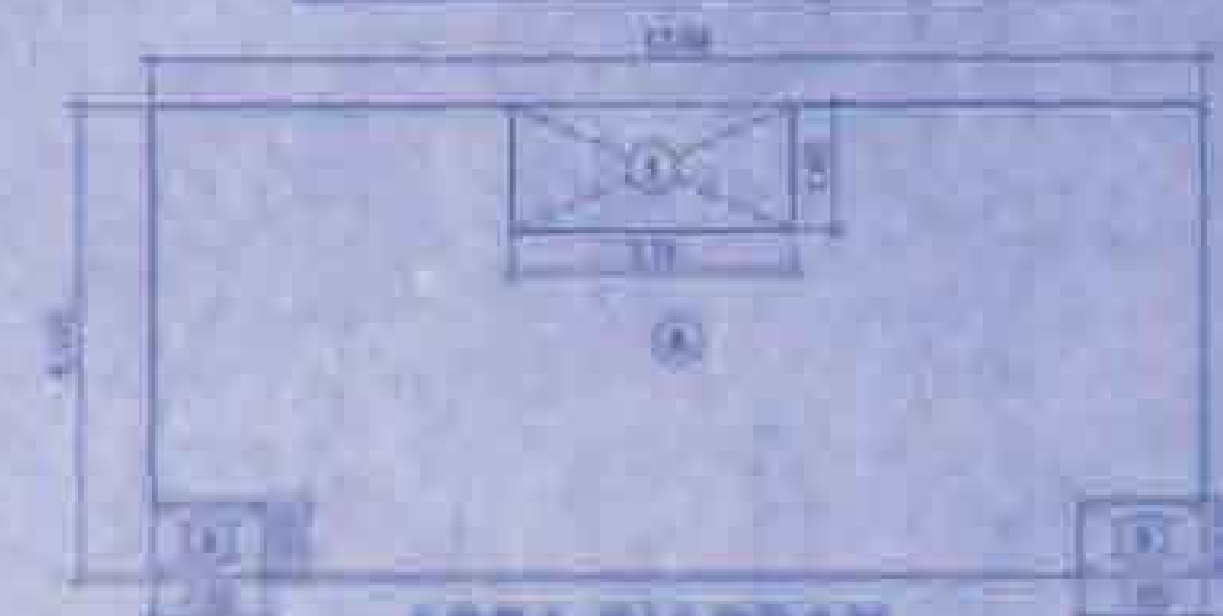


AREA DIAGRAM
SCALE 1:100

COVERED	17'0" x 17'0" = 289.00
TOTAL COVERED	= 289.00
UNCOVERED	17'0" x 17'0" = 289.00
TOTAL UNCOVERED	= 289.00
NET TOTAL AREA	= 578.00

AREA CALCULATION

**BUILT - UP AREA DIAGRAM &
CALCULATION FITNESS CENTER**

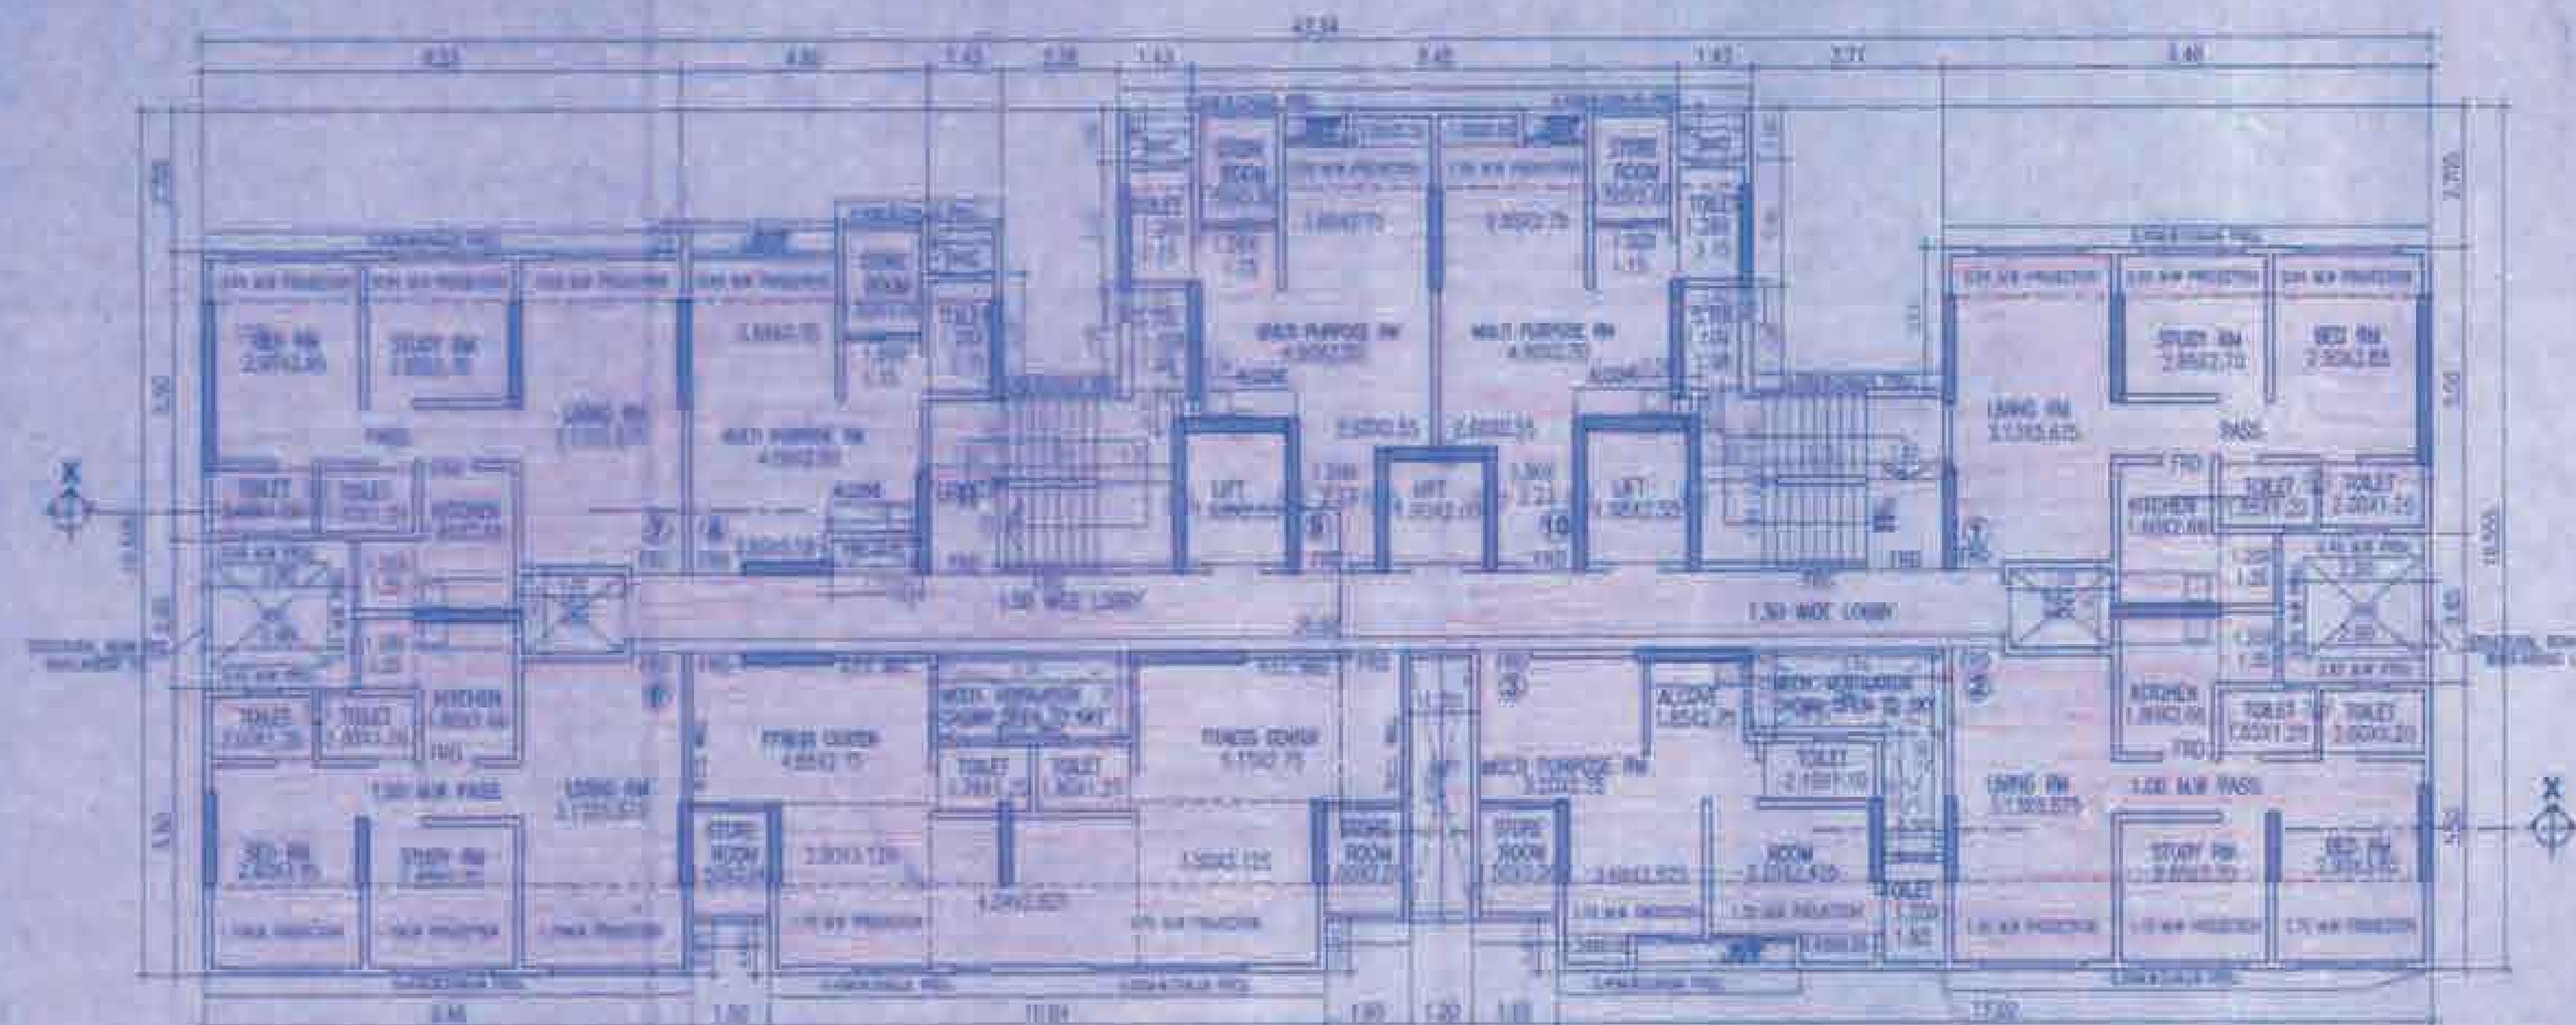

1ST. FLOOR PLAN
SCALE 1:100

FORM - II

CERTIFICATE OF AREA -

ADVISED THAT I HAVE SURVEYED THE PLAT UNDER REFERENCE ON THE 17TH APRIL 2016 AND THAT THE DIMENSIONS OF THE BUILT-UP AREA OF THE PLAT STATED ON THE PLAT ARE AS MEASURED IN LINE AND THE AREA IS WORKED OUT TO BE 101.15 SQ.M. (ONE THOUSAND TWENTY ONE POINT ONE FIVE SQ.M.) AND CALLED WITH THE AREA STATED IN THE DOCUMENT OF THE OWNER / COMPLAINING SCHEME RECORD.

SIGNATURE OF THE ARCHITECT

STAMP OF DATE OF RECEIPT OF PLANS

STAMP OF APPROVAL OF PLANS

APPROVED 17 APR 2016

NAME AND SIGNATURE OF OWNER

TIRUPATI GRUHPRAVESH LLP

CA TO OWNER

CONTENTS OF SHEET

1ST. FLOOR PLAN
2ND TO 4TH FLOOR PLAN
FITNESS AREA DIAGRAM & CALC.

JOB NO.

ROP / DNT / PG / 00 / 120

DRWG. NO.

ROP / DNT / 03 - 25

JOB TITLE

Proposed Redevelopment of
D.N. NAGAR TIRUPATI CH.S.I.
Bearing NO: Existing Bldg. No. 7,
C.Y.S No 185/05 and 186/1A, 186A,
D.N. NAGAR MHADA LAYOUT, at
D.N. NAGAR, Andheri (W) Mumbai.
for TIRUPATI GRUHPRAVESH LLP

DRAWING TITLE

DWG. FOR MUN. APPROVAL

DATE

17 APR 2016

TIME

10:00 AM

BY

AS STATED





DATE

17 APR 2016


BY

AS STATED

NOTE: ALL MAIN DOOR, KITCHEN DOOR, STAIRCASE DOOR, ELEC. DUCT & REFUGE AREA SHALL BE PROVIDED WITH P.R.D.

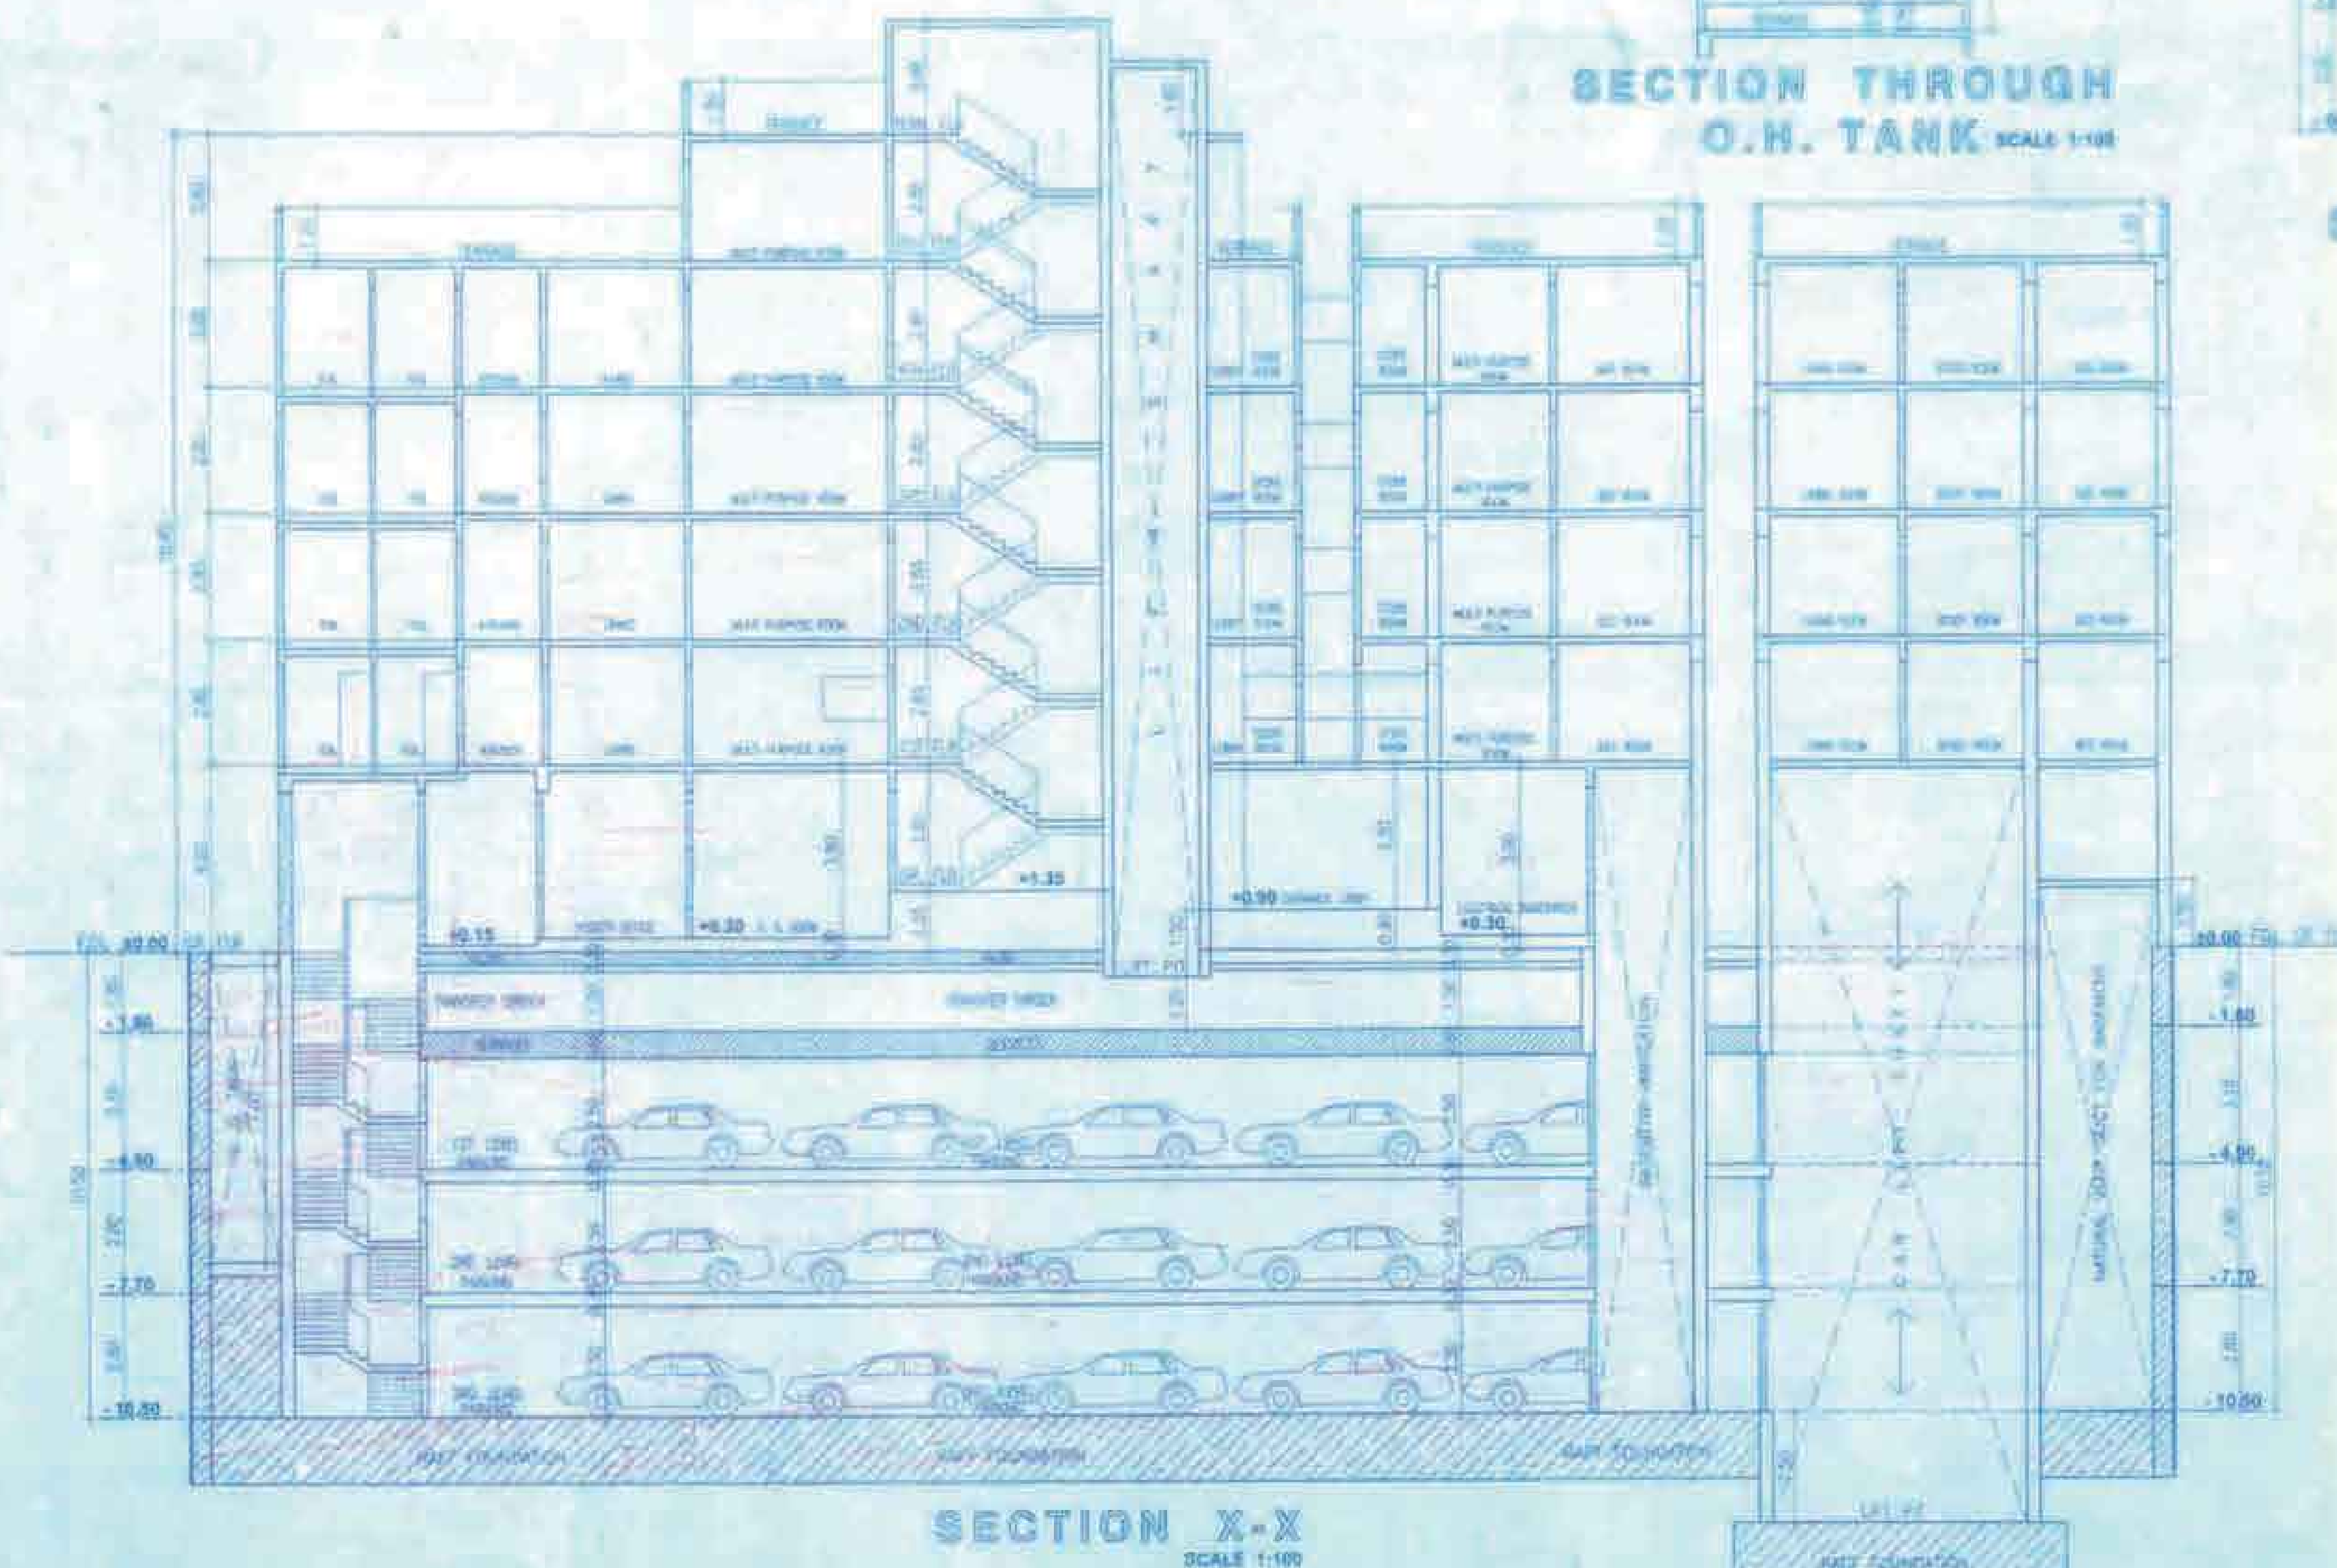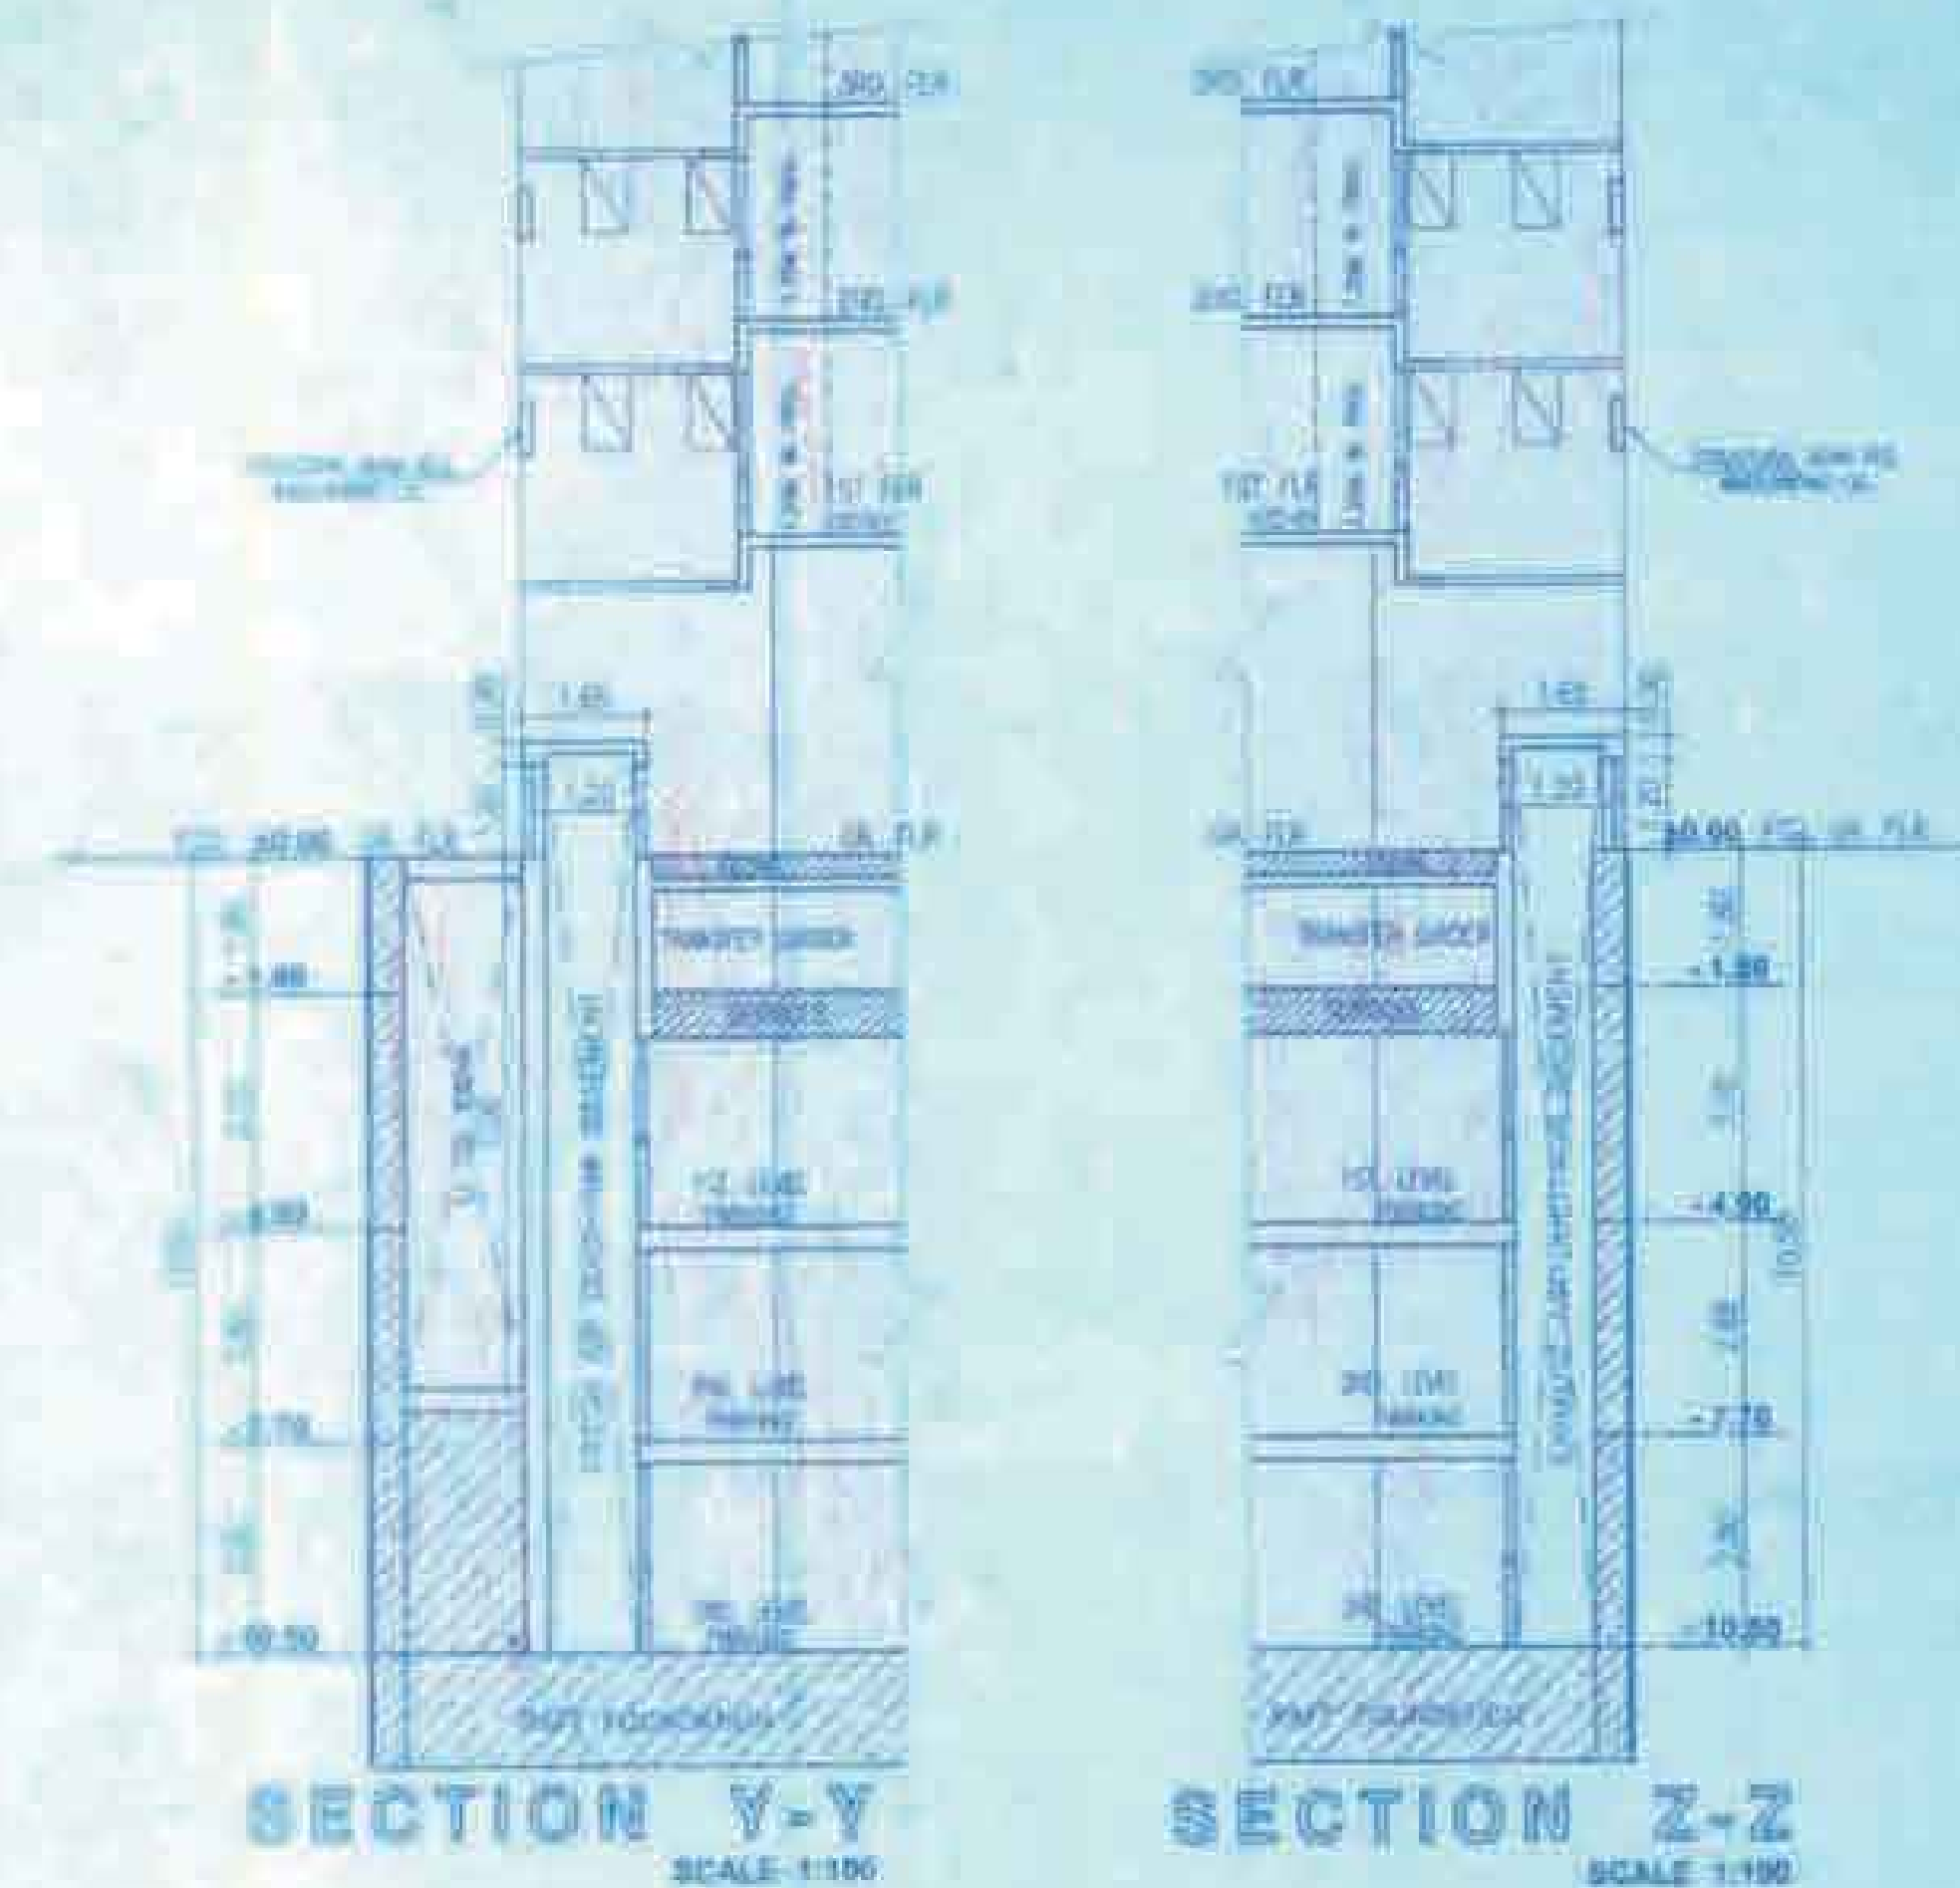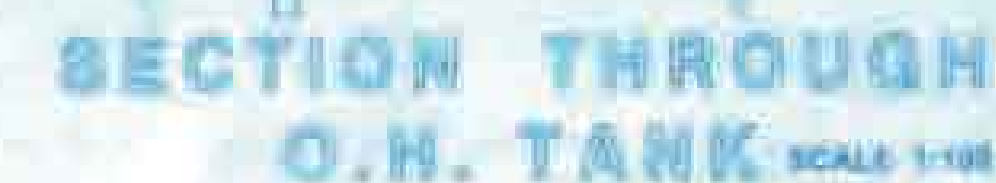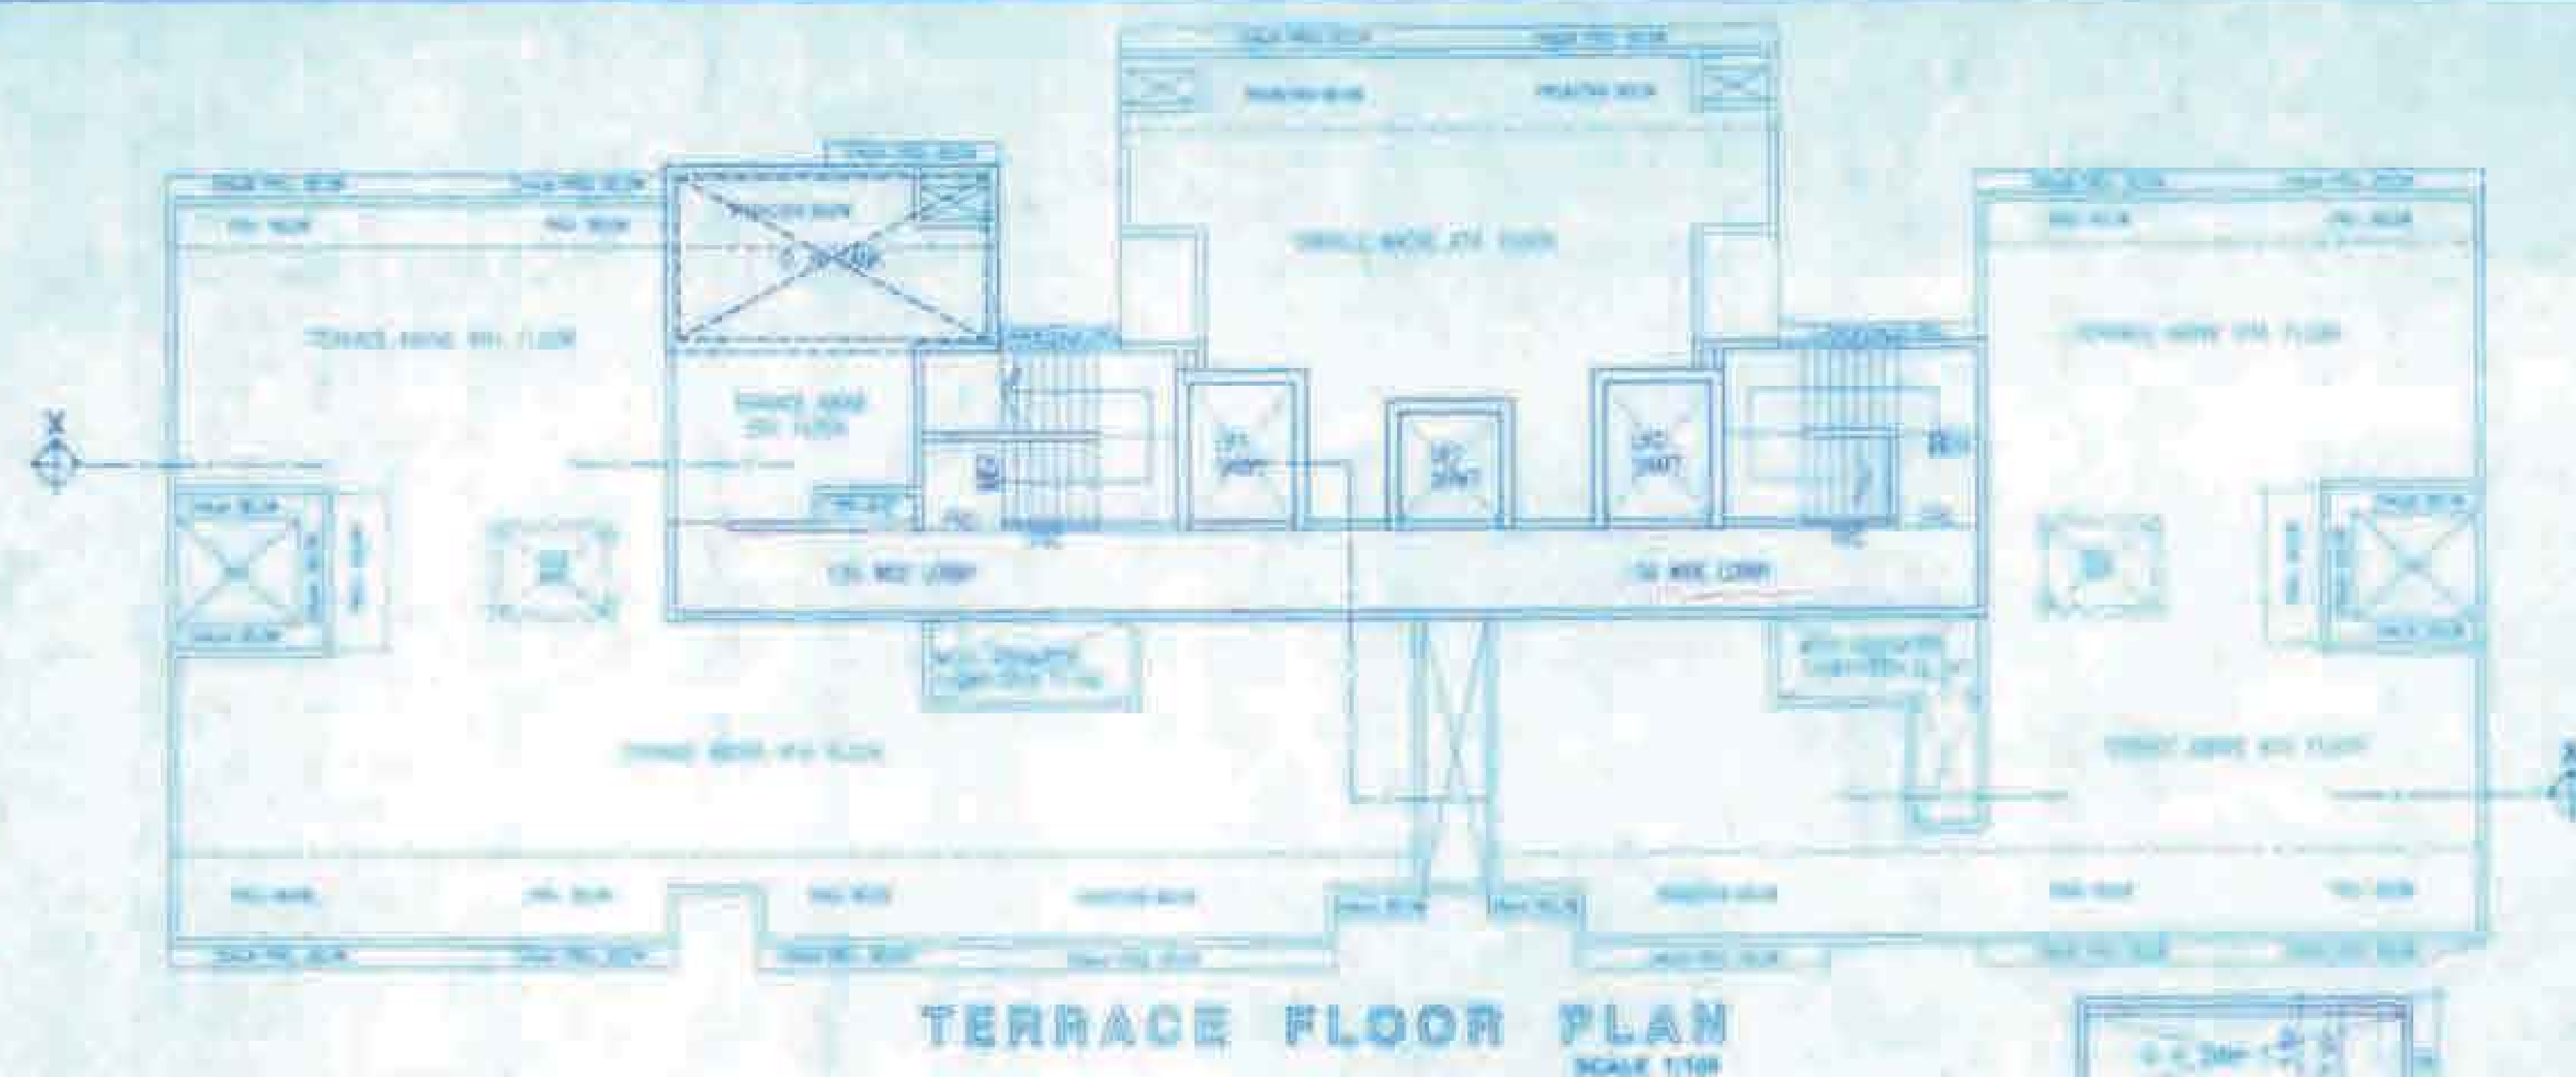


F O R M - II	
CERTIFICATE OF AREA WHEREAS, THAT I HAVE EXAMINED THE PLOT UNDER REFERENCE IN THE FORM AND THAT THE DIMENSIONS OF THE PLOT, 20% OF THE PLOT SITED ON THE PLOT AND AS MEASURED IN 2001 AND THE AREA IS WORKED OUT IS 1021.18 SQ.M (ONE THOUSAND TWENTY ONE POINT ONE EIGHT SQ.M.) AND CALLED WITH THE PLOT SITED IN THE (ADDRESS OF THE OWNER) / (LOCALITY) / (CITY) / (STATE) / (PIN CODE).	
STAMP OF DATE OF RECEIPT OF PLANS 	SIGNATURE OF THE ARCHITECT  SPACE MOULDERS The Professional Drafting Studio
STAMP OF APPROVAL OF PUNJEE 21 APR 2015	 Chairman, Karnataka Planning, Revenue, Housing, Urban Development, Government of Karnataka 100, 101, 102, 799, 8

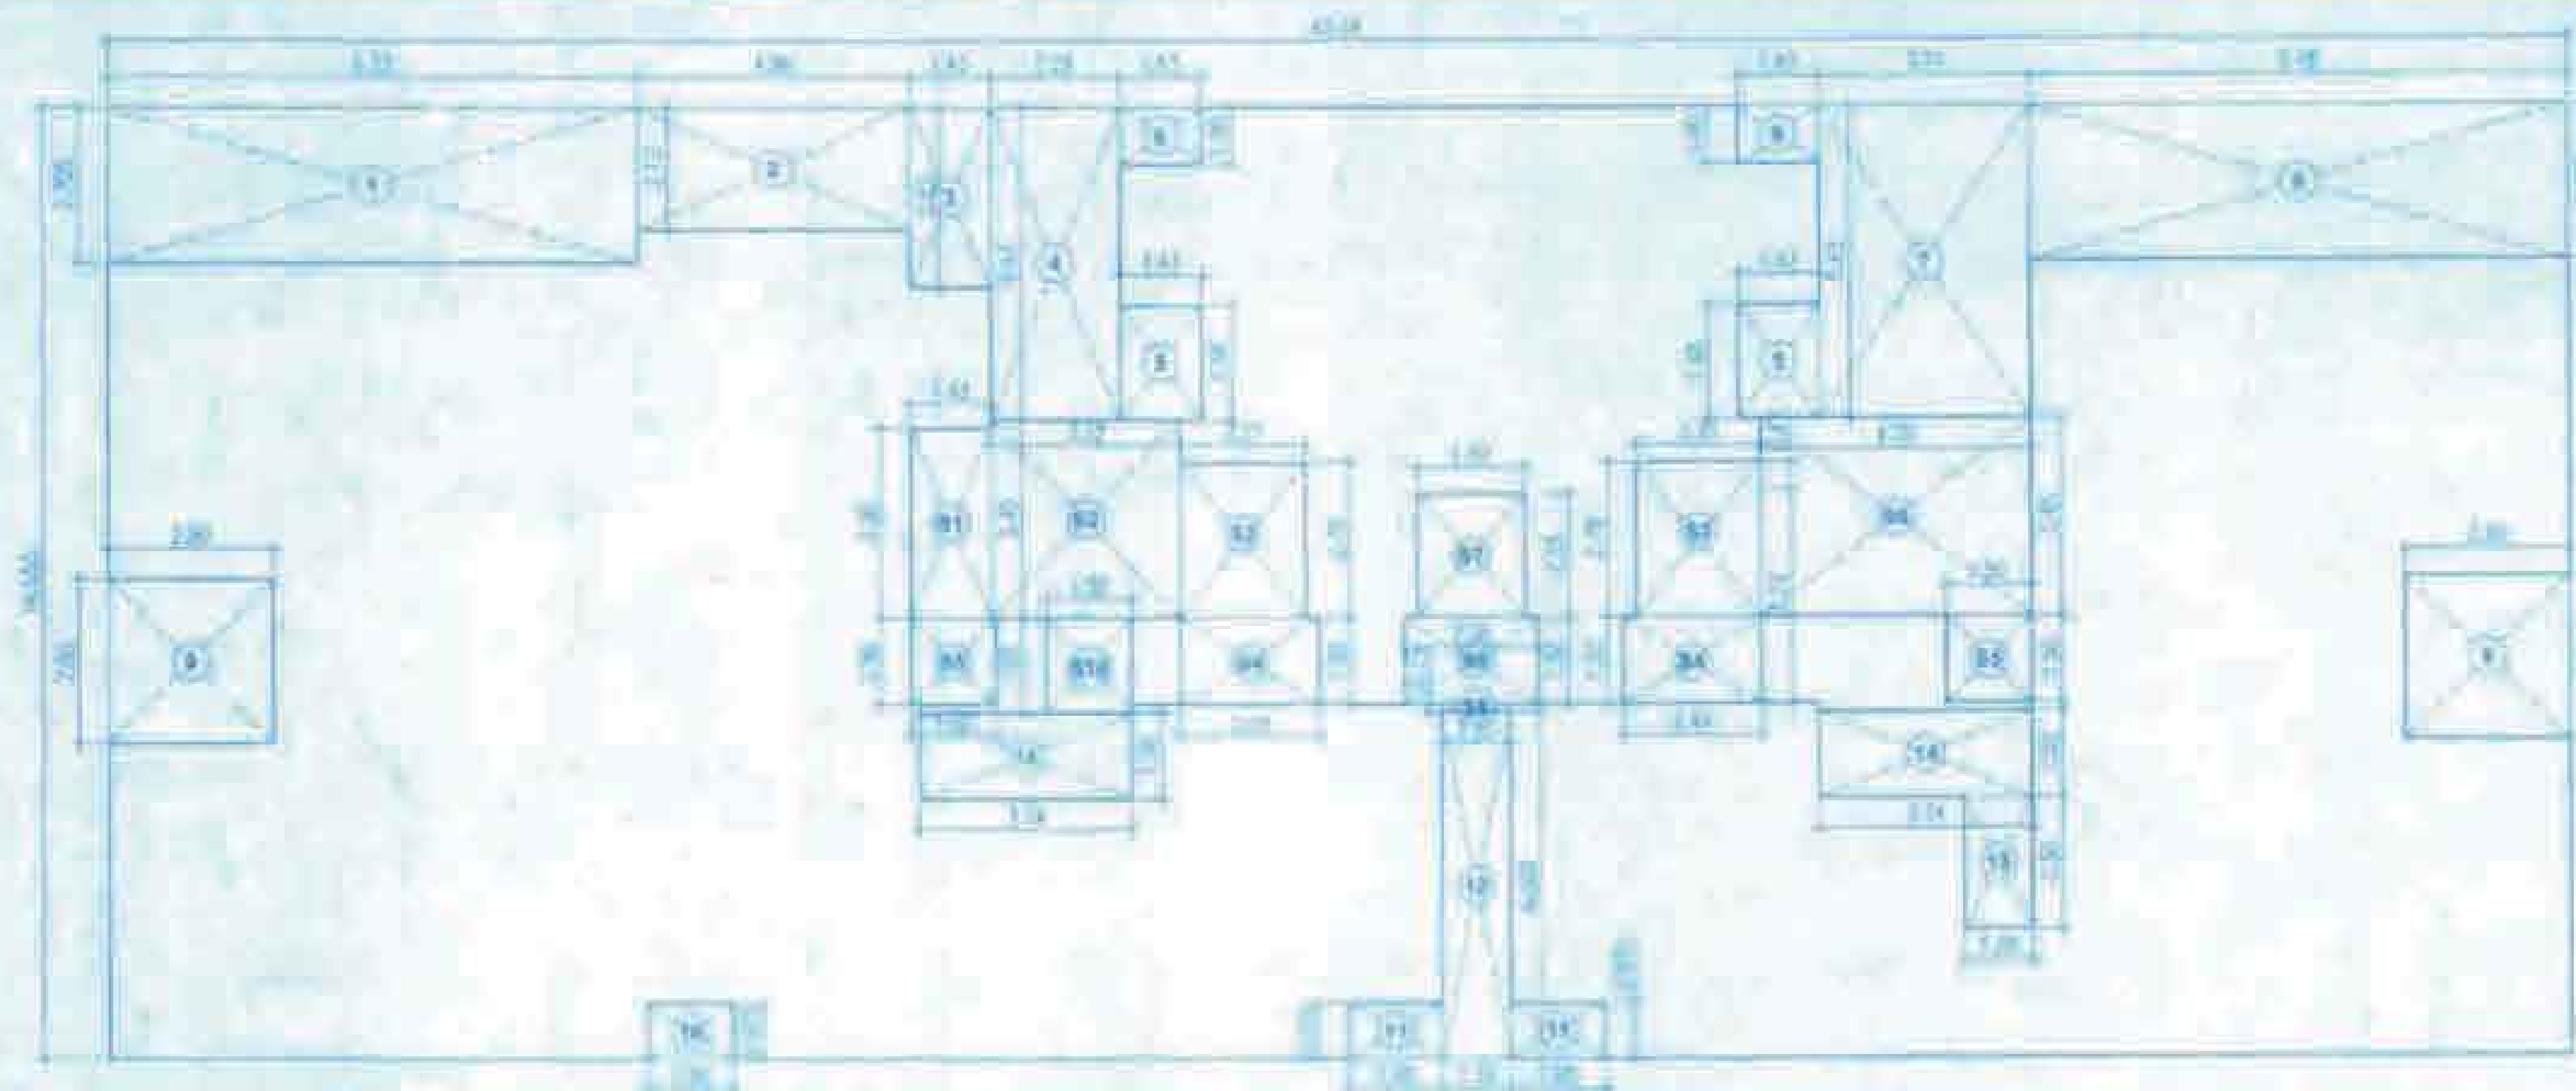

AREA DIAGRAM 2ND TO 4TH FLOOR
SCALE 1:100

REQUIRE					
Account	1	2	3	4	5
1	11.24	1	1.40	1	1
TOTAL REQUIRE					= 117.40
REQUIRE					
1	11.24	1	1.40	1	1
TOTAL REQUIRE					= 117.40
REQUIRE					
1	11.24	1	1.40	1	1
TOTAL REQUIRE					= 117.40


TOTAL REQUIRE = 140.05
NET TOTAL AREA = 588.24
AREA CALCULATION

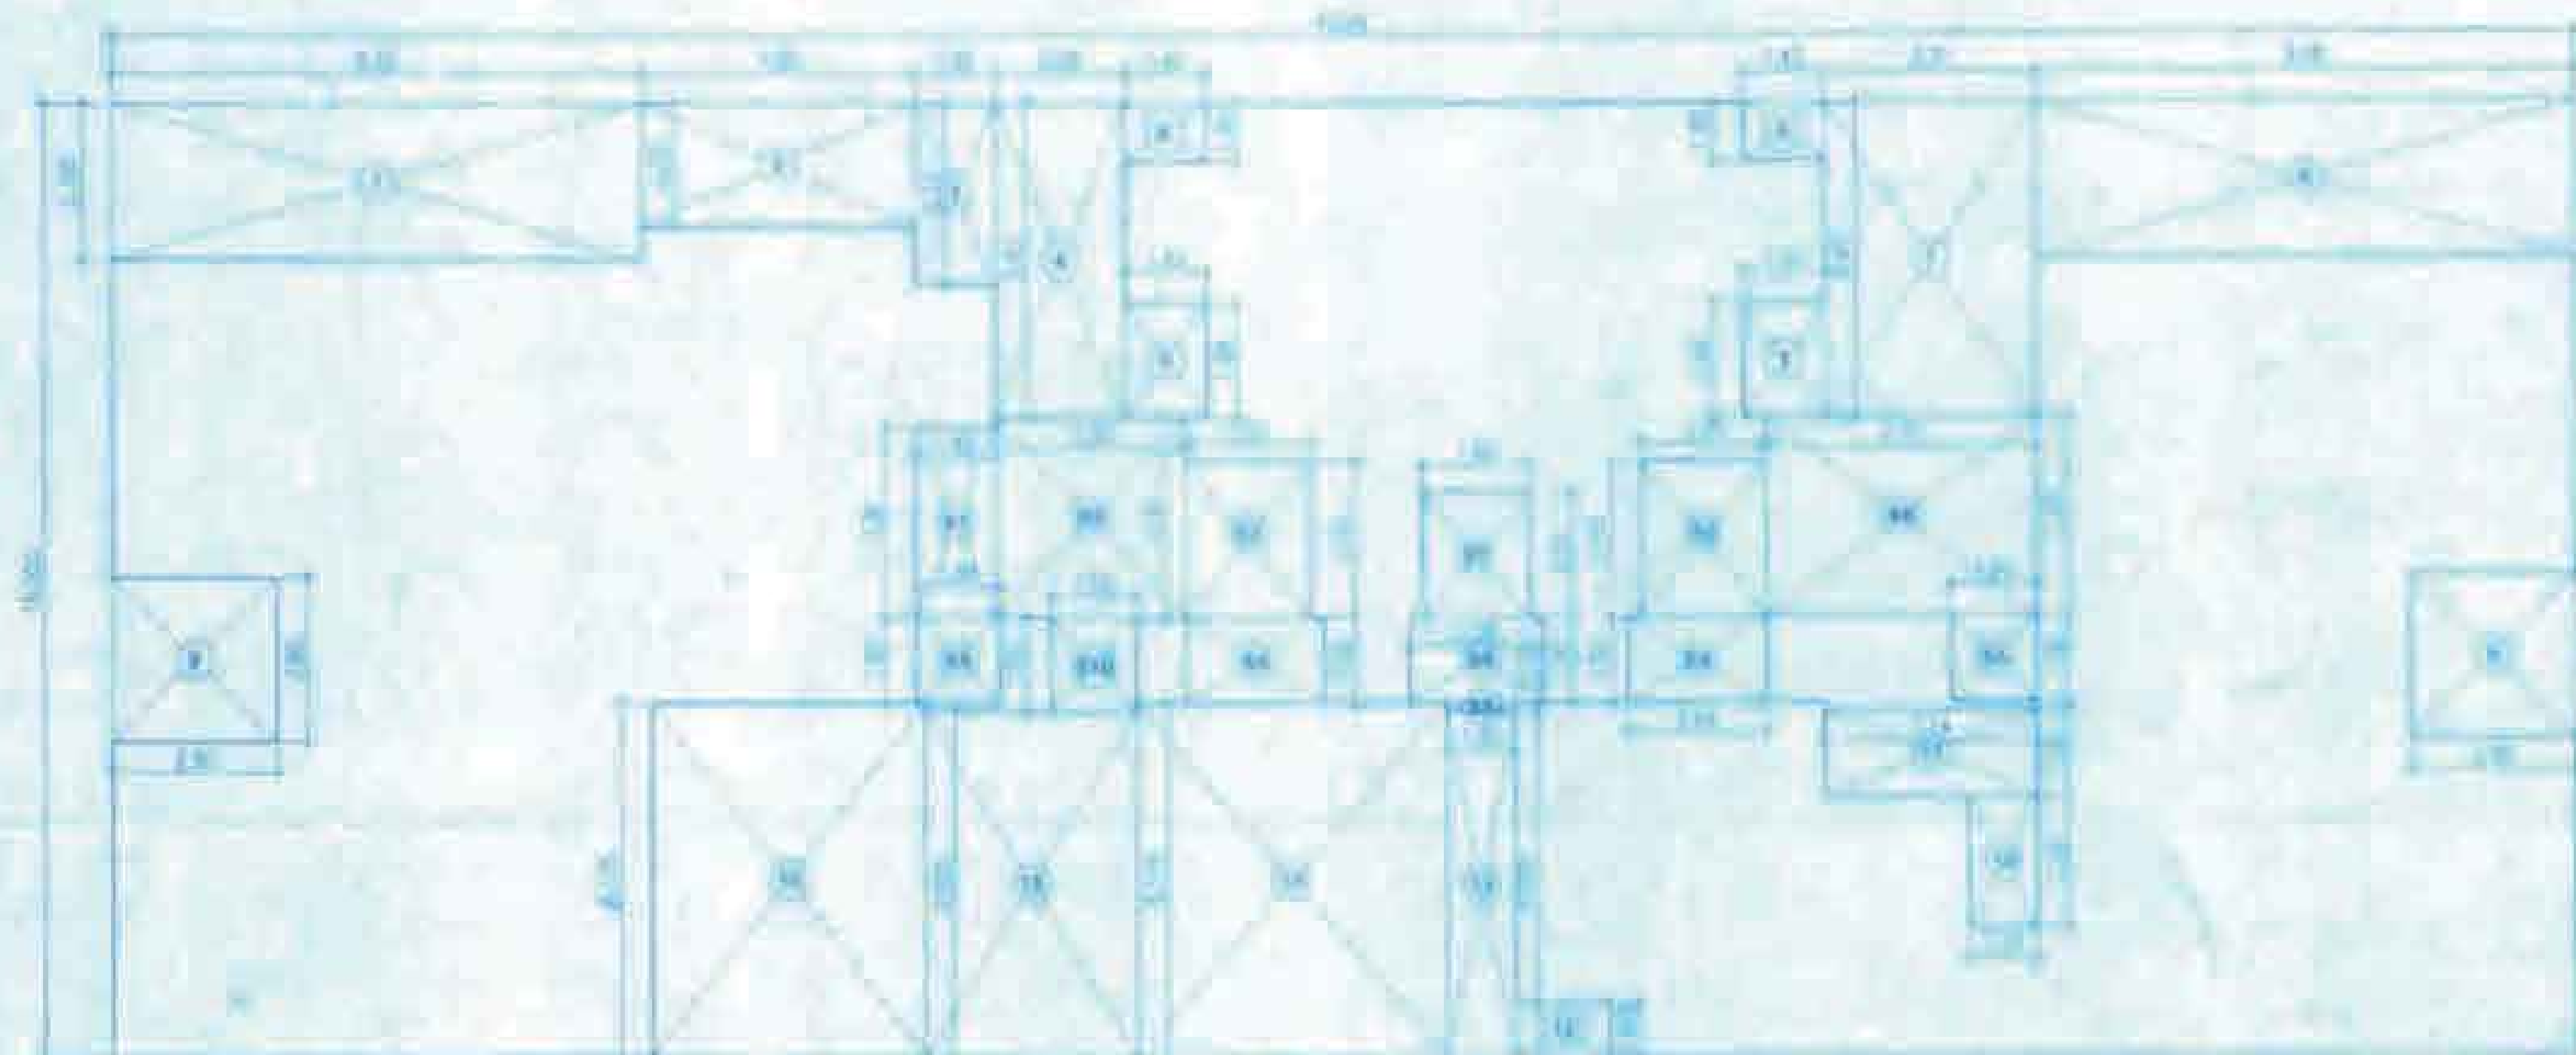

AREA DIAGRAM 1ST FLOOR
SCALE 1:100

REQUIRE										8 102M
REQUIRE										117.40
TOTAL REQUIRE										117.40
REQUIRE										117.40
REQUIRE										117.40
TOTAL REQUIRE = 226.20
NET TOTAL AREA = 491.20
AREA CALCULATION

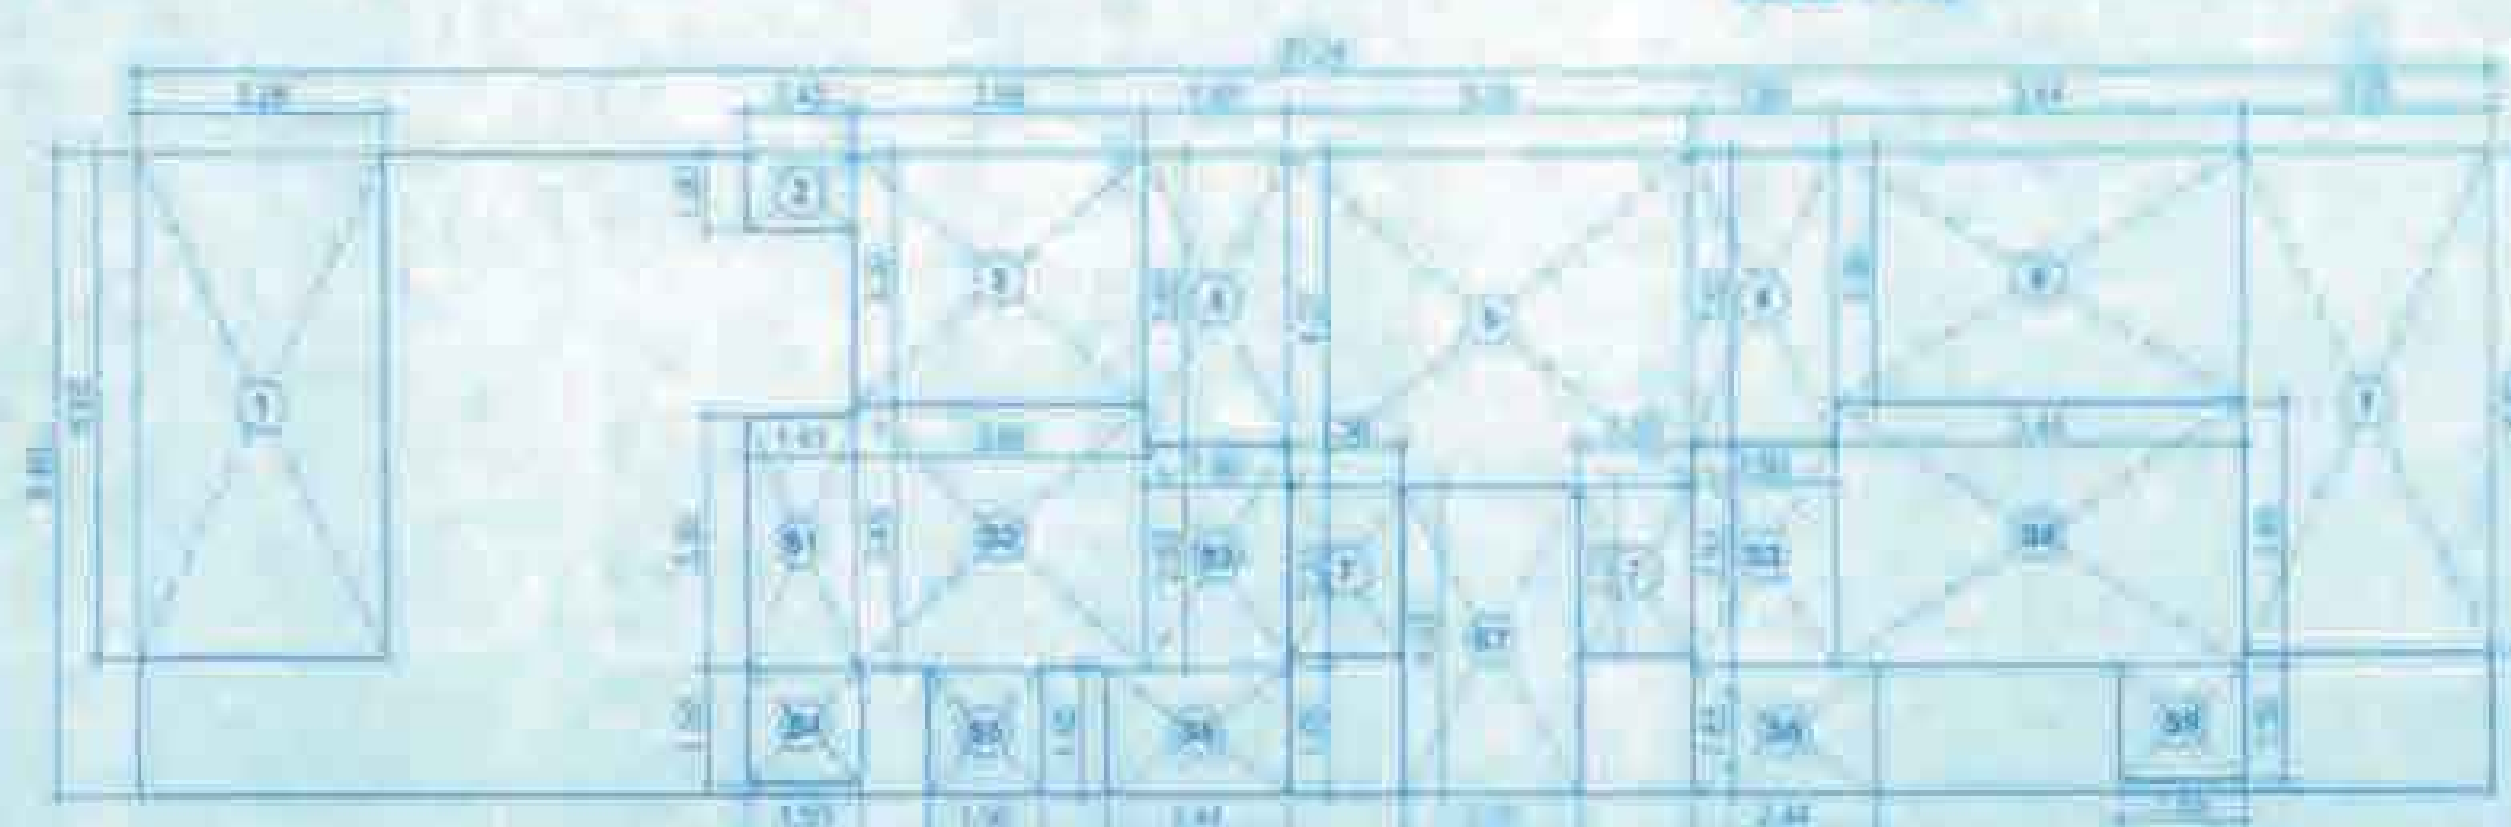

AREA DIAGRAM 5TH FLOOR
SCALE 1:100

REQUIRE										= 224
1	11.24	1	1.40	1	1	1	1	1	1	117.40
TOTAL ACCEPT										= 262.42
REQUIRE										
1	1.20	1	1.60	1	1	1	1	1	1	43.60
2	0.45	1	1.10	1	1	1	1	1	1	14.20
3	1.80	1	1.60	1	1	1	1	1	1	12.70
4	1.90	1	1.20	1	1	1	1	1	1	14.50
5	3.30	1	1.20	1	1	1	1	1	1	22.80
6	2.40	1	1.20	1	1	1	1	1	1	17.10
7	1.20	1	1.20	1	1	1	1	1	1	8.60
TOTAL REDUCTION										= 120.00

TOTAL REQUIRE = 120.01
NET TOTAL AREA = 142.41
AREA CALCULATION

BUILT - UP AREA DIAGRAM & CALCULATION

NOTE: ALL MAIN DOOR, KITCHEN DOOR, STAIRCASE DOOR, ELEC. DUCT & REFUGE AREA SHALL BE PROVIDED WITH E.R.D.

F O R M - II

CERTIFICATE OF AREA

STATED THAT I HAVE TURNED THE FLIP BOOK REFERENCE ON 10/10/16 AND THAT THE DIMENSIONS OF THE BUILDING OF THE FLOOR SHOWN ON THE PLAN ARE AS MEASURED IN SITU AND THE AREA SO WORKED OUT IS 1021.18 SQ.M. (ONE THOUSAND TWENTY ONE POINT ONE EIGHT SQ.M.) AND I HAVE THE AREA STATED IN THE DOCUMENT OF THE OWNER'S / PROPRIETOR'S SIGNATURE RETURN.

SIGNATURE OF THE ARCHITECT

STAMP OF DATE OF RECORD



SPACE
MOULDERS

STAMP OF APPROVAL OF PLANS

APPROVED 11 APR 2016

APPROVED 11 APR 2016

