


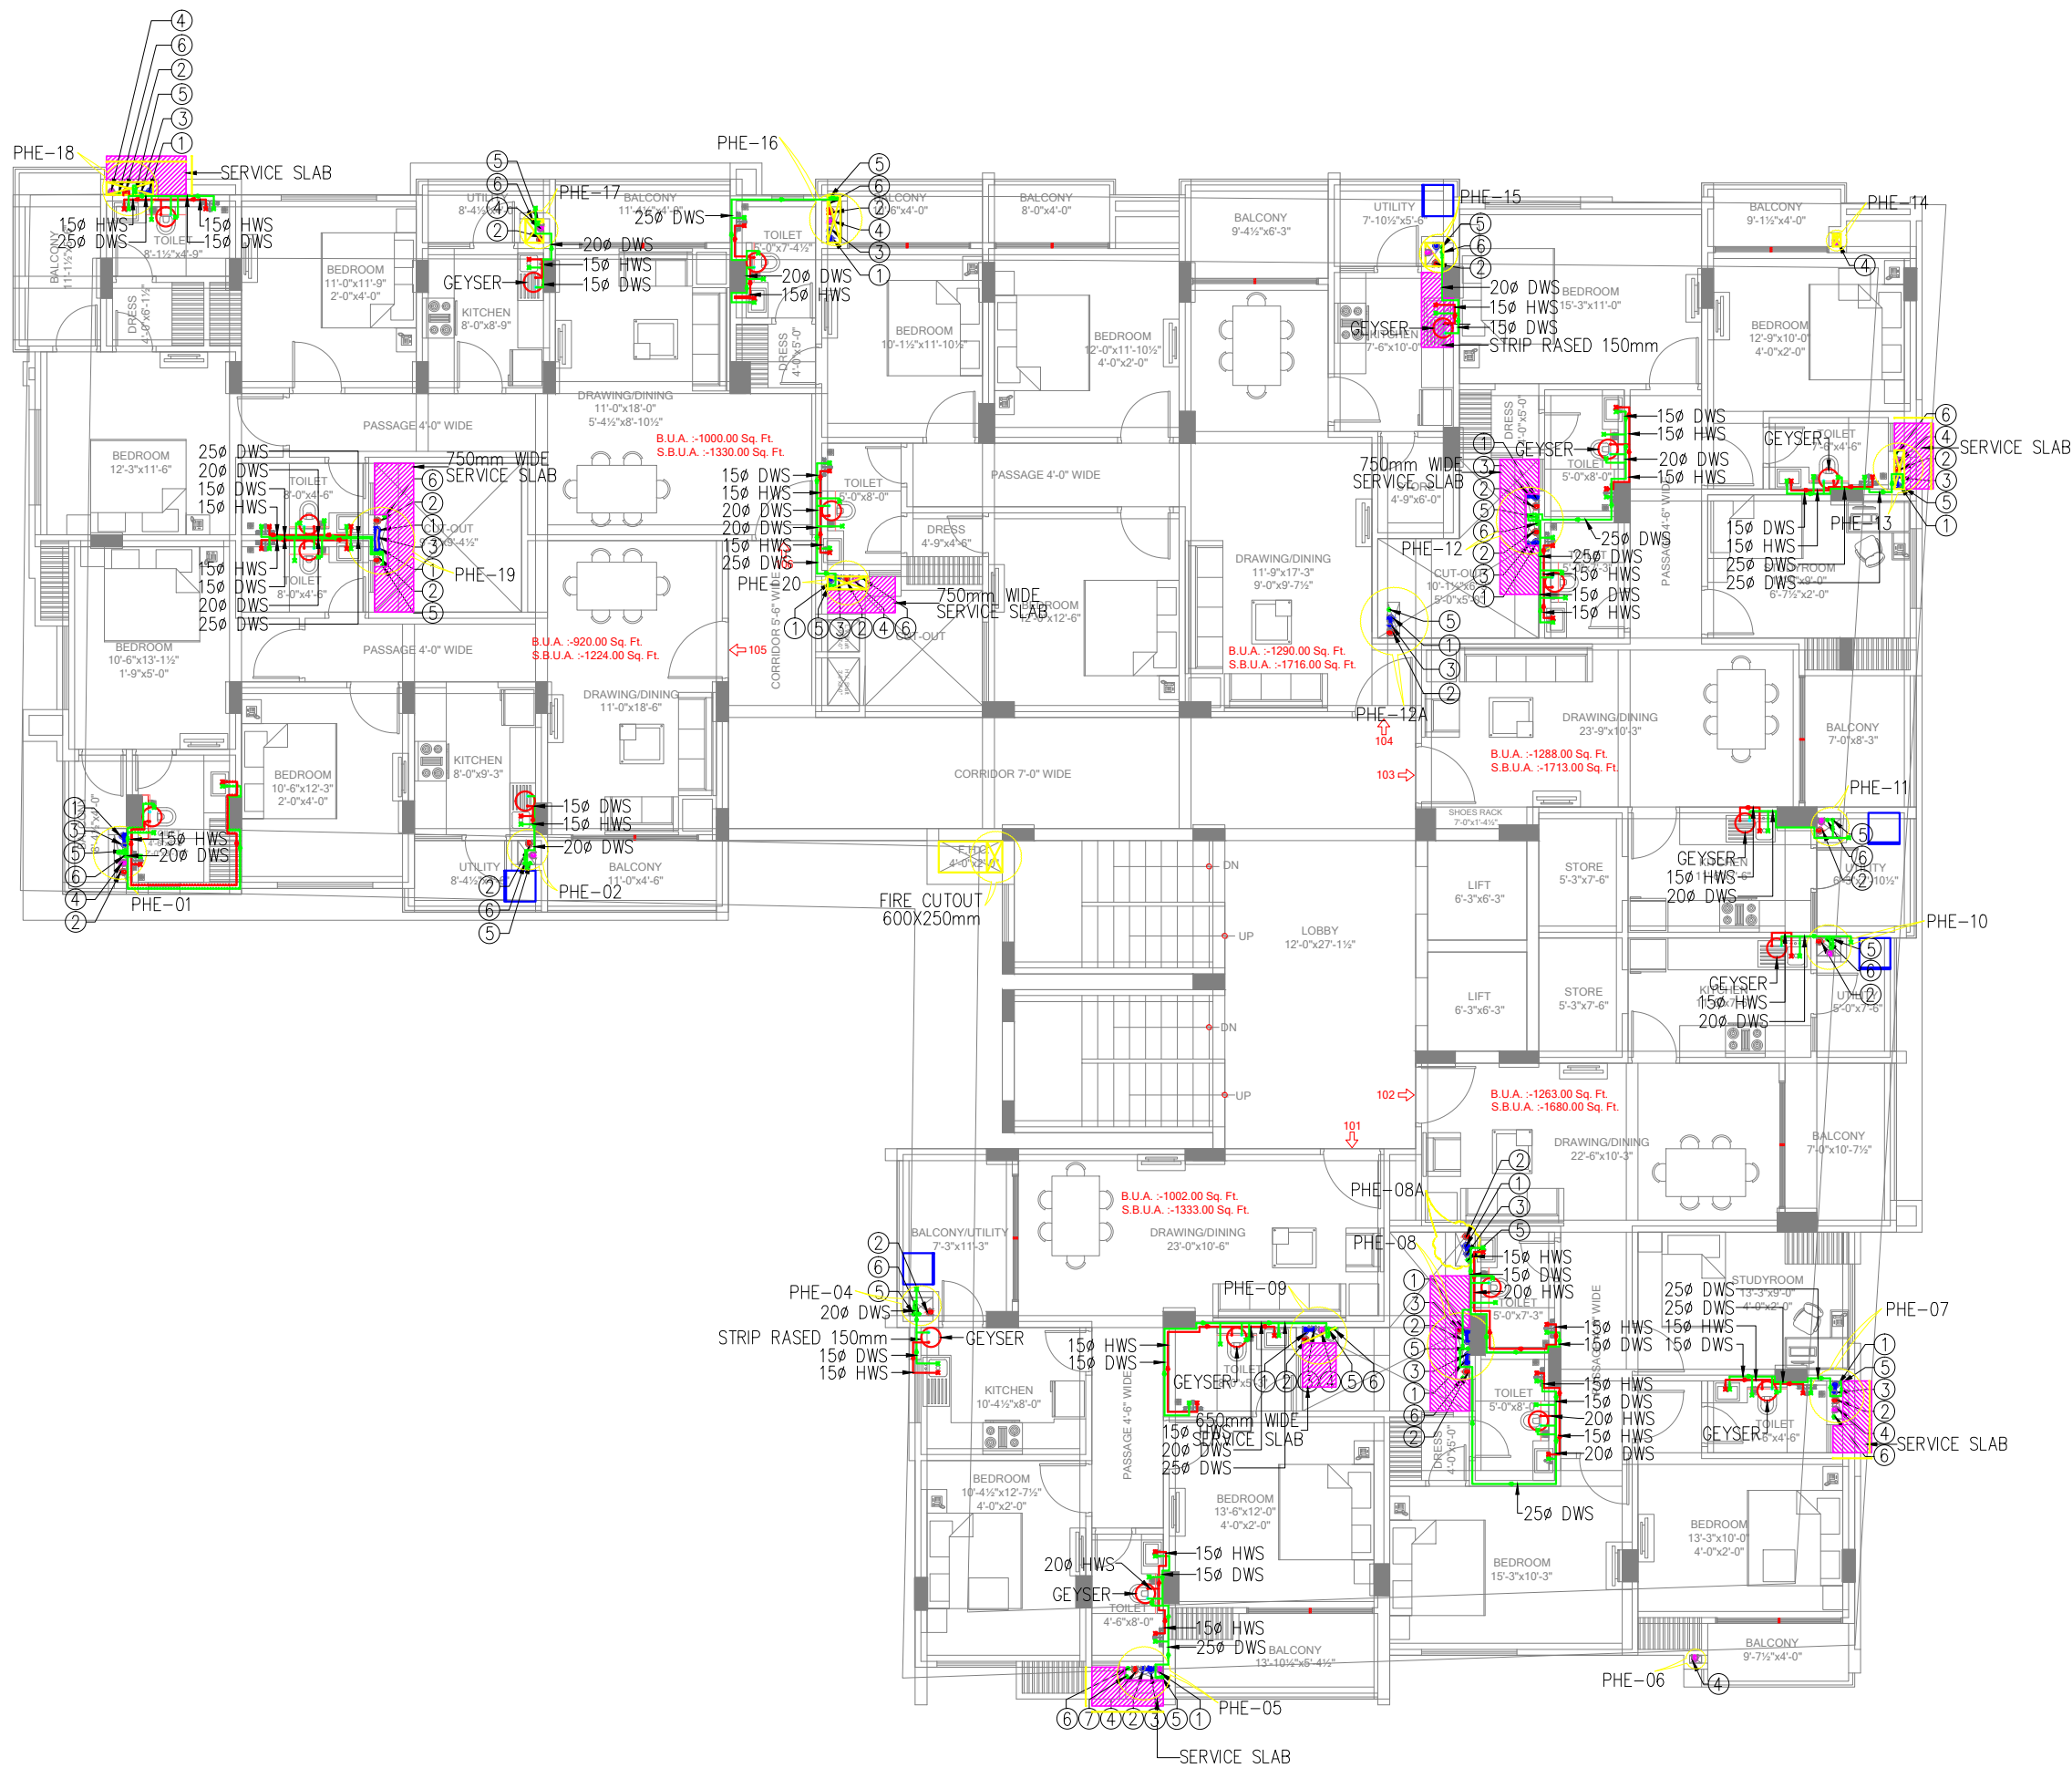

TYPICAL (1st to 4th & 7th) FLOOR PLAN

| PLUMBING LEGEND                                |                                                   |
|------------------------------------------------|---------------------------------------------------|
| 1                                              | 110 OD uPVC SOIL & VENT PIPE                      |
| 2                                              | 110 OD uPVC WASTE & VENT PIPE                     |
| 3                                              | 75Ø VENT PIPE                                     |
| 4                                              | 110 OD uPVC RAIN WATER PIPE                       |
| 5                                              | DWS DN TAKE PIPE FROM O.H.T. (STILT TO 6th FLOOR) |
| 6                                              | DWS DN TAKE PIPE FROM O.H.T. (TOP 3 FLOOR)        |
| 7                                              | DWS RISER PIPE                                    |
| FD=FLOOR DRAIN                                 |                                                   |
| FT=FLOOR TRAP                                  |                                                   |
| WASH BASIN TO FLOOR TRAP 40 OD uPVC WASTE PIPE |                                                   |
| WC TO MAIN STACK 110 OD SOIL PIPE              |                                                   |
| FT TO MAIN STACK 110 OD WASTE PIPE             |                                                   |
| FD TO FT 63 OD WASTE PIPE                      |                                                   |
| DWS-DOMESTIC WATER SUPPLY                      |                                                   |

CLIENT:-

KGK Projects India Pvt.Ltd.

D-44A, BHAGAT SINGH MARG, C-SCHEME

JAIPUR-302017 (Rajasthan)

ARCHITECT:-

Tushar Sogani Designs Pvt. Ltd.

architects 'n' designers

Studio :- 400, F-72, "SURYODAY", Subhash Marg,

Bagadiya Bhawan, C-Scheme, Jaipur-302001

TEL:- +91-141-4004560, 4004537

email: studio@tsdplarch.com

website : www.tsdplarch.com

THIS DRAWING IS THE PROPERTY OF Tushar Sogani Designs Pvt.Ltd.

IT SHALL NOT BE COPIED OR USED WITHOUT THEIR WRITTEN

PERMISSION OR MADE KNOWN TO A THIRD PARTY.

THE INFORMATION IS ISSUED ON THE UNDERSTANDING THAT NO

PART THERE OF SHALL BE DUPLICATED FOR THE PURPOSE OTHER

THAN THE EXPRESSED PURPOSE.

Project Management Consultant:-

KGK Infrastructure (India) Pvt.Ltd.

D-44, SUBHASH MARG, C-SCHEME,

Jaipur-302017 (Rajasthan)

MEP CONSULTANTS:-

Innovative Consulting Engineers

G-79/3, 2nd Floor, Sarita Vihar-Kalindi Kunj Road,

New Delhi-110025

TEL: 011- 26941605

email : innovative.mep@gmail.com

STRUCTURAL CONSULTANTS:-

Prime Tech Design Consultants

B-1, ASHOK VIHAR, NEAR SECTOR- 11,

MALVIYA NAGAR, JAIPUR-17

M-+91- 94142 97788

email : ptdcjaipur@gmail.com

|       |      |                      |       |      |           |  |  |
|-------|------|----------------------|-------|------|-----------|--|--|
| 04    |      |                      |       | 04   |           |  |  |
| 02    |      |                      |       | 02   |           |  |  |
| 02    |      |                      |       | 02   |           |  |  |
| 01    |      |                      |       | 01   |           |  |  |
| S.No. | DATE | REVISION DESCRIPTION | S.No. | DATE | ISSUED TO |  |  |

G79/3, 2nd Floor

Sarita Vihar-Kalindi Kunj Main Road,

New Delhi-110025

Ph: 011-26941605

email :- innovative.mep@gmail.com

|       |      |                      |       |      |           |  |  |
|-------|------|----------------------|-------|------|-----------|--|--|
| 04    |      |                      |       | 04   |           |  |  |
| 03    |      |                      |       | 03   |           |  |  |
| 02    |      |                      |       | 02   |           |  |  |
| 01    |      |                      |       | 01   |           |  |  |
| S.No. | DATE | REVISION DESCRIPTION | S.No. | DATE | ISSUED TO |  |  |

PROJECT:-

'The OASIS'

At Plot No.- 1, 2, 25, 26 & 27

Scheme - Surya Vihar (Mahatma Gandhi)

Siddharth Nagar, Surya Vihar Colony


Tehsil - Sanganer, Jaipur

NAME OF DRAWING:-

WATER SUPPLY LAYOUT

1st-4th & 7th FLOOR PLAN

|               |               |
|---------------|---------------|
| WORKING       | PROJECT No.:- |
| DRAWING       |               |
| DATE:-        | DEALT BY:-    |
| 10-07-2015    | RAJENDER      |
| SCALE:-       | CHECKED BY:   |
| 1:125(A2)     | SAJJAD HASAN  |
| REV No.:-     | APPROVED BY:  |
| R-00          |               |
| NOTES:-       | NORTH:-       |
|               |               |
| DRAWING No.:- | WS-4          |
| PATH:-        |               |

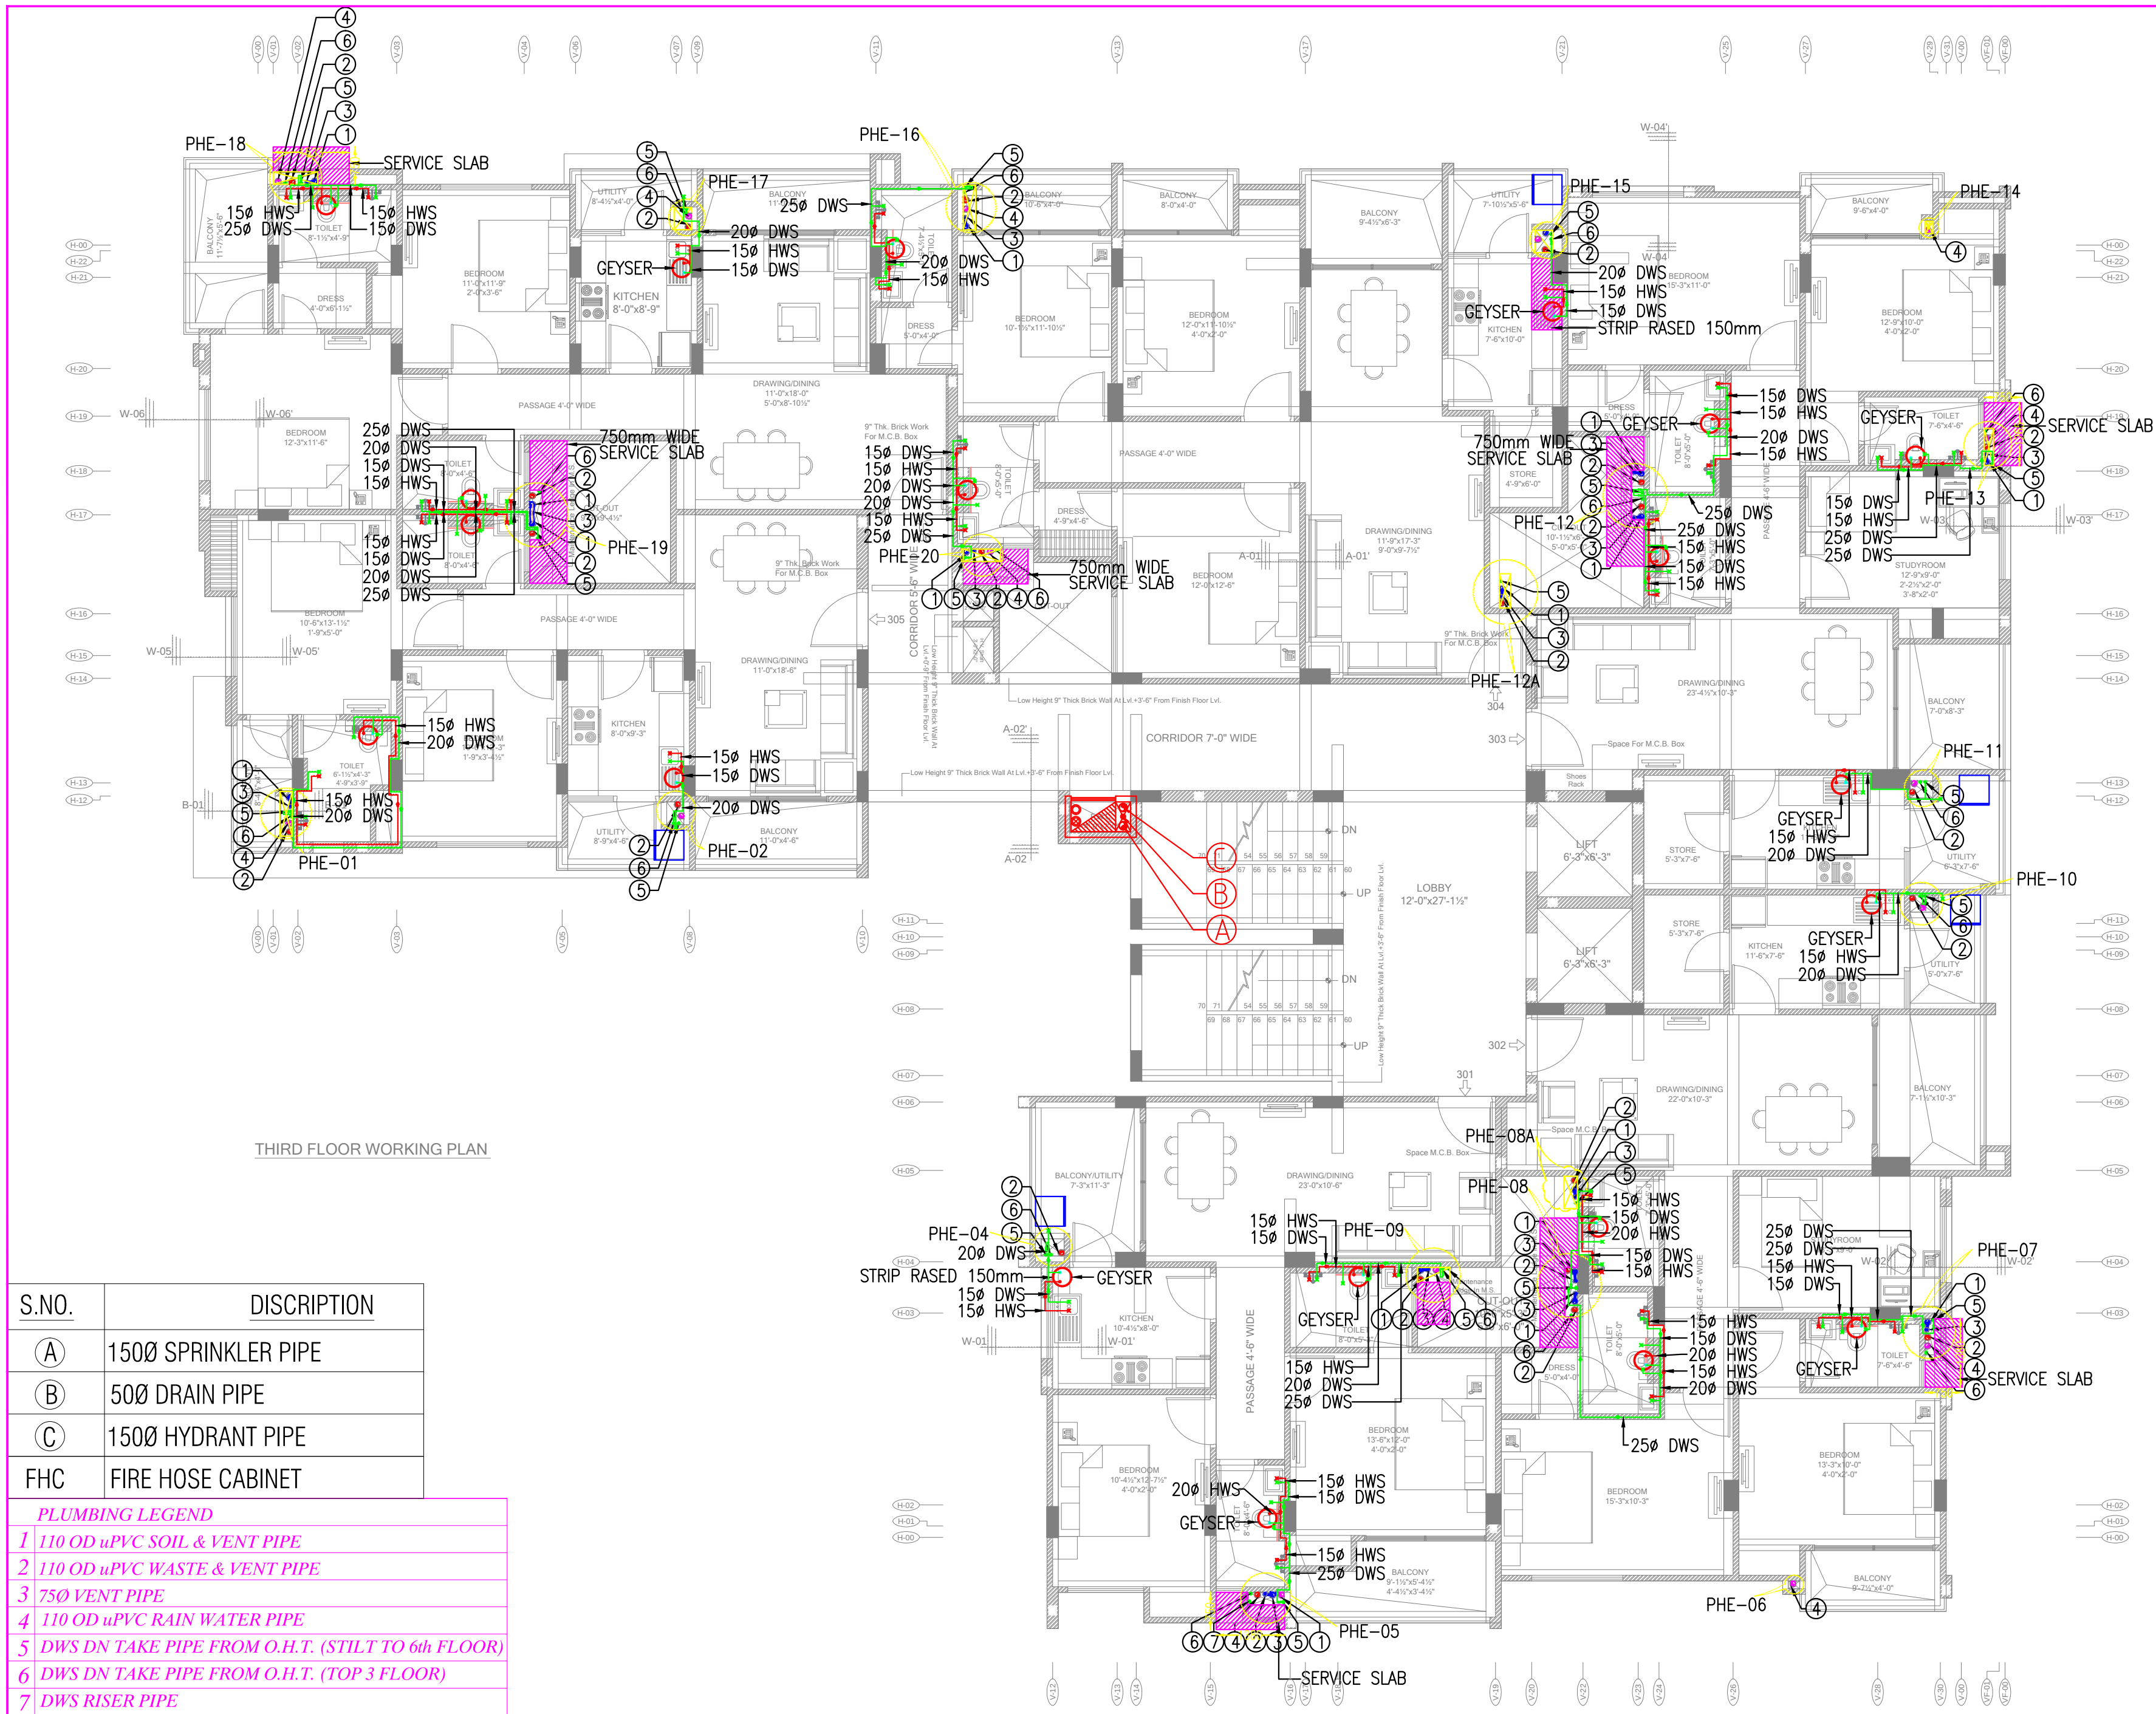

| S.NO. | DISCRIPTION         |
|-------|---------------------|
| (A)   | 150Ø SPRINKLER PIPE |
| (B)   | 50Ø DRAIN PIPE      |
| (C)   | 150Ø HYDRANT PIPE   |
| FHC   | FIRE HOSE CABINET   |

| PLUMBING LEGEND |                                                   |
|-----------------|---------------------------------------------------|
| 1               | 110 OD uPVC SOIL & VENT PIPE                      |
| 2               | 110 OD uPVC WASTE & VENT PIPE                     |
| 3               | 75Ø VENT PIPE                                     |
| 4               | 110 OD uPVC RAIN WATER PIPE                       |
| 5               | DWS DN TAKE PIPE FROM O.H.T. (STILT TO 6th FLOOR) |
| 6               | DWS DN TAKE PIPE FROM O.H.T. (TOP 3 FLOOR)        |
| 7               | DWS RISER PIPE                                    |

CLIENT:-  
**KGK Projects India Pvt.Ltd.**  
D-44A, BHAGAT SINGH MARG, C-SCHEME  
JAIPUR-302017 (Rajasthan)

ARCHITECT:-  
**Tushar Sogani Designs Pvt. Ltd.**  
architects 'n' designers  
Studio :- 400, F-72, "SURYODAY", Subhash Marg,  
Bagadiya Bhawan, C-Scheme, Jaipur-302001  
TEL: +91-141-4004560, 4004537  
email: studio@tsdplarch.com  
website : www.tsdplarch.com

THIS DRAWING IS THE PROPERTY OF Tushar Sogani Designs Pvt.Ltd.  
IT SHALL NOT BE COPIED OR USED WITHOUT THEIR WRITTEN  
PERMISSION OR MADE KNOWN TO A THIRD PARTY.  
THE INFORMATION IS ISSUED ON THE UNDERSTANDING THAT NO  
PART THERE OF SHALL BE DUPLICATED FOR THE PURPOSE OTHER  
THAN THE EXPRESSED PURPOSE.

Project Management Consultant:-  
**KGK Infrastructure (India) Pvt.Ltd.**  
D-44, SUBHASH MARG, C-SCHEME,  
Jaipur-302017 (Rajasthan)

MEP CONSULTANTS:-  
**Innovative Consulting Engineers**  
G-79/3, 2nd Floor, Sarita Vihar-Kalindi Kunj Road,  
New Delhi-110025  
TEL: 011- 26941605  
email : innovative.mep@gmail.com

STRUCTURAL CONSULTANTS:-  
**Prime Tech Design Consultants**  
B-1, ASHOK VIHAR, NEAR SECTOR- 11,  
MALVIYA NAGAR, JAIPUR-17  
M-+91- 94142 97788  
email : ptdcjaipur@gmail.com

| S.No. | DATE | REVISION DESCRIPTION | S.No. | DATE | ISSUED TO |
|-------|------|----------------------|-------|------|-----------|
| 04.   |      |                      | 04.   |      |           |
| 03.   |      |                      | 03.   |      |           |
| 02.   |      |                      | 02.   |      |           |
| 01.   |      |                      | 01.   |      |           |

PROJECT:-  
**'The OASIS'**  
At Plot No.- 1, 2, 25, 26 & 27  
Scheme - Surya Vihar (Mahatma Gandhi)  
Siddharth Nagar, Surya Vihar Colony  
Tehsil - Sanganer, Jaipur

NAME OF DRAWING:-  
**WATER SUPPLY LAYOUT  
THIRD FLOOR PLAN**

| WORKING<br>DRAWING   | PROJECT No.:-                |
|----------------------|------------------------------|
| DATE:-<br>03-03-2016 | DEALT BY:-<br>RAJENDER       |
| SCALE:-              | CHECKED BY:-<br>SAJJAD HASAN |
| REV No.:-<br>R-00    | APPROVED BY:-                |
| NOTES:-              | NORTH:-                      |

DRAWING No.:-  
**WS-04**

PATH:-

CLIENT:-  
KGK Projects India Pvt.Ltd.  
D-44A, BHAGAT SINGH MARG, C-SCHEME  
JAIPUR-302017 (Rajasthan)

ARCHITECT:-  
**Tushar Sogani Designs Pvt. Ltd.**  
architects 'n' designers  
Studio :- 400, F-72, "SURYODAY", Subhash Marg,  
Bagadiya Bhawan, C-Scheme, Jaipur-302001  
TEL: +91-141-4004560, 4004537  
email: studio@tsdplarch.com  
website : www.tsdplarch.com

THIS DRAWING IS THE PROPERTY OF Tushar Sogani Designs Pvt.Ltd.  
IT SHALL NOT BE COPIED OR USED WITHOUT THEIR WRITTEN  
PERMISSION OR MADE KNOWN TO A THIRD PARTY.  
THE INFORMATION IS ISSUED ON THE UNDERSTANDING THAT NO  
PART THERE OF SHALL BE DUPLICATED FOR THE PURPOSE OTHER  
THAN THE EXPRESSED PURPOSE.

Project Management Consultant:-  
KGK Infrastructure (India) Pvt.Ltd.  
D-44, SUBHASH MARG, C-SCHEME,  
Jaipur-302017 (Rajasthan)

MEP CONSULTANTS:-  
**Innovative Consulting Engineers**  
G-79/3, 2nd Floor, Sarita Vihar-Kalindi Kunj Road,  
New Delhi-110025  
TEL: 011- 26941605  
email : innovative.mep@gmail.com

STRUCTURAL CONSULTANTS:-  
**Prime Tech Design Consultants**  
B-1, ASHOK VIHAR, NEAR SECTOR- 11,  
MALVIYA NAGAR, JAIPUR-17  
M:+91- 94142 97788  
email : ptdcjaipur@gmail.com

|       |      |                      |       |      |           |  |  |
|-------|------|----------------------|-------|------|-----------|--|--|
| 04.   |      |                      |       | 04.  |           |  |  |
| 03.   |      |                      |       | 03.  |           |  |  |
| 02.   |      |                      |       | 02.  |           |  |  |
| 01.   |      |                      |       | 01.  |           |  |  |
| S.No. | DATE | REVISION DESCRIPTION | S.No. | DATE | ISSUED TO |  |  |

|       |      |                      |       |      |           |  |  |
|-------|------|----------------------|-------|------|-----------|--|--|
| 04.   |      |                      |       | 04.  |           |  |  |
| 03.   |      |                      |       | 03.  |           |  |  |
| 02.   |      |                      |       | 02.  |           |  |  |
| 01.   |      |                      |       | 01.  |           |  |  |
| S.No. | DATE | REVISION DESCRIPTION | S.No. | DATE | ISSUED TO |  |  |

PROJECT:-  
**'The OASIS'**  
At Plot No.- 1, 2, 25, 26 & 27  
Scheme - Surya Vihar (Mahatma Gandhi)  
Siddharth Nagar, Surya Vihar Colony  
Tehsil - Sanganer, Jaipur

NAME OF DRAWING:-  
**WATER SUPPLY LAYOUT  
5th FLOOR PLAN**

|                      |                              |
|----------------------|------------------------------|
| WORKING<br>DRAWING   | PROJECT No.:-                |
| DATE:-<br>02-12-2015 | DEALT BY:-<br>RAJENDER       |
| SCALE:-<br>1:100(A2) | CHECKED BY:-<br>SAJJAD HASAN |
| REV No.:-<br>R-00    | APPROVED BY:-                |

NOTES:-  
NORTH:-

DRAWING No.:-  
PATH:-

|                                                     |
|-----------------------------------------------------|
| <b>PLUMBING LEGEND</b>                              |
| 1 110 OD uPVC SOIL & VENT PIPE                      |
| 2 110 OD uPVC WASTE & VENT PIPE                     |
| 3 75Ø VENT PIPE                                     |
| 4 110 OD uPVC RAIN WATER PIPE                       |
| 5 DWS DN TAKE PIPE FROM O.H.T. (STILT TO 6th FLOOR) |
| 6 DWS DN TAKE PIPE FROM O.H.T. (TOP 3 FLOOR)        |
| 7 DWS RISER PIPE                                    |
| FD=FLOOR DRAIN                                      |
| FT=FLOOR TRAP                                       |
| WASH BASIN TO FLOOR TRAP 40 OD uPVC WASTE PIPE      |
| WC TO MAIN STACK 110 OD SOIL PIPE                   |
| FT TO MAIN STACK 110 OD WASTE PIPE                  |
| FD TO FT 63 OD WASTE PIPE                           |
| DWS=DOMESTIC WATER SUPPLY                           |



FIFTH FLOOR WORKING PLAN

CLIENT:-  
KGK Projects India Pvt.Ltd.  
D-44A, BHAGAT SINGH MARG, C-SCHEME  
JAIPUR-302017 (Rajasthan)

ARCHITECT:-  
**Tushar Sogani Designs Pvt. Ltd.**  
architects 'n' designers  
Studio :- 400, F-72, "SURYODAY", Subhash Marg,  
Bagadiya Bhawan, C-Scheme, Jaipur-302001  
TEL: +91-141-4004560, 4004537  
email: studio@tsdplarch.com  
website : www.tsdplarch.com

THIS DRAWING IS THE PROPERTY OF Tushar Sogani Designs Pvt.Ltd.  
IT SHALL NOT BE COPIED OR USED WITHOUT THEIR WRITTEN  
PERMISSION OR MADE KNOWN TO A THIRD PARTY.  
THE INFORMATION IS ISSUED ON THE UNDERSTANDING THAT NO  
PART THERE OF SHALL BE DUPLICATED FOR THE PURPOSE OTHER  
THAN THE EXPRESSED PURPOSE.

Project Management Consultant:-  
**KGK Infrastructure (India) Pvt.Ltd.**  
D-44, SUBHASH MARG, C-SCHEME,  
Jaipur-302017 (Rajasthan)

MEP CONSULTANTS:-  
**Innovative Consulting Engineers**  
G-79/3, 2nd Floor, Sarita Vihar-Kalindi Kunj Road,  
New Delhi-110025  
TEL: 011- 26941605  
email : innovative.mep@gmail.com

STRUCTURAL CONSULTANTS:-  
**Prime Tech Design Consultants**  
B-1, ASHOK VIHAR, NEAR SECTOR- 11,  
MALVIYA NAGAR, JAIPUR-17  
M-91- 94142 97788  
email : ptdcjapur@gmail.com

|       |      |                      |       |      |           |  |  |
|-------|------|----------------------|-------|------|-----------|--|--|
| 04.   |      |                      |       | 04.  |           |  |  |
| 02.   |      |                      |       | 02.  |           |  |  |
| 02.   |      |                      |       | 02.  |           |  |  |
| 01.   |      |                      |       | 01.  |           |  |  |
| S.No. | DATE | REVISION DESCRIPTION | S.No. | DATE | ISSUED TO |  |  |

|       |      |                      |       |      |           |  |  |
|-------|------|----------------------|-------|------|-----------|--|--|
| 04.   |      |                      |       | 04.  |           |  |  |
| 03.   |      |                      |       | 03.  |           |  |  |
| 02.   |      |                      |       | 02.  |           |  |  |
| 01.   |      |                      |       | 01.  |           |  |  |
| S.No. | DATE | REVISION DESCRIPTION | S.No. | DATE | ISSUED TO |  |  |

PROJECT:-  
**'The OASIS'**  
At Plot No.- 1, 2, 25, 26 & 27  
Scheme - Surya Vihar (Mahatma Gandhi)  
Siddharth Nagar, Surya Vihar Colony  
Tehsil - Sanganer, Jaipur

NAME OF DRAWING:-  
**WATER SUPPLY LAYOUT  
6th FLOOR PLAN**

WORKING  
DRAWING

DATE:-  
03-03-2016

SCALE:-  
1:100(A2)

REV No.:-  
R-00

NOTES:-


PROJECT No.:-  
DEALT BY:-  
RAJENDER  
CHECKED BY:-  
SAJJAD HASAN  
APPROVED BY:-

DRAWING No.:-  
WS-09

PATH:-



| PLUMBING LEGEND |                                                   |
|-----------------|---------------------------------------------------|
| 1               | 110 OD uPVC SOIL & VENT PIPE                      |
| 2               | 110 OD uPVC WASTE & VENT PIPE                     |
| 3               | 75Ø VENT PIPE                                     |
| 4               | 110 OD uPVC RAIN WATER PIPE                       |
| 5               | DWS DN TAKE PIPE FROM O.H.T. (STILT TO 6th FLOOR) |
| 6               | DWS DN TAKE PIPE FROM O.H.T. (TOP 3 FLOOR)        |
| 7               | DWS RISER PIPE                                    |
| FD              | FLOOR DRAIN                                       |
| FT              | FLOOR TRAP                                        |
| WB              | WASH BASIN TO FLOOR TRAP 40 OD uPVC WASTE PIPE    |
| WC              | TO MAIN STACK 110 OD SOIL PIPE                    |
| FT              | TO MAIN STACK 110 OD WASTE PIPE                   |
| FD              | TO FT 63 OD WASTE PIPE                            |

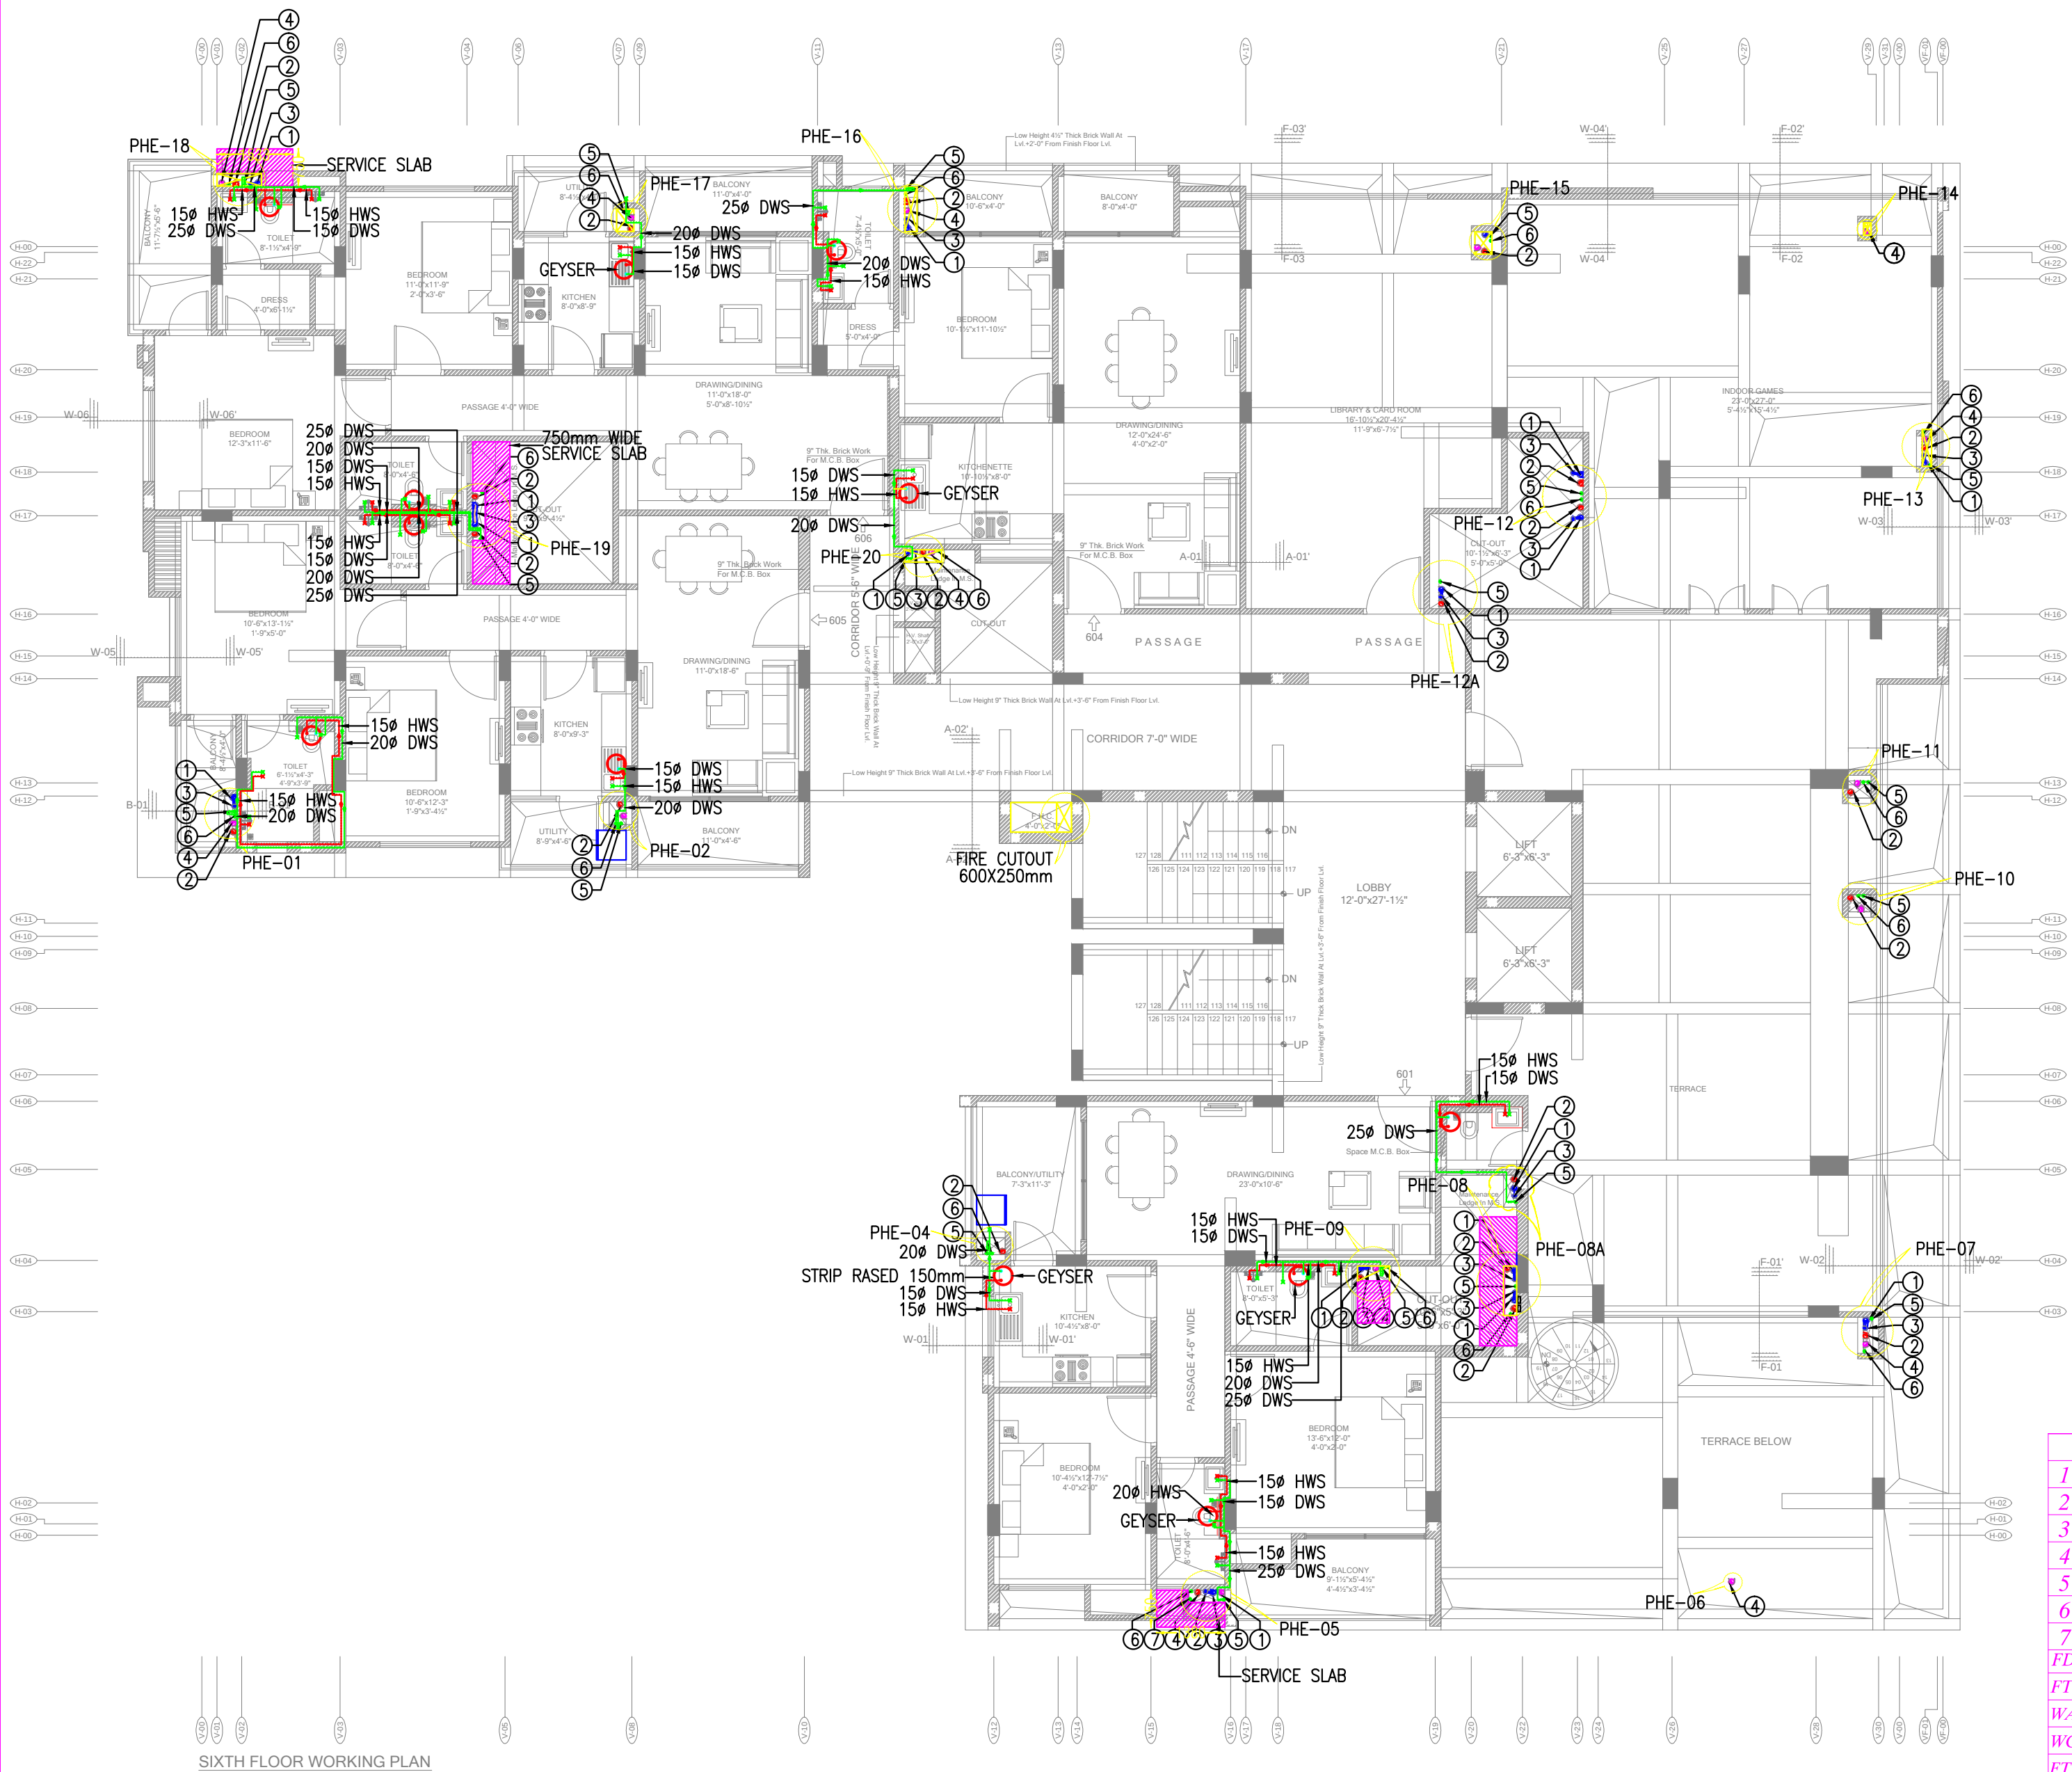

SIXTH FLOOR WORKING PLAN



NINTH FLOOR WORKING PLAN

| PLUMBING LEGEND          |                                                   |
|--------------------------|---------------------------------------------------|
| 1                        | 110 OD uPVC SOIL & VENT PIPE                      |
| 2                        | 110 OD uPVC WASTE & VENT PIPE                     |
| 3                        | 75Ø VENT PIPE                                     |
| 4                        | 110 OD uPVC RAIN WATER PIPE                       |
| 5                        | DWS DN TAKE PIPE FROM O.H.T. (STILT TO 6th FLOOR) |
| 6                        | DWS DN TAKE PIPE FROM O.H.T. (TOP 3 FLOOR)        |
| 7                        | DWS RISER PIPE                                    |
| FD                       | FLOOR DRAIN                                       |
| FT                       | FLOOR TRAP                                        |
| WASH BASIN TO FLOOR TRAP | 40 OD uPVC WASTE PIPE                             |
| WC TO MAIN STACK         | 110 OD SOIL PIPE                                  |
| FT TO MAIN STACK         | 110 OD WASTE PIPE                                 |
| FD TO FT                 | 63 OD WASTE PIPE                                  |
| DWS                      | DOMESTIC WATER SUPPLY                             |

CLIENT:-  
KGK Projects India Pvt.Ltd.  
D-44A, BHAGAT SINGH MARG, C-SCHEME  
JAIPUR-302017 (Rajasthan)

ARCHITECT:-  
Tushar Sogani Designs Pvt. Ltd.  
architects 'n' designers  
Studio :- 400, F-72, "SURYODAY", Subhash Marg,  
Bagadiya Bhawan, C-Scheme, Jaipur-302001  
TEL: +91-141-4004560, 4004537  
email: studio@tsdplarch.com  
website : www.tsdplarch.com  
THIS DRAWING IS THE PROPERTY OF Tushar Sogani Designs Pvt.Ltd.  
IT SHALL NOT BE COPIED OR USED WITHOUT THEIR WRITTEN  
PERMISSION OR MADE KNOWN TO A THIRD PARTY.  
THE INFORMATION IS ISSUED ON THE UNDERSTANDING THAT NO  
PART THERE OF SHALL BE DUPLICATED FOR THE PURPOSE OTHER  
THAN THE EXPRESSED PURPOSE.

Project Management Consultant:-  
KGK Infrastructure (India) Pvt.Ltd.  
D-44, SUBHASH MARG, C-SCHEME,  
Jaipur-302017 (Rajasthan)

MEP CONSULTANTS:-  
Innovative Consulting Engineers  
G-79/3, 2nd Floor, Sarita Vihar-Kalindi Kunj Road,  
New Delhi-110025  
TEL: 011- 26941605  
email : innovative.mep@gmail.com

STRUCTURAL CONSULTANTS:-  
Prime Tech Design Consultants  
B-1, ASHOK VIHAR, NEAR SECTOR- 11,  
MALVIYA NAGAR, JAIPUR-17  
M.+91- 94142 97788  
email : ptdcjaipur@gmail.com

|       |      |                      |       |      |           |  |  |
|-------|------|----------------------|-------|------|-----------|--|--|
| 04.   |      |                      |       | 04.  |           |  |  |
| 03.   |      |                      |       | 03.  |           |  |  |
| 02.   |      |                      |       | 02.  |           |  |  |
| 01.   |      |                      |       | 01.  |           |  |  |
| S.No. | DATE | REVISION DESCRIPTION | S.No. | DATE | ISSUED TO |  |  |

|       |      |                      |       |      |           |  |  |
|-------|------|----------------------|-------|------|-----------|--|--|
| 04.   |      |                      |       | 04.  |           |  |  |
| 03.   |      |                      |       | 03.  |           |  |  |
| 02.   |      |                      |       | 02.  |           |  |  |
| 01.   |      |                      |       | 01.  |           |  |  |
| S.No. | DATE | REVISION DESCRIPTION | S.No. | DATE | ISSUED TO |  |  |

PROJECT:-  
'The OASIS'  
At Plot No.- 1, 2, 25, 26 & 27  
Scheme - Surya Vihar (Mahatma Gandhi)  
Siddharth Nagar, Surya Vihar Colony  
Tehsil - Sanganeer, Jaipur

NAME OF DRAWING:-  
WATER SUPPLY LAYOUT  
8th FLOOR PLAN

|                      |                              |
|----------------------|------------------------------|
| WORKING<br>DRAWING   | PROJECT No.:-                |
| DATE:-<br>05-12-2015 | DEALT BY:-<br>RAJENDER       |
| SCALE:-<br>1:100(A2) | CHECKED BY:-<br>SAJJAD HASAN |
| REV No.:-<br>R-00    | APPROVED BY:-                |
| NOTES:-              | NORTH:-<br>                  |

|               |       |
|---------------|-------|
| DRAWING No.:- | WS-11 |
| PATH:-        |       |


BUILDER/DEVELOPER:-  
**KGK Infrastructure Pvt.Ltd.**  
Near Entertainment Paradise, Jawahar  
Circle, J.L.N. Marg Jaipur-302017 (Rajasthan)  
Tel:+91-141- 2720557  
Fax:+91-141- 2720886

ARCHITECT:-  
**Tushar Sogani Designs Pvt. Ltd.**  
architects n designers  
F-72, 105, 'SURYODAY', Subhash Marg,  
Bagadiya Bhawan, C-Scheme, Jaipur.  
TEL: +91-141-4004560, 4004537  
email: studio@tsdplarch.com, tsdplpr@gmail.com  
website : www.tsdplarch.com

THIS DRAWING IS THE PROPERTY OF Tushar Sogani Designs Pvt.Ltd.  
IT SHALL NOT BE COPIED OR USED WITHOUT THEIR WRITTEN  
PERMISSION OR MADE KNOWN TO A THIRD PARTY.  
THE INFORMATION IS ISSUED ON THE UNDERSTANDING THAT NO  
PART THERE OF SHALL BE DUPLICATED FOR THE PURPOSE OTHER  
THAN THE EXPRESSED PURPOSE.

SERVICES CONSULTANTS:-  
**VIPUL CONSULTING**  
F-9 / 440, Keshav Marg, Chitrakut  
Scheme, Jaipur  
PH:+91-141-2440946, 2440302  
M:+91-9314610438  
email : vipul8599@yahoo.com

STRUCTURAL CONSULTANTS:-  
**Prime Tech Design Consultants**  
B-1, ASHOK VIHAR, NEAR SECTOR- 11,  
MALVIYA NAGAR, JAIPUR-17  
M:+91- 94142 97788  
email : plotjaipur@gmail.com

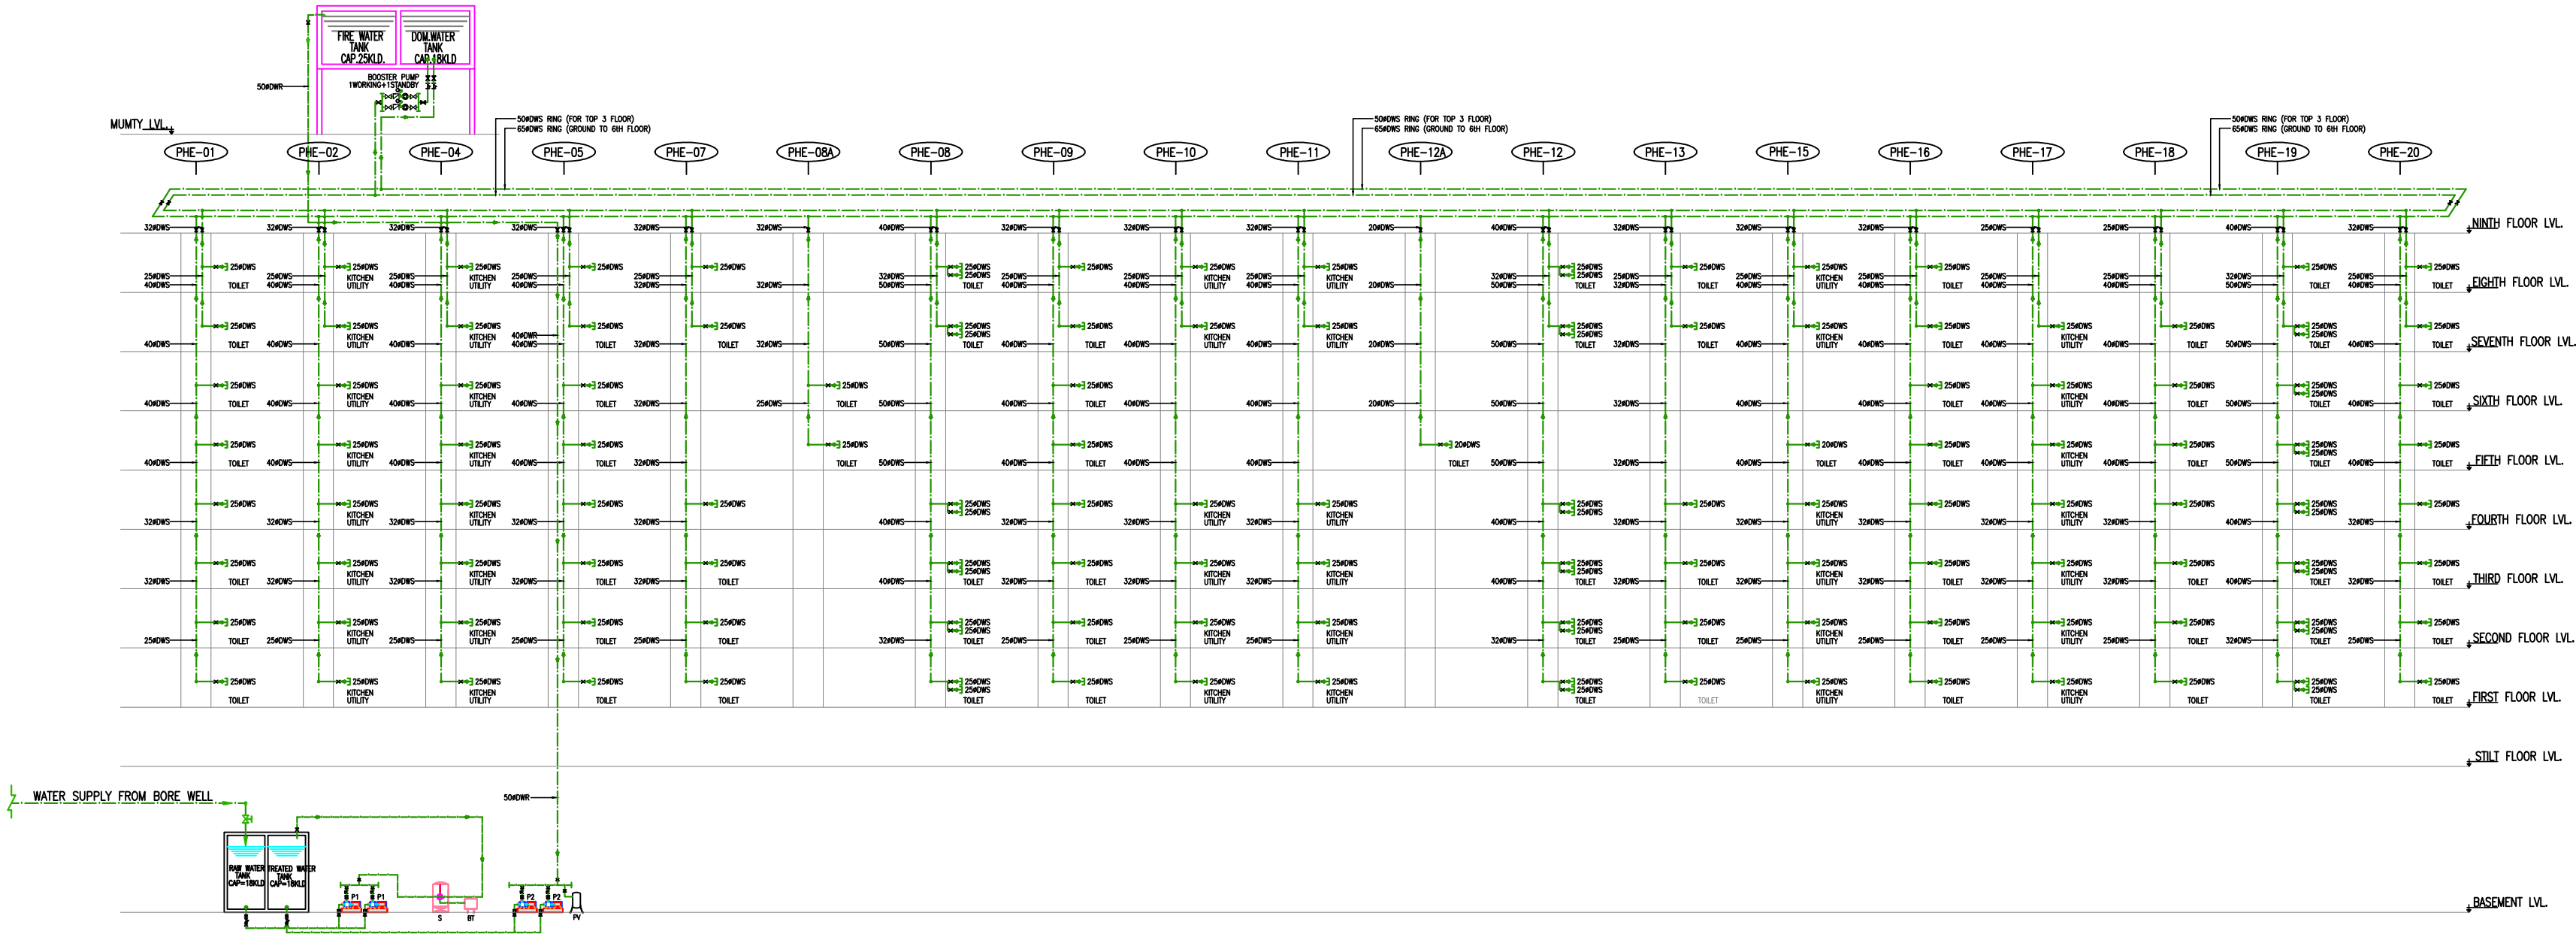

## LEGEND

| SYMBOL | DESCRIPTION                              |
|--------|------------------------------------------|
|        | BALL VALVE                               |
|        | NON RETURN VALVE                         |
|        | 'Y' STRAINER                             |
| P1.    | SOFTENER FEED PUMP(1W+1STANDBY)          |
| P2.    | TREATED WATER TRANSFER PUMP(1W+1STANDBY) |
| S      | SOFTENER                                 |
| BT     | BRINE TANK                               |
|        | DOMESTIC WATER SUPPLY LINE               |
| DWS    | DOMESTIC WATER SUPPLY                    |
| DWR    | DOMESTIC WATER RISER                     |

## MEP CONSULTANT

**INNOVATIVE CONSULTING ENGINEERS**  
G79/3, 2nd Floor  
Sarita Vihar-Kalindi Kunj Main Road,  
New Delhi-110025  
Ph: 011-28941605  
email :- innovative.mep@gmail.com

|     |  |     |  |
|-----|--|-----|--|
| 04. |  | 04. |  |
| 03. |  | 03. |  |
| 02. |  | 02. |  |
| 01. |  | 01. |  |

S.N.O. DATE REVISION DESCRIPTION S.N.O. DATE ISSUED TO

PROJECT:-

**'The OASIS'**  
At Plot No.- 1, 2, 25, 26 & 27  
Scheme - Surya Vihar (Mahatma Gandhi)  
Siddharth Nagar, Surya Vihar Colony  
Tehsil - Sanganer, Jaipur

NAME OF DRAWING:-

**SCHEMATIC DIAGRAM FOR  
WATER SUPPLY SYSTEM**

| WORKING<br>DRAWING   | PROJECT No.:-               |
|----------------------|-----------------------------|
| DATE:-<br>19-08-2016 | DEALT BY:-<br>RAJENDER      |
| SCALE:-<br>NTS(A2)   | CHECKED BY:<br>SAJJAD HASAN |
| REV No.:-<br>R-00    | APPROVED BY:                |
| NOTES:-              | NORTH:-<br>                 |
| DRAWING No.:-        | WS-01                       |
| PATH:-               |                             |