


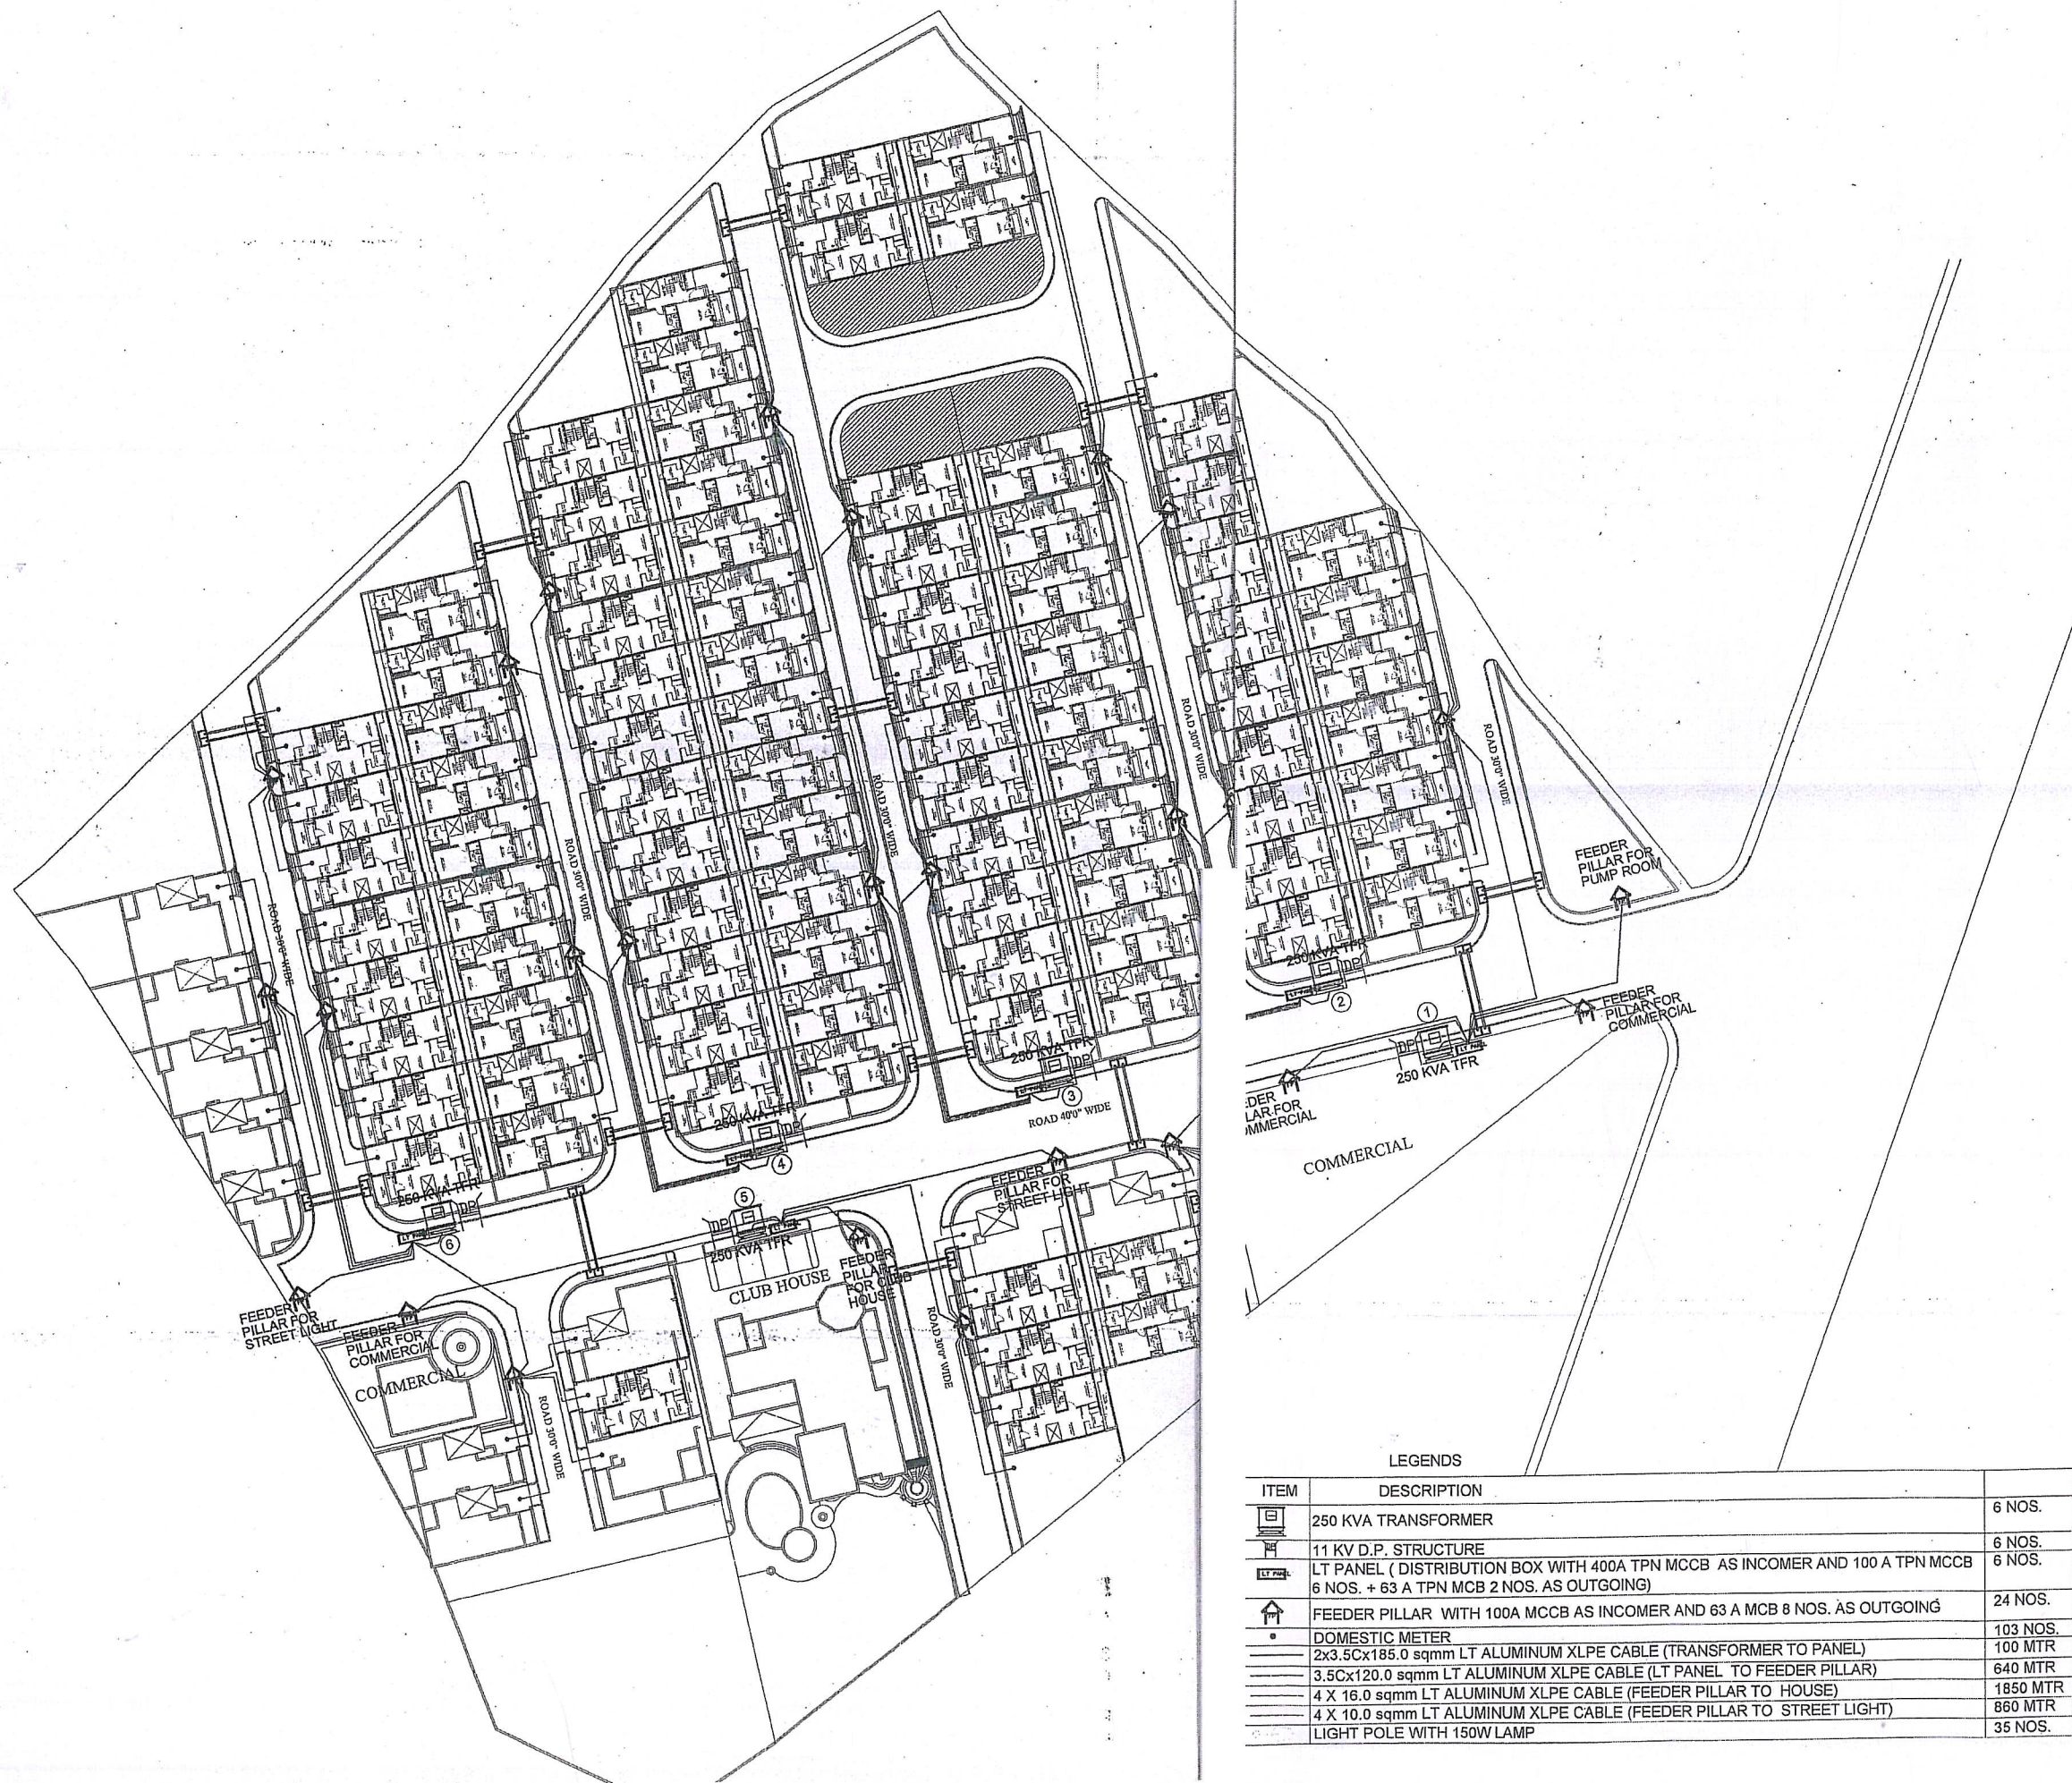

LEGENDS

ITEM	DESCRIPTION	
	250 KVA TRANSFORMER	6 NOS.
	11 KV D.P. STRUCTURE	6 NOS.
	LT PANEL (DISTRIBUTION BOX WITH 400A TPN MCCB AS INCOMER AND 100 A TPN MCCB 6 NOS. + 63 A TPN MCB 2 NOS. AS OUTGOING)	6 NOS.
	FEEDER PILLAR WITH 100A MCCB AS INCOMER AND 63 A MCB 8 NOS. AS OUTGOING	24 NOS.
	DOMESTIC METER	103 NOS.
	2x3.5Cx185.0 sqmm LT ALUMINUM XLPE CABLE (TRANSFORMER TO PANEL)	100 MTR
	3.5Cx120.0 sqmm LT ALUMINUM XLPE CABLE (LT PANEL TO FEEDER PILLAR)	640 MTR
	4 X 16.0 sqmm LT ALUMINUM XLPE CABLE (FEEDER PILLAR TO HOUSE)	1850 MTR
	4 X 10.0 sqmm LT ALUMINUM XLPE CABLE (FEEDER PILLAR TO STREET LIGHT)	860 MTR
	LIGHT POLE WITH 150W LAMP	35 NOS.

Project:
**PROPOSED HOUSING SCHEME FOR
CASA 9**
AT MANSAROVER, JAIPUR.

EXTERNAL ELECTRICAL LAYOUT

SCALE NOT TO SCALE

DATE 03 JAN. 2013

CADDY: VINOD P.T. Architect: ANSHUMAN SHARMA

DESIGN INC.
ARCHITECTS INTERIORS TURNKEY PROJECTS

34 BHAGAT VATIKA, RAJ BHAWAN ROAD
CIVIL LINES, JAIPUR - 302006.

p: 0141 2220263, 9983831453
e: designincjaipur@gmail.com

THIS DRAWING IS COPYRIGHT. IT IS THE PROPERTY OF THE ARCHITECTS AND IS NOT