



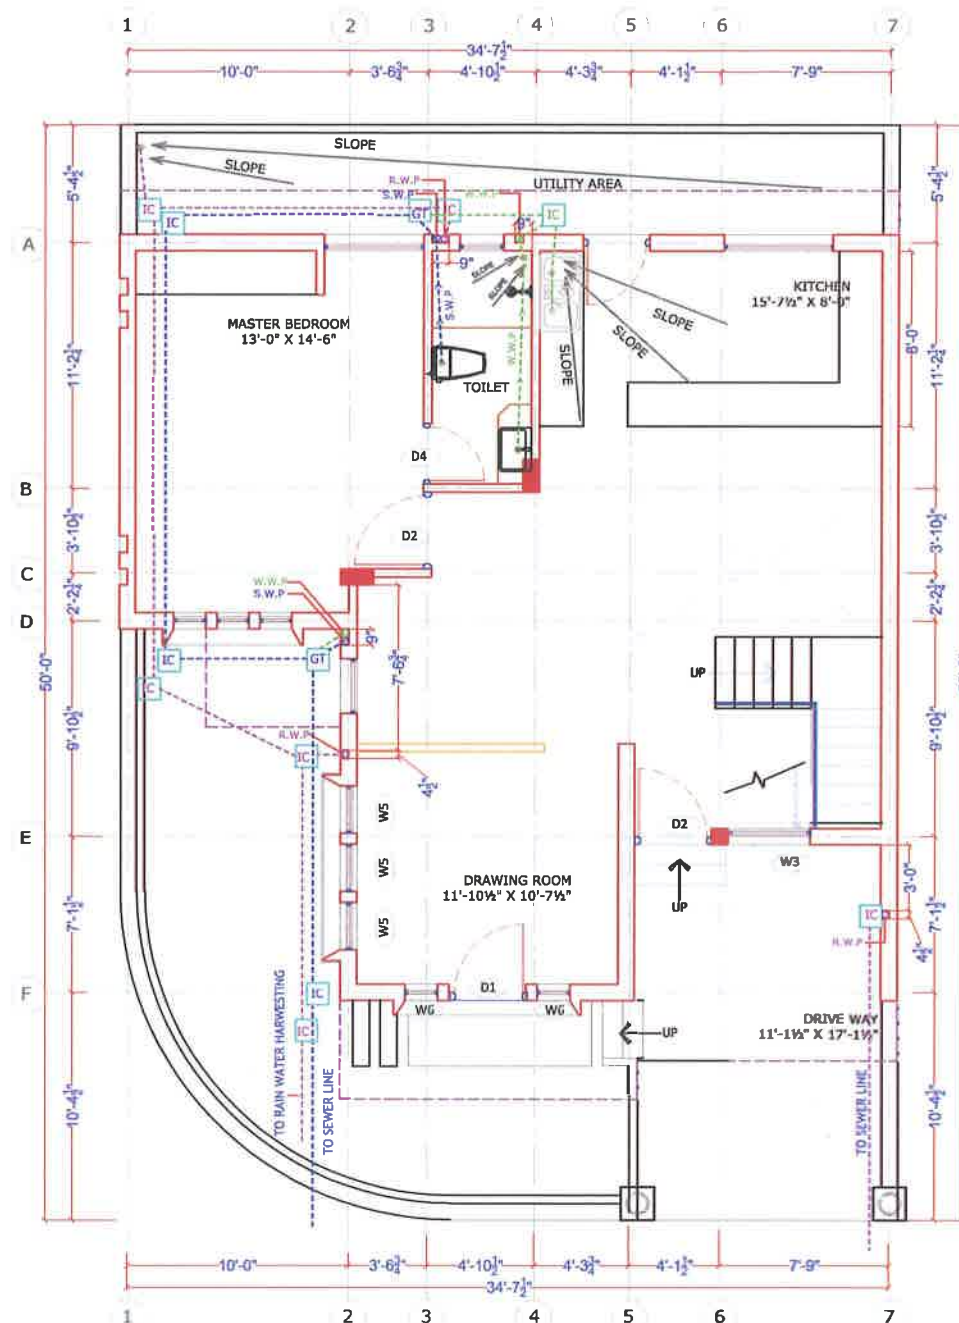

GROUND FLOOR PLAN

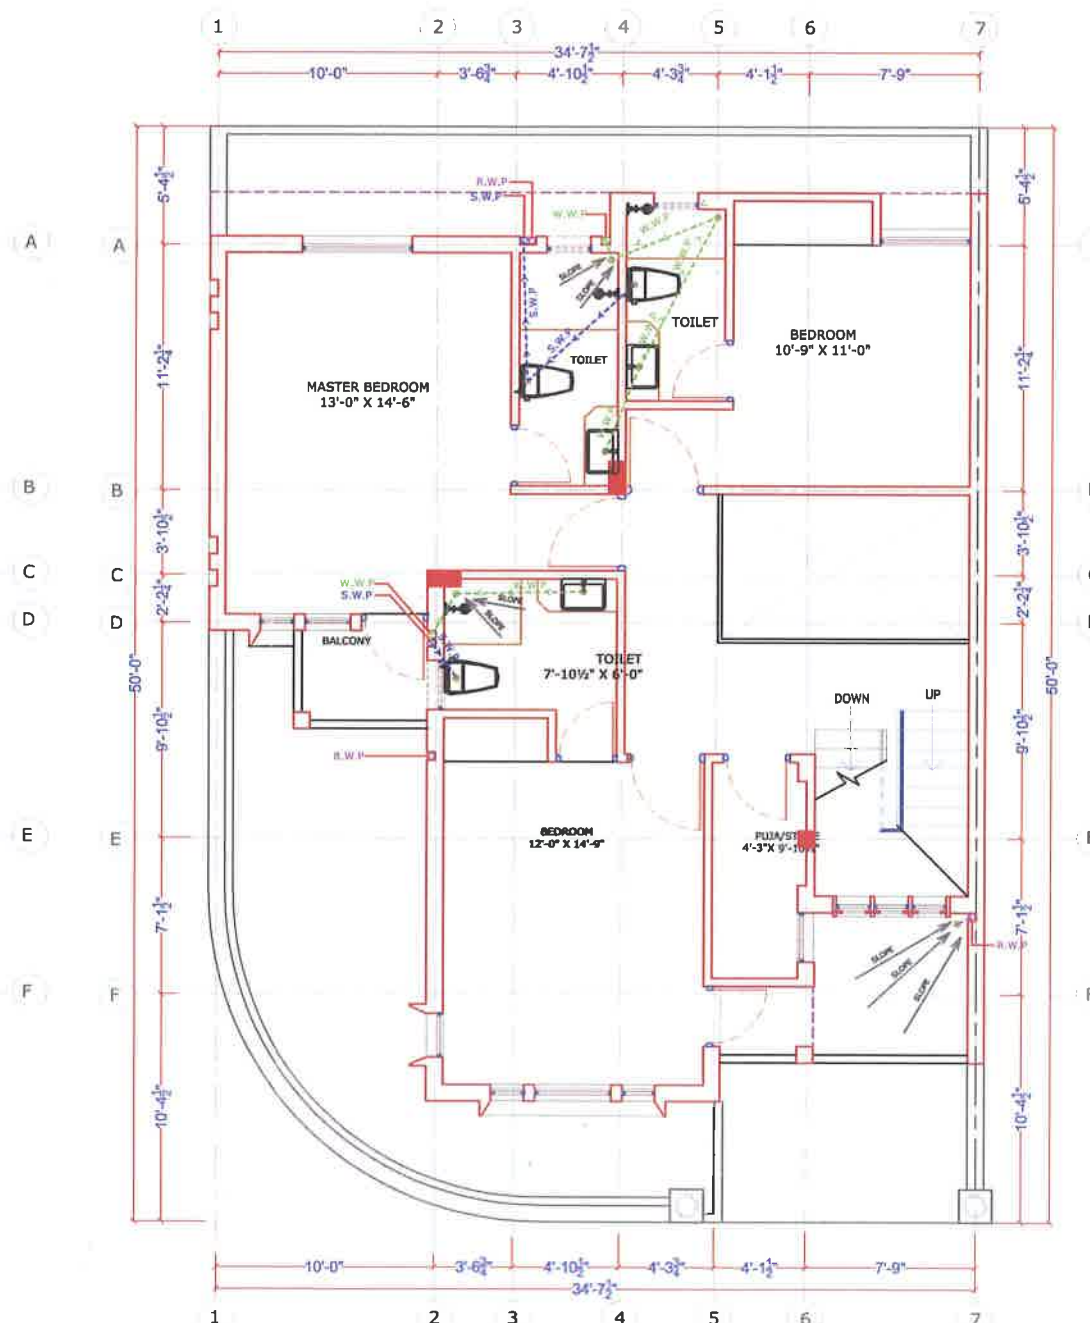

FIRST FLOOR PLAN

LEGENDS:

ID	DESCRIPTION	SYMBOL
RWP	RAIN WATER PIPE	---
WWP	WASTE WATER PIPE	---
SWP	SOIL WATER PIPE	---
GT	GULLY TRAP	GT
IC	INSPECTION CHAMBER	IC

Project:

PROPOSED HOUSING SCHEME FOR
CASA 9
AT MANSAROVER, JAIPUR.

SANITARY LAYOUT
OF EAST FACING CORNER PLOTS
(35'-0" X 50'-0")

SCALE: NOT TO SCALE

DATE: 12 DEC. 2013

CADDY: VINOD P.T.

Architect: ANSHUMAN SHARMA

DESIGN INC.

JP/HSG/C9/EA08


A1

ARCHITECTS INTERIORS TURNKEY PROJECTS


34 BHAGAT VATIKA, RAJ BHAWAN ROAD
CIVIL LINES, JAIPUR - 302006.

p: 0141 2220263, 9983831453
e: designincjaipur@gmail.com

THIS DRAWING IS COPYRIGHTED. IT IS THE PROPERTY OF THE ARCHITECTS AND IS NOT TO BE REPRODUCED, COPIED, HANDLED OVER TO A THIRD PARTY OR USED FOR ANY PURPOSE OTHER THAN THAT FOR WHICH IT HAS BEEN LOANED.

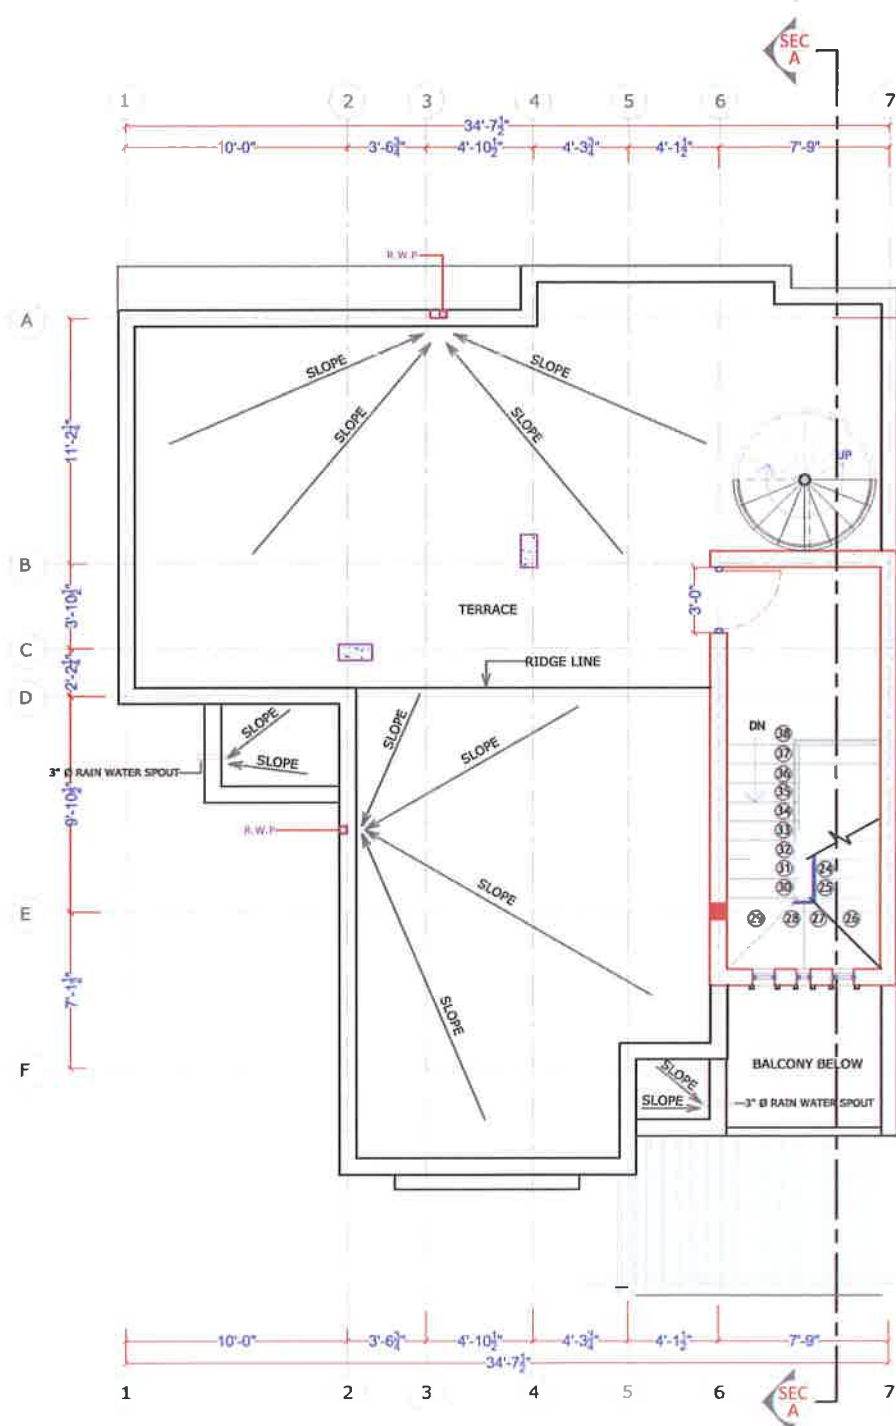

**TERRACE PLAN
AT MUMTY LVL.**

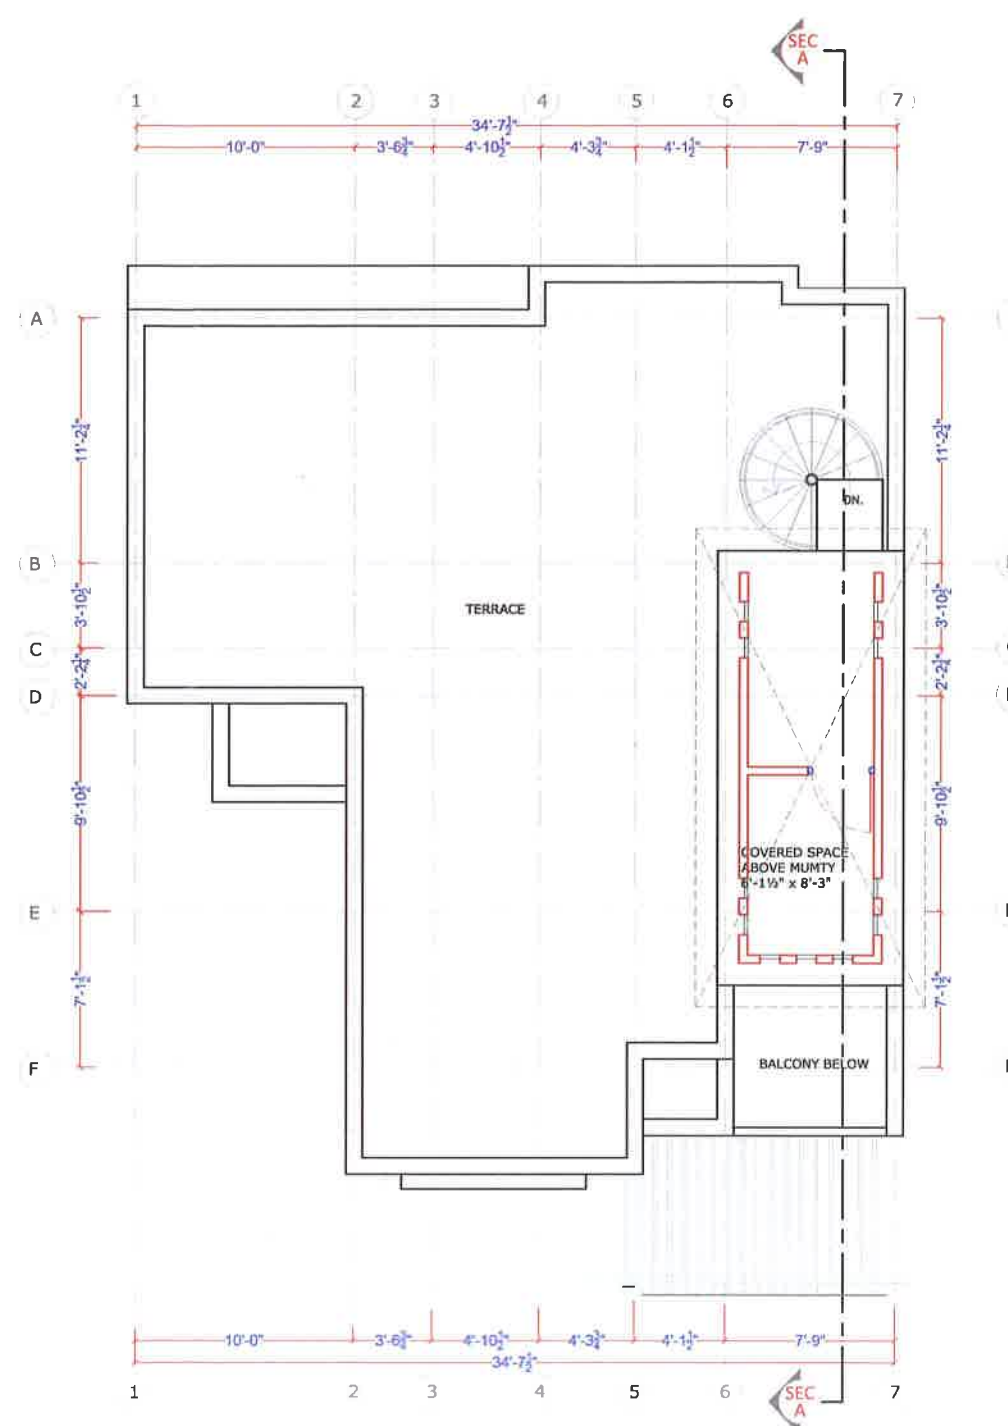

PLAN ABOVE MUMTY LVL.

Project:
**PROPOSED HOUSING SCHEME FOR
CASA 9
AT MANSAROVER, JAIPUR.**

**SANITARY LAYOUT
OF EAST FACING CORNER PLOTS
(35'-0\"/>**

SCALE: NOT TO SCALE
DATE: 12 DEC. 2013

CAD.DEV.
VINOD P.T.

Architect:
ANSHUMAN SHARMA

A JP/HSG/C9/EA09 REV. NO. A1

DESIGN INC.


ARCHITECTS INTERIORS TURNKEY PROJECTS

34 BHAGAT VATIKA, RAJ BHAWAN ROAD
CIVIL LINES, JAIPUR - 302006.


p: 0141 2220263, 9983831453

e: designincjaipur@gmail.com

THIS DRAWING IS COPYRIGHT. IT IS THE PROPERTY OF THE ARCHITECTS AND IS NOT TO BE REPRODUCED, COPIED, HANDED OVER TO A THIRD PARTY OR USED FOR ANY PURPOSE OTHER THAN THAT FOR WHICH IT HAS BEEN LOANED.

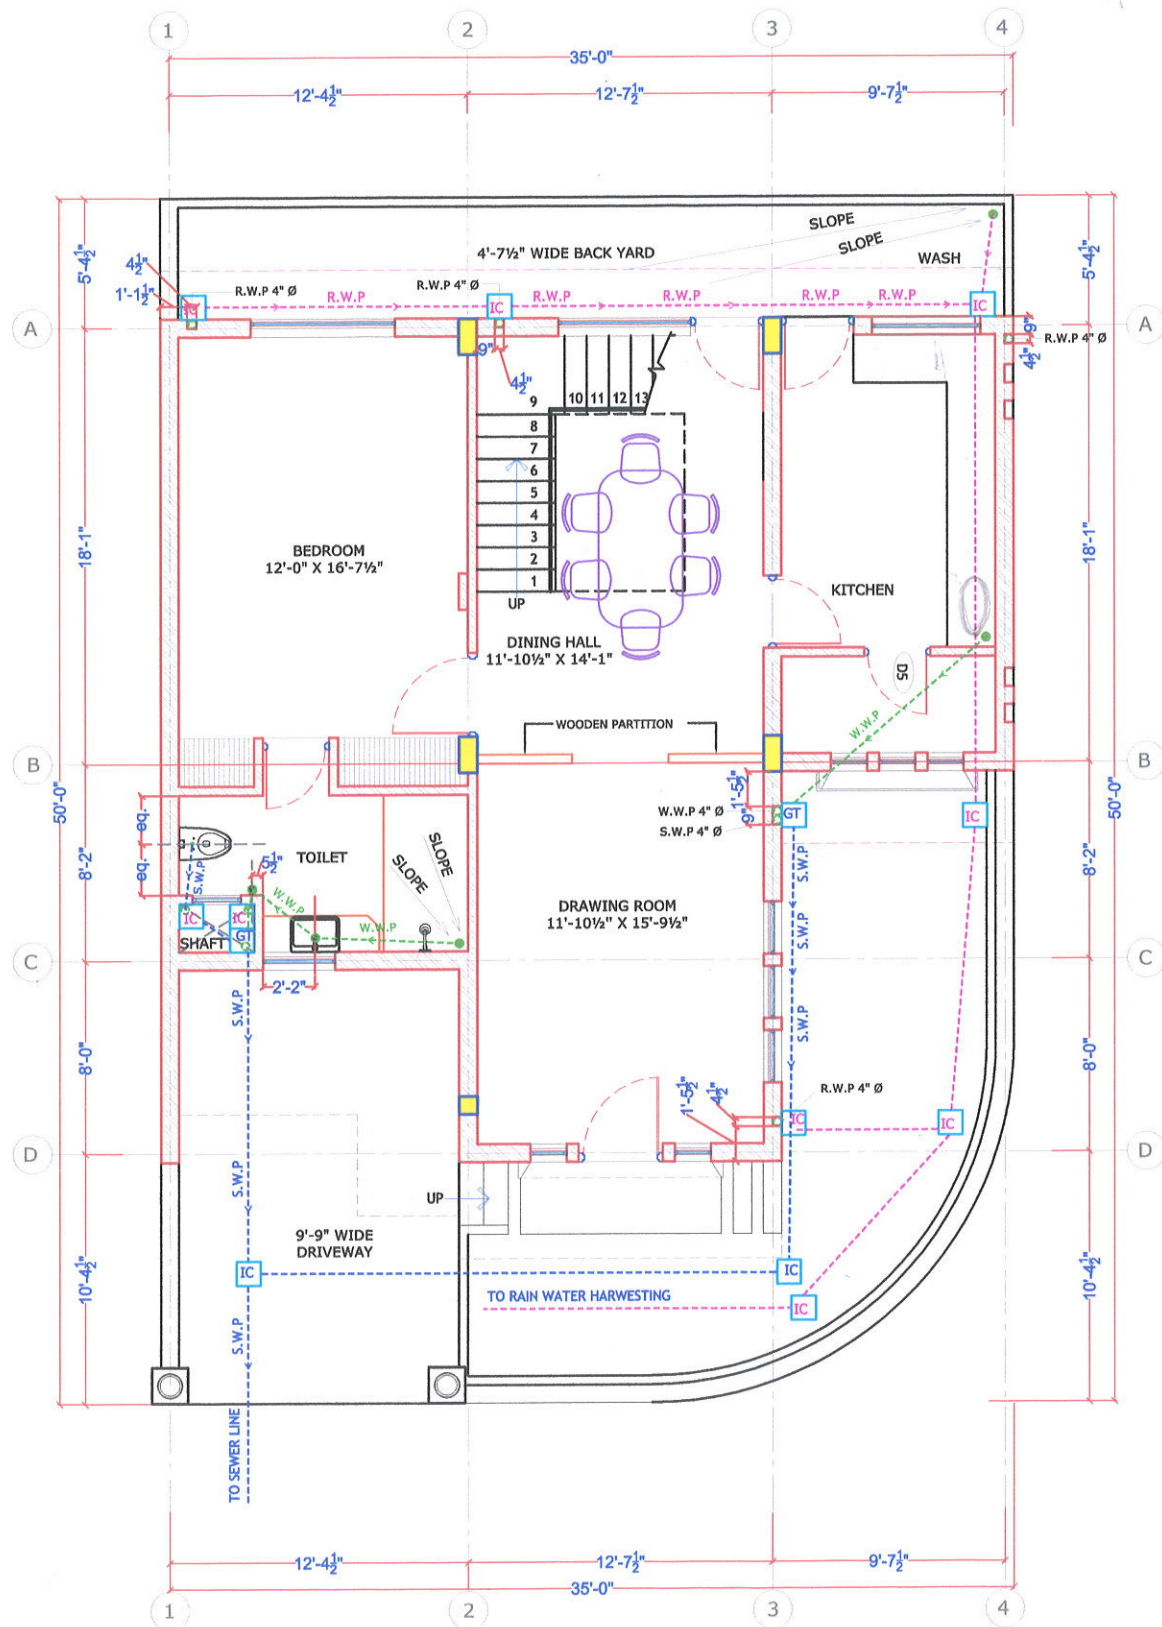

GROUND FLOOR PLAN

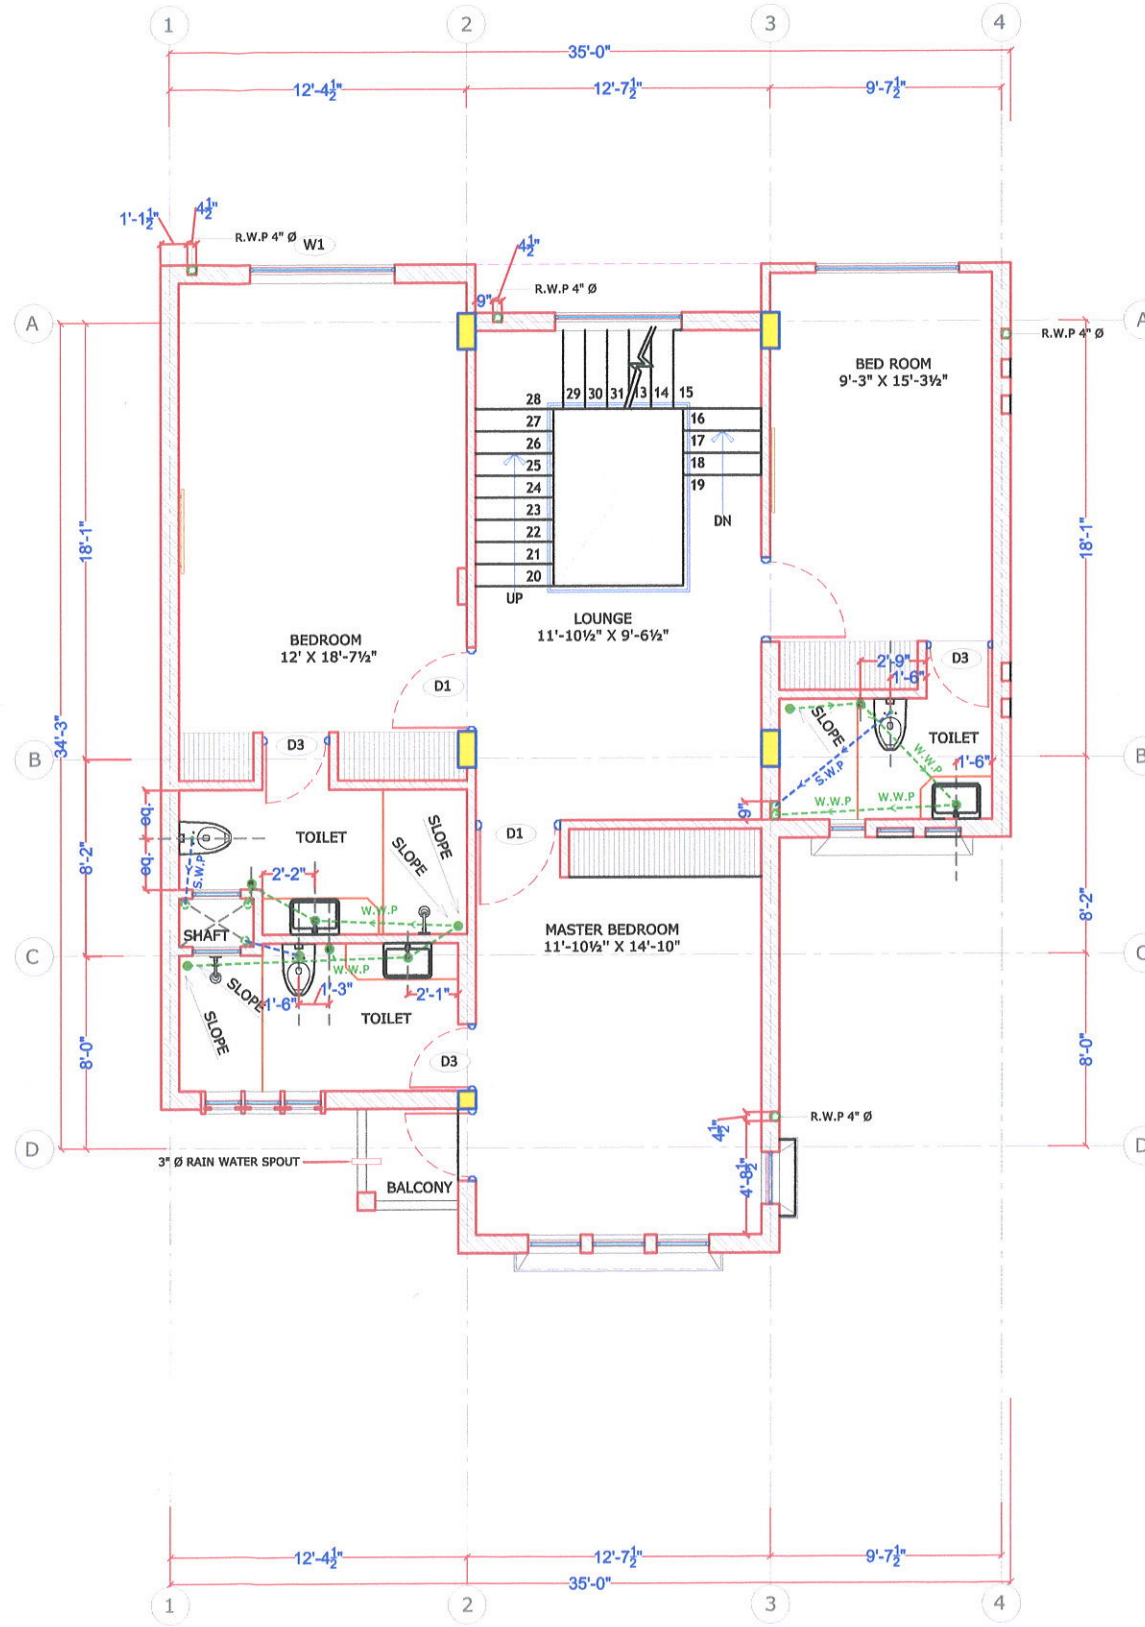

FIRST FLOOR PLAN

REVISIONS :

S. NO.	DESCRIPTION	DATE

LEGENDS:

ID	DESCRIPTION	SYMBOL
RWP	RAIN WATER PIPE	---
WWP	WASTE WATER PIPE	---
SWP	SOIL WATER PIPE	---
GT	GULLY TRAP	GT
IC	INSPECTION CHAMBER	IC

Project:

PROPOSED HOUSING SCHEME FOR
CASA 9
AT MANSAROVER, JAIPUR.

SANITARY LAY OUT
OF WEST FACING CORNER PLOTS
(35'-0"X50'-0")

SCALE
NOT TO SCALE
DATE
SEP. 2014

CAD.DEV.

VINOD P.T

Architect:

ANSHUMAN SHARMA



DRG.NO

JP/HSG/C9/WE/05

REV.NO
A1


DESIGN INC.

ARCHITECTS INTERIORS TURNKEY PROJECTS


34 BHAGAT VATIKA, RAJ BHAWAN ROAD
CIVIL LINES, JAIPUR - 302006.

p: 0141 2220263, 9983831453
e: designincjaipur@gmail.com

THIS DRAWING IS COPYRIGHT. IT IS THE PROPERTY OF THE ARCHITECTS AND IS NOT TO BE REPRODUCED, COPIED, HANDED OVER TO A THIRD PARTY OR USED FOR ANY PURPOSE OTHER THAN THAT FOR WHICH IT HAS BEEN LOANED.

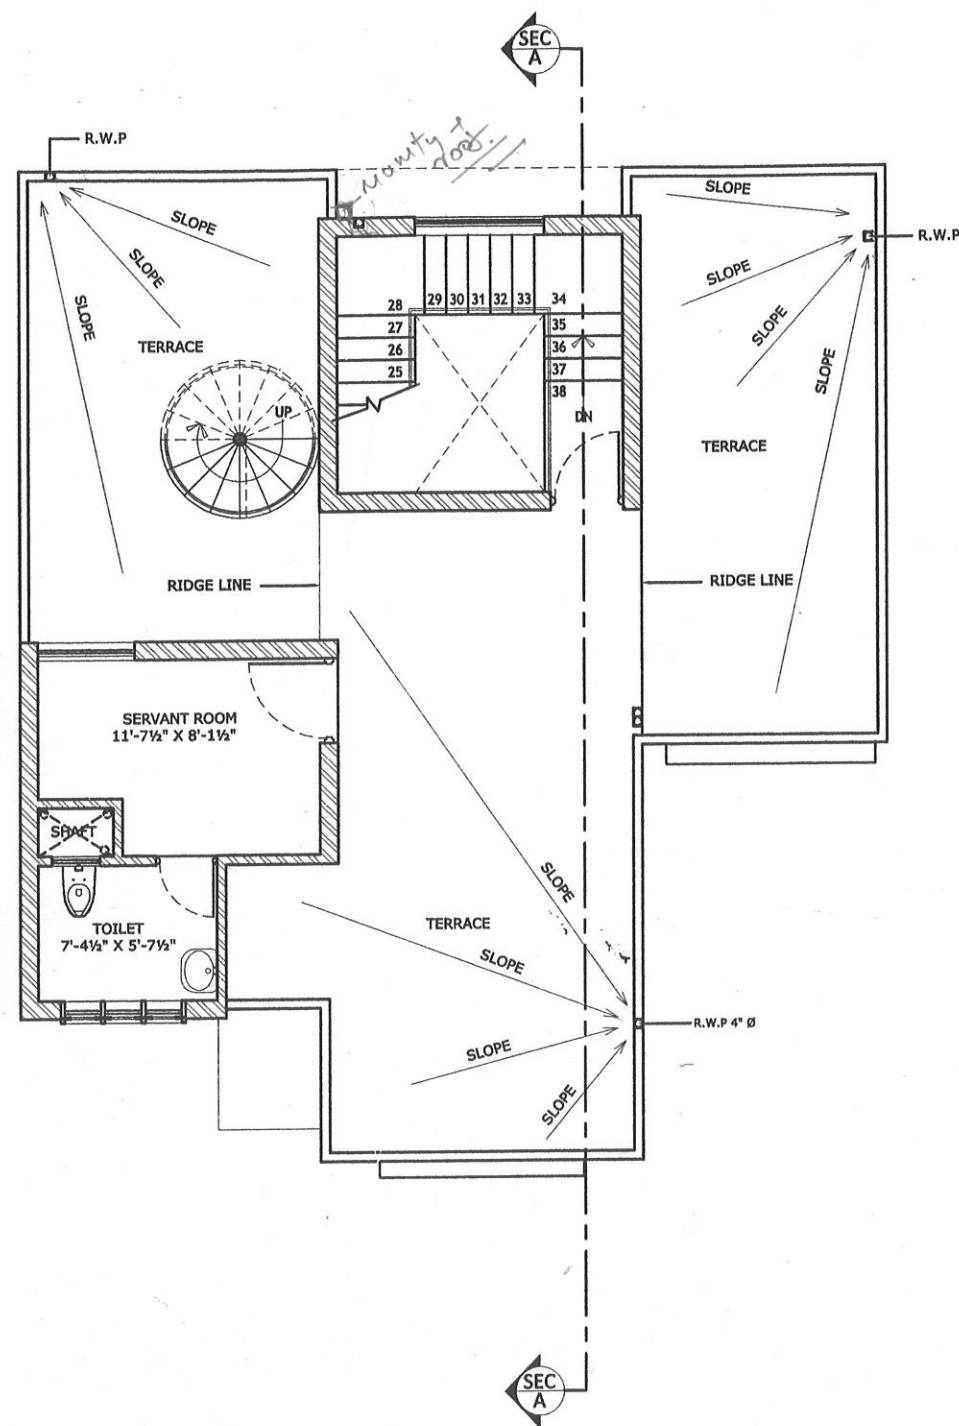

TERRACE PLAN AT
MUMTY LEVEL.

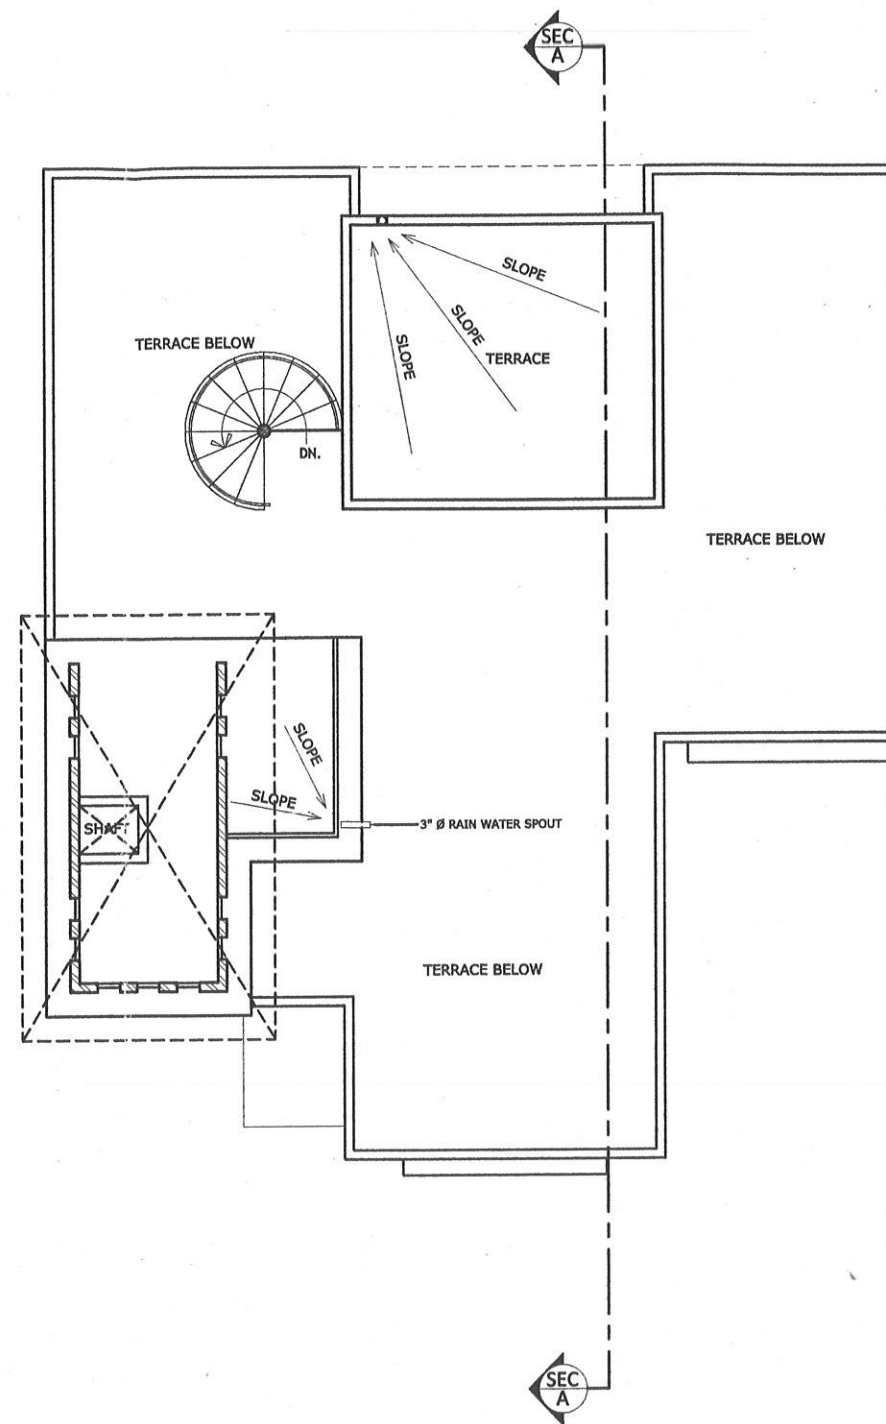

PLAN ABOVE MUMTY LEVEL.

REVISIONS :

S. NO.	DESCRIPTION	DATE

Project:

PROPOSED HOUSING SCHEME FOR
CASA 9
AT MANSAROVER, JAIPUR.

SANITARY LAY OUT
OF WEST FACING CORNER PLOTS
(35'-0"X50'-0")

SCALE
NOT TO SCALE
DATE
SEP. 2014

CAD.DEV.

VINOD P.T

Architect:

ANSHUMAN SHARMA



DWG. NO

JP/HSG/C9/A01

REV. NO
A1


DESIGN INC.

ARCHITECTS INTERIORS TURNKEY PROJECTS


34 BHAGAT VATIKA, RAJ BHAWAN ROAD
CIVIL LINES, JAIPUR - 302006.

p: 0141 2220263, 9983831453
e: designincjaipur@gmail.com

THIS DRAWING IS COPYRIGHT. IT IS THE PROPERTY OF THE ARCHITECTS AND IS NOT
TO BE REPRODUCED, COPIED, HANDED OVER TO A THIRD PARTY OR USED FOR ANY
PURPOSE OTHER THAN THAT FOR WHICH IT HAS BEEN LOANED.

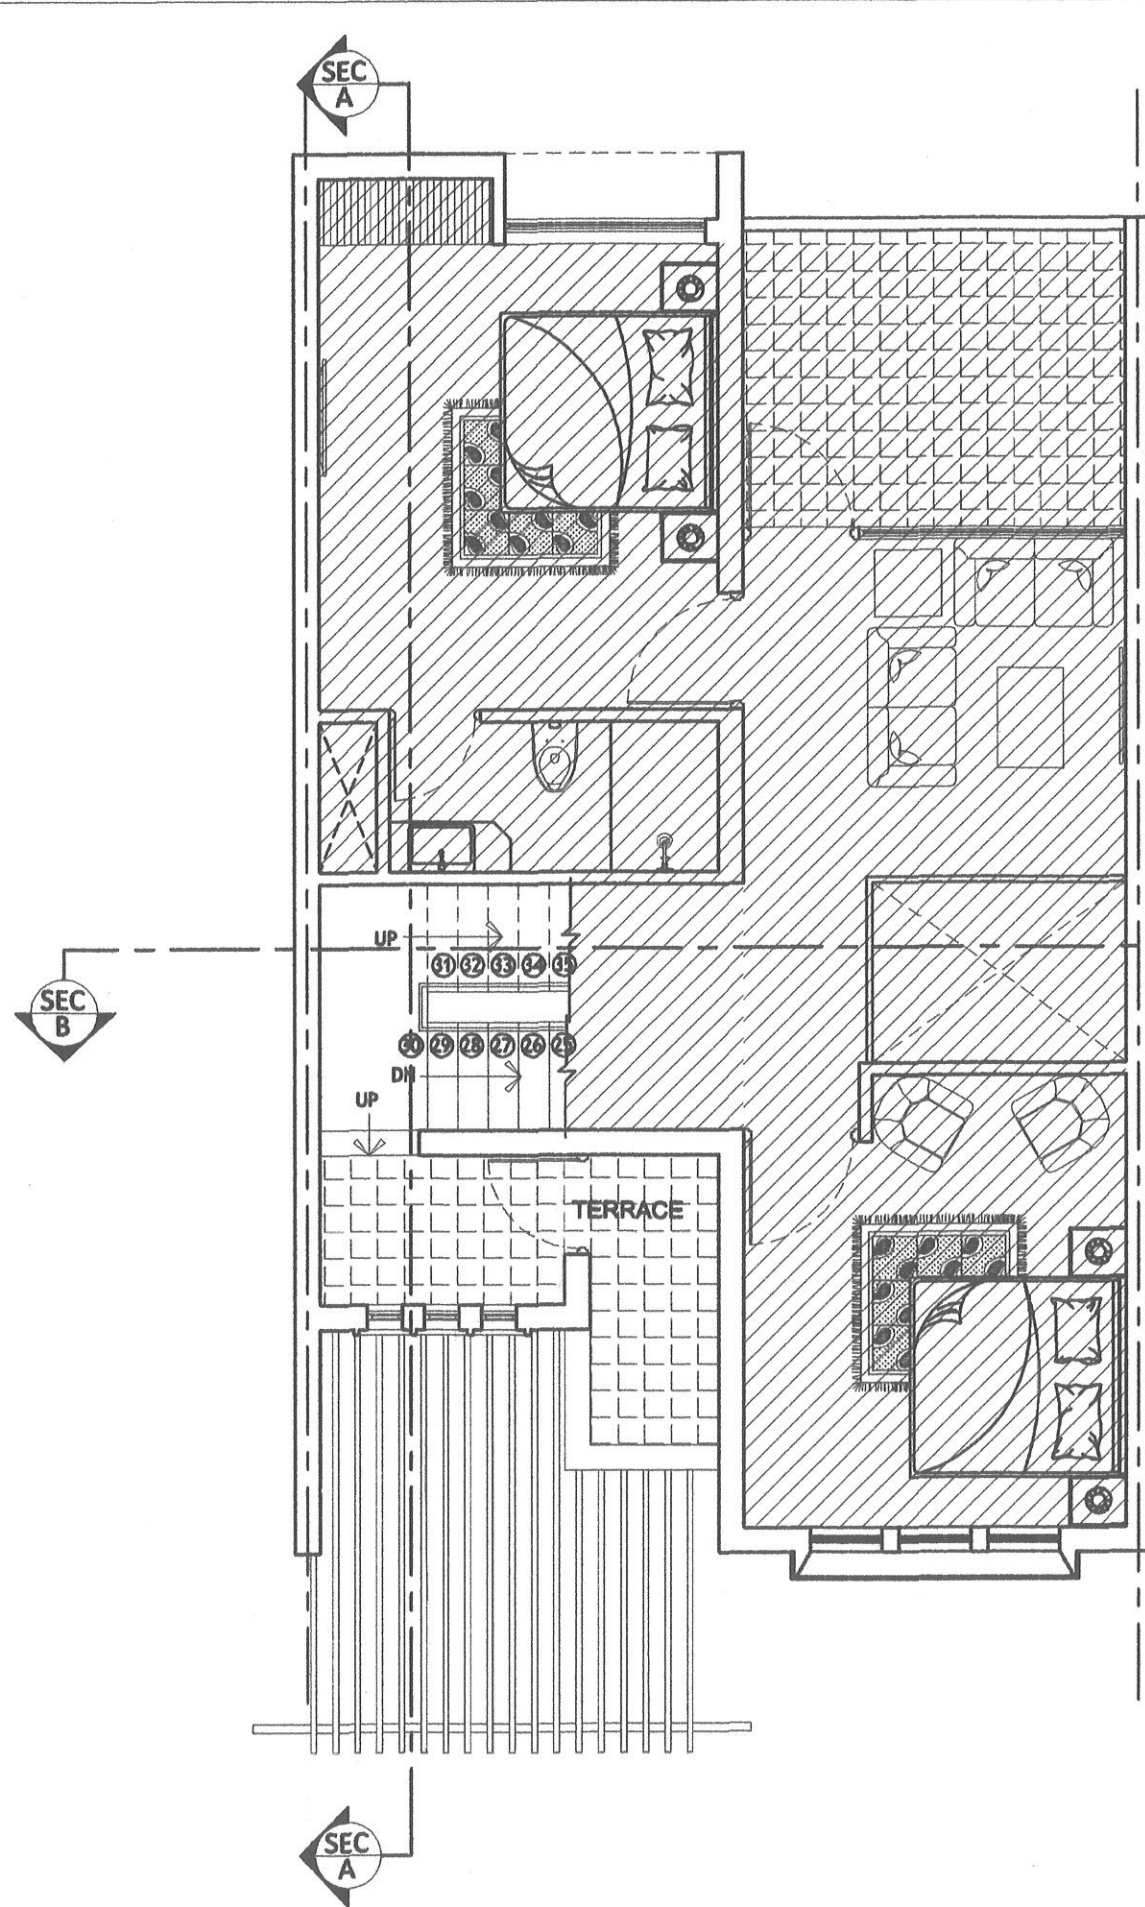

**FIRST FLOOR PLAN
AT LINTEL LEVEL**

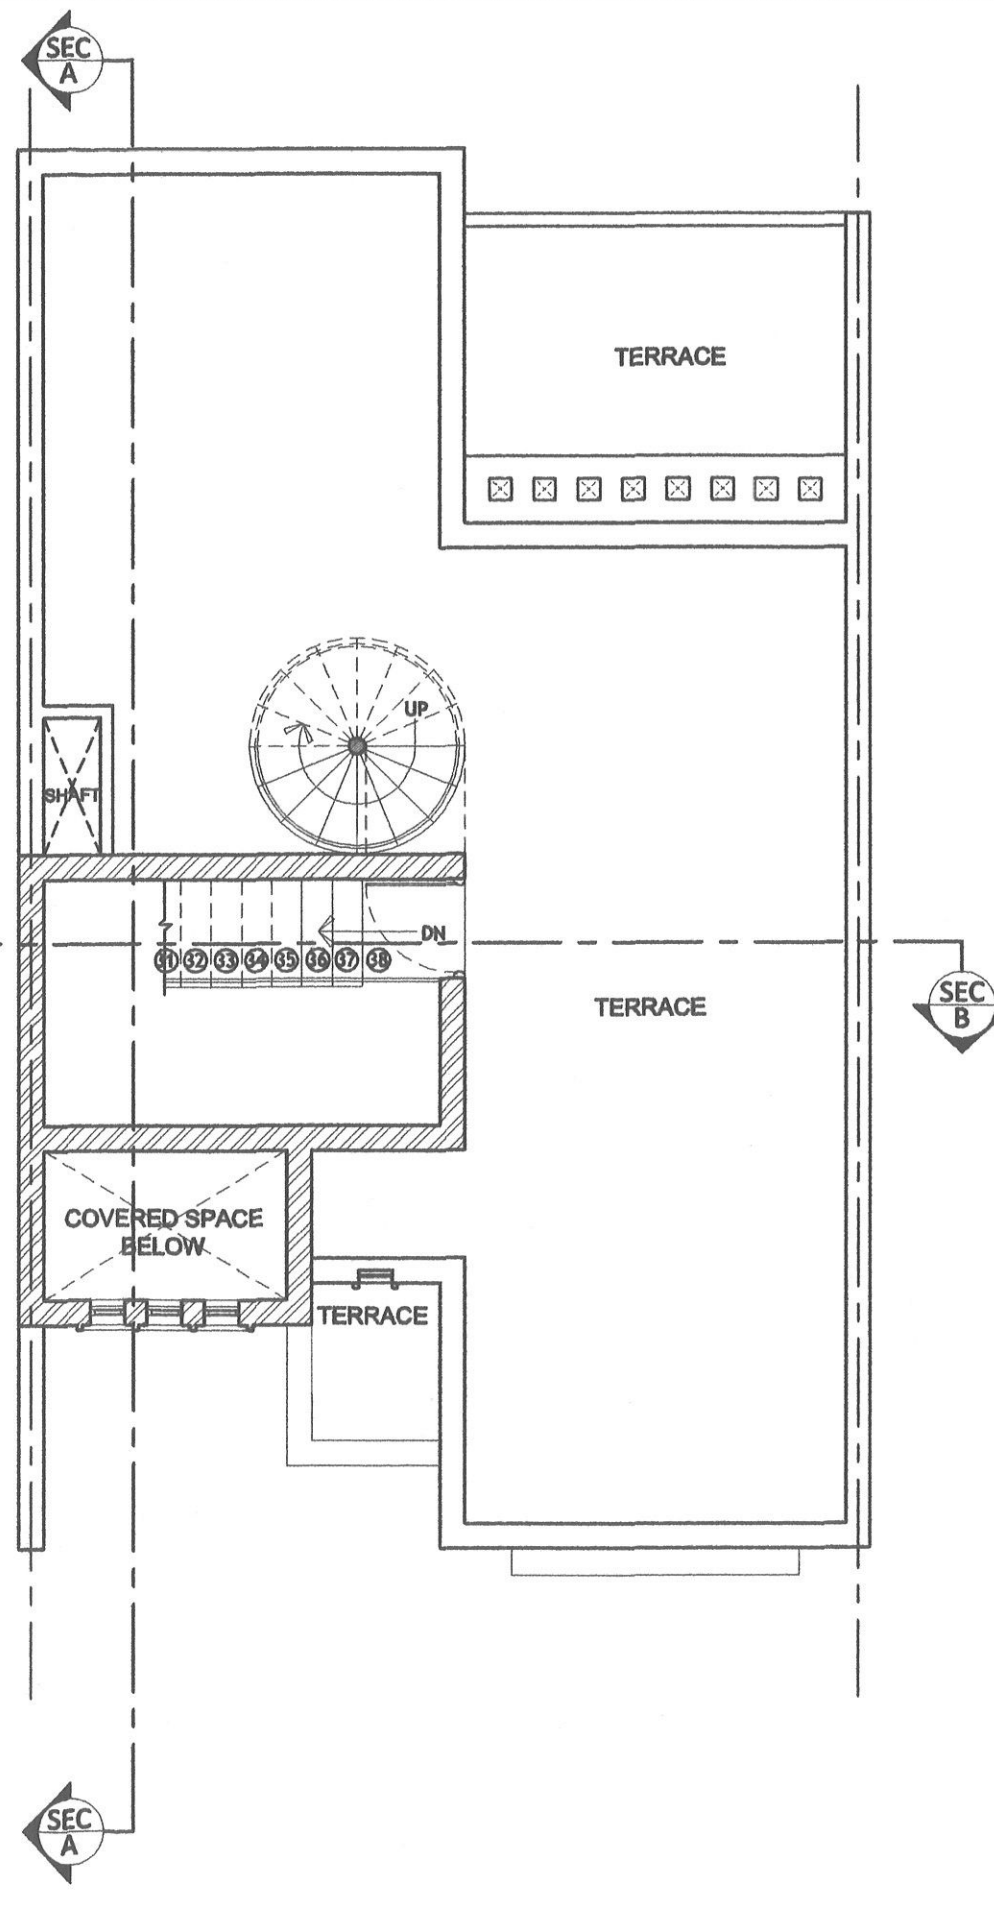

**TERRACE PLAN
AT MUMTY LVL.**

Project:
**PROPOSED HOUSING SCHEME FOR
CASA 9
AT MANSAROVER, JAIPUR.**

**TYPICAL LAYOUT PLAN
OF WEST FACING PLOTS
(25'-0"X50'-0")**

SCALE: NOT TO SCALE
DATE: 03/10/13
BY: ANSHUMAN SHARMA

CAD.DRV: MAHESH CHOUDHARY Architect: ANSHUMAN SHARMA


DESIGN INC. JP/HSG/C9/WE02 A1

ARCHITECTS INTERIORS TURNKEY PROJECTS


34 BHAGAT VATIKA, RAJ BHAWAN ROAD
CIVIL LINES, JAIPUR - 302006.

p: 0141 2220263, 9983831453
e: designincjaipur@gmail.com

THIS DRAWING IS COPYRIGHT, IT IS THE PROPERTY OF THE ARCHITECTS AND IS NOT TO BE REPRODUCED, COPIED, HANDED OVER TO A THIRD PARTY OR USED FOR ANY PURPOSE OTHER THAN THAT FOR WHICH IT HAS BEEN LOANED.

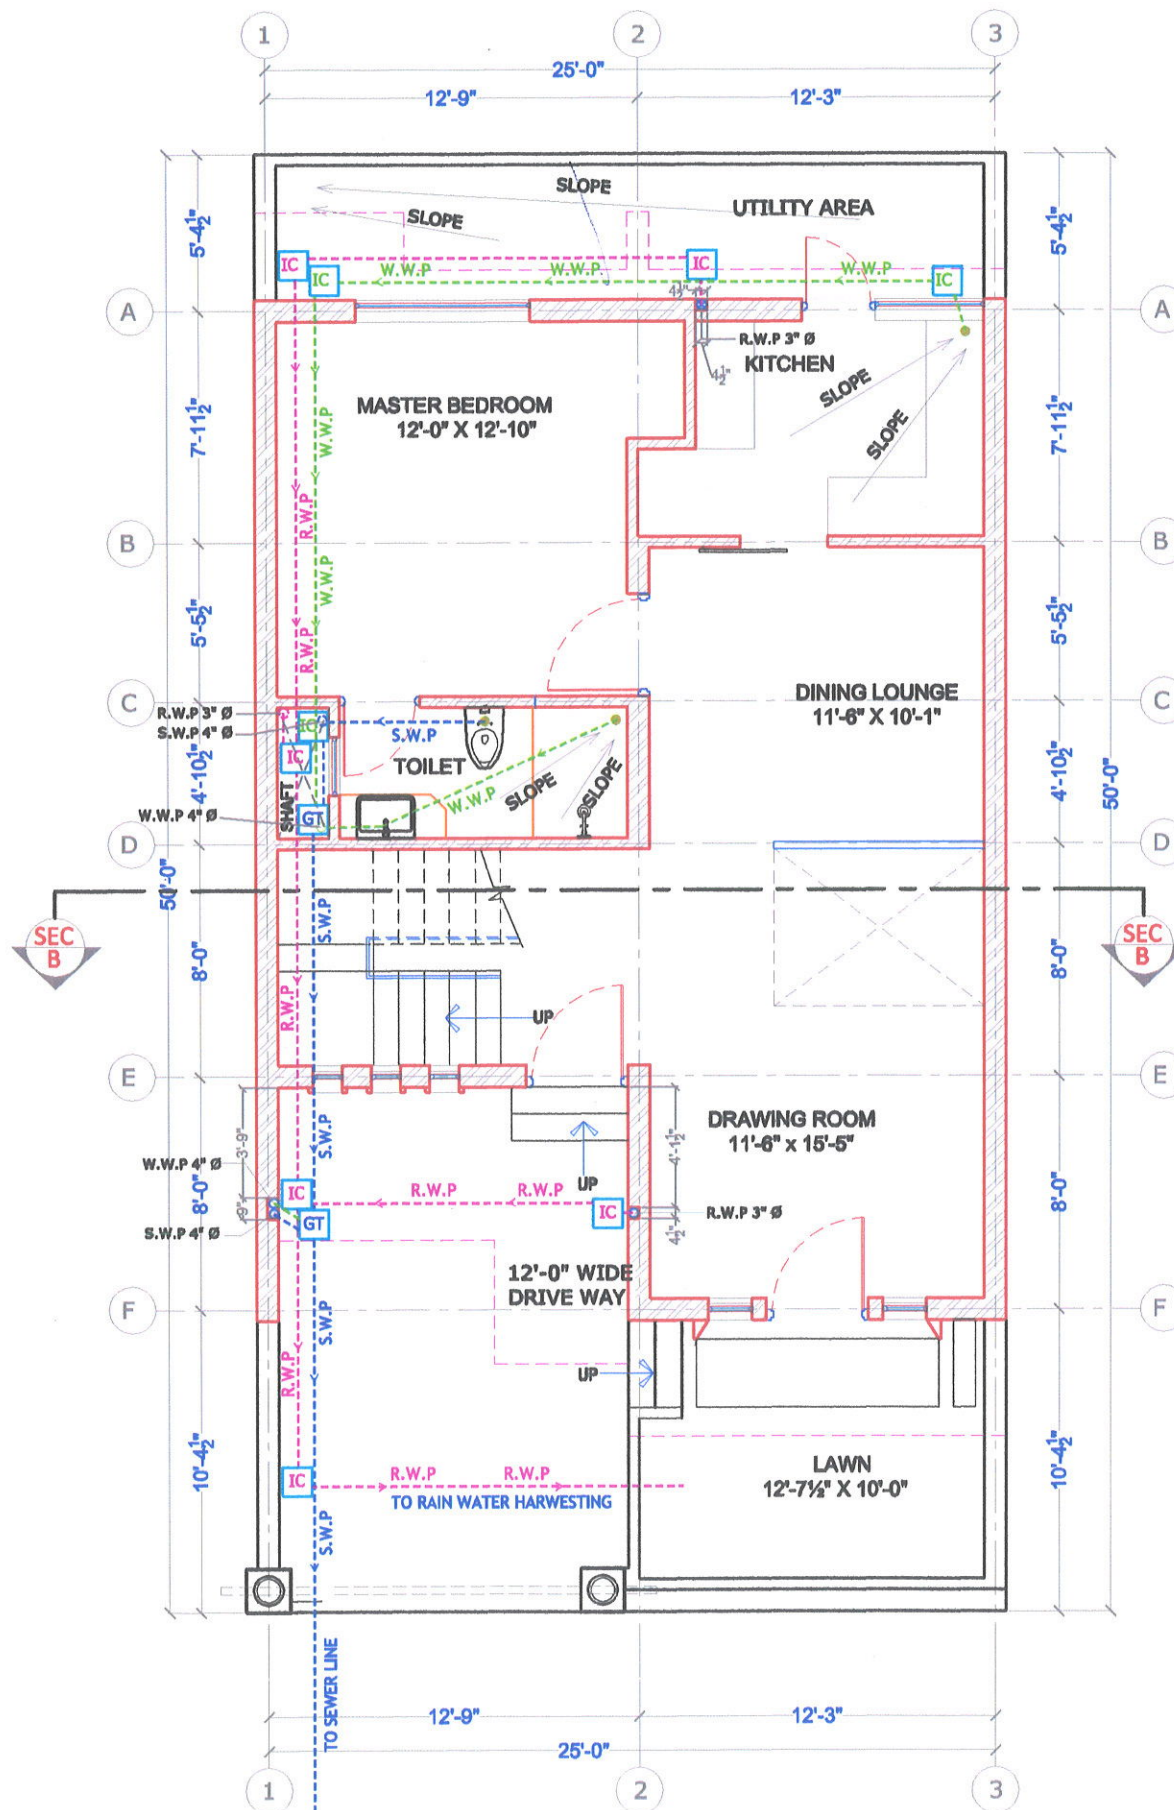

GROUND FLOOR PLAN

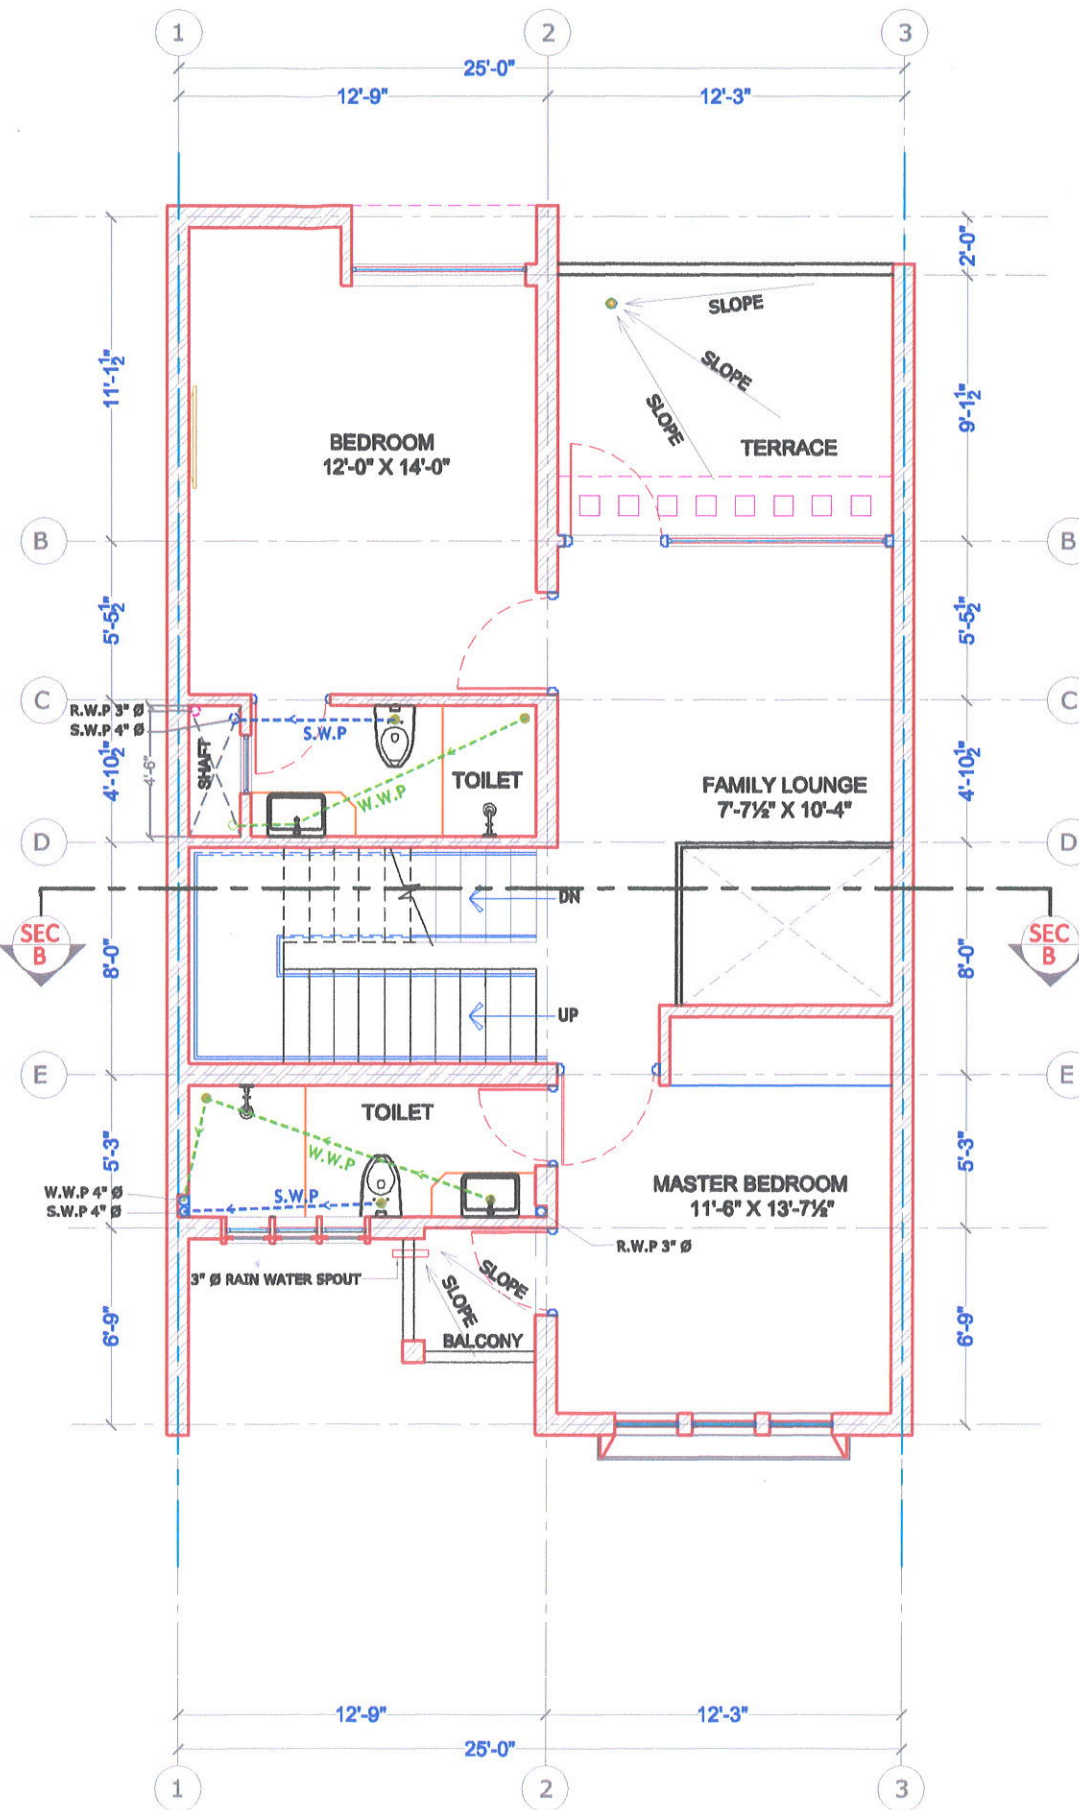

FIRST FLOOR PLAN

LEGENDS:

ID	DESCRIPTION	SYMBOL
RWP	RAIN WATER PIPE	---
WWP	WASTE WATER PIPE	---
SWP	SOIL WATER PIPE	---
GT	GULLY TRAP	GT
IC	INSPECTION CHAMBER	IC

IMPORTANT

ALL PROJECT DRAWINGS ARE PREPARED IN FEET/INCHES, EXCEPT THE DOOR/WINDOW SCHEDULE WHICH IS PREPARED IN MM. SITE ENGINEER TO VERIFY THE SIZE OF OPENINGS AS PER THE DOOR/WINDOW SCHEDULE PROVIDED.

Project:

PROPOSED HOUSING SCHEME FOR
CASA 9
AT MANSAROVER, JAIPUR.

SANITARY LAYOUT
OF WEST FACING PLOTS
(25'-0" X 50'-0")

MAHESH CHOUDHARY ANSHUMAN SHARMA

DESIGN INC. ARCHITECTS INTERIORS TURNKEY PROJECTS

34 BHAGAT VATIKA, RAJ BHAWAN ROAD
CIVIL LINES, JAIPUR - 302006.

p: 0141 2220263, 9983831453
e: designincjalpur@gmail.com

THIS DRAWING IS COPYRIGHT, IT IS THE PROPERTY OF THE ARCHITECTS AND IS NOT TO BE REPRODUCED, COPIED, HANDED OVER TO A THIRD PARTY OR USED FOR ANY PURPOSE OTHER THAN THAT FOR WHICH IT HAS BEEN LOANED.

CONSTRUCTION ISSUE