


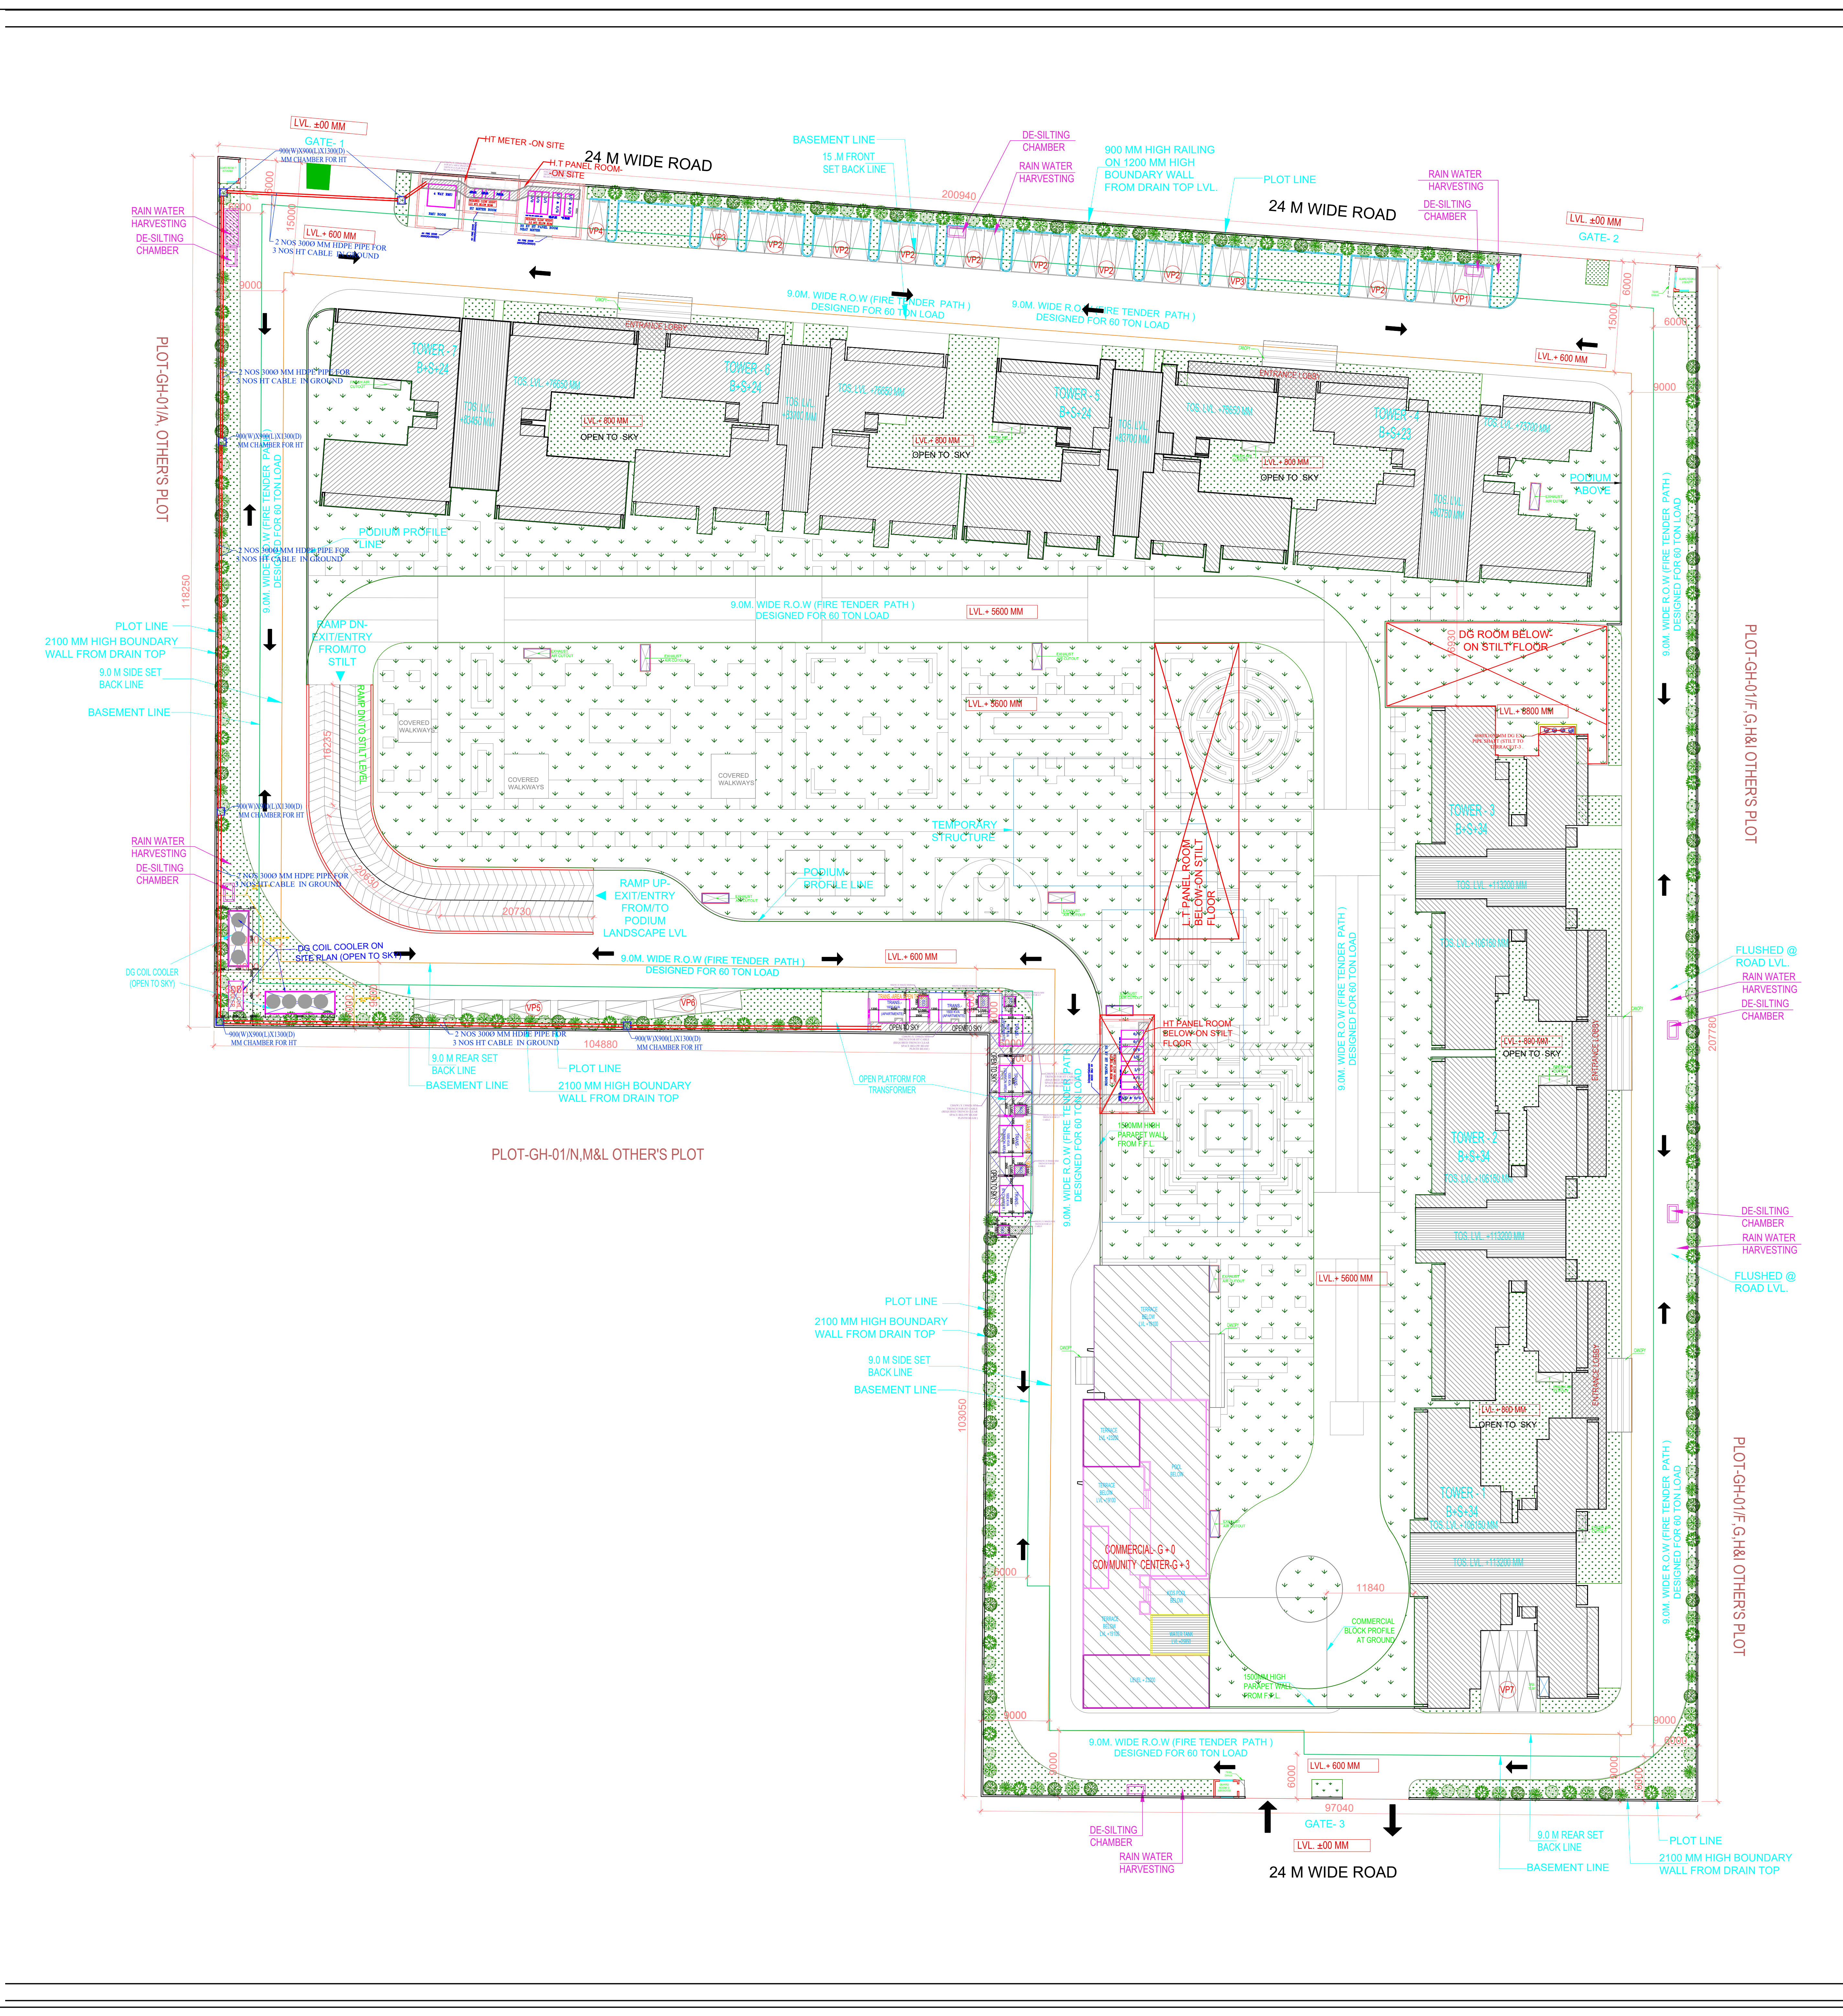

OWNER SIGN		ARCHITECT SIGN	
TOWN PLANNER SIGN			
MEP CONSULTANT DESIGN CENTRE CONSULTING ENGINEERS PVT.LTD OFFICE NO. 44 TO 47, 4TH FLOOR ANSAL PLAZA, DABUR CHOWK VAISHALI, GHAZIABAD, UP PHONE: 0120-4333451,4333452			
OWNER GODREJ PROPERTIES LIMITED			
SUBMISSION DRAWING			
KEY PLAN 			
PROJECT PROPOSED GROUP HOUSING FOR PLOT NO :- GH-01/B,C,D,E,J & K SECTOR -12, GREATER NOIDA, G.B. NAGAR, (U.P.)			
DATE 23 - 01 -2025	PROJECT INCH. BALRAJ SINGH	CHECKED BY BALRAJ SINGH	
SCALE 1:100	DEALT BY ABDRESH JHA	APPROVED BY VISHAL SHARMA	
DRAWING TITLE ELECTRICAL LAYOUT SITE PLAN			
SITE PLAN			
ARCHITECTS GOLDEN INIDA ARCHITECTS THE TEAM OF ARCHITECTS FF-37, KADAMBA SHOPPING COMPLEX GAMMA-IGREATER NOIDA CON. + 91-94-1585-6777			
DESIGN BY: Confluence NEW DELHI , INDIA F-1, FIRST FLOOR, MIRA CORPORATE SUITES, ISHWAR NAGAR, NEW DELHI 110065 Ph. +91-11-26925684 ccs@inconfluence.com Member of IGBC Ph. +91-11-40564768 www.inconfluence.com ISO - 9001 : 2000 architecture urban design hospitality interiors			
DRAWING NO. DCCE/1446/EL-SP-01			REVISION