


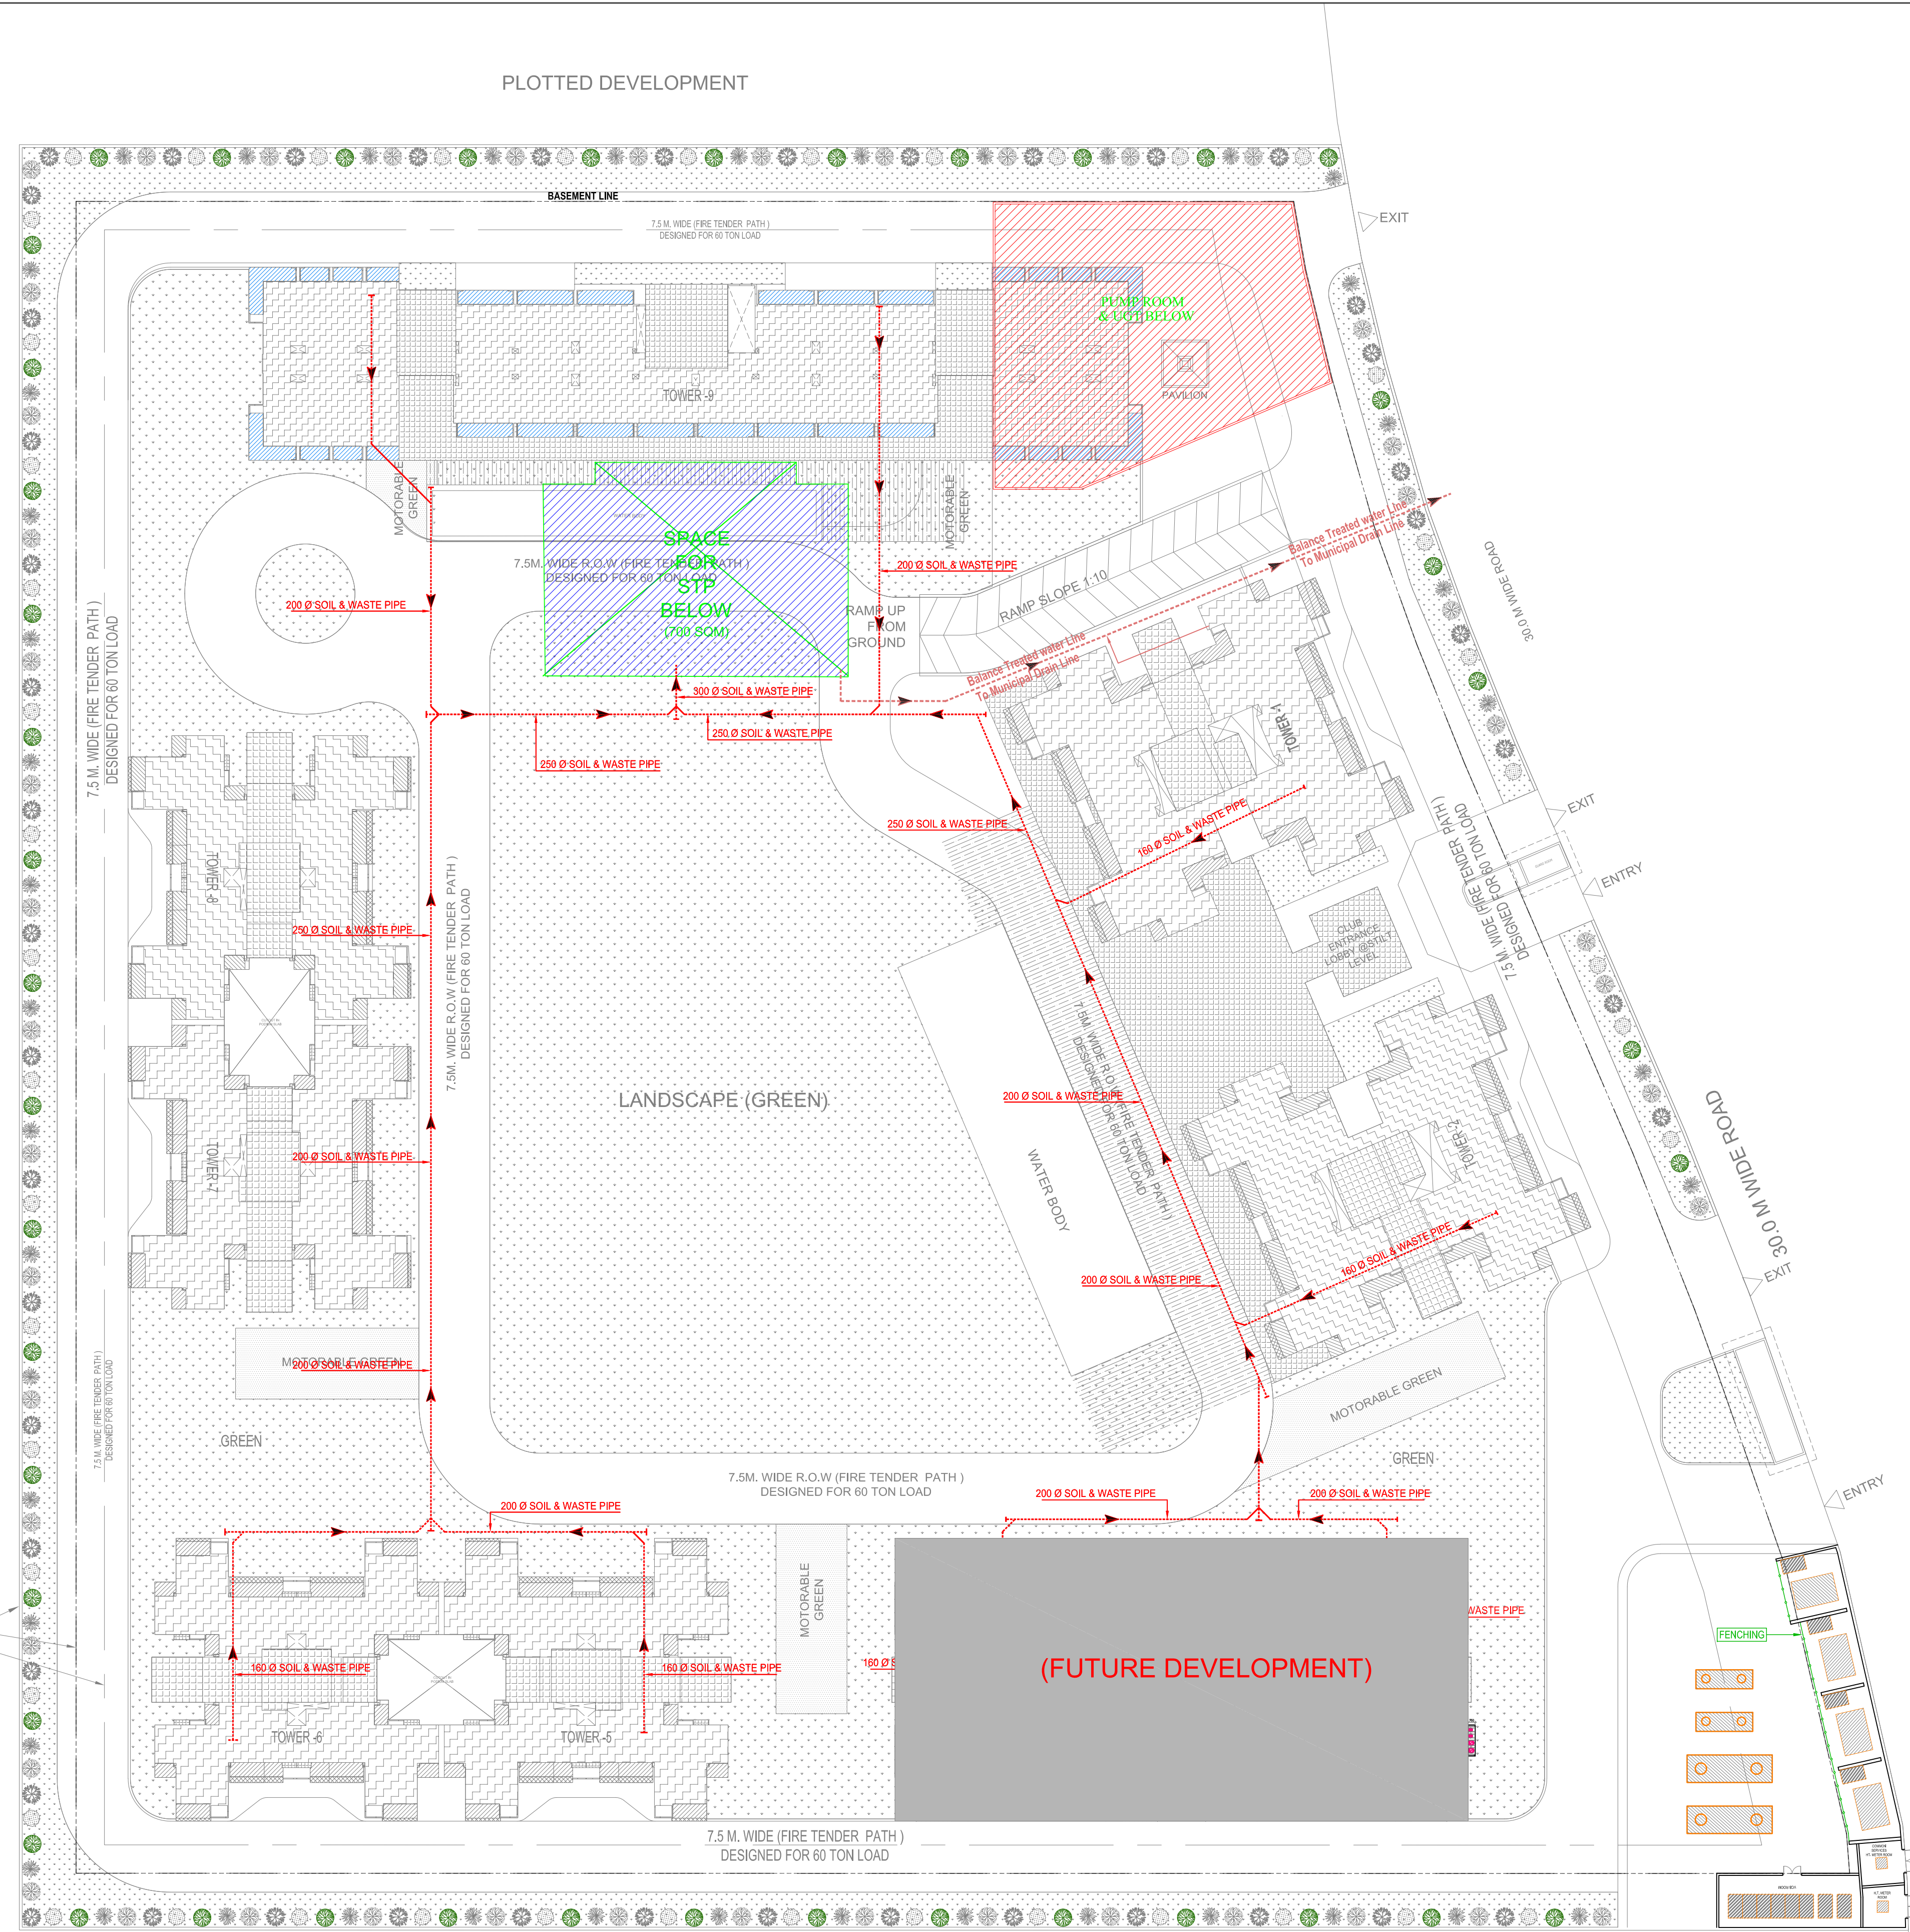


PLOTTED DEVELOPMENT

STILT LEVEL PLAN

PLOTTED DEVELOPMENT

LEGEND :		
S. No.	SYMBOL	DESCRIPTION
1.		SEWER LINE
2.		BYPASS SEWER LINE
3.		BASEMENT LINE

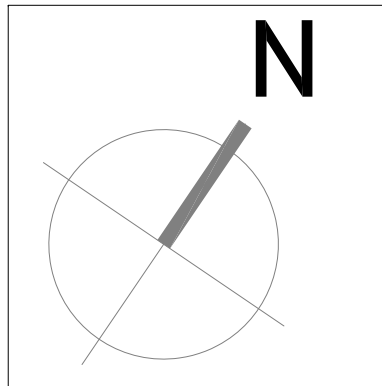

Rev. no.	Date	Revision
..	..	..

Project
PROPOSED GROUP HOUSING AT PLOT NO. GH-01 IN PLOT NO. TS - 01, SECTOR 22-A, YAMUNA EXPRESSWAY, (U.P.) FOR M/S THREE C HOMES PVT. LTD.

Title
SITE PLAN

Subtitle
WASTE DISPOSAL PLAN

Drawing released for
☐ APPROVAL ☒ SUBMISSION
☐ ADVANCE COPY ☐ CONSTRUCTION

Drg. no. EX / S-01 Drawn by Kulwant

Scale 1 : 400 Designed by R.K.

Date Nov. 2024 Checked by Anand Havelia

OWNER
M/S THREE C HOMES PVT. LTD.

Architects
Confluence
NEW DELHI, INDIA
F-1, FIRST FLOOR, MIRA CORPORATE SUITES,
ISHWAR NAGAR, NEW DELHI 110065
Ph: +91-11-26935684 cca@inconfluence.com Member of IGBC
Ph: +91-11-40564768 www.inconfluence.com ISO - 9001 : 2000
architecture urban design hospitality interiors

Services Consultant
Cespl Consultants Pvt. Ltd.
B - 67, Sector - 67, Noida - 201 301
Tel : (0120) 3225400 / 3225401
e mail : mail@cespl.in, website : www.cespl.in



THREE C HOMES PVT. LTD.
Ratna
Authorised Signatory