


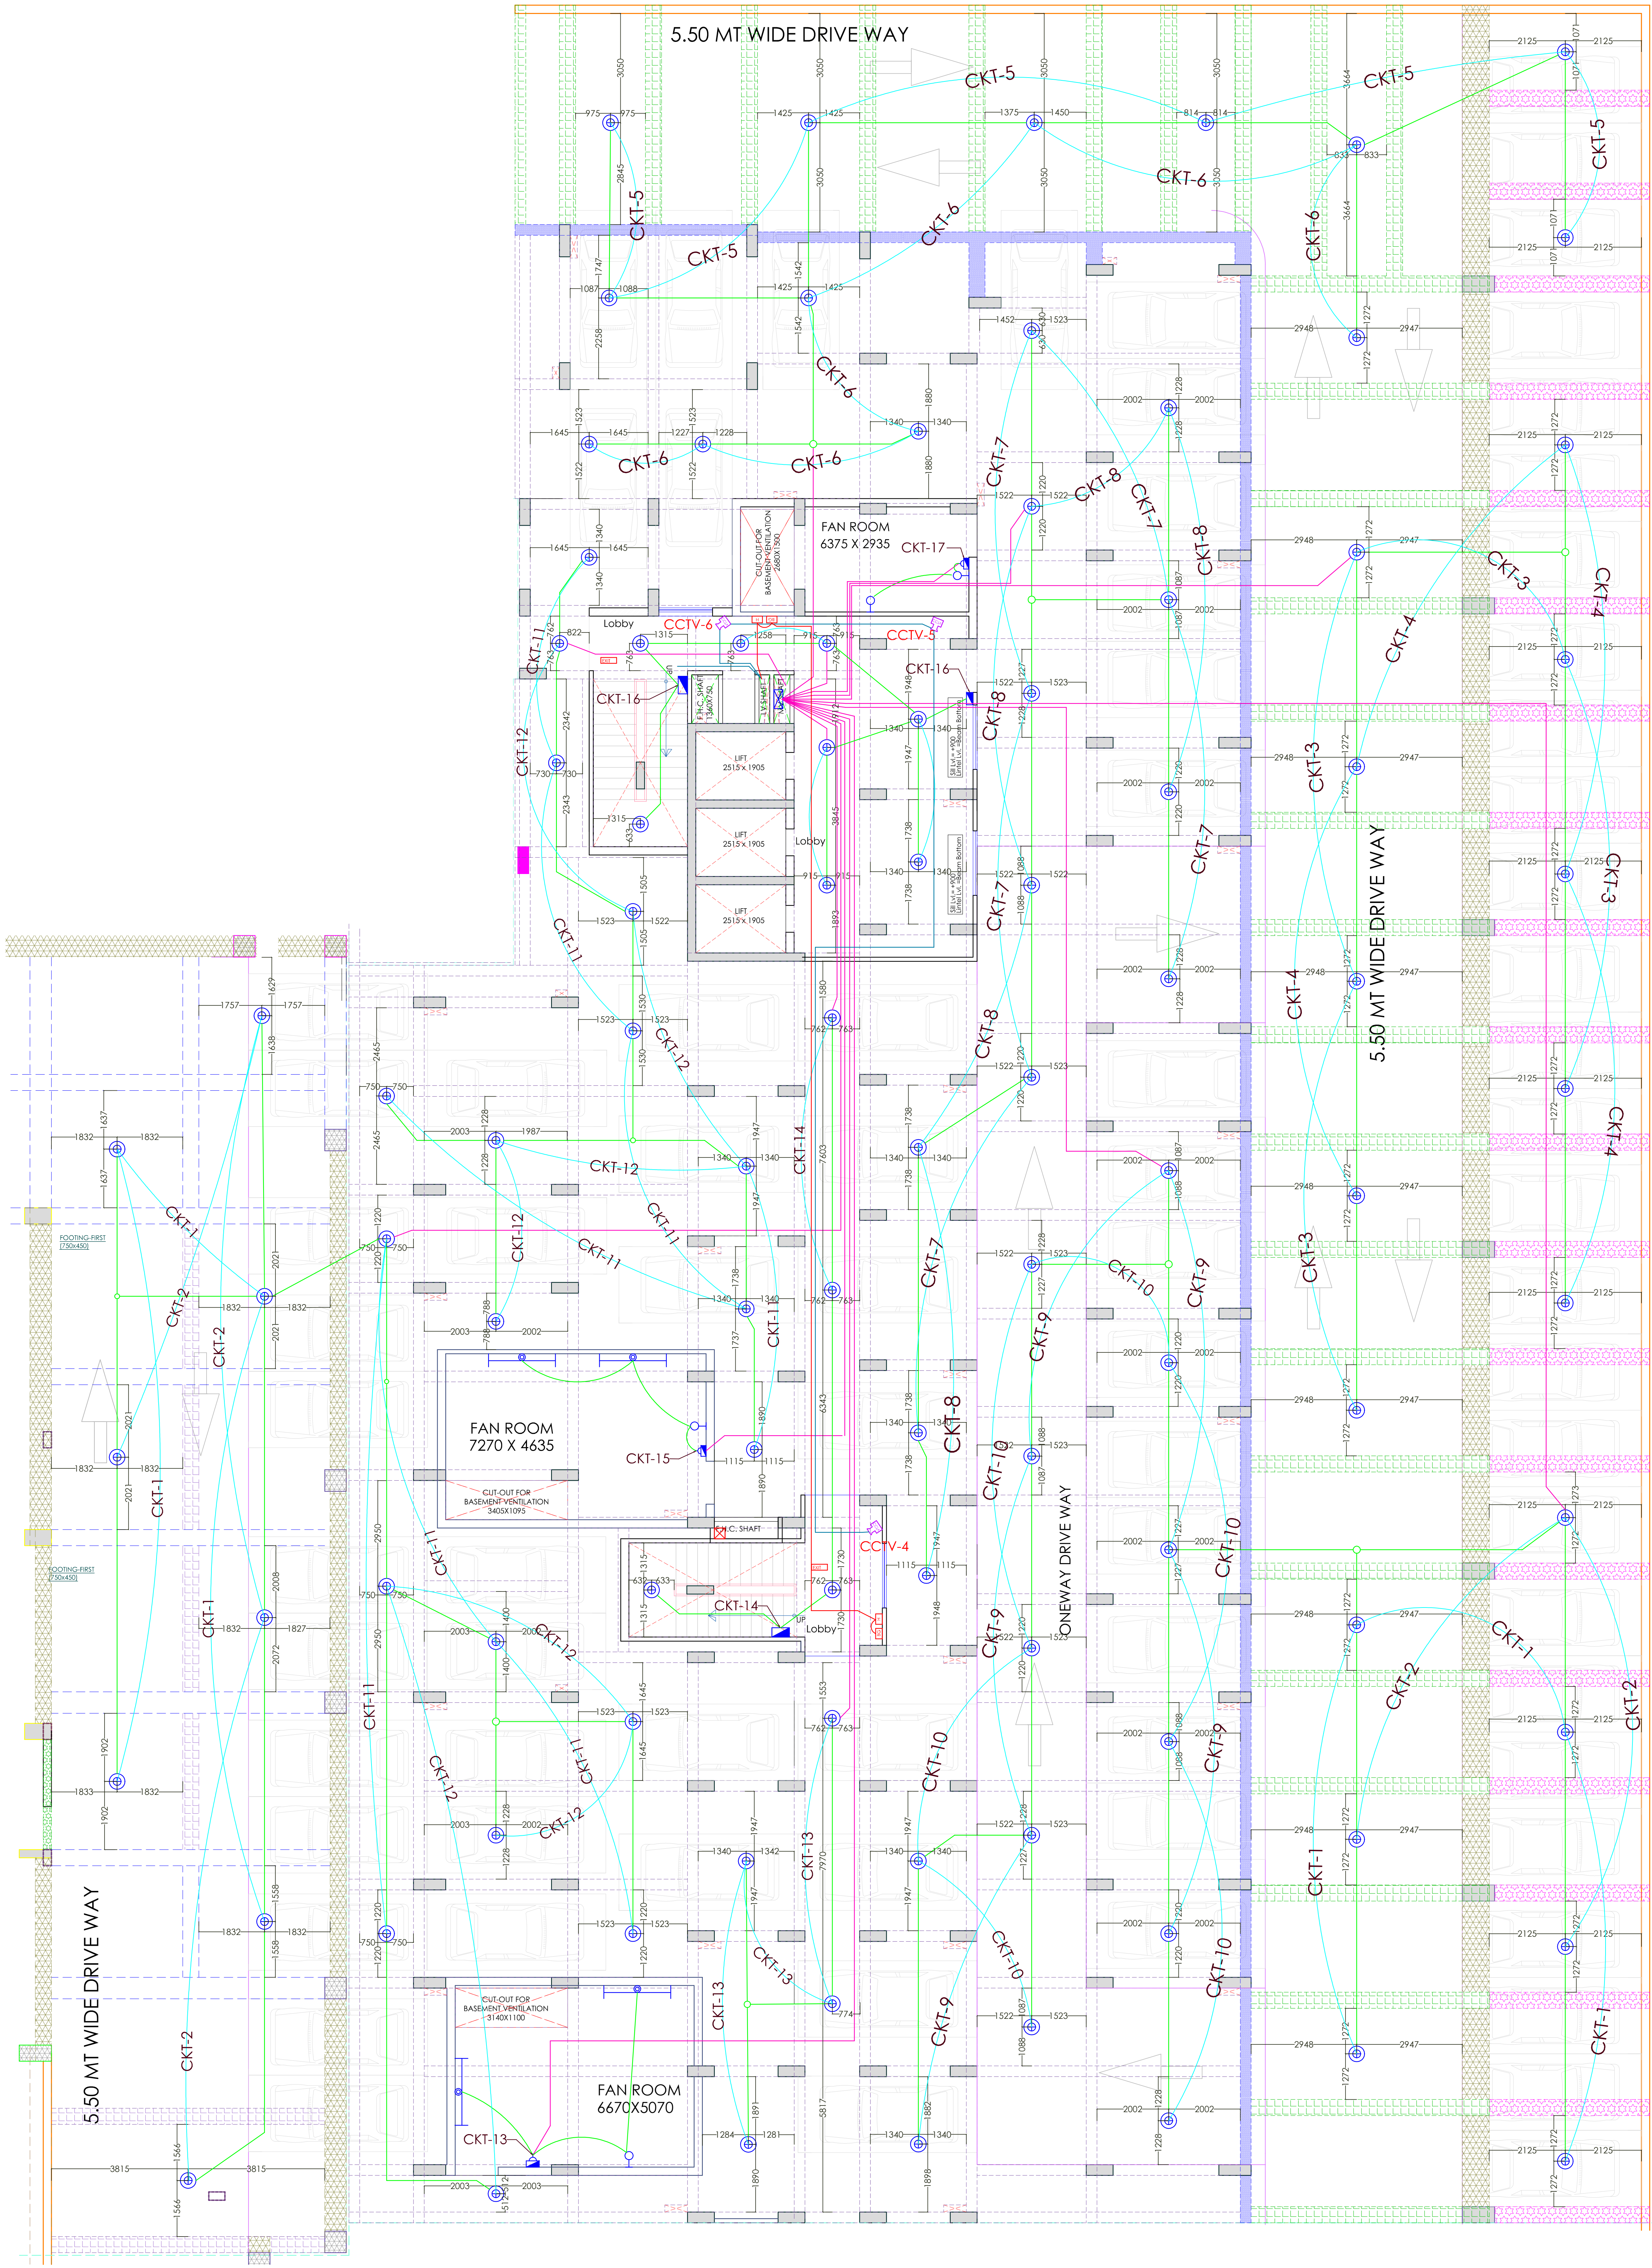

PROJECT TITLE

PROPOSED
GROUP HOUSING
AT
SUKHIYA,JAIPUR

LEGEND			
NO	DESCRIPTION	SYMBOL	FROM PFL
1.	CEILING FAN		CEILING
2.	EXHAUST		6'-0"
3.	WALL FAN POINT		6'-0"
4.	A.C POINTS (SPLIT AC)		AS PER SITE
5.	A.C SOCKET		AS PER SITE
6.	18 AMP POWER PLUG POINT (GENERAL)		1'-0"
7.	GYSER SOCKET 16 AMP		6'-0"
8.	18 AMP POWER PLUG POINT (KITCHEN)		12' 0" KITCHEN SLAB
9.	16 AMP SOCKET		AS PER SITE
10.	6 AMP PLUG POINT (BED SIDE)		2'-6"
11.	6 AMP SOCKET (CHIMNEY)		7'-0"
12.	6 AMP SOCKET		AS PER SITE
13.	2 NOS 4 AMP POWER PLUG POINT (FOR TV)		1'-6" 4" 6"
14.	2 NOS 6 AMP SOCKET		1'-6" 4" 6"
15.	INVERTOR SOCKET		1'-6"
16.	SWITCH BOARD WITH 4 AMP POINT		4'-0"
17.	SWITCH BOARD WITH 6 AMP POINT		4'-0"
18.	BELL PULL		4'-0"
19.	GYSER SWITCH 16 AMP		4'-0"
20.	TELEPHONE POINT (BED SIDE)		2'-6"
21.	TELEPHONE POINT (GENERAL)		1'-0"
22.	TV POINT (GENERAL)		2'-6"
23.	CEILING LIGHT		CEILING
24.	40W TUBE LIGHT ON CEILING		CEILING
25.	BULB HOLDER ON SIDE WALL		7'-3"
26.	TUBE LIGHT ON WALL		7'-3"
27.	DISTRIBUTION BOX		5'-0"
28.	BELL		7'-3"
29.	CONDUIT CIRCUIT (25MM)		CEILING
30.	CONDUIT POINT WIRING (25MM)		CEILING
31.	CONDUIT SUB MAIN WIRING (25MM)		CEILING

LEGEND			
NO	DESCRIPTION	SYMBOL	
1.	MANUAL CALL POINT		02- NOS
2.	HOTTER		02- NOS
3.	25MM MS CONDUIT		02- NOS
4.	SELF LUMINOUS GLOW SKIN BOARD		02- NOS
5.	FIRE PANEL		NIL
6.	CCTV		03- NOS
7.	25MM MS CONDUIT CCTV		

REVISION:		
MARK	DATE	DESCRIPTION
R-01	04-05-15	EXTENDED BASEMENT ROOF LVL. CHANGED

1. All dimensions are to be verified on site by the contractor. Any discrepancies are to be reported to the Client and Architects immediately.
2. This drawing is to be read in conjunction with other relevant Structural and Services Details
3. Drawings not showing the latest revisions are to be canceled.
4. All dimensions are to be read and not scaled.
5. All dimensions and levels are in mm unless specified otherwise.
6. The drawing and design is the property of RICKY MATHUR AND ASSOCIATES. No portion may be used or reproduced without their written permission.

VIPUL AGARWAL
M.E.P. CONSULTANT
B.E. ELECTRICAL

MEP CONSULTANT :

ASHI ASSOCIATES,
F 9 / 440 , Keshav Marg Chitrakut
Scheme,Jaipur
PH:91-0-93146-10438 ,0141-2440946
Mail:vipul8599@yahoo.com


ARCHITECT

Ricky Mathur & Associates
architects interior designers planners
33, Dhuleshwar Garden,
Jaipur, (RAJ.) India. 302 001
Tel: 91-141-236 2688, 512 5444
Fax: 91-141-400 8700
e-mail: ricky@rickymathur.com

DRAWING TITLE

BASEMENT FLOOR ELECTRICAL
PLAN BLOCK –C

SCALE	1:100	DATE	03.02.2021
DEALT BY	SAMEER	STATUS	WORKING
NORTH	DRG NO.	REVISION	
	SA/RMA/21/22	R-02	

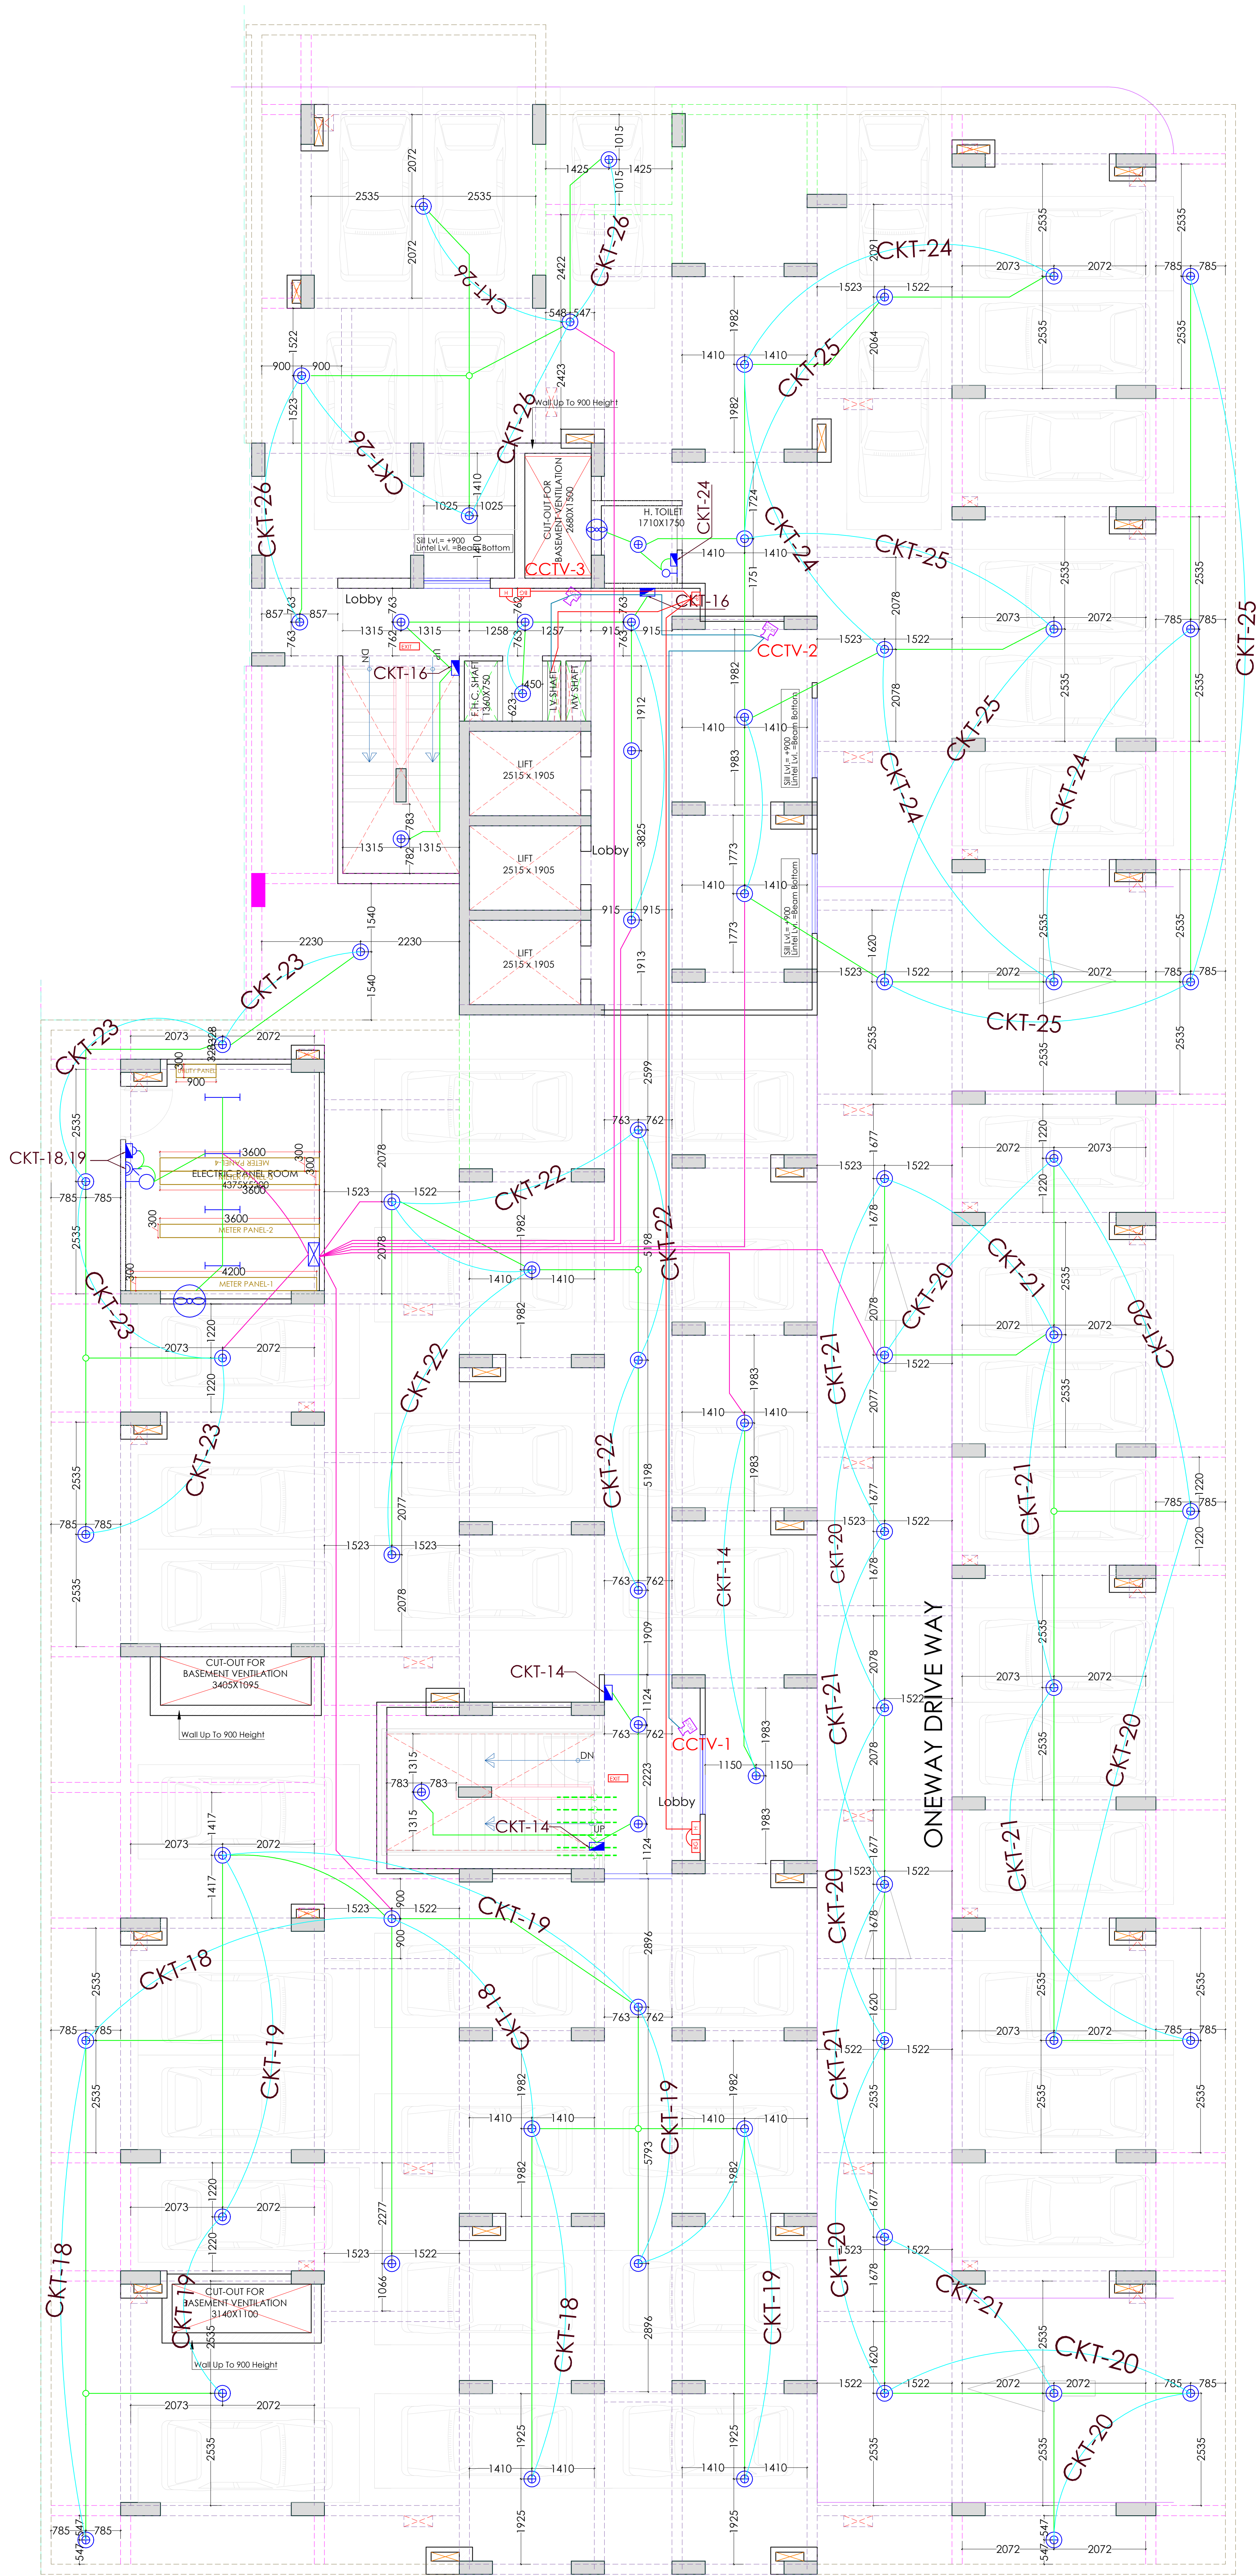

PROJECT TITLE

PROPOSED
GROUP HOUSING
AT
SUKHIYA, JAIPUR

LEGEND			
NO	DESCRIPTION	SYMBOL	FROM FFL
1.	CEILING FAN		CEILING
2.	EXHAUST		6'-0"
3.	WALL FAN POINT		6'-0"
4.	A C POINT(SPLIT AC)		AS PER SITE
5.	A C SOCKET		AS PER SITE
6.	16 AMP POWER PLUG POINT(GENERAL)		1'-0"
7.	GYSER SOCKET 16 AMP		6'-0"
8.	16 AMP POWER PLUG POINT(KITCHEN)		1'-0" ABOVE KITCHEN SLAB
9.	16 AMP SOCKET		AS PER SITE
10.	6 AMP PLUG POINT (BED SIDE)		2'-6"
11.	6 AMP SOCKET (CHIMNEY)		7'-0"
12.	6 AMP SOCKET		AS PER SITE
13.	2 NOS 6 AMP POWER PLUG POINT (PUB TV)		1'-6"/4'-6"
14.	2 NOS 6 AMP SOCKET		1'-6"/4'-6"
15.	INVERTOR SOCKET		1'-6"
16.	SWITCH BOARD WITH 6 AMP POINT		4'-0"
17.	SWITCH BOARD WITH 6 AMP POINT		4'-0"
18.	BELL PUSH		4'-0"
19.	GYSER SWITCH 16 AMP		4'-0"
20.	TELEPHONE POINT(BED SIDE)		2'-6"
21.	TELEPHONE POINT (GENERAL)		1'-0"
22.	TV POINT (GENERAL)		2'-6"
23.	CEILING LIGHT		CEILING
24.	40W TUBE LIGHT ON CEILING		CEILING
25.	BULB HOLDER ON SIDE WALL		7'-3"
26.	TUBE LIGHT ON WALL		7'-3"
27.	DISTRIBUTION BOX		5'-0"
28.	BELL		7'-3"
29.	CONDUIT CIRCUIT (25MM)		CEILING
30.	CONDUIT POINT WIRING (25MM)		CEILING
31.	CONDUIT SUB MAIN WIRING (25MM)		CEILING

LEGEND			
NO	DESCRIPTION	SYMBOL	
1.	MANUAL CALL POINT		02- NOS
2.	HOOTER		02- NOS
3.	25MM MS CONDUIT		02- NOS
4.	SELF LUMINOUS GLOW SIGN BOARD		02- NOS
5.	FIRE PANEL		01- NOS
6.	CCTV		03- NOS
7.	25MM MS CONDUIT CCTV		

REVISION:

MARK	DATE	DESCRIPTION
R-01	04-05-15	EXTENDED BASEMENT ROOF LVL. CHANGED

1. All dimensions are to be verified on site by the contractor. Any discrepancies are to be reported to the Client and Architects immediately.

2. This drawing is to be read in conjunction with other relevant Structural and Services Details

3. Drawings not showing the latest revisions are to be canceled.

4. All dimensions are to be read and NOT scaled.

5. All dimensions and levels are in mm unless specified otherwise

6. The drawing and design is the property of RICKY MATHUR AND ASSOCIATES. No portion maybe used or reproduced without their written permission.

VIPUL AGARWAL
M.E.P. CONSULTANT
B.E. ELECTRICAL

MEP CONSULTANT :

ASHI ASSOCIATES,
F 9 / 440 , Keshav Marg Chitrakut
Scheme,Jaipur
PH:91-0-93146-10438 ,0141-2440946
Mail:vipul8599@yahoo.com

ARCHITECT


Ricky Mathur & Associates
architects interior designers planners
33, Dhuleshwar Garden,
Jaipur. (RAJ.) India. 302 001
Tel: 91-141-236 2688, 512 5444
Fax: 91-141-400 8700
e-mail: ricky@rickymathur.com

DRAWING TITLE

STILT FLOOR ELECTRICAL
PLAN BLOCK –C

SCALE	1:100	DATE	03.02.2021
DEALT BY	SAMEER	STATUS	WORKING
NORTH		DRG NO.	REVISION
		SA/RMA/21/23	R-02

PROPOSED
GROUP HOUSING
AT
SUKHIYA,JAIPUR

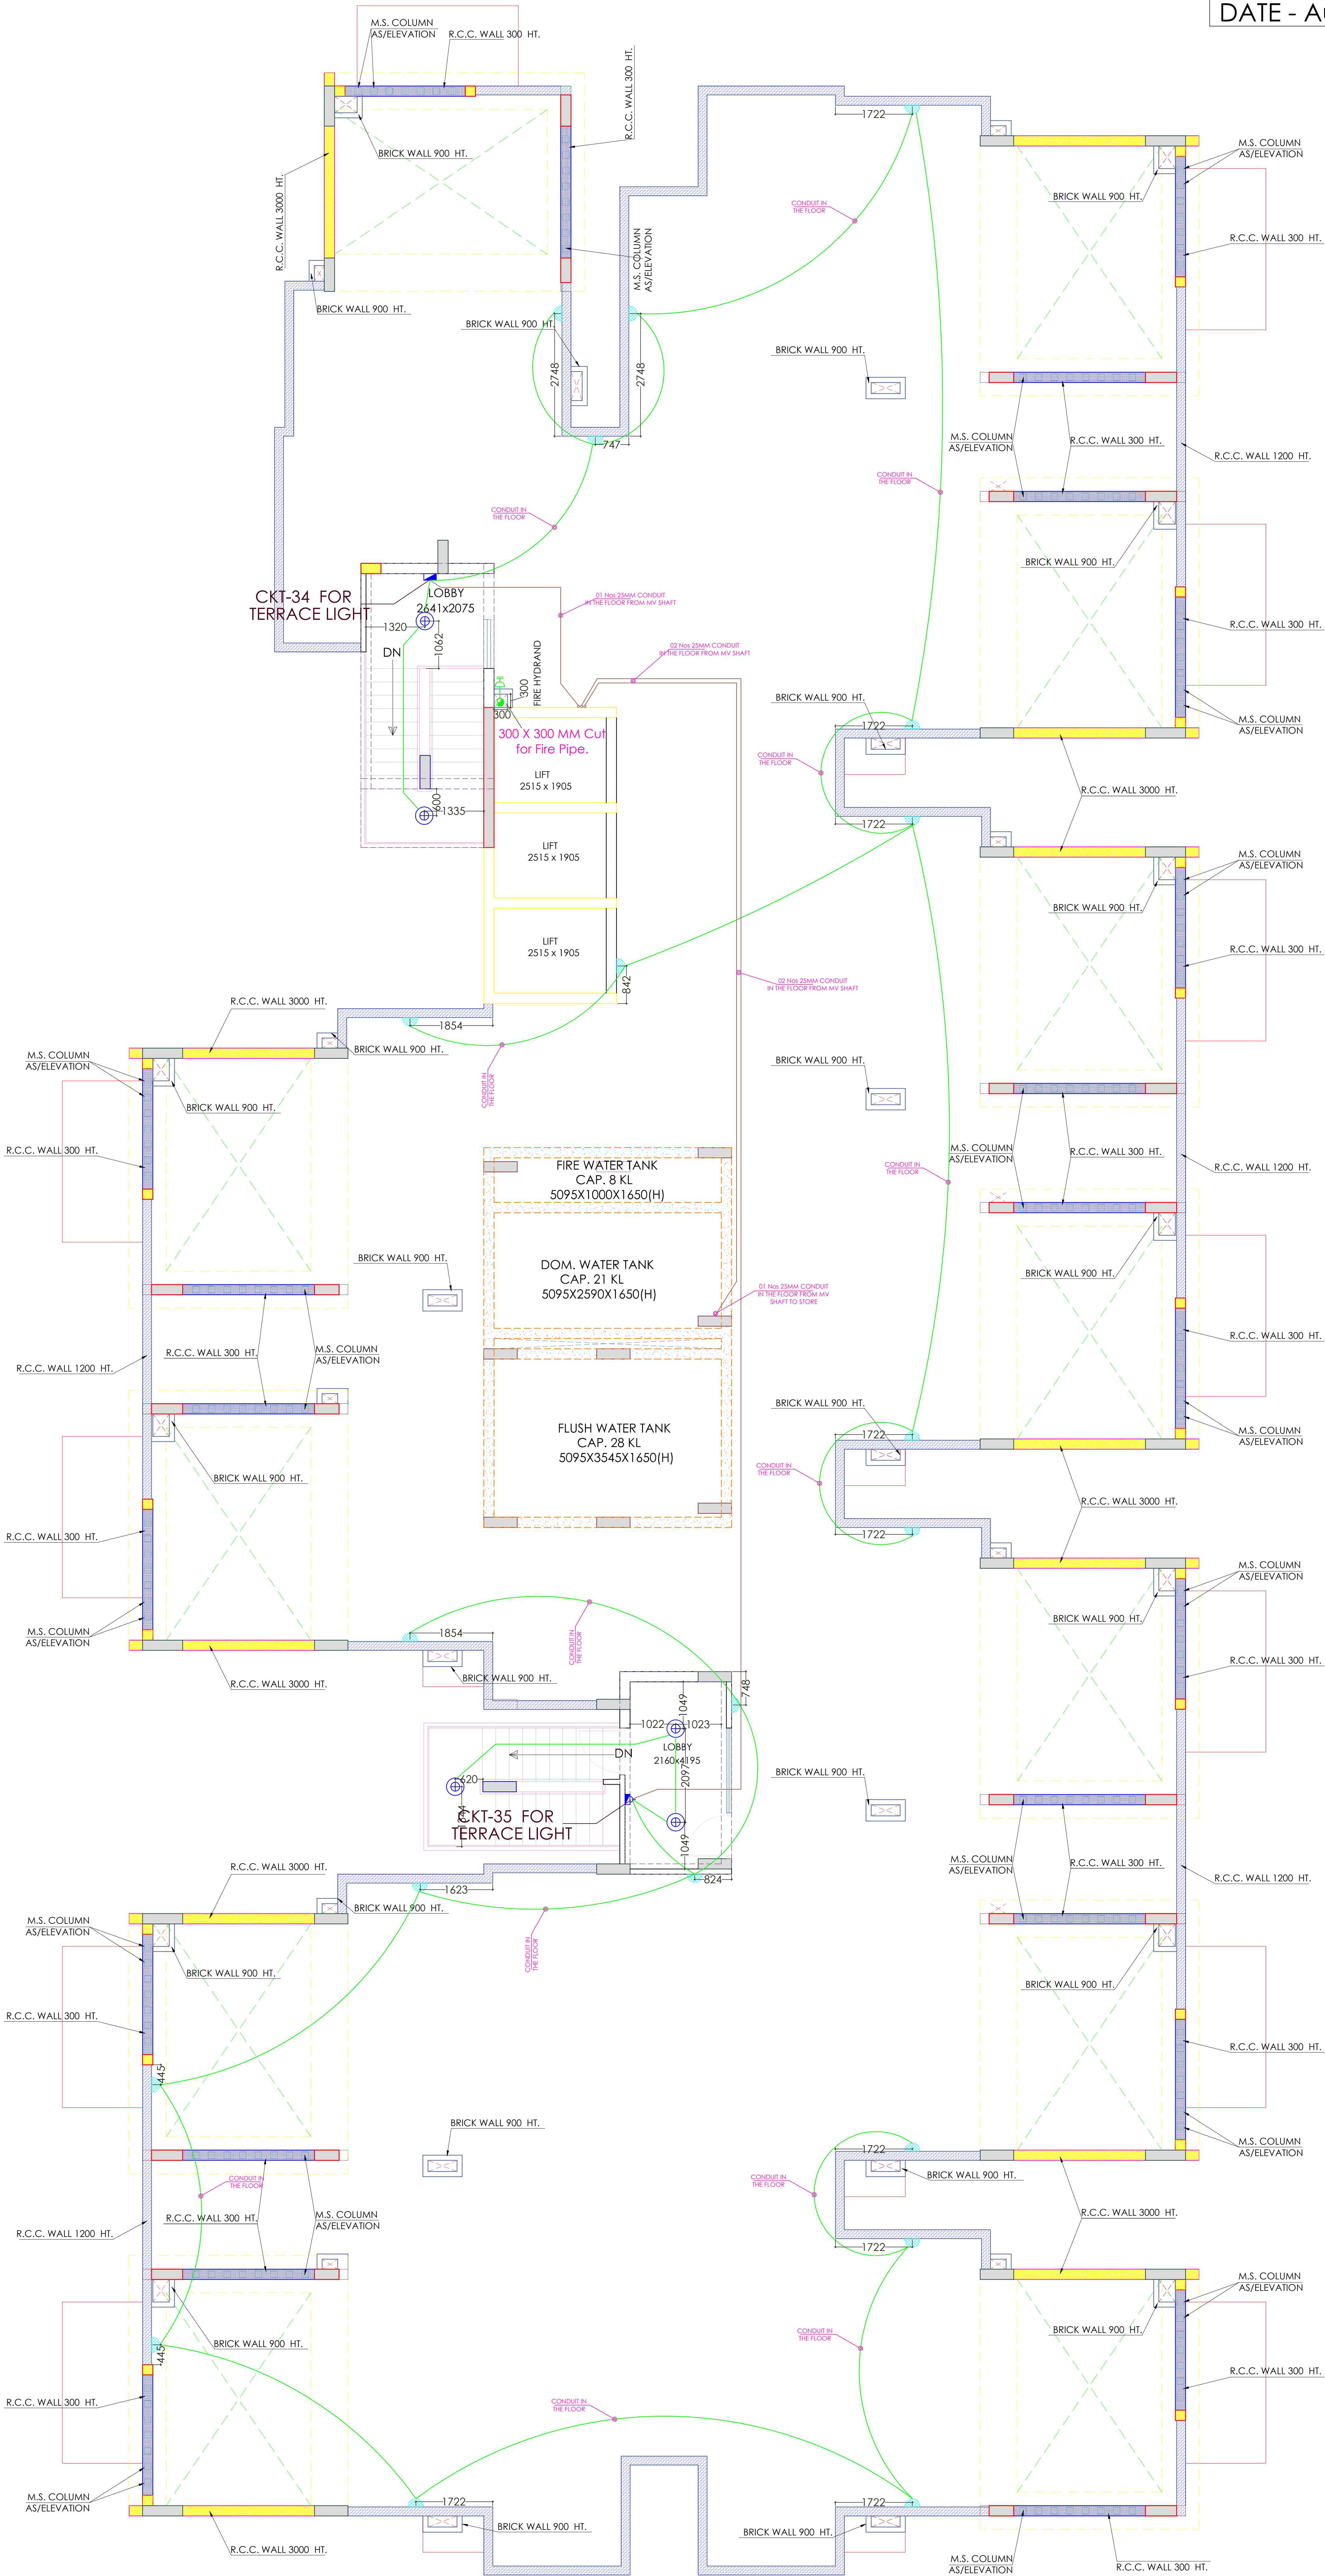

REVISION:		
MARK	DATE	DESCRIPTION
1. All dimensions are to be verified on site by the contractor. Any discrepancies are to be reported to the Client and Architects immediately.		
2. This drawing is to be read in conjunction with other relevant Structural and Services Details		
3. Drawings not showing the latest revisions are to be canceled.		
4. All dimensions are to be read and NOT scaled.		
5. All dimensions and levels are in mm unless specified otherwise		
6. The drawing and design is the property of RICKY MATHUR AND ASSOCIATES. No portion may be used or reproduced without their written permission.		

Vipul
VIPUL AGARWAL
M.E.P. CONSULTANT
B.E. ELECTRICAL

MEP CONSULTANT :

ASHI ASSOCIATES.
F 9 / 440 , Keshav Marg Chitrakut
Scheme,Jaipur
PH:91-0-93146-10438 ,0141-2440946
Mail:vipul8599@yahoo.com

ARCHITECT
Ricky Mathur & Associates
architects interior designers planners
33, Dhuleshwar Garden,
Jaipur, (RAJ.) India. 302 001
Tel: 91-141-236 2688, 512 5444
Fax: 91-141-400 8700
e-mail: ricky@rickymathur.com

DRAWING TITLE
TERRACE FLOOR
ELECTRICAL PLAN
(BLOCK - C)

SCALE	N.T.S	DATE	30.01.2021
DEALT BY	SHARWAN	STATUS	WORKING
NORTH		DRG NO.	REVISION
		SA/RMA/21/26	R-01

PROJECT TITLE

PROPOSED
GROUP HOUSING
AT
SUKHIYA, JAIPUR

CKT-28	3F TO 4TH FLOOR
CKT-29	5THF TO 6TH FLOOR
CKT-30	7THF TO 8TH FLOOR
CKT-31	9THF TO 10TH FLOOR
CKT-32	11THF TO 12TH FLOOR
CKT-33	13THF TO 14TH FLOOR
CKT-34	TERRACE FLOOR
CKT-35	TERRACE FLOOR

LEGEND			
NO	DESCRIPTION	SYMBOL	QTY
1.	HEAT DETECTOR		NIL
2.	SMOKE DETECTOR		NIL
3.	MANUAL CALL POINT		02 NOS
4.	HOTTER		02 NOS
5.	FIRE PANEL		NIL
6.	25MM MS CONDUIT		
7.	SELF LUMINOUS GLOW SIGN BOARD		4 NOS

LEGEND			
NO	DESCRIPTION	SYMBOL	FROM FFL
1.	CEILING FAN		CEILING
2.	EXHAUST		6'-0"
3.	WALL FAN POINT		6'-0"
4.	A C POINT(WINDOW AC)		1'-0"
5.	A C POINT(SPLIT AC)		AS PER SITE
6.	3 PHASE POINT		AS PER SITE
7.	A C SOCKET		AS PER SITE
8.	8 AMP POWER PLUG POINT(GENERAL)		1'-0"
9.	GYSER SOCKET 16 AMP		6'-0"
10.	8 AMP POWER PLUG POINT(KITCHEN)		1'-0"
11.	16 AMP SOCKET		AS PER SITE
12.	6 AMP PLUG POINT (BED SIDE)		2'-6"
13.	6 AMP SOCKET (CHIMNEY)		7'-0"
14.	6 AMP SOCKET		AS PER SITE
15.	2 NOS 8 AMP POWER PLUG POINT (FOR TV)		1'-0"
16.	2 NOS 6 AMP SOCKET		1'-0"
17.	6 AMP PLUG POINT(GENERAL)		1'-0"
18.	NIGHT LAMP		1'-6"
19.	KEY TAG		4'-0"
20.	INVERTER SOCKET		1'-6"
21.	SWITCH BOARD WITH OUT 6 AMP POINT		4'-0"
22.	SWITCH BOARD WITH 6 AMP POINT		4'-0"
23.	BELL PSI		4'-0"
24.	GYSER SWITCH 16 AMP		4'-0"
25.	PROJECTOR POINT		3'-6"
26.	TELEPHONE POINT(SIDE)		2'-6"
27.	TELEPHONE POINT(GENERAL)		1'-0"
28.	TV POINT(GENERAL)		2'-6"
29.	LAN POINT		2'-6"
30.	CEILING LIGHT 2X2'		CEILING
31.	CEILING LIGHT		CEILING
32.	CHANDELIER		CEILING
33.	40W TUBE LIGHT ON CEILING		CEILING
34.	BULB HOLDER ON SIDE WALL		7'-3"
35.	BULB HOLDER ON MAIN DOOR		8'-3"
36.	TUBE LIGHT ON WALL		7'-3"
37.	BULKHEAD Fixture		2'-6"
38.	DISTRIBUTION BOX		5'-0"
39.	BELL		7'-3"
40.	CONDUIT CIRCUIT (25MM)		CEILING
41.	CONDUIT POINT WIRING (25MM)		CEILING
42.	CONDUIT WIRING (25MM)		CEILING

1. All dimensions are to be verified on site by the contractor. Any discrepancies are to be reported to the Client and Architects immediately.
2. This drawing is to be read in conjunction with other relevant Structural and Services Details
3. Drawings not showing the latest revisions are to be canceled.
4. All dimensions are to be read and NOT scaled.
5. All dimensions and levels are in mm unless specified otherwise
6. The drawing and design is the property of RICKY MATHUR AND ASSOCIATES. No portion may be used or reproduced without their written permission.

VIPUL AGARWAL
M.E.P. CONSULTANT
B.E. ELECTRICAL

MEP CONSULTANT :

ASHI ASSOCIATES,
F 9 / 440 , Keshav Marg Chitrakut
Scheme,Jaipur
PH:91-0-93146-10438 ,0141-2440946
Mail:vipu8599@yahoo.com

ARCHITECT

Ricky Mathur & Associates
architects interior designers planners
33, Dhuleshwar Garden,
Jaipur, (RAJ.) India. 302 001
Tel: 91-141-236 2688, 512 5444
Fax: 91-141-400 8700
e-mail: ricky@rickymathur.com

DRAWING TITLE

TYPICAL(1st to 14th)
FLOOR ELECTRICAL PLAN
BLOCK -C

SCALE	1:100	DATE	30.01.2021
DEALT BY	SAMEER	STATUS	WORKING
NORTH	DRG NO.	REVISION	
	SA/RMA/21/24	R-1	

PROJECT TITLE

PROPOSED
GROUP HOUSING
AT
SUKHIYA,JAPUR

NO	LEGEND	SYMBOL	ROOM TEL.
1	CHIMNEY		CEILING
2	EXHAUST		6"-0"
3	WALL MOUNT		6"-0"
4	A.C. CONDENSATE AD		ATBES
5	A.C. SOCKET		ATBES
6	3/4" RAMPING AUTOMORPHICALLY		6"-0"
7	OVERSEER SOCKET IN AMP		ATBES
8	3/4" RAMPING AUTOMORPHICALLY		ATBES
9	3/4" RAMPING AUTOMORPHICALLY		ATBES
10	3/4" RAMPING AUTOMORPHICALLY		ATBES
11	3/4" RAMPING AUTOMORPHICALLY		ATBES
12	3/4" RAMPING AUTOMORPHICALLY		ATBES
13	3/4" RAMPING AUTOMORPHICALLY		ATBES
14	3/4" RAMPING AUTOMORPHICALLY		ATBES
15	3/4" RAMPING AUTOMORPHICALLY		ATBES
16	3/4" RAMPING AUTOMORPHICALLY		ATBES
17	3/4" RAMPING AUTOMORPHICALLY		ATBES
18	3/4" RAMPING AUTOMORPHICALLY		ATBES
19	3/4" RAMPING AUTOMORPHICALLY		ATBES
20	3/4" RAMPING AUTOMORPHICALLY		ATBES
21	3/4" RAMPING AUTOMORPHICALLY		ATBES
22	3/4" RAMPING AUTOMORPHICALLY		ATBES
23	3/4" RAMPING AUTOMORPHICALLY		ATBES
24	3/4" RAMPING AUTOMORPHICALLY		ATBES
25	3/4" RAMPING AUTOMORPHICALLY		ATBES
26	3/4" RAMPING AUTOMORPHICALLY		ATBES
27	3/4" RAMPING AUTOMORPHICALLY		ATBES
28	3/4" RAMPING AUTOMORPHICALLY		ATBES
29	3/4" RAMPING AUTOMORPHICALLY		ATBES
30	3/4" RAMPING AUTOMORPHICALLY		ATBES
31	3/4" RAMPING AUTOMORPHICALLY		ATBES

NO	LEGEND	SYMBOL	ROOM TEL.
1	MANUAL CALL POINT		65 NOS
2	HOOPER		65 NOS
3	3/4" RAMPING AUTOMORPHICALLY		65 NOS
4	3/4" RAMPING AUTOMORPHICALLY		65 NOS
5	3/4" RAMPING AUTOMORPHICALLY		65 NOS
6	3/4" RAMPING AUTOMORPHICALLY		65 NOS
7	3/4" RAMPING AUTOMORPHICALLY		65 NOS

REVISION:	MARK	DATE	DESCRIPTION
R-01	04-05-15	EXTENDED BASEMENT ROOF	LVL. CHANGED


- All dimensions are to be verified on site by the contractor. Any discrepancies are to be reported to the client and resolved before construction begins.
- This drawing is to be used in conjunction with other relevant Structural and Services Details.
- Drawings not showing the latest revisions are to be cancelled.
- All dimensions are to be read and NOT scaled, unless specified otherwise.
- All dimensions and levels are in mm.
- The drawing and design is the property of RICKY MATUR AND ASSOCIATES.
- Without their written permission.

VISHAL KARNAL
M.P. CONSULTANT
BE ELECTRICAL

MEP CONSULTANT :

ASHI ASSOCIATES,
F 9 / 440 , Keshav Marg Chitrakut
Scheme,Japur
Ph:91-99310619438, 0141-240946
Mail:vp88599@yahoo.com

ARCHITECT
Ricky Mathur & Associates
architects interior designers planners
33, Dhuleshwar Garden,
Jodpur, (RAJ) India, 302 001
Tel: 91-141-236 2688, 512 5444
Fax: 91-141-400 8700
e-mail: ricky@rickymathur.com

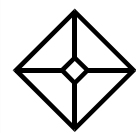



DRAWING TITLE
BASEMENT FLOOR
ELECTRICAL
PLAN BLOCK -D

SCALE	1:100	DATE	03.02.2021
DEALT BY	SAVEER	STATUS	WORKING
NORTH	DRG NO.	REVISION	



SA/RMA/21/22 R-02

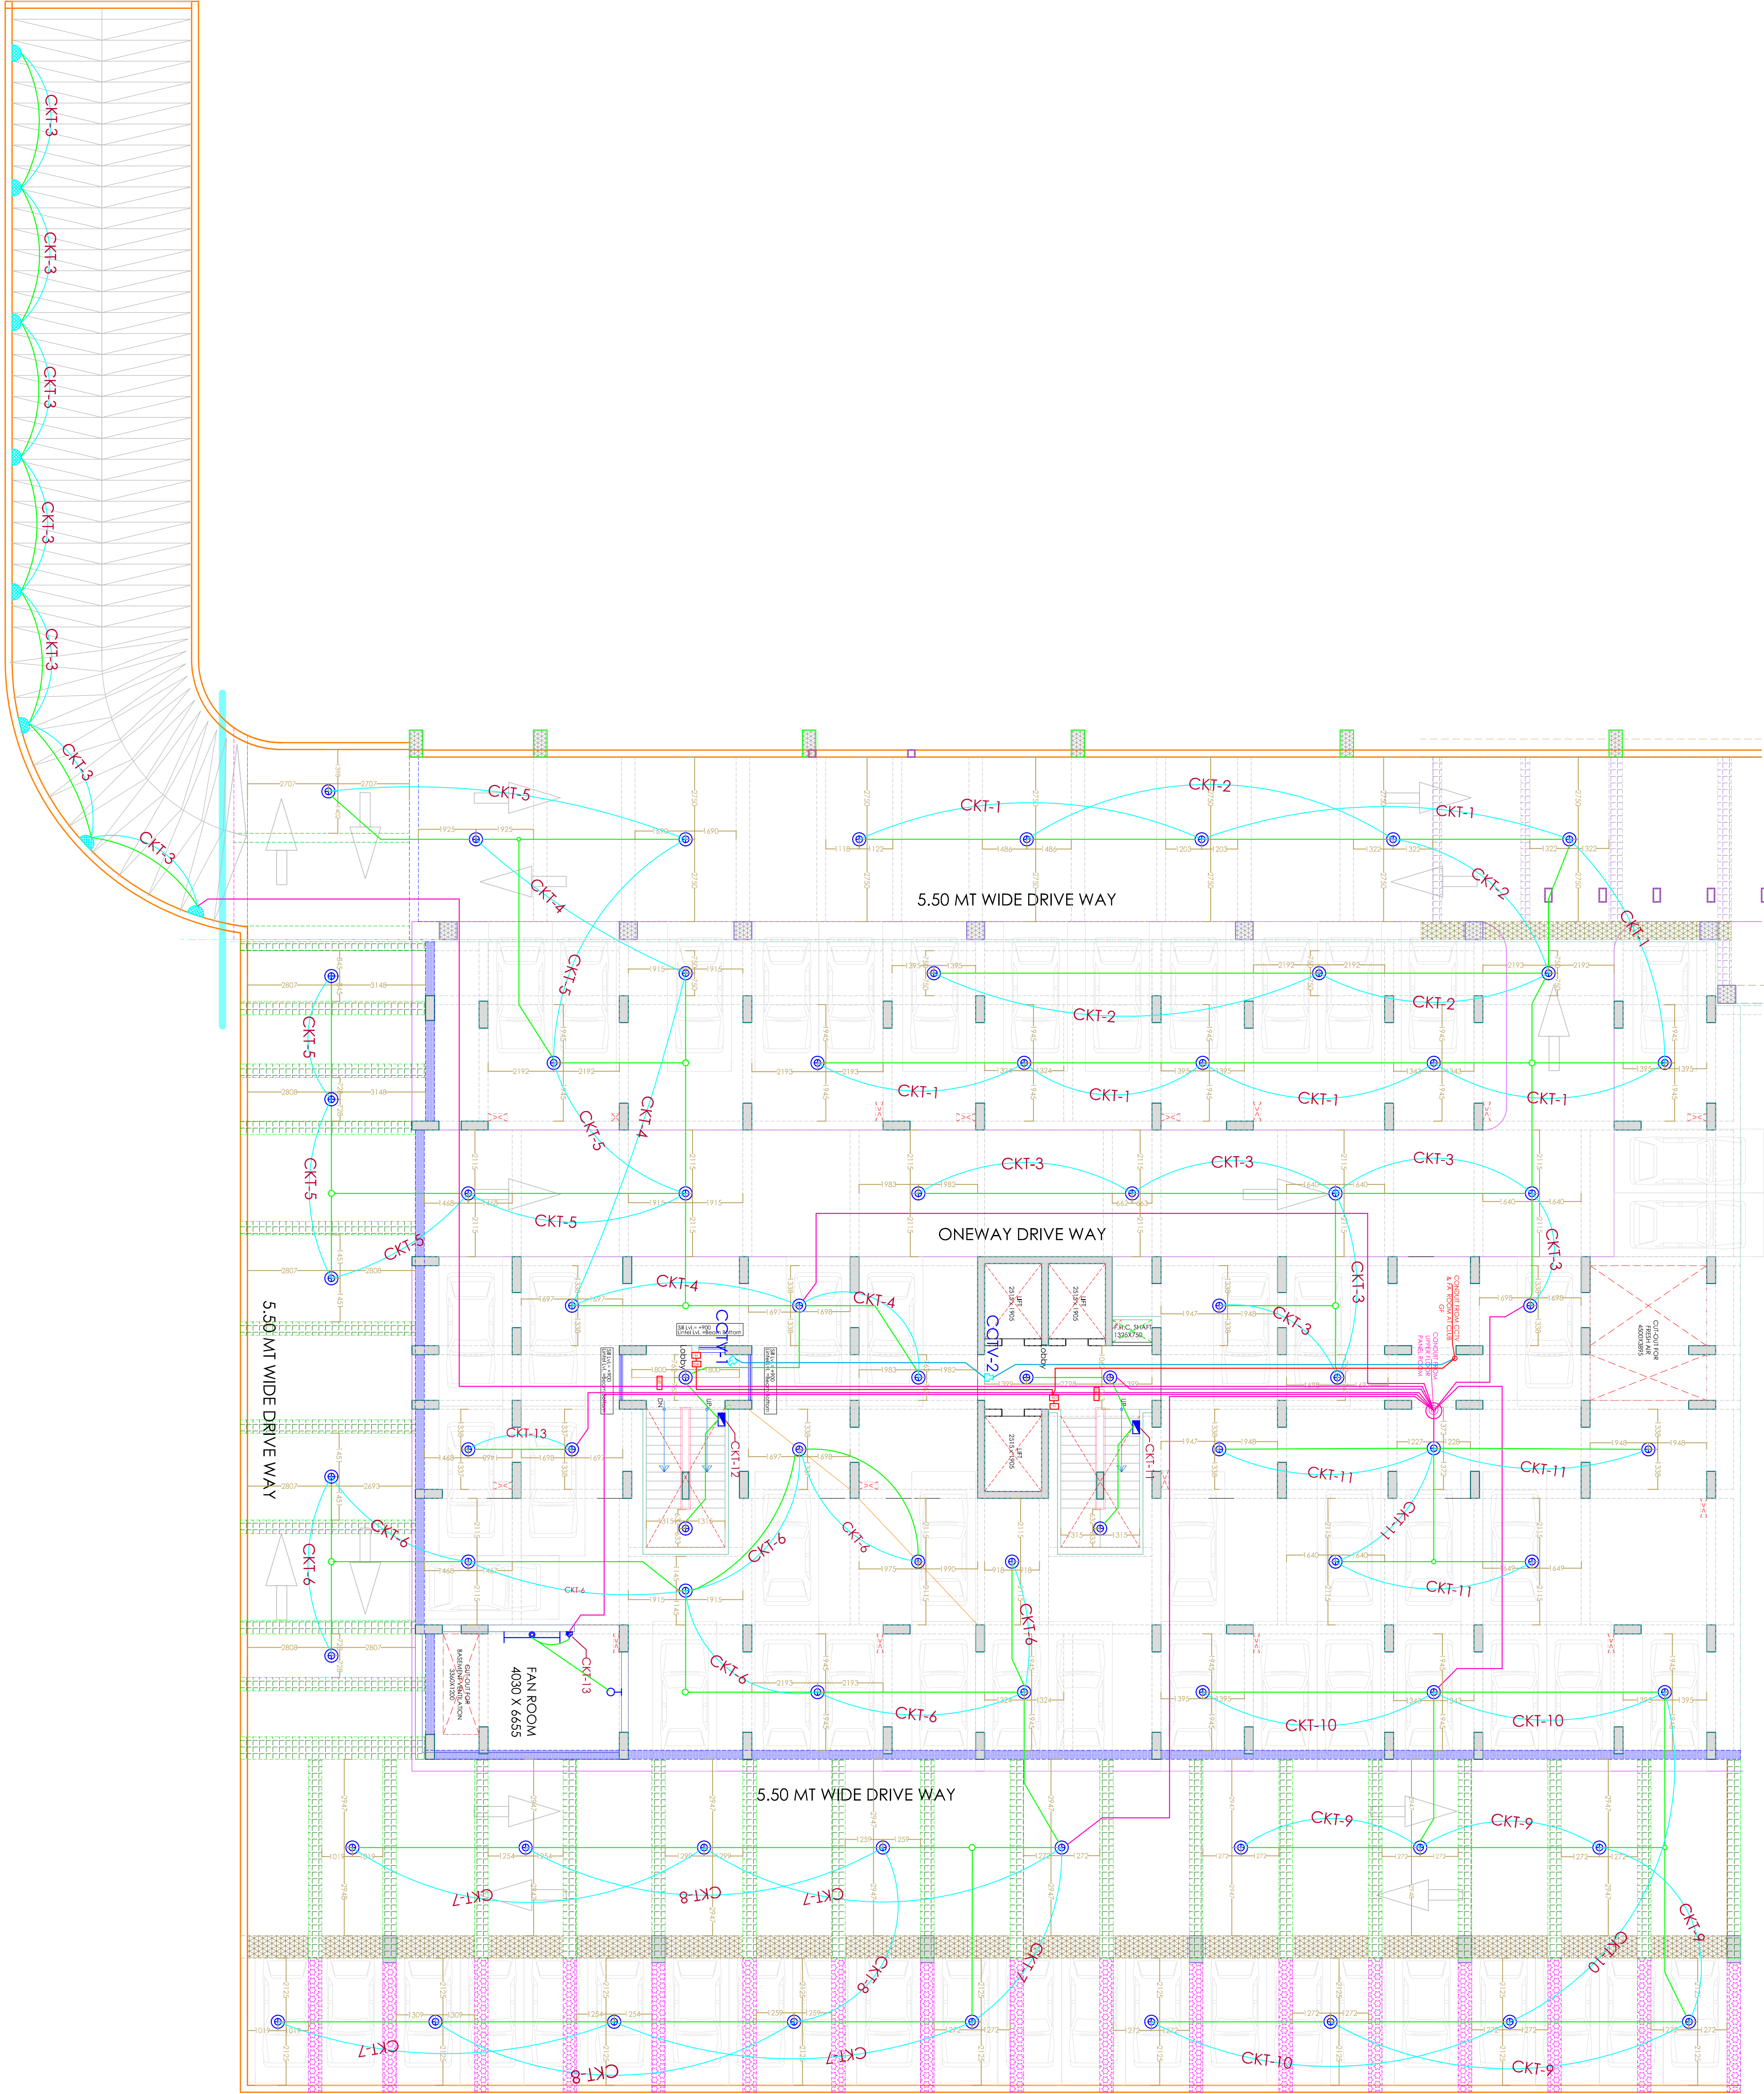

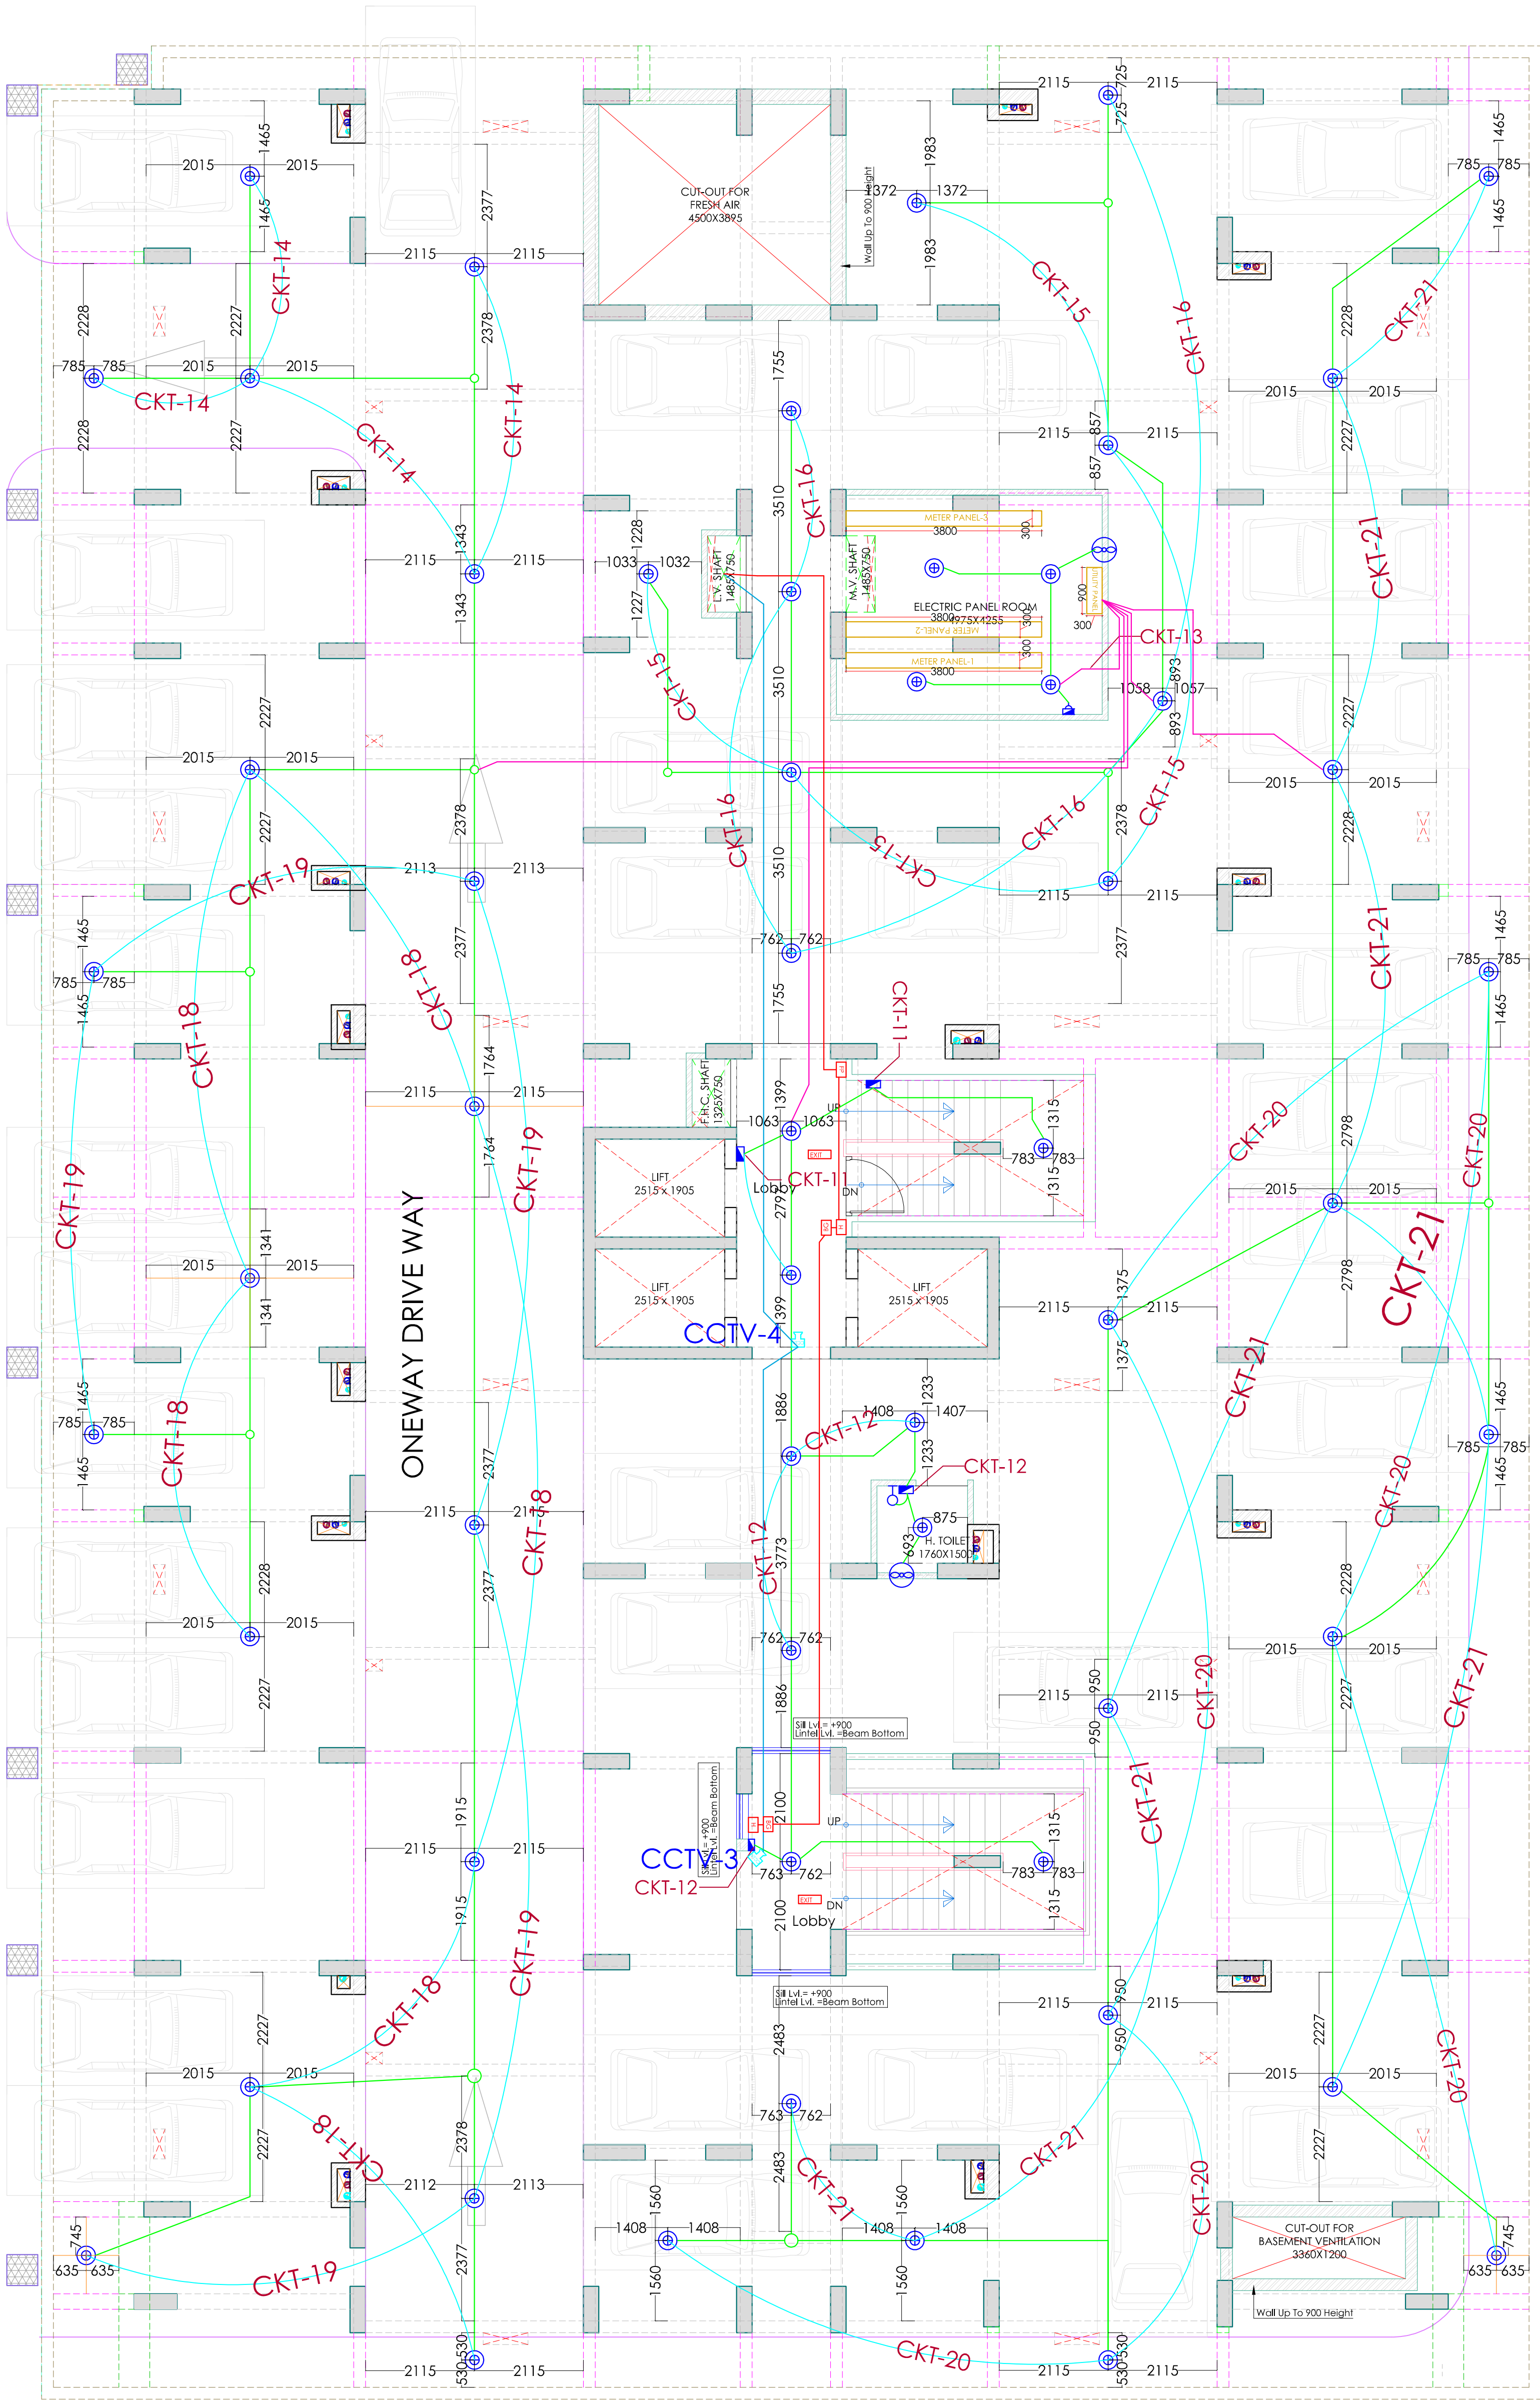

PROJECT TITLE

PROPOSED
GROUP HOUSING
AT
SUKHIYA,JAIPUR

LEGEND			
NO	DESCRIPTION	SYMBOL	FROM FFL
1.	CEILING FAN		CEILING
2.	EXHAUST		6'-0"
3.	WALL FAN POINT		6'-0"
4.	A C POINT(SPLIT AC)		AS PER SITE
5.	A C SOCKET		AS PER SITE
6.	16 AMP POWER PLUG POINT(GENERAL)		1'-0"
7.	GYSER SOCKET 16 AMP		6'-0"
8.	16 AMP POWER PLUG POINT(KITCHEN)		1'-0" ABOVE KITCHEN SLAB
9.	16 AMP SOCKET		AS PER SITE
10.	6 AMP PLUG POINT (BED SIDE)		2'-6"
11.	6 AMP SOCKET (CHIMNEY)		7'-0"
12.	6 AMP SOCKET		AS PER SITE
13.	2 NOS 6 AMP POWER PLUG POINT (FOR TV)		1'-6"/4'-6"
14.	2 NOS 6 AMP SOCKET		1'-6"/4'-6"
15.	INVERTOR SOCKET		1'-6"
16.	SWITCH BOARD WITH CKT 4 AMP POINT		4'-0"
17.	SWITCH BOARD WITH 6 AMP POINT		4'-0"
18.	BELL PUSH		4'-0"
19.	GYSER SWITCH 16 AMP		4'-0"
20.	TELEPHONE POINT(BED SIDE)		2'-6"
21.	TELEPHONE POINT (GENERAL)		1'-0"
22.	TV POINT (GENERAL)		2'-6"
23.	CEILING LIGHT		CEILING
24.	40W TUBE LIGHT ON CEILING		CEILING
25.	BULB HOLDER ON SIDE WALL		7'-3"
26.	TUBE LIGHT ON WALL		7'-3"
27.	DISTRIBUTION BOX		5'-0"
28.	BELL		7'-3"
29.	CONDUIT CIRCUIT (25MM)		CEILING
30.	CONDUIT POINT WIRING (25MM)		CEILING
31.	CONDUIT SUB MAIN WIRING (25MM)		CEILING

LEGEND			
NO	DESCRIPTION	SYMBOL	
1.	MANUAL CALL POINT		02- NOS
2.	HOOTER		02- NOS
3.	25MM MS CONDUIT		02- NOS
4.	SELF LUMINOUS GLOW SIGN BOARD		02- NOS
5.	FIRE PANEL		01- NOS
6.	CCTV		02- NOS
7.	25MM MS CONDUIT CCTV		

REVISION:

MARK	DATE	DESCRIPTION
R-01	04-05-15	EXTENDED BASEMENT ROOF LVL. CHANGED

1. All dimensions are to be verified on site by the contractor. Any discrepancies are to be reported to the Client and Architects immediately.

2. This drawing is to be read in conjunction with other relevant Structural and Services Details

3. Drawings not showing the latest revisions are to be canceled.

4. All dimensions are to be read and NOT scaled.

5. All dimensions and levels are in mm unless specified otherwise

6. The drawing and design is the property of RICKY MATHUR AND ASSOCIATES. No portion maybe used or reproduced without their written permission.

VIPUL AGARWAL
M.E.P. CONSULTANT
B.E. ELECTRICAL

MEP CONSULTANT :

ASHI ASSOCIATES,
F 9 / 440 , Keshav Marg Chitrakut
Scheme,Jaipur
PH:91-0-93146-10438 ,0141-2440946
Mail:vipul8599@yahoo.com


ARCHITECT

Ricky Mathur & Associates
architects interior designers planners
33, Dhuleshwar Garden,
Jaipur. (RAJ.) India. 302 001
Tel: 91-141-236 2688, 512 5444
Fax: 91-141-400 8700
e-mail: ricky@rickymathur.com

DRAWING TITLE

STILT FLOOR ELECTRICAL
PLAN BLOCK -D

SCALE	1:100	DATE	03.02.2021
DEALT BY	SAMEER	STATUS	WORKING
NORTH		DRG NO.	REVISION
		SA/RMA/00/00	R-02

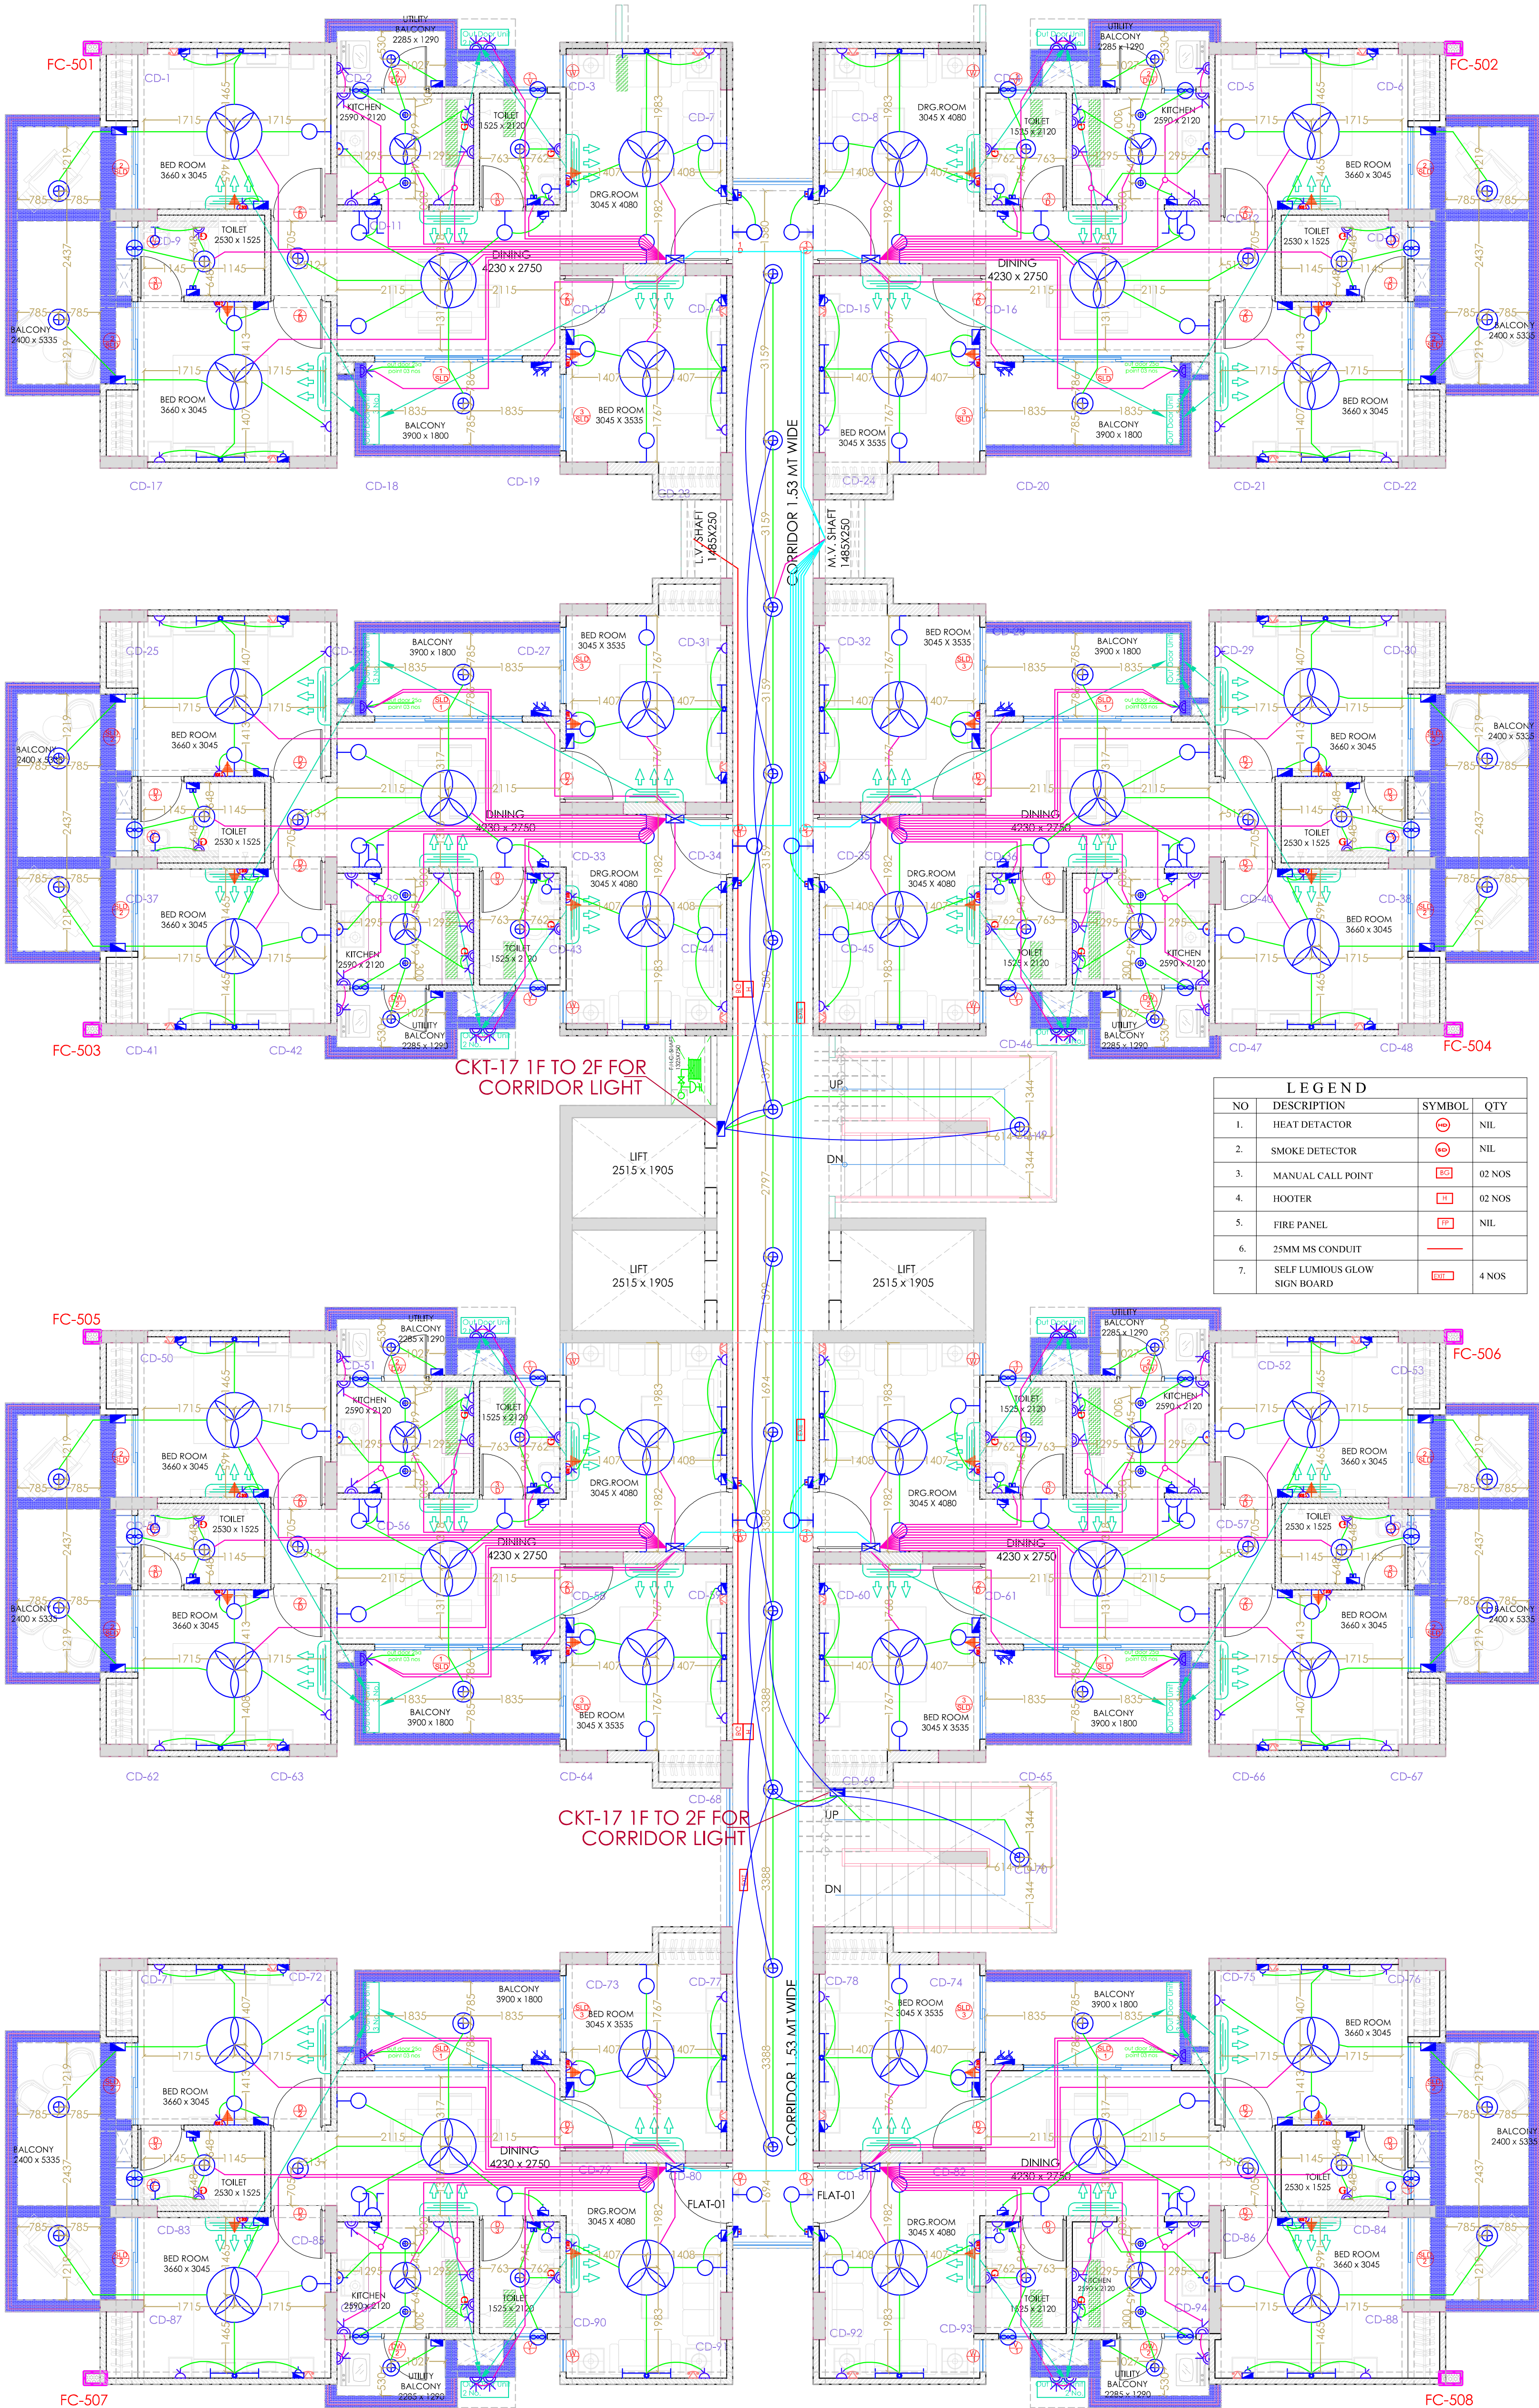


PROJECT TITLE	
PROPOSED GROUP HOUSING AT SUKHIYA,JAIPUR	
CKT-23	3F TO 4TH FLOOR
CKT-24	5THF TO 6TH FLOOR
CKT-25	7THF TO 8TH FLOOR
CKT-26	9THF TO 10TH FLOOR
CKT-27	11THF TO 12TH FLOOR
CKT-28	13THF TO 14TH FLOOR
CKT-29	TERRACE FLOOR
CKT-30	TERRACE FLOOR

LEGEND			
NO	DESCRIPTION	SYMBOL	FROM FFL
1.	CEILING FAN		CEILING
2.	EXHAUST		6'-0"
3.	WALL FAN POINT		6'-0"
4.	A C POINT(WINDOW AC)		1'-0"
5.	A C POINT(SPLIT AC)		AS PER SITE
6.	3 PHASE POINT		AS PER SITE
7.	A C SOCKET		AS PER SITE
8.	16 AMP POWER PLUG POINT(GENERAL)		1'-0"
9.	GYSER SOCKET 16 AMP		6'-0"
10.	16 AMP POWER PLUG POINT(KITCHEN)		1'-0" ABOVE KITCHEN SLAB
11.	16 AMP SOCKET		AS PER SITE
12.	6 AMP PLUG POINT (BED SIDE)		2'-6"
13.	6 AMP SOCKET (CHIMNEY)		7'-0"
14.	6 AMP SOCKET		AS PER SITE
15.	2 NOS 6 AMP POWER PLUG POINT (FOR TV)		1'-6"/4'-6"
16.	2 NOS 6 AMP SOCKET		1'-6"/4'-6"
17.	6 AMP PLUG POINT (GENERAL)		1'-0"
18.	NIGHT LAMP		1'-6"
19.	KEY TAG		4'-0"
20.	INVERTOR SOCKET		1'-6"
21.	SWITCH BOARD WITH OUT 6 AMP POINT		4'-0"
22.	SWITCH BOARD WITH 6 AMP POINT		4'-0"
23.	BELL PUSH		4'-0"
24.	GYSER SWITCH 16 AMP		4'-0"
25.	PROJECTOR POINT		3'-6"
26.	TELEPHONE POINT(BED SIDE)		2'-6"
27.	TELEPHONE POINT (GENERAL)		1'-0"
28.	TV POINT (GENERAL)		2'-6"
29.	LAN POINT		2'-6"
30.	CEILING LIGHT 2X2'		CEILING
31.	CEILING LIGHT		CEILING
32.	CHANDELIER		CEILING
33.	40W TUBE LIGHT ON CEILING		CEILING
34.	BULB HOLDER ON SIDE WALL		7'-3"
35.	BULB HOLDER ON MAIN DOOR		8'-3"
36.	TUBE LIGHT ON WALL		7'-3"
37.	BULKHEAD Fixture		2'-6"
38.	DISTRIBUTION BOX		5'-0"
39.	BELL		7'-3"
40.	CONDUIT CIRCUIT (25MM)		CEILING
41.	CONDUIT POINT WIRING (25MM)		CEILING
	CONDUIT SUB MAIN WIRING (25MM)		CEILING

VIPUL AGARWAL
M.E.P. CONSULTANT
B.E. ELECTRICAL

MEP CONSULTANT :
ASHI ASSOCIATES,
F 9 / 440 , Keshav Marg Chitrakut
Scheme,Jaipur
PH:91-0-93146-10438 ,0141-2440946
Mail:vipul8599@yahoo.com

ARCHITECT
Ricky Mathur & Associates
architects interior designers planners
33, Dhuleshwar Garden,
Jaipur. (RAJ.) India. 302 001
Tel: 91-141-236 2688, 512 5444
Fax: 91-141-400 8700
e-mail: ricky@rickymathur.com

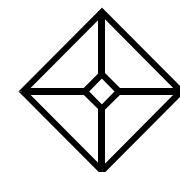

DRAWING TITLE
TYPICAL(1st to 14th) FLOOR
ELECTRICAL PLAN BLOCK – D

SCALE	1:100	DATE	30.01.2021
DEALT BY	SAMEER	STATUS	WORKING
NORTH		DRG NO.	REVISION
		SA/RMA/21/34	R-1

