


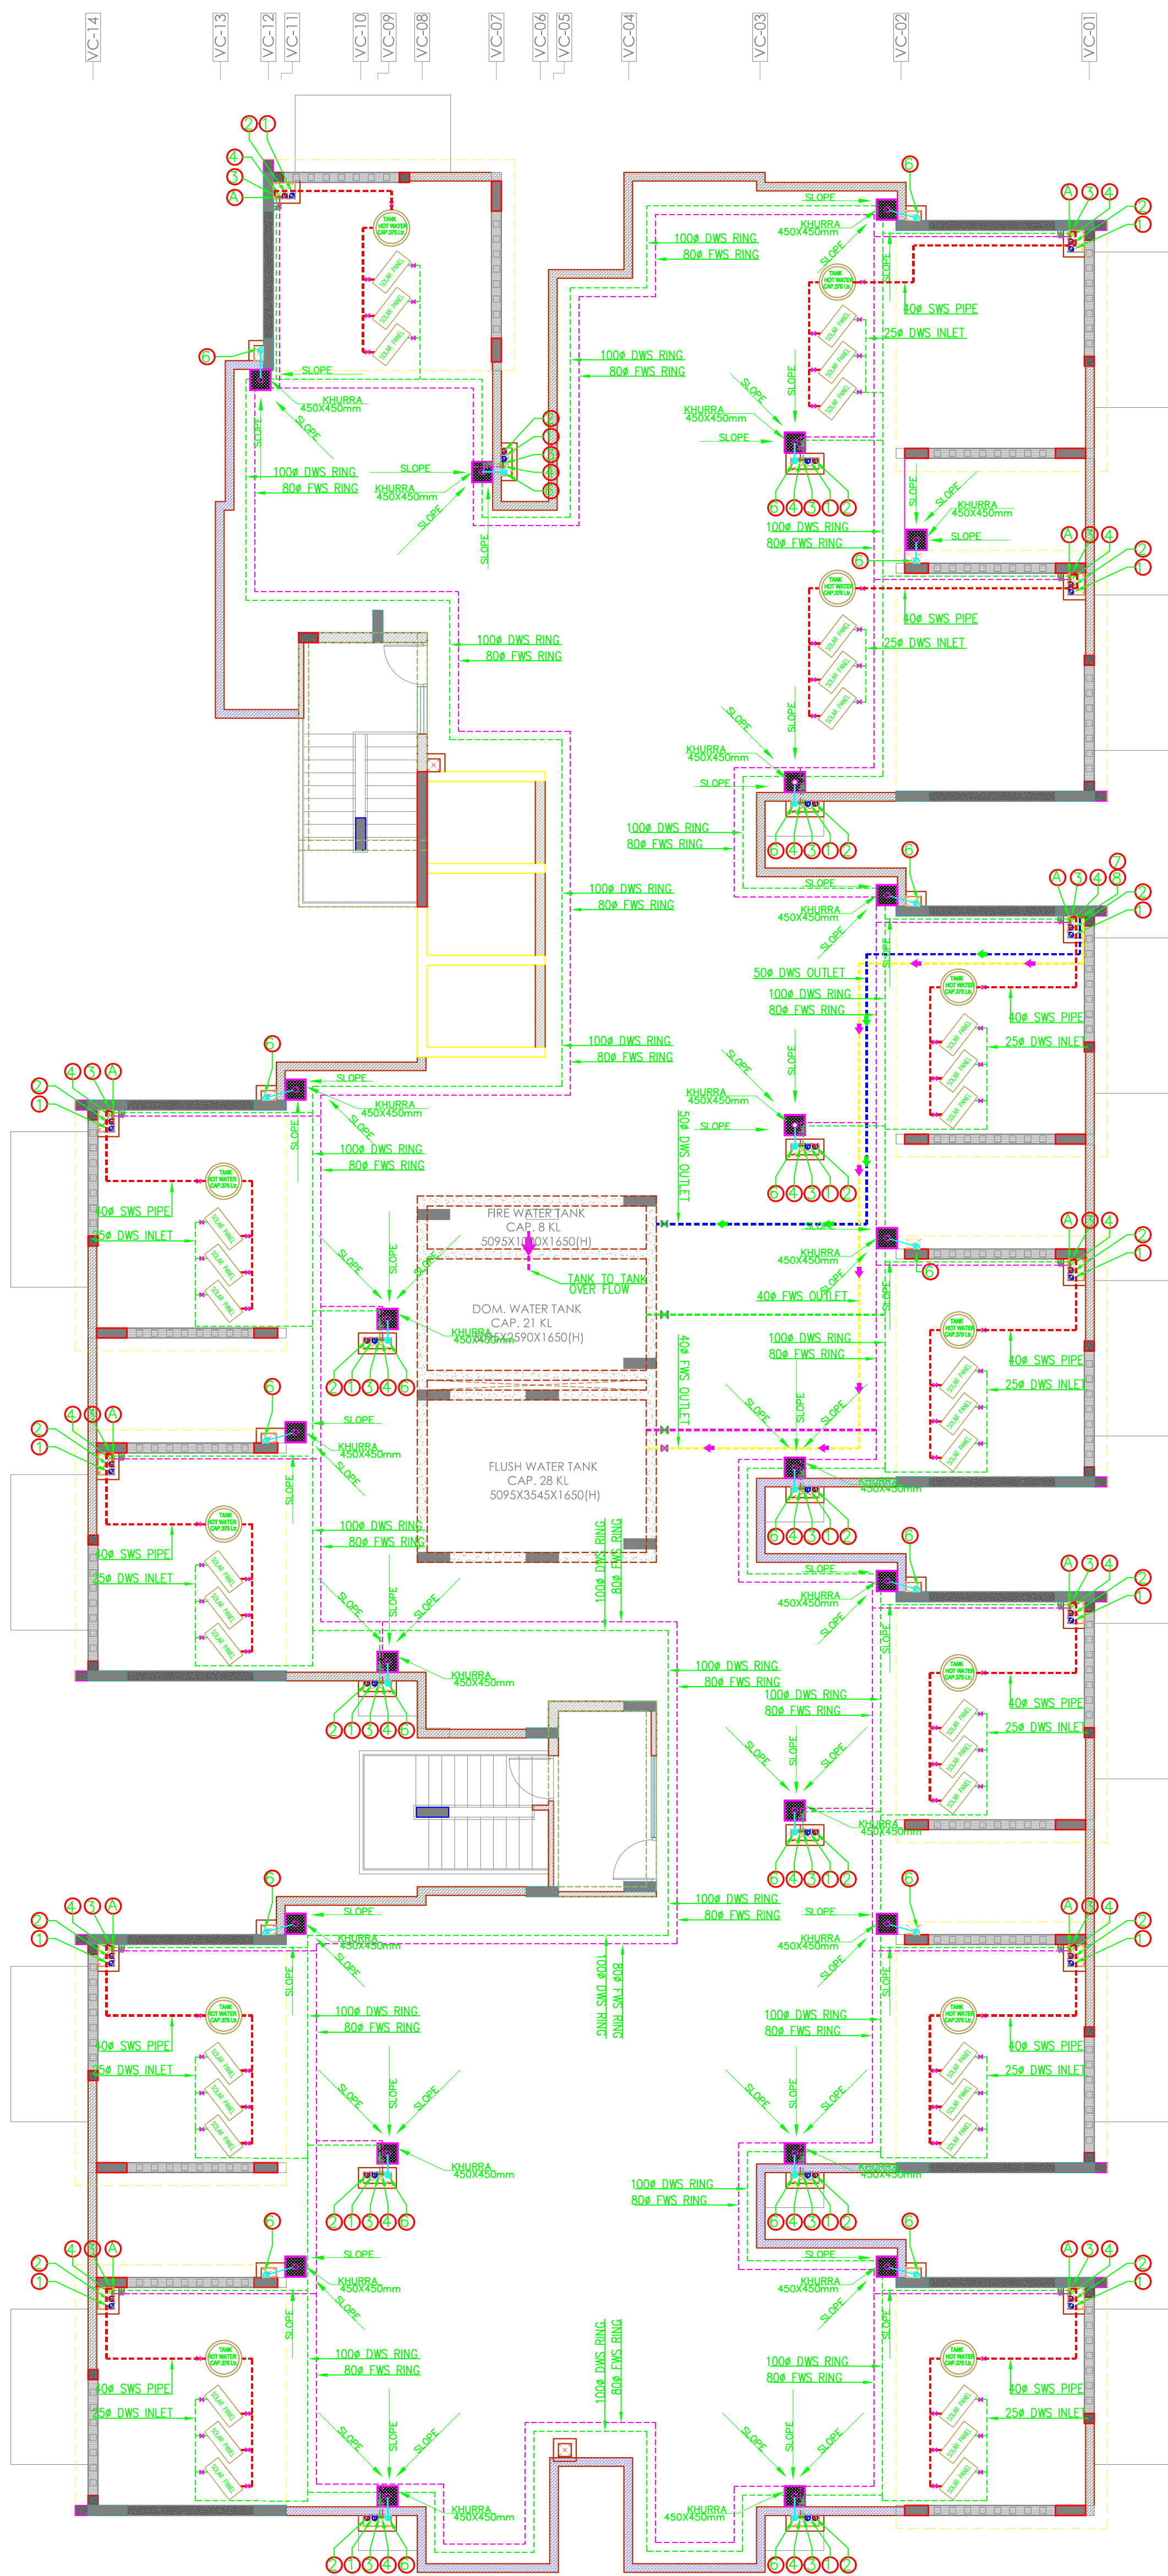

TYPICAL FLOOR BRICKWORK PLAN_BLOCK -C

SCHEDULE OF PIPES

PIPE NO.	DESCRIPTION
1	110 OD uPVC SOIL
2	110 OD uPVC WASTE
3	DOMESTIC WATER SUPPLY D/N TAKE PIPE *
4	FLUSHING WATER SUPPLY D/N TAKE PIPE *
5	90 OD uPVC RAIN WATER PIPE FOR BALCONY
6	110 OD uPVC RAIN WATER PIPE FOR TERRACE
7	DOMESTIC WATER SUPPLY RISER PIPE *
8	FLUSHING WATER SUPPLY RISER PIPE *
A	SOLER WATER SUPPLY D/N TAKE PIPE FOR KITCHEN

LEGEND:-

	DOMESTIC WATER SUPPLY D/N TAKE
	FLUSHING WATER SUPPLY D/N TAKE
	SOLAR WATER SUPPLY D/N TAKE
	FLUSHING WATER SUPPLY RISER
	DOMESTIC WATER SUPPLY RISER
DWS	DOMESTIC WATER SUPPLY
FWS	FLUSHING WATER SUPPLY
SWS	SOLAR WATER SUPPLY
	 BALL VALVE
	 PRESSURE REDUCE VALVE

VIPUL AGARWAL
M.E.P. CONSULTANT
B.E. ELECTRICAL

M.E.P. CONSULTANT

ASHI ASSOCIATES,
F 9 / 440 , Keshav Marg Chitrakut
Scheme,Jaipur
PH:91-0-93146-10438 ,0141-2440946
Mail:vipul8599@yahoo.com

PROJECT TITLE

PROPOSED
GROUP HOUSING
AT
SUKHIYA,JAIPUR


ARCHITECT

Ricky Mathur & Associates
architects interior designers planners
33, Dhuleshwar Garden,
Jaipur. (RAJ.) India. 302 001
Tel: 91-141-236 2688, 512 5444
Fax: 91-141-400 8700
e-mail: ricky@rickymathur.com

DRAWING TITLE

TERRACE PLAN
PLUMBING LAYOUT

SCALE	NTS A1	DATE	20-09-17
DEALT BY	DK GOLA	STATUS	CONCEPT
NORTH	DRG NO.	REVISION	
	PL-BA-BD-TER-01		

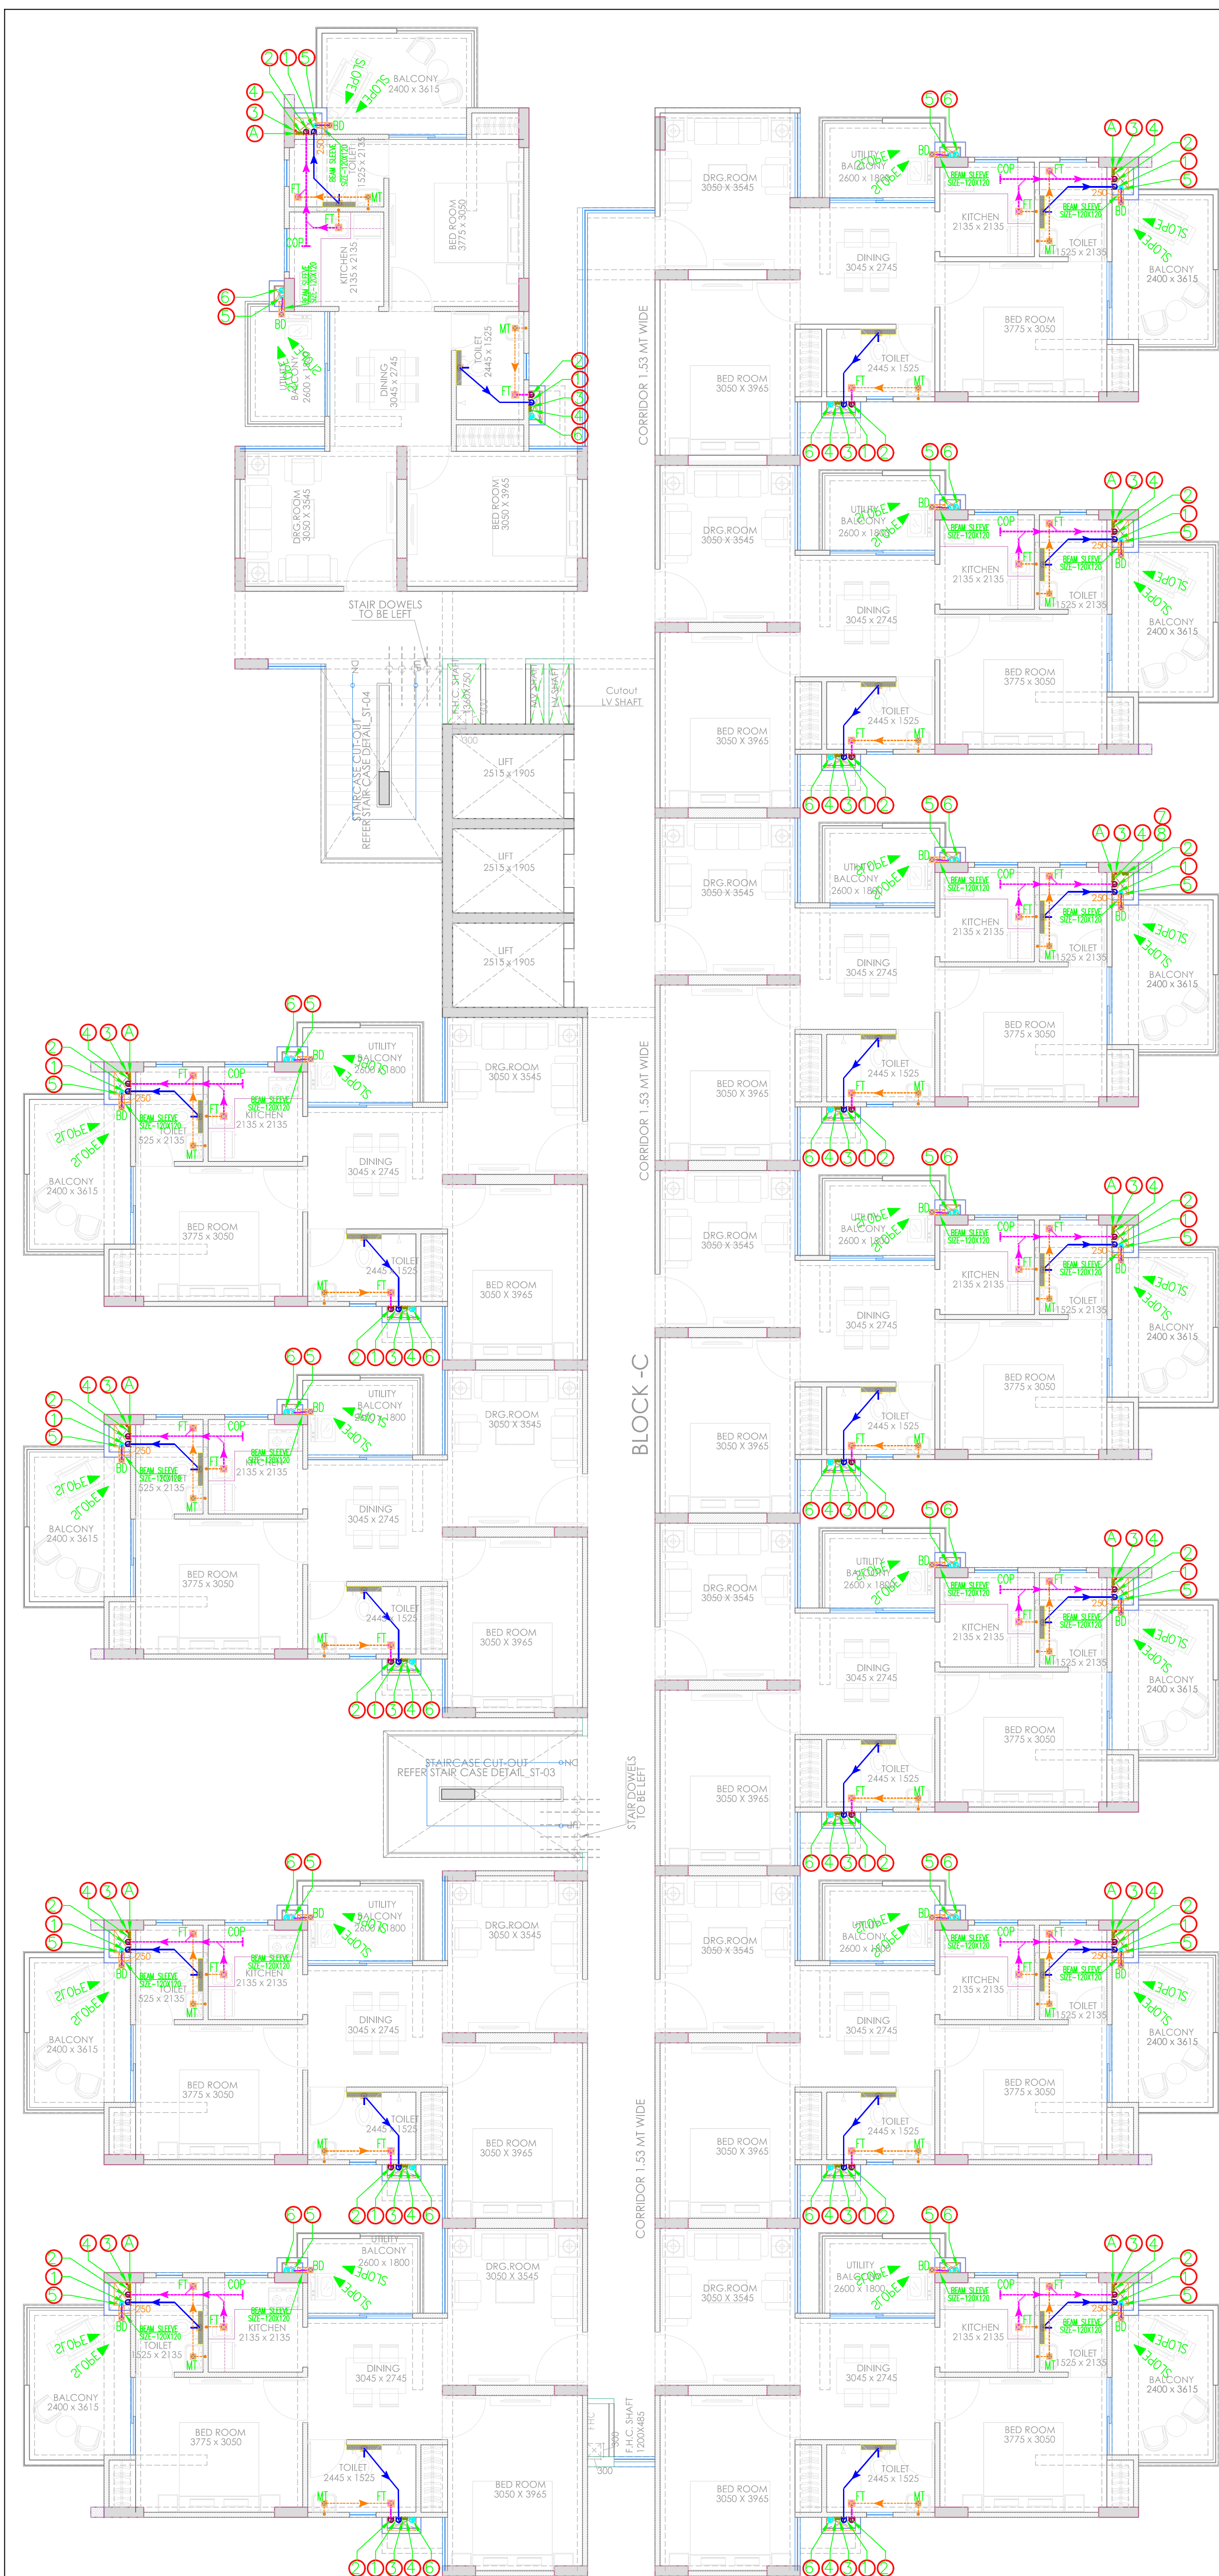

PLUMBING NOTES:-

- WASH BASIN TO FLOOR DRAIN (FD) 40 OD uPVC
- FLOOR DRAIN (FD) TO FLOOR TRAP (FT) 63 OD uPVC WASTE PIPE.
- FLOOR TRAP (FT) TO VERTICAL PIPE 110 OD uPVC
- 110 OD uPVC PIPE USED FOR SOIL & WASTE.
- 110 OD uPVC PIPE USED FOR TERRACE RAIN WATER
- 90 OD uPVC PIPE USED FOR BALCONY.


SCHEDULE OF PIPES

PIPE NO.	DESCRIPTION
1	110 OD uPVC SOIL
2	110 OD uPVC WASTE
3	DOMESTIC WATER SUPPLY D/N TAKE PIPE *
4	FLUSHING WATER SUPPLY D/N TAKE PIPE *
5	90 OD uPVC RAIN WATER PIPE FOR BALCONY
6	110 OD uPVC RAIN WATER PIPE FOR TERRACE
7	DOMESTIC WATER SUPPLY RISER PIPE *
8	FLUSHING WATER SUPPLY RISER PIPE *
A	SOLER WATER SUPPLY D/N TAKE PIPE FOR KITCHEN

FT FLOOR TRAP (110X110mm)

FD FLOOR DRAIN (110X63mm)

BD BALCONY DRAIN

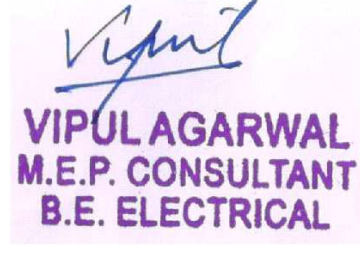

VIPUL AGARWAL
M.E.P. CONSULTANT
B.E. ELECTRICAL


MEP CONSULTANT

ASHI ASSOCIATES,
F 9 / 440 , Keshav Marg Chitrakut Scheme,Jaipur
PH:91-0-93146-10438 ,0141-2440946
Mail:vipul8599@yahoo.com

PROJECT TITLE

PROPOSED GROUP HOUSING AT SUKHIYA,JAIPUR


ARCHITECT

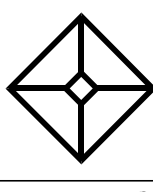


Ricky Mathur & Associates
architects interior designers planners
33, Dhuleshwar Garden, Jaipur. (RAJ.) India. 302 001
Tel: 91-141-236 2688, 512 5444
Fax: 91-141-400 8700
e-mail: ricky@rickymathur.com

DRAWING TITLE

TYPICAL FLOOR(1st to 14th) PLUMBING PLAN C-BLOCK

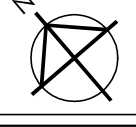
SCALE	NTS A1	DATE	18.12.2015
DEALT BY	M.SINGH	STATUS	CONCEPT
NORTH	DRG. NO.	REVISION	
	PL-BA-RMA/AK/01		

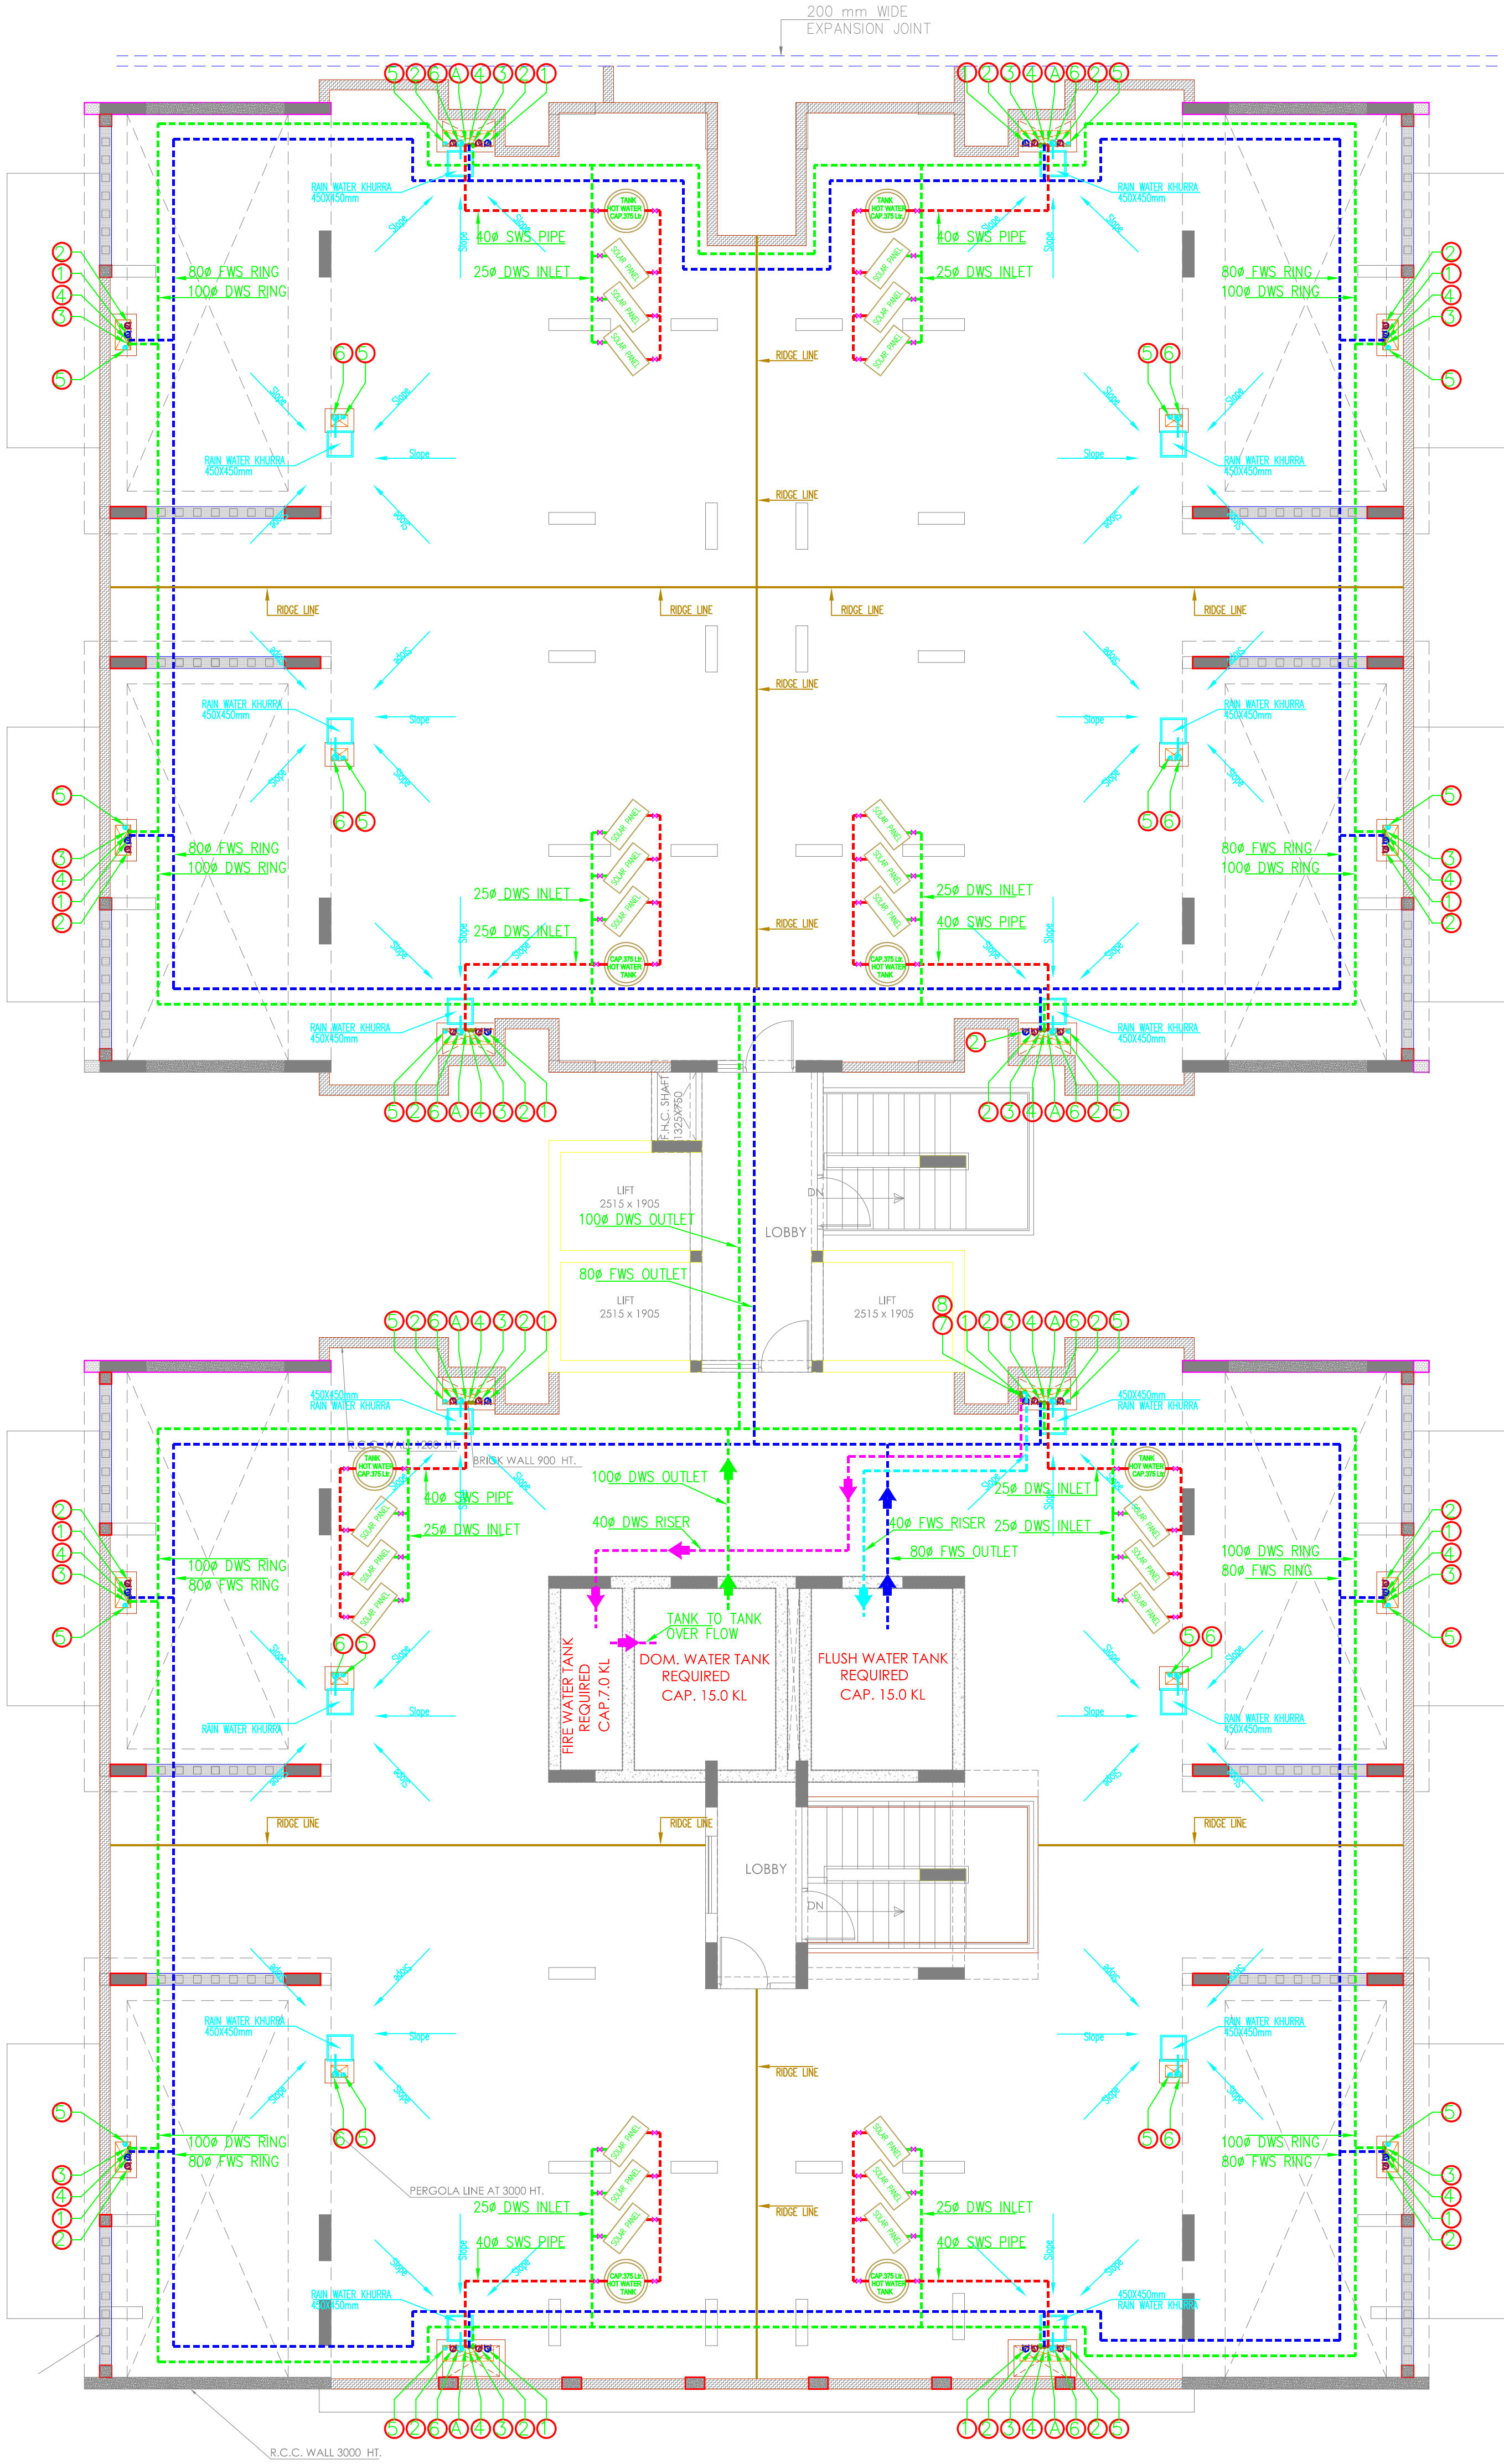

TERRACE FLOOR PLAN_BLOCK - D

SCHEDULE OF PIPES	
PIPE NO.	DESCRIPTION
1	110 OD uPVC SOIL
2	110 OD uPVC WASTE
3	DOMESTIC WATER SUPPLY D/N TAKE PIPE *
4	FLUSHING WATER SUPPLY D/N TAKE PIPE *
5	90 OD uPVC RAIN WATER PIPE FOR BALCONY
6	110 OD uPVC RAIN WATER PIPE FOR TERRACE
7	DOMESTIC WATER SUPPLY RISER PIPE *
8	FLUSHING WATER SUPPLY RISER PIPE *
A	SOLER WATER SUPPLY D/N TAKE PIPE FOR KITCHEN

LEGEND:-	
—	DOMESTIC WATER SUPPLY D/N TAKE
—	FLUSHING WATER SUPPLY D/N TAKE
—	SOLAR WATER SUPPLY D/N TAKE
—	FLUSHING WATER SUPPLY RISER
—	DOMESTIC WATER SUPPLY RISER
DWS	DOMESTIC WATER SUPPLY
FWS	FLUSHING WATER SUPPLY
SWS	SOLAR WATER SUPPLY
	 BALL VALVE
	 PRESSURE REDUCE VALVE

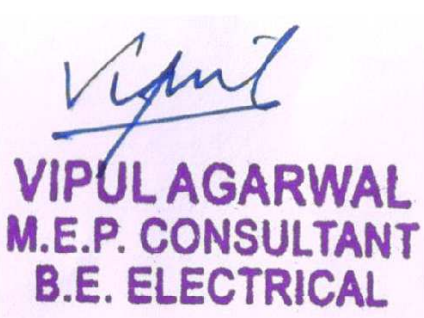

VIPUL AGARWAL
M.E.P. CONSULTANT
B.E. ELECTRICAL


MEP CONSULTANT

ASHI ASSOCIATES,
F 9 / 440 , Keshav Marg Chitrakut
Scheme,Jaipur
PH:91-0-93146-10438 ,0141-2440946
Mail:vipul8599@yahoo.com

PROJECT TITLE

**PROPOSED
GROUP HOUSING
AT
SUKHIYA,JAIPUR**


ARCHITECT

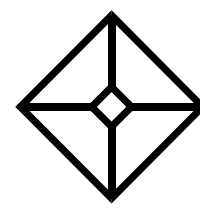

Ricky Mathur & Associates
architects interior designers planners
33, Dhuleshwar Garden,
Jaipur. (RAJ.) India. 302 001
Tel: 91-141-236 2688, 512 5444
Fax: 91-141-400 8700
e-mail: ricky@rickymathur.com

DRAWING TITLE

**TERRACE FLOOR PLAN
BLOCK-D**

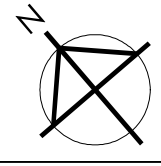SCALE	NTS A1	DATE	01-09-2017
DEALT BY	M.SINGH	STATUS	EXECUTION
NORTH		DRG NO.	REVISION
		PL-BA-BD-TER-07	R-01




LINE

PLUMBING NOTES:-

1. WASH BASIN TO FLOOR DRAIN (FD) 40 OD uPVC
2. FLOOR DRAIN (FD) TO FLOOR TRAP (FT) 63 OD uPVC WASTE PIPE.
3. FLOOR TRAP (FT) TO VERTICAL PIPE 110 OD uPVC
4. 110 OD uPVC PIPE USED FOR SOIL & WASTE.
5. 110 OD uPVC PIPE USED FOR TERRACE RAIN WATER
6. 90 OD uPVC PIPE USED FOR BALCONY.

SCHEDULE OF PIPES

PIPE NO.	DESCRIPTION
1	110 OD uPVC SOIL
2	110 OD uPVC WASTE
3	DOMESTIC WATER SUPPLY D/N TAKE PIPE *
4	FLUSHING WATER SUPPLY D/N TAKE PIPE *
5	90 OD uPVC RAIN WATER PIPE FOR BALCONY
6	110 OD uPVC RAIN WATER PIPE FOR TERRACE
7	DOMESTIC WATER SUPPLY RISER PIPE *
8	FLUSHING WATER SUPPLY RISER PIPE *
A	SOLER WATER SUPPLY D/N TAKE PIPE FOR KITCHEN
FT	FLOOR TRAP (110X110mm)
FD	FLOOR DRAIN (110X63mm)
BD	BALCONY DRAIN (110X63mm)

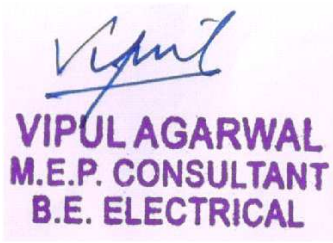

MEP CONSULTANT

ASHI ASSOCIATES,
F 9 / 440 , Keshav Marg Chitrakut
Scheme,Jaipur
PH:91-0-93146-10438 ,0141-2440946
Mail:vipul8599@yahoo.com

PROJECT TITLE

PROPOSED
GROUP HOUSING
AT
SUKHIYA,JAIPUR


ARCHITECT

Ricky Mathur & Associates
architects interior designers planners
33, Dhuleshwar Garden,
Jaipur. (RAJ.) India. 302 001
Tel: 91-141-236 2688, 512 5444
Fax: 91-141-400 8700
e-mail: ricky@rickymathur.com

DRAWING TITLE

TYPICAL FLOOR(1st to 14th)
PLUMBING PLAN
D-BLOCK

SCALE	NTS A1	DATE	12-11-2015
DEALT BY	M.SINGH	STATUS	CONCEPT
NORTH		DRG NO.	REVISION
		PL-BA-RMA/AK/02	

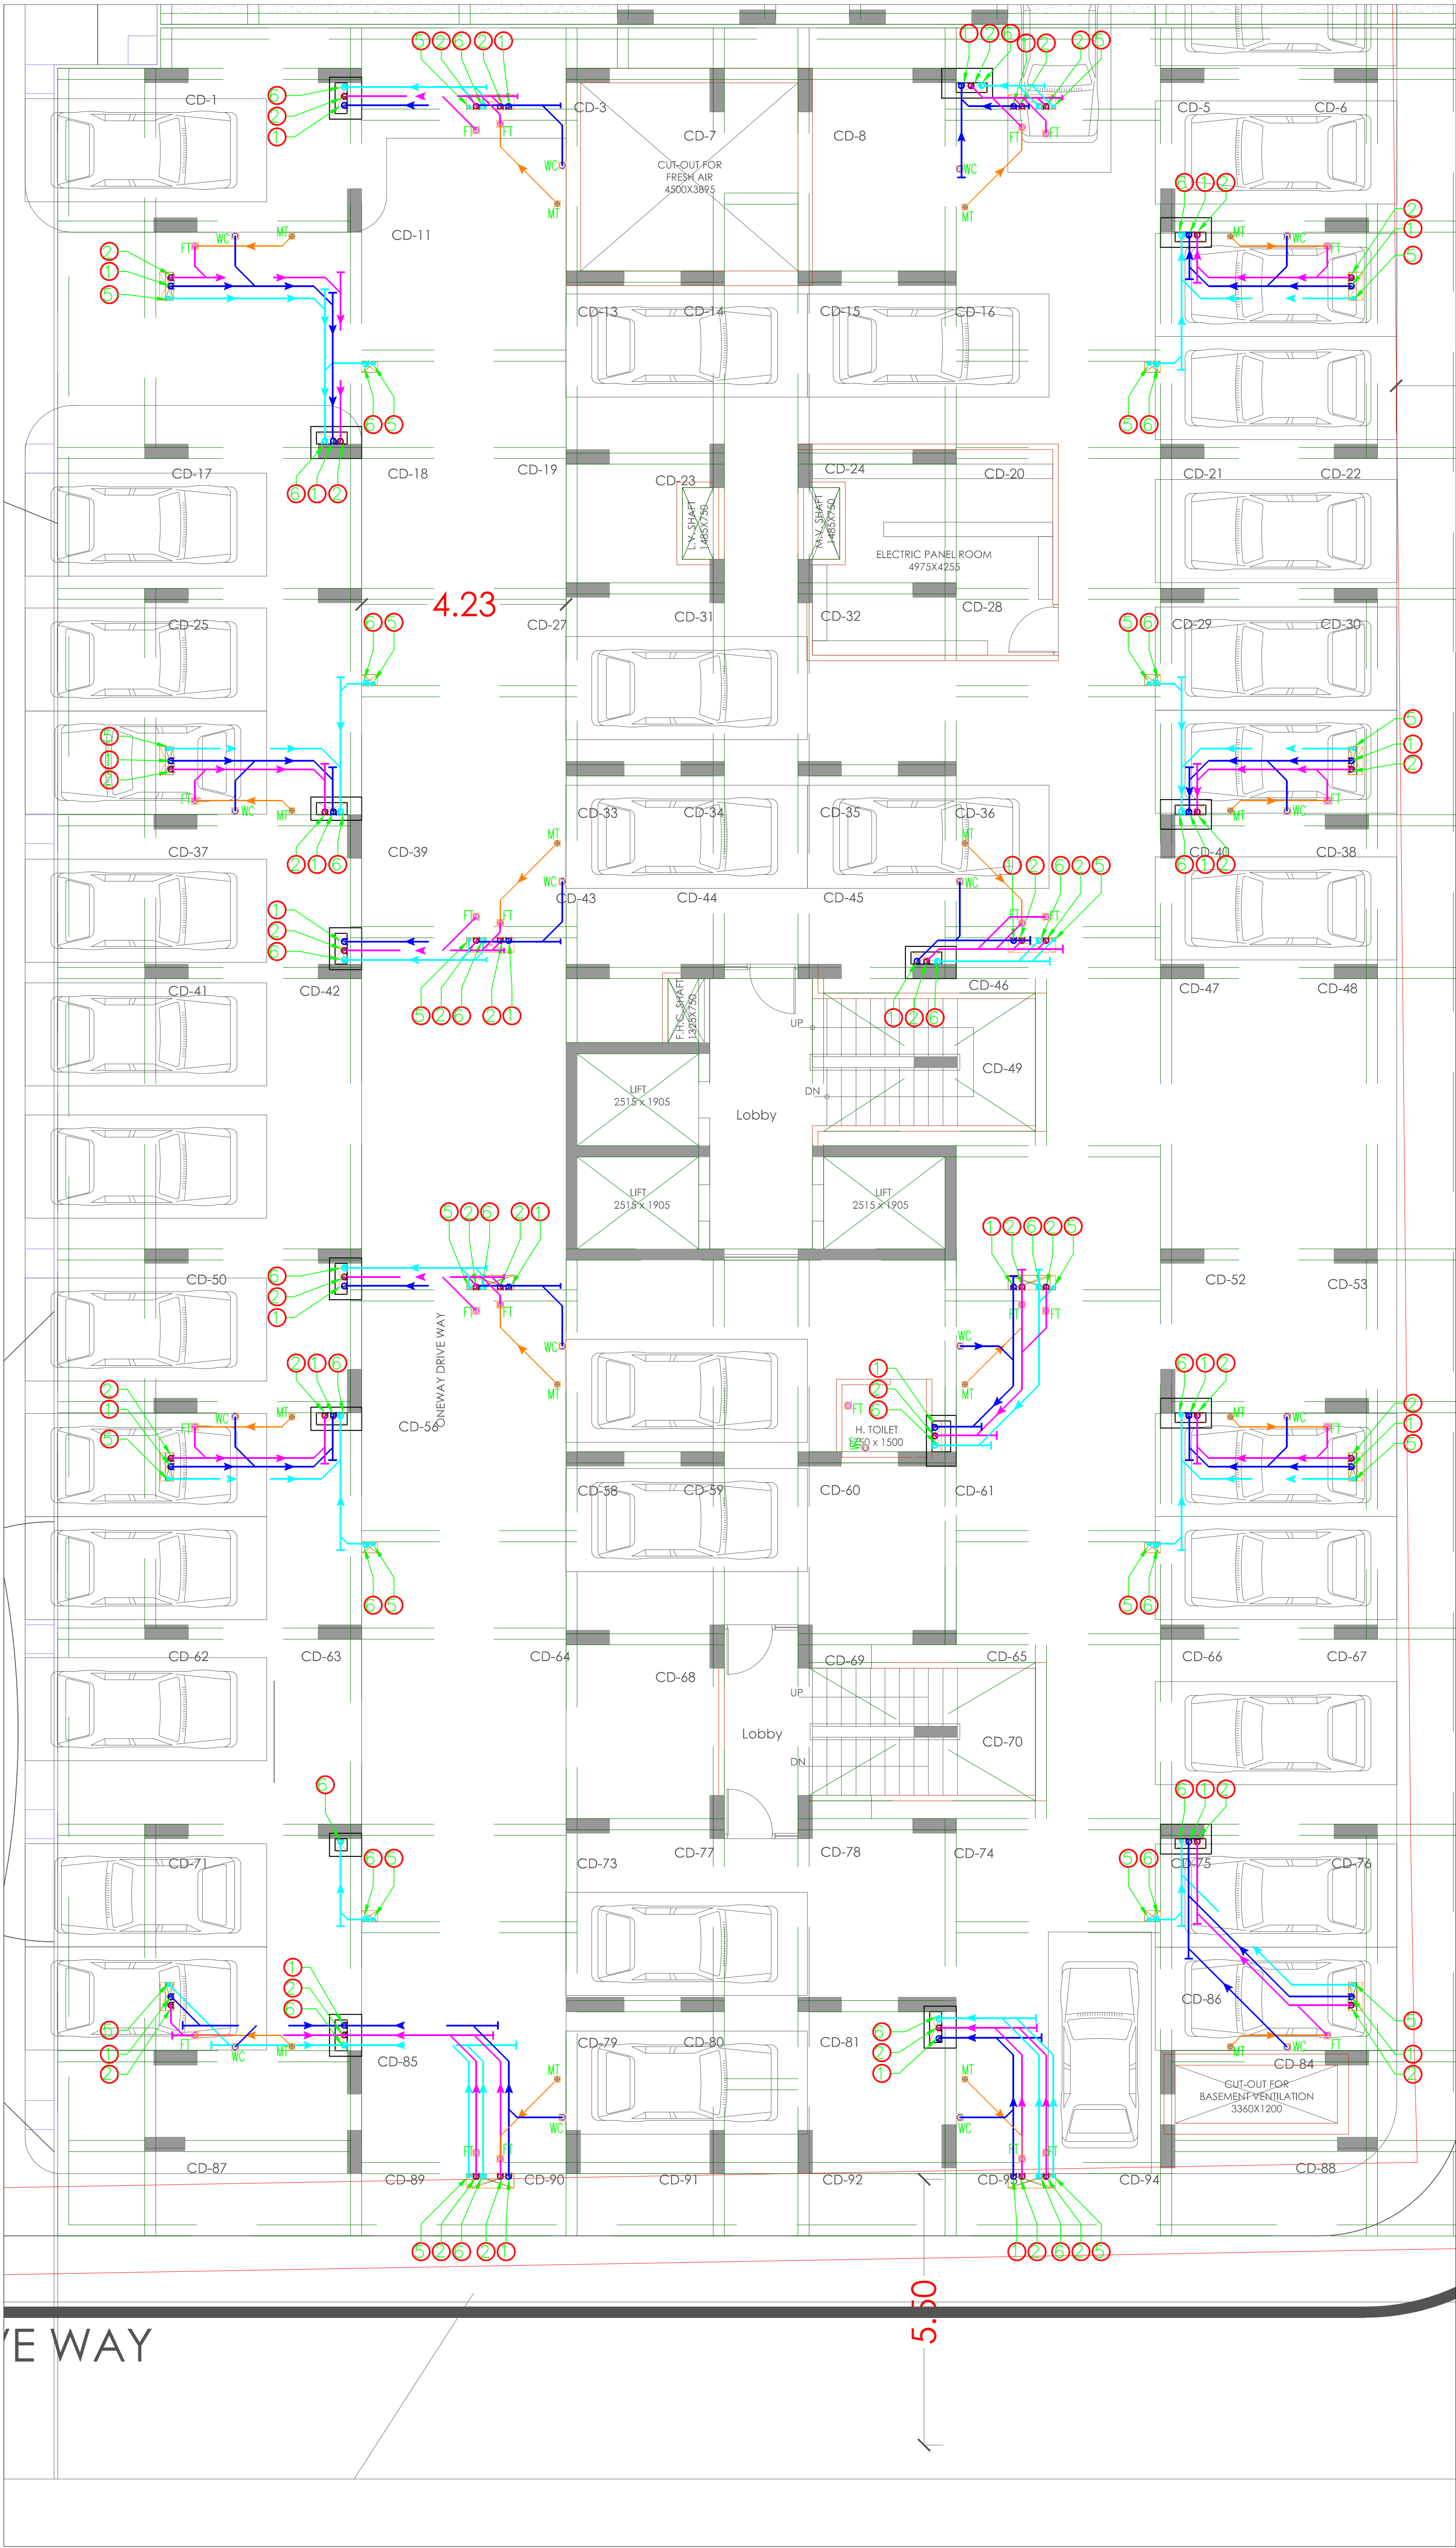

SCHEDULE OF PIPES	
PIPE NO.	DESCRIPTION
1	110 OD uPVC SOIL
2	110 OD uPVC WASTE
3	DOMESTIC WATER SUPPLY D/N TAKE PIPE *
4	FLUSHING WATER SUPPLY D/N TAKE PIPE *
5	90 OD uPVC RAIN WATER PIPE FOR BALCONY
6	110 OD uPVC RAIN WATER PIPE FOR TERRACE
7	DOMESTIC WATER SUPPLY RISER PIPE *
8	FLUSHING WATER SUPPLY RISER PIPE *
A	SOLER WATER SUPPLY D/N TAKE PIPE FOR KITCHEN
FT	FLOOR TRAP (110X110mm)
FD	FLOOR DRAIN (110X63mm)
WC	WATER CLOSET (110X110mm)