



24 M.WIDE ROAD

24 M.WIDE ROAD

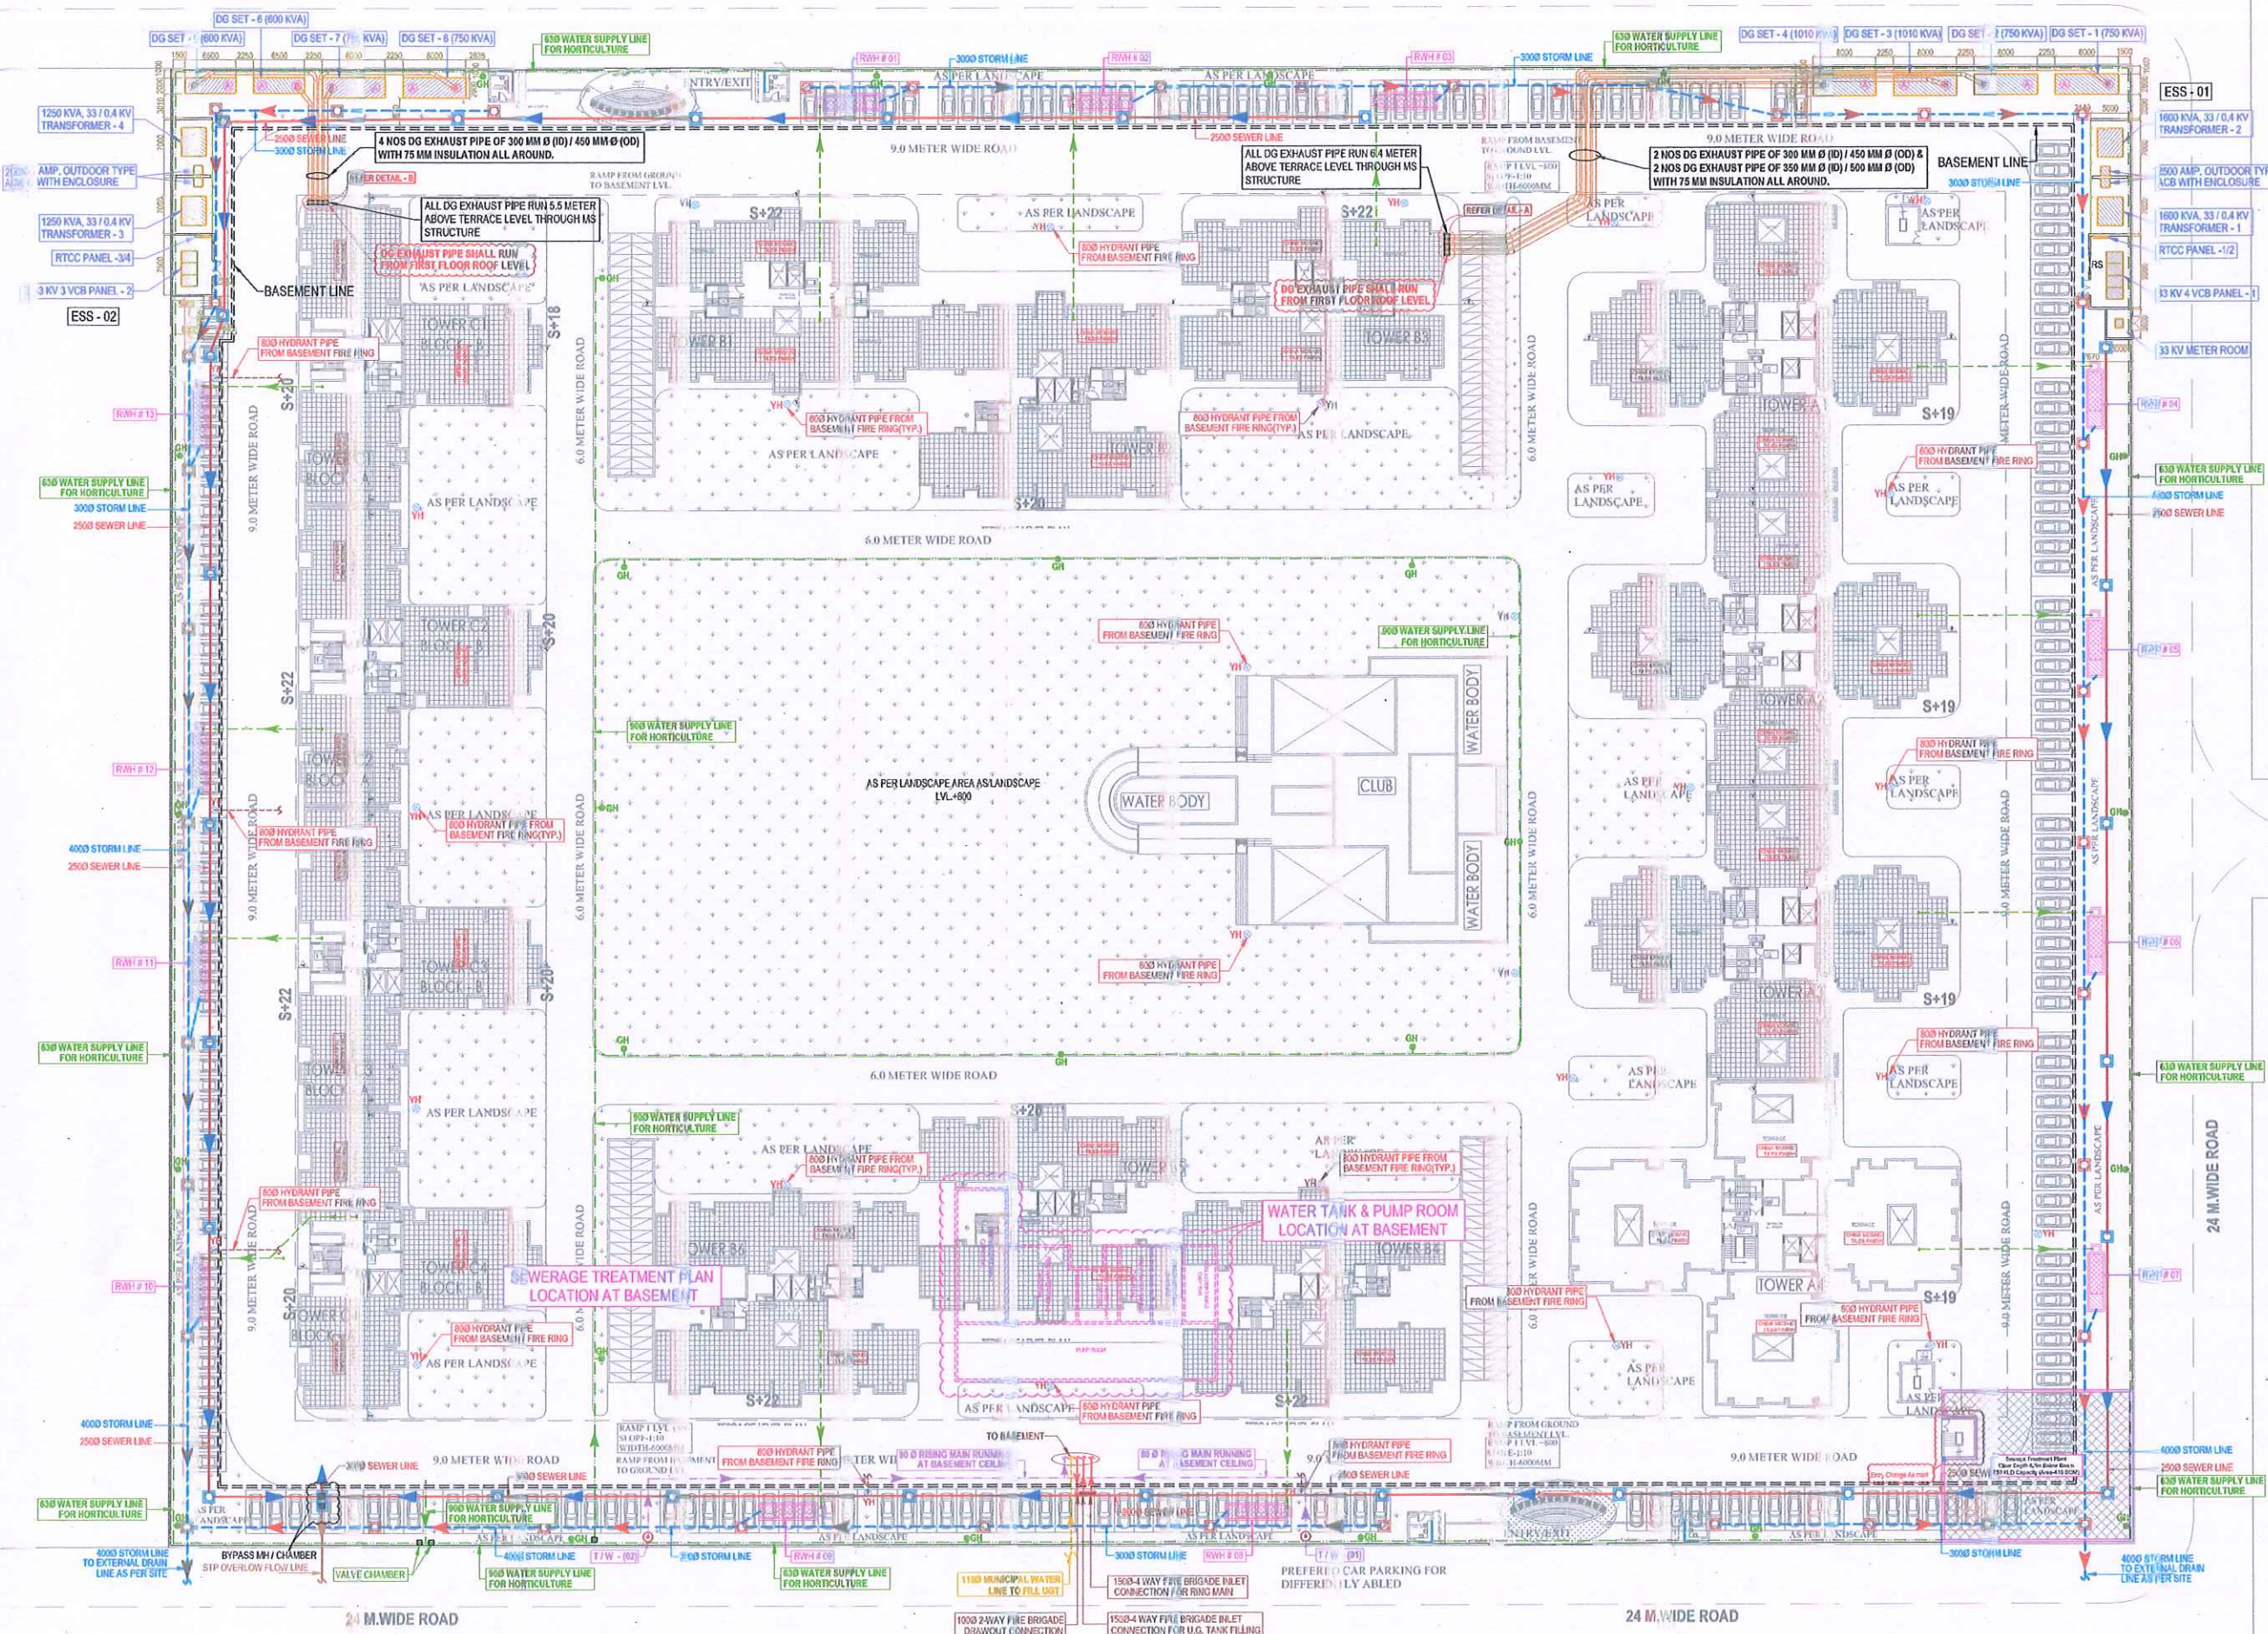

KEY PLAN

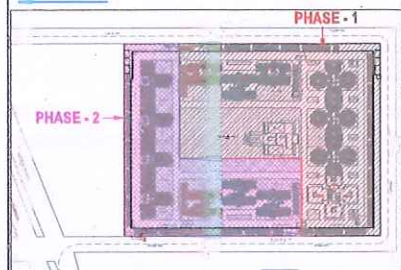

LEGEND :

S. No.	SYMBOL	DESCRIPTION
1.	C.P.	CATCH PIT
2.	UNDER GROUND PIPE DRAIN	
3.	M.H.	MANHOLE
4.	SEWER LINE	
5.	PROPOSED TUBE WELL	
6.	RISEING MAIN LINE (FROM DW TO U.G.T.)	
7.	MUNICIPAL WATER SUPPLY PIPE LINE	
8.	RECYCLED WATER SUPPLY LINE FOR HORTICULTURE	
9.	GARDEN HYDRANT	
10.	MASONRY CHAMBER FOR ISOLATING VALVE	
11.	BASEMENT RETAINING WALL	
12.	PLOT LINE	
13.	DESILTING TANK 5000 X 1750 X 2000 mm RECHARGE PIT 2500 X 1750 X 1000 mm	
14.	FIRE LINE	
15.	FIRE BRIGADE CONNECTION	
16.	BUTTERFLY VALVE	
17.	NON-RETURN VALVE (CHECK VALVE)	
18.	ISOLATING VALVE WITH MASONRY CHAMBER	
19.	YARD HYDRANT 63 MM DIA. SINGLE HEADED HYDRANT VALVE WITH 2 NOS. 15 M. LONG, 63 MM. DIA. FIRE HOSE PIPE & 1 NO. BRANCH PIPE WITH NOZZLE	

R3	22.10.2016	Arch. Plan Revised
R2	31.07.2015	Revised as per requirement
R1	22.07.2015	Revised as per requirement
rev. no.	date	revision

project
**MANHATTAN GROUP HOUSING
AT LUCKNOW**

title
SITE PLAN

sub title
CO-ORDINATE LAYOUT

drawing released for
☒ APPROVAL ☐ SUBMISSION
☐ ADVANCE COPY ☐ CONSTRUCTION

drg. no. RM/PL-02 drawn by Imran

scale 1:425 designed by Shahr Shabbir

date July 2015 checked by Anand Havella

architects
dfi DESIGN FORUM INTERNATIONAL
K-47, NARAIN COLONY NEW DELHI-110028
PHONE: 011-46550100 FAX: 46550101

services consultant
Consummate Engineering Services (P) Ltd.
Noida Office : B-47, Sector - 67, Noida - 201301
Tel : (0120) 6143101 (24 Lines)
Lko. Office : P-066, Rohini Phase-I, Confl Nagar, Lucknow
e mail : mail@cespln, website : www.cespln