


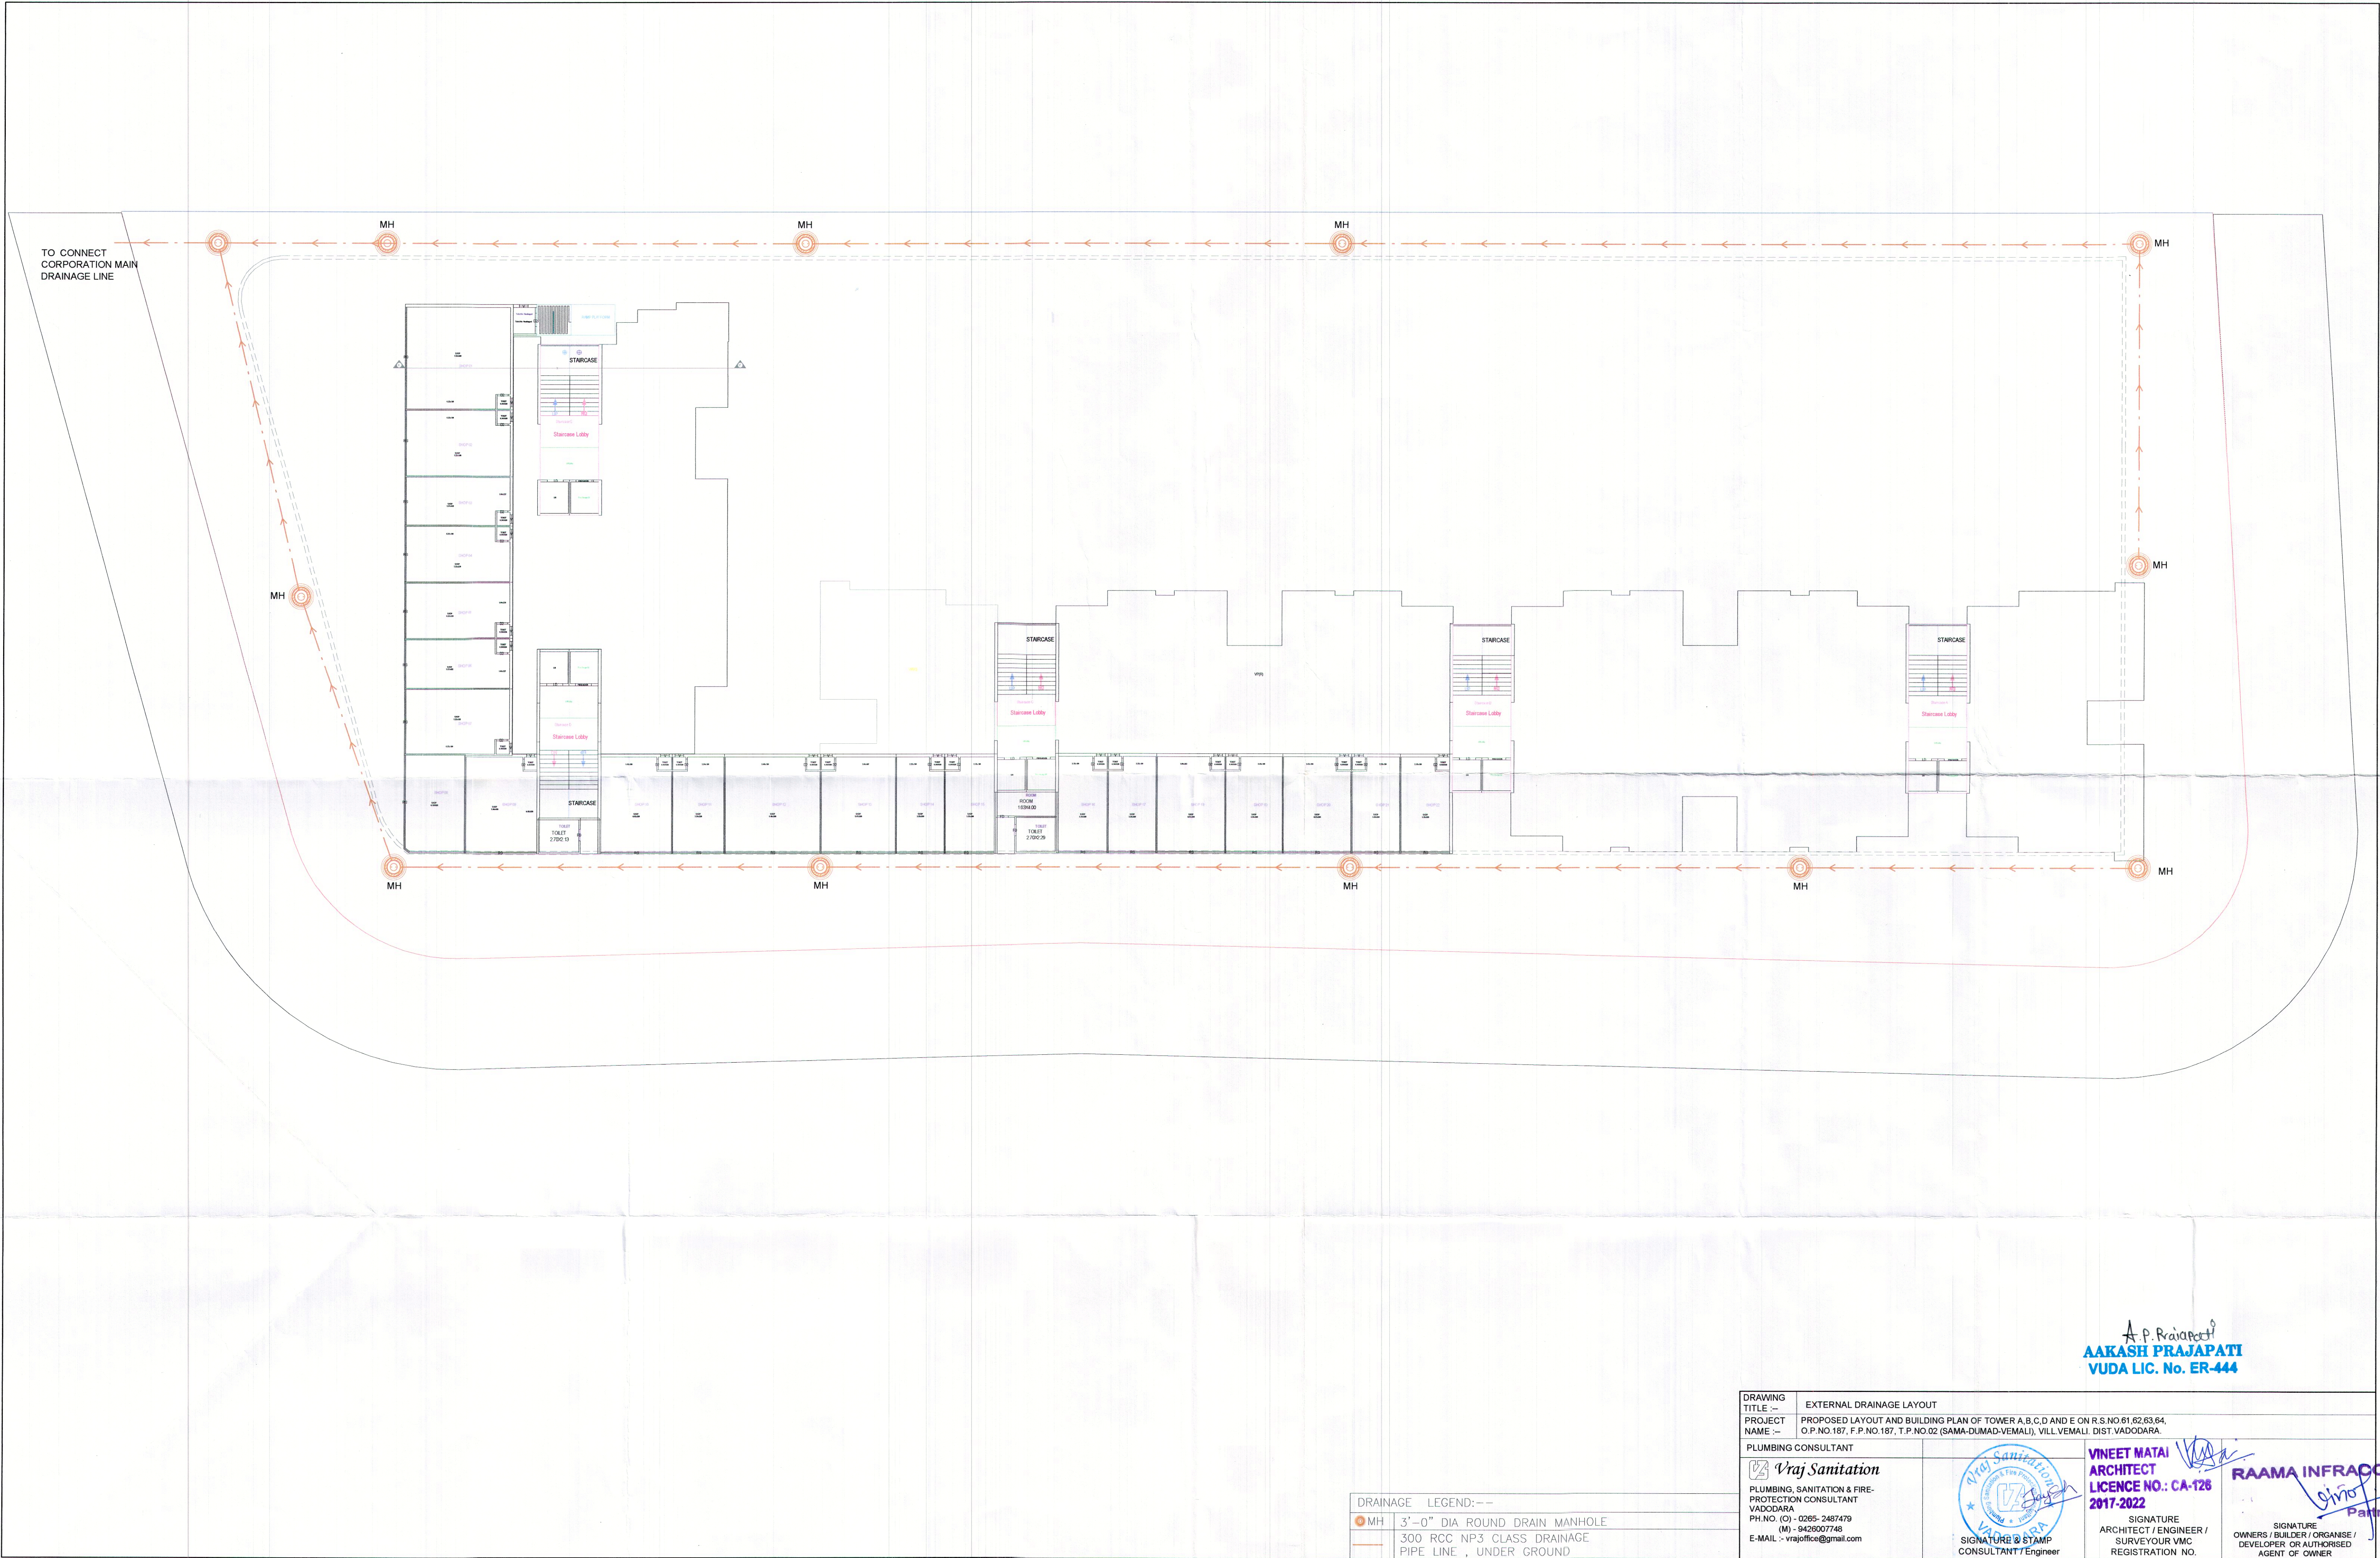

A.P. Prajapati
AAKASH PRAJAPATI
VUDA LIC. No. ER-444

DRAWING TITLE :-	EXTERNAL DRAINAGE LAYOUT		
PROJECT NAME :-	PROPOSED LAYOUT AND BUILDING PLAN OF TOWER A,B,C,D AND E ON R.S.NO.61,62,63,64, O.P.NO.187, F.P.NO.187, T.P.NO.02 (SAMA-DUMAD-VELALI), VILL VEMALI, DIST. VADODARA.		
PLUMBING CONSULTANT			
 Vraj Sanitation		VINEET MATAI ARCHITECT LICENCE NO. : CA-128 2017-2022	 RAAMA INFRA
PLUMBING, SANITATION & FIRE- PROTECTION CONSULTANT VADODARA PH.NO. (C) - 0265-2457479 (M) - 9429007746 E-MAIL - vrazoffice@gmail.com	SIGNATURE ARCHITECT / ENGINEER / SURVEYOR VMC REGISTRATION NO.		SIGNATURE OWNERS / BUILDER / ORGANISE / DEVELOPER OR AUTHORISED AGENT OF OWNER
SIGNATURE & STAMP CONSULTANT / Engineer			

DRAINAGE LEGEND:-	
 MH	3'-0" DIA ROUND DRAIN MANHOLE
	300 RCC NP3 CLASS DRAINAGE PIPE LINE , UNDER GROUND

Inward No	ODPS/2020/030931	Sheet	1
Inward Date		Scale	1:400

COLOR INDEX

PLOT BOUNDARY	
ABUTTING ROAD	
PROPOSED CONSTRUCTION	
COMMON PLOT	
ROAD ALIGNMENT (ROAD WIDENING AREA)	
FUTURE T.P.SCHEME DEDUCTION AREA	
EXISTING (To be retained)	
EXISTING (To be demolished)	

Floor Name	Building Name				Total		
	A B C D E (TOWER)		CLUB HOUSE (1)				
	Proposed Built Up Area (Sq.mt.)	Proposed FSI Area (Sq.mt.)	Proposed Built Up Area (Sq.mt.)	Proposed FSI Area (Sq.mt.)	Total Proposed Built Up Area (Sq.mt.)	Total FSI Area (Sq.mt.)	Total Paid FSI Area (Sq.mt.)
Basement Floor	5059.28	0.00	0.00	0.00	5059.28	0.00	0.00
Parking Floor	0.00	0.00	52.78	0.00	52.78	0.00	0.00
Ground Floor	1327.42	690.08	0.00	0.00	1327.42	690.08	0.00
First Floor	2023.95	1793.39	52.78	40.80	2076.73	1834.19	0.00
Second Floor	2023.95	1697.07	0.00	0.00	2023.95	1697.07	0.00
Third Floor	2023.95	1697.07	0.00	0.00	2023.95	1697.07	0.00
Fourth Floor	2023.95	1697.07	0.00	0.00	2023.95	1697.07	0.00
Fifth Floor	2023.95	1697.07	0.00	0.00	2023.95	1697.07	0.00
Sixth Floor	2023.95	1697.07	0.00	0.00	2023.95	1697.07	0.00
Seventh Floor	2023.95	1697.07	0.00	0.00	2023.95	1697.07	250.69
Eighth Floor	2023.95	1697.07	0.00	0.00	2023.95	1697.07	1697.07
Ninth Floor	2023.95	1697.07	0.00	0.00	2023.95	1697.07	1697.07
Tenth Floor	2023.95	1697.07	0.00	0.00	2023.95	1697.07	1697.07
Eleventh Floor	2023.95	1697.07	0.00	0.00	2023.95	1697.07	1697.07
Twelfth Floor	2023.95	1697.07	0.00	0.00	2023.95	1697.07	1697.07
Thirteenth Floor	2023.95	1697.07	0.00	0.00	2023.95	1697.07	1697.07
Fourteenth Floor	1135.36	904.80	0.00	0.00	1135.36	904.80	904.80
Terrace Floor	273.43	0.00	7.78	0.00	281.21	0.00	0.00
Total:	34106.84	23753.11	113.34	40.80	34220.18	23763.91	11337.91

Building	No. of Same Bldg	Total Built Up Area (Sq.ft.)	Deductions (Area in Sq.ft.)							Proposed FSI Area (Sq.ft.)		Total FSI Area (Sq.ft.)	No. of Unit	
			StairCase	Stair Lobby	Lift	Lift Machine	Lift Lobby	Ramp	Refuge Area	Parking	Resi.			Commercial
A B C D E (TOWER)	1	34106.84	1622.05	703.11	776.00	48.50	724.71	267.87	1155.84	5055.65	23063.03	690.08	23753.11	294
CLUB HOUSE (Total)	1	113.34	23.34	4.20	0.00	0.00	0.00	0.00	0.00	45.00	40.80	0.00	40.80	01
Grand Total:	2	34220.18	1645.39	707.31	776.00	48.50	724.71	267.87	1155.84	5100.65	23103.83	690.08	23793.91	295

Plot	Name	Nos Of Trees	
		Reqd	Prop
R.S.NO.61,62,63,64 O.P.NO. 187 F.P.NO. 187 T.P.NO.02 (SAMA-DUMAD-VEMALI)	Tree	175	175

Use Type	Car				Visitor's Car Parking				Total Parking Area			
	Area		No.		Area		No.		Area		No.	
	Reqd.	Prop.	Reqd.	Prop.	Reqd.	Prop.	Reqd.	Prop.	Reqd.	Prop.	Reqd.	Prop.
Residential	2308.30	3607.88	0	0	461.26	1021.66	0	2	4612.60	4629.54	-	-
Commercial	172.52	352.55	0	0	69.01	118.50	0	1	345.04	471.11	-	-
Total	2478.82	3960.43	0	0	530.27	1140.21	0	3	4957.64	5100.65	-	-

Building Name	Building Use	Building SubUse	Building Use Group	No Of Residential Units	No Of Non-Residential Units	Floor Name	Floor Use	Floor SubUse	FSI Name	FSI Use	FSI SubUse
A B C D E (TOWER)	Mercantile	ResiComm Building	Mercantile-1 (M1)	271	23	BASEMENT FLOOR PLAN	Mercantile	ResiComm Building	-	-	-
						GROUND FLOOR PLAN	Mercantile	Shop	Residential FSI	Residential	Residential Apartment Bldg
									Residential FSI	Residential	Residential Apartment Bldg
									Residential FSI	Residential	Residential Apartment Bldg
									Commercial FSI	Mercantile	Shop
						FIRST FLOOR PLAN	Residential	Residential Apartment Bldg	Residential FSI	Residential	Residential Apartment Bldg
									Residential FSI	Residential	Residential Apartment Bldg
									Residential FSI	Residential	Residential Apartment Bldg
									Residential FSI	Residential	Residential Apartment Bldg
						TYPICAL - 2, 3, 4, 5, 6, 7, 8, 9, 10, 11, 12, 13 FLOOR PLAN	Residential	Residential Apartment Bldg	Residential FSI	Residential	Residential Apartment Bldg
									Residential FSI	Residential	Residential Apartment Bldg
									Residential FSI	Residential	Residential Apartment Bldg
									Residential FSI	Residential	Residential Apartment Bldg
						FOURTEENTH FLOOR PLAN	Residential	Residential Apartment Bldg	Residential FSI	Residential	Residential Apartment Bldg
Residential FSI	Residential	Residential Apartment Bldg									
Residential FSI	Residential	Residential Apartment Bldg									
Residential FSI	Residential	Residential Apartment Bldg									
TERRACE FLOOR PLAN	Mercantile	ResiComm Building	-	-	-						
CLUB HOUSE (1)	Residential	Detached Dwelling Unit	Dwelling-1 (DW1)	1	0	PARKING FLOOR PLAN	Residential	Detached Dwelling Unit	-	-	-
						FIRST FLOOR PLAN	Residential	Detached Dwelling Unit	Residential FSI	Residential	Detached Dwelling Unit
						TERRACE FLOOR PLAN	Residential	Detached Dwelling Unit	-	-	-

Building Name	Type	SubUse	Area	Units		Required Parking Area(Sq.mt.)	Car	Other Parking Visitor's Car Parking
				Regd.	Prop.			
A B C D E (TOWER)	Residential	Residential Apartment Bldg	0.0 - 80	1	23063.01	4612.60	2306.30	461.26
			> 80.0	-				
			0 - 0	-				
	Mercantile	Shop	> 0	1	690.08	345.04	172.52	69.01
			0 - 0	-				
			0 - 0	-				
			0 - 1000	1000				
Total:						4957.64	-	530.27

Name	Prop. Area
COMMON PLOT	765.50



Vinodkumar J Jair

STRUCTURE ENGINEER

003ERH3103250028

DESIGNATION OF APPROVER



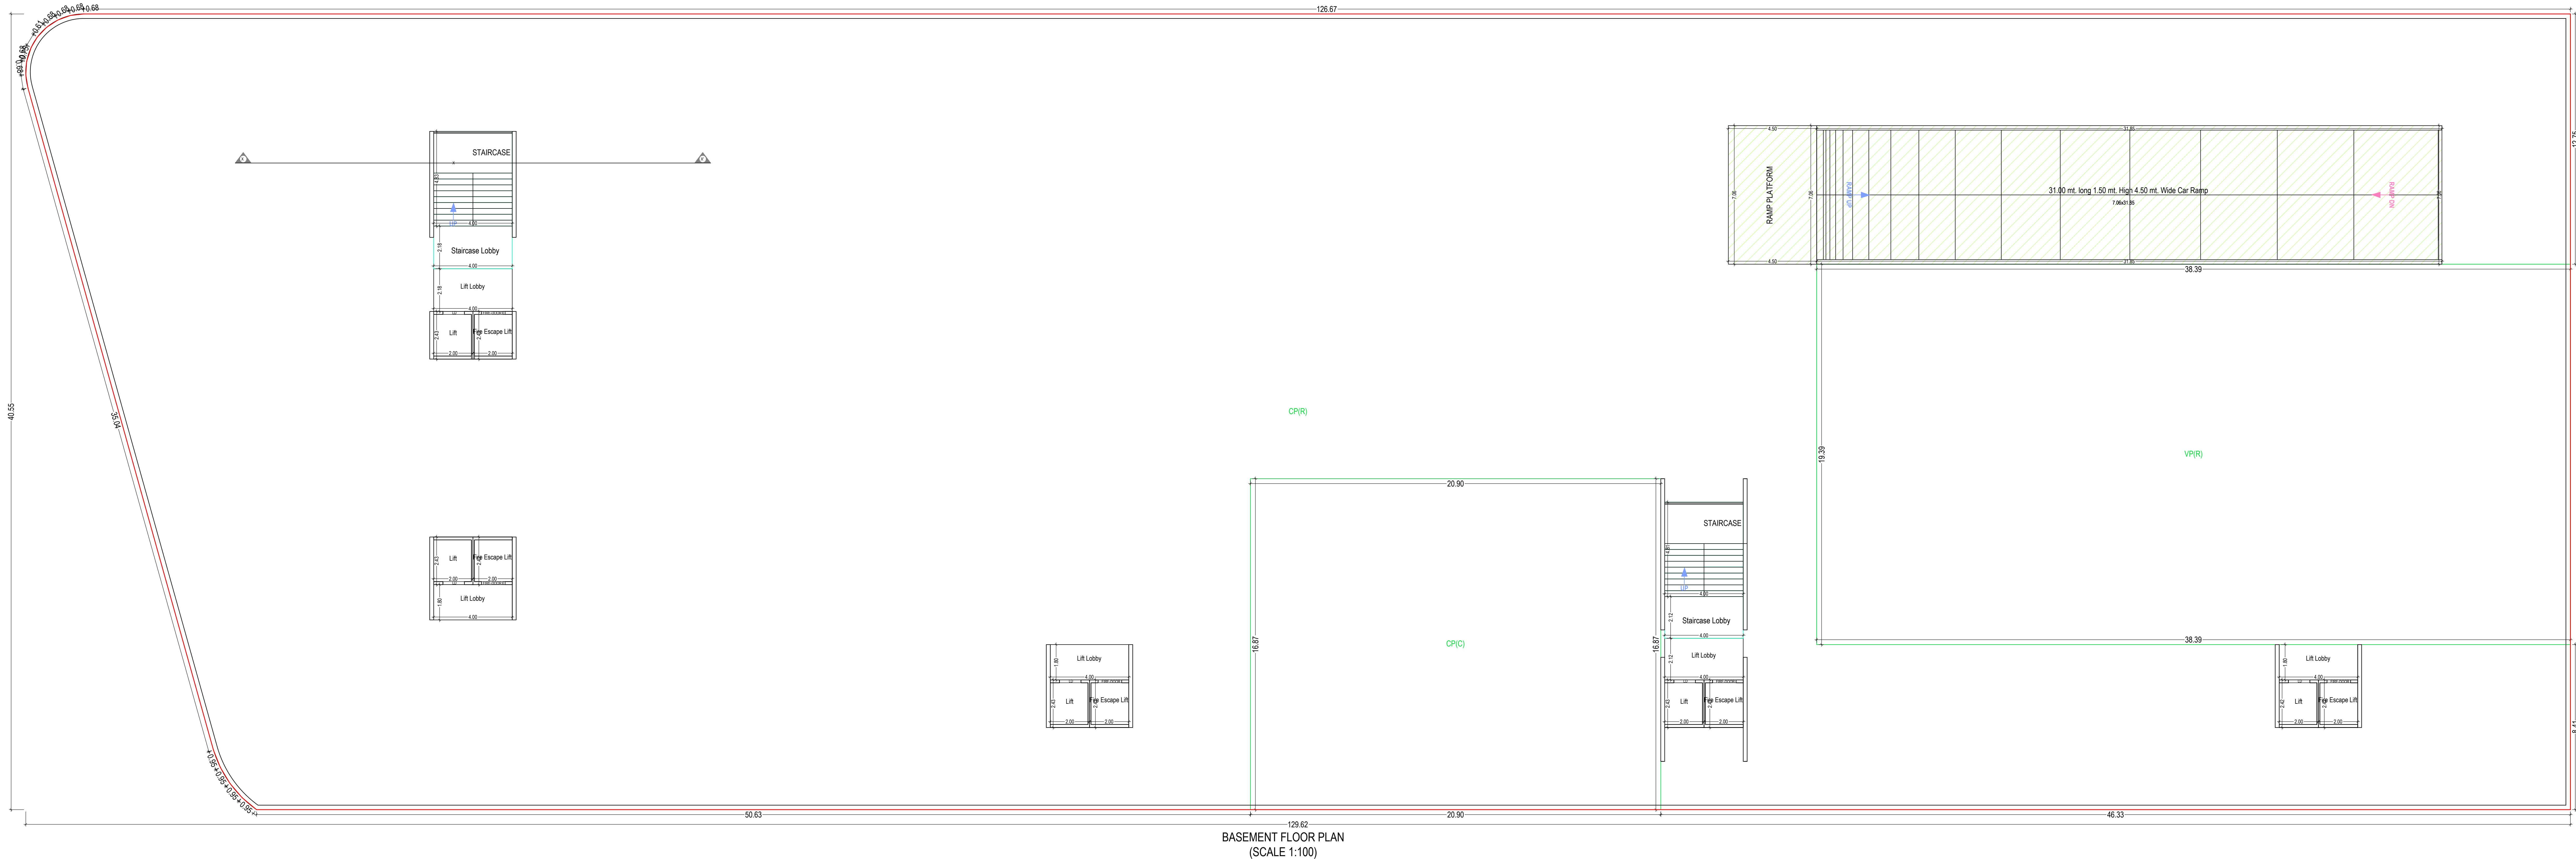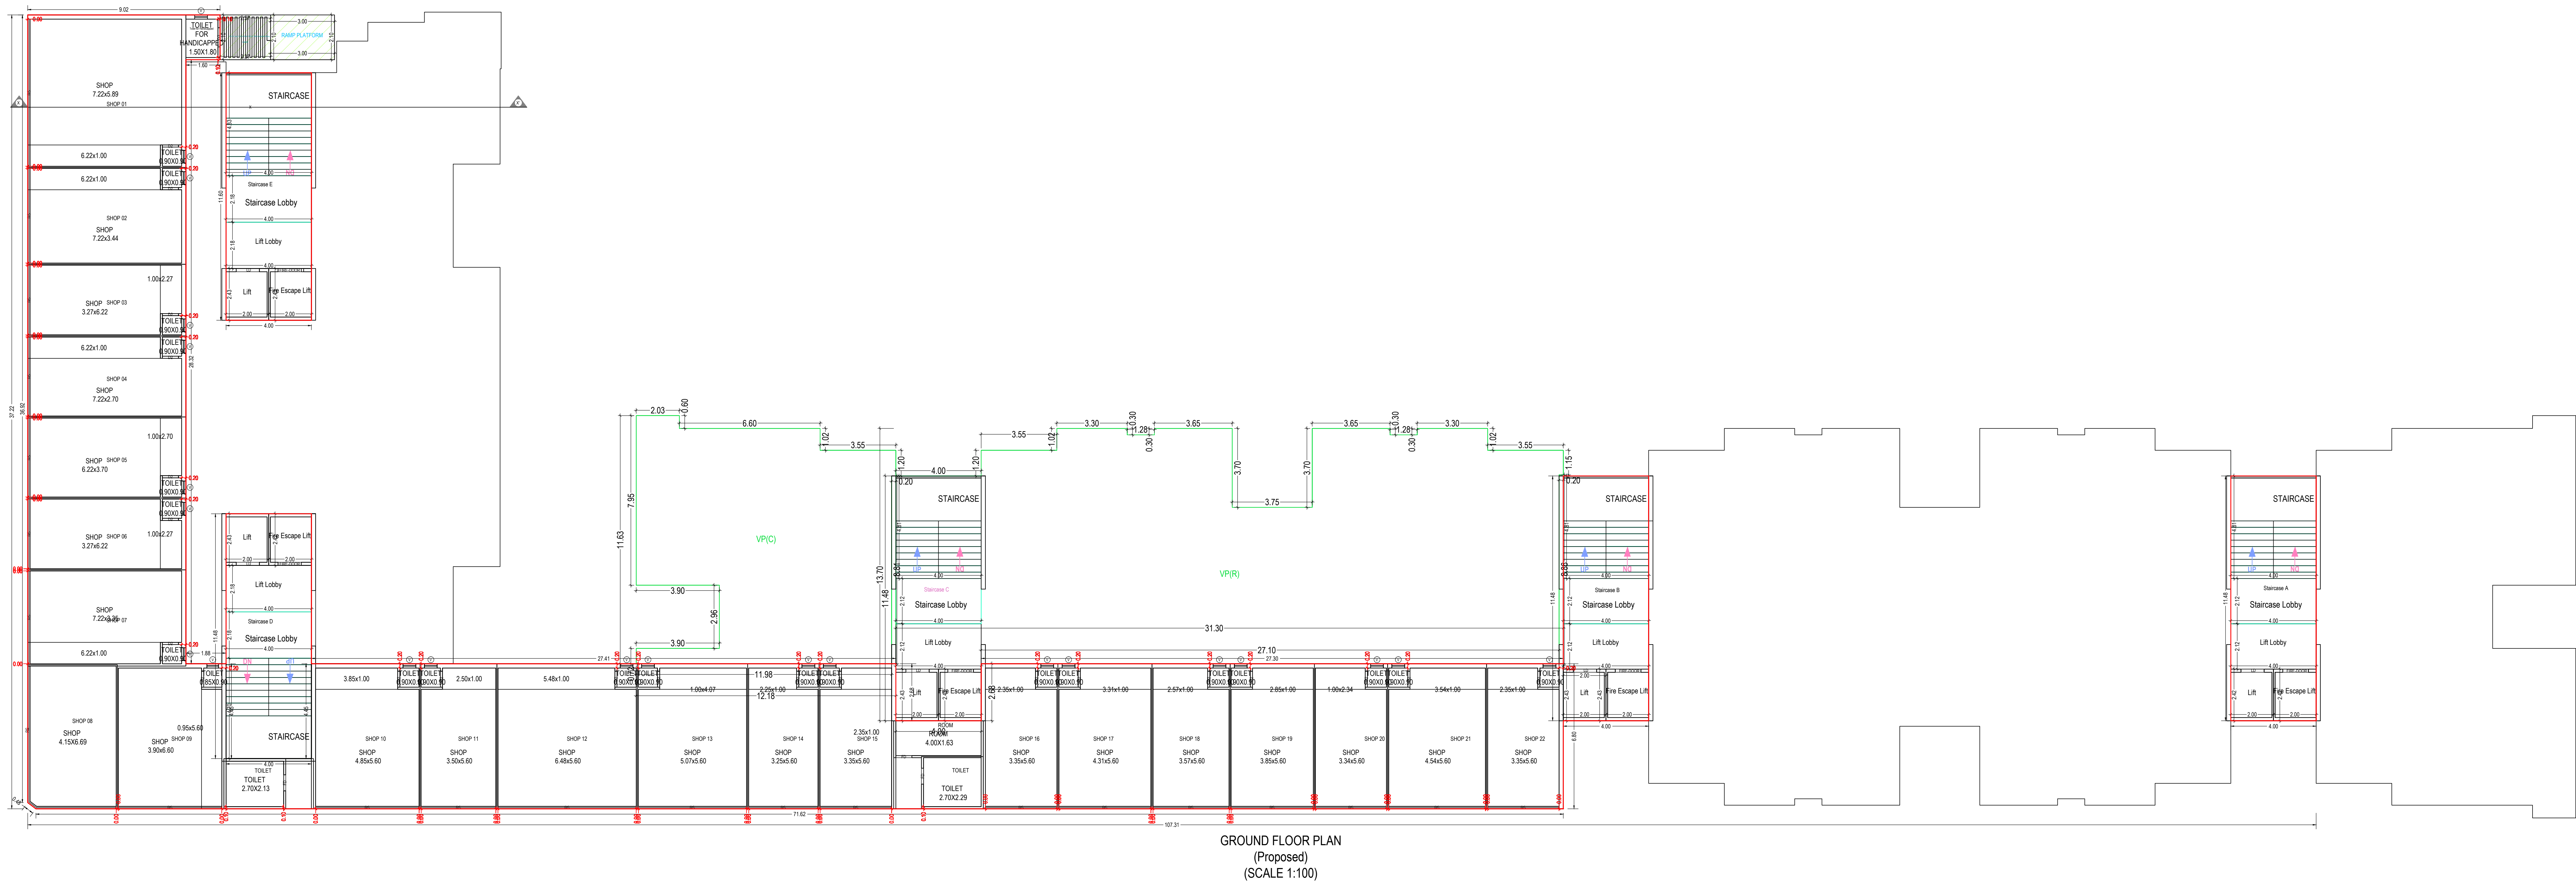


OWNER'S NAME AND SIGNATURE	
Vishwanath J. Jatti	
ARCHITECT'S NAME AND SIGNATURE	STRUCTURE ENGINEER
Architect: Vishwanath J. Jatti	
DATE OF APPROVAL	
DESIGNATION OF APPROVER	
[Signature]	
[Barcode]	



ELEVATION

OWNER'S NAME AND SIGNATURE	
Vishal Kumar J. Jain	
ARCHITECT'S NAME AND SIGNATURE	
Vishal Kumar J. Jain	
DATE OF APPROVAL	
DESIGNATION OF APPROVER	
QR CODE	
BARCODE	

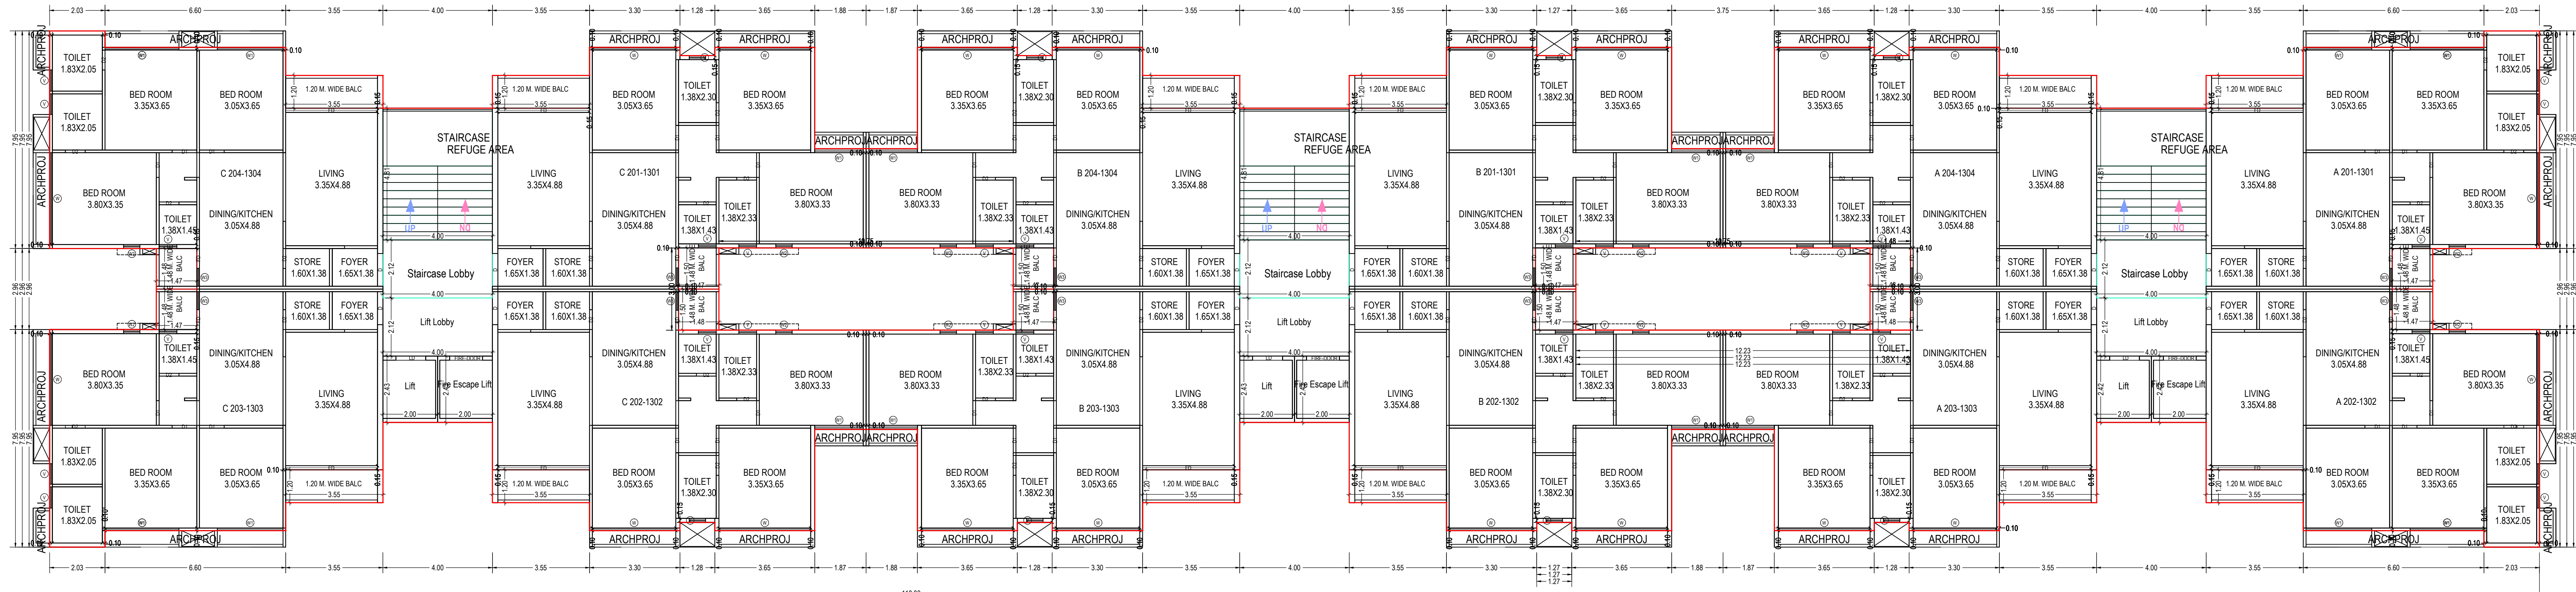


Architectural floor plan of a 14-story building. The plan shows a symmetrical layout with a central staircase and elevator shaft. Rooms are labeled: Terrace Floor, Fourteenth Floor, Thirteenth Floor, Twelfth Floor, Eleventh Floor, Tenth Floor, Ninth Floor, Eighth Floor, Seventh Floor, Sixth Floor, Fifth Floor, Fourth Floor, Third Floor, Second Floor, First Floor, and Ground Floor. Rooms include Living Room, Dining Room, Kitchen, Bedroom, and Bathroom. The plan also shows a Terrace, Staircase, and Lift Machine Room. The building is situated on a plot with a road to the left and a river to the right. The plan is dated 2024 and includes a scale bar.

Figure 10 is a detailed floor plan of the 10th floor of the building. The plan is symmetrical, with two wings separated by a central corridor. Each wing contains several bedrooms, bathrooms, a living area, a dining kitchen, and a staircase. The plan is labeled with room names, dimensions, and area measurements. The overall dimensions of the floor are 120.00m by 120.00m.

OWNER'S NAME AND SIGNATURE	
Vinothkumar J Jan	
ARCHENG'S NAME AND SIGNATURE	STRUCTURE ENGINEER
Aakash Pravinrath Paragpat 003ERH31032500381	
DATE OF APPROVAL	
DESIGNATION OF APPROVER	



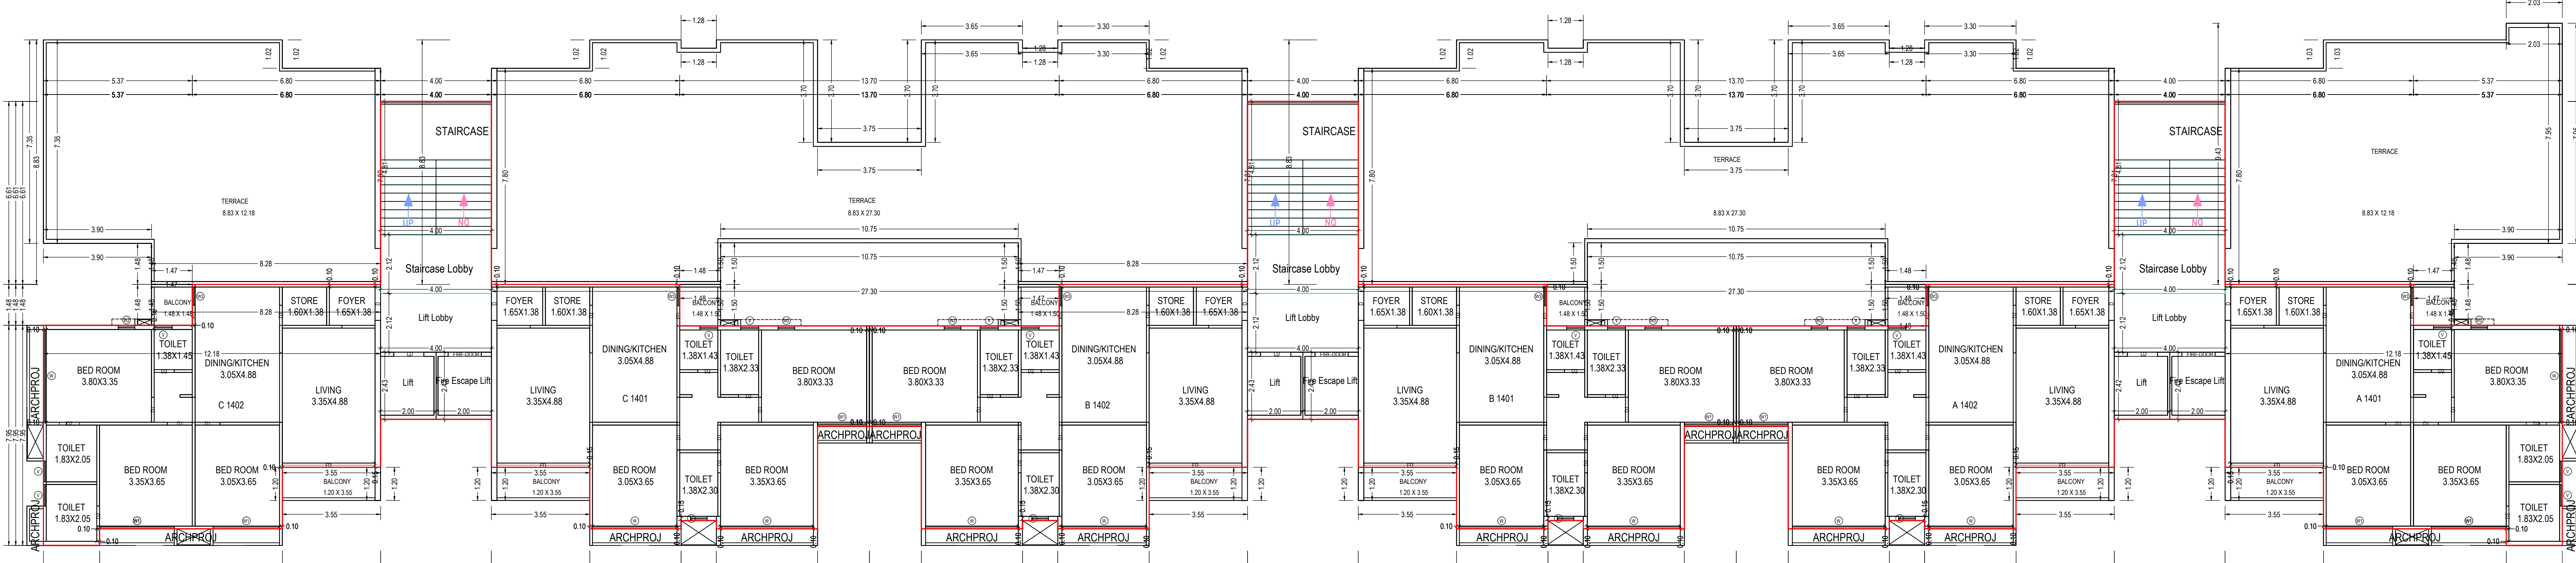

FOURTEENTH FLOOR PLAN
(Proposed)
(SCALE 1:100)

LBSHA Table for Building A B C D E F G H												
Floor	Room	Unit	LBSHA Type	Cess (LBSHA Type)	Cess (LBSHA Type)		LBSHA Area	Defectives (LBSHA Type)		Cess Area	No. of Rooms	
					From One (LBSHA Type)	From Two (LBSHA Type)		Defectives (LBSHA Type)	Defectives (LBSHA Type)			
GROUND FLOOR PLAN	DR001	DR001	DR001	0.50	0.50	0.50	0.50	0.50	0.50	0.50	1	
	DR001	DR001	DR001	0.50	0.50	0.50	0.50	0.50	0.50	1		
	DR002	DR002	DR002	0.50	0.50	0.50	0.50	0.50	0.50	1		
	DR003	DR003	DR003	0.50	0.50	0.50	0.50	0.50	0.50	1		
	DR004	DR004	DR004	0.50	0.50	0.50	0.50	0.50	0.50	1		
	DR005	DR005	DR005	0.50	0.50	0.50	0.50	0.50	0.50	1		
	DR006	DR006	DR006	0.50	0.50	0.50	0.50	0.50	0.50	1		
	DR007	DR007	DR007	0.50	0.50	0.50	0.50	0.50	0.50	1		
	DR008	DR008	DR008	0.50	0.50	0.50	0.50	0.50	0.50	1		
	DR009	DR009	DR009	0.50	0.50	0.50	0.50	0.50	0.50	1		
	DR010	DR010	DR010	0.50	0.50	0.50	0.50	0.50	0.50	1		
	DR011	DR011	DR011	0.50	0.50	0.50	0.50	0.50	0.50	1		
	DR012	DR012	DR012	0.50	0.50	0.50	0.50	0.50	0.50	1		
	DR013	DR013	DR013	0.50	0.50	0.50	0.50	0.50	0.50	1		
	DR014	DR014	DR014	0.50	0.50	0.50	0.50	0.50	0.50	1		
	DR015	DR015	DR015	0.50	0.50	0.50	0.50	0.50	0.50	1		
	DR016	DR016	DR016	0.50	0.50	0.50	0.50	0.50	0.50	1		
	DR017	DR017	DR017	0.50	0.50	0.50	0.50	0.50	0.50	1		
	DR018	DR018	DR018	0.50	0.50	0.50	0.50	0.50	0.50	1		
	DR019	DR019	DR019	0.50	0.50	0.50	0.50	0.50	0.50	1		
DR020	DR020	DR020	0.50	0.50	0.50	0.50	0.50	0.50	1			
1ST FLOOR PLAN	DR101	DR101	DR101	0.50	0.50	0.50	0.50	0.50	0.50	0.50	1	
	DR101	DR101	DR101	0.50	0.50	0.50	0.50	0.50	0.50	0.50	1	
	DR102	DR102	DR102	0.50	0.50	0.50	0.50	0.50	0.50	0.50	1	
	DR103	DR103	DR103	0.50	0.50	0.50	0.50	0.50	0.50	0.50	1	
	DR104	DR104	DR104	0.50	0.50	0.50	0.50	0.50	0.50	0.50	1	
	DR105	DR105	DR105	0.50	0.50	0.50	0.50	0.50	0.50	0.50	1	
	DR106	DR106	DR106	0.50	0.50	0.50	0.50	0.50	0.50	0.50	1	
	DR107	DR107	DR107	0.50	0.50	0.50	0.50	0.50	0.50	0.50	1	
	DR108	DR108	DR108	0.50	0.50	0.50	0.50	0.50	0.50	0.50	1	
	DR109	DR109	DR109	0.50	0.50	0.50	0.50	0.50	0.50	0.50	1	
	DR110	DR110	DR110	0.50	0.50	0.50	0.50	0.50	0.50	0.50	1	
	DR111	DR111	DR111	0.50	0.50	0.50	0.50	0.50	0.50	0.50	1	
	DR112	DR112	DR112	0.50	0.50	0.50	0.50	0.50	0.50	0.50	1	
	DR113	DR113	DR113	0.50	0.50	0.50	0.50	0.50	0.50	0.50	1	
	DR114	DR114	DR114	0.50	0.50	0.50	0.50	0.50	0.50	0.50	1	
	DR115	DR115	DR115	0.50	0.50	0.50	0.50	0.50	0.50	0.50	1	
	DR116	DR116	DR116	0.50	0.50	0.50	0.50	0.50	0.50	0.50	1	
	DR117	DR117	DR117	0.50	0.50	0.50	0.50	0.50	0.50	0.50	1	
	DR118	DR118	DR118	0.50	0.50	0.50	0.50	0.50	0.50	0.50	1	
	DR119	DR119	DR119	0.50	0.50	0.50	0.50	0.50	0.50	0.50	1	
DR120	DR120	DR120	0.50	0.50	0.50	0.50	0.50	0.50	0.50	1		
2ND FLOOR PLAN	DR201	DR201	DR201	0.50	0.50	0.50	0.50	0.50	0.50	0.50	1	
	DR201	DR201	DR201	0.50	0.50	0.50	0.50	0.50	0.50	0.50	1	
	DR202	DR202	DR202	0.50	0.50	0.50	0.50	0.50	0.50	0.50	1	
	DR203	DR203	DR203	0.50	0.50	0.50	0.50	0.50	0.50	0.50	1	
	DR204	DR204	DR204	0.50	0.50	0.50	0.50	0.50	0.50	0.50	1	
	DR205	DR205	DR205	0.50	0.50	0.50	0.50	0.50	0.50	0.50	1	
	DR206	DR206	DR206	0.50	0.50	0.50	0.50	0.50	0.50	0.50	1	
	DR207	DR207	DR207	0.50	0.50	0.50	0.50	0.50	0.50	0.50	1	
	DR208	DR208	DR208	0.50	0.50	0.50	0.50	0.50	0.50	0.50	1	
	DR209	DR209	DR209	0.50	0.50	0.50	0.50	0.50	0.50	0.50	1	
	DR210	DR210	DR210	0.50	0.50	0.50	0.50	0.50	0.50	0.50	1	
	DR211	DR211	DR211	0.50	0.50	0.50	0.50	0.50	0.50	0.50	1	
	DR212	DR212	DR212	0.50	0.50	0.50	0.50	0.50	0.50	0.50	1	
	DR213	DR213	DR213	0.50	0.50	0.50	0.50	0.50	0.50	0.50	1	
	DR214	DR214	DR214	0.50	0.50	0.50	0.50	0.50	0.50	0.50	1	
	DR215	DR215	DR215	0.50	0.50	0.50	0.50	0.50	0.50	0.50	1	
	DR216	DR216	DR216	0.50	0.50	0.50	0.50	0.50	0.50	0.50	1	
	DR217	DR217	DR217	0.50	0.50	0.50	0.50	0.50	0.50	0.50	1	
	DR218	DR218	DR218	0.50	0.50	0.50	0.50	0.50	0.50	0.50	1	
	DR219	DR219	DR219	0.50	0.50	0.50	0.50	0.50	0.50	0.50	1	
DR220	DR220	DR220	0.50	0.50	0.50	0.50	0.50	0.50	0.50	1		
3RD FLOOR PLAN	DR301	DR301	DR301	0.50	0.50	0.50	0.50	0.50	0.50	0.50	1	
	DR301	DR301	DR301	0.50	0.50	0.50	0.50	0.50	0.50	0.50	1	
	DR302	DR302	DR302	0.50	0.50	0.50	0.50	0.50	0.50	0.50	1	
	DR303	DR303	DR303	0.50	0.50	0.50	0.50	0.50	0.50	0.50	1	
	DR304	DR304	DR304	0.50	0.50	0.50	0.50	0.50	0.50	0.50	1	
	DR305	DR305	DR305	0.50	0.50	0.50	0.50	0.50	0.50	0.50	1	
	DR306	DR306	DR306	0.50	0.50	0.50	0.50	0.50	0.50	0.50	1	
	DR307	DR307	DR307	0.50	0.50	0.50	0.50	0.50	0.50	0.50	1	
	DR308	DR308	DR308	0.50	0.50	0.50	0.50	0.50	0.50	0.50	1	
	DR309	DR309	DR309	0.50	0.50	0.50	0.50	0.50	0.50	0.50	1	
	DR310	DR310	DR310	0.50	0.50	0.50	0.50	0.50	0.50	0.50	1	
	DR311	DR311	DR311	0.50	0.50	0.50	0.50	0.50	0.50	0.50	1	
	DR312	DR312	DR312	0.50	0.50	0.50	0.50	0.50	0.50	0.50	1	
	DR313	DR313	DR313	0.50	0.50	0.50	0.50	0.50	0.50	0.50	1	
	DR314	DR314	DR314	0.50	0.50	0.50	0.50	0.50	0.50	0.50	1	
	DR315	DR315	DR315	0.50	0.50	0.50	0.50	0.50	0.50	0.50	1	
	DR316	DR316	DR316	0.50	0.50	0.50	0.50	0.50	0.50	0.50	1	
	DR317	DR317	DR317	0.50	0.50	0.50	0.50	0.50	0.50	0.50	1	
	DR318	DR318	DR318	0.50	0.50	0.50	0.50	0.50	0.50	0.50	1	
	DR319	DR319	DR319	0.50	0.50	0.50	0.50	0.50	0.50	0.50	1	
DR320	DR320	DR320	0.50	0.50	0.50	0.50	0.50	0.50	0.50	1		
4TH FLOOR PLAN	DR401	DR401	DR401	0.50	0.50	0.50	0.50	0.50	0.50	0.50	1	
	DR401	DR401	DR401	0.50	0.50	0.50	0.50	0.50	0.50	0.50	1	
	DR402	DR402	DR402	0.50	0.50	0.50	0.50	0.50	0.50	0.50	1	
	DR403	DR403	DR403	0.50	0.50	0.50	0.50	0.50	0.50	0.50	1	
	DR404	DR404	DR404	0.50	0.50	0.50	0.50	0.50	0.50	0.50	1	
	DR405	DR405	DR405	0.50	0.50	0.50	0.50	0.50	0.50	0.50	1	
	DR406	DR406	DR406	0.50	0.50	0.50	0.50	0.50	0.50	0.50	1	
	DR407	DR407	DR407	0.50	0.50	0.50	0.50	0.50	0.50	0.50	1	
	DR408	DR408	DR408	0.50	0.50	0.50	0.50	0.50	0.50	0.50	1	
	DR409	DR409	DR409	0.50	0.50	0.50	0.50	0.50	0.50	0.50	1	
	DR410	DR410	DR410	0.50	0.50	0.50	0.50	0.50	0.50	0.50	1	
	DR411	DR411	DR411	0.50	0.50	0.50	0.50	0.50	0.50	0.50	1	
	DR412	DR412	DR412	0.50	0.50	0.50	0.50	0.50	0.50	0.50	1	
	DR413	DR413	DR413	0.50	0.50	0.50	0.50	0.50	0.50	0.50	1	
	DR414	DR414	DR414	0.50	0.50	0.50	0.50	0.50	0.50	0.50	1	
	DR415	DR415	DR415	0.50	0.50	0.50	0.50	0.50	0.50	0.50	1	
	DR416	DR416	DR416	0.50	0.50	0.50	0.50	0.50	0.50	0.50	1	
	DR417	DR417	DR417	0.50	0.50	0.50	0.50	0.50	0.50	0.50	1	
	DR418	DR418	DR418	0.50	0.50	0.50	0.50	0.50	0.50	0.50	1	
	DR419	DR419	DR419	0.50	0.50	0.50	0.50	0.50	0.50	0.50	1	
DR420	DR420	DR420	0.50	0.50	0.50	0.50	0.50	0.50	0.50	1		
5TH FLOOR PLAN	DR501	DR501	DR501	0.50	0.50	0.50	0.50	0.50	0.50	0.50	1	
	DR501	DR501	DR501	0.50	0.50	0.50	0.50	0.50	0.50	0.50	1	
	DR502	DR502	DR502	0.50	0.50	0.50	0.50	0.50	0.50	0.50	1	
	DR503	DR503	DR503	0.50	0.50	0.50	0.50	0.50	0.50	0.50	1	
	DR504	DR504	DR504	0.50	0.50	0.50	0.50	0.50	0.50	0.50	1	
	DR505	DR505	DR505	0.50	0.50	0.50	0.50	0.50	0.50	0.50	1	
	DR506	DR506	DR506	0.50	0.50	0.50	0.50	0.50	0.50	0.50	1	
	DR507	DR507	DR507	0.50	0.50	0.50	0.50	0.50	0.50	0.50	1	
	DR508	DR508	DR508	0.50	0.50	0.50	0.50	0.50	0.50	0.50	1	
	DR509	DR509	DR509	0.50	0.50	0.50	0.50	0.50	0.50	0.50	1	
	DR510	DR510	DR510	0.50	0.50	0.50	0.50	0.50	0.50	0.50	1	
	DR511	DR511	DR511	0.50	0.50	0.50	0.50	0.50	0.50	0.50	1	
	DR512	DR512	DR512	0.50	0.50	0.50	0.50	0.50	0.50	0.50	1	
	DR513	DR513	DR513	0.50	0.50	0.50	0.50	0.50	0.50	0.50	1	
	DR514	DR514	DR514	0.50	0.50	0.50	0.50	0.50	0.50	0.50	1	
	DR515	DR515	DR515	0.50	0.50	0.50	0.50	0.50	0.50	0.50	1	
	DR516	DR516	DR516	0.50	0.50	0.50	0.50	0.50	0.50	0.50	1	
	DR517	DR517	DR517	0.50	0.50	0.50	0.50	0.50				

SCHEDULING OF WINDOW VENTILATION					
BUILDING NAME	NAME	U-VALUE	HEIGHT	MS	SCORE
ARCOPT WINDOW	W1	0.23	1.08	54	10
ARCOPT WINDOW	W2	0.55	1.08	100	10
ARCOPT WINDOW	W3	0.60	1.08	114	10
ARCOPT WINDOW	W4	0.60	1.25	92	10
ARCOPT WINDOW	W5	0.60	1.25	92	10
ARCOPT WINDOW	W6	0.55	1.08	100	210
ARCOPT WINDOW	W7	0.55	1.08	100	210
ARCOPT WINDOW	W8	0.55	0.96	54	10
ARCOPT WINDOW	W9	0.55	0.96	54	10
ARCOPT WINDOW	W10	0.73	1.08	54	10
ARCOPT WINDOW	W11	0.73	1.08	54	10
ARCOPT WINDOW	W12	1.26	1.25	100	10
ARCOPT WINDOW	W13	2.40	1.25	64	10
ARCOPT WINDOW	W14	2.40	1.25	64	10
ARCOPT WINDOW	W15	2.70	1.25	64	10
ARCOPT WINDOW	W16	3.00	1.25	64	10
ARCOPT WINDOW	W17	3.00	1.25	64	10
ARCOPT WINDOW	W18	3.30	1.25	64	10
ARCOPT WINDOW	W19	3.30	1.25	64	10
ARCOPT WINDOW	W20	3.30	1.25	64	10

[illegible]

FLOOR	SIZE	AREA	TOTAL AREA
FIRST FLOOR PLAN	140' x 51' x 6' x 1'	9366	1193
	120' x 140' x 6' x 1'	1710	
	120' x 160' x 2' x 1'	612	
	140' x 180' x 1'	2520	
	140' x 150' x 2'	2100	
TYPICAL 2, 3, 4, 5, 6, 7, 8, 9, 10, 11, 12, 13 FLOOR PLAN	140' x 150' x 10' x 12'	23160	4423
	120' x 120' x 10' x 12'	2880	
	140' x 150' x 12' x 12'	25920	
	140' x 140' x 4' x 12'	14664	
	140' x 150' x 4' x 12'	21016	
TOTAL			100151

OWNER'S NAME AND SIGNATURE

ROHNG'S NAME AND SIGNATURE	STRUCTURE ENGINEER
----------------------------	--------------------

DATE OF APPROVAL _____



Project Title :PROPOSED LAYOUT AND BUILDING PLAN OF CLUB HOUSE ON R.S.NO.61,62,63,64, O.P.NO.187, F.P.NO.187, T.P.NO.02 (SAMA-DUMAD-VEMALI), VILL.VEMALI. DIST.VADODARA.

Inward No	ODPS/2020/030931	Sheet	6
Inward Date		Scale	1:100

UnitBUA Table for Building :CLUB HOUSE (1)

Floor	Name	UnitBUA Type	Gross UnitBUA Area	UnitBUA Area	Deductions (Area in Sq.mt.)		Carpet Area	No. of Unit
					Wall	Stair Case		
FIRST FLOOR PLAN	SPLIT club house	DWELLING UNIT	52.78	52.78	4.59	11.98	36.21	01
			Total :	52.78	4.59	11.98	36.21	01
	Total per Floor:	Typical Floor = 1						
-		Total :	52.78	52.78	4.59	11.98	36.21	01
Total:	-	-	52.78	52.78	4.59	11.98	36.21	01

Building :CLUB HOUSE (1)

Floor Name	Total Built Up Area (Sq.mt.)	Deductions from FSI(Area in Sq.mt.)			Proposed Area (Sq.mt.)	FSI	Total FSI Area (Sq.mt.)	No. of Unit
		StairCase	Stair Lobby	Parking		Resi.		
Parking Floor	52.78	7.78	0.00	45.00	0.00		0.00	00
First Floor	52.78	7.78	4.20	0.00	40.80		40.80	01
Terrace Floor	7.78	7.78	0.00	0.00	0.00		0.00	00
Total:	113.34	23.34	4.20	45.00	40.80		40.80	01
Total Number of Same Buildings:	1							
Total:	113.34	23.34	4.20	45.00	40.80		40.80	01

Staircase Checks (Table 8a-1)





Floor Name	StairCase Name	Flight Width	Tread Width	Riser Height
PARKING FLOOR PLAN	STAIRCASE	1.20	0.23	0.20
FIRST FLOOR PLAN	STAIRCASE	1.20	0.23	0.20
TERRACE FLOOR PLAN	STAIRCASE	1.20	0.23	0.00

SCHEDULE OF DOOR:

BUILDING NAME	NAME	LENGTH	HEIGHT	NOS
CLUB HOUSE (1)	FD	0.75	2.10	02
CLUB HOUSE (1)	FD	1.50	2.10	01

SCHEDULE OF WINDOW/VENTILATION:

BUILDING NAME	NAME	LENGTH	HEIGHT	NOS
CLUB HOUSE (1)	V	0.60	1.00	02
CLUB HOUSE (1)	W	3.81	1.20	01

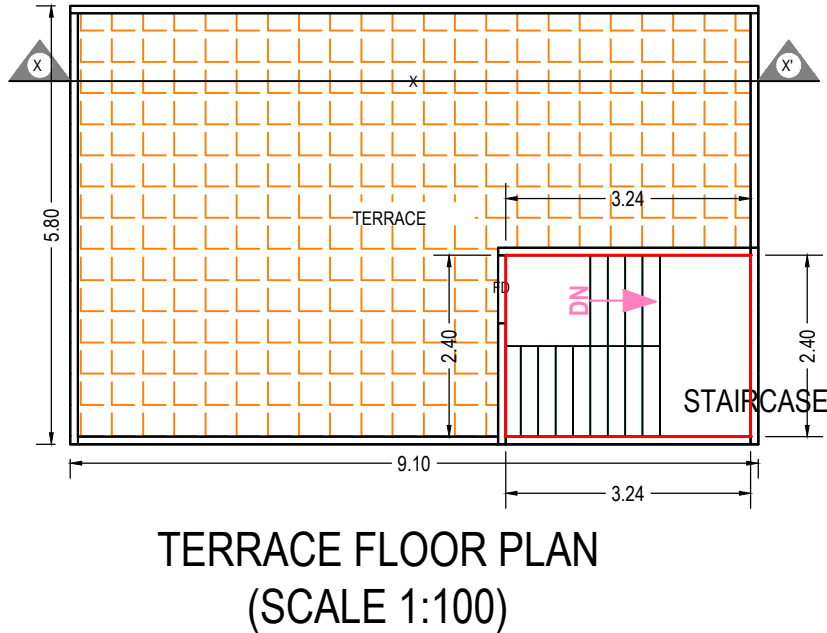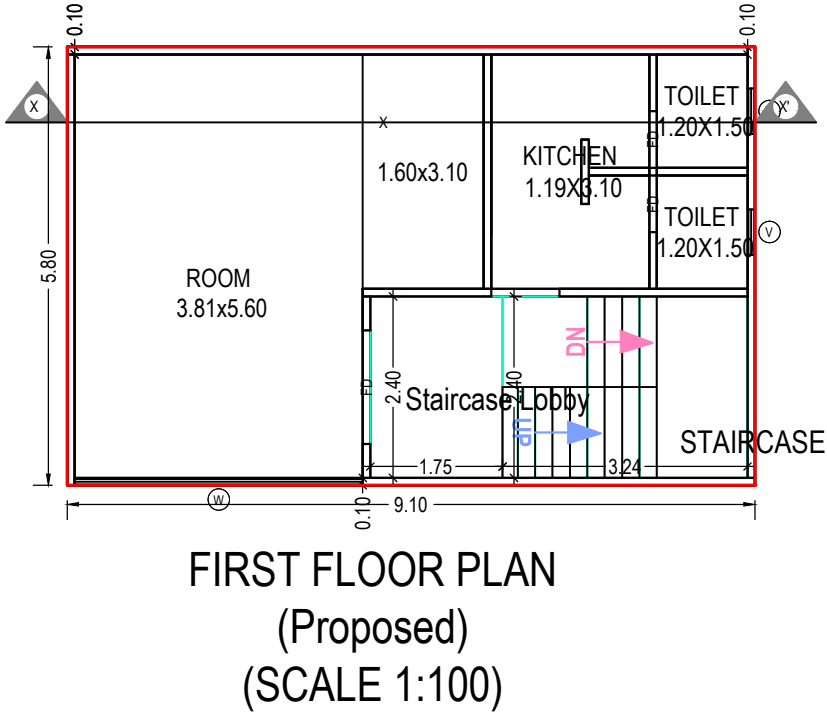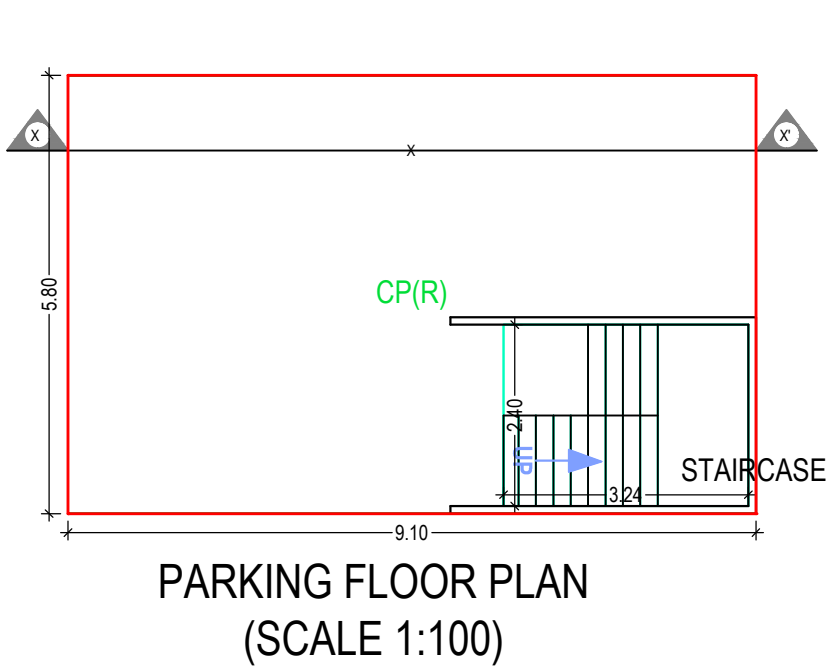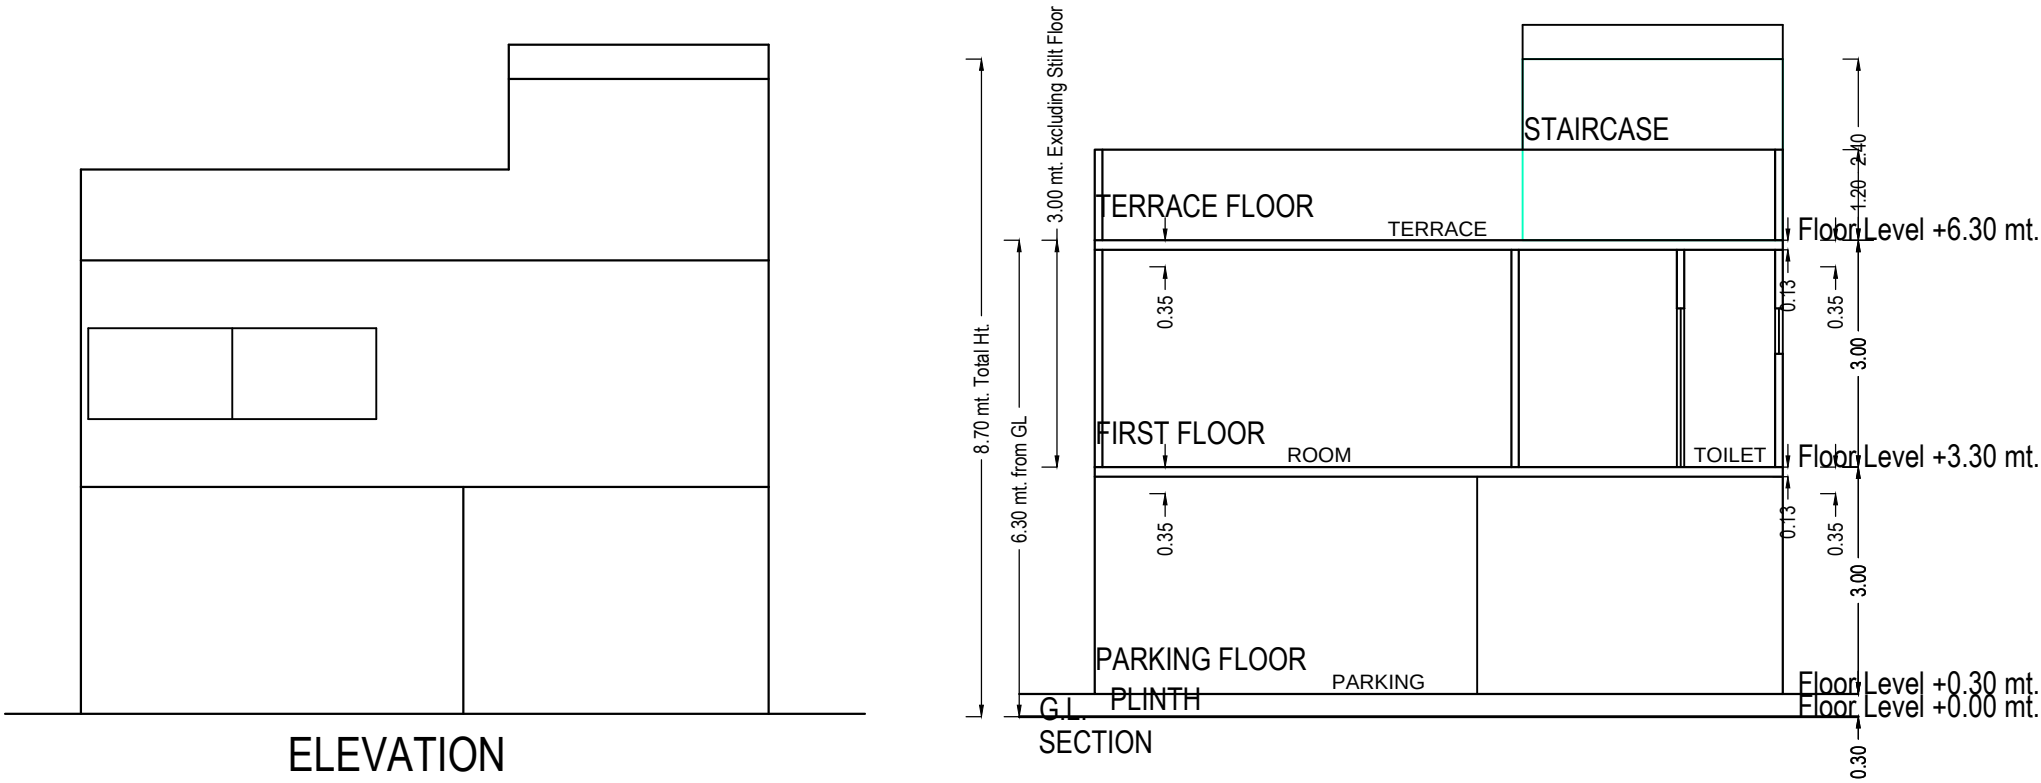

OWNER'S NAME AND SIGNATURE	
Vinodkumar J Jain	
ARCH/ENG'S NAME AND SIGNATURE	STRUCTURE ENGINEER
Aakash Pravinkant Parajpati	
003ERH31032500281	
DATE OF APPROVAL	
DESIGNATION OF APPROVER	