


LEGEND FOR FIRE FIGHTING	
	UPRIGHT TYPE SPRINKLER
	SIDE WALL TYPE SPRINKLER
F.S	FLOW SWITCH
B.F.V	BUTTER FLY VALVE
M.S	MILD STEEL
	M.S SPRINKLER BRANCH PIPE
	M.S SPRINKLER HEADER PIPE

LEGEND FOR FIRE HOSE CABINET	
FHC=	FIRE HOSE CABINET COMPRISING OF
(1)	ONE NO. FIRE HOSE CABINET SIZE: 1200mmx1000mm
(2)	TWO NO. 63mm SINGLE LANDING VALVE
(3)	ONE NO. FIRST AID HOSE REEL WITH DRUM 20mm ϕ x36.5M, LONG WITH 5mm BORE NOZZLE
(4)	FOUR NOS. 63mm ϕ x15M, LONG RRL HOSE PIPES
(5)	ONE NO. 20mm ϕ BRANCH PIPE WITH NOZZLE
(6)	ONE NO. 4.5 KG. CO2 TYPE FIRE EXTINGUISHERS
(7)	ONE NO. 4.0 KG. ABC POWDER TYPE FIRE EXTINGUISHERS

IMPORTANT NOTE:-
 * PLEASE GIVE THE UGT & PUMP ROOM LOCATION PHASE-I BASEMENT AS DISCUSSED.
 * WATER CURTAIN SYSTEM ARE HOLD DUE TO NON AVAILABILITY OF HVAC VENTILATION ZONES.

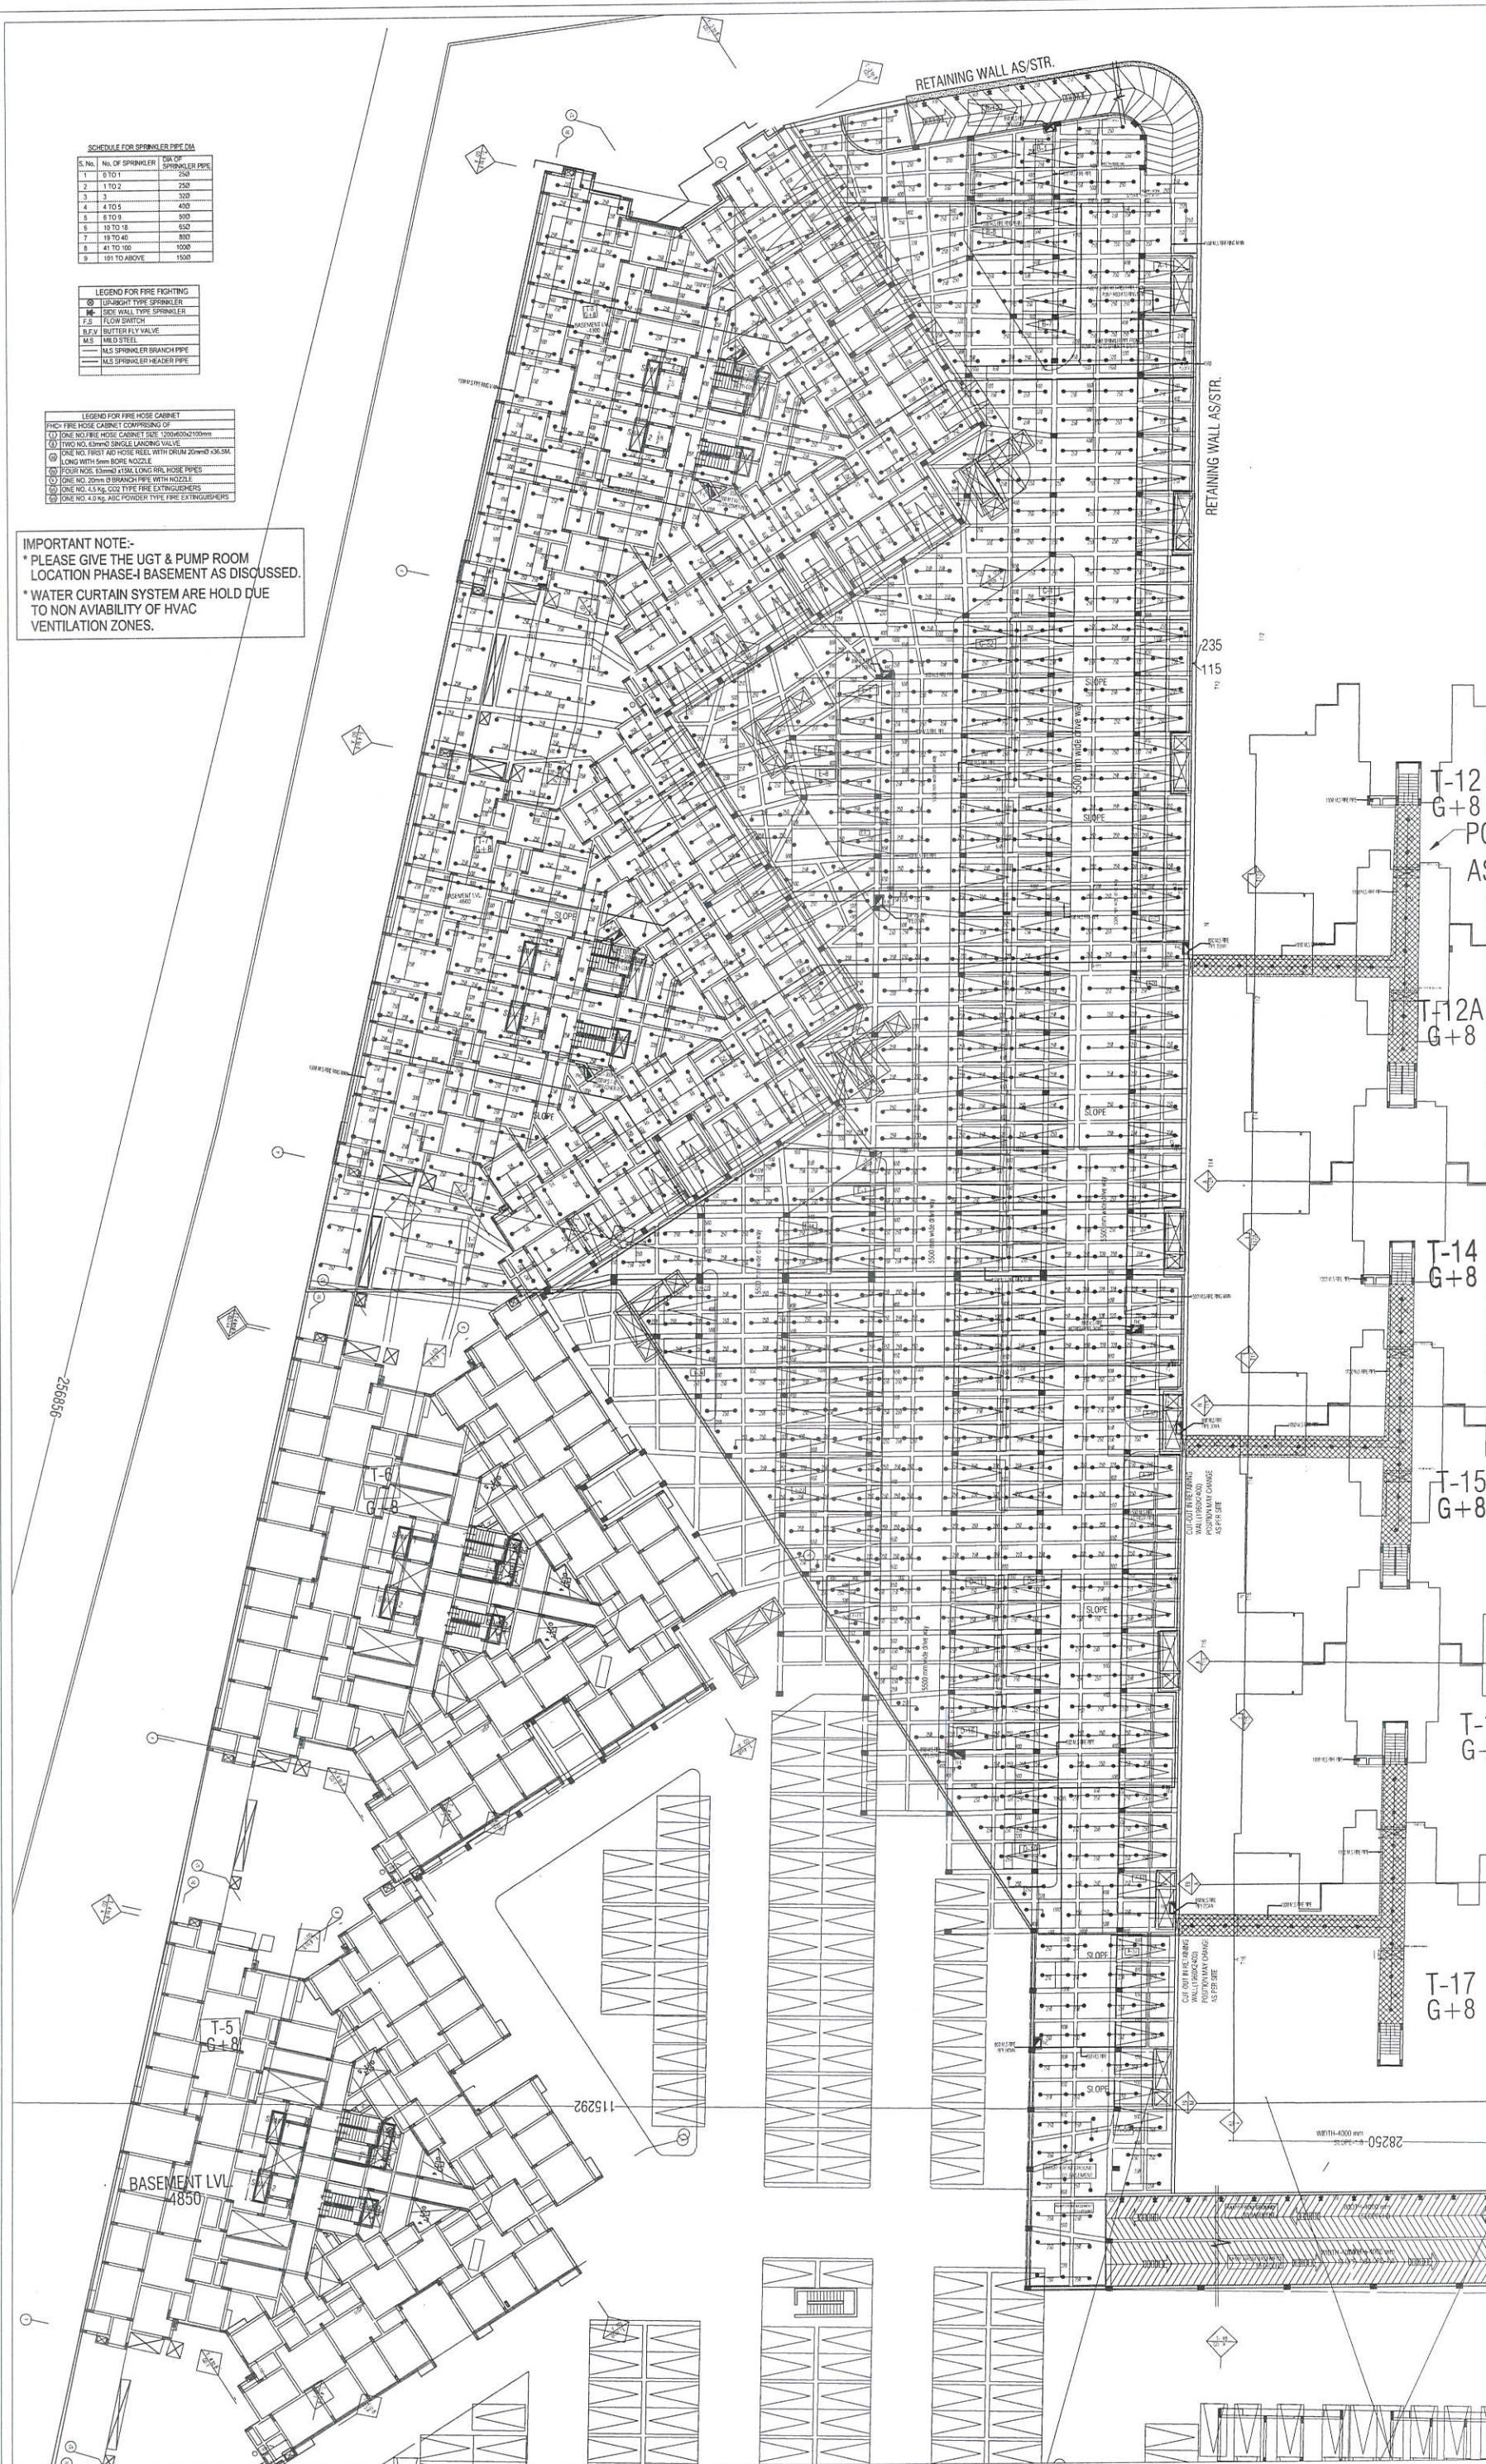

THIS DRAWING IS THE PROPERTY OF M/S
VASTUNIKHI AND SHALL NOT BE REPRODUCED
OR USED FOR ANY OTHER PURPOSE THAN
SPECIFIED WITHOUT WRITTEN PERMISSION

NOTES:

1. ALL DRAWINGS ARE IN MM.
2. THE DRAWING IS NOT TO SCALE.
3. THE CHAIRMAN SHALL BE RESPONSIBLE FOR ACTION WITH REGARD TO ANY CHANGES.
4. ANY AMENDMENT SHOULD BE REFERRED TO THE ARCHITECT BEFORE PROCEEDING.
5. THE FINAL DESIGN SHALL BE LOCATED AS SHOWN.

PRINT DATA:

S.NO.	DATE	NO. (PRINTS)	ISSUED TO
-------	------	--------------	-----------

REVISIONS:

REVISIONS:		
S.NO.	REV.NO.	PARTICULARS

CLIENT:

I - HOMES AND
MAJESTIC PROPERTIES PVT. LTD
208,OCEAN COMPLEX SEC-18,NOIDA

PROJECT:
LAVANYA HOUSING
VILLAGE BHANKROTA, AJMER ROAD

ARCHITECT:
VASTUNIDHI
ARCHITECT, PLANNER & INT. DESIGNERS
B-135, SECTOR 44, NOIDA
PHONE 2432190, FAX 4331407

DRG. TITLE
BASEMENT FLOOR CEILING PLAN
(FIRE FIGHTING)

SCALE : 1:200

DEALT
SHANKAR

SHANKAR
CHECKED

A.GANGW
DATE

DATE
28.10.16

REV	NO	R2
-----	----	----

DRG. NO.
FF-B-WD- 01

NORTH

1

DATE
28.10.16

GROUND FLOOR PLAN

LEGEND FOR PLUMBING			
MARK	DESCRIPTION	MARK	DESCRIPTION
110(00) UPVC SOIL WASTE & VENT PIPE		D.W.S.	DOMESTIC WATER SUPPLY PIPE
110(00) UPVC WASTE & VENT PIPE		H.W.S.	HOT WATER SUPPLY PIPE
75(00) UPVC ANTI-SIPHONIC PIPE		F.W.S.	FLUSHING WATER SUPPLY PIPE
DOMESTIC WATER SUPPLY DOWNTAKE PIPE FOR 8th & 7th FLOOR		F.T.	FLOOR TRAP
DOMESTIC WATER SUPPLY DOWNTAKE PIPE 6th TO STILT FLOOR		B.D.	BALCONY DRAIN
FLUSHING WATER SUPPLY DOWNTAKE PIPE 8th FLOOR TO STILT FLOOR		G.I.	GALVANIZED IRON
H.W.S. PIPE FROM SOLAR PANEL FOR KITCHENS		OD	OUTER DIA
75(00) UPVC RAIN WATER PIPE FOR BALCONY			
110(00) UPVC RAIN WATER PIPE FOR TERRACE			
400 G.I. D.W.S. O.H. WATER TANK FILLING PIPE FROM PUMP ROOM			
320 G.I. F.W.S. O.H. WATER TANK FILLING PIPE FROM S.T.P.			

PLUMBING NOTE:-
 * W.C. TO VERTICAL SOIL STACK 110(00) UPVC SOIL PIPE
 * F.T. TO VERTICAL WASTE STACK 110(00) UPVC WASTE PIPE
 * SINK TO F.T. FLEXIBLE PIPE
 * WASH BASIN TO F.T. 40(00) UPVC WASTE PIPE

PLUMBING NOTES:-
 * ALL WATER SUPPLY PIPES WITH IN THE SHAFTS & TERRACE LEVEL SHALL BE G.I. PIPES & FITTINGS.
 * ALL WATER SUPPLY PIPES WITH IN THE TOILET WALL CHASING SHALL BE CPVC PIPES & FITTINGS.
 * ALL VALVE UP TO 40mm DIA SHALL BE BALL VALVE

THIS DRAWING IS THE PROPERTY OF M/S VASTUNIDHI AND SHALL NOT BE REPRODUCED OR USED FOR ANY OTHER PURPOSE THAN SPECIFIED WITHOUT WRITTEN PERMISSION

- NOTES:
1. ALL DRAWINGS ARE IN MM.
 2. THIS DRAWING IS NOT TO BE SCALED.
 3. THIS DRAWING SHOULD BE READ IN CONJUNCTION WITH OTHER RELEVANT DRAWINGS.
 4. ANY AMBIGUITY FOUND SHOULD BE REFERRED TO THE ARCHITECT BEFORE EXECUTION.
 5. RW PIPES ARE DIVERTED TO PIPE LOCATION AS SHOWN.
 6. THE BEAM, FROM WHERE THE TOILET PIPES ARE GOING TOWARDS THE SHAFTS, HAS TO BE UPTURNED OR OTHERWISE AS SPECIFIED.

PRINT DATA:			
S.NO.	DATE	NO.(PRINTS)	ISSUED TO

REVISIONS:		
S.NO.	REV. NO.	PARTICULARS

NAVEEN KUMAR
 B.TECH-CIVIL ENGINEER



CLIENT:
I-HOMES AND MAJESTIC PROPERTY PVT. LTD.
 208, OCEAN COMPLEX SEC-18, NOIDA

PROJECT:
LAVANYA HOUSING
 VILLAGE BHANKROTA, AJMER ROAD, JAIPUR

PLUMBING CONSULTANTS
ARK CONSULTANTS
 1/30 ROSHAN GARDEN-II
 KAKROLA ROAD NAJAFGARH
 NEW DELHI-110043
 PH:- 25322575
 E-MAIL-arkconsultants@yahoo.com


ARCHITECT:
VASTUNIDHI
 ARCHITECT, PLANNER & INT. DESIGNERS
 B-135, SECTOR 44, NOIDA
 PHONE: 2432190 FAX: 4331407

TOWER NO.
 TOWER NO. T1 TO T8

DRG. TITLE
GROUND FLOOR & CEILING PLAN (FIRE FIGHTING)

SCALE 1:100	REV. NO. R3
DEALT RAJESH	DRG. NO. CT(4T08)-PL-4
CHECKED MAHENDRA	NORTH
DATE 22.04.15	

LEGEND FOR FIRE FIGHTING	
FHC - FIRE HOSE CABINET COMPRISING OF	
ONE NO. M.S. FIRE CABINET SIZE 2100X900X600mm	
ONE NO. 57mmID SINGLE LAUNCHING VALVE	
ONE NO. FIRE HOSE REEL WITH DRUM 20mmID x 36.5M. LONG	
TWO NOS. 63mmID x 15M. LONG RRL HOSE PIPES	
ONE NO. BRANCH PIPE	
4.5 Kg CO2 TYPE FIRE EXTINGUISHER	
3.0 Kg ABC TYPE FIRE EXTINGUISHER	

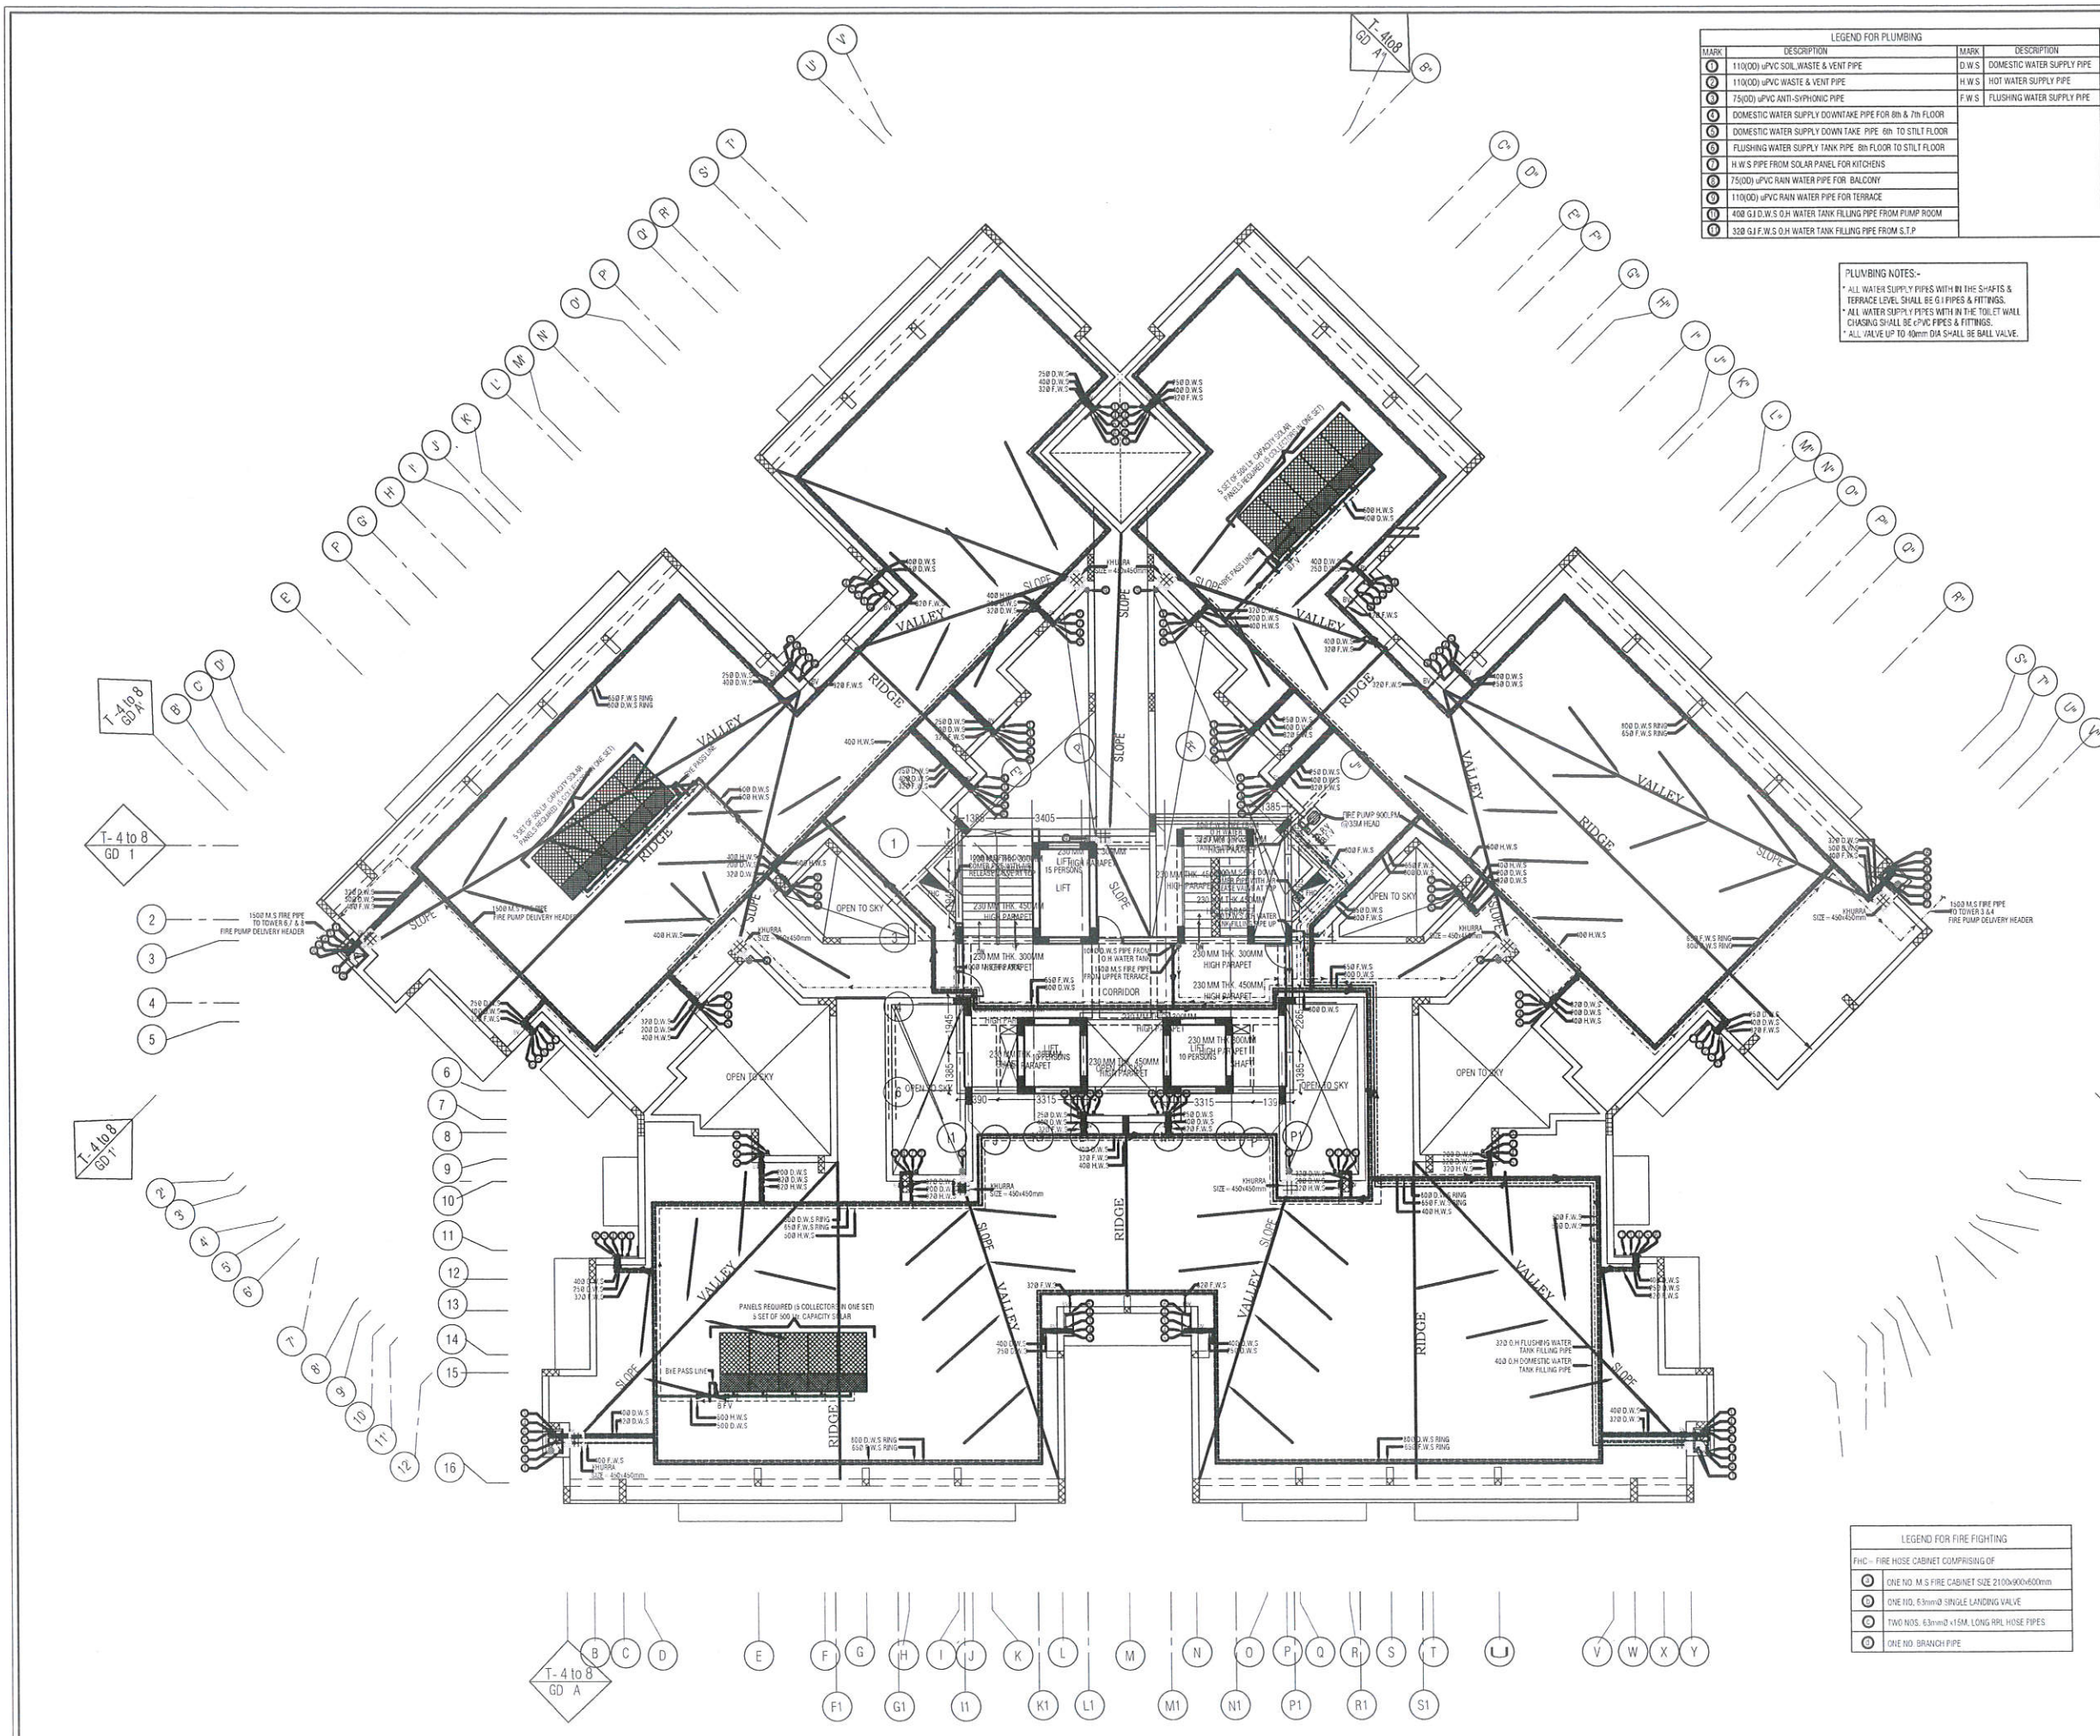

LEGEND FOR PLUMBING			
MARK	DESCRIPTION	MARK	DESCRIPTION
110(00)	UPVC SOIL WASTE & VENT PIPE	D.W.S	DOMESTIC WATER SUPPLY PIPE
110(00)	UPVC WASTE & VENT PIPE	H.W.S	HOT WATER SUPPLY PIPE
75(00)	UPVC ANTI-SIPHONIC PIPE	F.W.S	FLUSHING WATER SUPPLY PIPE
0	DOMESTIC WATER SUPPLY DOWNTAKE PIPE FOR 8th & 7th FLOOR		
0	DOMESTIC WATER SUPPLY DOWN TAKE PIPE 6th TO STILT FLOOR		
0	FLUSHING WATER SUPPLY TANK PIPE 8th FLOOR TO STILT FLOOR		
0	H.W.S PIPE FROM SOLAR PANEL FOR KITCHENS		
75(00)	UPVC RAIN WATER PIPE FOR BALCONY		
110(00)	UPVC RAIN WATER PIPE FOR TERRACE		
0	400 G.I.D.W.S.O.H WATER TANK FILLING PIPE FROM PUMP ROOM		
0	320 G.I.F.W.S.O.H WATER TANK FILLING PIPE FROM S.T.P		


PLUMBING NOTES:-
* ALL WATER SUPPLY PIPES WITH IN THE SHAFTS & TERRACE LEVEL SHALL BE G.I PIPES & FITTINGS.
* ALL WATER SUPPLY PIPES WITH IN THE TOILET WALL CHASING SHALL BE CPVC PIPES & FITTINGS.
* ALL VALVE UP TO 40mm DIA SHALL BE BALL VALVE.

THIS DRAWING IS THE PROPERTY OF M/S VASTUNIDHI AND SHALL NOT BE REPRODUCED OR USED FOR ANY OTHER PURPOSE THAN SPECIFIED WITHOUT WRITTEN PERMISSION

1. ALL DRAWINGS ARE IN MM.
2. THIS DRAWING IS NOT TO BE SCALED.
3. THIS DRAWING SHOULD BE READ IN CONJUNCTION WITH OTHER RELEVANT DRAWINGS.
4. ANY AMBIGUITY FOUND SHOULD BE REFERRED TO THE ARCHITECT BEFORE EXECUTION.
5. RW PIPES ARE DIVERTED TO PIPE LOCATION AS SHOWN.
6. THE BEAM FROM WHERE THE TOILET PIPES ARE GOING TOWARDS THE SHAFTS HAS TO BE UPTURNED OR OTHERWISE AS SPECIFIED.

PRINT DATA:	
DATE	NO.(PRINTS)

NAVEEN KUMAR
BTECH-CIVIL ENGINEER

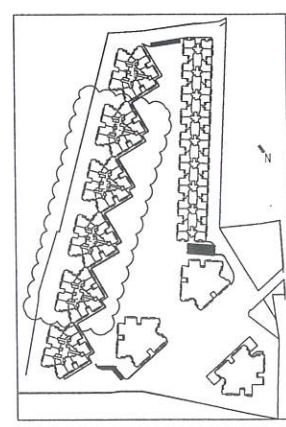

MAJESTIC PROPERTY PVT. LTD.
208,OCEAN COMPLEX SEC-18,NOIDA

MELANGE JEWELS
VILLAGE BHANKROTA, AJMER ROAD, JAIPUR


PLUMBING CONSULTANTS
ARK CONSULTANTS
1/30 ROSHAN GARDEN-II
KAKROLA ROAD NAJAFGARH
NEW DELHI-110043
PH:- 25322575
E-MAIL-ag_arkconsultants@yahoo.com

VASTUNIDHI
ARCHITECT, PLANNER & INT. DESIGNERS
B-28, SECTOR 44,NOIDA
PHONE:2432190 FAX:4331407

TOWER NO.-T5 (FOR FIRE PIPING
TOWER-T1 TO T8 REFER COMBIND
TERRACE FLOOR PLAN)

ORG. TITLE
TERRACE FLOOR PLAN
(FIRE FIGHTING)

SCALE 1:100	REV. NO.
DEALT RAJESH	DRG. NO. CT(4T08)-PL-6
CHECKED MAHENDRA	NORTH
DATE 22.04.15	

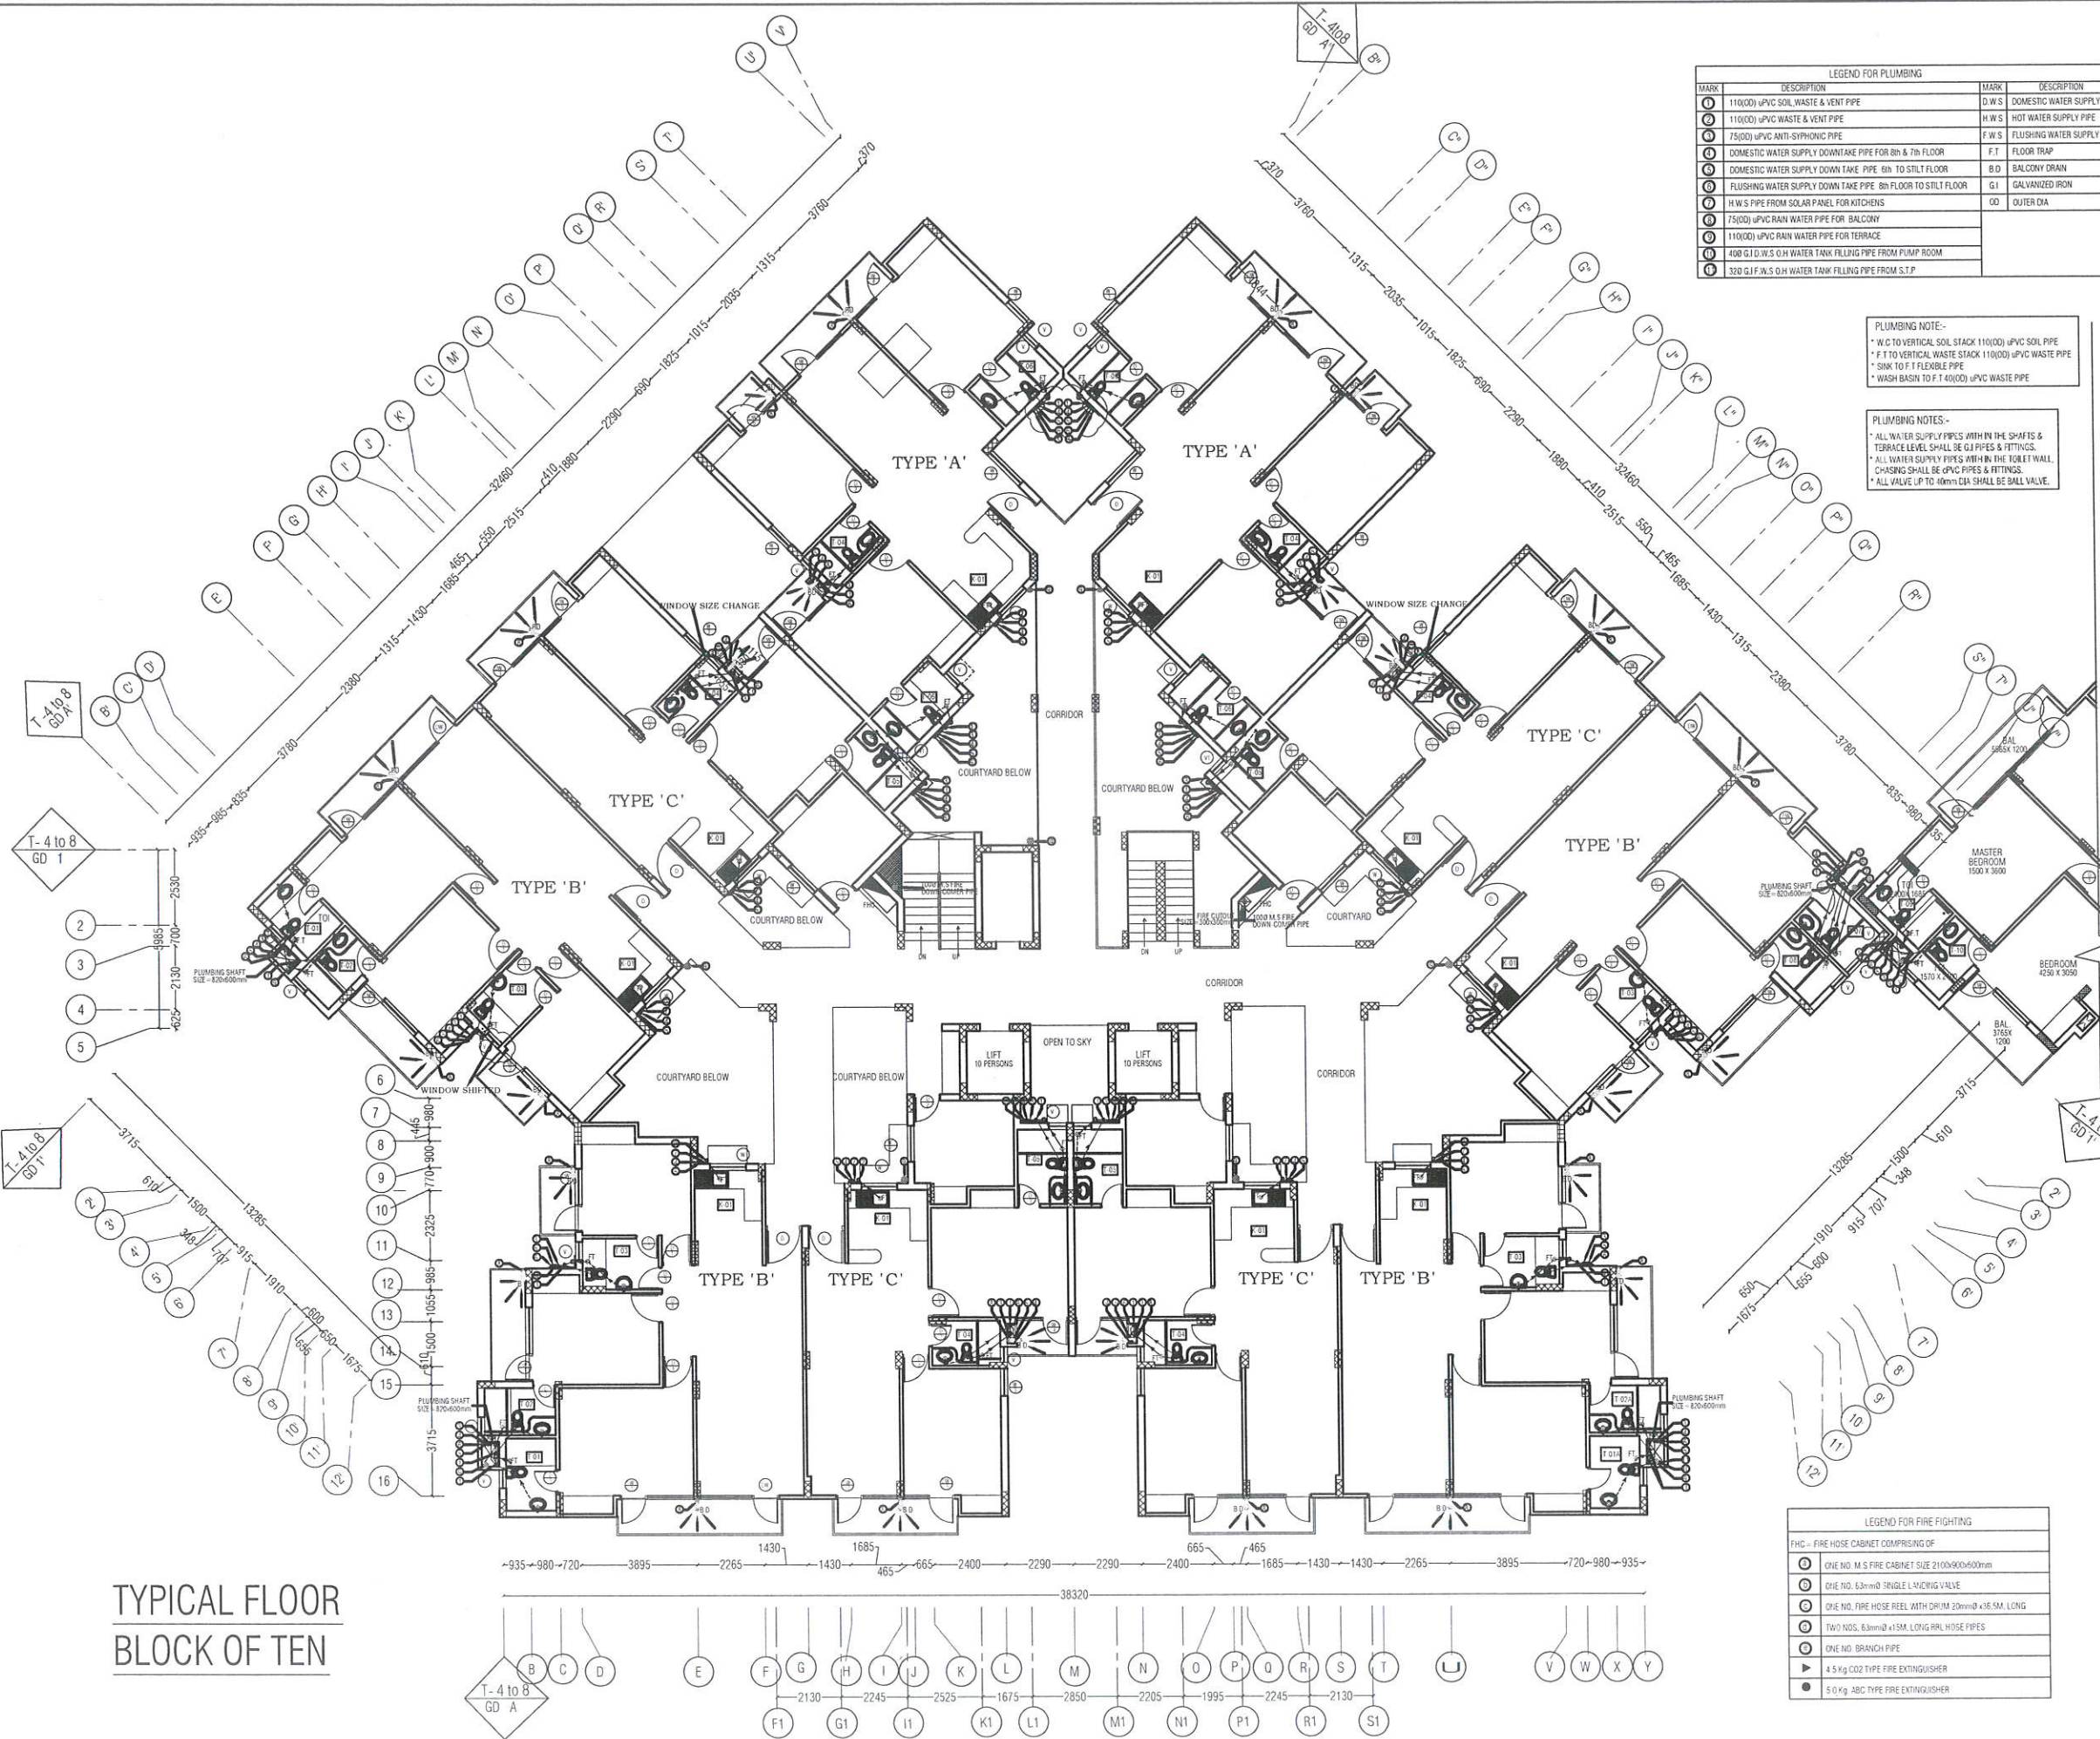

TYPICAL FLOOR
BLOCK OF TEN

LEGEND FOR PLUMBING			
MARK	DESCRIPTION	MARK	DESCRIPTION
110(00) UPVC SOIL WASTE & VENT PIPE		D.W.S	DOMESTIC WATER SUPPLY PIPE
110(00) UPVC WASTE & VENT PIPE		H.W.S	HOT WATER SUPPLY PIPE
75(00) UPVC ANTI-SIPHONIC PIPE		F.W.S	FLUSHING WATER SUPPLY PIPE
DOMESTIC WATER SUPPLY DOWNTAKE PIPE FOR 8th & 7th FLOOR		F.T	FLOOR TRAP
DOMESTIC WATER SUPPLY DOWNTAKE PIPE 6th TO STILT FLOOR		B.D	BALCONY DRAIN
FLUSHING WATER SUPPLY DOWNTAKE PIPE 8th FLOOR TO STILT FLOOR		G.I	GALVANIZED IRON
H.W.S PIPE FROM SOLAR PANEL FOR KITCHENS		OD	OUTER DIA
75(00) UPVC RAIN WATER PIPE FOR BALCONY			
110(00) UPVC RAIN WATER PIPE FOR TERRACE			
400 G.I.D.W.S O.H WATER TANK FILLING PIPE FROM PUMP ROOM			
320 G.I.F.W.S O.H WATER TANK FILLING PIPE FROM S.T.P			

PLUMBING NOTE:-
* W.C TO VERTICAL SOIL STACK 110(00) UPVC SOIL PIPE
* F.T TO VERTICAL WASTE STACK 110(00) UPVC WASTE PIPE
* SINK TO F.I.F FLEXIBLE PIPE
* WASH BASIN TO F.T 40(00) UPVC WASTE PIPE

PLUMBING NOTES:-
* ALL WATER SUPPLY PIPES WITH IN THE SHAFTS & TERRACE LEVEL SHALL BE G.I PIPES & FITTINGS
* ALL WATER SUPPLY PIPES WITH IN THE TOILET WALL CHASING SHALL BE UPVC PIPES & FITTINGS
* ALL VALVE UP TO 10mm DIA SHALL BE BALL VALVE

THIS DRAWING IS THE PROPERTY OF M/S VASTUNIDHI AND SHALL NOT BE REPRODUCED OR USED FOR ANY OTHER PURPOSE THAN SPECIFIED WITHOUT WRITTEN PERMISSION

NOTES:
1. ALL DRAWINGS ARE IN MM
2. THIS DRAWING IS NOT TO BE SCALED
3. THIS DRAWING SHOULD BE READ IN CONJUNCTION WITH OTHER RELEVANT DRAWINGS
4. ANY AMBIGUITY FOUND SHOULD BE REFERRED TO THE ARCHITECT BEFORE EXECUTION
5. RW PIPES ARE DIVERTED TO PIPE LOCATION AS SHOWN
6. THE BEAM FROM WHERE THE TOILET PIPES ARE GOING TOWARDS THE SHAFTS, HAS TO BE UPTURNED OR OTHERWISE AS SPECIFIED

PRINT DATA
S.NO. DATE NO.(PRINTS) ISSUED TO

REVISIONS:
S.NO. REV.NO. PARTICULARS

NAVEEN KUMAR
BTECH-CIVIL ENGINEER



CLIENT:
I-HOMES AND
MAJESTIC PROPERTY PVT. LTD.
208,OCEAN COMPLEX SEC-18,NOIDA

PROJECT:
LAVANYA
VILLAGE BHANKROTA, AJMER ROAD, JAIPUR

PLUMBING CONSULTANTS
ARK CONSULTANTS
1/30 ROSHAN GARDEN-II
KAKROLA ROAD NAJAFGARH
NEW DELHI-110043
PH:- 25322575
E-MAIL:-ag_arkconsultants@yahoo.com

ARCHITECT:
VASTUNIDHI
ARCHITECT, PLANNER & INT. DESIGNERS
B-135, SECTOR 44,NOIDA
PHONE:2432190 FAX:4331407

TOWER NO.
TOWER NO. T1 TO T8

DRG. TITLE
TYPICAL FLOOR PLAN (FIRE FIGHTING)

SCALE 1:100	REV. NO. R4
DEALT RAJESH	DRG. NO. CT(4T08)-PL-5
CHECKED MAHENDRA	NORTH
DATE 22.04.15	

GROUND FLOOR PLAN

LEGEND FOR PLUMBING			
MARK	DESCRIPTION	MARK	DESCRIPTION
110(00) uPVC SOIL WASTE & VENT PIPE		D.W.S	DOMESTIC WATER SUPPLY PIPE
110(00) uPVC WASTE & VENT PIPE		H.W.S	HOT WATER SUPPLY PIPE
75(00) uPVC ANTI-SIPHONIC PIPE		F.W.S	FLUSHING WATER SUPPLY PIPE
DOMESTIC WATER SUPPLY DOWNTAKE PIPE FOR 8th & 7th FLOOR		F.T	FLOOR TRAP
DOMESTIC WATER SUPPLY DOWNTAKE PIPE 8th TO STILT FLOOR		B.D	BALCONY DRAIN
FLUSHING WATER SUPPLY DOWNTAKE PIPE 8th FLOOR TO STILT FLOOR		G.I	GALVANIZED IRON
H.W.S PIPE FROM SOLAR PANEL FOR KITCHENS		OD	OUTER DIA
75(00) uPVC RAIN WATER PIPE FOR BALCONY			
110(00) uPVC RAIN WATER PIPE FOR TERRACE			
408 G.I.D.W.S O.H WATER TANK FILLING PIPE FROM PUMP ROOM			
328 G.I.F.W.S O.H WATER TANK FILLING PIPE FROM S.T.P			

PLUMBING NOTE:-
 * W.C TO VERTICAL SOIL STACK 110(00) uPVC SOIL PIPE
 * F.T TO VERTICAL WASTE STACK 110(00) uPVC WASTE PIPE
 * SINK TO F.T FLEXIBLE PIPE
 * WASH BASIN TO F.T 40(00) uPVC WASTE PIPE

PLUMBING NOTES:-
 * ALL WATER SUPPLY PIPES WITH IN THE SHAFTS & TERRACE LEVEL SHALL BE G.I PIPES & FITTINGS.
 * ALL WATER SUPPLY PIPES WITH IN THE TOILET WALL, CHASING SHALL BE uPVC PIPES & FITTINGS.
 * ALL VALVE UP TO 10mm DIA SHALL BE BALL VALVE.

LEGEND FOR FIRE FIGHTING	
F.H.C - FIRE HOSE CABINET COMPRISING OF	
ONE NO. M.S FIRE CABINET SIZE 2100x900x500mm	
ONE NO. 63mm ID SINGLE LANDING VALVE	
ONE NO. FIRE HOSE REEL WITH DRUM 20mm ID x 35.0M. LONG	
TWO NOS. 63mm ID x 15M. LONG RRL HOSE PIPES	
ONE NO. BRANCH PIPE	
4.5 kg CO2 TYPE FIRE EXTINGUISHER	
5.0 kg ABC TYPE FIRE EXTINGUISHER	

THIS DRAWING IS THE PROPERTY OF M/S VASTUNIDHI AND SHALL NOT BE REPRODUCED OR USED FOR ANY OTHER PURPOSE THAN SPECIFIED WITHOUT WRITTEN PERMISSION

NOTES:
 1. ALL DRAWINGS ARE IN MM.
 2. THIS DRAWING IS NOT TO BE SCALED.
 3. THIS DRAWING SHOULD BE READ IN CONJUNCTION WITH OTHER RELEVANT DRAWINGS.
 4. ANY AMBIGUITY FOUND SHOULD BE REFERRED TO THE ARCHITECT BEFORE EXECUTION.
 5. RW PIPES ARE DIVERTED TO PIPE LOCATION AS SHOWN.
 6. THE BEAM FROM WHERE THE TOILET PIPES ARE GOING TOWARDS THE SHAFTS, HAS TO BE UPTURNED OR OTHERWISE AS SPECIFIED.

PRINT DATA:

S.NO.	DATE	NO (PRINTS)	ISSUED TO

REVISIONS:

S.NO.	REV.NO.	PARTICULARS

NAVEEN KUMAR
 B.TECH-CIVIL ENGINEER



CLIENT:
 I-HOMES AND MAJESTIC PROPERTY PVT. LTD.
 208, OCEAN COMPLEX SEC-18, NOIDA

PROJECT:
 LAVANYA HOUSING
 VILLAGE BHANKROTA, AJMER ROAD, JAIPUR


PLUMBING CONSULTANTS
 ARK CONSULTANTS
 1/30 ROSHAN GARDEN-II
 KAKROLA ROAD NAJAFGARH
 NEW DELHI-110043
 PH:- 25322575
 E-MAIL-ag_arkconsultants@yahoo.com

ARCHITECT:
 VASTUNIDHI
 ARCHITECT, PLANNER & INT. DESIGNERS
 B-135, SECTOR 44, NOIDA
 PHONE: 2432190 FAX: 4331407

TOWER NO.
 TOWER NO. T1 TO T8

DRG. TITLE
 GROUND FLOOR & CEILING
 PLAN (FIRE FIGHTING)

SCALE 1:100	REV. NO. R3
DEALT RAJESH	DRG. NO. CT(4T08)-PL-4
CHECKED MAHENDRA	NORTH
DATE 22.04.15	

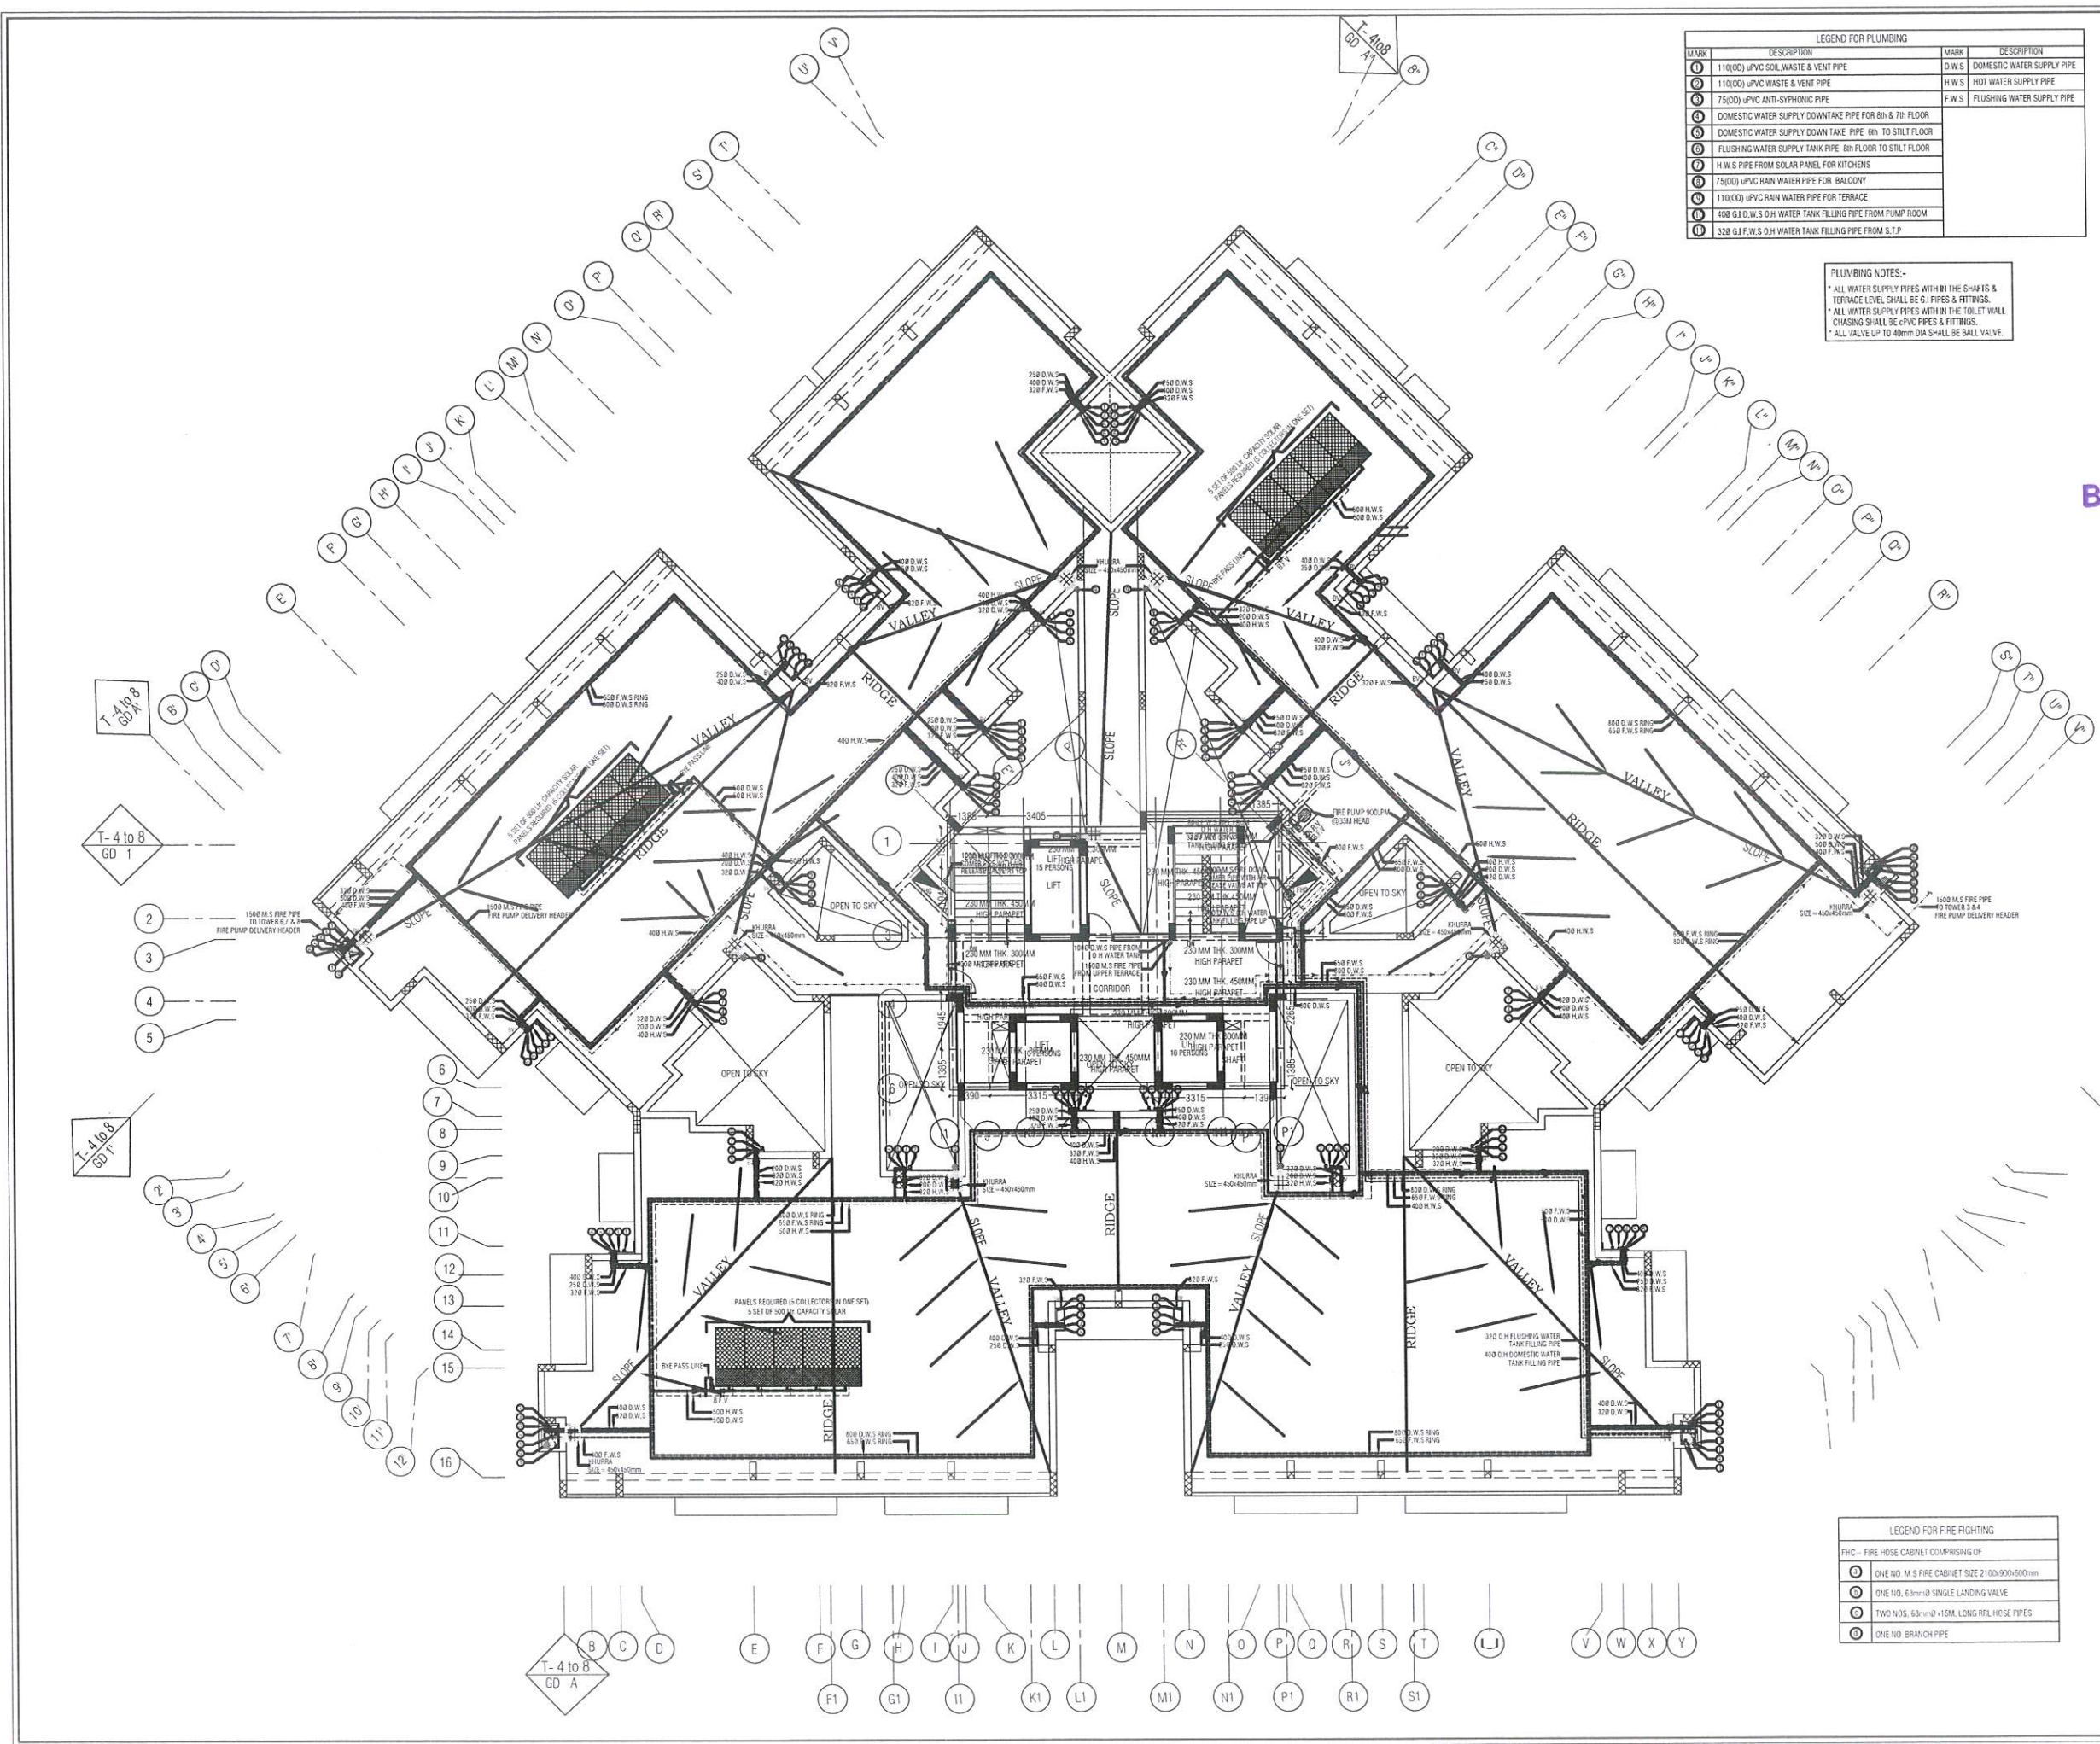

LEGEND FOR PLUMBING			
MARK	DESCRIPTION	MARK	DESCRIPTION
1	110(D) UPVC SOIL WASTE & VENT PIPE	D.W.S.	DOMESTIC WATER SUPPLY PIPE
2	110(D) UPVC WASTE & VENT PIPE	H.W.S.	HOT WATER SUPPLY PIPE
3	75(D) UPVC ANTI-SYPHONIC PIPE	F.W.S.	FLUSHING WATER SUPPLY PIPE
4	DOMESTIC WATER SUPPLY DOWNTAKE PIPE FOR 8th & 7th FLOOR		
5	DOMESTIC WATER SUPPLY DOWNTAKE PIPE 8th TO STILT FLOOR		
6	FLUSHING WATER SUPPLY DOWNTAKE PIPE 8th FLOOR TO STILT FLOOR		
7	H.W.S. PIPE FROM SOLAR PANEL FOR KITCHENS		
8	75(D) UPVC RAIN WATER PIPE FOR BALCONY		
9	110(D) UPVC RAIN WATER PIPE FOR TERRACE		
10	408 G.I. D.W.S. O.H. WATER TANK FILLING PIPE FROM PUMP ROOM		
11	328 G.I. F.W.S. O.H. WATER TANK FILLING PIPE FROM S.T.P.		

PLUMBING NOTES:-
• ALL WATER SUPPLY PIPES WITHIN THE SHAPES & TERRACE LEVEL SHALL BE G.I. PIPES & FITTINGS.
• ALL WATER SUPPLY PIPES WITHIN THE TOILET WALL CHASING SHALL BE CPVC PIPES & FITTINGS.
• ALL VALVE UP TO 40mm DIA SHALL BE BALL VALVE.

THIS DRAWING IS THE PROPERTY OF M/S VASTUNIDHI AND SHALL NOT BE REPRODUCED OR USED FOR ANY OTHER PURPOSE THAN SPECIFIED WITHOUT WRITTEN PERMISSION

1. ALL DRAWINGS ARE IN MM.
2. THIS DRAWING IS NOT TO BE SCALED.
3. THIS DRAWING SHOULD BE READ IN CONJUNCTION WITH OTHER RELEVANT DRAWINGS.
4. ANY AMBIGUITY FOUND SHOULD BE REFERRED TO THE ARCHITECT BEFORE EXECUTION.
5. R/W PIPES ARE DIVERTED TO PIPE LOCATION AS SHOWN.
6. THE BEAM FROM WHERE THE TOILET PIPES ARE GOING TOWARDS THE SHAFTS, HAS TO BE UPTURNED OR OTHERWISE AS SPECIFIED.

PRINT DATA:
DATE: NO. (PRINTS):
REVISIONS:
REV. NO.:

NAVEEN KUMAR
BTECH-CIVIL ENGINEER

MAJESTIC PROPERTY PVT. LTD.
208, OCEAN COMPLEX SEC-18, NOIDA

MELANGE JEWELS
VILLAGE BHANKROTA, AJMER ROAD, JAIPUR


PLUMBING CONSULTANTS
ARK CONSULTANTS
1/30 ROSHAN GARDEN-II
KAKROLA ROAD NAJAFGARH
NEW DELHI-110043
PH:- 25322575
E-MAIL- ag_arkconsultants@yahoo.com

VASTUNIDHI
ARCHITECT, PLANNER & INT. DESIGNERS
B-28, SECTOR 44, NOIDA
PHONE: 2432190 FAX: 4331407

TOWER NO.-T5 (FOR FIRE PIPING)
TOWER-T1 TO T8 REFER COMBIND TERRACE FLOOR PLAN)

DRG. TITLE
TERRACE FLOOR PLAN (FIRE FIGHTING)

SCALE 1:100	REV. NO.
DEALT RAJESH	DRG. NO. CT(4T08)-PL-6
CHECKED MAHENDRA	NORTH
DATE 22.04.15	

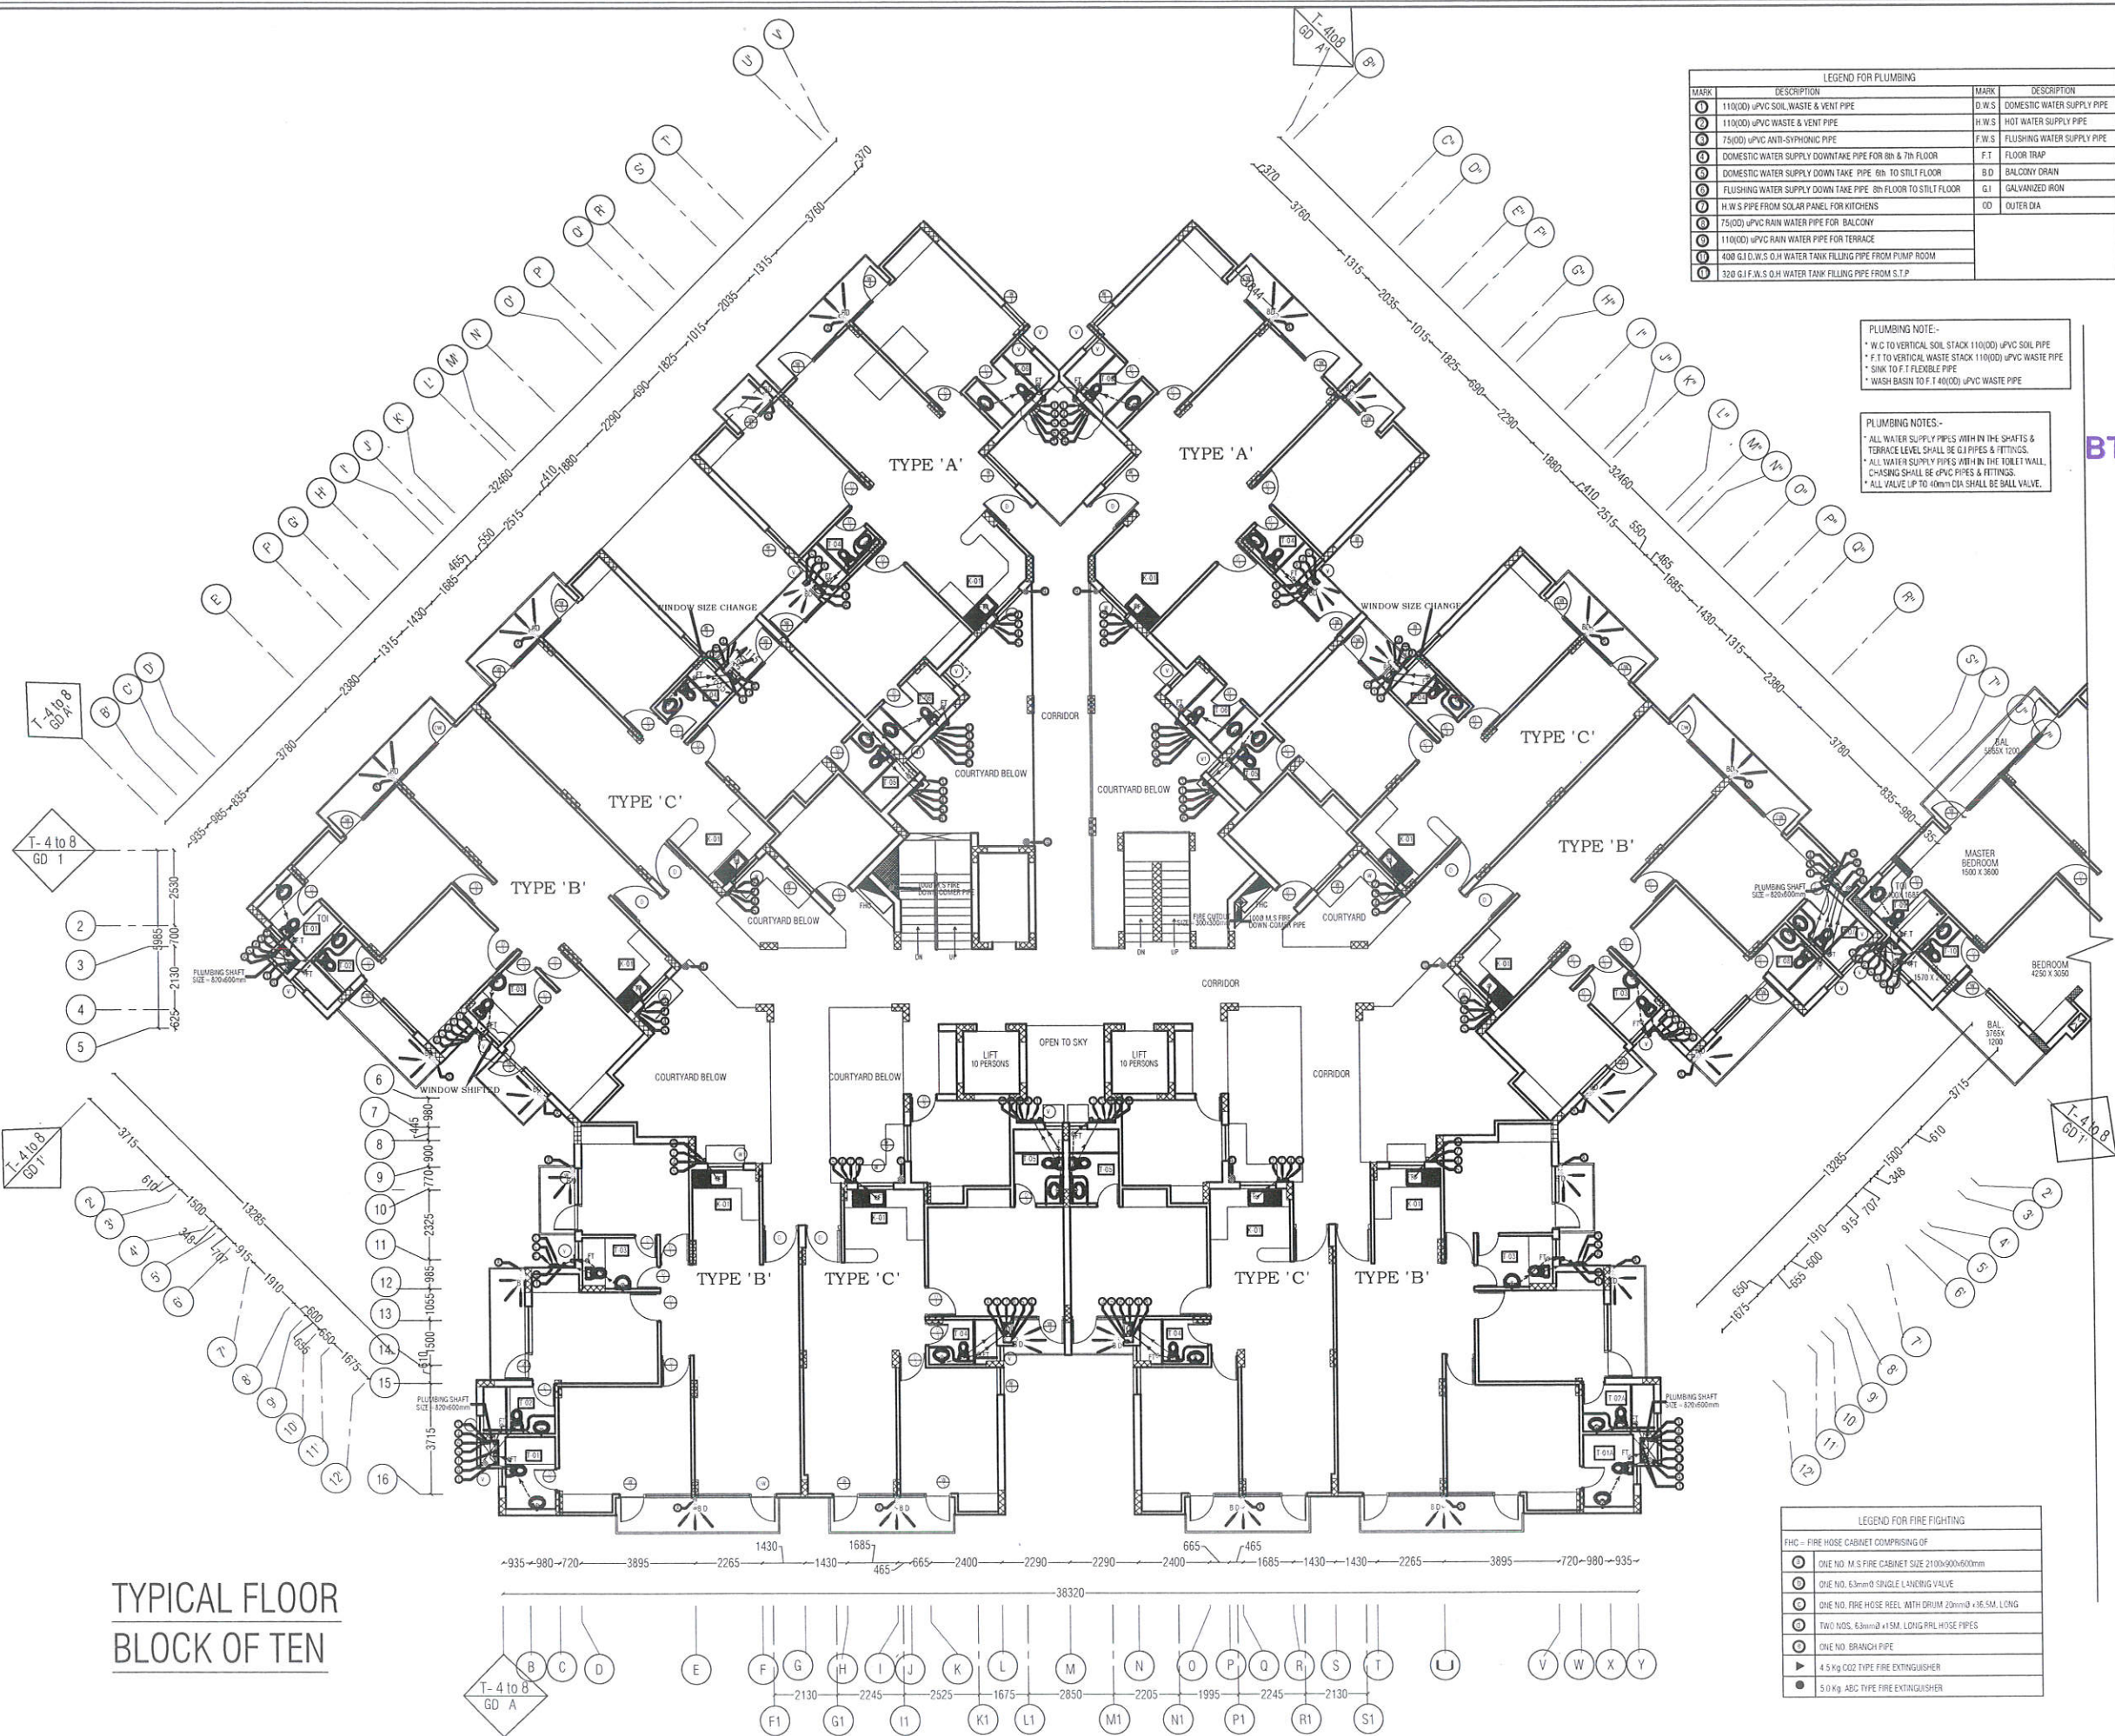

THIS DRAWING IS THE PROPERTY OF M/S VASTUNIDHI AND SHALL NOT BE REPRODUCED OR USED FOR ANY OTHER PURPOSE THAN SPECIFIED WITHOUT WRITTEN PERMISSION

NOTES:
1. ALL DRAWINGS ARE IN MM.
2. THIS DRAWING IS NOT TO BE SCALED.
3. THIS DRAWING SHOULD BE READ IN CONJUNCTION WITH OTHER RELEVANT DRAWINGS.
4. ANY AMBIGUITY FOUND SHOULD BE REFERRED TO THE ARCHITECT BEFORE EXECUTION.
5. RW PIPES ARE INVERTED TO PIPE LOCATION AS SHOWN.
6. THE BEAM FROM WHERE THE TOILET PIPES ARE GOING TOWARDS THE SHAFTS, HAS TO BE OBTAINED OR OTHERWISE AS SPECIFIED.

PRINT DATA:
S.NO. DATE NO.(PRINTS) ISSUED TO

REVISIONS:
S.NO. REV. NO. PARTICULARS

NAVEEN KUMAR
BTECH-CIVIL ENGINEER

CLIENT:
I-HOMES AND MAJESTIC PROPERTY PVT. LTD.
208, OCEAN COMPLEX SEC-18, NOIDA

PROJECT:
LAVANYA
VILLAGE BHANKROTA, AJMER ROAD, JAIPUR

PLUMBING CONSULTANTS
ARK CONSULTANTS
1/30 ROSHAN GARDEN-II
KAKROLA ROAD NAJAFGARH
NEW DELHI-110043
PH:- 25322575
E-MAIL-ag_arkconsultants@yahoo.com

ARCHITECT:
VASTUNIDHI
ARCHITECT, PLANNER & INT. DESIGNERS
B-135, SECTOR 44, NOIDA
PHONE:2432190 FAX:4331407

TOWER NO.
TOWER NO. T1 TO T8

DRG. TITLE
TYPICAL FLOOR PLAN (FIRE FIGHTING)

SCALE
1:100

DEALT
RAJESH


CHECKED
MAHENDRA

DATE
22.04.15

REV. NO. R4

DRG. NO.
CT(4T08)-PL-5

NORTH

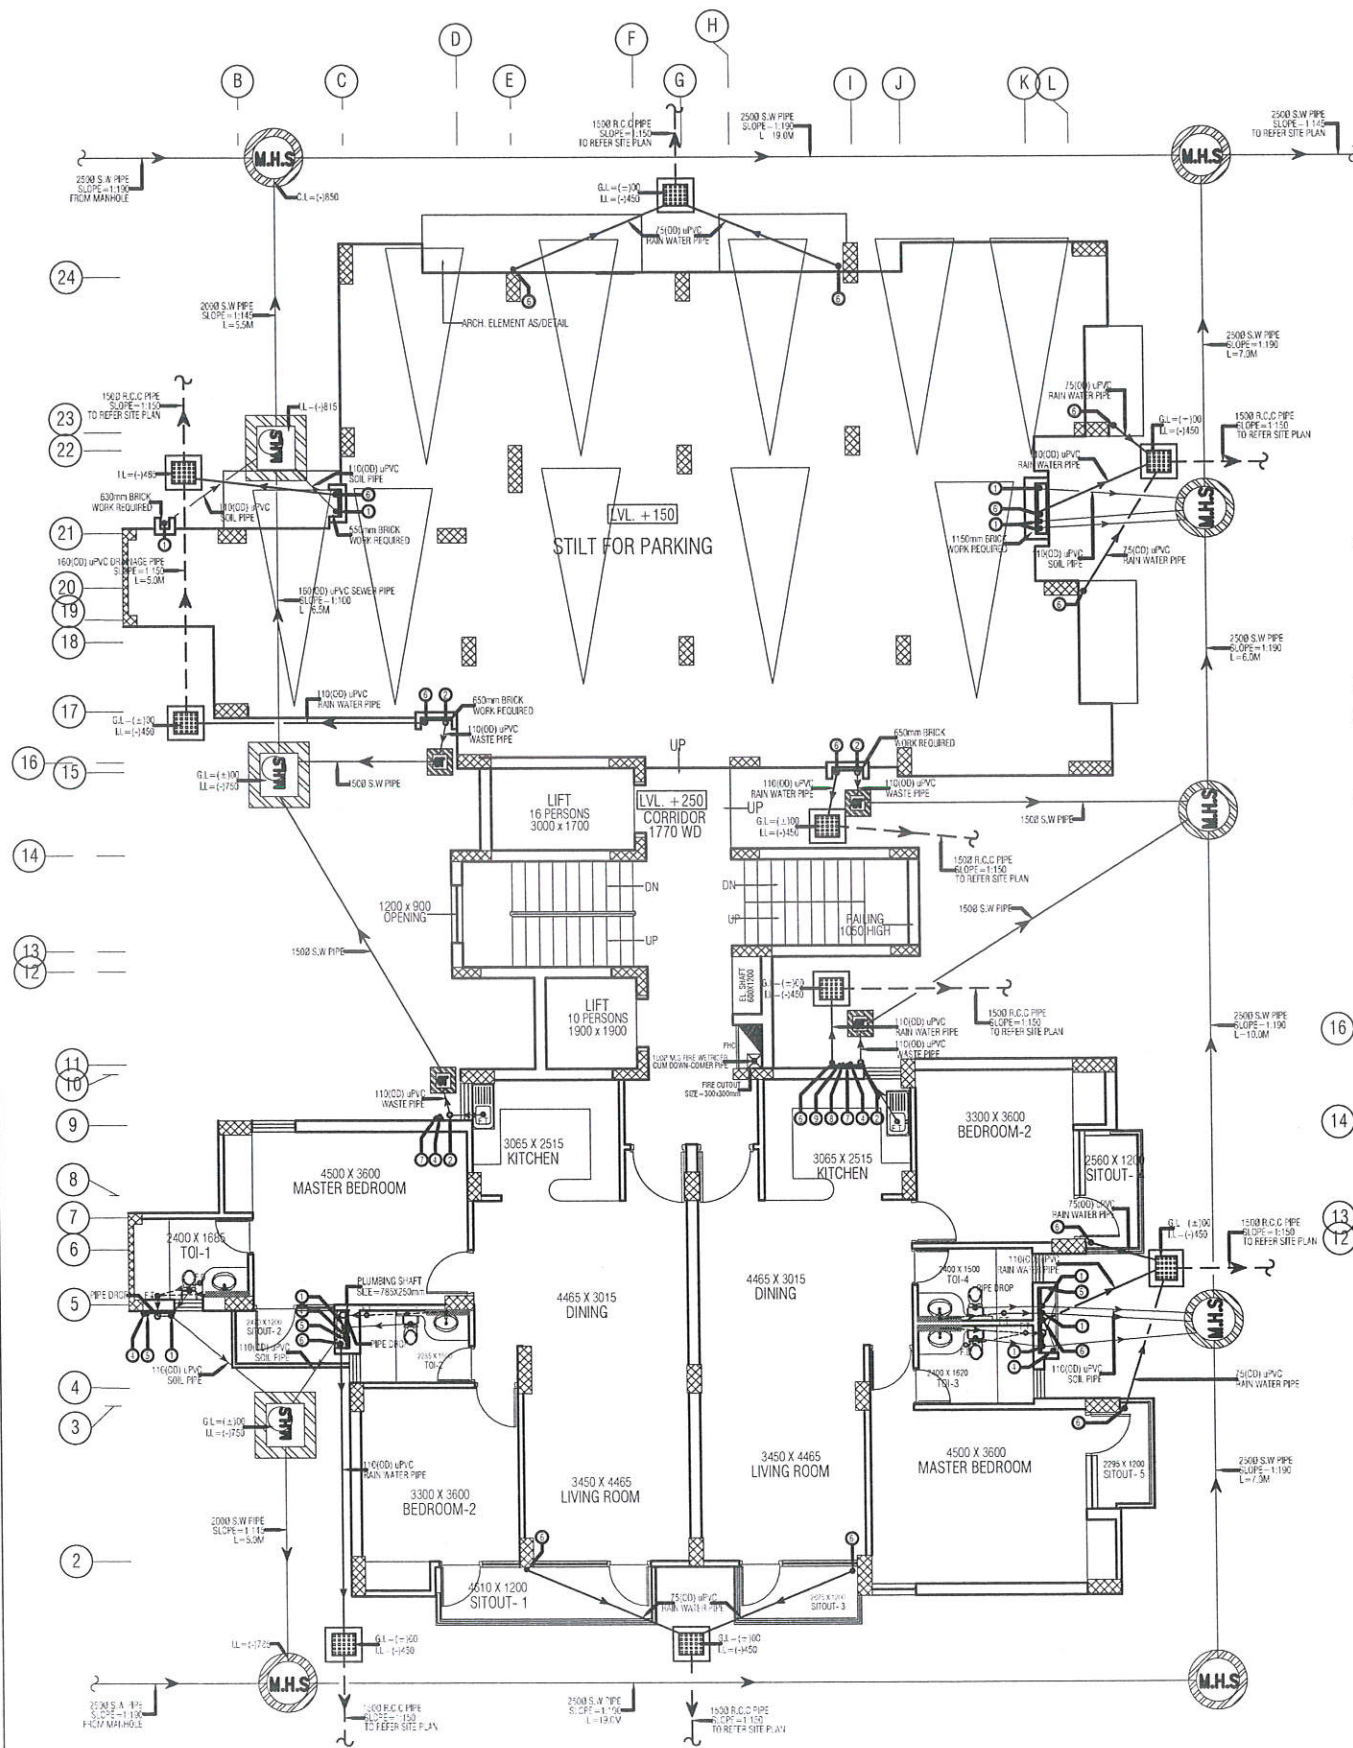

STILT PLAN


PLUMBING NOTE:-
* CIRCULAR MANHOLE EXACT LOCATION & INVERT LEVEL TAKING FROM PLUMBING SITE LAYOUT PLAN

LEGEND FOR PLUMBING			
MARK	DESCRIPTION	MARK	DESCRIPTION
1	110(OD) uPVC SOIL, WASTE & VENT PIPE	D.W.S	DOMESTIC WATER SUPPLY PIPE
2	110(OD) uPVC WASTE & VENT PIPE FOR KITCHEN	H.W.S	HOT WATER SUPPLY PIPE
3	75(OD) uPVC ANTI-SYPHONIC PIPE	F.W.S	FLUSHING WATER SUPPLY PIPE
4	DOMESTIC WATER SUPPLY DOWNTAKE PIPE FOR 8th & 7th FLOOR	F.T	FLOOR TRAP
5	DOMESTIC WATER SUPPLY DOWNTAKE PIPE 6th TO STILT FLOOR	F.D	FLOOR DRAIN
6	FLUSHING WATER SUPPLY TANK PIPE 8th FLOOR TO STILT FLOOR	B.D	BALCONY DRAIN
7	75(OD) uPVC RAIN WATER PIPE FOR BALCONY	G.I	GALVANIZED IRON
8	110(OD) uPVC RAIN WATER PIPE FOR TERRACE	OD	OUTER DIA
9	H.W.S PIPE FROM SOLAR PANEL FOR KITCHENS		
10	400 G.I D.W.S O.H WATER TANK FILLING PIPE FROM PUMP ROOM		
11	320 G.I F.W.S O.H WATER TANK FILLING PIPE FROM S.T.P		

PLUMBING NOTE:-
* W.C TO VERTICAL SOIL STACK 110(OD) uPVC SOIL PIPE
* F.T TO VERTICAL WASTE STACK 110(OD) uPVC WASTE PIPE
* F.D TO F.T 63(OD) uPVC WASTE PIPE
* SINK TO F.T FLEXIBLE PIPE
* WASH BASIN TO F.T 40(OD) uPVC WASTE PIPE

PLUMBING NOTES:-
* ALL WATER SUPPLY PIPES WITH IN THE SHAFTS & TERRACE LEVEL SHALL BE G.I PIPES & FITTINGS.
* ALL WATER SUPPLY PIPES WITH IN THE TOILET WALL, CHASING SHALL BE uPVC PIPES & FITTINGS.
* ALL VALVE UP TO 40mm DIA SHALL BE BALL VALVE.

LEGEND FOR FIRE FIGHTING	
FHC = FIRE HOSE CABINET COMPRISING OF	
1	ONE NO. M.S FIRE CABINET SIZE 2100x900x600mm
2	ONE NO. 63mmØ SINGLE LANDING VALVE
3	ONE NO. FIRE HOSE REEL WITH DRUM 20mmØ x36.5M. LONG
4	TWO NOS. 63mmØ x15M. LONG RRL HOSE PIPES
5	ONE NO. BRANCH PIPE
6	4.5 Kg CO2 TYPE FIRE EXTINGUISHER
7	5.0 Kg. ABC TYPE FIRE EXTINGUISHER

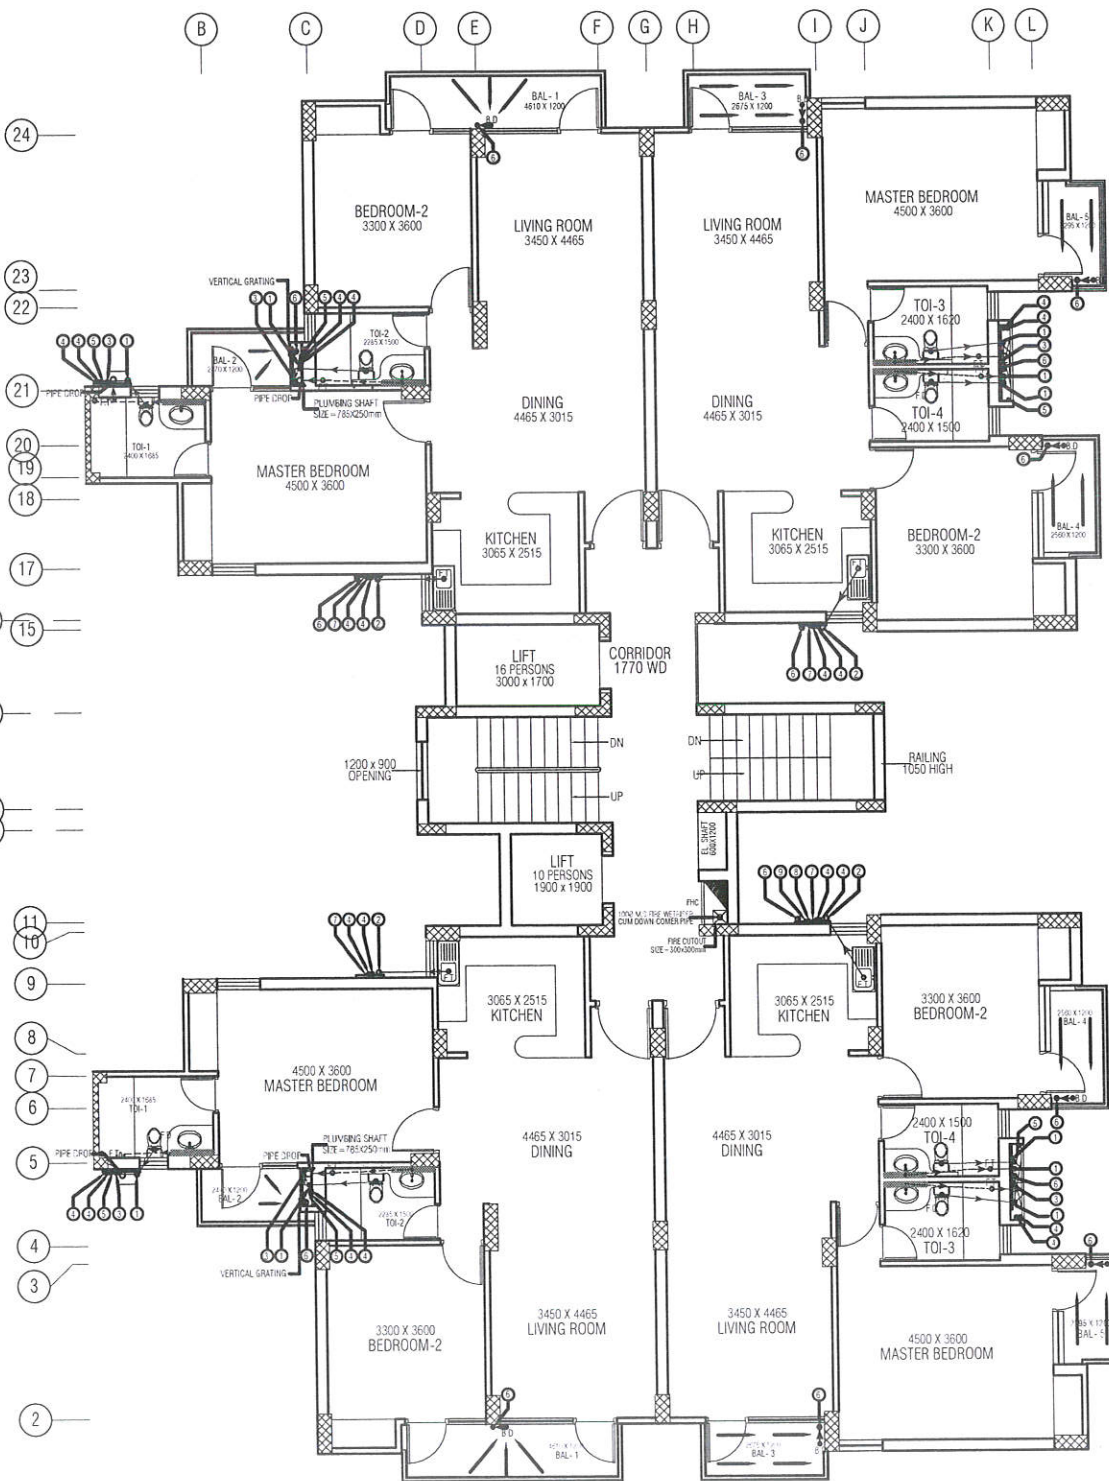

TYPICAL PLAN

NAVEEN KUMAR
BTECH-CIVIL ENGINEER

THIS DRAWING IS THE PROPERTY OF M/S VASTUNIDHI AND SHALL NOT BE REPRODUCED OR USED FOR ANY OTHER PURPOSE THAN SPECIFIED WITHOUT WRITTEN PERMISSION

NOTES:
1. ALL DRAWINGS ARE IN MM.
2. THIS DRAWING IS NOT TO BE SCALED.
3. THIS DRAWING SHOULD BE READ IN CONJUNCTION WITH OTHER RELEVANT DRAWINGS.
4. ANY AMBIGUOUS FIGURE SHOULD BE REFERRED TO THE ARCHITECT BEFORE EXECUTION.
5. R/W PIPES ARE DIVERTED TO PIPE LOCATION AS SHOWN.
6. THE BEAM FROM WHERE THE TOILET PIPES ARE GOING TOWARDS THE SHAFTS, HAS TO BE LIFTED UP OR OTHERWISE AS SPECIFIED.

PRINT DATA			
S.NO.	DATE	NO. (PRINTS)	ISSUED TO
REVISIONS			
S.NO.	REV. NO.	PARTICULARS	



CLIENT:
I-HOMES AND MAJESTIC PROPERTIES PVT.LTD.
208, OCEAN COMPLEX SEC-18, NOIDA

PROJECT:
LAVANYA
VILLAGE BHANKROTA, AJMER ROAD, JAIPUR


PLUMBING CONSULTANTS
ARK CONSULTANTS
1/30 ROSHAN GARDEN-II
KAKROLA ROAD NAJAFGARH
NEW DELHI-110043
PH:- 25322575
E-MAIL:- ag_arkconsultants@yahoo.com

ARCHITECT:
VASTUNIDHI
ARCHITECT, PLANNER & INT. DESIGNERS
B-135, SECTOR 44, NOIDA
PHONE: 2432190 FAX: 4331407

TOWER NO.
TOWER NO. T17

DRG. TITLE
GROUND & TYPICAL FLOOR PLAN (PLUMBING)

SCALE 1:75	REV. NO. R2
DEALT HITESH	DRG. NO. DT(9.17)-PL-01
CHECKED MAHENDRA	
DATE 12-03-2014	

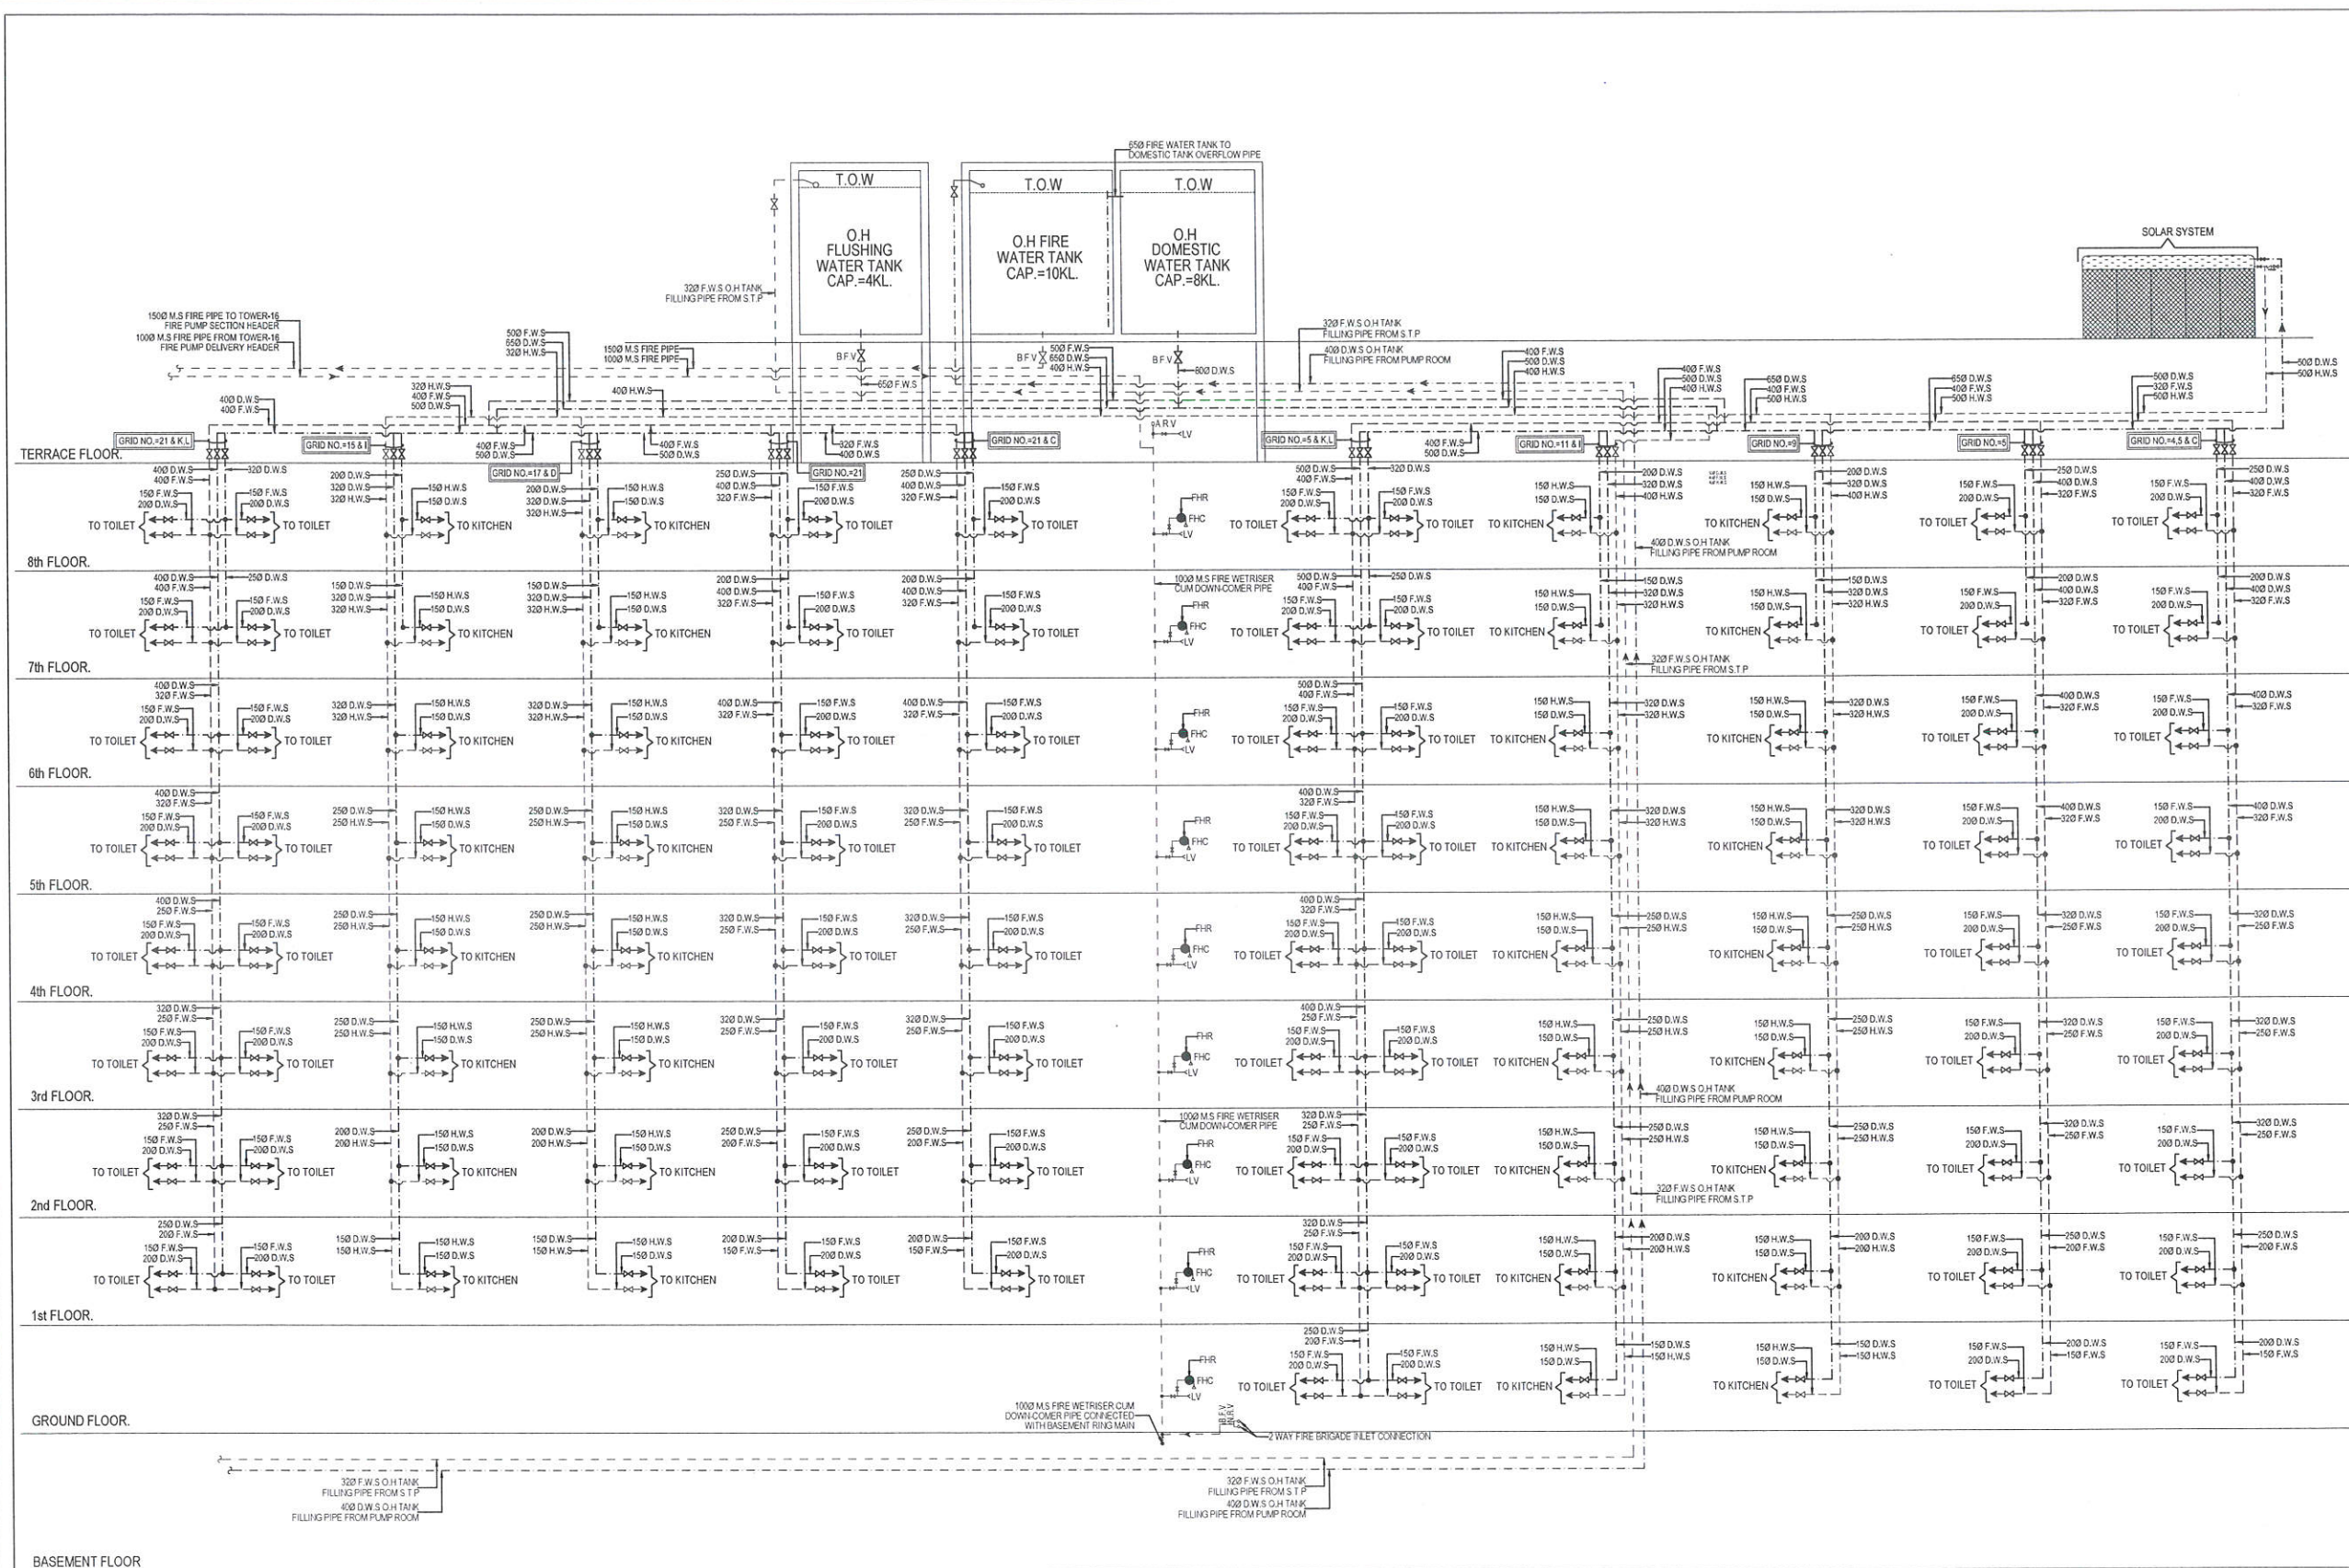

THIS DRAWING IS THE PROPERTY OF M/S VASTUNIDHI AND SHALL NOT BE REPRODUCED OR USED FOR ANY OTHER PURPOSE THAN SPECIFIED WITHOUT WRITTEN PERMISSION

NOTES:
 1. ALL DRAWINGS ARE IN MM.
 2. THIS DRAWING IS NOT TO BE SCALED.
 3. THIS DRAWING SHOULD BE READ IN CONJUNCTION WITH OTHER RELEVANT DRAWINGS.
 4. ANY AMBIGUITY FOUND SHOULD BE REFERRED TO THE ARCHITECT BEFORE EXECUTION.
 5. R/W PIPES ARE DIVERTED TO PIPE LOCATION AS SHOWN.
 6. THE BEAM FROM WHERE THE TOILET PIPES ARE GOING TOWARDS THE SHAFTS, HAS TO BE TURNED OR OTHERWISE AS SPECIFIED.

PRINT DATA:
 S.NO. DATE NO.(PRINTS) ISSUED TO

REVISIONS:
 S.NO. REV.NO. PARTICULARS

CLIENT:
I-HOMES AND MAJESTIC PROPERTIES PVT.LTD.
 208,OCEAN COMPLEX SEC-18,NOIDA

PROJECT:
LAVANYA
 VILLAGE BHANKROTA, AJMER ROAD, JAIPUR

PLUMBING CONSULTANTS
ARK CONSULTANTS
 1/30 ROSHAN GARDEN-II
 KAKROLA ROAD NAJAFGARH
 NEW DELHI-110043
 PH:- 25322575
 E-MAIL-ag_arkconsultants@yahoo.com

ARCHITECT:
VASTUNIDHI
 ARCHITECT, PLANNER & INT. DESIGNERS
 B-135, SECTOR 44,NOIDA
 PHONE:2432190 FAX:4331407

TOWER NO.
TOWER NO. B&C

DRG. TITLE
**WATER SUPPLY SYSTEM
 DIAGRAM (PLUMBING)**

SCALE
1:150

DEALT
HITESH

CHECKED
MAHENDRA

DATE
12-03-2014

REV. NO.
**DRG. NO.
 D'T(9)-PL-SYS-7**

LEGEND FOR PLUMBING

D.W.S	DOMESTIC WATER SUPPLY PIPE
F.W.S	FLUSHING WATER SUPPLY PIPE
H.W.S	HOT WATER SUPPLY PIPE
T.O.W	TOP OF WATER
N.R.V	NON-RETURN VALVE
B.F.V	BUTTER FLY VALVE
VALVE	VALVE
N.R.V	NON-RETURN VALVE

PLUMBING NOTES:-
 * ALL VALVE UP TO 40mm DIA SHALL BE BALL VALVE
 * ALL VALVE 50mm DIA & ABOVE SHALL BE BUTTER FLY VALVE.

NAVEEN KUMAR
BTECH-CIVIL ENGINEER