


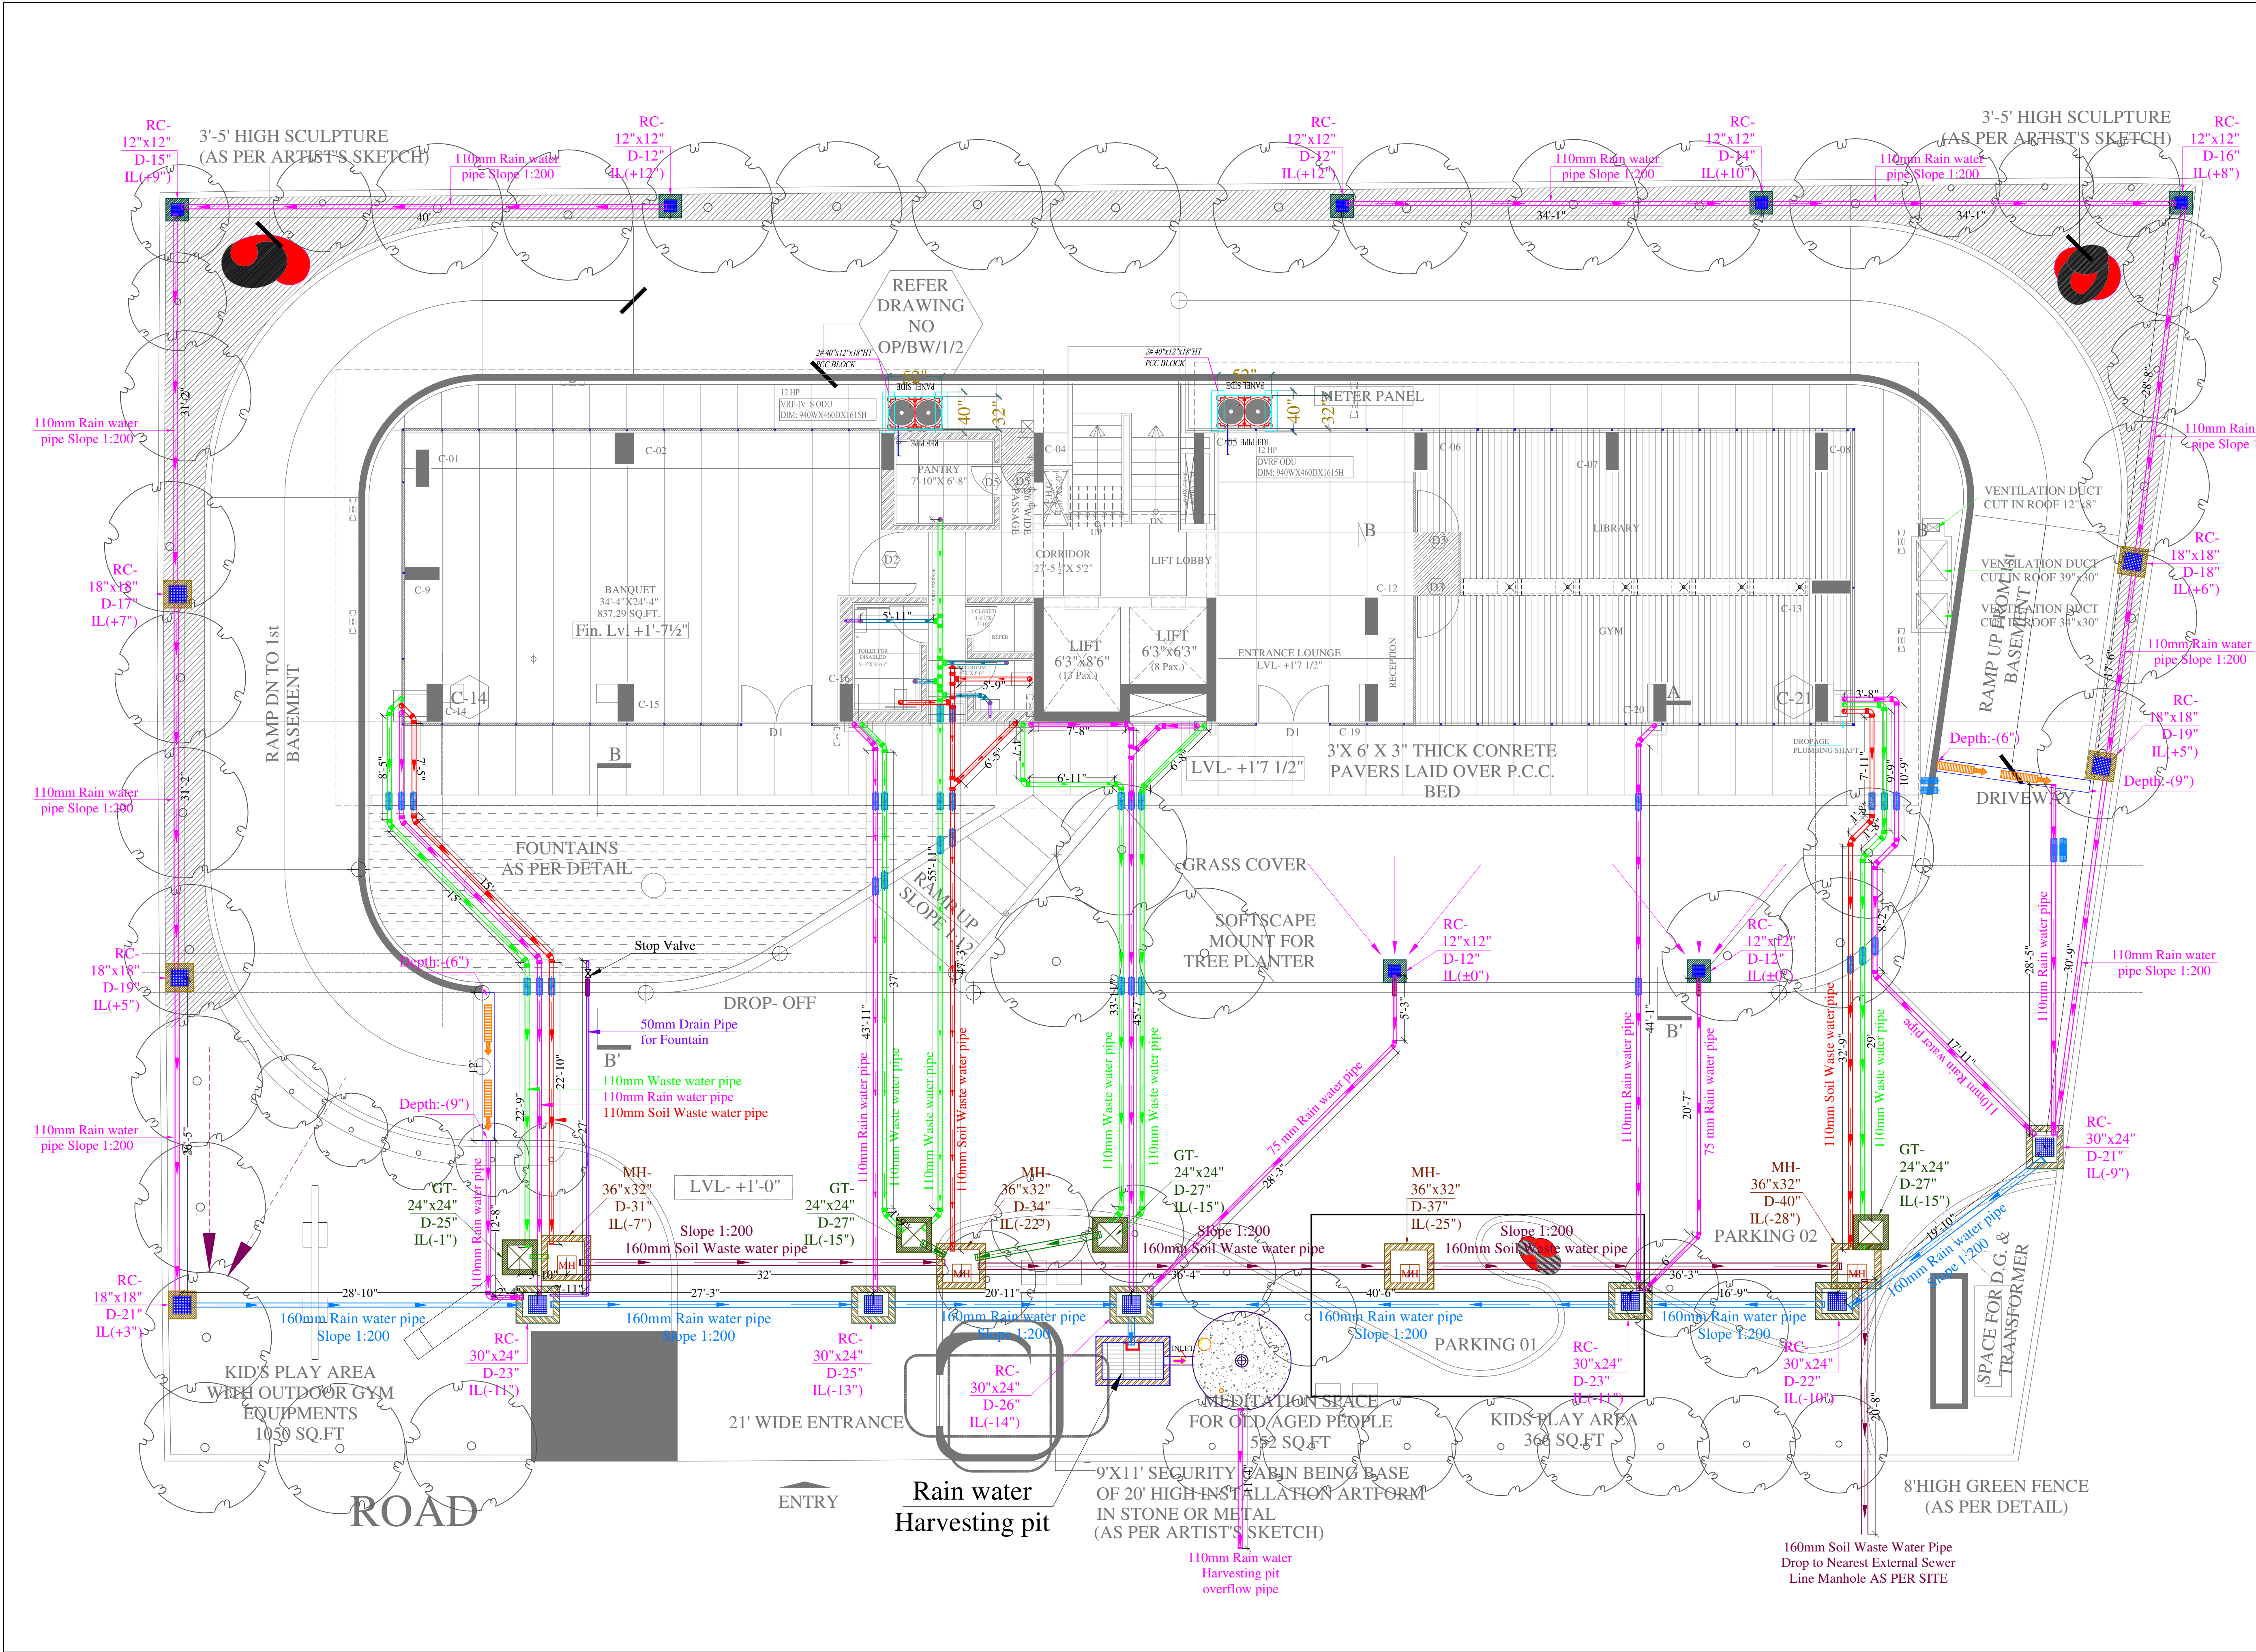

REV NO.

DATE

REMARKS

VIPUL AGARWAL

M.E.P. CONSULTANT

B.E. ELECTRICAL

LEGENDS:-

GULLY TRAP
300X300MM

SEWERAGE MANHOLE
900X800MM

GULLY TRAP
600X600MM

RAIN WATER CHAMBER
750X600 MM

RAIN WATER HARVESTING TANK

PIPES & SLOPE DETAIL :-

Ø 160mm RAIN WATER PIPE SLOPE 1:200

Ø 110mm RAIN WATER PIPE SLOPE 1:150

Ø 160mm SOIL WATER PIPE SLOPE 1:200

Ø 110mm SOIL WATER PIPE SLOPE 1:150

Ø 160mm WASTE WATER PIPE SLOPE 1:200

Ø 110mm WASTE WATER PIPE SLOPE 1:150

SERVICES CONSULTANT:
VIPUL CONSULTING,
F 9 / 440 , Keshav Marg Chitrakut Scheme,Jaipur
PH:91-0-93146-1043X 0141-2449494 Mail:vipul8599@yahoo.com
REV. NO. 02 DATE: 04-10-2018

PROJECT ADDRESS:

PLOT NO. D-23A,
PRITHVIRAJ ROAD,
C-SCHEME, JAIPUR

PROJECT NAME:

5TH AVENUE

CLIENT:

UPASANA COLONISERS AND RESORTS,
B-70, RAJENDRA MARG,
BAPU NAGAR,
JAIPUR-302015

ARCHITECT

Ricky Mathur & Associates

architects interior designers planners

33, Dhuleshwar Garden,
Jaipur. (RAJ.) India. 302 001
Tel: 91-141-236 2688, 512 5444
Fax: 91-141-400 8700
e-mail: ricky@rickymathur.com

DRAWING TITLE

GROUND FLOOR EXTERNAL
DRAINAGE PLAN

SCALE

N.T.S.

DATE

04-10-2018

DEALT BY

RAAJ

STATUS


CONCEPT

NORTH

DRG NO.


REVISION

R2

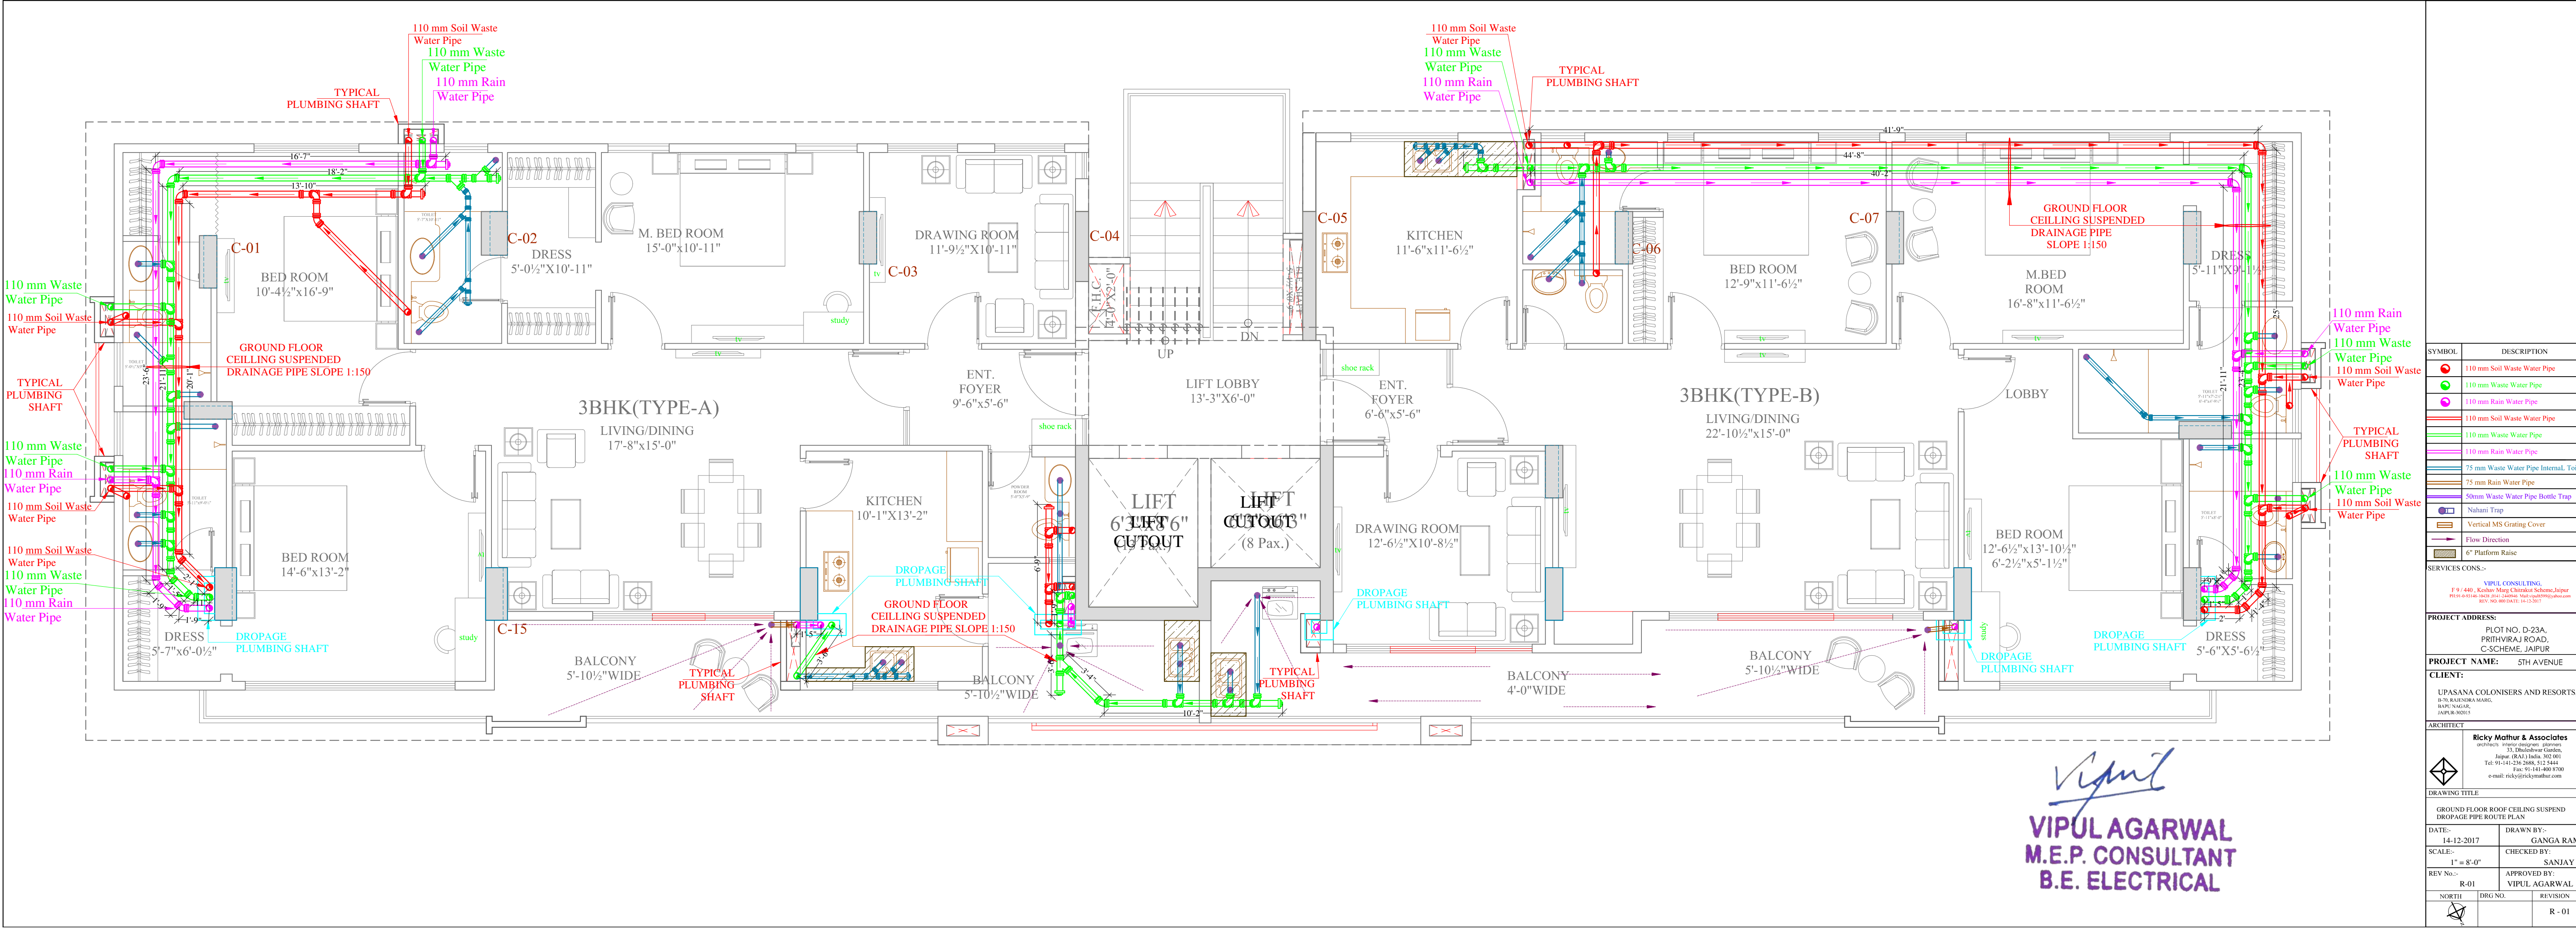

Vipul
VIPUL AGARWAL
M.E.P. CONSULTANT
B.E. ELECTRICAL

SYMBOL	DESCRIPTION
	110 mm Soil Waste Water Pipe
	110 mm Waste Water Pipe
	110 mm Rain Water Pipe
	110 mm Soil Waste Water Pipe
	110 mm Waste Water Pipe
	110 mm Rain Water Pipe
	75 mm Waste Water Pipe Internal Toilet
	75 mm Rain Water Pipe
	Shower Waste Water Pipe Bottle Trap
	Nahani Trap
	Vertical MS Grating Cover
	Flow Direction
	6" Platform Raise
SERVICES CONS:-	
VIPUL CONSULTING, F/9/440, Keshav Marg Chitrakot Scheme, Jaipur Rajasthan-302002, India. Tel: 91-141-250 2488, 512 5444. Fax: 91-141-460 8700 e-mail: ricky@rickymathur.com	
PROJECT ADDRESS:-	
PLOT NO. D-23A, PRITHVIRAJ ROAD, C-SCHEME, JAIPUR	
PROJECT NAME:-	
5TH AVENUE	
CLIENT:-	
UPASANA COLONISERS AND RESORTS, B-16, KACHHARA MARG, BAPET NAGAR, JAIPUR-302012	
ARCHITECT	
 Ricky Mathur & Associates architects: ricky mathur, shantanu 31, Durgam Chandra Jaipur-302012, India. Tel: 91-141-250 2488, 512 5444. Fax: 91-141-460 8700 e-mail: ricky@rickymathur.com	
DRAWING TITLE	
GROUND FLOOR ROOF CEILING SUSPEND DROPAGE PIPE ROUTE PLAN	
DATE:- 14-12-2017	DRAWN BY:- GANGA RAM
SCALE:- 1" = 8'-0"	CHECKED BY:- SANJAY
REV No.:- R-01	APPROVED BY:- VIPUL AGARWAL
NORTH 	REVISION R - 01

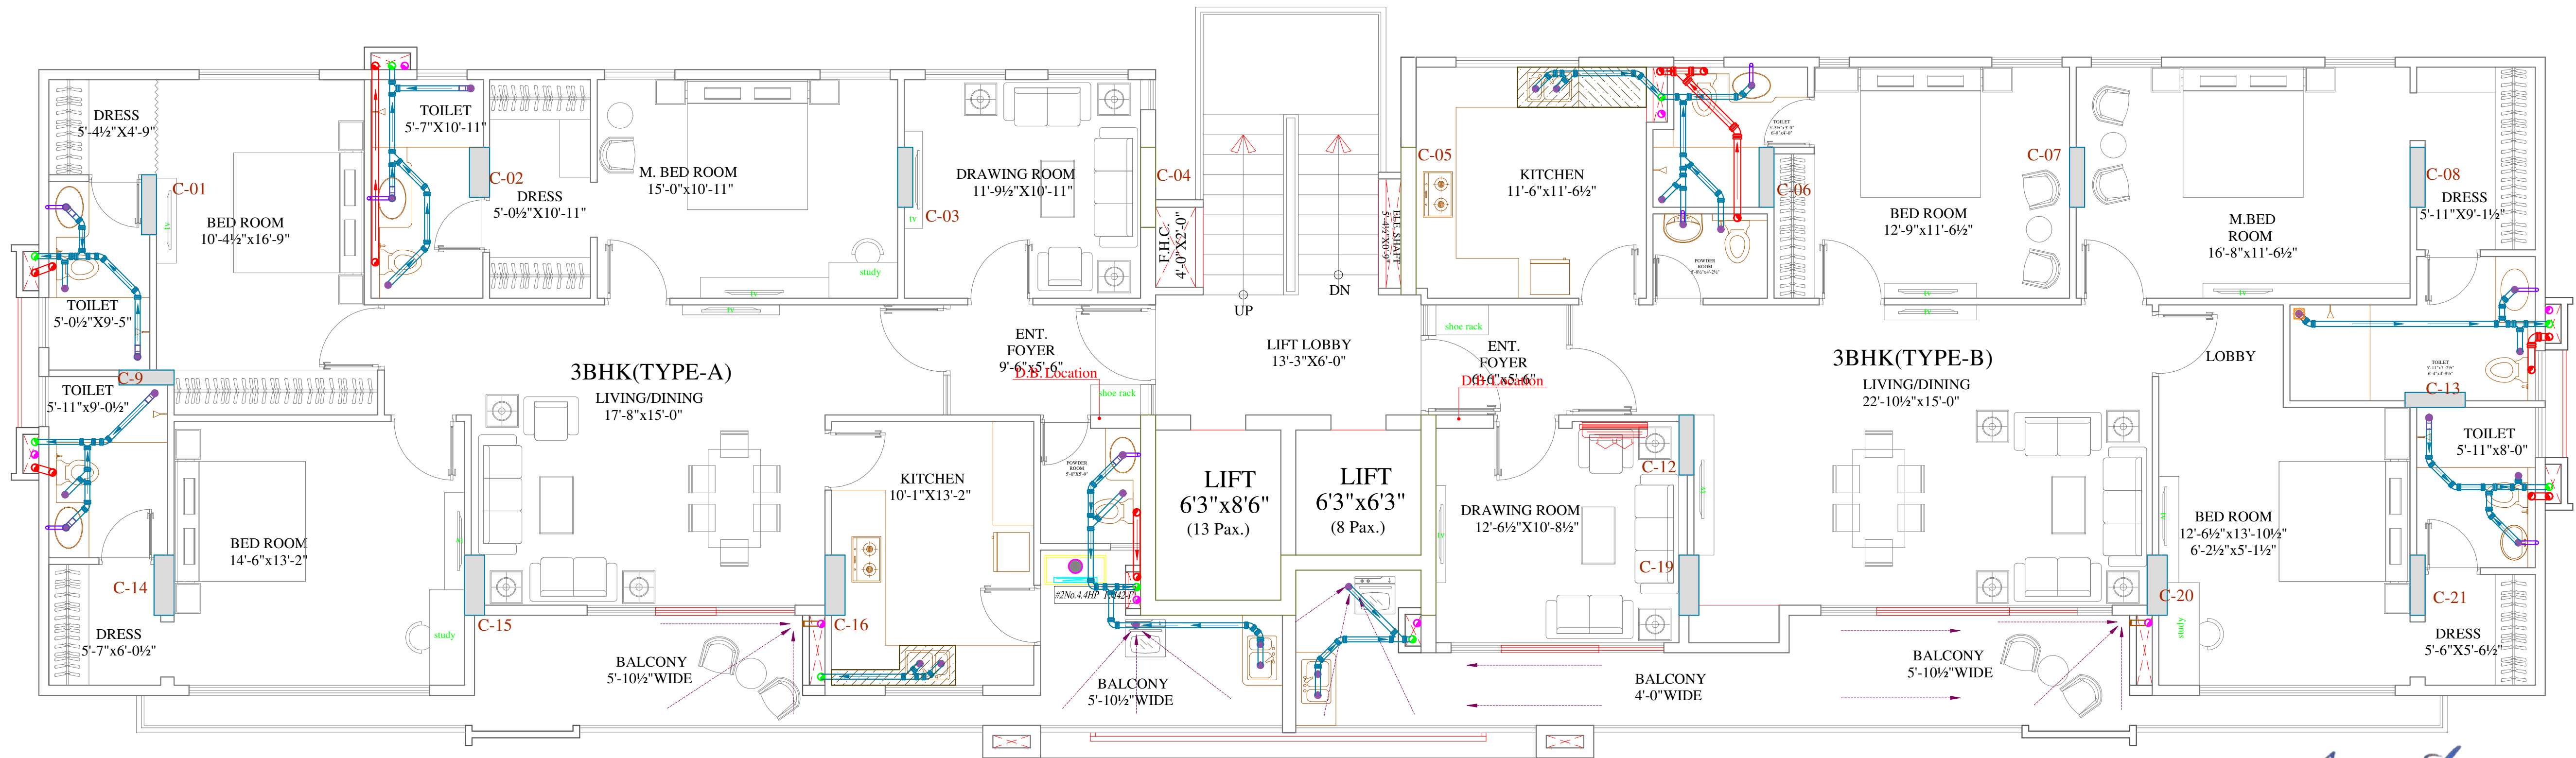

Vipul
VIPUL AGARWAL
M.E.P. CONSULTANT
B.E. ELECTRICAL

SYMBOL	DESCRIPTION
	110 mm Soil Waste Water Pipe
	110 mm Waste Water Pipe
	110 mm Rain Water Pipe
	110 mm Soil Waste Water Pipe
	110 mm Waste Water Pipe
	110 mm Rain Water Pipe
	75 mm Waste Water Pipe Internal, Toilet
	75 mm Rain Water Pipe
	Steam Waste Water Pipe Bottle Trap
	Nubank Trap
	Vertical MS Grating Cover
	Flow Direction
	6" Platform Raine
SERVICES CONS:-	
VIPUL CONSULTING F-9-440, Keshav Marg Chitrakot Scheme, Jaipur Rajasthan-302018, INDIA. Tel: 0141-230 2005, 232 2444 Fax: 0141-400 8700 e-mail: vipul@vipulmep.com	
PROJECT ADDRESS:-	
PLOT NO. D-23A, PRITHVIRAJ ROAD, C-Scheme, JAIPUR	
PROJECT NAME:- 5TH AVENUE	
CLIENT:-	
UPASANA COLONISERS AND RESORTS, B-70, KALSHRAMA MARG, BAPET NAGAR, JAIPUR-302013	
ARCHITECT	
 Ricky Mathur & Associates Architects & Engineers 15, Shri Krishna Colony, Jaipur (RAJ) India-302 001 Tel: 91-141-230 2005, 232 2444 Fax: 91-141-400 8700 e-mail: ricky@rickymathur.com	
DRAWING TITLE	
2nd-4th-8th-9th FLOOR TYPICAL FLOOR INTERNAL DRAINAGE PLAN	
DATE:-	DRAWN BY:-
27-10-2017	GANGIA RAM
SCALE:-	CHECKED BY:-
1" = 8'-0"	SANJAY
REV No.:-	APPROVED BY:-
R-01	VIPUL AGARWAL
NORTH	REVISION
MEP TY-PL-01	R - 01