


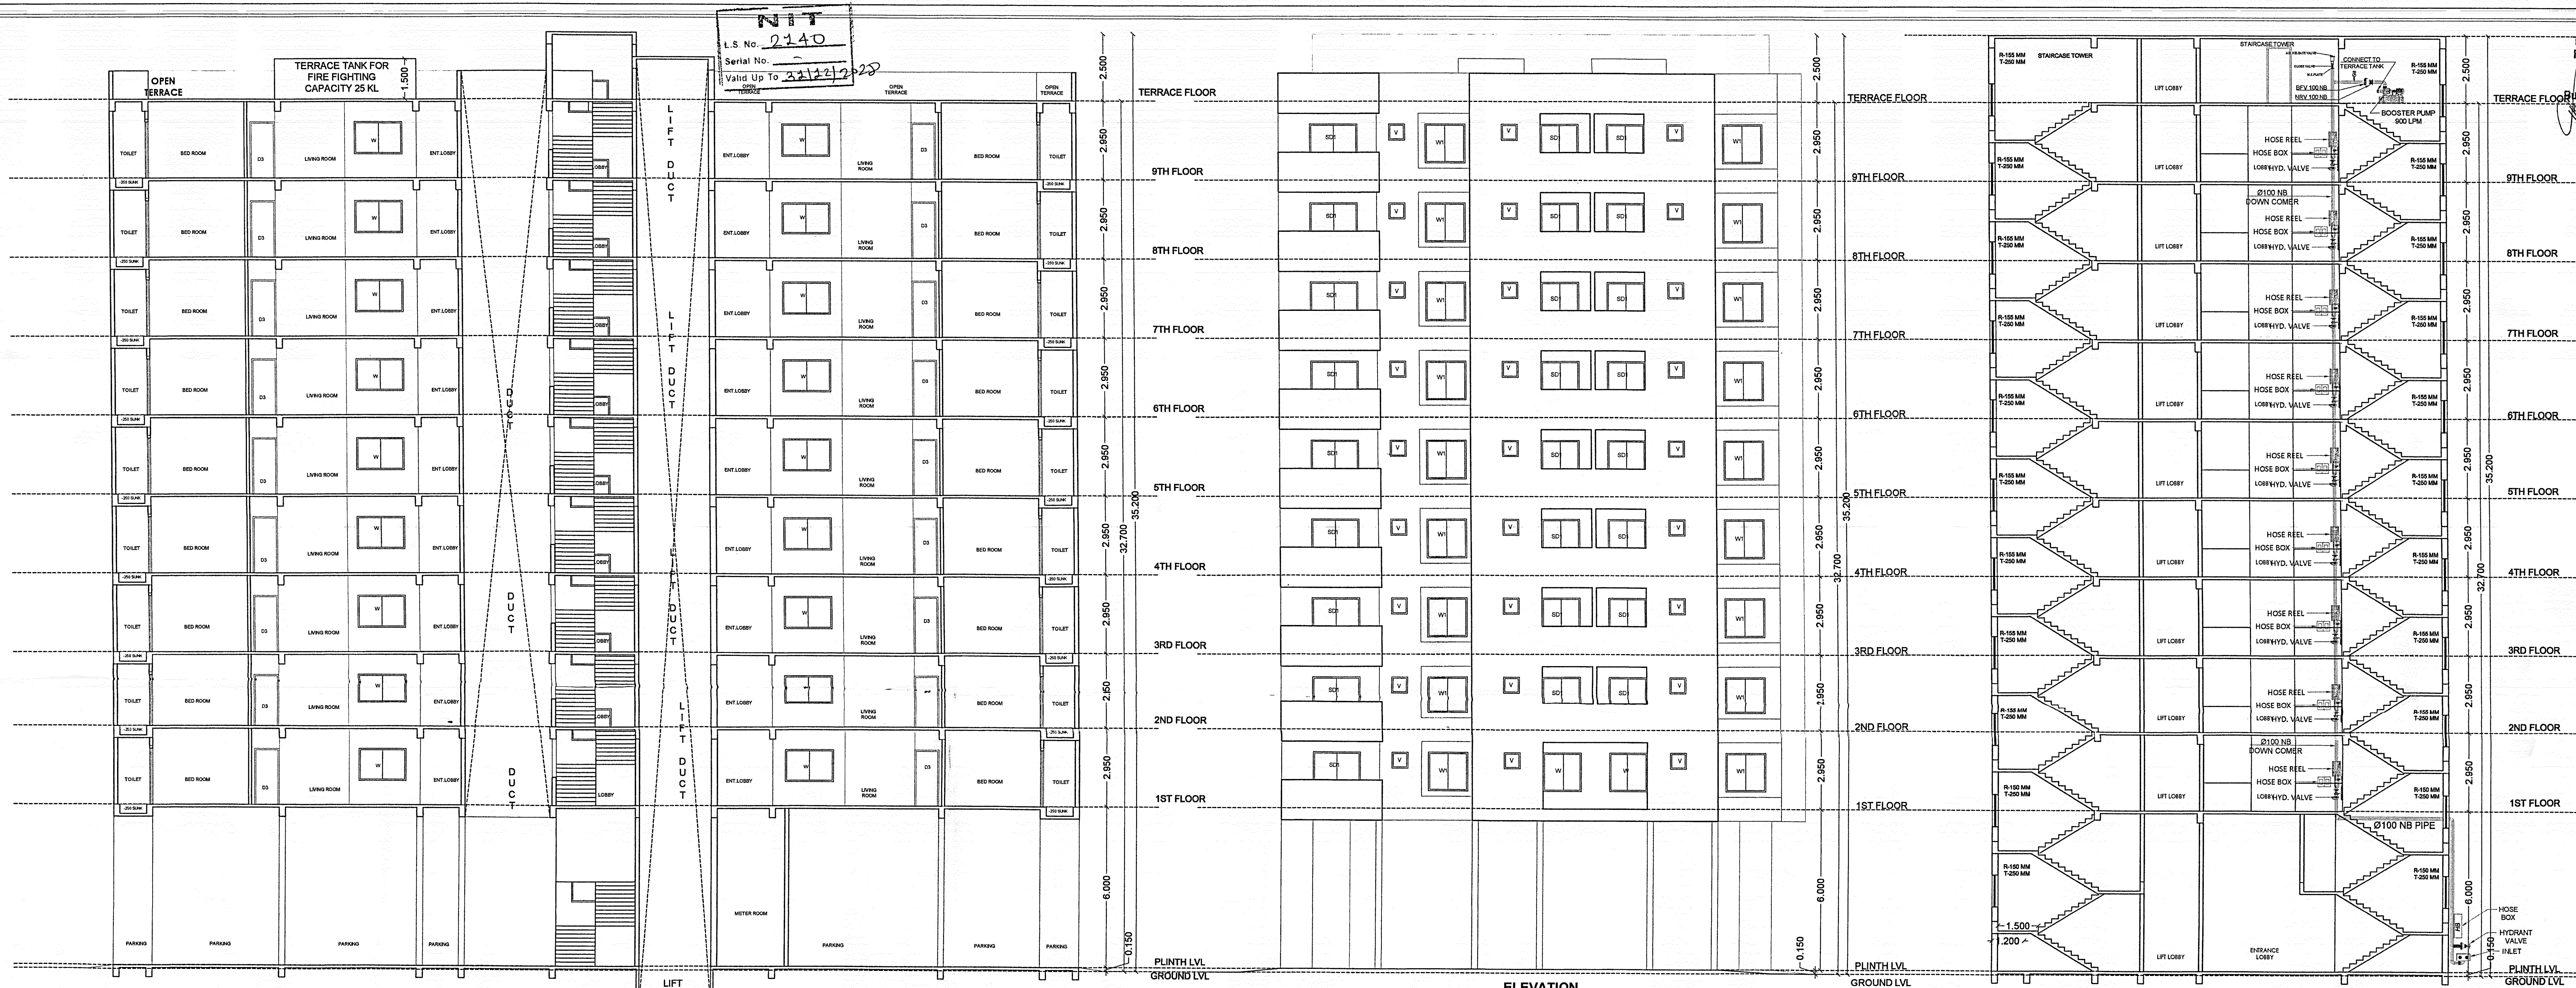

FLOOR'S NAME	FLOOR WISE FSI STATEMENT			PROPOSED TENEMENTS
	RESIDENTIAL	COMMERCIAL	TOTAL	
GROUND FLOOR	0.00	0.000	0.000	0
1st FLOOR	529.028	0.000	529.028	4
2nd FLOOR	538.610	0.000	538.610	4
3rd FLOOR	538.610	0.000	538.610	4
4th FLOOR	538.610	0.000	538.610	4
5th FLOOR	538.610	0.000	538.610	4
6th FLOOR	538.610	0.000	538.610	4
7th FLOOR	538.610	0.000	538.610	4
8th FLOOR	515.864	0.000	515.864	4
9th FLOOR	538.610	0.000	538.610	4
TOTAL	4815.13	0.0000	4815.13	36

LEGENDS -

	FIRE PUMP
	FIRE HYDRANT VALVE
	HR-HOSE REEL
	HB-HOSE BOX
	AIR RELEASE VALVE
	BUTTERFLY VALVE
	BALL VALVE
	NRV-NON RETURN VALVE
	FIRE HYDRANT STAND POST
	FIRE SERVICE INLET
	BUTTERFLY VALVE NON RETURN VALVE
	100 NB PIPE LINE - HYDRANT
	80 NB PIPE LINE
	FIRE ALARM CONTROL PANEL
	FIRE MANUAL CALL POINT
	FIRE HOOTER WITH PA TALK BACK
	ABC FIRE EXTINGUISHER
	CO2 FIRE EXTINGUISHER
	FIRE RESISTANT DOOR

TERRACE TANK DETAILS -

TERRACE TANK FOR FIRE FIGHTING CAPACITY 25,000 LITER

PUMP DETAILS -

BOOSTER PUMP 900 LPM - 01 NO.

DESIGN NOTE:-

THE FIRE PROTECTION SYSTEM SHALL BE DESIGNED FOR BUILDING AS PER NATIONAL BUILDING CODE (NBC PART-4, TABLE NO. 7, RESIDENTIAL BUILDINGS-(A-4), SR. NO. 2) 2016 GUIDELINE. THE SYSTEM SHALL INCLUDE HOSE REEL, DOWN COMER, FIRE EXTINGUISHERS, SPRINKLER IN BASEMENT PARKING, FIRE ALARM SYSTEM AND SIGNAGES

JOB TITLE

PROPOSED CONSTRUCTION OF MULTI-FAMILY RESIDENTIAL DWELLING UNIT PROPOSED ON PLOT NO-153 & 154 AT SHEET NO-300/12, CITY SURVEY NO-24, WARD NO-75, KH NO-9, P.S.K. NO-44 MOUZA-SONEGON IN SWAGAT CO.OP. HOUSING SOCIETY, TAH-DIST- NAGPUR.

BELONGING TO: MRS. NANI'S BUILDCON PVT. LTD. THROUGH DIRECTOR MRS. YASHWANT ALAMBRAO KHODKE

SCHEDULE OF OPENINGS :

CODE	SIZE	REMARKS
W1	1800 x 1500	ALU GLAZED WINDOW
W2	1500 x 1000	ALU GLAZED WINDOW
W3	1000 x 900	ALU GLAZED WINDOW
W4	900 x 750	ALU GLAZED WINDOW
D1	1065 x 2100	RCC FRAME WITH RUSH DOOR
D2	1000 x 2100	RCC FRAME WITH RUSH DOOR
D3	915 x 2100	RCC FRAME WITH RUSH DOOR
D4	165 x 2100	RCC FRAME WITH RUSH DOOR
SD1	1000 x 2100	ALUMINUM GLAZED SLIDING DOOR
SD2	1500 x 2100	ALUMINUM GLAZED SLIDING DOOR
FRD	1000 x 2100	FIRE RESISTANCE DOOR

SUBMISSION DWG.

REFERENCE :

PLOT BOUNDARY SHOWN IN THIS

PROPOSED CONSTRUCTION SHOWN IN THIS

OWNER'S DECLARATION

CERTIFICATE OF AREA

OWNER'S NAME AND SIGNATURE

DATE

SCALE

NOTE - ALL DIMENSIONS ARE IN M

OWNER'S DECLARATION

CERTIFICATE OF AREA

OWNER'S NAME AND SIGNATURE

DATE

SCALE

NOTE - ALL DIMENSIONS ARE IN M

OWNER'S DECLARATION

CERTIFICATE OF AREA

OWNER'S NAME AND SIGNATURE

DATE

SCALE

NOTE - ALL DIMENSIONS ARE IN M

OWNER'S DECLARATION

CERTIFICATE OF AREA

OWNER'S NAME AND SIGNATURE





DATE

SCALE

NOTE - ALL DIMENSIONS ARE IN M

Proposed building	Floor No.	Apartment No.	Total No. of Tenement's	Carpet area of apartment
1	GROUND FLOOR	101 TO 701 & 901	8	123.786
	TYPICAL 1st to 9th FLOOR	102 TO 902	9	90.641
		103 TO 903	9	88.535
		104 TO 904	9	87.217
	8th FLOOR	801	1	104.981
	TOTAL		36	495.160

FLOOR NAME	FLAT NOS.	AREA SQM
101 TO 701	1	1 X 3.700 X 7.315 = 27.358
	2	1 X 2.310 X 4.465 = 10.314
	3	1 X 2.675 X 2.400 = 6.420
	4	1 X 7.975 X 2.390 = 19.070
	5	1 X 10.341 X 1.315 = 13.598
	6	1 X 11.630 X 3.425 = 39.833
	7	1 X 2.200 X 1.315 = 2.893
TOTAL CARPET AREA		123.786
102 TO 702	1	1 X 3.740 X 2.850 = 10.659
	2	1 X 0.750 X 1.950 = 1.463
	3	1 X 5.665 X 2.400 = 13.596
	4	1 X 6.412 X 2.515 = 16.126
	5	1 X 6.715 X 4.740 = 31.829
	6	1 X 2.200 X 1.315 = 2.893
	TOTAL CARPET AREA	90.641
103 TO 703	1	1 X 2.200 X 1.315 = 2.893
	2	1 X 6.715 X 4.695 = 31.487
	3	1 X 2.515 X 6.415 = 16.134
	4	1 X 0.900 X 2.815 = 2.534
	5	1 X 4.380 X 1.775 = 7.775
	6	1 X 2.990 X 2.930 = 8.761
	7	1 X 3.740 X 4.800 = 17.952
TOTAL CARPET AREA		88.535
104 TO 704	1	1 X 2.200 X 1.315 = 2.893
	2	1 X 6.715 X 4.642 = 31.171
	3	1 X 6.415 X 2.515 = 16.134
	4	1 X 0.900 X 2.815 = 2.534
	5	1 X 1.775 X 4.379 = 7.775
	6	1 X 2.990 X 2.930 = 8.761
	7	1 X 3.740 X 4.800 = 17.952
TOTAL CARPET AREA		87.217
801 & 901	1	1 X 2.160 X 2.065 = 4.460
	2	1 X 3.890 X 2.368 = 9.212
	3	1 X 4.825 X 2.400 = 11.594
	4	1 X 7.975 X 2.390 = 19.070
	5	1 X 10.340 X 1.315 = 13.597
	6	1 X 11.630 X 3.425 = 39.833
	7	1 X 2.200 X 1.315 = 2.893
TOTAL CARPET AREA		104.981
902	1	1 X 2.525 X 2.065 = 5.214
	2	1 X 5.665 X 2.400 = 13.596
	3	1 X 6.415 X 2.515 = 16.134
	4	1 X 6.715 X 4.740 = 31.829
	5	1 X 2.200 X 1.315 = 2.893
	TOTAL CARPET AREA	91.262
903 & 904	1	1 X 2.220 X 1.322 = 2.935
	2	1 X 6.715 X 4.740 = 31.829
	3	1 X 6.415 X 2.515 = 16.134
	4	1 X 5.665 X 2.815 = 15.947
	5	1 X 6.625 X 1.565 = 10.363
	TOTAL CARPET AREA	66.388

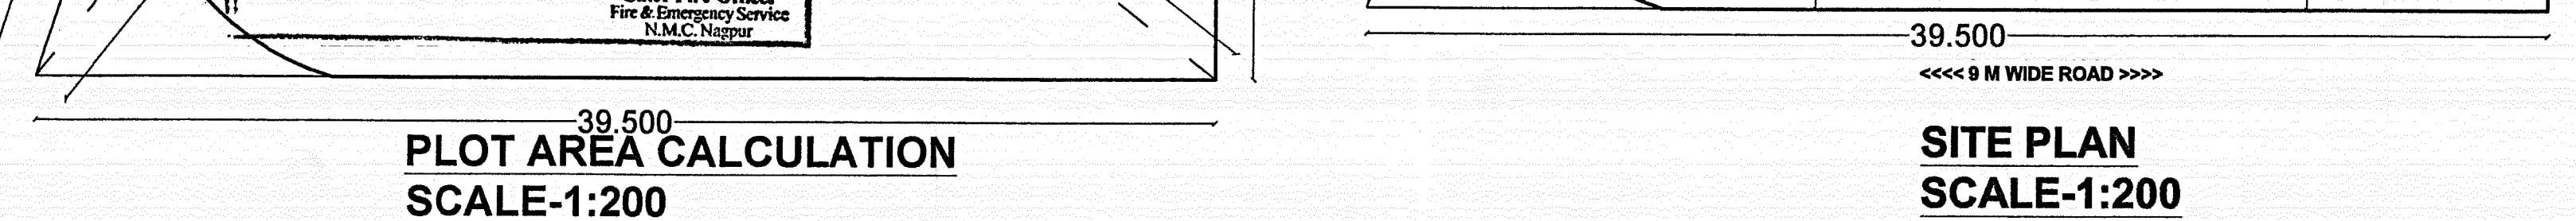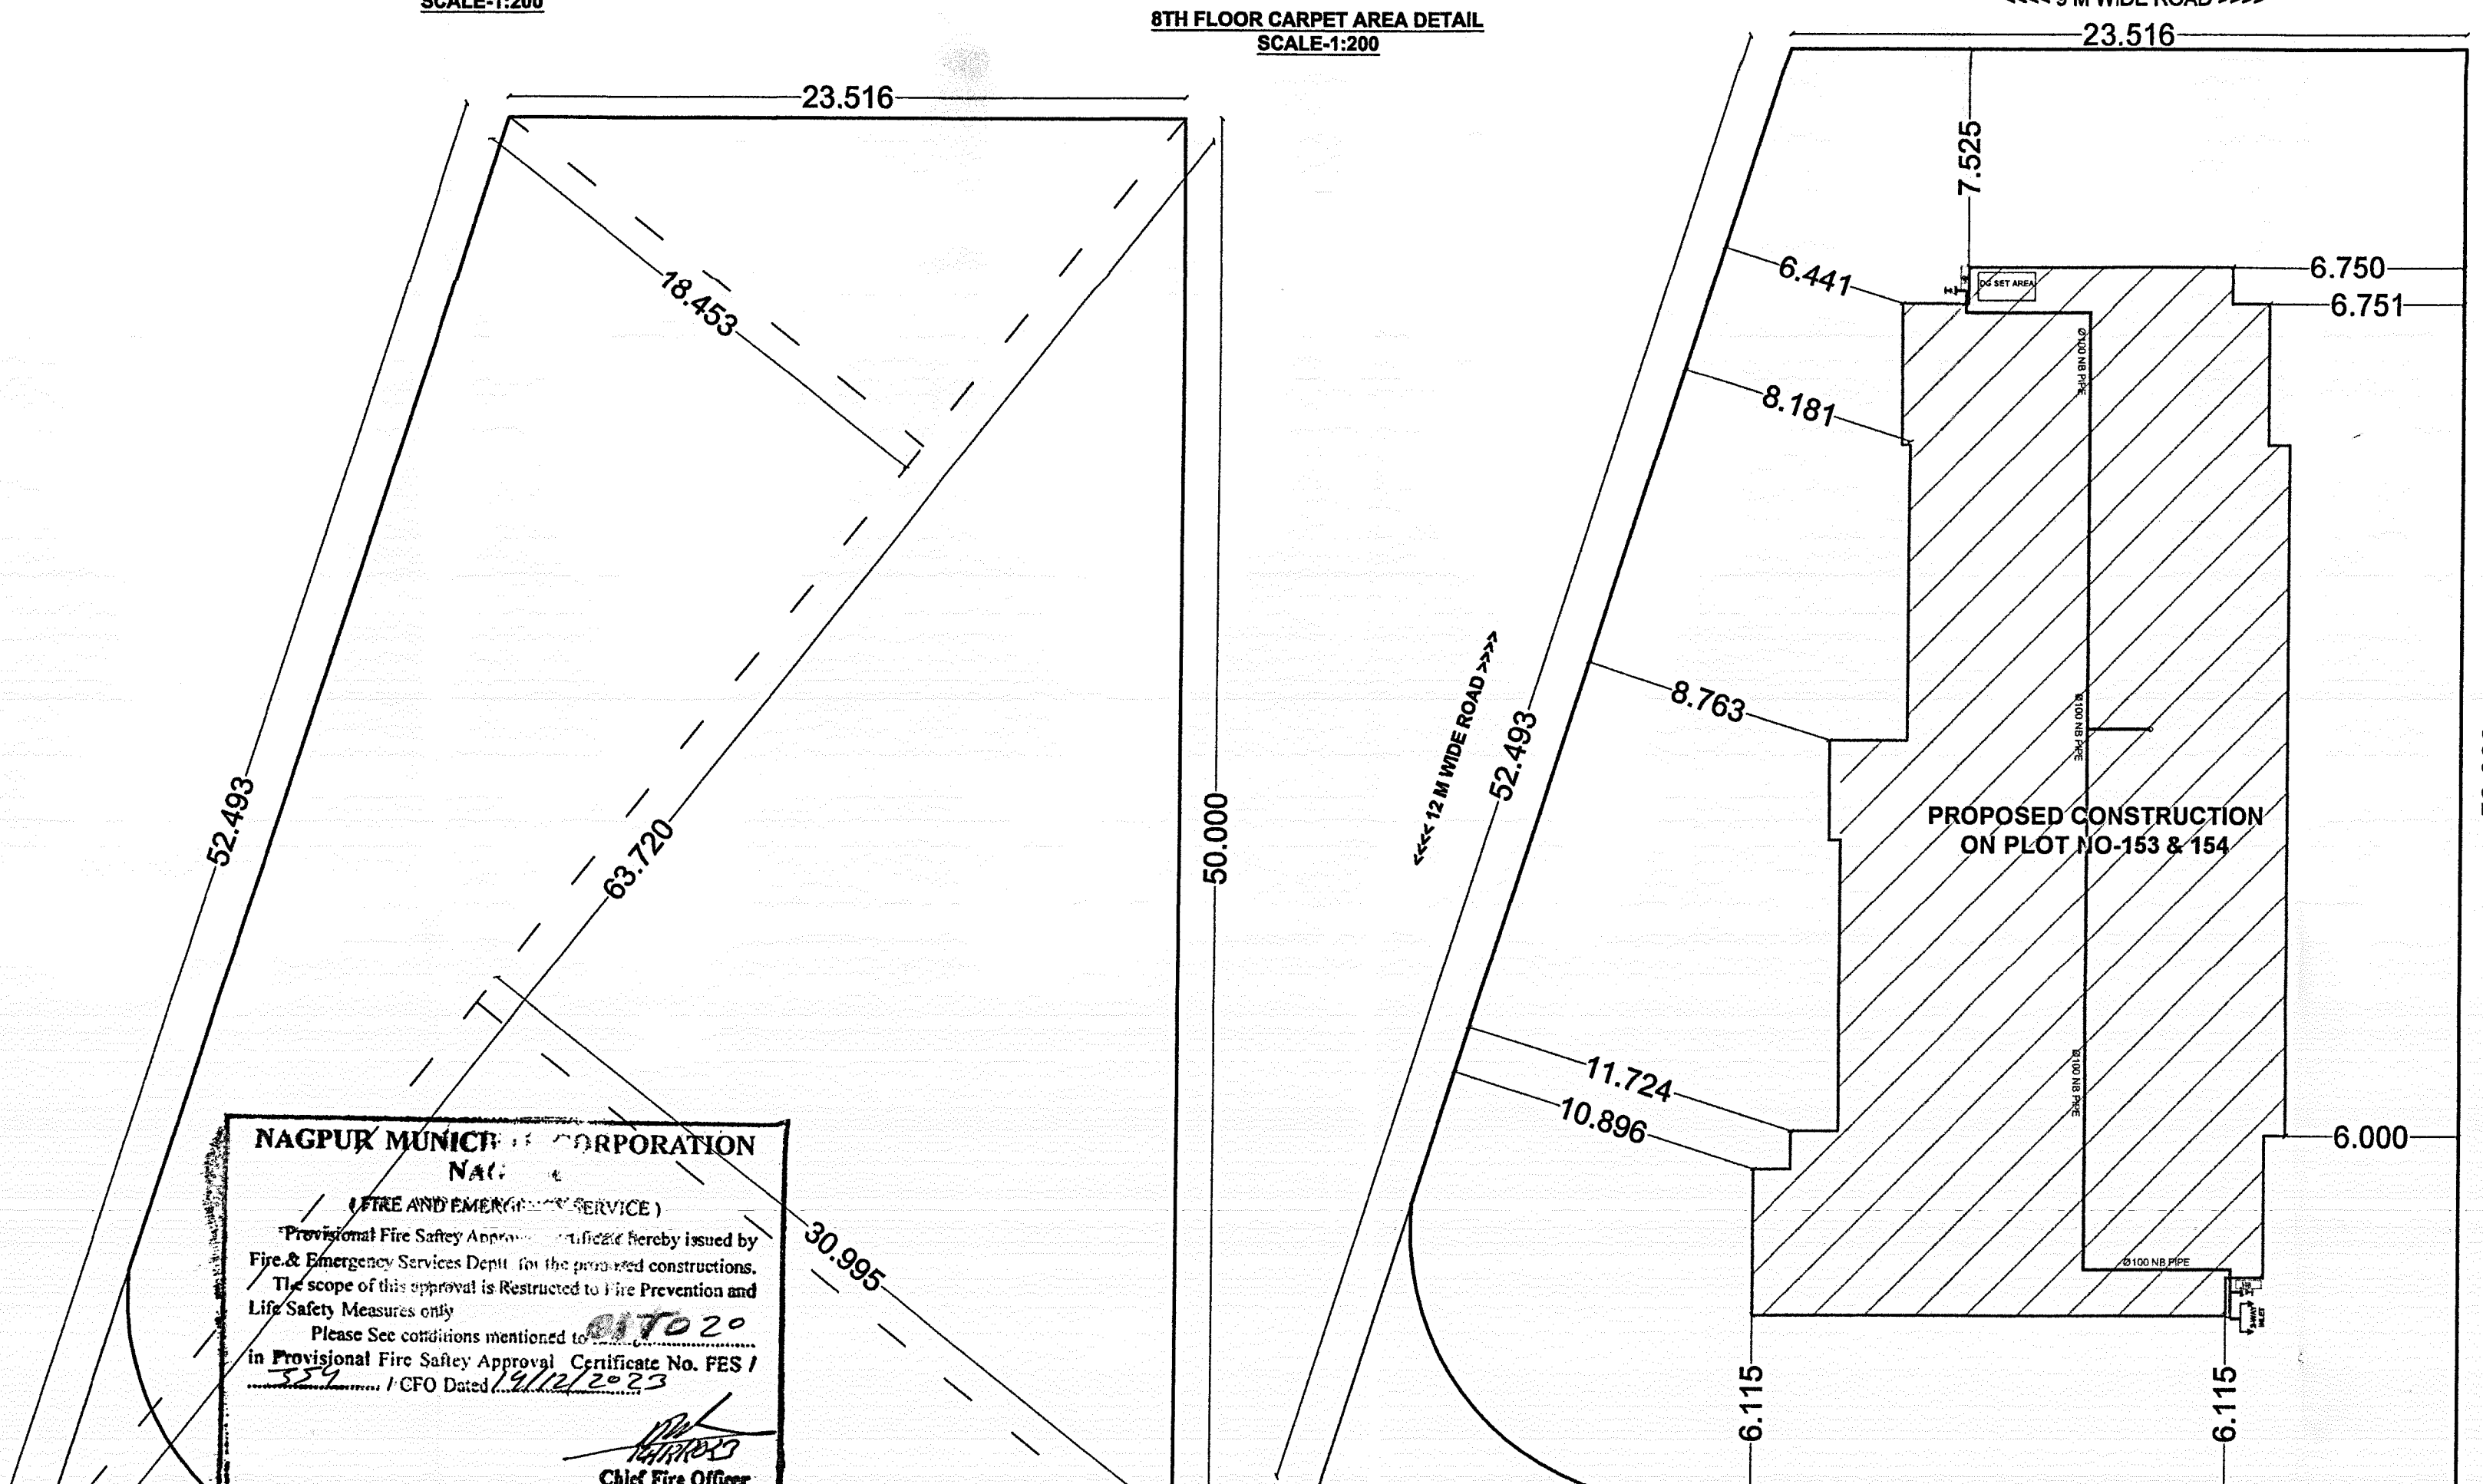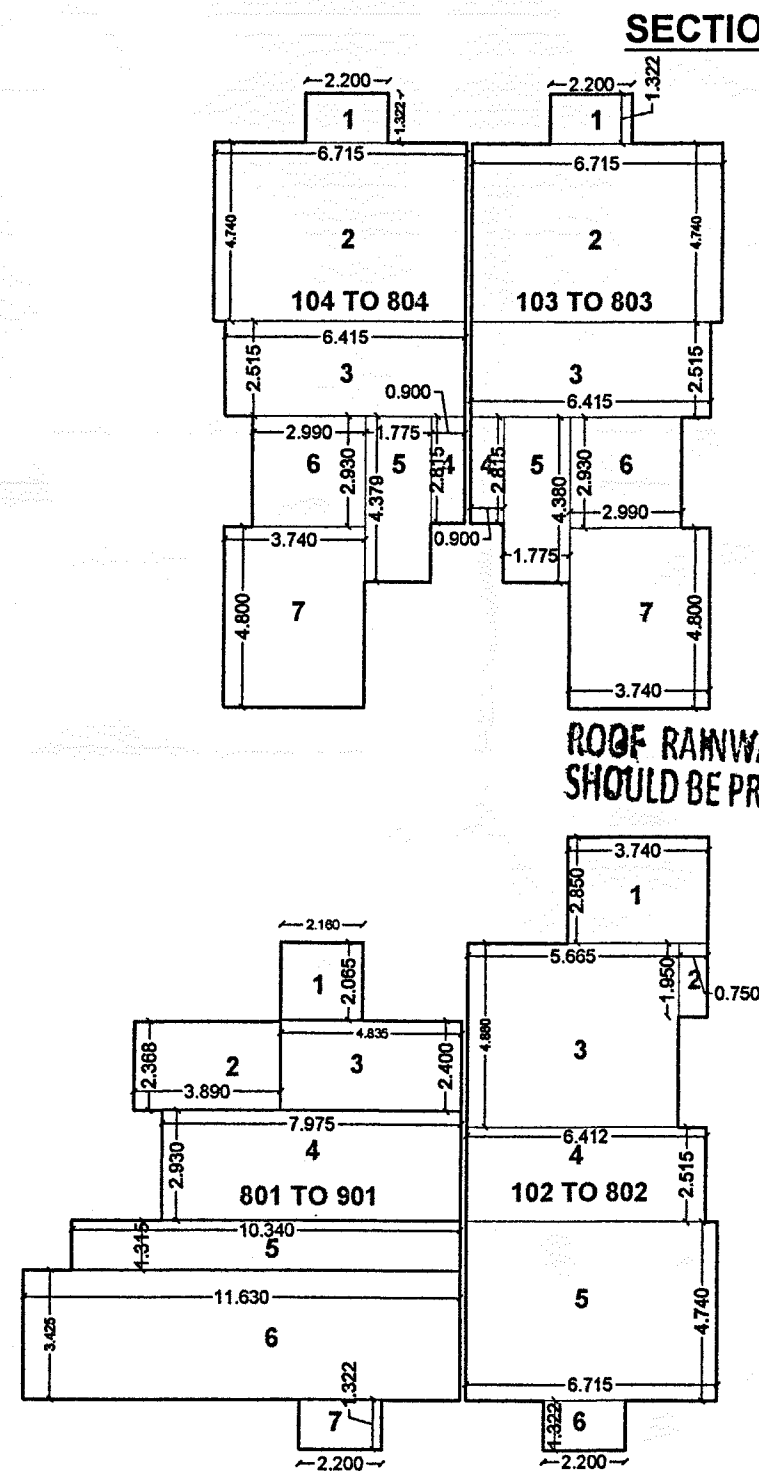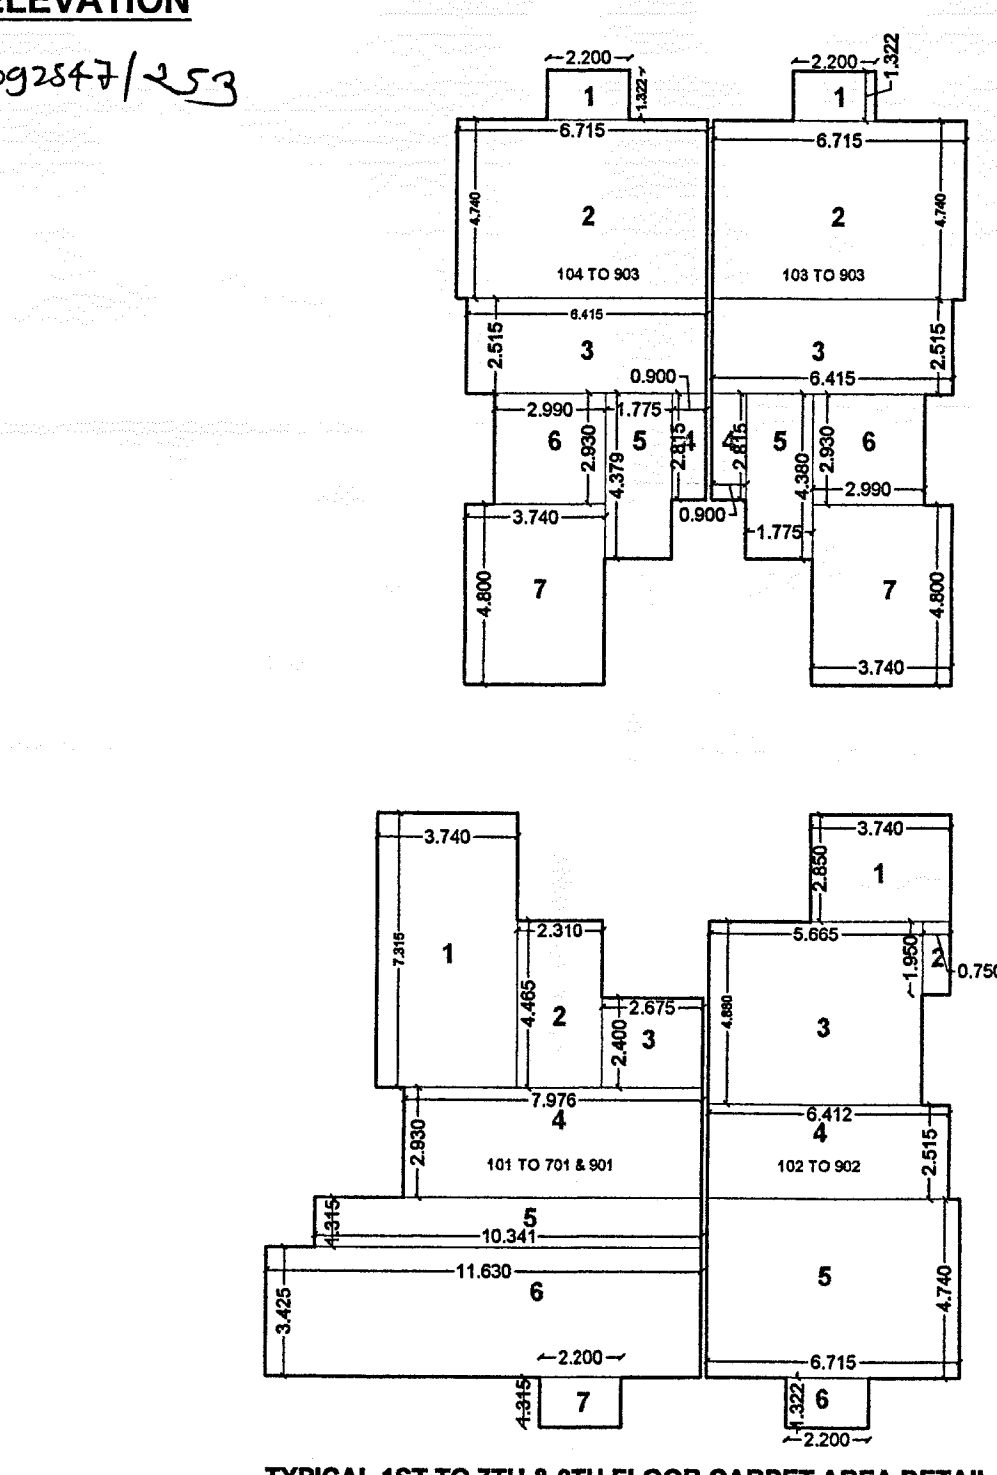

Ar. LOKESH KADU
CA/2007/39381
N°CR-402 NIT-2140
COA No. CA/201/881

Ar. LOKESH W. KADU
Architects, Planning, Interior's
Block No. 11, 11A, 11B, 11C, 11D, 11E, 11F, 11G, 11H, 11I, 11J, 11K, 11L, 11M, 11N, 11O, 11P, 11Q, 11R, 11S, 11T, 11U, 11V, 11W, 11X, 11Y, 11Z, 11AA, 11AB, 11AC, 11AD, 11AE, 11AF, 11AG, 11AH, 11AI, 11AJ, 11AK, 11AL, 11AM, 11AN, 11AO, 11AP, 11AQ, 11AR, 11AS, 11AT, 11AU, 11AV, 11AW, 11AX, 11AY, 11AZ, 11BA, 11BB, 11BC, 11BD, 11BE, 11BF, 11BG, 11BH, 11BI, 11BJ, 11BK, 11BL, 11BM, 11BN, 11BO, 11BP, 11BQ, 11BR, 11BS, 11BT, 11BU, 11BV, 11BW, 11BX, 11BY, 11BZ, 11CA, 11CB, 11CC, 11CD, 11CE, 11CF, 11CG, 11CH, 11CI, 11CJ, 11CK, 11CL, 11CM, 11CN, 11CO, 11CP, 11CQ, 11CR, 11CS, 11CT, 11CU, 11CV, 11CW, 11CX, 11CY, 11CZ, 11DA, 11DB, 11DC, 11DD, 11DE, 11DF, 11DG, 11DH, 11DI, 11DJ, 11DK, 11DL, 11DM, 11DN, 11DO, 11DP, 11DQ, 11DR, 11DS, 11DT, 11DU, 11DV, 11DW, 11DX, 11DY, 11DZ, 11EA, 11EB, 11EC, 11ED, 11EE, 11EF, 11EG, 11EH, 11EI, 11EJ, 11EK, 11EL, 11EM, 11EN, 11EO, 11EP, 11EQ, 11ER, 11ES, 11ET, 11EU, 11EV, 11EW, 11EX, 11EY, 11EZ, 11FA, 11FB, 11FC, 11FD, 11FE, 11FF, 11FG, 11FH, 11FI, 11FJ, 11FK, 11FL, 11FM, 11FN, 11FO, 11FP, 11FQ, 11FR, 11FS, 11FT, 11FU, 11FV, 11FW, 11FX, 11FY, 11FZ, 11GA, 11GB, 11GC, 11GD, 11GE, 11GF, 11GG, 11GH, 11GI, 11GJ, 11GK, 11GL, 11GM, 11GN, 11GO, 11GP, 11GQ, 11GR, 11GS, 11GT, 11GU, 11GV, 11GW, 11GX, 11GY, 11GZ, 11HA, 11HB, 11HC, 11HD, 11HE, 11HF, 11HG, 11HH, 11HI, 11HJ, 11HK, 11HL, 11HM, 11HN, 11HO, 11HP, 11HQ, 11HR, 11HS, 11HT, 11HU, 11HV, 11HW, 11HX, 11HY, 11HZ, 11IA, 11IB, 11IC, 11ID, 11IE, 11IF, 11IG, 11IH, 11II, 11IJ, 11IK, 11IL, 11IM, 11IN, 11IO, 11IP, 11IQ, 11IR, 11IS, 11IT, 11IU, 11IV, 11IW, 11IX, 11IY, 11IZ, 11JA, 11JB, 11JC, 11JD, 11JE, 11JF, 11JG, 11JH, 11JI, 11JJ, 11JK, 11JL, 11JM, 11JN, 11JO, 11JP, 11JQ, 11JR, 11JS, 11JT, 11JU, 11JV, 11JW, 11JX, 11JY, 11JZ, 11KA, 11KB, 11KC, 11KD, 11KE, 11KF, 11KG, 11KH, 11KI, 11KJ, 11KK, 11KL, 11KM, 11KN, 11KO, 11KP, 11KQ, 11KR, 11KS, 11KT, 11KU, 11KV, 11KW, 11KX, 11KY, 11KZ, 11LA, 11LB, 11LC, 11LD, 11LE, 11LF, 11LG, 11LH, 11LI, 11LJ, 11LK, 11LL, 11LM, 11LN, 11LO, 11LP, 11LQ, 11LR, 11LS, 11LT, 11LU, 11LV, 11LW, 11LX, 11LY, 11LZ, 11MA, 11MB, 11MC, 11MD, 11ME, 11MF, 11MG, 11MH, 11MI, 11MJ, 11MK, 11ML, 11MM, 11MN, 11MO, 11MP, 11MQ, 11MR, 11MS, 11MT, 11MU, 11MV, 11MW, 11MX, 11MY, 11MZ, 11NA, 11NB, 11NC, 11ND, 11NE, 11NF, 11NG, 11NH, 11NI, 11NJ, 11NK, 11NL, 11NM, 11NN, 11NO, 11NP, 11NQ, 11NR, 11NS, 11NT, 11NU, 11NV, 11NW, 11NX, 11NY, 11NZ, 11OA, 11OB, 11OC, 11OD, 11OE, 11OF, 11OG, 11OH, 11OI, 11OJ, 11OK, 11OL, 11OM, 11ON, 11OO, 11OP, 11OQ, 11OR, 11OS, 11OT, 11OU, 11OV, 11OW, 11OX, 11OY, 11OZ, 11PA, 11PB, 11PC, 11PD, 11PE, 11PF, 11PG, 11PH, 11PI, 11PJ, 11PK, 11PL, 11PM, 11PN, 11PO, 11PP, 11PQ, 11PR, 11PS, 11PT, 11PU, 11PV, 11PW, 11PX, 11PY, 11PZ, 11QA, 11QB, 11QC, 11QD, 11QE, 11QF, 11QG, 11QH, 11QI, 11QJ, 11QK, 11QL, 11QM, 11QN, 11QO, 11QP, 11QQ, 11QR, 11QS, 11QT, 11QU, 11QV, 11QW, 11QX, 11QY, 11QZ, 11RA, 11RB, 11RC, 11RD, 11RE, 11RF, 11RG, 11RH, 11RI, 11RJ, 11RK, 11RL, 11RM, 11RN, 11RO, 11RP, 11RQ, 11RR, 11RS, 11RT, 11RU, 11RV, 11RW, 11RX, 11RY, 11RZ, 11SA, 11SB, 11SC, 11SD, 11SE, 11SF, 11SG, 11SH, 11SI, 11SJ, 11SK, 11SL, 11SM, 11SN, 11SO, 11SP, 11SQ, 11SR, 11SS, 11ST, 11SU, 11SV, 11SW, 11SX, 11SY, 11SZ, 11TA, 11TB, 11TC, 11TD, 11TE, 11TF, 11TG, 11TH, 11TI, 11TJ, 11TK, 11TL, 11TM, 11TN, 11TO, 11TP, 11TQ, 11TR, 11TS, 11TT, 11TU, 11TV, 11TW, 11TX, 11TY, 11TZ, 11UA, 11UB, 11UC, 11UD, 11UE, 11UF, 11UG, 11UH, 11UI, 11UJ, 11UK, 11UL, 11UM, 11UN, 11UO, 11UP, 11UQ, 11UR, 11US, 11UT, 11UU, 11UV, 11UW, 11UX, 11UY, 11UZ, 11VA, 11VB, 11VC, 11VD, 11VE, 11VF, 11VG, 11VH, 11VI, 11VJ, 11VK, 11VL, 11VM, 11VN, 11VO, 11VP, 11VQ, 11VR, 11VS, 11VT, 11VU, 11VV, 11VW, 11VX, 11VY, 11VZ, 11WA, 11WB, 11WC, 11WD, 11WE, 11WF, 11WG, 11WH, 11WI, 11WJ, 11WK, 11WL, 11WM, 11WN, 11WO, 11WP, 11WQ, 11WR, 11WS, 11WT, 11WU, 11WV, 11WW, 11WX, 11WY, 11WZ, 11XA, 11XB, 11XC, 11XD, 11XE, 11XF, 11XG, 11XH, 11XI, 11XJ, 11XK, 11XL, 11XM, 11XN, 11XO, 11XP, 11XQ, 11XR, 11XS, 11XT, 11XU, 11XV, 11XW, 11XX, 11XY, 11XZ, 11YA, 11YB, 11YC, 11YD, 11YE, 11YF, 11YG, 11YH, 11YI, 11YJ, 11YK, 11YL, 11YM, 11YN, 11YO, 11YP, 11YQ, 11YR, 11YS, 11YT, 11YU, 11YV, 11YW, 11YX, 11YY, 11YZ, 11ZA, 11ZB, 11ZC, 11ZD, 11ZE, 11ZF, 11ZG, 11ZH, 11ZI, 11ZJ, 11ZK, 11ZL, 11ZM, 11ZN, 11ZO, 11ZP, 11ZQ, 11ZR, 11ZS, 11ZT, 11ZU, 11ZV, 11ZW, 11ZX, 11ZY, 11ZZ

FIRE CONSULTANT & CONTRACTOR -

DEVANSH ENTERPRISES

09, DWARKAPURI, SHUKLA NAGAR, NAGPUR - 440027
Contact No.: +91-7264862203
Email: devansh.ent2021@gmail.com

TITLE :

FIRE FIGHTING SYSTEM PLAN

AUTHORISED SIGNATORY

DRAWN BY - DESIGNED BY - SHEET -

DATE - 23/11/2023

CHECKED BY -

DATE - 23/11/2023

APPROVED BY -

FF-REV-1-