


30M WIDE ROAD

6' TALL / 1830MM HIGH TALL COMPOUND WALL FROM INTERNAL ROAD FFL

ROAD AS WELL.

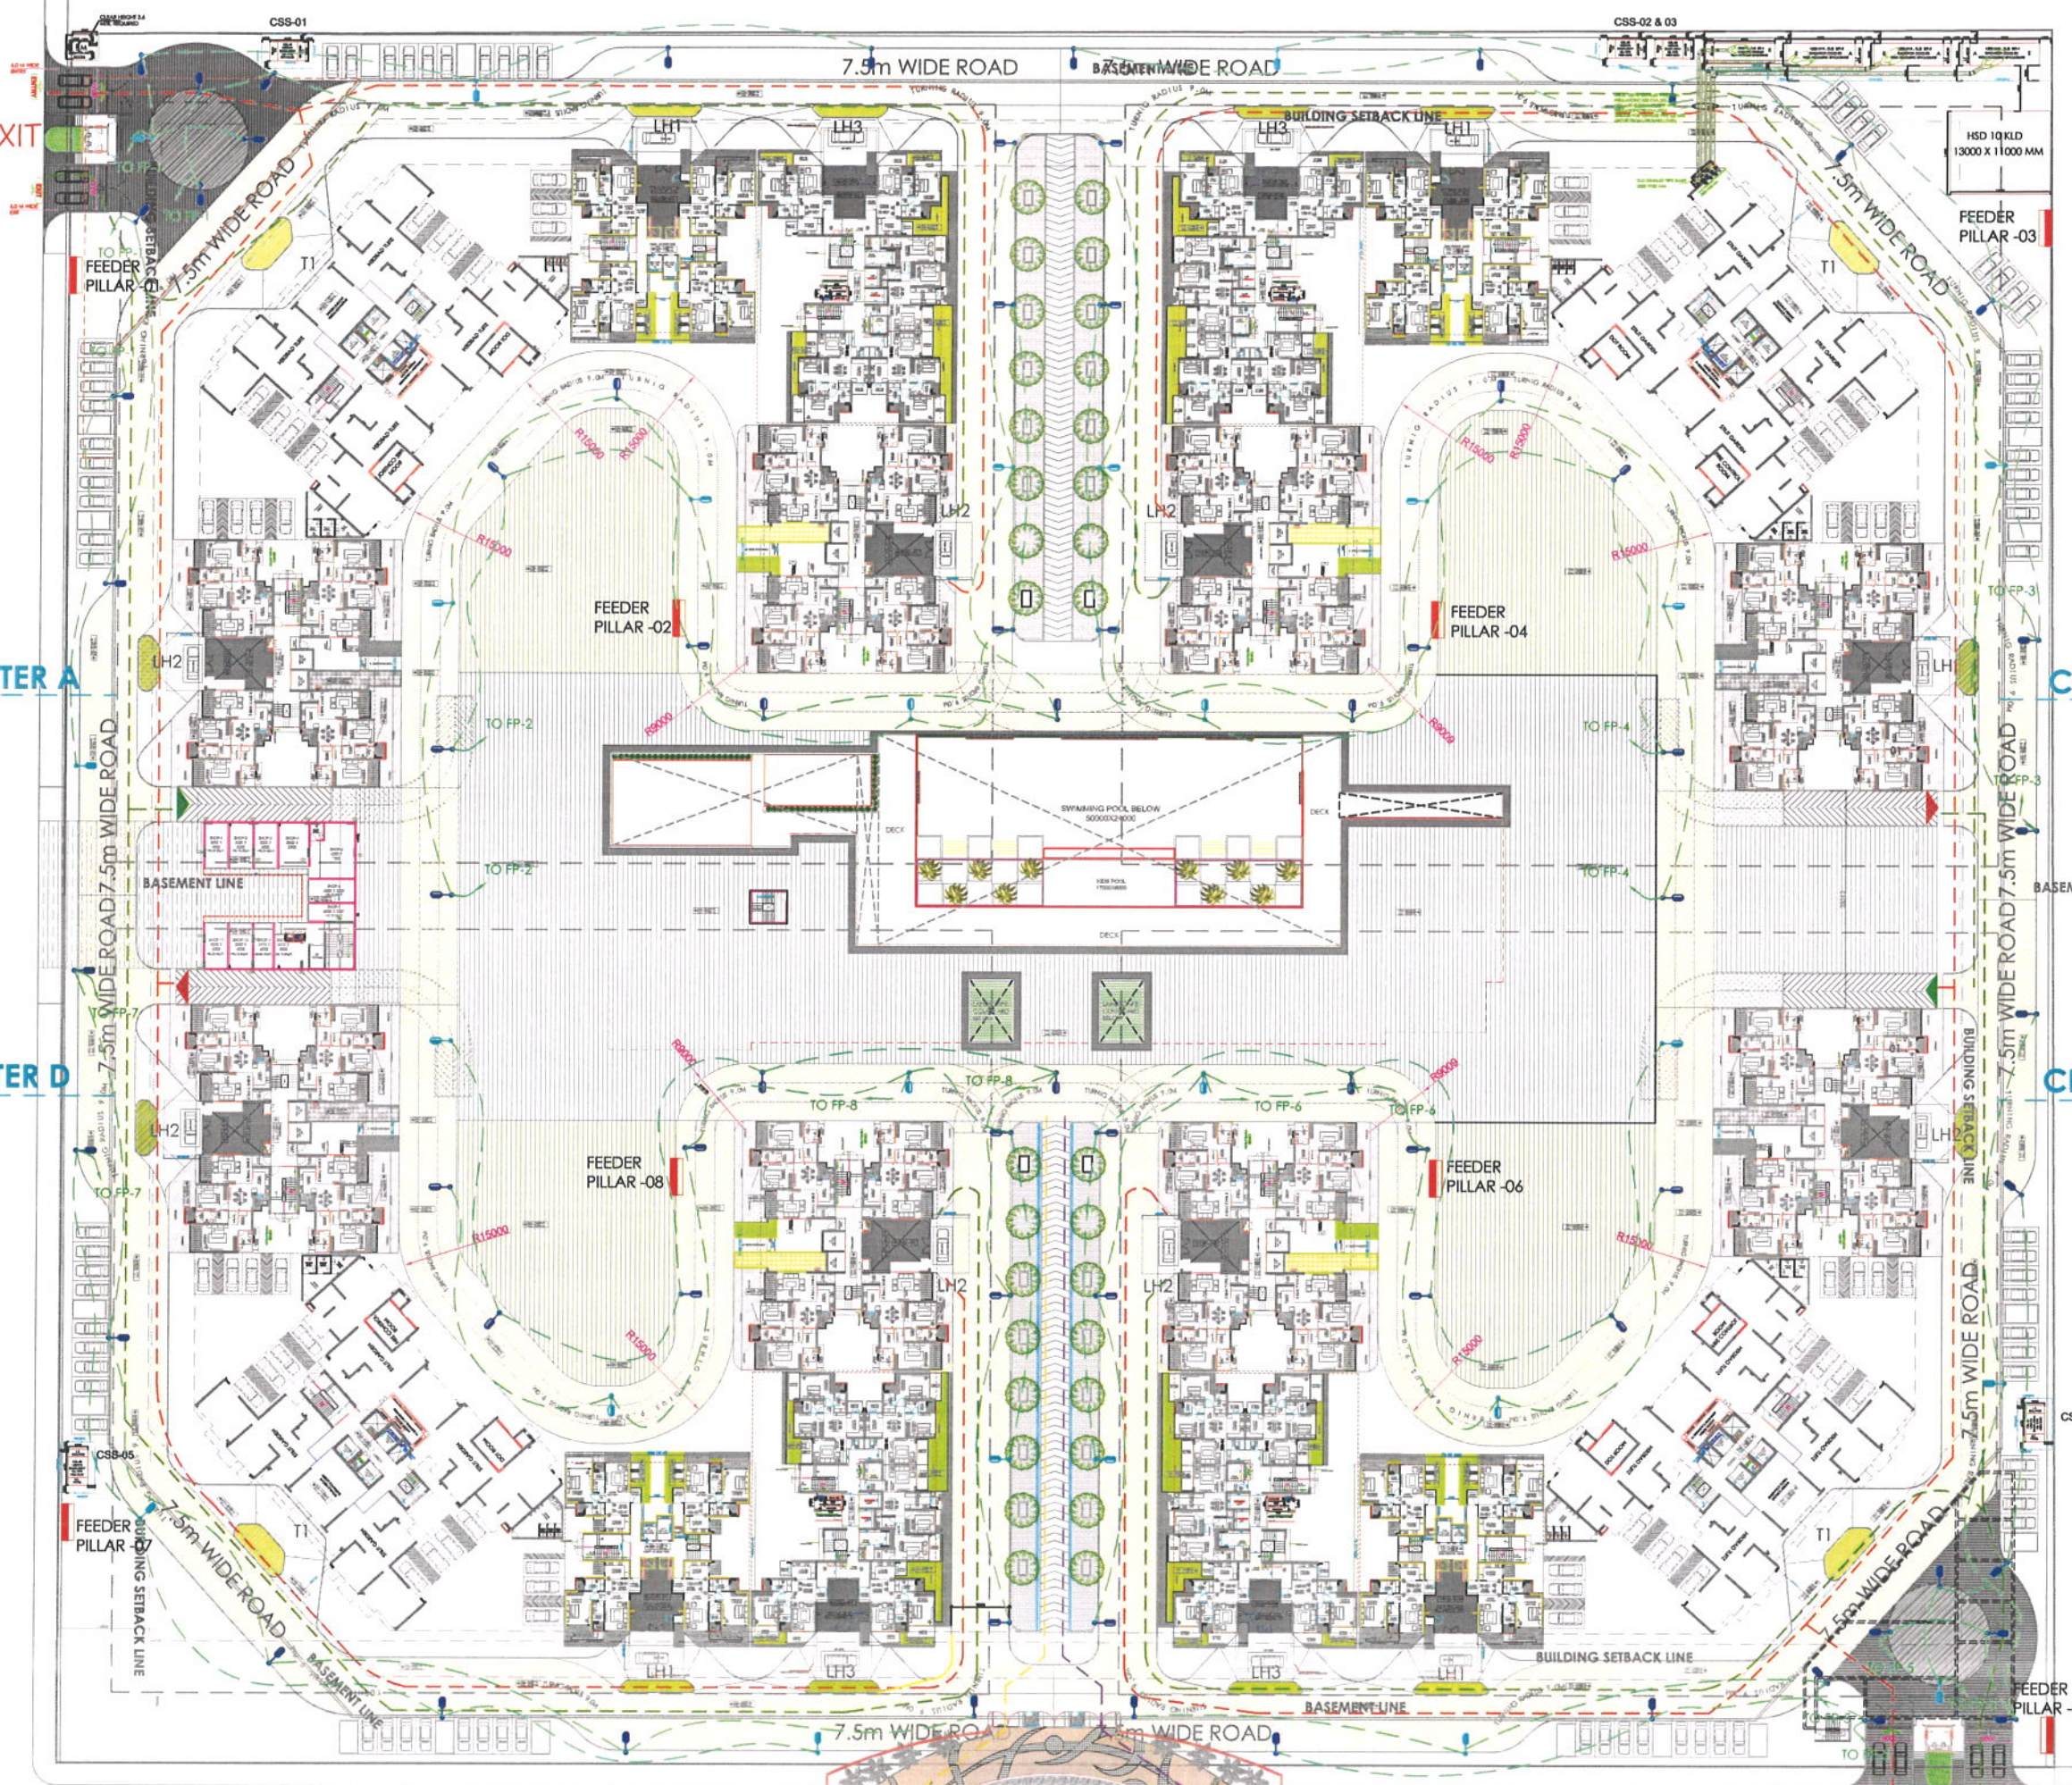

SYMBOL	DESCRIPTION
[Symbol]	INTRA HEIGHT POLE WITH W LED LIGHT
[Symbol]	STANDALONE SOLAR 7 MTR. HEIGHT POLE WITH W LED LIGHT
[Symbol]	INTRA HEIGHT POLE WITH W LED LIGHT
[Symbol]	STANDALONE SOLAR 8 MTR. HEIGHT POLE WITH W LED LIGHT
[Symbol]	EXTERNAL LIGHTING FEEDER PILLAR

--PHA

CLUSTER B

CLUSTER C

--PHA

MEP CONSULTANT
SUNIL NAYAR CONSULTING ENGINEERS LLP.
Head Office : 204, 204A & 305A-305B, 2nd & 3rd Floor
Time Centre, DLF Golf Course Road,
Sector-54, Gurgaon-122002, Haryana (India)
Tale : +91-124-4803800 (30 Lines)
Fax : +91-124-4803817
E-mail : sncgurgaon@snc.co.in
URL : www.snc.co.in

**SUBMISSION
DRAWINGS**

PROJECT TITLE
M/S ACE INFRA CITY DEVELOPERS PVT. LTD.
PLOT NO. - SC-02/F
SEC 150,
NOIDA-201301

SHEET TITLE
**SITE PLAN
ELECTRICAL LAYOUT**

OWNER'S SIGN ARCHITECT'S SIGN

DRAWN BY : CHECKED BY : DWG.NO. :
ANAND PRASHANT