


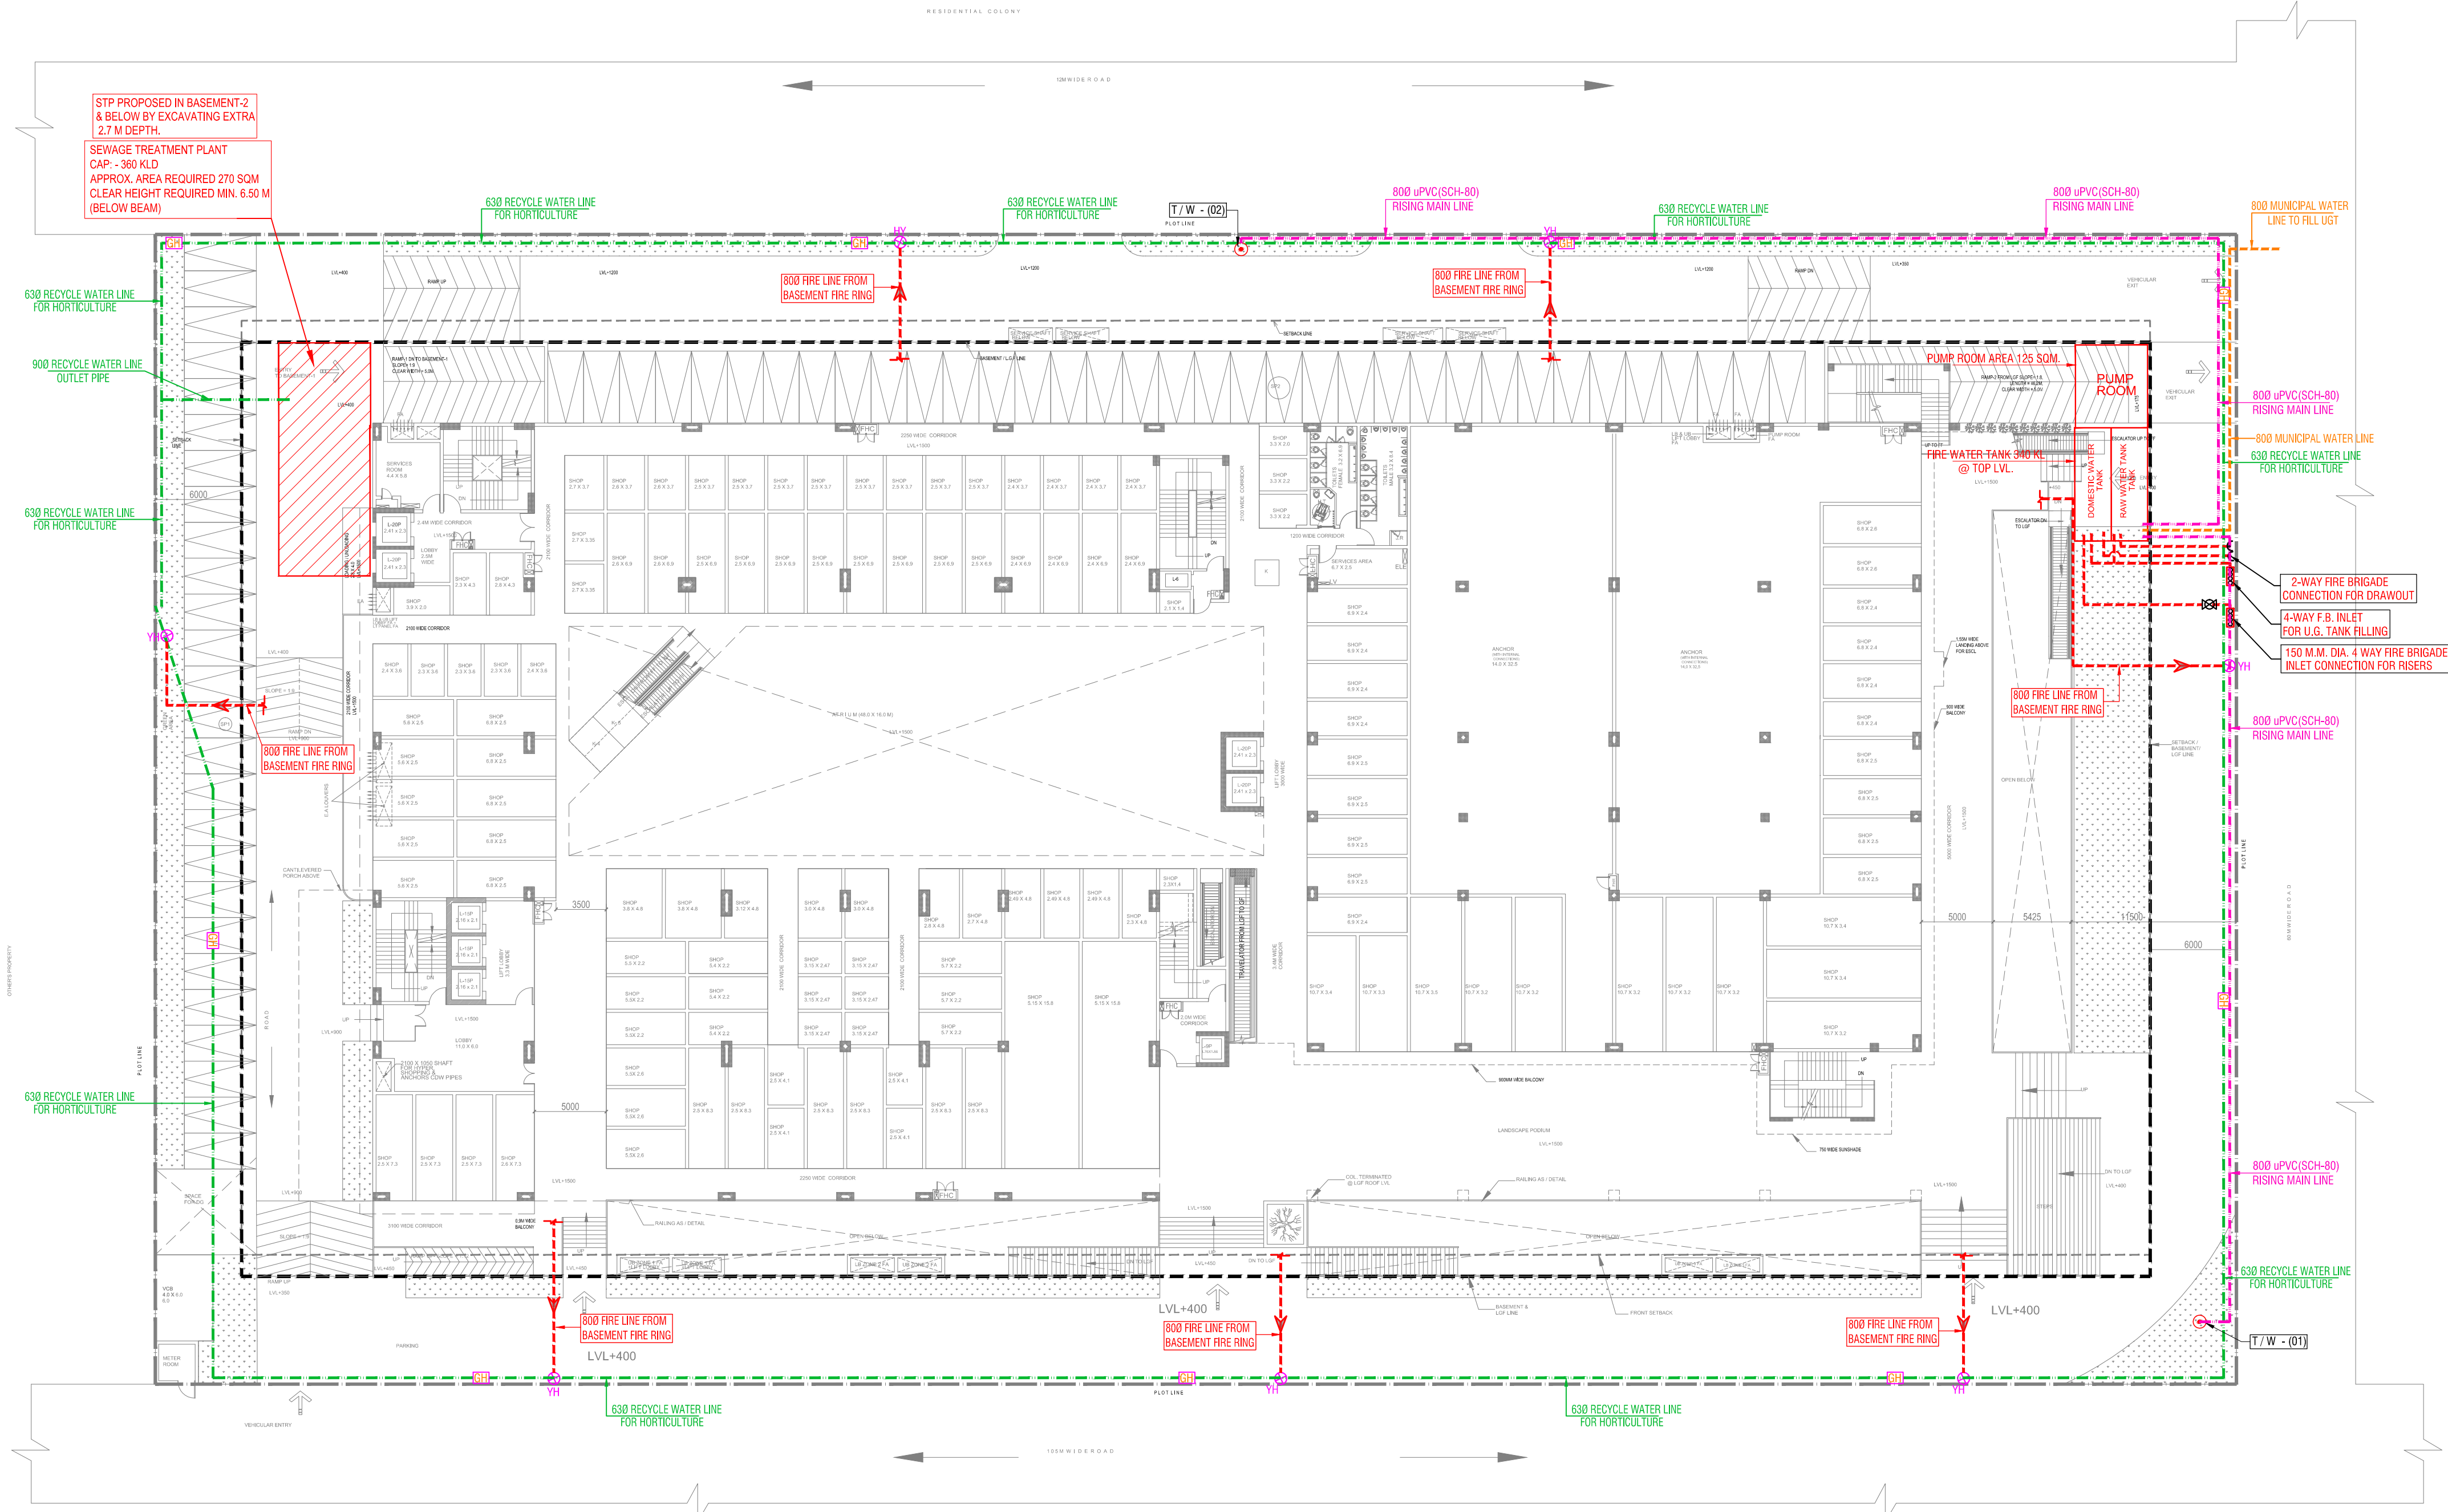

LEGEND :		
S. No.	SYMBOL	DESCRIPTION
1.		RECYCLED WATER SUPPLY PIPE LINE.
2.		RISING MAIN WATER PIPE LINE.
3.		MUNICIPAL WATER SUPPLY PIPE LINE.
4.		ISOLATING VALVE
5.		PROPOSED TUBE WELL
6.		BASEMENT LINE
7.		GARDEN HYDRANT

LEGEND : FIRE SYSTEM		
S. No.	SYMBOL	DESCRIPTION
1.		FIRE LINE
2.		YARD HYDRANT 63 M.M. DIA. SINGLE HEADED HYDRANT VALVE WITH 2 NOS. 15 M. LONG. 63 M.M. DIA. FIRE HOSE PIPE & 1 NO. BRANCH PIPE WITH NOZZLE
3.		FIRE BRIGADE CONNECTION
4.		BUTTERFLY VALVE
5.		NONRETURN VALVE (CHECK VALVE)
6.		ISOLATING VALVE WITH MASONRY CHAMBER

Rev. no.	Date	Revision
..	..	..

OWNERS:
M/S ADHM DEVELOPERS PVT LTD, AT
B-1/504, SATYAM APARTMENTS, THE NEW PROGRESSIVE,
CGHS LTD, 20-B, VASUNDHARA ENCLAVE, DELHI-110096

Project
PROPOSED THE COMMERCIAL /MULTIPLEX/OFFICES AT C-3,
COMMERCIAL BELT, ALPHA II, GREATER NOIDA,
GAUTAMBUDH NAGAR U.P.

Title
SITE PLAN

Subtitle
EXTERNAL WATER SUPPLY SYSTEM

Drawing released for
☐ APPROVAL ☒ SUBMISSION
☐ ADVANCE COPY ☐ CONSTRUCTION

Drg. no. G. N. / EX / S-02 Drawn by Kulwant

Scale 1:300 @ A1 Designed by R.K.

Date .. Checked by Anand Havella

Architects
BRU (INDIA) ARCHITECTS
F-89, GREEN PARK, NEW DELHI -16.
Ph. +91-11-26853815, 2685307; Fax : +91-11-26850788
E-mail : bruch@rediffmail.com , info@bruin.in
Website : www.atwin.in

Services Consultant
Consummate Engineering Services (P) Ltd.
Noida Office : B - 67, Sector - 67, Noida - 201 301
Tel : (0120) 6943500 (23 Lines)
Lko. Office : R 006, Rohtas Plumeria, Gomti Nagar, Lucknow
e mail : mail@cespl.in, website : www.cespl.in

