




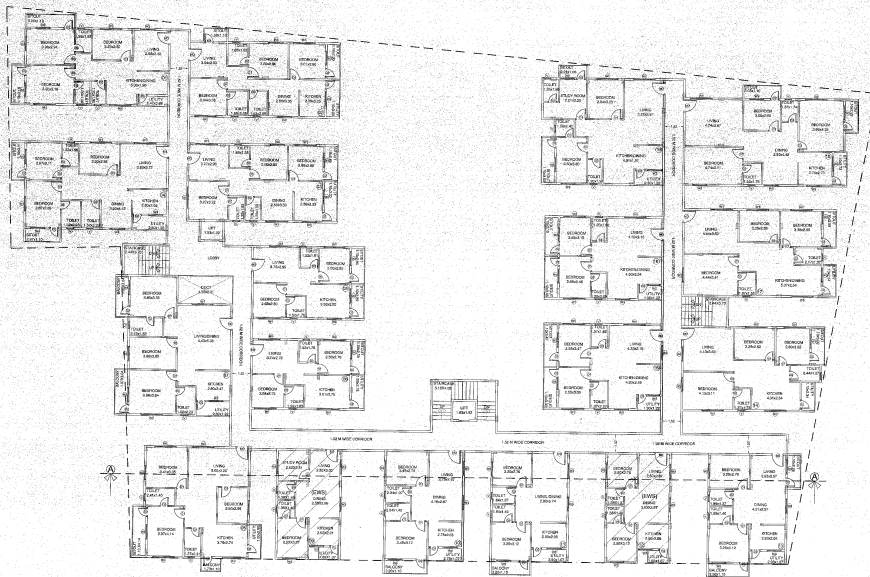


TYPICAL 1ST TO 3RD FLOOR PLAN
LVL=5.40M TO LVL=11.40M
NO OF UNITS = 17 + 12 = 29 X 03 = 87 NOS

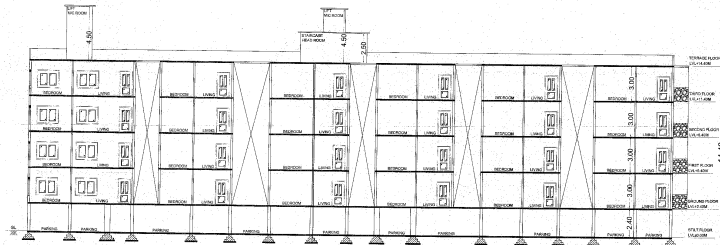

SECTION A-A

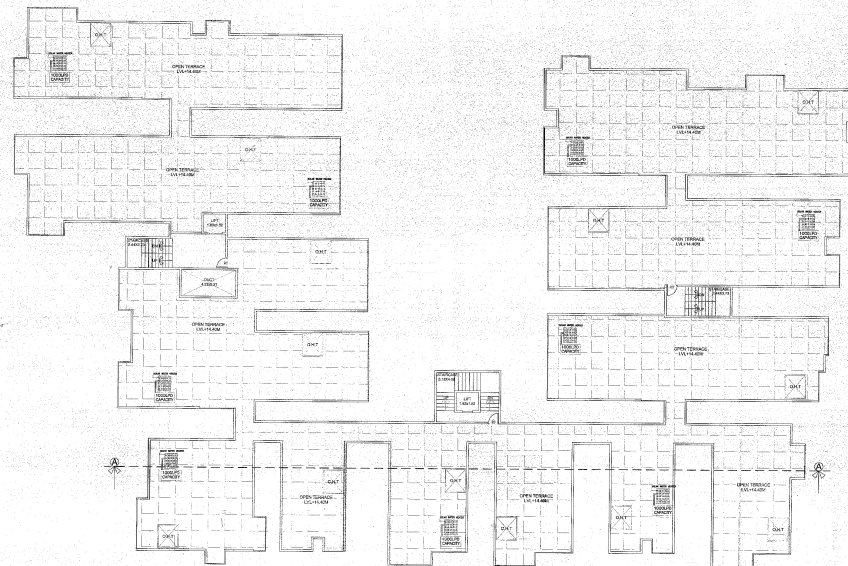

TERRACE FLOOR PLAN
LVL=14.40M

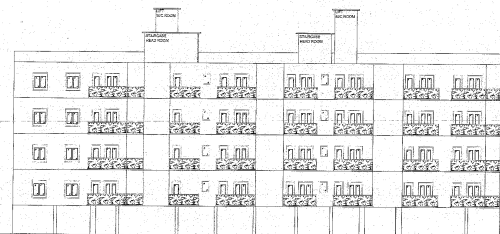

ELEVATION

NOTES:

1. All the dimensions are in meters unless otherwise specified.
2. The floor levels are as per the site plan.
3. The wall thickness is 200 mm.
4. The door and window openings are as per the architectural details.
5. The floor finish is as per the specification.
6. The wall finish is as per the specification.
7. The ceiling finish is as per the specification.
8. The floor slab is 150 mm thick.
9. The roof slab is 150 mm thick.
10. The foundation is as per the specification.
11. The structural details are as per the specification.
12. The electrical and plumbing details are as per the specification.
13. The fire safety details are as per the specification.
14. The ventilation details are as per the specification.
15. The drainage details are as per the specification.
16. The lift details are as per the specification.
17. The staircase details are as per the specification.
18. The parking details are as per the specification.
19. The boundary wall details are as per the specification.
20. The gate details are as per the specification.

SCHEDULE OF OPENING

NO	DESCRIPTION	SIZE (M ²)
D1	MAIN DOOR	1.00 X 2.10
D2	DOOR	0.90 X 2.10
W1	WINDOW	1.80 X 1.80
W2	WINDOW	1.80 X 1.80
W3	KITCHEN WINDOW	1.20 X 1.80
V	VENTILATOR	1.00 X 0.75

OWNER'S SIGNATURE:

[Signature]

ARCHITECT'S SIGNATURE:

[Signature]

CHITAN'S
BCCL-3.6E-4048-2014-15

SUBJECT OF DRAWING:
SANCTION DRAWING

PROJECT:
PROPOSED RESIDENTIAL APARTMENT
BUILDING AT SURVEY NO 89/1P
MARAGONDANAHALLI VILLAGE, JIGANI HOBLI,
ANEKAL TALUK, BANGALORE

TITLE:
TYPICAL 1ST TO 3RD FLOOR PLAN,
TERRACE FLOOR PLAN, SECTION A-A,
ELEVATION

SCALE: 1:100 **DATE:** 13-04-2017 **SHEET NO:** 4 OF 4

63.38

GROUND FLOOR PLAN

LVL+2.40M

NO OF UNITS = 17 + 02 (EWS UNITS) = 19 NOS

- [illegible]

1. ಸಾರ್ವಜನಿಕ ಶುಲ್ಕ	424564.00
2. ಮು. ಶಾಖೆಗೆ	404564.00
3. ಉದ್ಯೋಗ ಶುಲ್ಕ	17972.00
4. ಕಾರ್ಯಾಲಯ ನಿರ್ಮಾಣ ಶುಲ್ಕ	7971.00
5. ಪ್ರಾಥಮಿಕ ಶುಲ್ಕದ ವಿಧಿ	613851.00
6. ಪ್ರದರ್ಶನ ಶುಲ್ಕ	449290.00
7. ಸ್ಥಳ ಸ್ವಾಧೀನ ಶುಲ್ಕ	24000.00
8. ಕೆಲ ಉದ್ಯೋಗ ಶುಲ್ಕ	77902.00

The Applicant has remitted the fees vide Challans No: 17990, Dated: 12-04-2017.

ಸಂಖ್ಯೆ: 17/4-2017-17943-2918
 ದಿನಾಂಕ: 16/4/2017
 ವಿಷಯ: 17/4/2017 ರಂದು 16/4/2017 ರಂದು
 17/4/2017 ರಂದು 16/4/2017 ರಂದು

17/4/2017

LEGEND

BOUNDARY LINE	_____
SETBACK LINE	_____
STILT FLOOR LINE	_____

SCHEDULE OF OPENING		
MD	MAIN DOOR	1.00X2.1M
D1	DOOR	0.9X2.1M
D2	DOOR	0.75X2.1M
W	WINDOW	1.82X1.8M
W1	WINDOW	1.80X1.8M
W2	WINDOW	1.22X1.8M
W3	KITCHEN WINDOW	1.22X1.5M
V	VENTILATOR	1.0X0.75M

OWNER'S SIGNATURE:

Y. ANANDA REDDY

ARCHITECT'S SIGNATURE:

SUBJECT OF DRAWING :

SANCTION DRAWING

PROJECT:
PROPOSED RESIDENTIAL APARTMENT
BUILDING AT SURVEY NO:88/1(P),
MARAGONDANAHALLI VILLAGE, JIGANI HOBLI,
ANEKAL TALUK,BANGALORE

TITLE : GROUND FLOOR PLAN

SCALE	DATE	SHEET NO
1:100	13-04-2017	3 OF 4

N

