



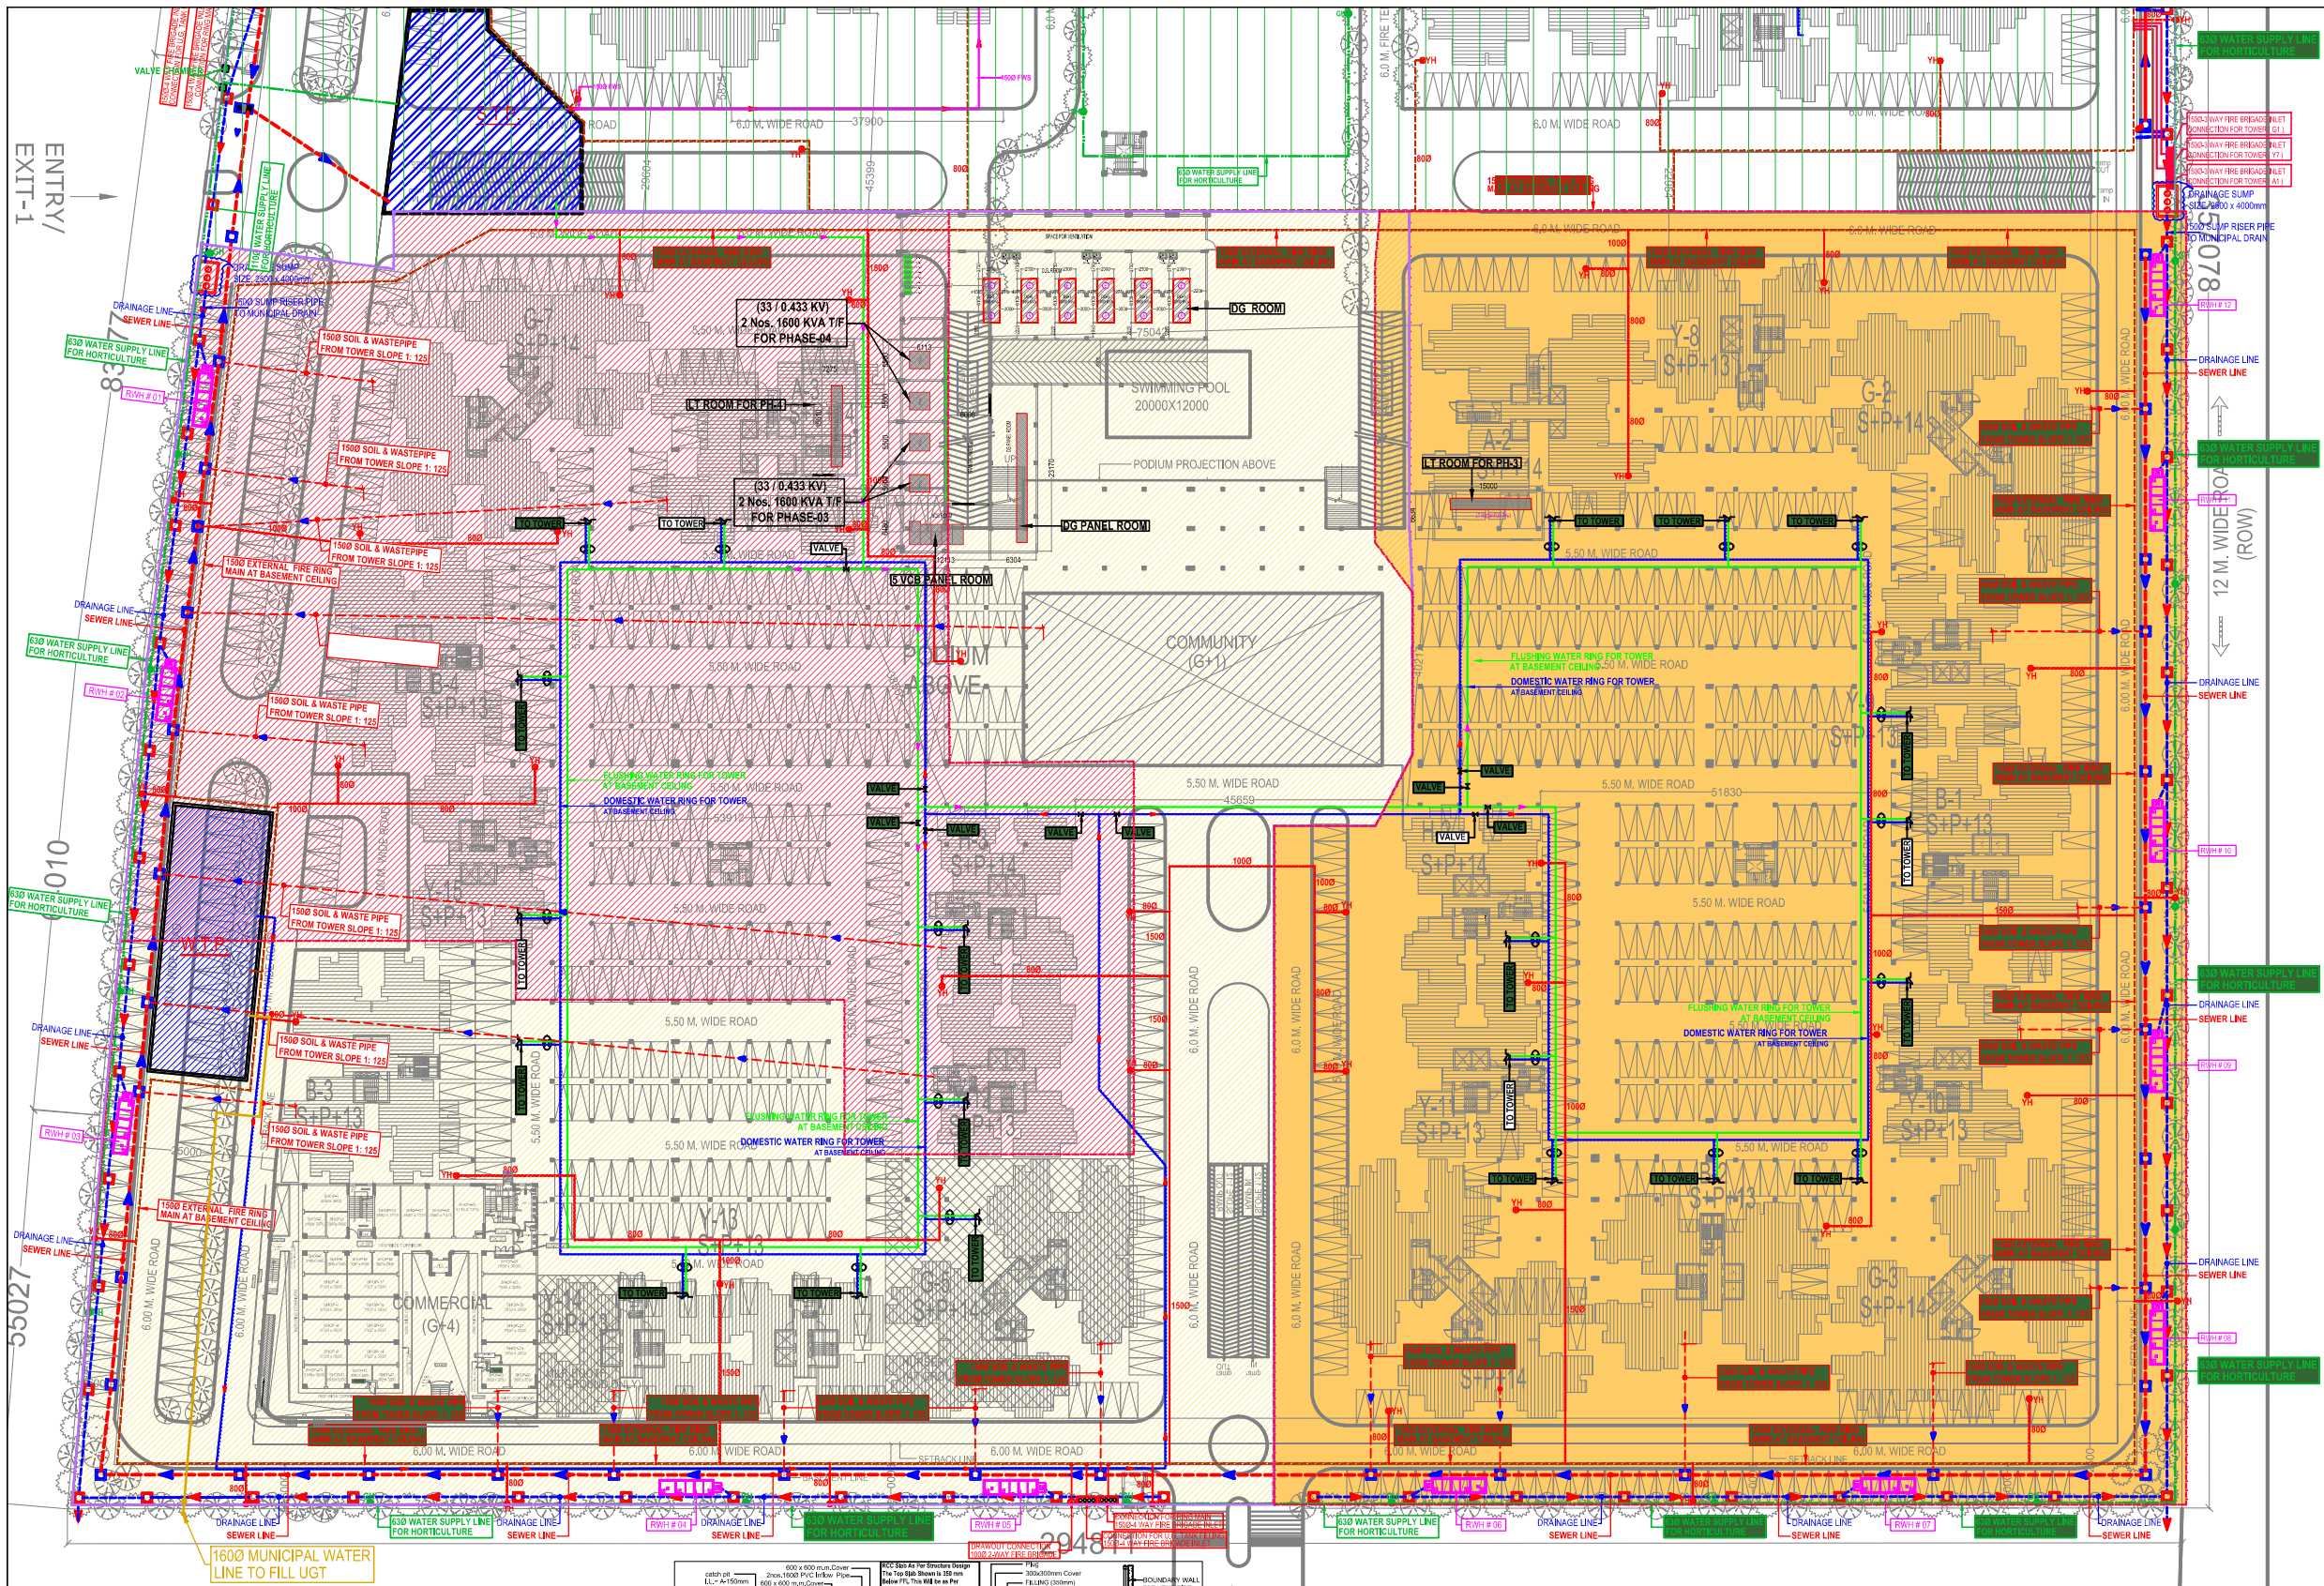



S. No.	SYMBOL	DESCRIPTION
1.	C.P.	CATCH PIT
2.	UGP	UNDER GROUND PIPE DRAIN
3.	M.H.	MAN-HOLE
4.	S.L.	SEWER LINE
5.	R.M.	RISE MAIN (FROM T.W. TO U.G.T.)
6.	M.W.S.P.	MUNICIPAL WATER SUPPLY PIPE LINE
7.	R.W.S.P.	RECYCLED WATER SUPPLY PIPE LINE FOR HORTICULTURE
8.	T.W.	PROPOSED TUBE WELL
9.	GH	GARDEN HYDRANT
10.	R.W.	BASEMENT RETAINING WALL
11.	D.T.	DESILTING TANK 2500 X 1750 X 2000 mm
12.	R.P.	RECHARGE PIT 3500 X 1750 X 2000 mm
13.	F.B.C.	FIRE BRIGADE CONNECTION
14.	B.V.	BUTTERFLY VALVE
15.	N.R.V.	NONRETURN VALVE (CHECK VALVE)
16.	S.V.	SLUICE VALVE WITH MASONRY CHAMBER
17.	Y.H.	YARD HYDRANT 63 M.M. DIA. SINGLE HEADED HYDRANT VALVE WITH 2 NOS. 15 M. LONG 63 M.M. DIA. FIRE HOSE PIPE & 1 NO. BRANCH PIPE WITH NOZZLE
18.	R.L.	INTERNAL ROAD LEVEL
19.	F.L.	FORMATION LEVEL
20.	I.L.	INVERT LEVEL
21.	C.L.	CONNECTION LEVEL

- NOTES : WATER SUPPLY**
- The depth of domestic water supply main shall be -1000 mm
 - The depth of recycle water supply main shall be -900 mm
 - The depth of rising main shall be -1000 mm
 - Pipe material for external water supply - recycle / tube well rising main / municipal line shall be : HDPE (PE100) PN8

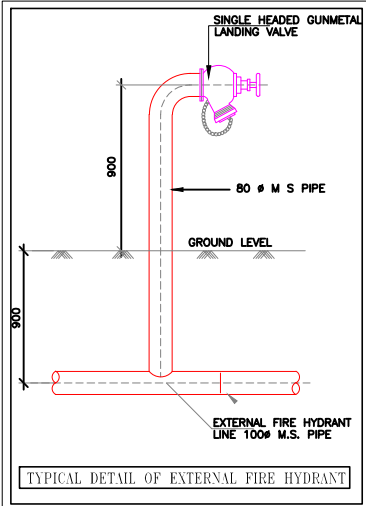

- LEGEND :**
- COMPLETED PHASE
 - PHASE, EROS SAMPOORNAM 1 SHOWN THUS AREA 16,380.00 Sqm. (Approx.)
 - PHASE, EROS SAMPOORNAM 2 SHOWN THUS AREA 13,534.00 Sqm. (Approx.)
 - PHASE, EROS SAMPOORNAM 3 SHOWN THUS AREA 21,555.00 Sqm. (Approx.)

ALL YARD HYDRANT SHALL BE CONNECTED FROM BASEMENT FIRE RING

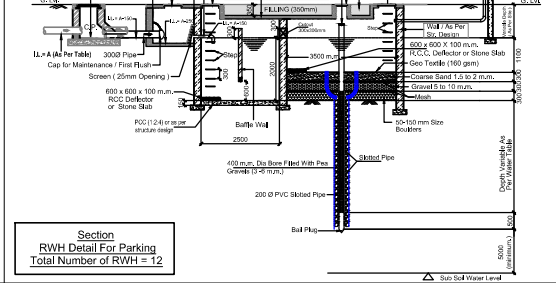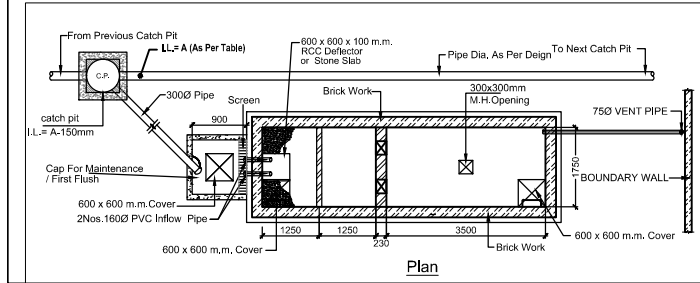

Desilting Tank Size
(L) = 2500 mm
(W) = 1750 mm
Effective Depth (D) = 2000 mm

Recharge Pit Size
(L) = 3500 mm
(W) = 1750 mm
Effective Depth (D) = 2000 mm

Note:
1) All Well / Slab / Base of RWH Shall Be Strictly As Per Structure Consultants Design & Detail.
2) The Bore Well Pipe of Recharge Pit Should Be Left At Least 5 m Above The Known Highest Water Table To Avoid Any Possible Pollution To The Aquifer.
3) The Slab Shall Start Below The Level of Foundation.

M.S. Screen Detail :
25mm Opening
320mm M.S. Bar (Epoxy Coated)

rev. no.	date	revision
1	26.10.2018	PHASE - III & IV SITE PLAN

project
EROS SAMPOORNAM GROUP HOUSING at GREATER NOIDA

title
PHASE - III & IV SITE PLAN

subtitle
SERVICES CO-ORDINATION PLAN

drawing released for	APPROVAL	SUBMISSION
drg. no.	CES / ES / SP / - 01	drawn by Arjun
scale	A1@1 : 475	designed by Shikhar Sabir
date	26.10.2018	checked by Anand Havelia

architects
VAIBHAVJAIN & ASSOCIATES
195, RAM VIHAR, DELHI-110082
PHONE/FAX : 42918322, 22377102
E mail : avinash@nae.co.in, info@nae.co.in

services consultant
Consummate Engineering Services (P) Ltd.
Noida Office : B - 67, Sector - 67, Noida - 201 301
Tel : (0120) 2993500 (30 Lines)
Lko Office : R 086, Rohas Plumeria, Gomti Nagar, Lucknow
Tel : (0522) 6515455
e mail : mail@cespln, website : www.cespln