


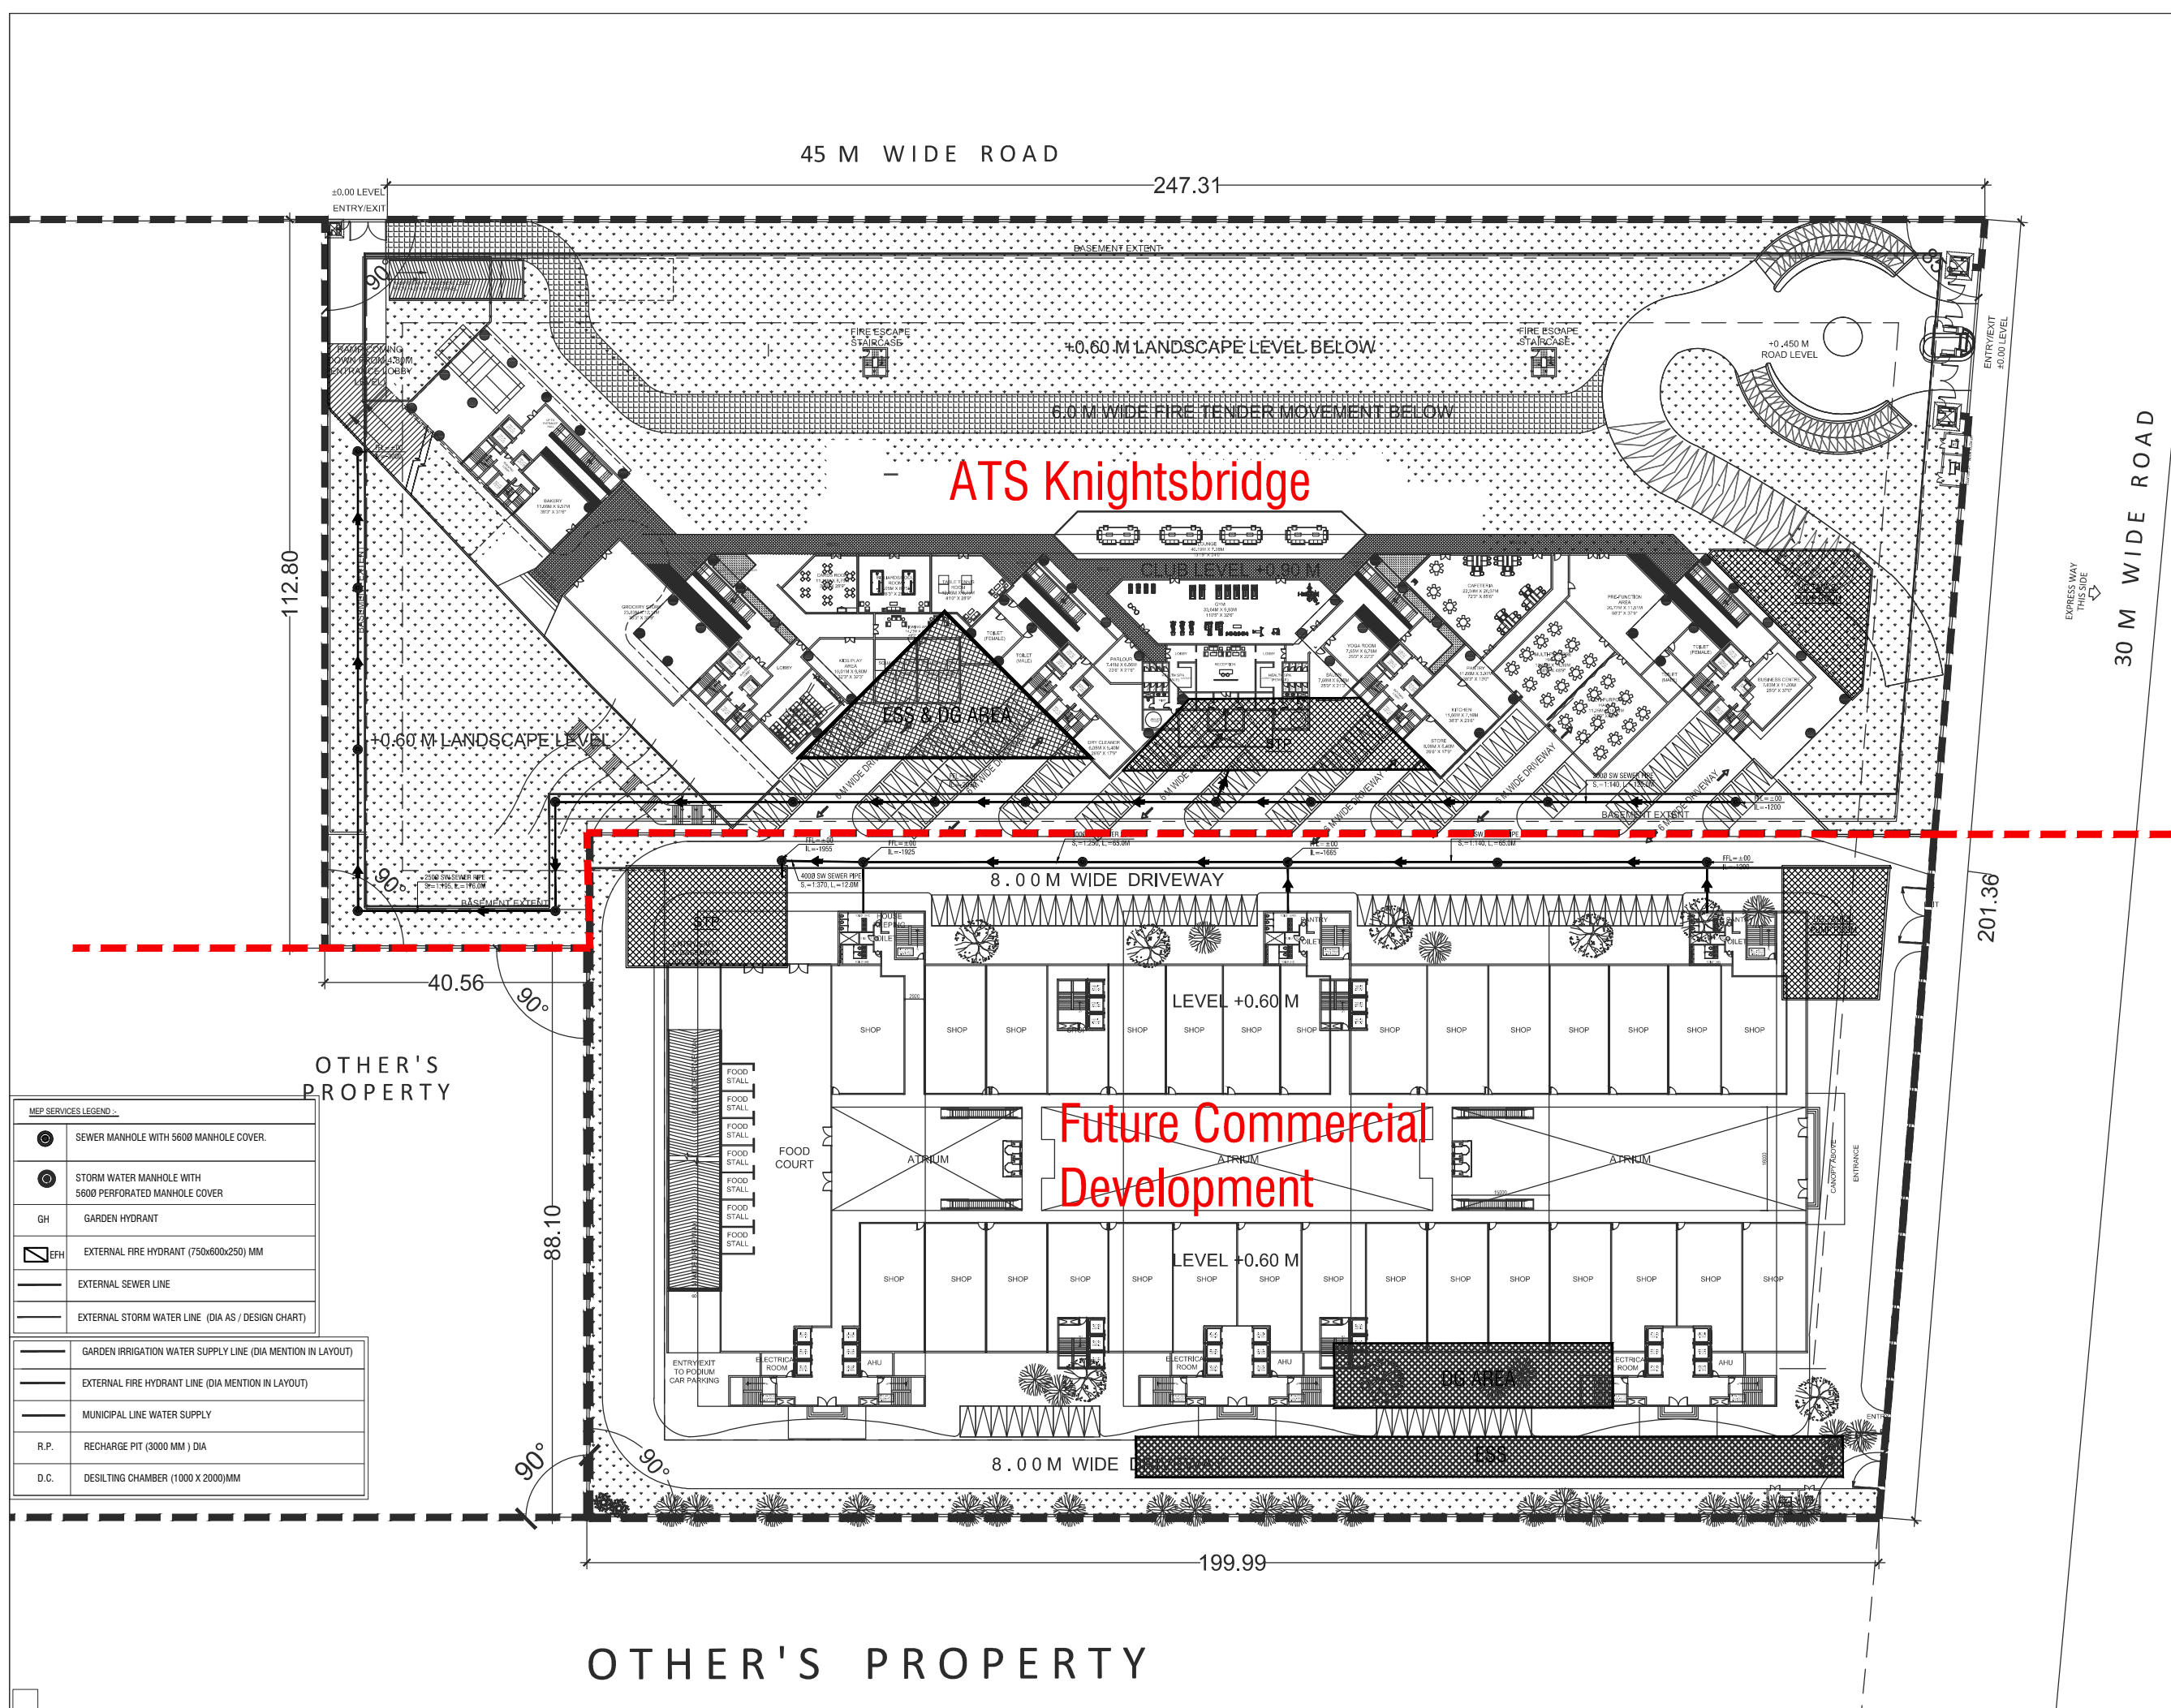

MEP SERVICES LEGEND :-	
	SEWER MANHOLE WITH 5600 MANHOLE COVER.
	STORM WATER MANHOLE WITH 5600 PERFORATED MANHOLE COVER
	GARDEN HYDRANT
	EXTERNAL FIRE HYDRANT (750x600x250) MM
	EXTERNAL SEWER LINE
	EXTERNAL STORM WATER LINE (DIA AS / DESIGN CHART)
	GARDEN IRRIGATION WATER SUPPLY LINE (DIA MENTION IN LAYOUT)
	EXTERNAL FIRE HYDRANT LINE (DIA MENTION IN LAYOUT)
	MUNICIPAL LINE WATER SUPPLY
	R.P. RECHARGE PIT (3000 MM) DIA
	D.C. DESILTING CHAMBER (1000 X 2000)MM

EIA SUBMISSION DRAWING				
OWNER :-				
ATS Heights Pvt Ltd				
AUTHORISED SIGNATORY				
ARCHITECT'S SIGNATURE				
PROJECT				
MIXED USE DEVELOPMENT PLOT NO. A-01/A , SECTOR - 124, GAUTAM BUDDHA NAGAR , NOIDA (U.P)				
DRAWING TITLE :-				
EXTERNAL SITE PLAN SEWER LAYOUT				
DEALT BY	SCALE :-	DATE :-	DRG. NO.	NO. OF SHEETS
T.S.	1:400 (A3)	16.12.2015	SD-01A	1