


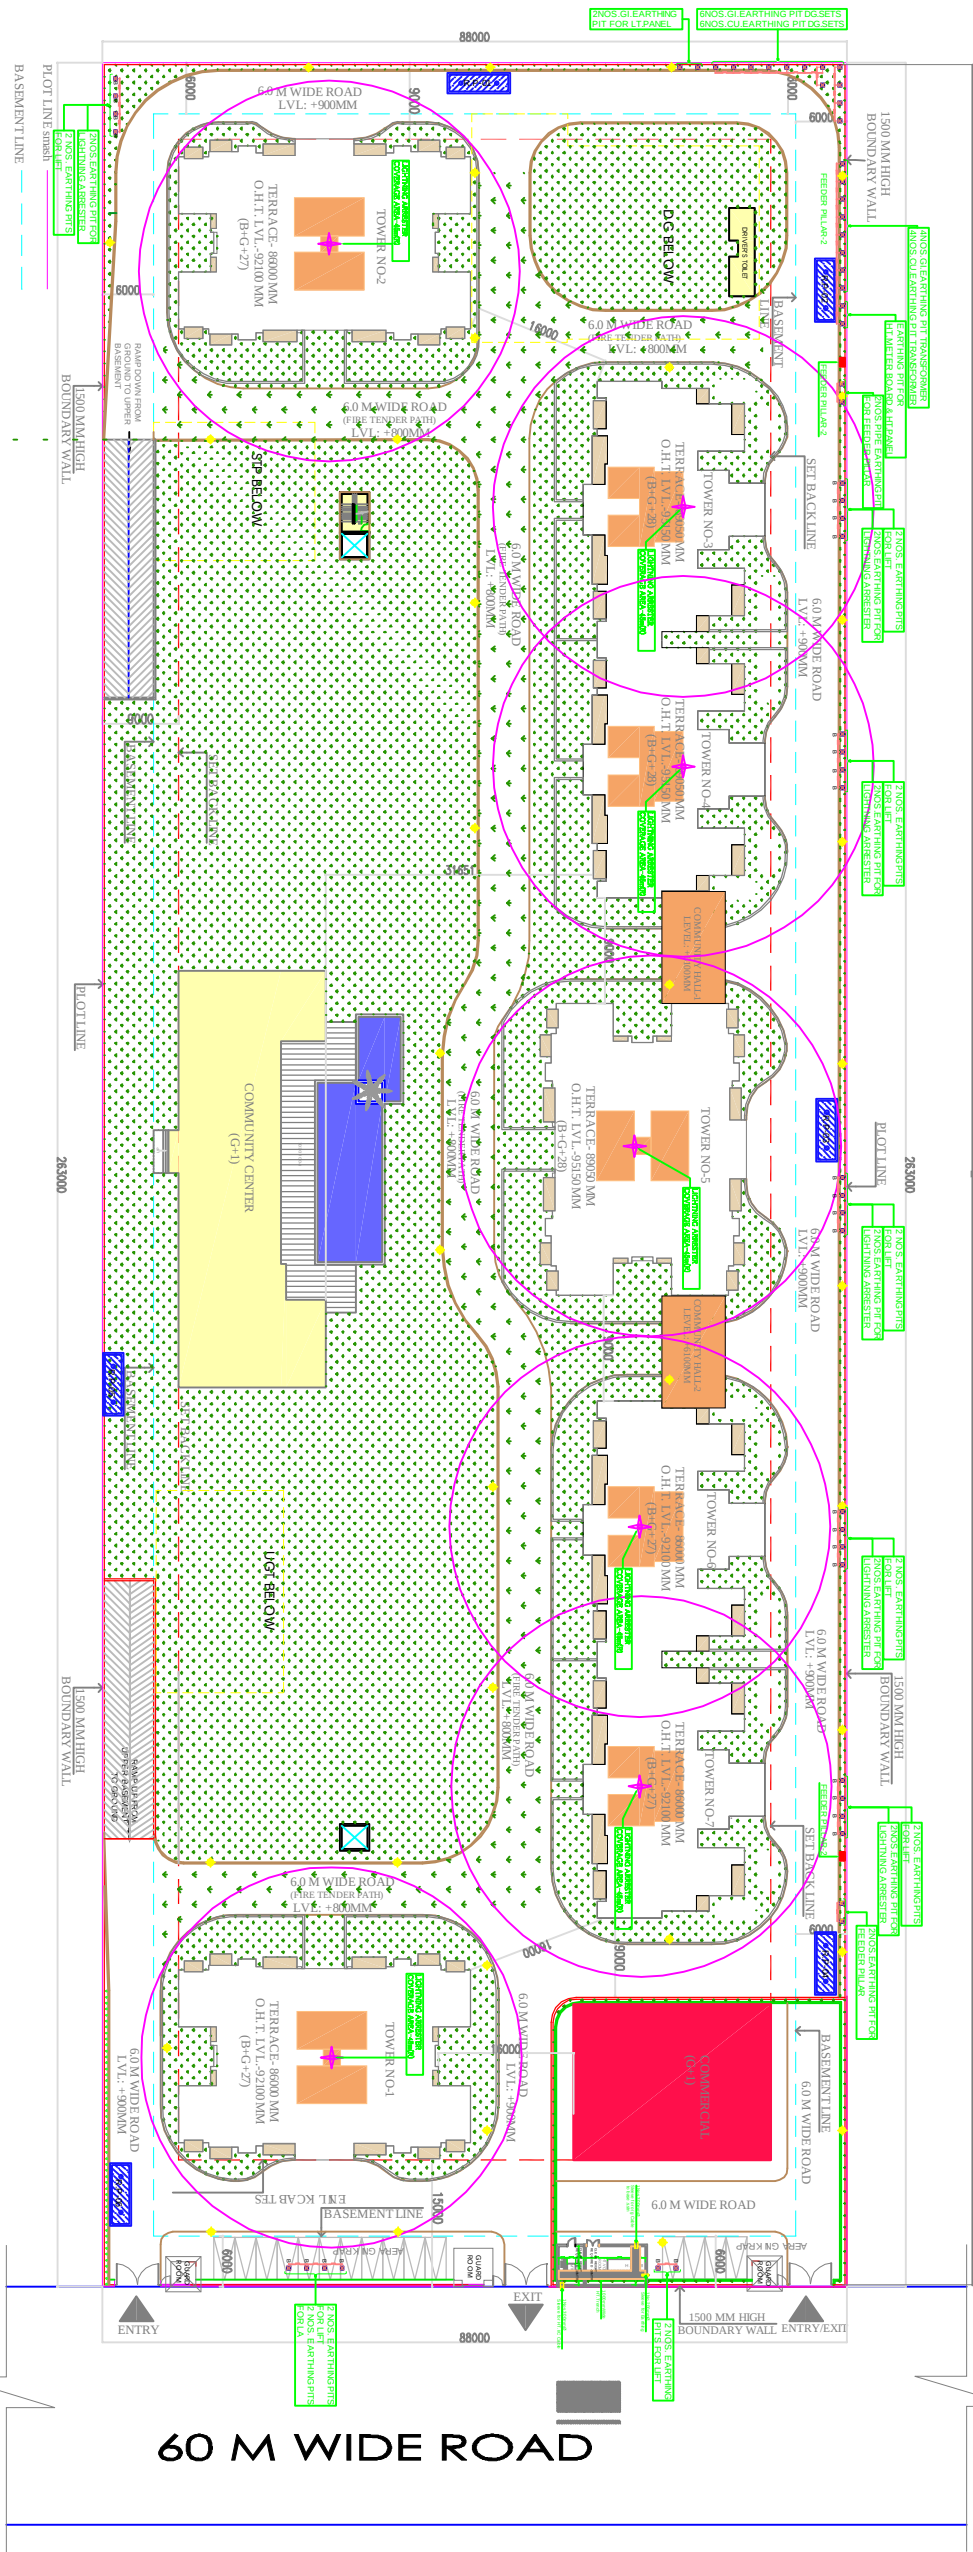

LEGEND:-

- COMMERCIAL AREA
- SERVICES
- BALCONY
- MUMMITYMACHINE ROOM
- SWIMMING POOL
- RECHARGE PIT
- GREEN AREA

LEGEND.

- POLE LIGHT - 6.0 M TALL.
- FEEDER PILLER
- EARTHING PITS

SUBMISSION DRAWING

ELECTRICAL LAYOUT SITE PLAN

OWNER: DAR HOUSING LIMITED
EARLIER KNOWN AS PANCHSHEEL PROMOTERS LIMITED
PLOT NO: GH-12/4
SECTOR 01
GREATER NOIDA

PROJECT: PROPOSED GROUP HOUSING
ATS BHAPRODY AT
PLOT NO: GH-12/1
SECTOR 01
GREATER NOIDA

ARCHITECT'S SIGNATURE

OWNER'S SIGNATURE

DRG. BY	SCALE	DRG. NO.	NORTH
SH	1:500	SD-01	
CHECKED BY	DATE		
K.A	08.04.2017		