


45.0 Mts WIDE ROAD


45.0 Mts WIDE ROAD

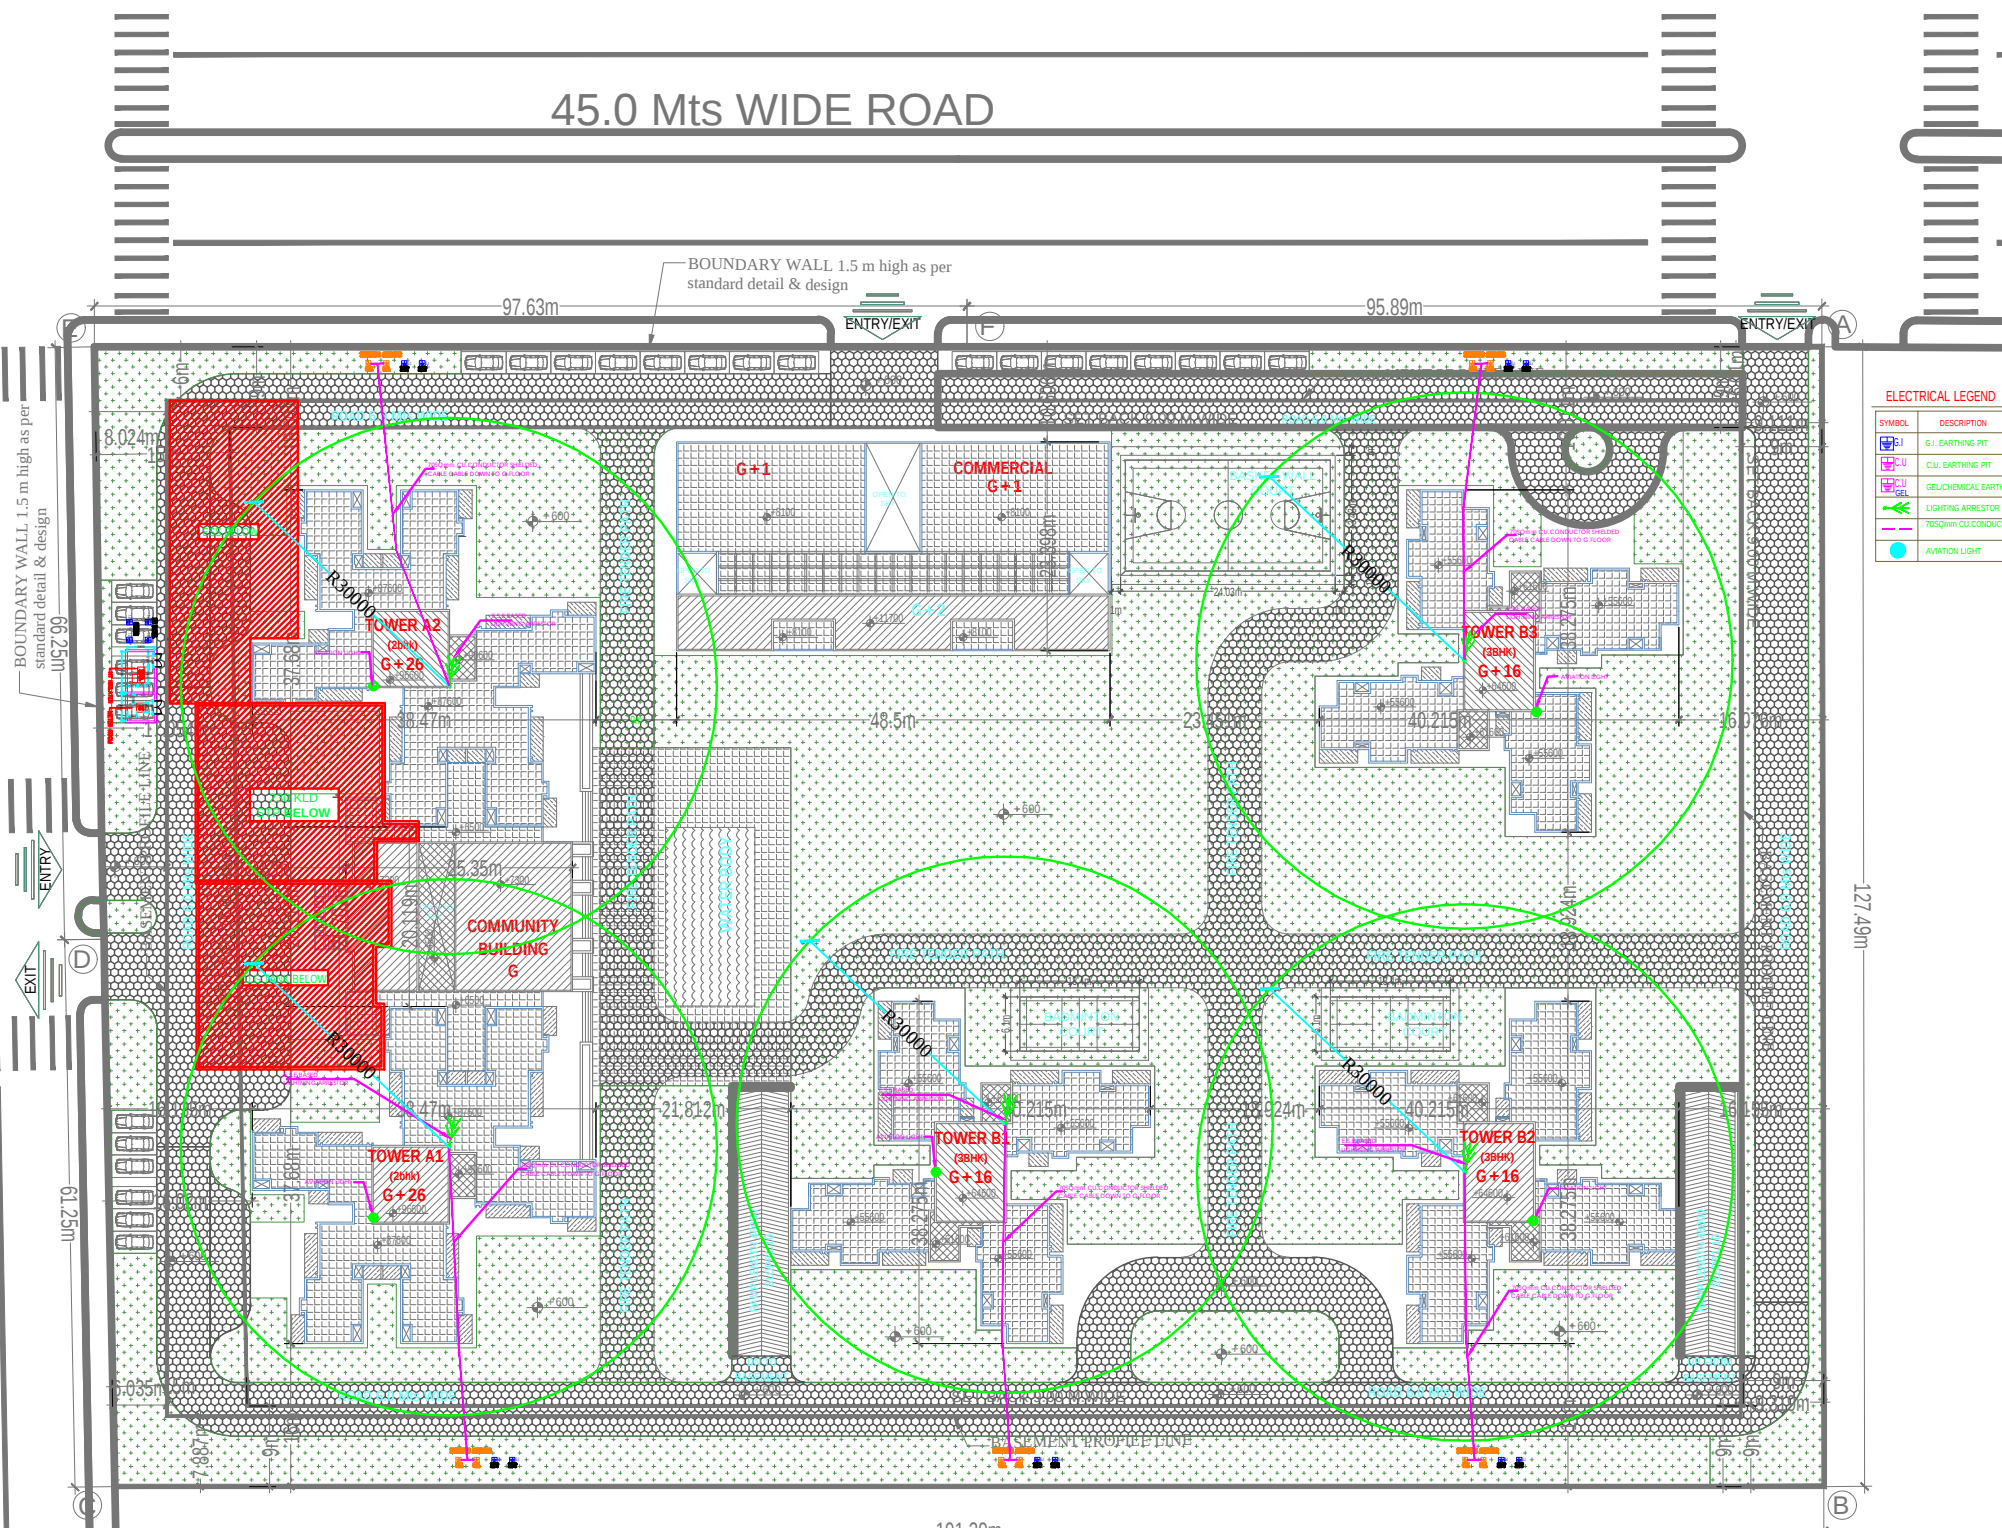

ELECTRICAL LEGEND	
SYMBOL	DESCRIPTION
	G.I. EARTHING PIT
	C.U. EARTHING PIT
	GELCHEMICAL EARTHING PIT
	LIGHTNING ARRESTOR
	705sqmm CU CONDUCTOR SHILED CABLE
	AVIATION LIGHT

- NOTES
1. ALL LIFTS SHALL HAVE 100% POWER BACK-UP.
 2. ALL ELECTRICAL INSTALLATIONS SHALL BE AS PER PROVISIONS OF NBC.
 3. VENTILATION IN BASEMENTS SHALL BE AS PER RELEVANT NBC PROVISIONS 12-15 AIR CHANGES PER HOUR FOR NORMAL OPERATION 30 AIR CHANGES PER HOUR FOR OPERATION IN CASE OF FIRE.
 4. FIRE-FIGHTING / SAFETY PROVISIONS WILL BE AS PER RELEVANT NBC PROVISIONS
 5. BUILDING STRUCTURE DESIGNED EARTH QUAKE RESISTANT
 6. ALL RAMP ARE IN 1:10 SLOP FOR CARS & 1:20 FOR HANDICAPS UNTIL UNLESS SPECIFIED
 7. 200 mm WIDE (AAC) BLOCKS SHALL BE USED FOR EXTERNAL WALLS & 100 MM WIDE (AAC) BLOCKS SHALL BE USED FOR INTERNAL WALLS
 8. KITCHEN & TOILETS EXHAUST FAN PROVIDED / MECHANICALLY LIT & VENTILATED.
 9. ALL FIRE STAIR CASE ARE ON EXPOSED WALL WITH 1050 RAILING OTHERWISE MECHANICALLY LIT & PRESSURISED AS NBC.

— PLOT BOUNDARY
— RETRAK LINE
— BASEMENT PROFILE LINE

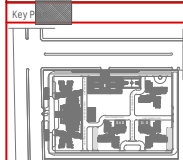

RERA SUBMISSION DRAWING

Architects Signature
ARCOP ASSOCIATES
A-15, PAMPOSH ENCLAVE
New Delhi-110 048

Owner's Signature

Clients
STARLANDCRAFT PVT. LTD.
B-47 Surajpur,
Ghaziabad -201010


Architects

Project title
Proposed Building Plan at Plot no SC-6109,
Sector 152, Noida being developed by M/S Star
Landcraft PVT. LTD.


MEP Consultants
PARADISE CONSULTANTS
PLOT NO. 103, POCKET-1 BASEMENT,
NEAR LIVING STYLE MALL,
JASOLA VIHAR NEW DELHI - 110025
PHONE NO. : 011-29943601, 26943216
E-MAIL : paradiseconsultants@gmail.com

Drawing Title
**EXTERNAL SITE PLAN
ELECTRICAL LAYOUT**

Job No. 2016/03	Drawing No. PL-ELECTRICAL-004
Drawn VIRRAM	Checked NAFEEZ
Date 09.04.21	Scale 1:300 (A2)
	Revisions

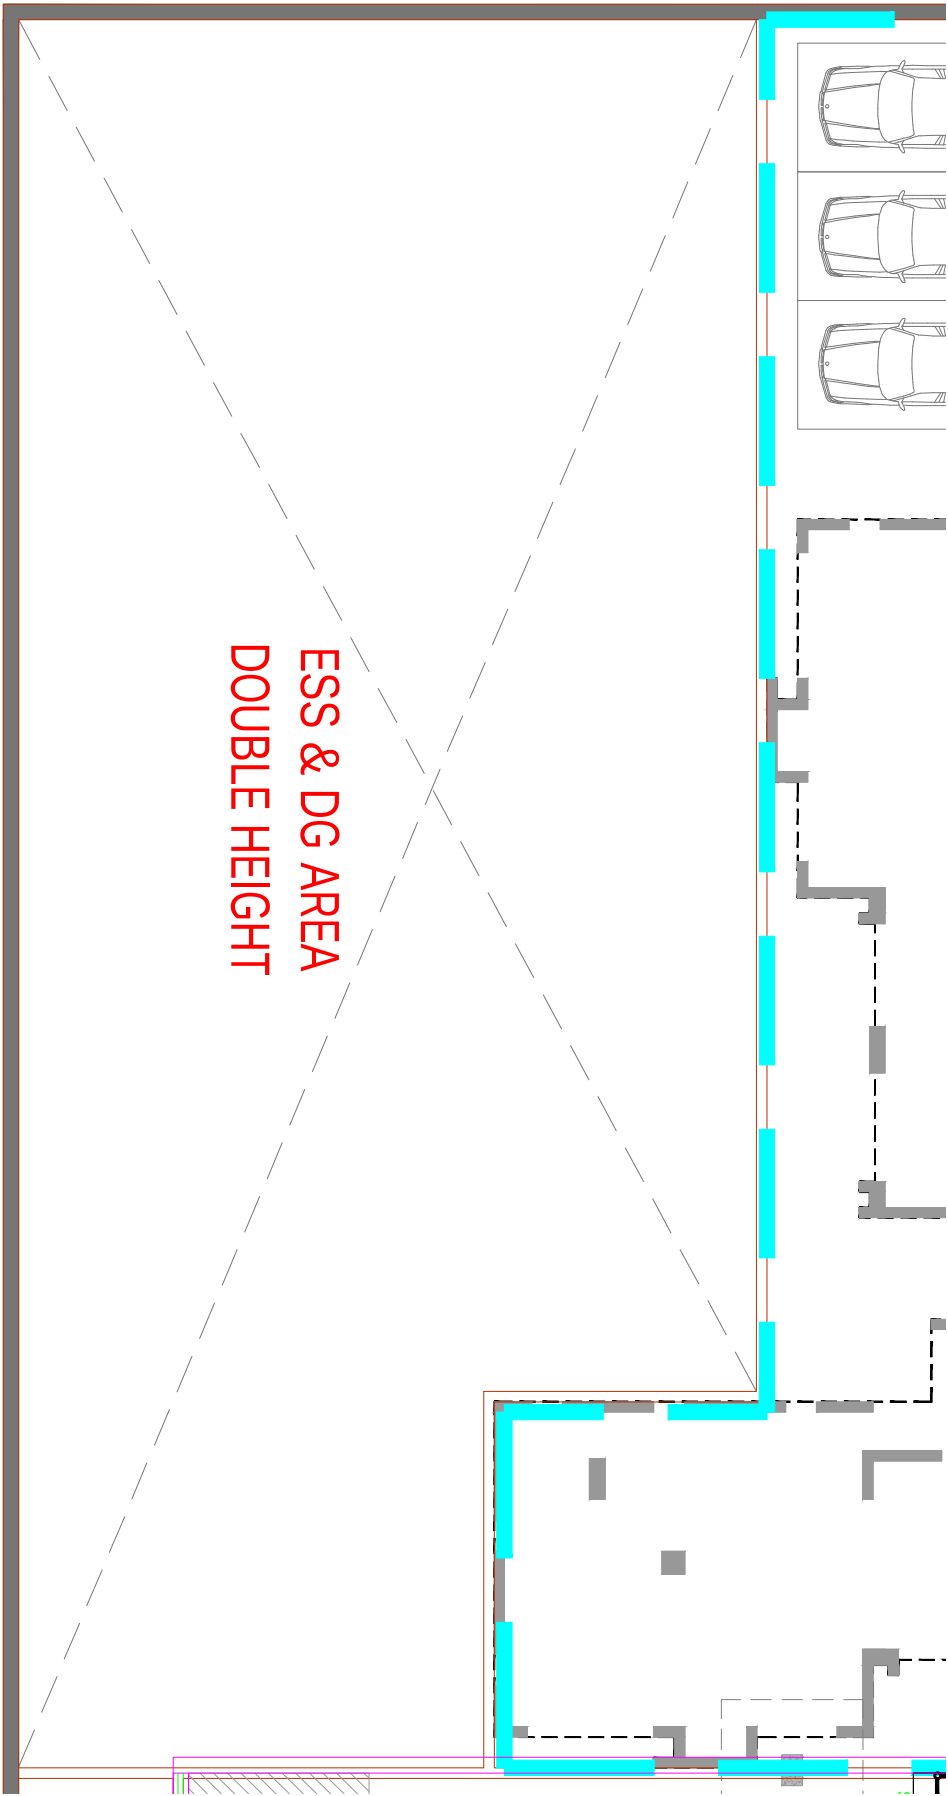

ESS & DG UPPER BASEMENT FLOOR LVL

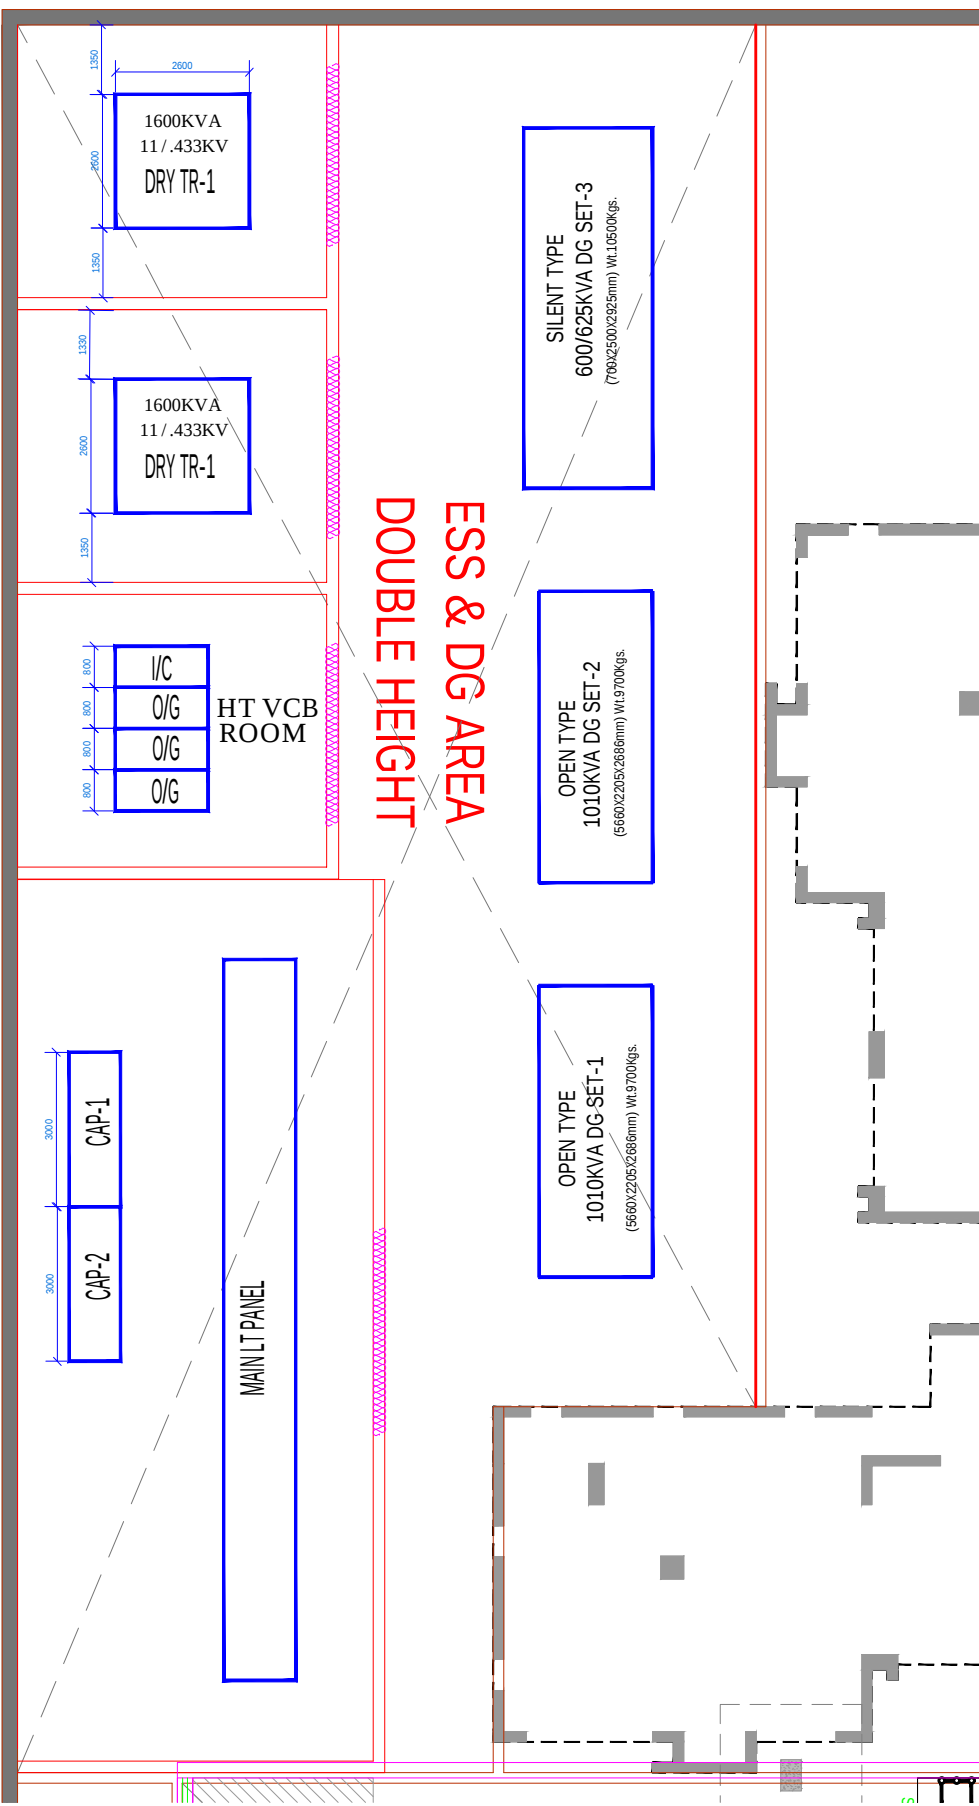

ESS & DG LOWER BASEMENT FLOOR LVL

NOTES

1. ALL LIFTS SHALL HAVE 100% POWER BACK-UP.
2. ALL ELECTRICAL INSTALLATIONS SHALL BE AS PER PROVISIONS OF NBC.
3. VENTILATION IN BASEMENTS SHALL BE AS PER RELEVANT NBC PROVISIONS 12-15 AIR CHANGES PER HOUR FOR NORMAL OPERATION 30 AIR CHANGES PER HOUR FOR OPERATION IN CASE OF FIRE.
4. FIRE-FIGHTING / SAFETY PROVISIONS WILL BE AS PER RELEVANT NBC PROVISIONS
5. BUILDING STRUCTURE DESIGNED EARTH QUAKE RESISTANT
6. ALL RAMP ARE IN 1:10 SLOP FOR CARS & 1:20 FOR HANDCAPS UNTIL UNLESS SPECIFIED
7. 200 mm WIDE (AAC) BLOCKS SHALL BE USED FOR EXTERNAL WALLS & 100 MM WIDE (AAC) BLOCKS SHALL BE USED FOR INTERNAL WALLS
8. KITCHEN & TOILETS EXHAUST FAN PROVIDED / MECHANICALLY LIT & VENTILATED.
9. ALL FIRE STAIR CASE ARE ON EXPOSED WALL WITH 1050 RAILING OTHERWISE MECHANICALLY LIT & PRESSURISED AS/NBC.

Key Plan

RERA SUBMISSION DRAWING

As per RERA Act, 2017 and RERA Rules, 2017. The drawing is submitted for the purpose of RERA registration.

Architects Signature

ARCOP ASSOCIATES
A-15, PAMPOSH ENCLAVE
New Delhi-110 048

Owner's Signature

Clients

STAR LANDCRAFT PVT. LTD.
B-47 Sayangar,
Ghaziabad-201010

Architects

Project title

Proposed Building Plan at Plot no SC-01/09,
Sector 152, Noida being developed by MIS Star
Landcraft PVT. LTD.

MEP Consultants

PARADISE CONSULTANTS
PLOT NO. 103, POCKET-1 BASEMENT,
NEAR LIVING STYLE MALL,
JASOLA VIHAR NEW DELHI - 110025
PHONE NO. : 011-29643601, 29643216
E-MAIL : paradise consultants @ gmail.com

Drawing Title

**ESS & DG
ELECTRICAL LAYOUT**

Job No.	2025043	Drawing No.	PL-ESS & DG -001
Drawn	VIKRAM	Checked	NAFEES
Date	05.04.23	Scale	1:50 (A2)
		Revisions	01