


45.0 Mts WIDE ROAD


45.0 Mts WIDE ROAD

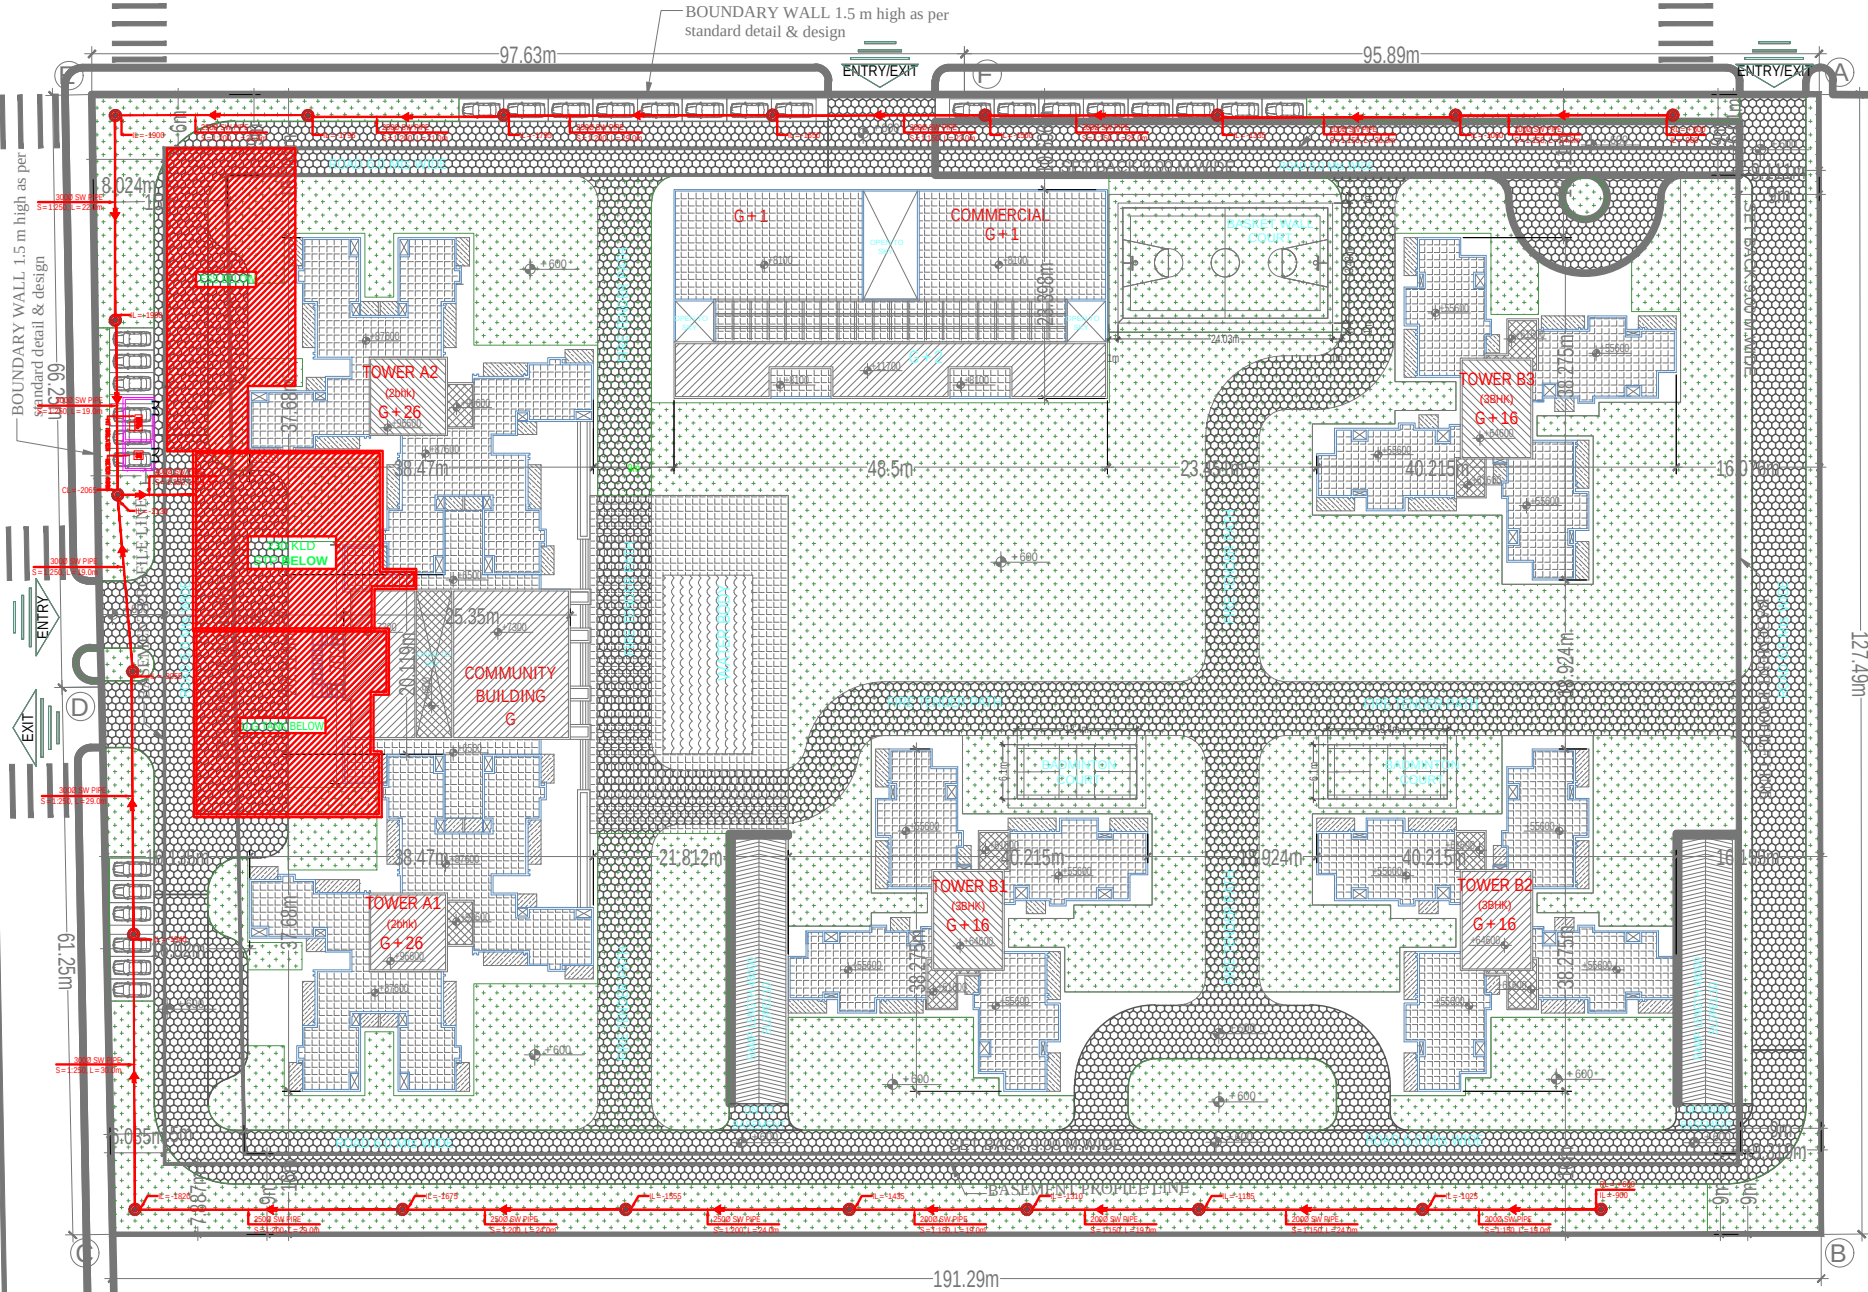

PLUMBING SYMBOLS LEGEND	
	STORM WATER MANHOLE (800 x 600) MM
	STORM WATER MANHOLE (800 x 800) MM
	SEWER MANHOLE (800 x 800) MM
	SEWER MANHOLE (800 x 800) MM
	EXTERNAL SEWER LINE
	EXTERNAL STORM WATER LINE
	DOMESTIC WATER SUPPLY LINE
	FLUSHING WATER SUPPLY LINE
	EXTERNAL FIRE HYDRANT LINE
	MUNICIPAL LINE WATER SUPPLY
	MUNICIPAL LINE WATER SUPPLY
	GARDEN IRRIGATION WATER SUPPLY LINE
	EXTERNAL FIRE HYDRANT (750x600x250) MM
	GARDEN HYDRANT
	RECHARGE PIT (3000 MM DIA)
	DESLEUDGING CHAMBER (1000 x 2000) MM
	VALVE WITH CHAMBER
	NON RETURN VALVE WITH CHAMBER (N.R.V.)

1. ALL LIFTS SHALL HAVE 100% POWER BACK-UP.
2. ALL ELECTRICAL INSTALLATIONS SHALL BE AS PER PROVISIONS OF NBC.
3. VENTILATION IN BASEMENTS SHALL BE AS PER RELEVANT NBC PROVISIONS 12-15 AIR CHANGES PER HOUR FOR NORMAL OPERATION 30 AIR CHANGES PER HOUR FOR OPERATION IN CASE OF FIRE.
4. FIRE-FIGHTING / SAFETY PROVISIONS WILL BE AS PER RELEVANT NBC PROVISIONS
5. BUILDING STRUCTURE DESIGNED EARTH QUAKE RESISTANT
6. ALL RAMP ARE IN 1:10 SLOP FOR CARS & 1:20 FOR HANDICAPS UNTIL UNLESS SPECIFIED
7. 200 mm WIDE (AAC) BLOCKS SHALL BE USED FOR EXTERNAL WALLS & 100 MM WIDE (AAC) BLOCKS SHALL BE USED FOR INTERNAL WALLS
8. KITCHEN & TOILETS EXHAUST FAN PROVIDED / MECHANICALLY LIT & VENTILATED.
9. ALL FIRE STAIR CASE ARE ON EXPOSED WALL WITH 1050 RAILING OTHERWISE MECHANICALLY LIT & PRESSURISED AS NBC.

— PLOT BOUNDARY
— SETBACK LINE
— BASEMENT PROFILE LINE

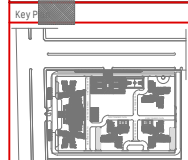

RERA SUBMISSION DRAWING

Architects Signature
ARCOP ASSOCIATES
A-15, PAMPOSH ENCLAVE
New Delhi-110 048

Owner's Signature

Clients
STARLANDCRAFT PVT. LTD.
B-47 Surajmal,
Ghaziabad - 201010


Architects

Project title
Proposed Building Plan at Plot no SC-6109,
Sector 152, Noida being developed by M/S Star
Landcraft PVT. LTD.

MEP Consultants
PARADISE CONSULTANTS
PLOT NO. 103, POCKET-1 BASEMENT,
NEAR LIVING STYLE MALL,
JASOLA VIHAR NEW DELHI - 110025
PHONE NO. : 011-29943601, 26943216
E-MAIL : paradiseconsultants@gmail.com


Drawing Title
**EXTERNAL SITE PLAN
SEWER LAYOUT**

Job No.	Drawing No.
2016/03	PL-SEWER-001
Drawn	Checked
VIKRAM	NAFEEZ
Date	Scale
09.04.21	1:300 (A2)
	Revisions
	1

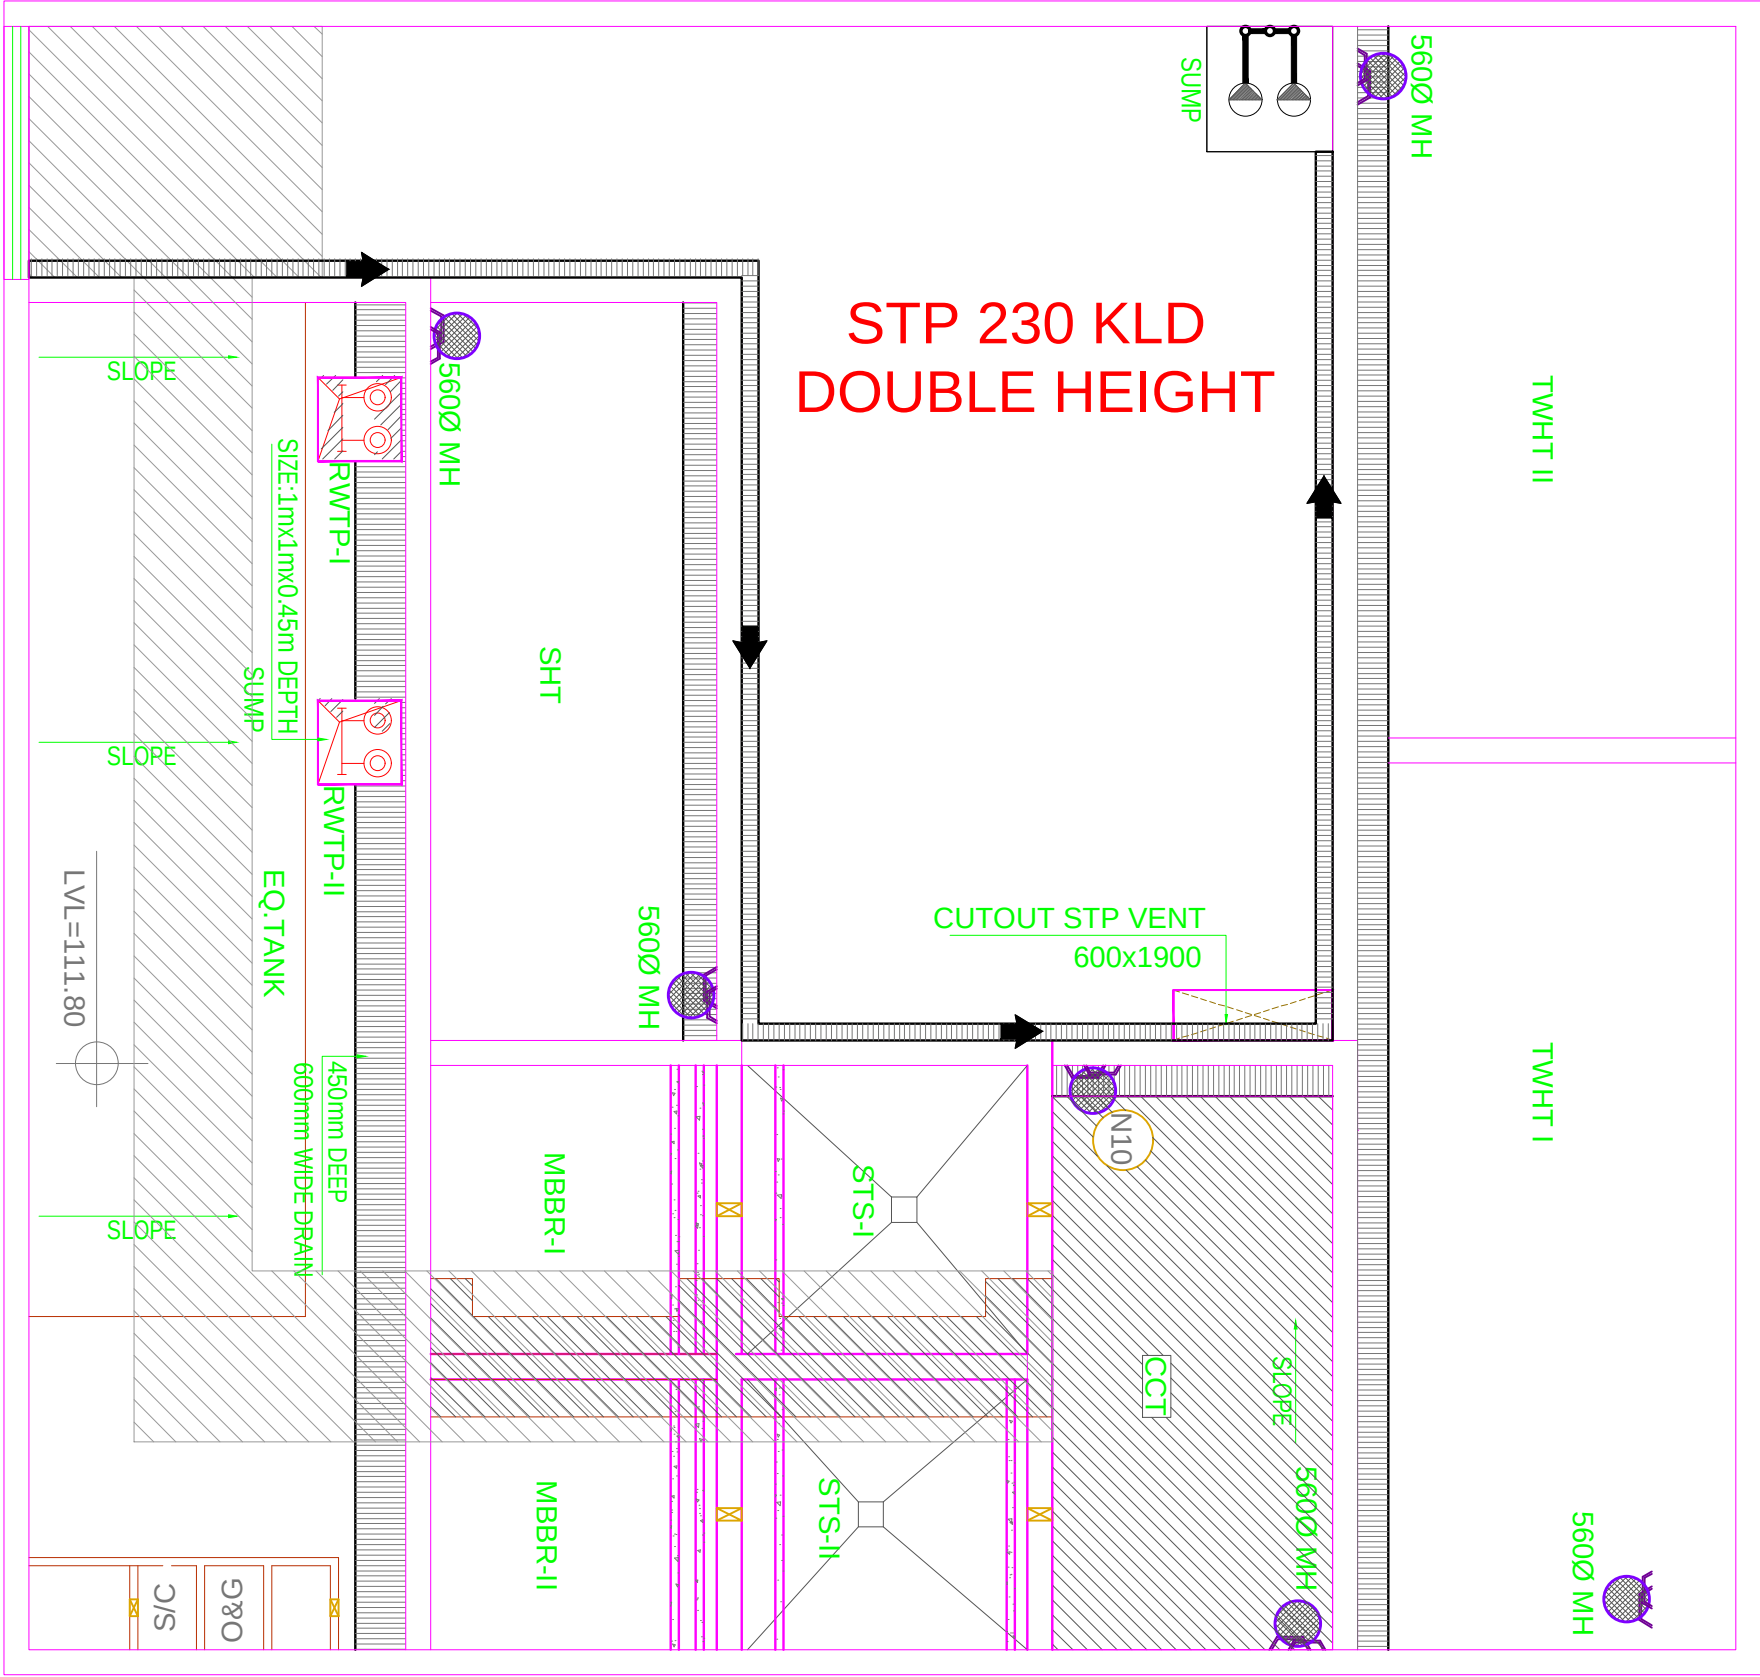

TANK SCHEDULE		
SYMBOL	DESCRIPTION	QTY
S/C	SCREEN CHAMBER	1 NOS
O&G	OIL & GREASE TANK	1 NOS
EQ.T.	EQUALIZATION TANK	1 NOS
MBBR	MBBR TANK	2 NOS
STS	SECONDARY TUBE SETTLER	2 NOS
CCT	CHLORINE CONTACT TANK	1 NOS
SHT	SLUDGE HOLDING TANK	1 NOS
TWHT	TREATED WATER HOLDING TANK	2 NOS
PRS	PLANT ROOM SUMP	1 NOS

- NOTES
1. ALL LIFTS SHALL HAVE 100% POWER BACK-UP.
 2. ALL ELECTRICAL INSTALLATIONS SHALL BE AS PER PROVISIONS OF NBC.
 3. VENTILATION IN BASEMENTS SHALL BE AS PER RELEVANT NBC PROVISIONS 12-15 AIR CHANGES PER HOUR FOR NORMAL OPERATION 30 AIR CHANGES PER HOUR FOR OPERATION IN CASE OF FIRE.
 4. FIRE-FIGHTING / SAFETY PROVISIONS WILL BE AS PER RELEVANT NBC PROVISIONS
 5. BUILDING STRUCTURE DESIGNED EARTHQUAKE RESISTANT
 6. ALL RAMP ARE IN 1:10 SLOP FOR CARS & 1:20 FOR HANDICAPS UNTIL UNLESS SPECIFIED
 7. 200 mm WIDE (AAC) BLOCKS SHALL BE USED FOR EXTERNAL WALLS & 100 MM WIDE (AAC) BLOCKS SHALL BE USED FOR INTERNAL WALLS
 8. KITCHEN & TOILETS EXHAUST FAN PROVIDED / MECHANICALLY LIT & VENTILATED.
 9. ALL FIRE STAIR CASE ARE ON EXPOSED WALL WITH 1050 RAILING OTHERWISE MECHANICALLY LIT & PRESSURISED AS/NBC.

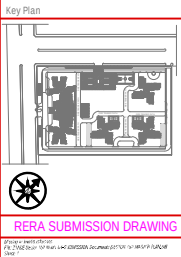

RERA SUBMISSION DRAWING

Architects Signature
ARCOP ASSOCIATES
A-15, PAMPOSH ENCLAVE
New Delhi-110 048

Owner's Signature

Clients
STAR LANDCRAFT PVT. LTD.
B-47 Sayyadgarh,
Ghaziabad-201010

Architects

Project title
Proposed Building Plan at Plot no SC-01/09,
Sector 152, Noida being developed by MIS Star
Landcraft PVT. LTD.

MEP Consultants
PARADISE CONSULTANTS
PLOT NO. 103, POCKET-1 BASEMENT,
NEAR LIVING STYLE MALL,
JASOLA VIHAR NEW DELHI - 110025
PHONE NO. : 011-29643601, 29643216
E-MAIL : paradiseconsultants@gmail.com

Drawing Title		Drawing No.	
STP 230 KLD PLUMBING LAYOUT		PL-STP-001	
Job No. 2025043	Drawn VIRAM	Checked NAFEES	Revisions
Date 05.04.23	Scale 1:50 (A2)		

STP UPPER & LOWER BASEMENT FLOOR LVL