


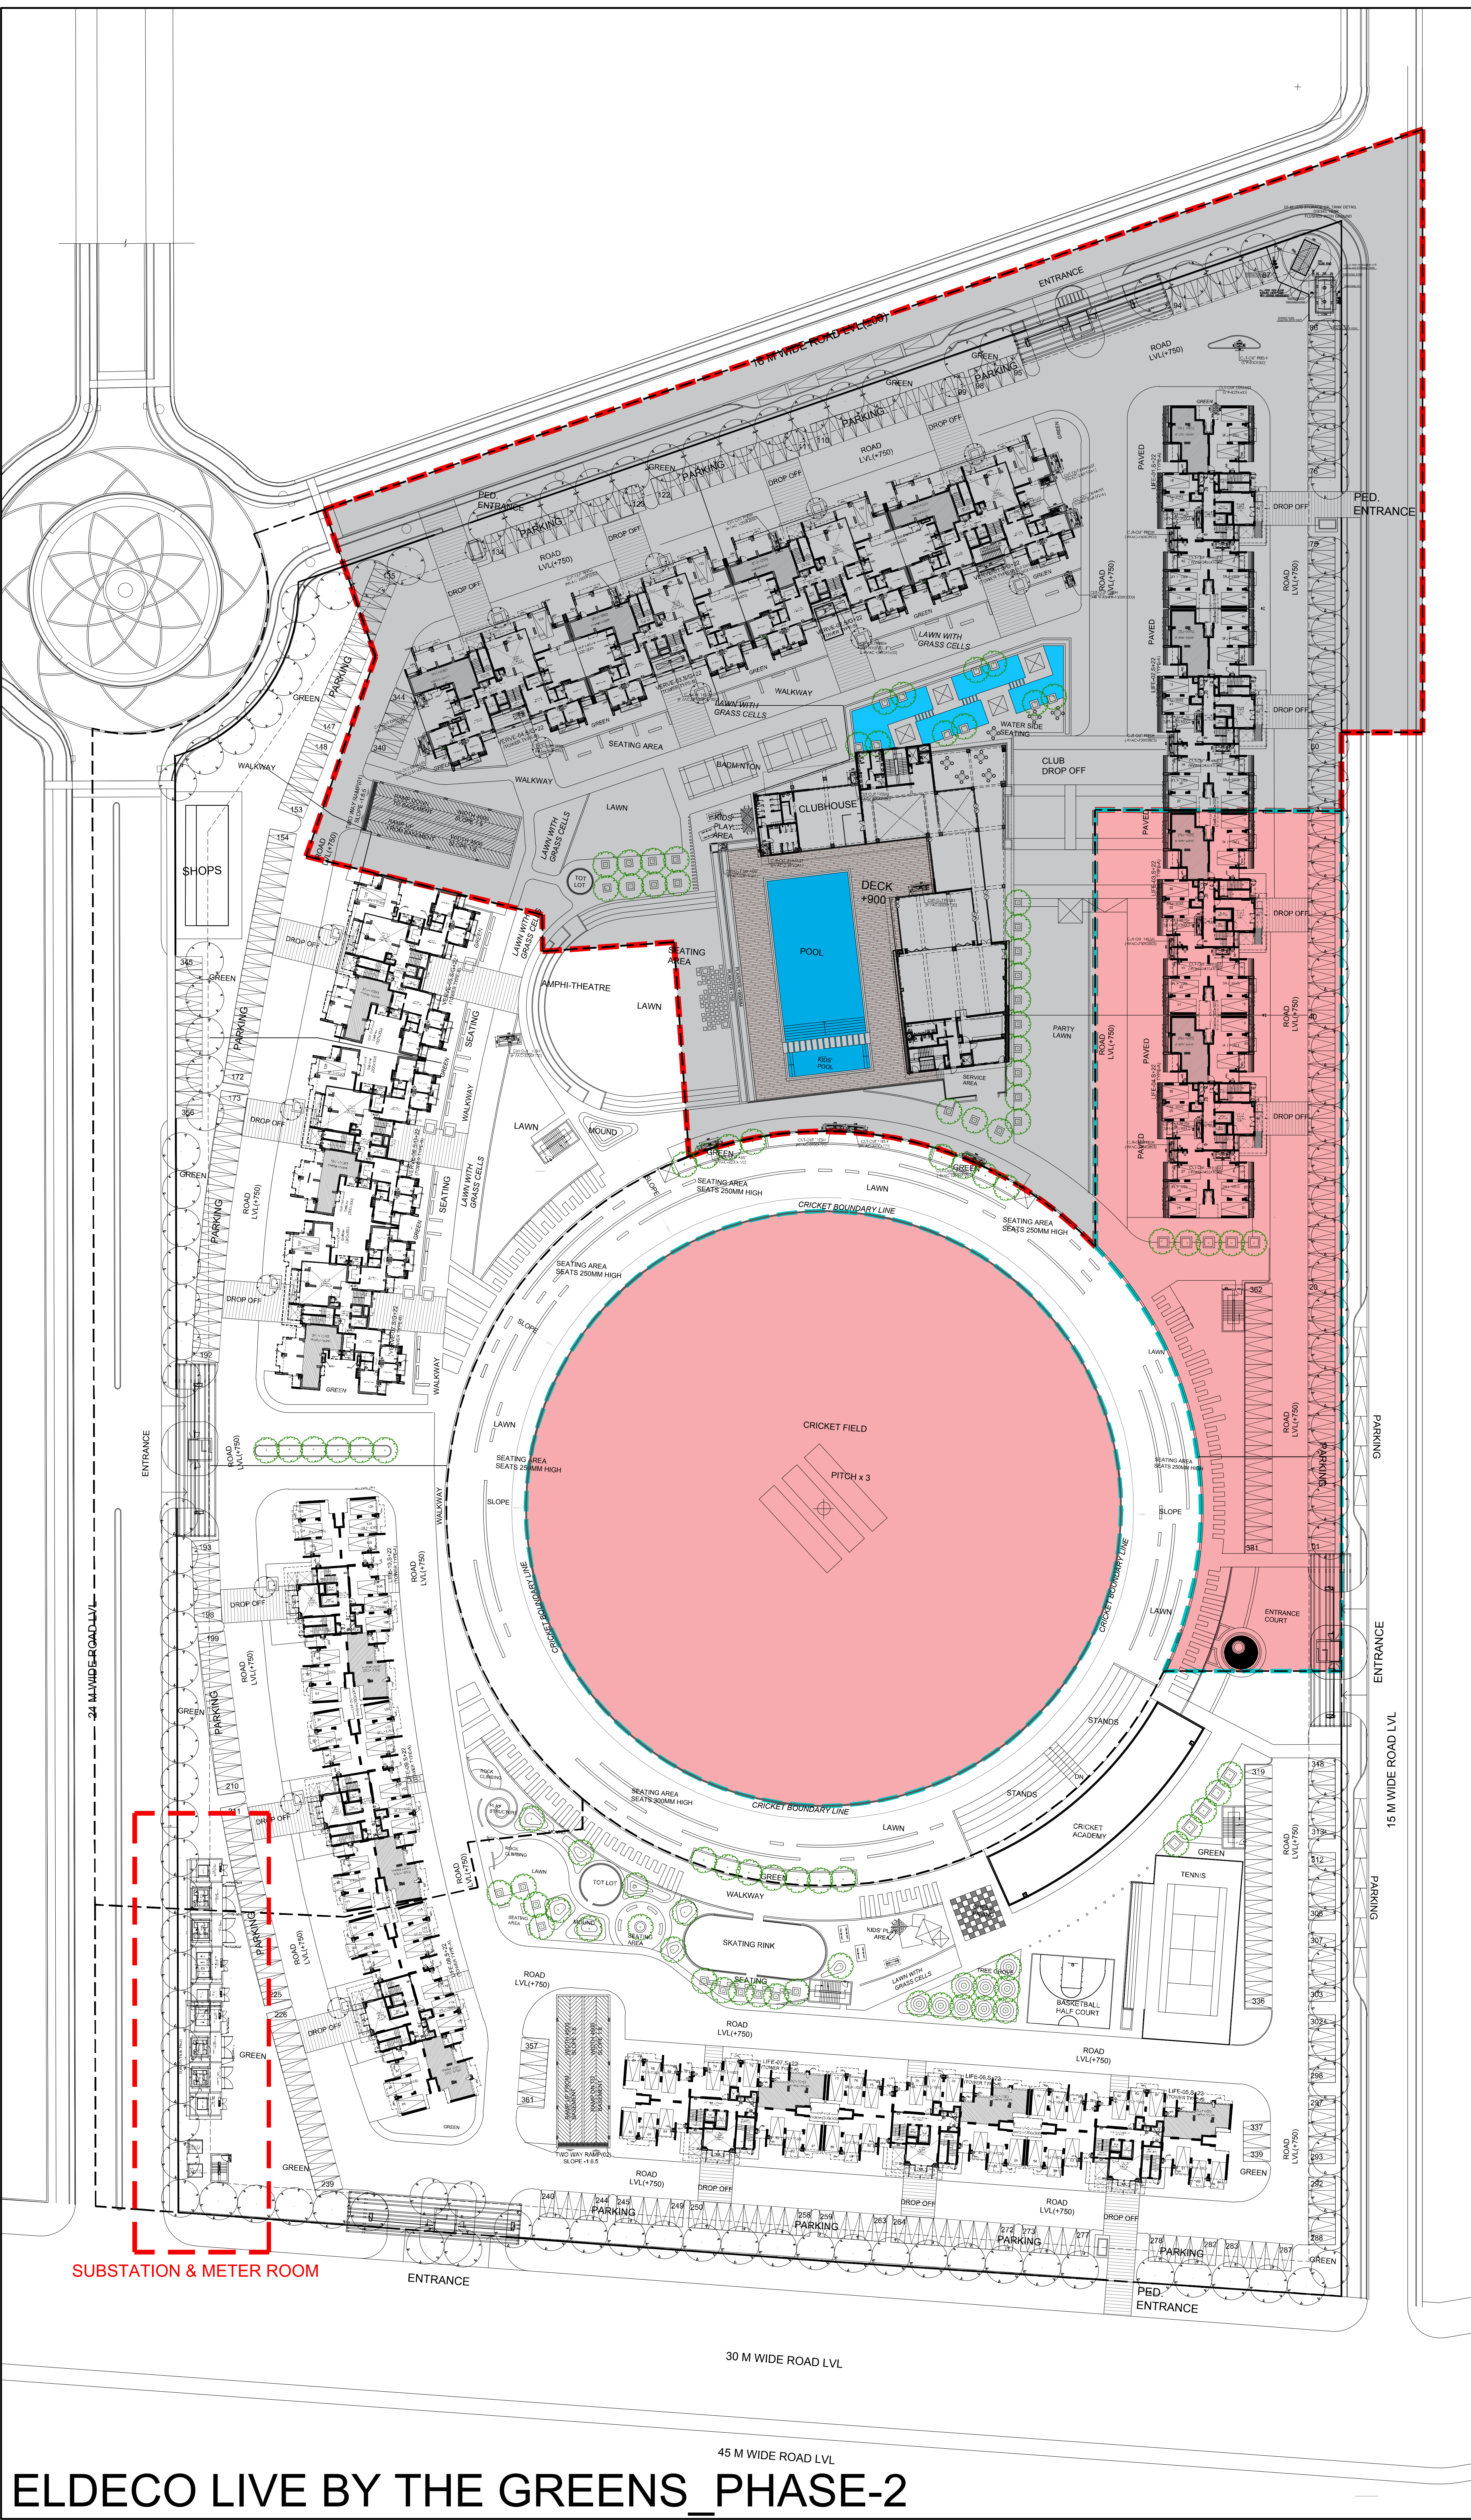


PHASE - I
TOTAL PLOT AREA
= 24111.93 SQM


PHASE - II
TOTAL PLOT AREA
= 15572.26 SQM

ELECTRICAL CONSULTANTS
AMPOWER CONSULTANCY SERVICES
B-222, Second Floor, Naraina Industrial
Area Phase-I, New Delhi -28, Phone - +91-11-25895772, +91-11-41414735

STRUCTURAL CONSULTANT
CE CON ENGG
HS-25, Second Floor, Kalash Colony Market, New Delhi-110048,
Phone - +91-11-41631766 Email: sssasabb@gmail.com

PLUMBING & FIRE FIGHTING
C P Vidya and Associates 312A, Unitech Arcadia, South City -II,
Sector 48, Gurgaon, Haryana - 122016 Phone - +91 124 4079336
Email: cpvidyaassociates@gmail.com

MEP CONSULTANTS
UDAYAN CHAUDHARI & ASSOCIATES PVT. LTD.
40/60, 2nd floor Chittaranjan Park, New Delhi-110 019
Phone - 011-26471312, 26416363, 40529512
e-mail: udayanchohary@gmail.com

DRAWING NAME

ELECTRICAL SUPPLY
SITE PLAN -PHASE-2

SCALE	DATE
1:400	09.04.21

DRAWING NO.

ES-01