


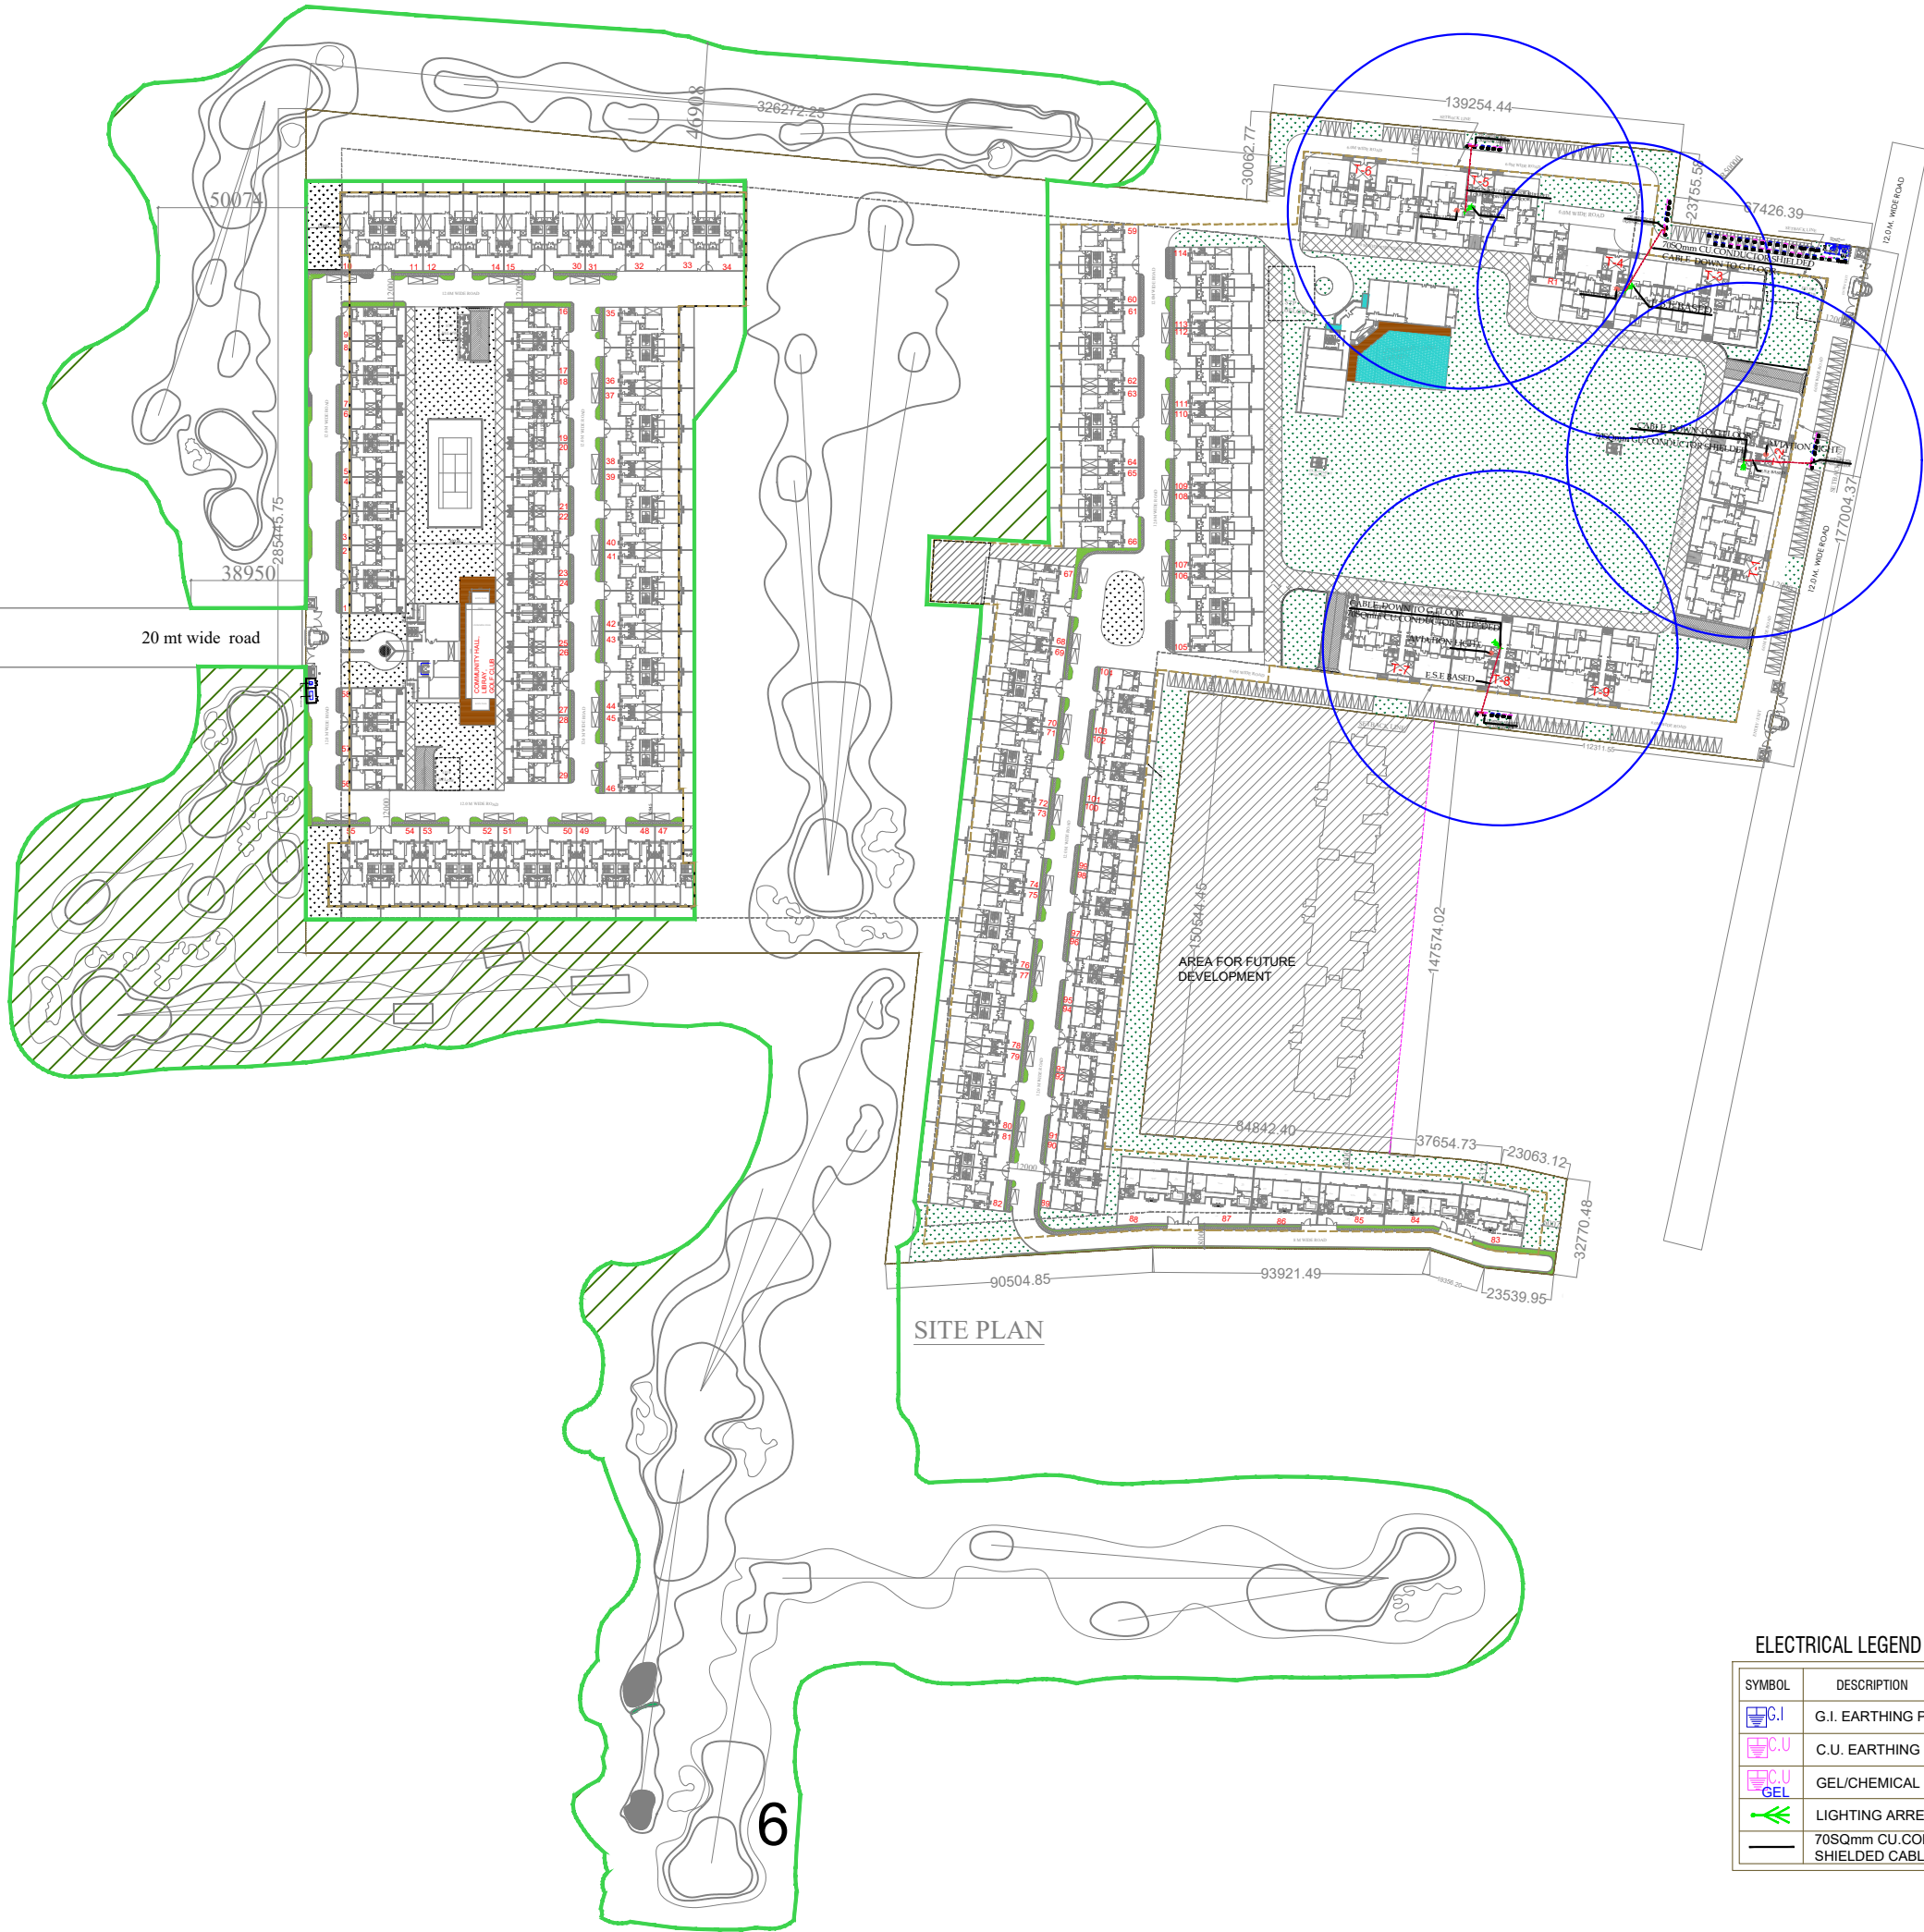

SITE PLAN

ELECTRICAL LEGEND

SYMBOL	DESCRIPTION
	G.I. EARTHING PIT
	C.U. EARTHING PIT
	GEL/CHEMICAL EARTHING PIT
	LIGHTING ARRESTOR
	70Sqmm CU.CONDUCTOR
	SHIELDED CABLE

SHEET TITLE
SITE PLAN
AREA CALCULATION

OWNER:
M/s CELERITY INFRASTRUCTURE PVT. LTD.
PLOT NO. SC-01/C,A2,A4,A6 & A11 IN SPORTS
CITY PROJECT, SECTOR-150 NOIDA (U.P)

PROJECT :
ATS-KINGSTON HEATH

ARCHITECT'S SIGNATURE

OWNER'S SIGNATURE

DEALT BY: MOHIT GAHLAUT	SCALE : 1:1000	DRG.NO. SD-01	NORTH
CHECKED BY: KAMAL NARAYAN	DATE : DECEMBER - 2015		