



OTHERS PLOT

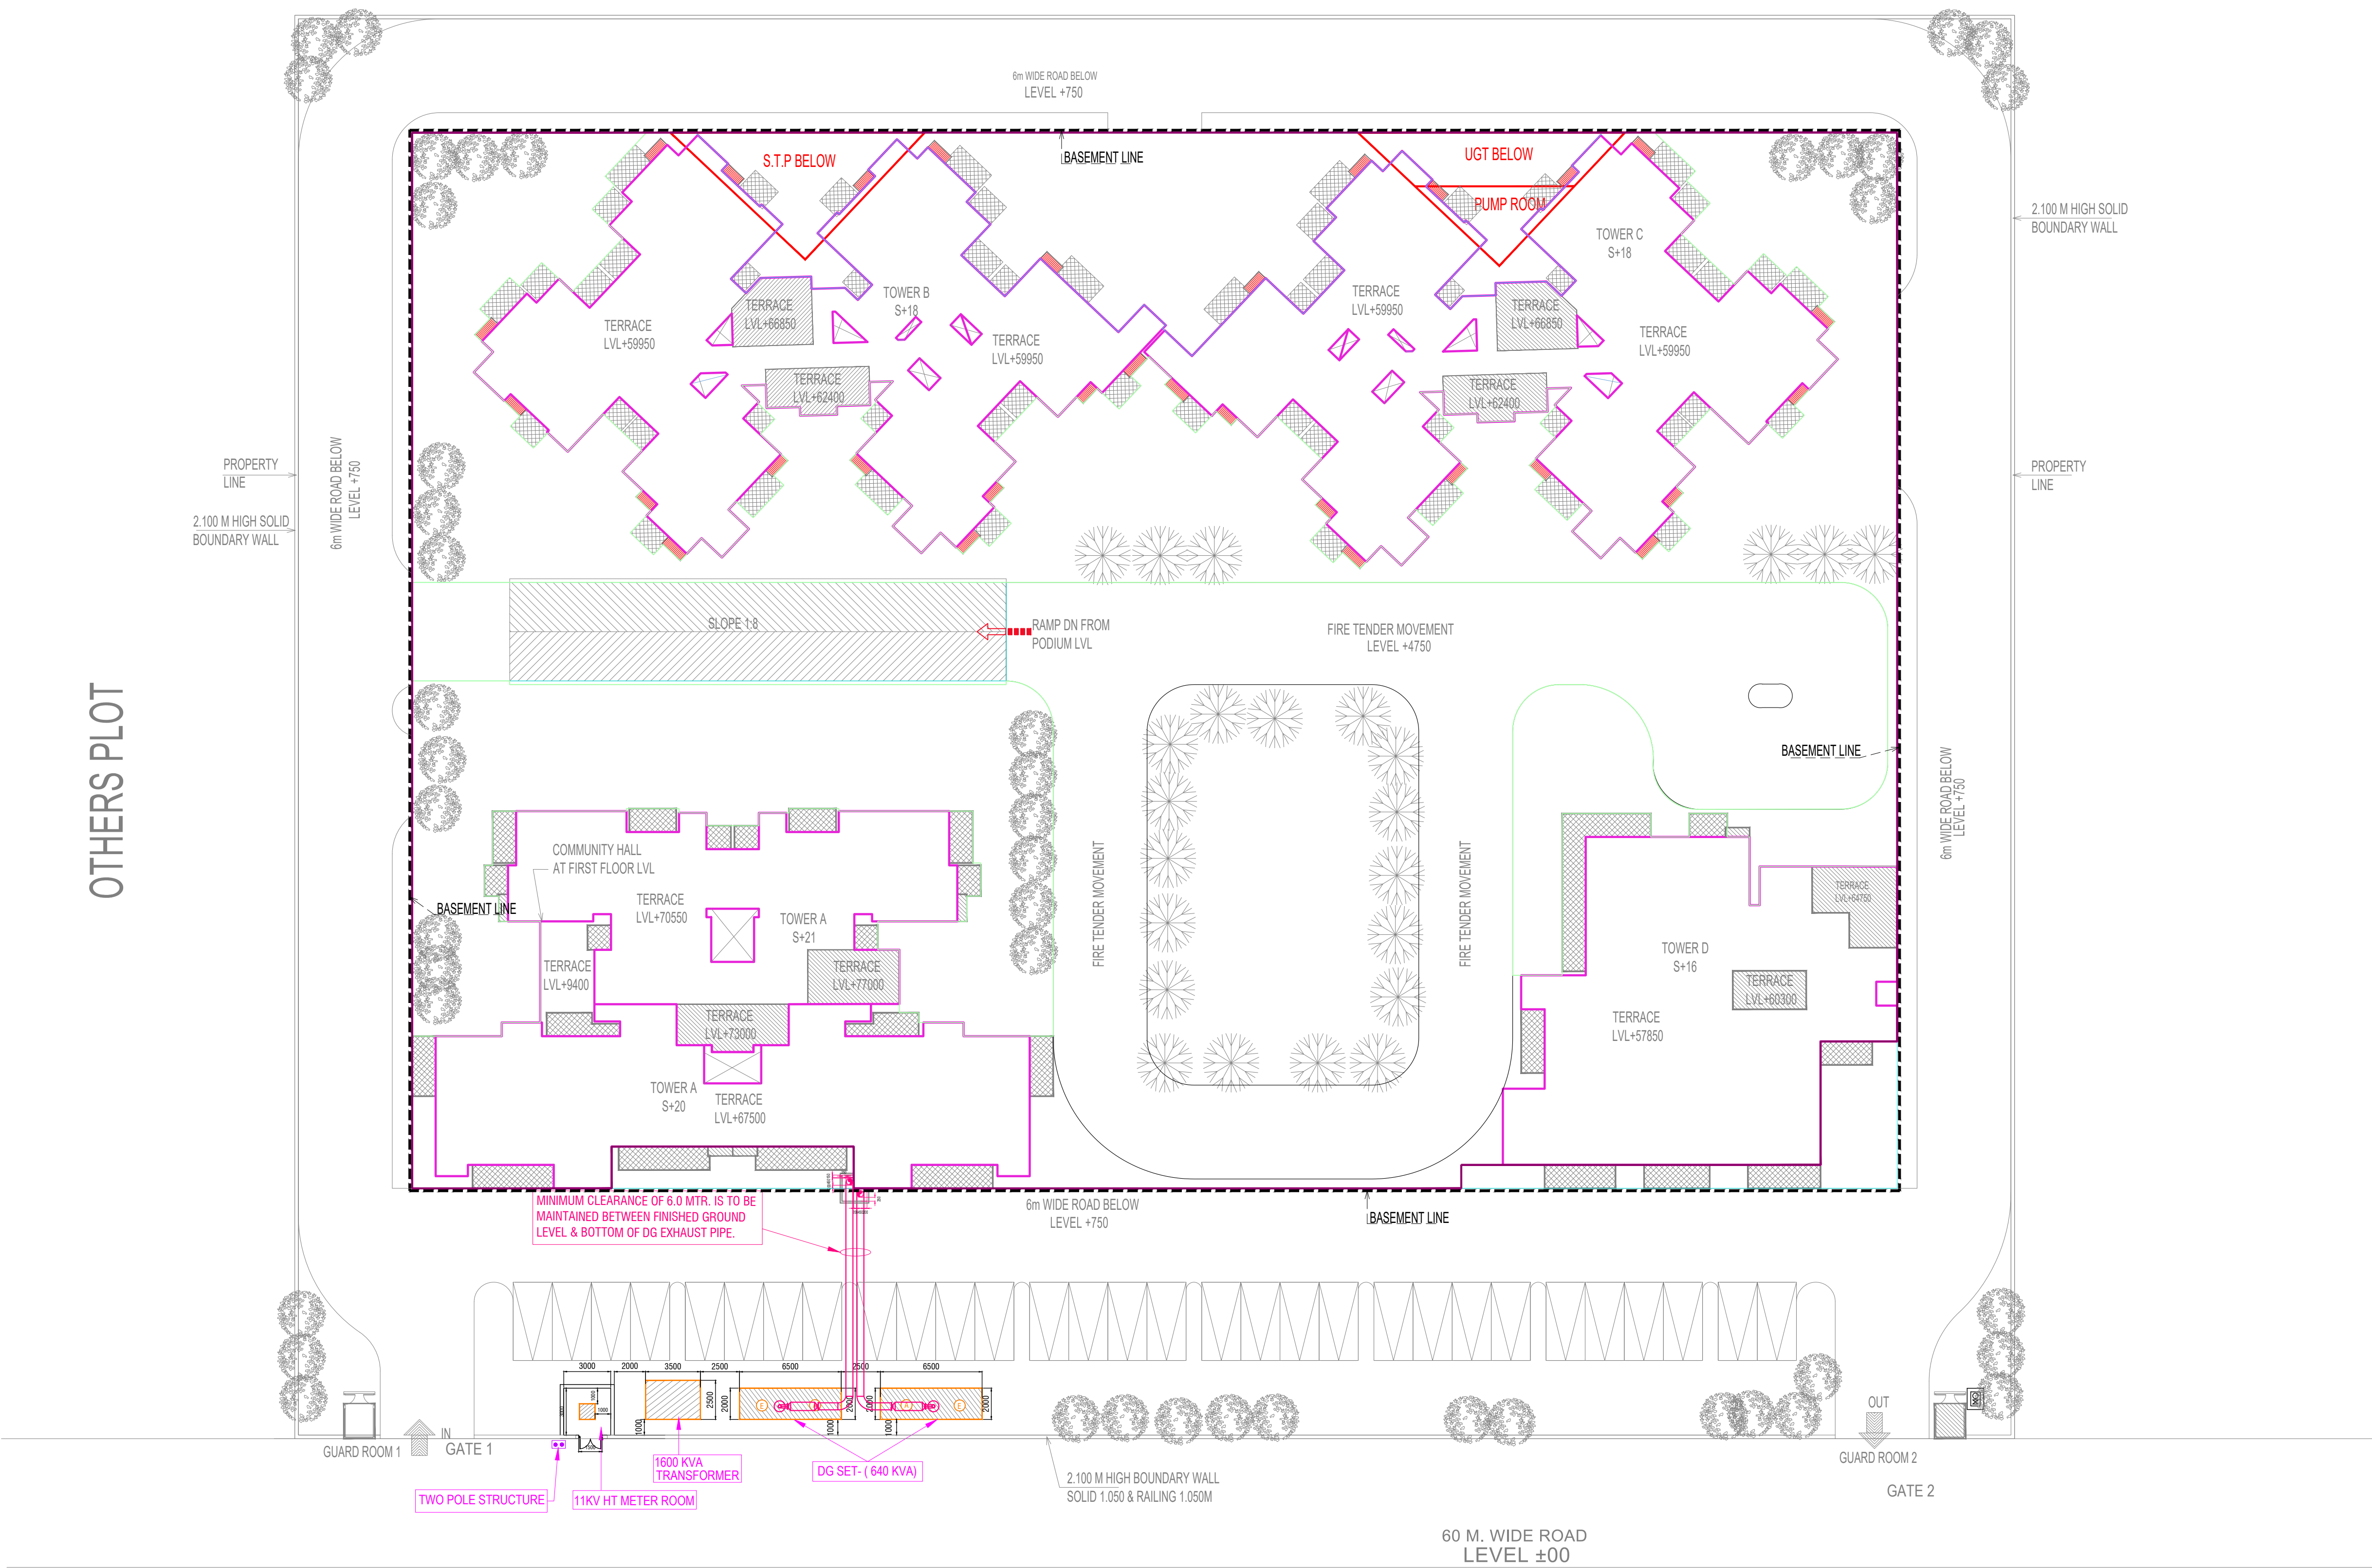

GIAN P. MATHUR
ARCHITECT
B. Arch., M.C.A., A.I.A.
CA No 80/5769

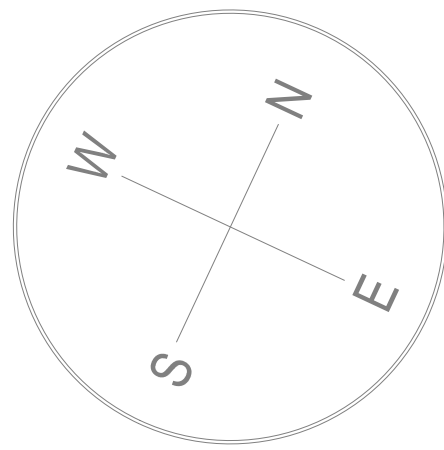

rev. no.	date	revision

project
SPRING HOMES
SC-1, GH-08, SPORTS CITY, TECHZONE, GREATERNOIDA

title
SITE PLAN

subtitle
EXTERNAL ELECTRICAL LAYOUT PLAN

drawing released for
☐ APPROVAL ☒ AUTHORITY SUBMISSION
☐ ADVANCE COPY ☐ CONSTRUCTION

drg. no. AGH/ EX / EL- 01 drawn by Satyam Sharma

scale 1 : 250 designed by M.Mansoor

date checked by Anand Havelia

architects
GIAN P. MATHUR AND ASSOCIATES (P) LTD.
C - 55, East Of Kailash, New Delhi-110065 T : 46599599 F 46599512
E : gpma@airtelmail.in W : www.gpmindia.com

services consultant
Consummate Engineering Services (P) Ltd.
Noida Office : B - 67, Sector - 67, Noida - 201 301
Tel : (0120) 2593500 (30 Lines)
Lko. Office : B-1006, Plotitas Plumeria, Gomti Nagar, Lucknow
Tel : (0522) 8515455
e mail : mail@cespln, website : www.cespln