


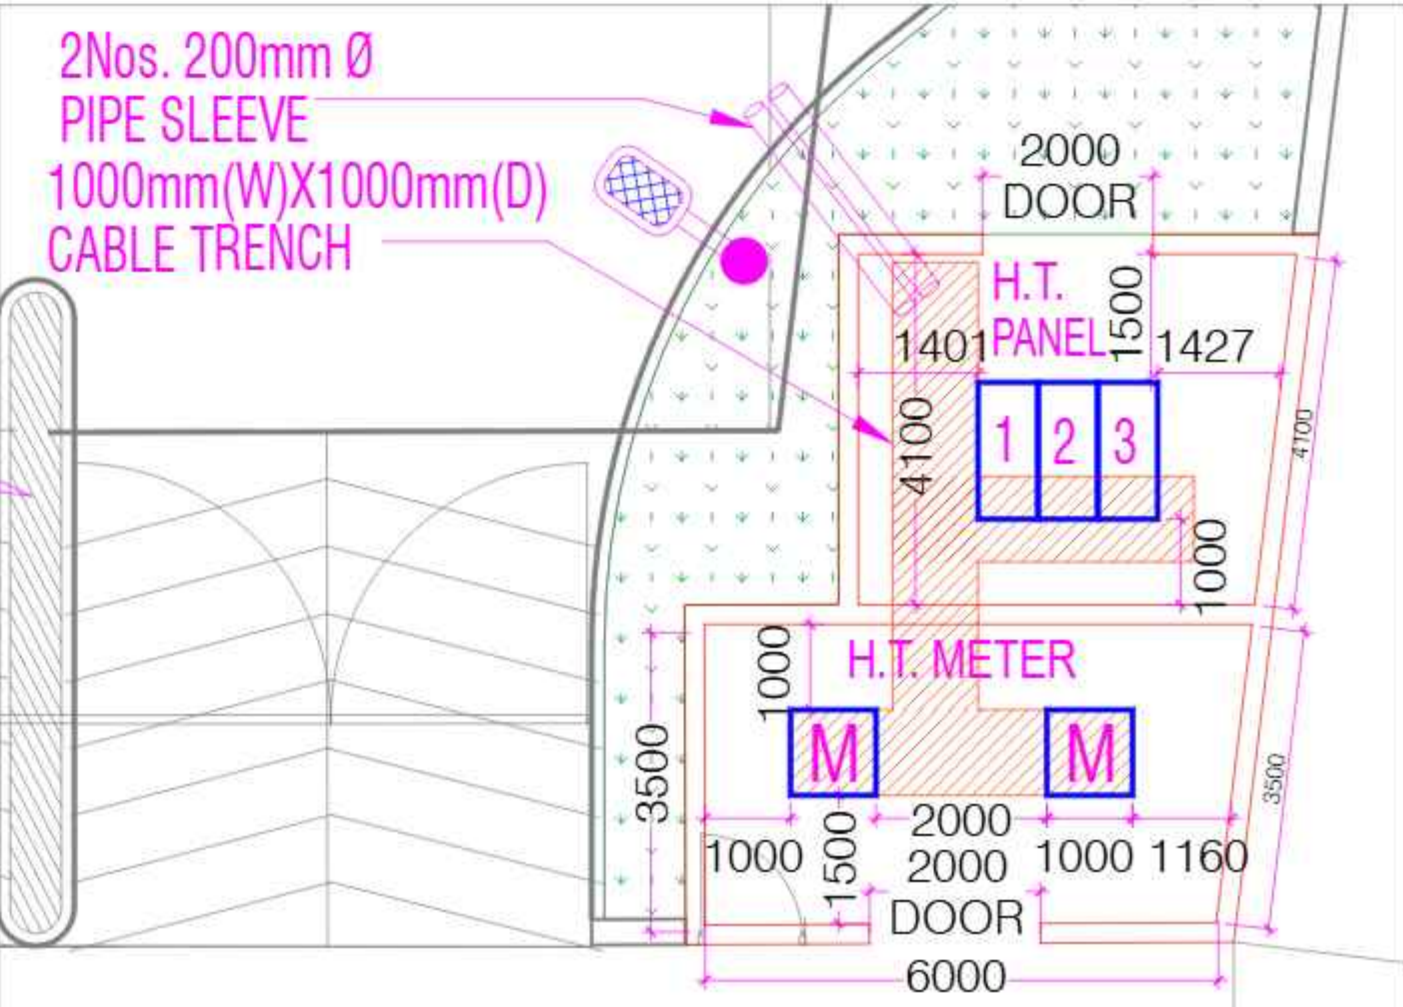

PARKING CALCULATION				
	DIRECT	JOCKEY	STACK	2 WHEELER
BASEMENT	340	70	166	63
STILT	125	14		
SURFACE	116	2		
TOTAL NO	581	86	166	
OVERALL		833		63



LEGENDS

STREET LIGHT POLE

Client

BALLADS OF BLISS GOODLIVING PROPERTIES LIMITED
201-212, 2nd Floor, Splendor Forum,
Jasola District Centre, New Delhi - 110 025

Architect

ARCOP ASSOCIATES PVT LTD
Plot No. 308, Sector-32, Industrial Area, Gurugram, Haryana, 122001, India
Tel: 91-124-4585500
91-124-4585550
Fax: 91-124-4585550

MEP Consultant

PARADISE CONSULTANTS
PLOT NO. 129, POCKET-2, BASEMENT
JASOLA VIHAR, NEW DELHI-110025
PH: 011-46132800, 41030619
E-mail: mep@paradiseconsultants.com

Structure Consultant

STEADFAST
STRUCTURAL CONSULTANTS
E-MAIL: chary@steadfastconsultants.com
Gachibowli, Hyderabad
CELL No: 9701797186

Landscape Consultant

roha
C-574 Defence Colony, G/F, New Delhi 110024
Office: 011 4165 0777
Mobile: 91-9971632047

Disclaimer

Drawings and written material appearing herein constitute original and unpublished work of the Consultant and may not be duplicated, used or disclosed without written consent of the Consultant.

Notes

1. Unless otherwise mentioned all dimensions are in Millimeters.
2. Unless otherwise mentioned all levels including finished floor levels are in Meters.
3. Unless otherwise mentioned all dimensions are shown exclusive of finishes & frames.
4. Dimensions are not to be scaled from the drawing.
5. Any discrepancies, either between written dimensions and site dimensions or within these drawings should be brought to the immediate attention of the consultant before executing the works.
6. This drawing is to be read in conjunction with all other documentation forming the construction document.

No	Date	Description
Revisions		
Drawing Status		
SUBMISSION DRAWING		
Key Plan		
Project Name		
ELDECO BALLADS OF BLISS		
Project Address		
PLOT NO. GH-1A/2, SEC. 22D, YAMUNA EXPRESS WAY, INDUSTRIAL DEVELOPMENT AUTHORITY, GAUTAM BUDDH NAGAR, U.P. - 203201		
Drawing Title		
EXTERNAL SITE PLAN ELECTRICAL LAYOUT		
Project No		
22.52.R		
Scale		
1:300		
Date		
MARCH 18, 2025		
Drawing No		
EL-PC-EH-SITE PLAN-102		
XX XX X XXX		
SHEET SIZE A1 : 841 X 594		



PARKING CALCULATION				
	DIRECT	JOCKEY	STACK	2 WHEELER
BASEMENT	340	70	166	63
STILT	125	14		
SURFACE	116	2		
TOTAL NO	581	86	166	
OVERALL	833			63

Client

BALLADS OF BLISS GOODLIVING PROPERTIES LIMITED
201-212, 2nd Floor, Splendor Forum,
Jasola District Centre, New Delhi - 110 025

Architect

ARCOP ASSOCIATES PVT LTD
Plot No. 308, Sector-32, Industrial Area, Gurugram, Haryana, 122001, India
Tel: 91-124-4595500
91-124-4595500
Fax: 91-124-4595550

MEP Consultant

PARADISE CONSULTANTS
PLOT NO. 129, POCKET-2, BASEMENT
JASOLA VIHAR, NEW DELHI-110025
PH: 011-46132800, 41030619
E-mail: mep@paradiseconsultants.com

Structure Consultant

STEADFAST
STRUCTURAL CONSULTANTS
EMAIL: chary@steadfastconsultants.com
Gachibowli, Hyderabad
CELL No: 9701797186

Landscape Consultant


C 574 Defence Colony, G/F, New Delhi 110024
Office: 011 4165 0777
Mobile: 91-9971632047

Disclaimer
Drawings and written material appearing herein constitute original and unpublished work of the Consultant and may not be duplicated, used or disclosed without written consent of the Consultant.

Notes
1. Unless otherwise mentioned all dimensions are in Millimeters.
2. Unless otherwise mentioned all levels including finished floor levels are in Meters.
3. Unless otherwise mentioned all dimensions are shown exclusive of finishes & frames.
4. Dimensions are not to be scaled from the drawing.
5. Any discrepancies, either between written dimensions and site dimensions or within these drawings should be brought to the immediate attention of the consultant before executing the works.
6. This drawing is to be read in conjunction with all other documentation forming the construction document.

No	Date	Description
Revisions		
Drawing Status		

SUBMISSION DRAWING

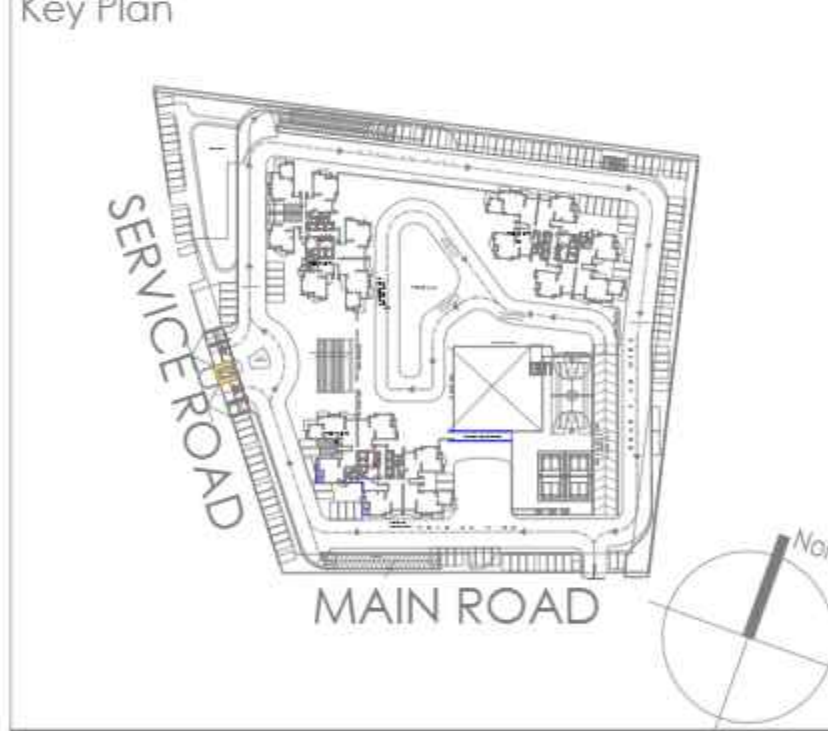

Project Name
ELDECO BALLADS OF BLISS

Project Address
PLOT NO. GH-1A/2, SEC. 22D, YAMUNA EXPRESS WAY, INDUSTRIAL DEVELOPMENT AUTHORITY, GAUTAM BUDDH NAGAR, U.P. - 203201

Drawing Title
BASEMENT-01 ELECTRICAL LAYOUT

Project No	22.52.R
Scale	1:300
Date	MARCH 18, 2025
Drawing No	

XX

XX

X

XXX

SHEET SIZE A1 : 841 X 594