

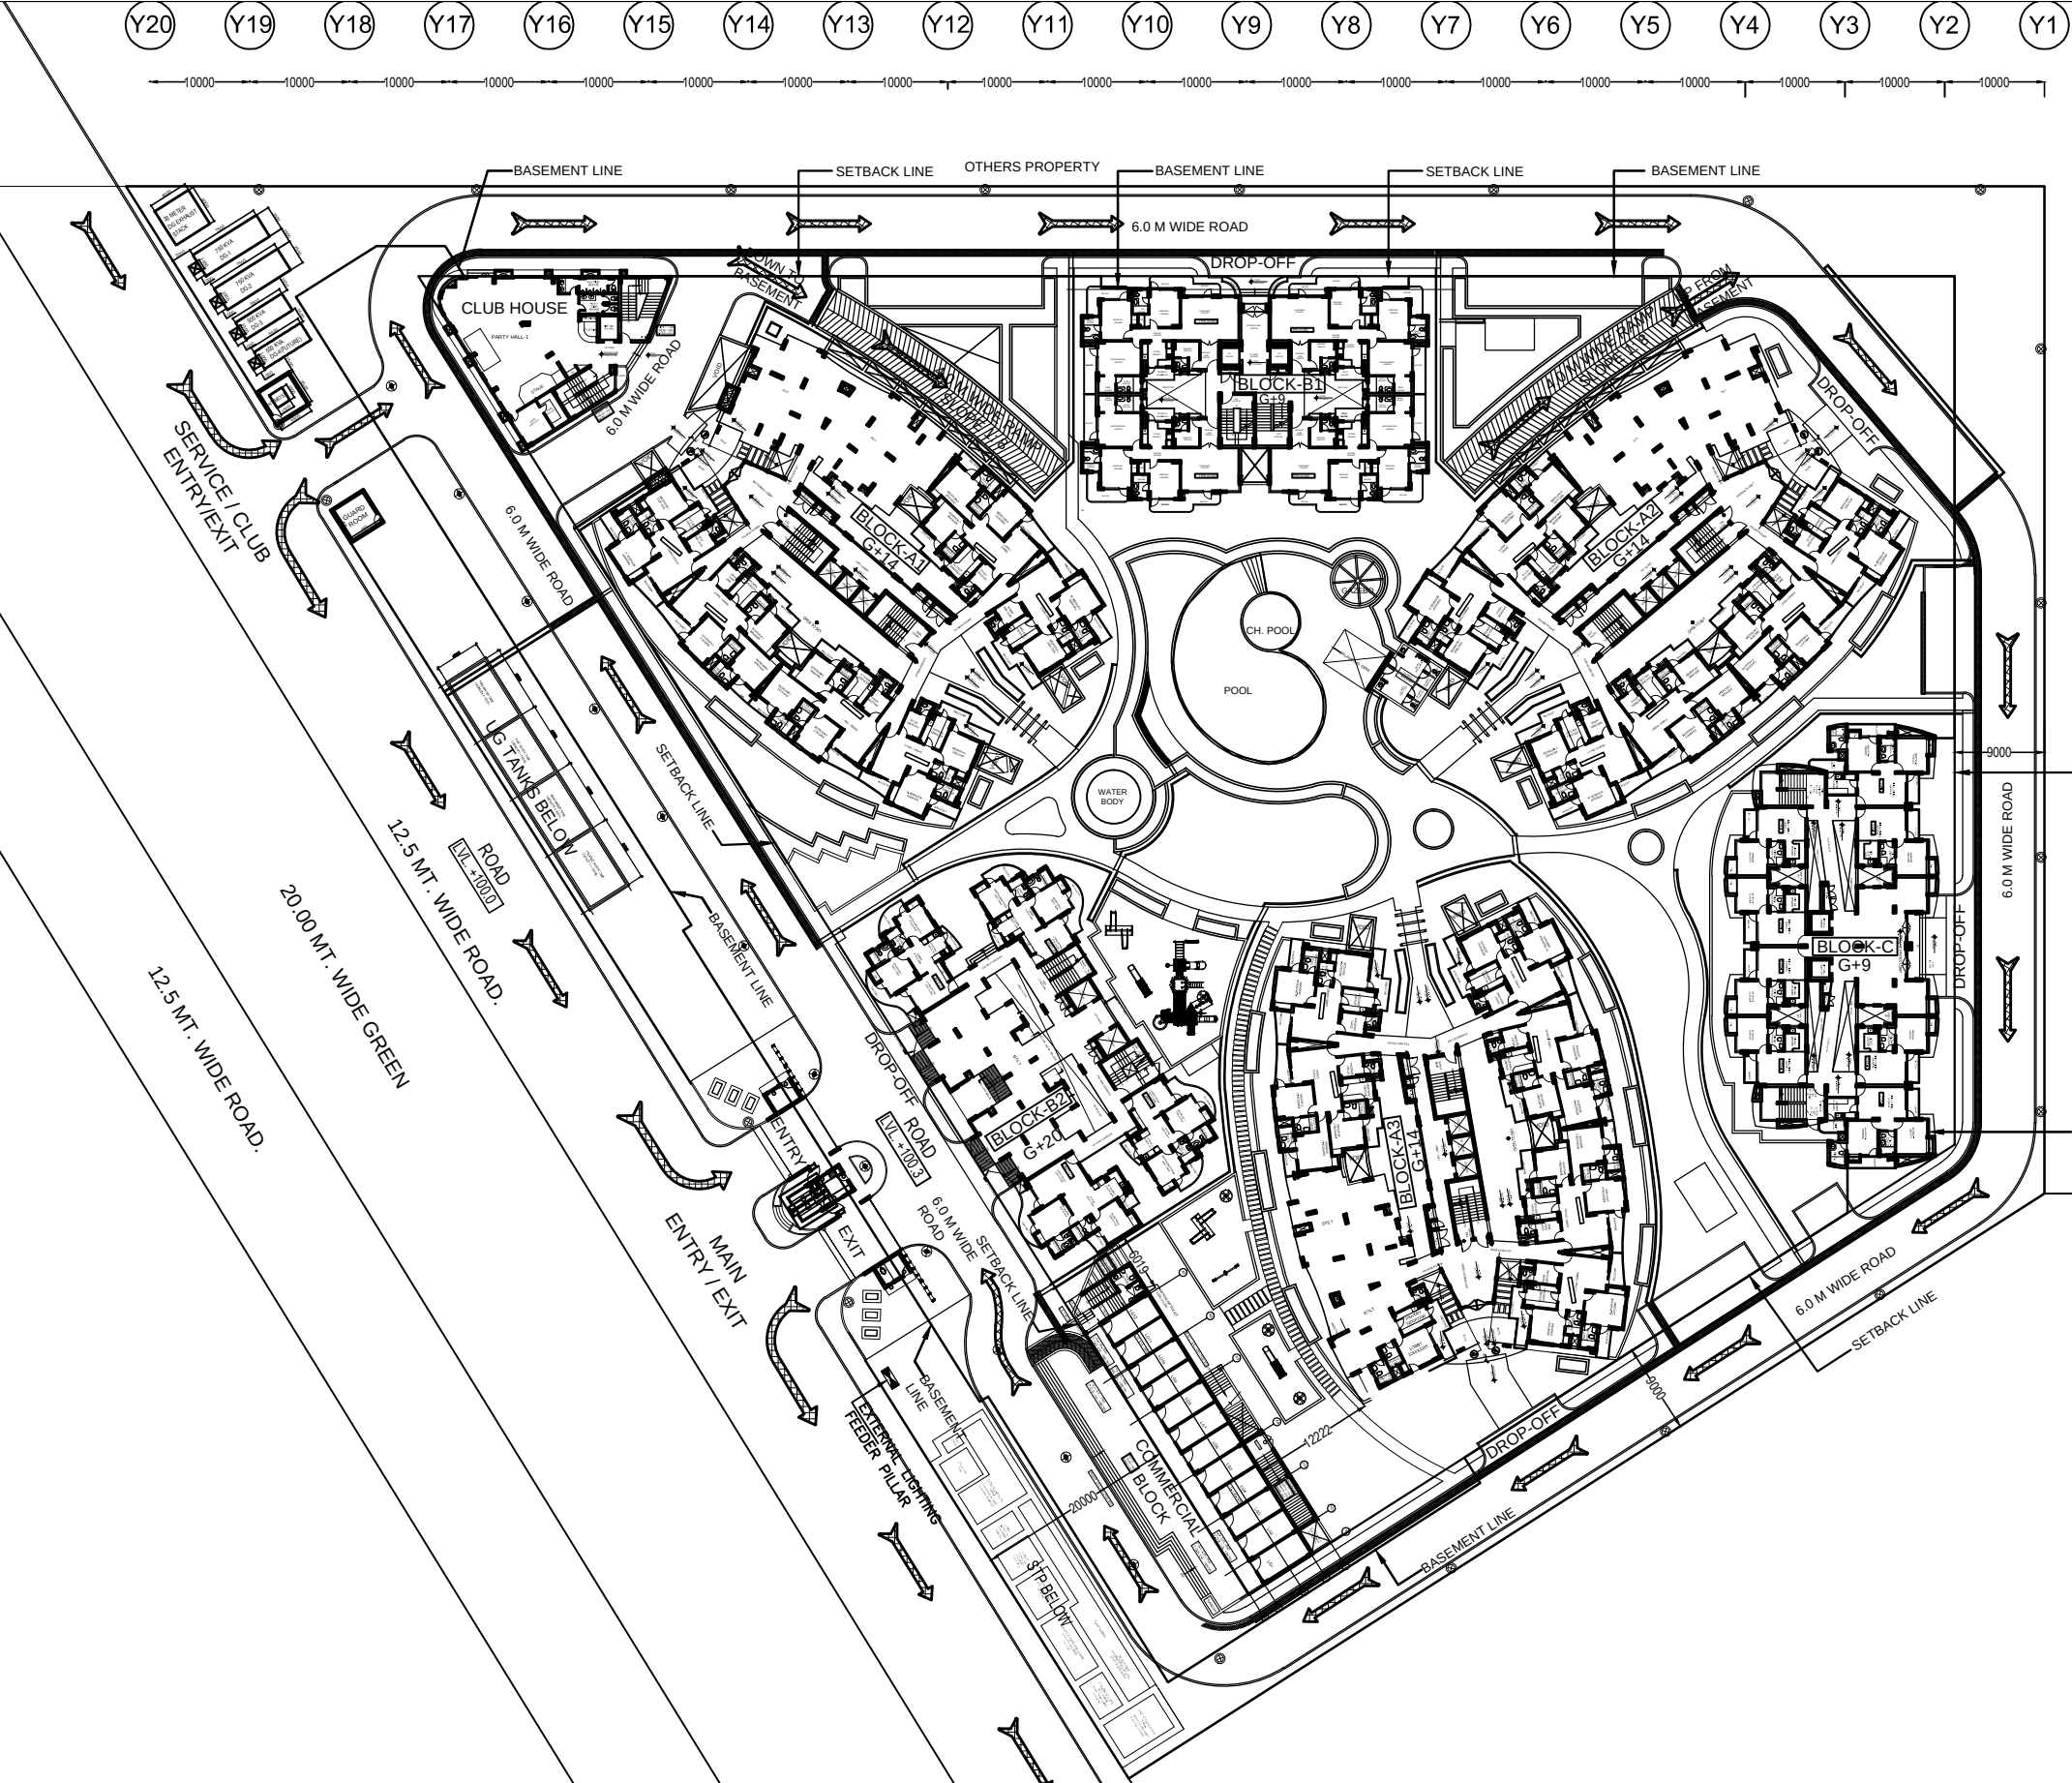


		The contents of this drawing or part thereof may not be used or reproduced without the permission of the Architect	
NO. OF PRINTS	DATE	ISSUED TO	REMARKS
REVISION	DATE	DESCRIPTION	BY
GENERAL NOTES :-			
1. All dimensions are in mm unless mentioned otherwise			
2. No dimensions are to be scaled from this drawing			
3. Contractors must verify all dimensions on site before commencing any work			

LEGEND	
SYMBOL	DESCRIPTION
	6MTR LONG G.I. POLE WITH LIGHT FIXTURE PHILIPS CAT NO SGP 301/70W (70W CDM-T LAMP) @ 30MTR C/C WITH 1000MM LONG G.I. BRACKET
	3MTR LONG G.I. PIPE POLE WITH BRACKET & LIGHT FIXTURE SIMILAR TO PHILIPS CAT NO BRPP 320/24 LED(45W)
	FEEDER PILLAR

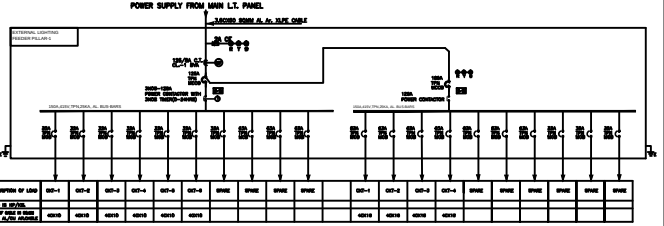

TENDER PURPOSE ONLY

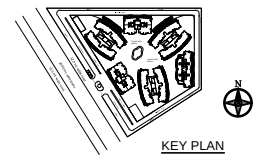

CLIENT
SIKKA PROMOTERS PVT. LTD.

PROJECT
SIKKA KARMIC GREENS
PLOT NO. 1 C
SECTOR-78, NOIDA

DATE SEP-2011	CHECKED BY S.K. MAHAPATRA/ G.N.RAO	PROJECT COORD./ APPROVED BY
SCALE 1:300	DEALT BY SUDHIR	D. C. KUKREJA

DRAWING TITLE
EXTERNAL LIGHTING SITE PLAN

ARCHITECTS:-
C. P. KUKREJA ASSOCIATES
ASHIRWAD BUILDING,
D-1, GREEN PARK,
NEW DELHI - 110016
PHONE :- 011 26863953 FAX :- 011 26865770
EMAIL:-cpkukreja@gmail.com

DRAWING NO.:- 10006/SIKKA/E-SP01-L	REVISION
CAD NO.:-	R0